

three inches = one foot  
one and one half inches = one foot  
one inch = one foot  
three quarters inch = one foot  
one half inch = one foot  
three eighths inch = one foot  
one quarter inch = one foot  
one eighth inch = one foot  
one sixteenth inch = one foot


1 2 3 4 5 6 7 8 9

26 25.5 25.4 25 24.9 24 23 22 21 20.5 20 19.5 19

Q.2  
Q  
P.7  
P  
N.7  
N.3  
N  
M  
L.5  
L

PHASE-3: HVAC FIRST FLOOR NEW DUCT WORK (EXPAND EMERGENCY DEPT.)

PHASE-4: HVAC FIRST FLOOR NEW DUCT WORK (NEW POLICE DEPT.)

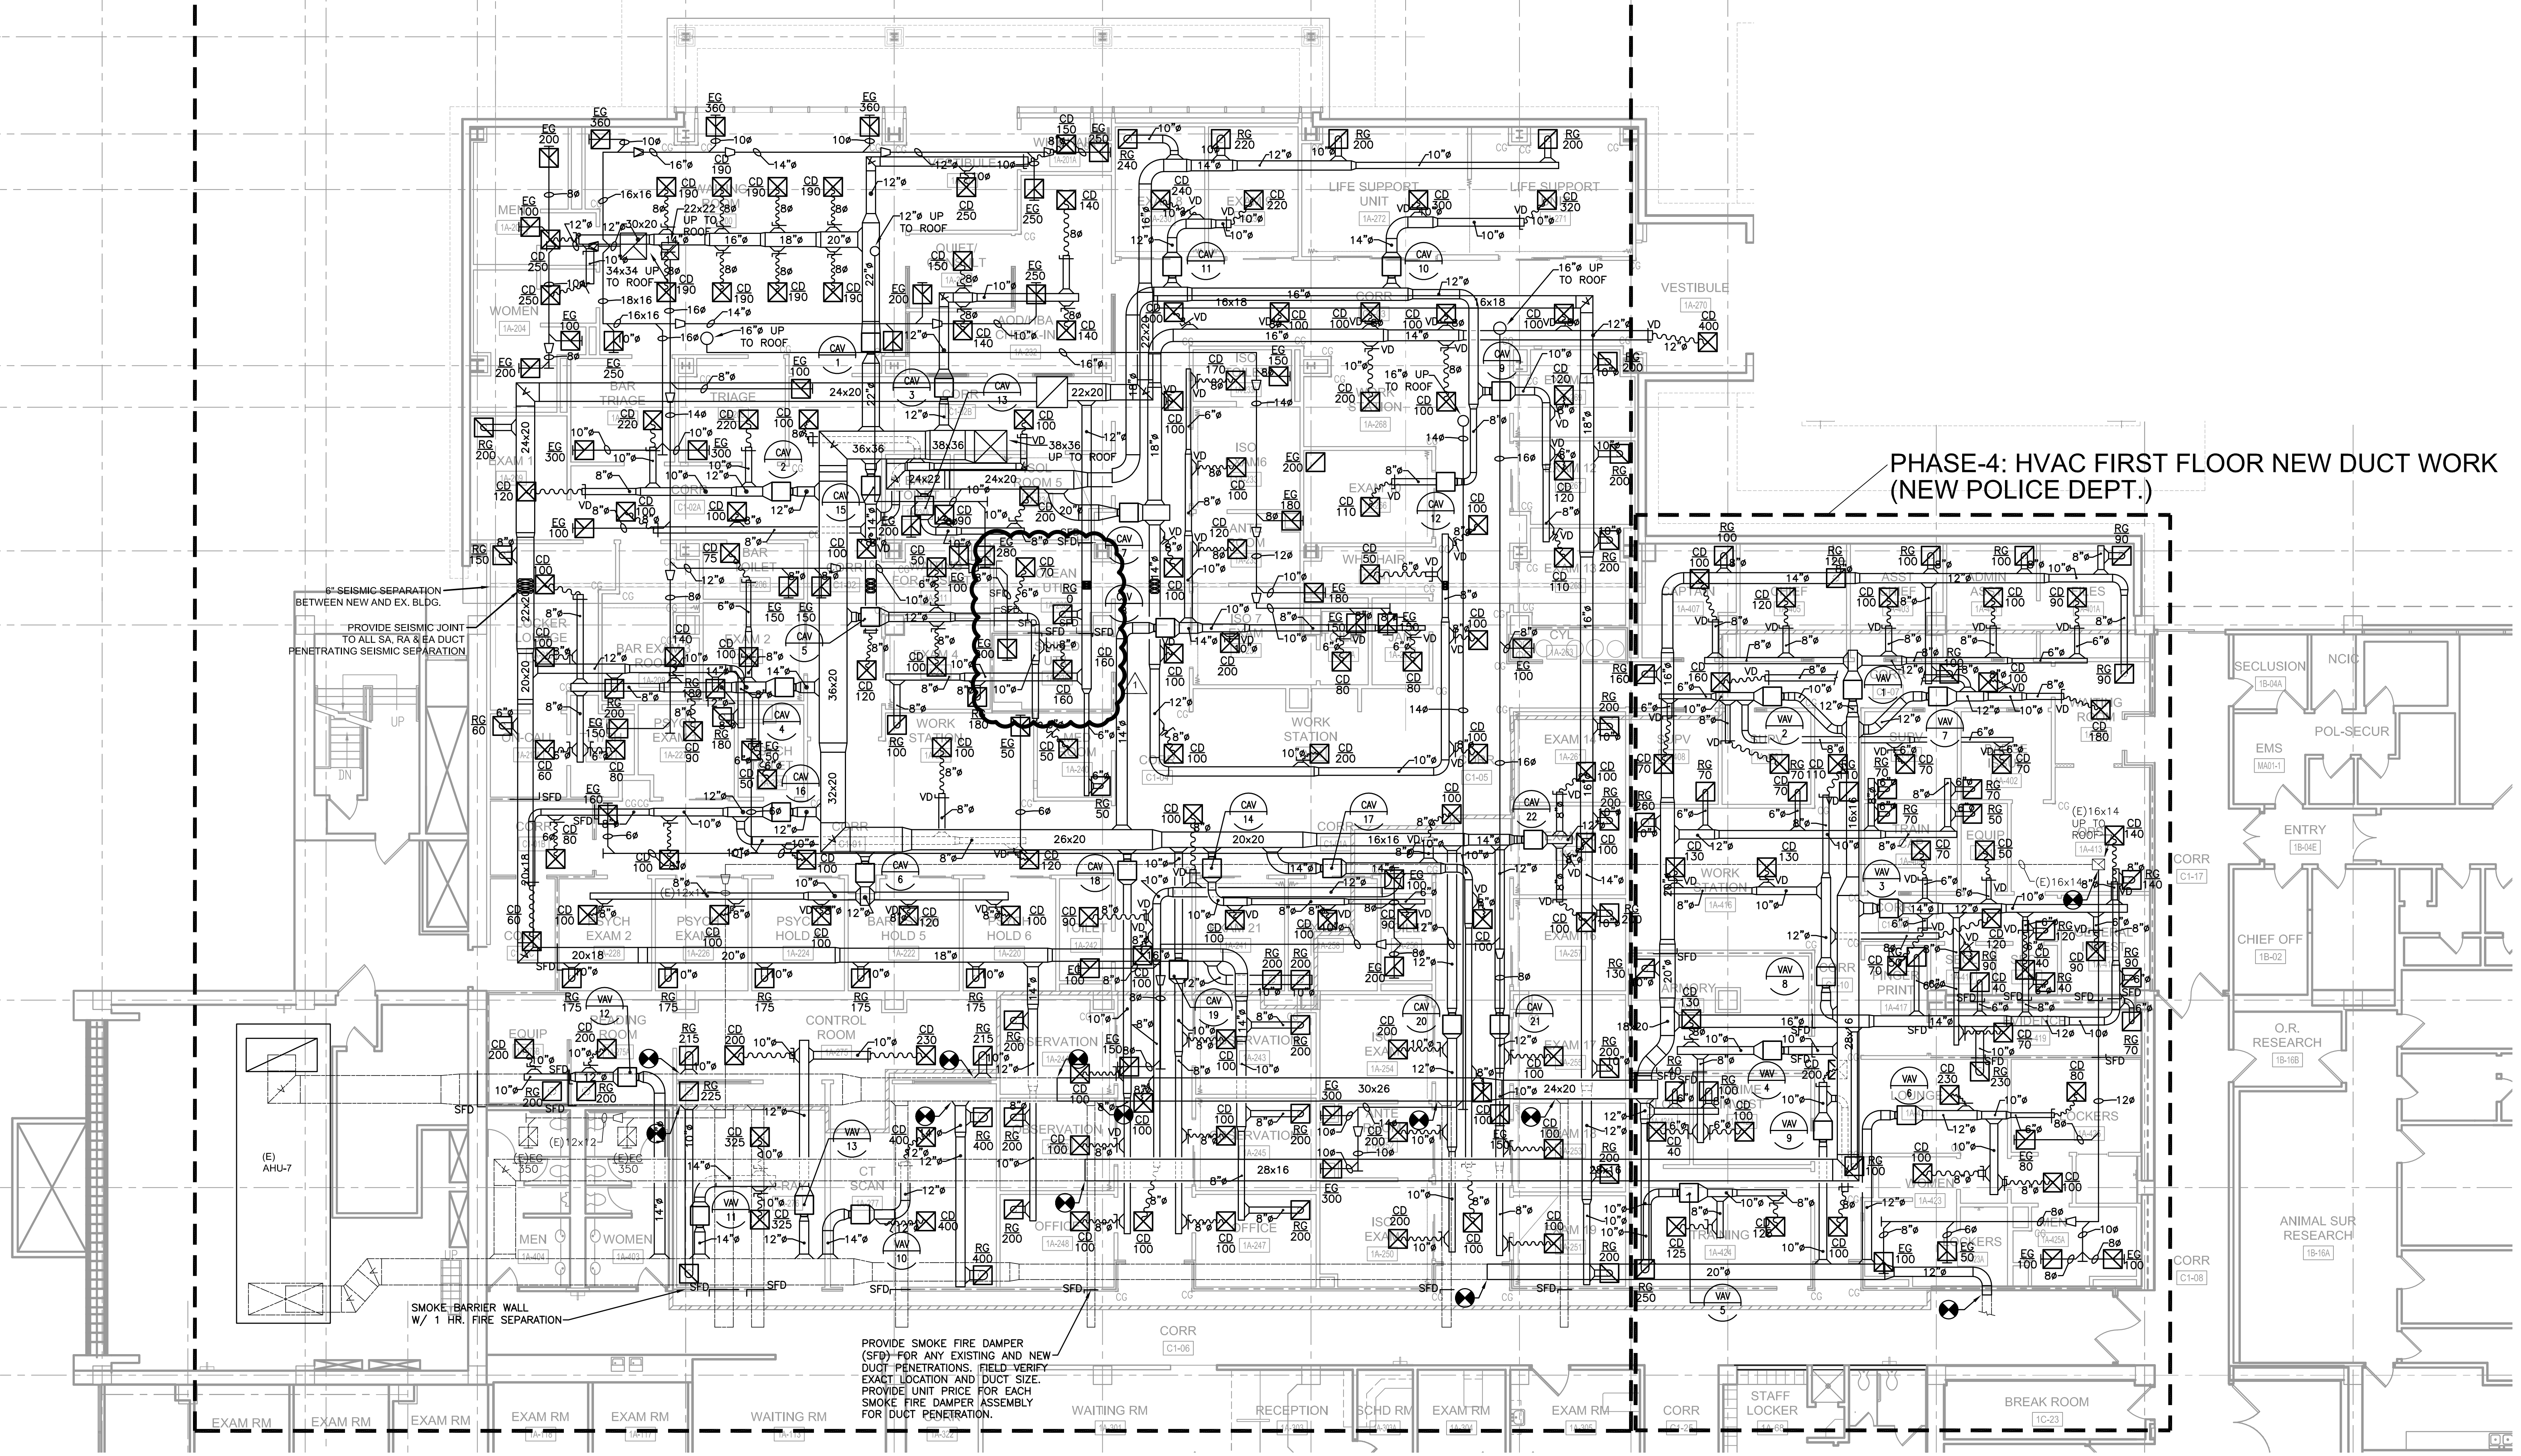

1 HVAC FIRST FLOOR NEW DUCTWORK PLAN - PHASE 3 & 4  
1/8" = 1'-0"

|   |  |  |  |                    |  |   |  |  |  |  |  |  |  |   |  |   |  |             |  |                          |  |
|---|--|--|--|--------------------|--|---|--|--|--|--|--|--|--|---|--|---|--|-------------|--|--------------------------|--|
| <b>ARCHITECTS/ENGINEERS</b><br>PRINCIPAL<br>Michael Lehman, AIA<br>PROJECT MANAGER<br>Ruby Carr, LEED AP<br>PROJECT ARCH/DESIGNER<br>Lisa Alzona, RA, LEED AP<br>PROJECT ENG/INT DESIGNER<br>Rupesh Patel, P.E. |  | <b>EWING COLE</b><br>20120401<br>LICENSED ARCHITECT<br>NO. C16617<br>REGISTERED PROFESSIONAL ENGINEER<br>NO. 36396<br>EX. 3-31-11<br>STATE OF CALIFORNIA |  | <b>CONSULTANTS</b> |  | Approved: VA Project Engineer<br>Approved: Chief, Project Section<br>Approved: Chief, Maint., & Operations Office<br>Approved: Chief, Engineering Dept. |  | Approved: Chief, Env. of Care Dept.<br>Approved: Chief, Env. Management Dept.<br>Approved: Dir., Facilities Management<br>Approved: Chief, Medical Officer |  | <b>Drawing Title</b><br>HVAC FIRST FLOOR NEW DUCTWORK PLAN - PHASE 3 & 4 |  | <b>Project Title</b><br>VA Loma Linda Healthcare System<br>Expand Emergency Department |  | <b>Project Number</b><br>605-330<br><b>Building Number</b><br>1 |  | <b>Office of Construction and Facilities Management</b> |  |             |  |                          |  |
| 1 ADDENDUM 001<br>CONSTRUCTION DOCUMENT ISSUE   |  | 05.12.16<br>02.15.16<br>Date   |  |                    |  |   |  |  |  | Approved: VP, Administration Support<br>Approved: C.E.O.                 |  | Location<br>11201 BENTON STREET<br>LOMA LINDA, CA 92357                                |  | Date<br>05.12.16  |  | Checked<br>RP   |  | Drawn<br>AG |  | <b>Dwg. of</b><br>MD-201 |  |

VA FORM 08-6231

ISSUED FOR 100% SUBMITTAL  
CONSTRUCTION DRAWINGS  
Copyright © 2009 by EWMCOLE

1 2 3 4 5 6 7 8 9