

DOOR SCHEDULE

NO.	TYPE	SIZE	FRAME TYPE	HDW SET	LABEL	REMARKS
100	A	PR3-0"x7'-0"x1 3/4"	HM			SEE ELEC DWGS FOR HDW
101A	B	3'-0"x7'-0"x1 3/4"	HM			SEE ELEC DWGS FOR HDW
101B	C	14'-0"x14'-0"	HM			
101C	C	14'-0"x14'-0"	HM			
101D	B	3'-0"x7'-0"x1 3/4"	HM			SEE ELEC DWGS FOR HDW

FINISH SCHEDULE

	FLOORS	BASE	WALLS	CEILING	
	CONCRETE HARD & SEAL	PAINT EPOXY 8"	PAINT EPOXY	PAINTED	

NO.	ROOM NAME	1	1	1	1	HEIGHT	REMARKS
-----	-----------	---	---	---	---	--------	---------


FIRST LEVEL FLOOR PLAN

100	VESTIBULE	1	1	1	1	-	
-----	-----------	---	---	---	---	---	--

101	FIRE BAY 1	1	1	1	1	-	
-----	------------	---	---	---	---	---	--

HARDWARE SET NO. 1


1 EA. CONT. GEAR HINGES
1 EA. LOCKSET
1 EA. CLOSER
1 EA. KICK PLATE
1 EA. THRESHOLD
1 EA. DOOR BOTTOM SEAL
1 SET WEATHERSTRIP (H & J)
1 EA. OVERHEAD RAIN DRIP CAP
66ZHD x L.A.F.
45H7AB
D4551CSH x SN
K0050-16" x 2 L.D.W. x B4E
425 HD x L.A.R.
101 VA
160 SA
N6P16A x FULL FRAME WIDTH
ALL HARDWARE EQUIVALENT TO STANLEY HARDWARE DIV. OF STANLEY WORKS & SHALL MATCH EXISTING. COORDINATE WITH ELECTRICAL.

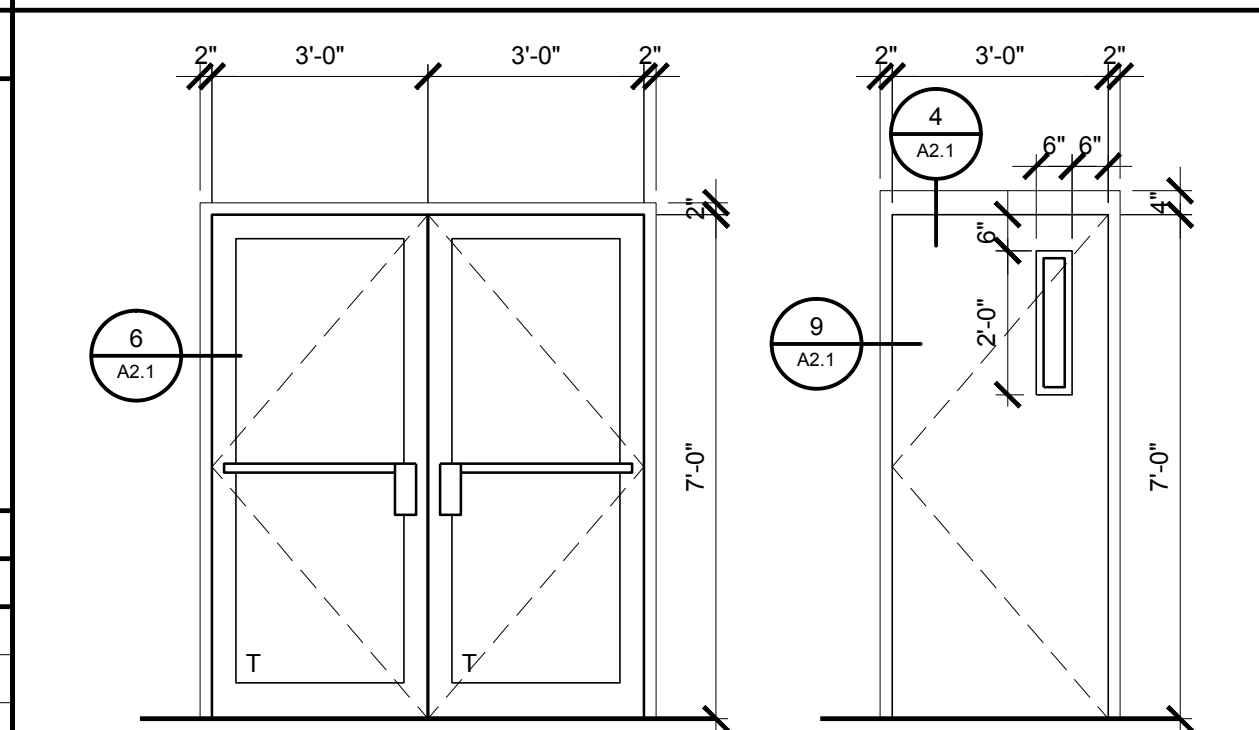


A PAIR 1-3/4" ALUM. STOREFRONT ENTRANCE EQUAL TO KAWNEER 500 SERIES. PROVIDE 1/4" TEMPERED GLASS, AND METAL THRESHOLD. HARDWARE BY S.F. MANUF.
B HOLLOW METAL DOOR WITH 1/4" TEMP. LITE IN PAINTED H.M. FRAME. SEE HARDWARE SET NO. 1 THIS SHEET. COORDINATE FRAME W/ ELECTRICAL DRAWINGS.

DOOR SCHEDULE

SCALE: 3/8" = 1'-0"

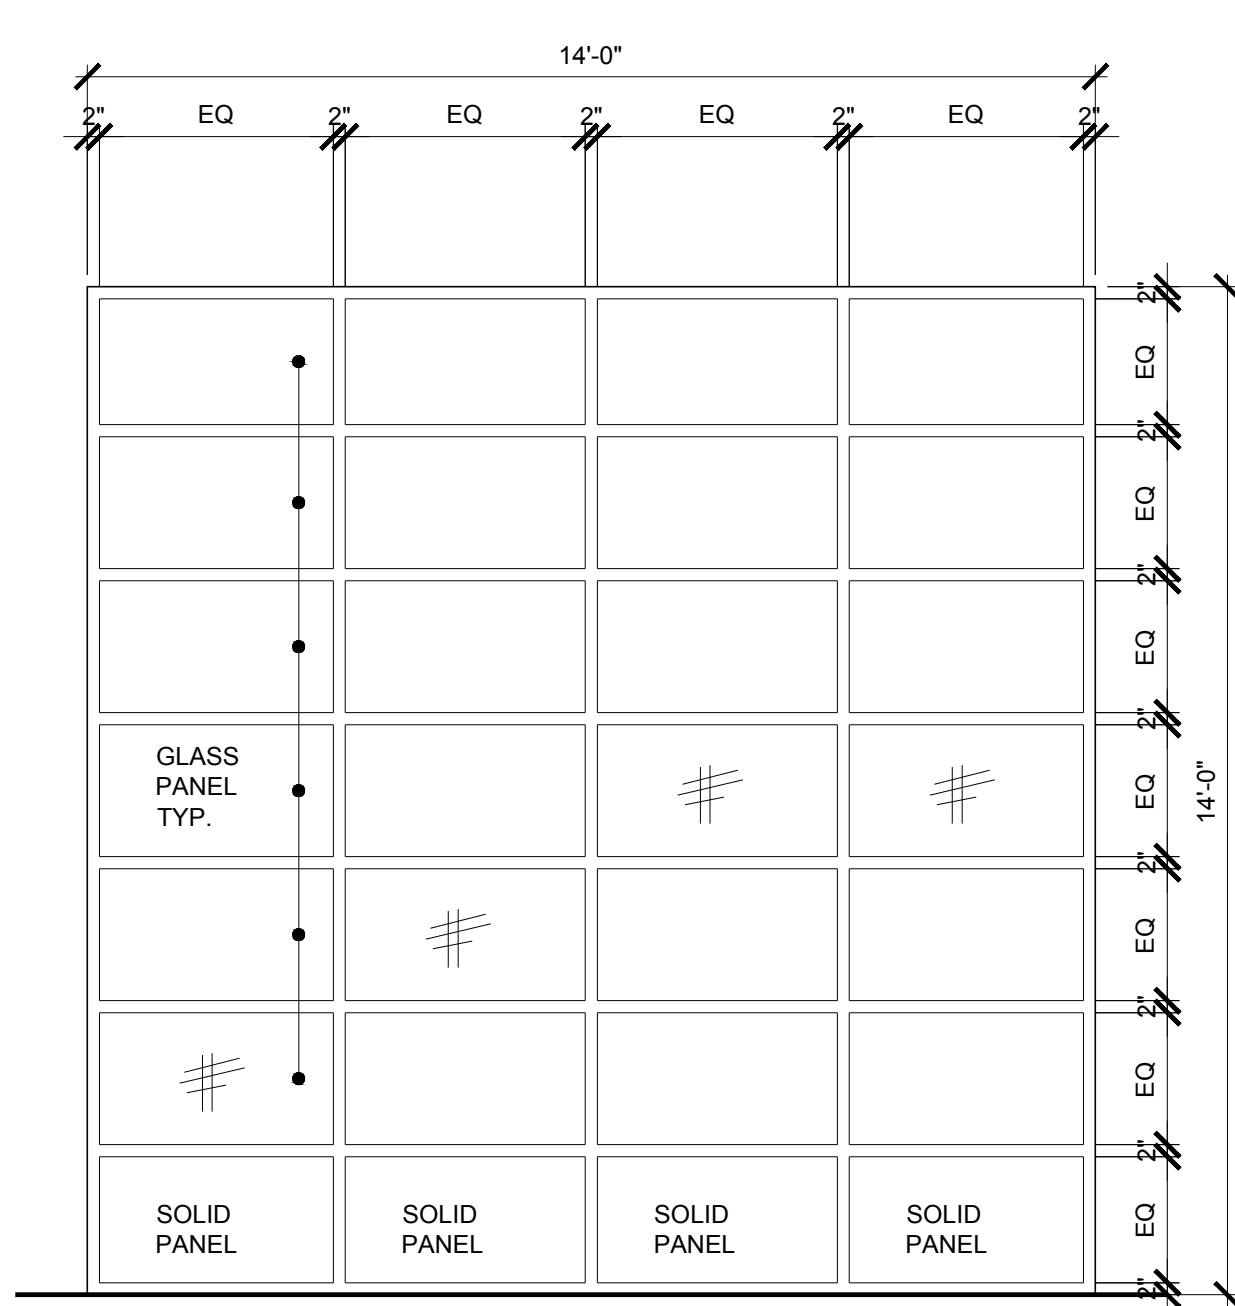


C EQUIVALENT TO OVERHEAD DOOR SERIES 521 ALUMINUM/GLASS SECTIONAL DOORS

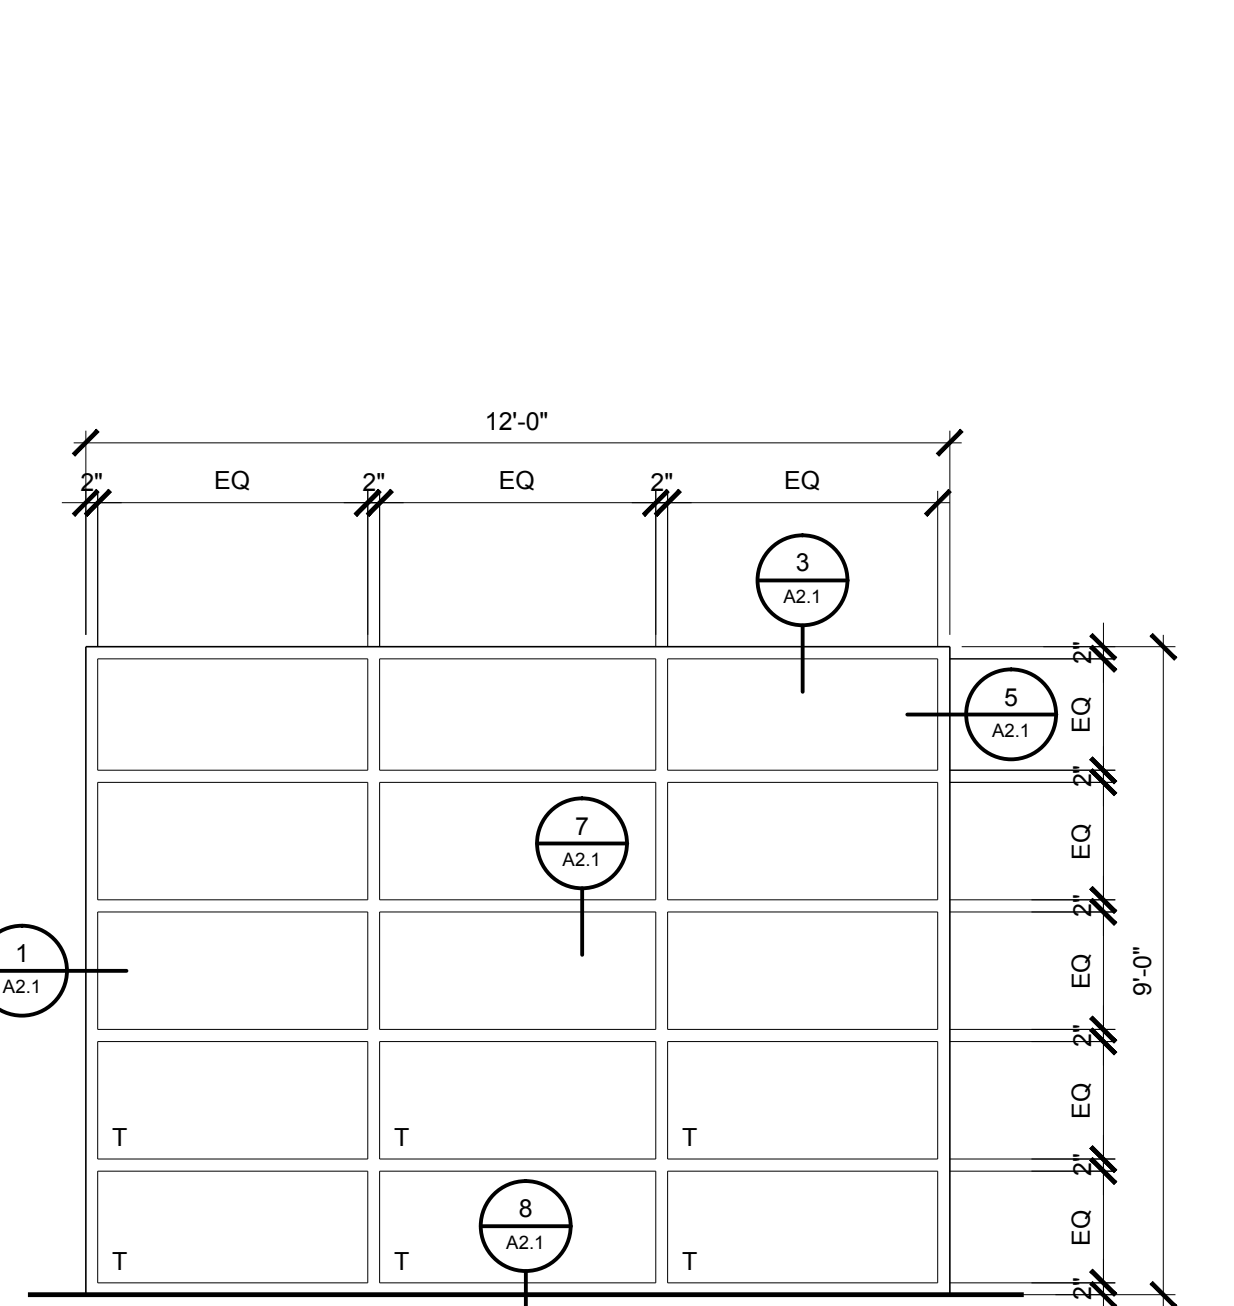


1 ALUMINUM STOREFRONT EQUAL TO KAWNEER 500 SERIES.

STOREFRONT SCHEDULE


SCALE: 3/8" = 1'-0"

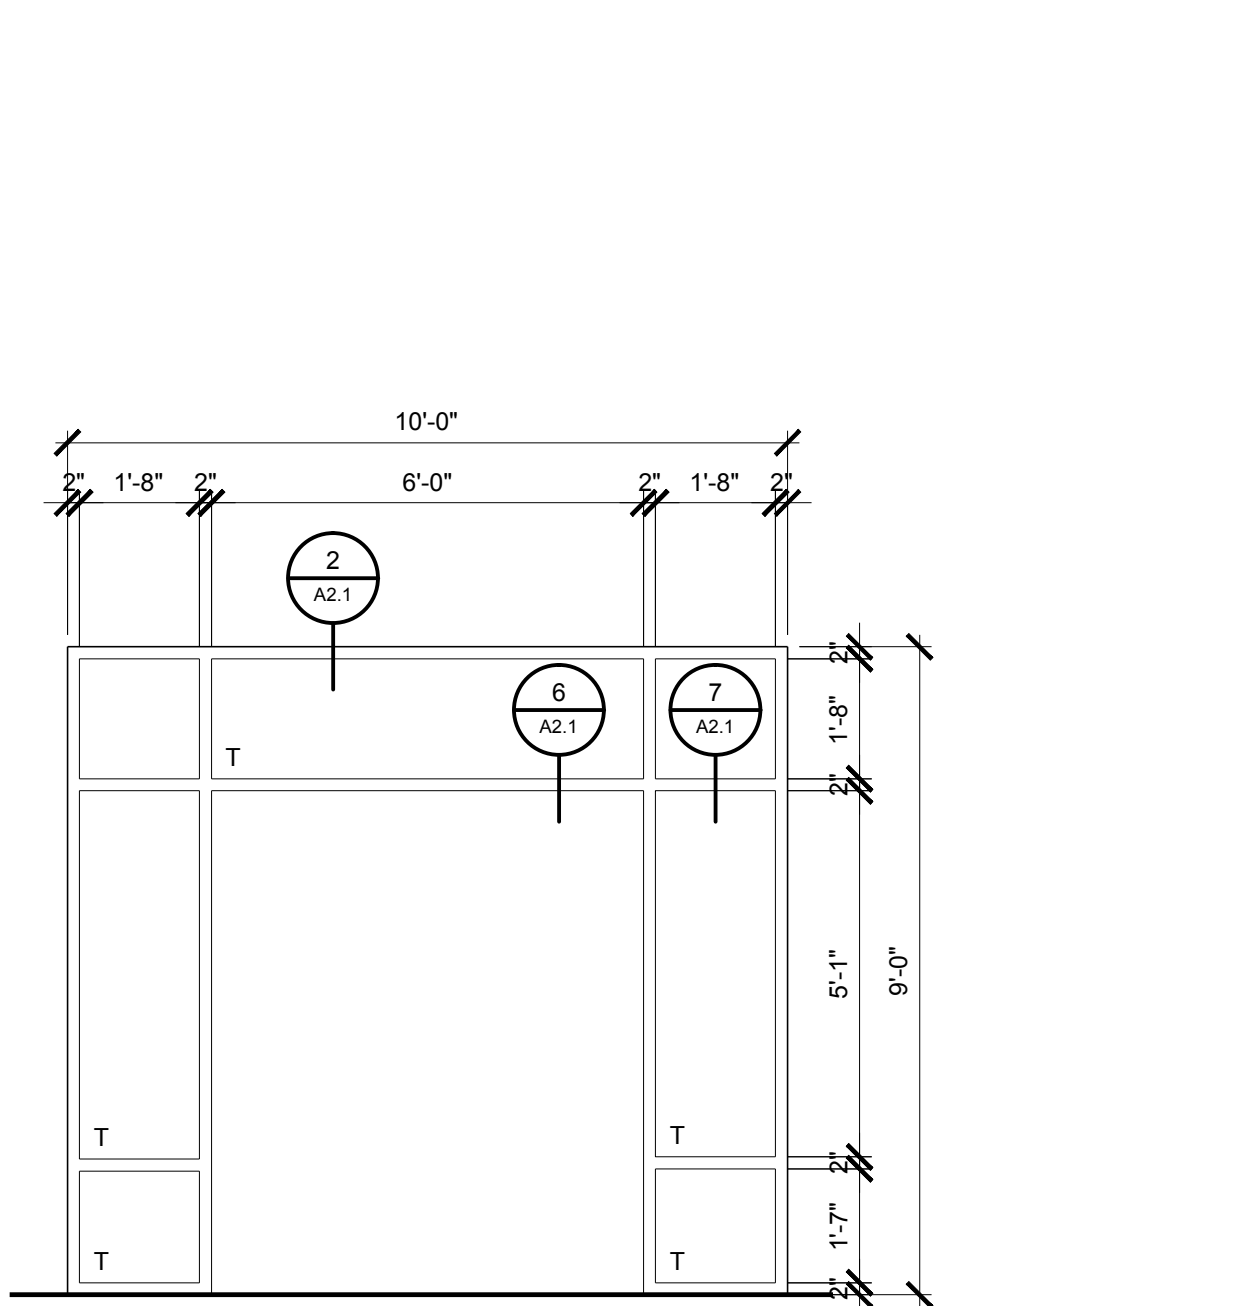


2 ALUMINUM STOREFRONT EQUAL TO KAWNEER 500 SERIES.

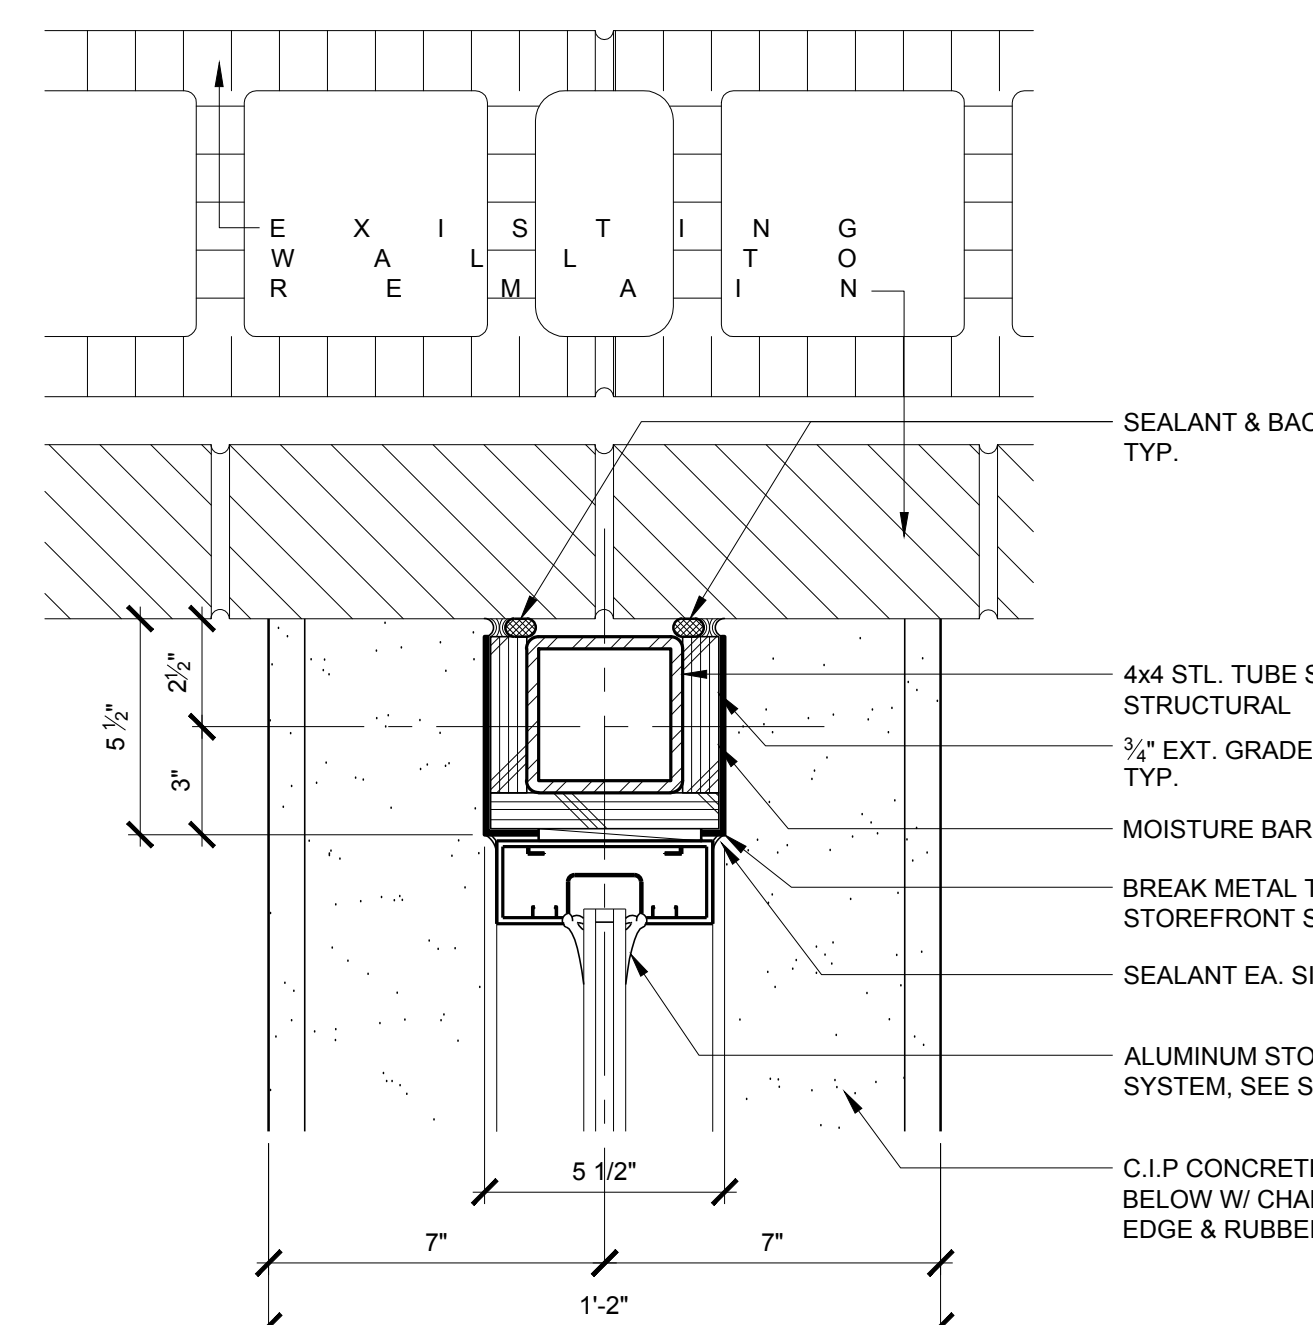


1 JAMB @ STOREFRONT
SCALE: 3" = 1'-0"

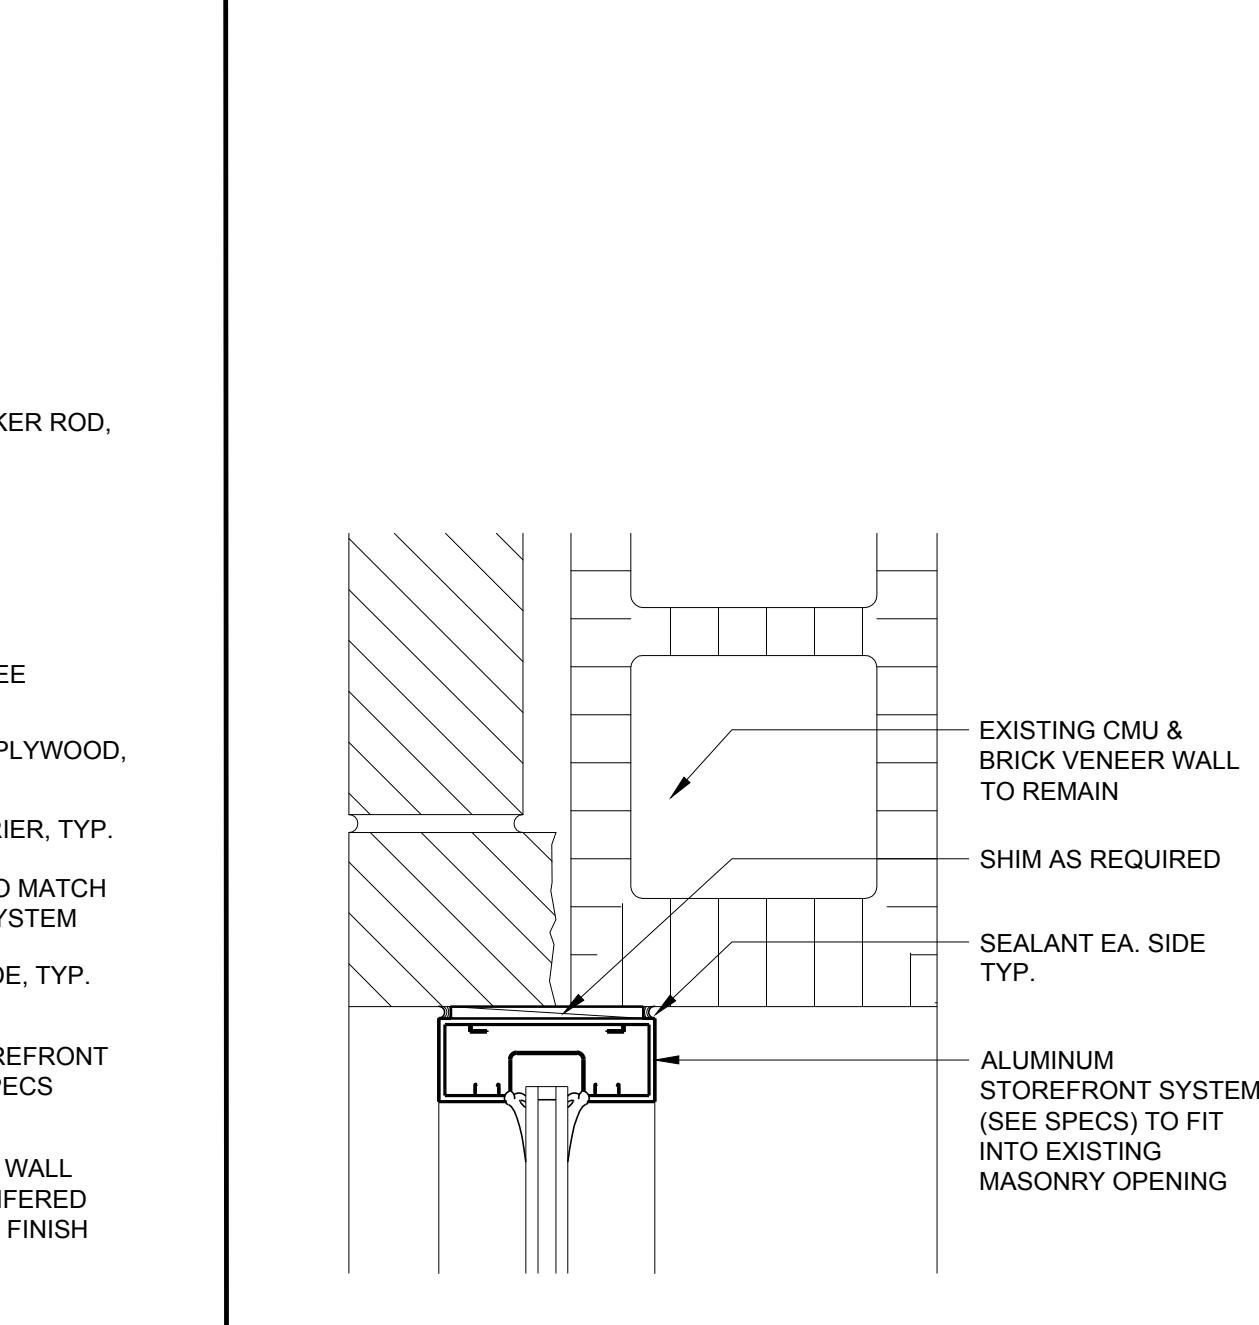


2 HEAD/JAMB @ STOREFRONT
SCALE: 3" = 1'-0"

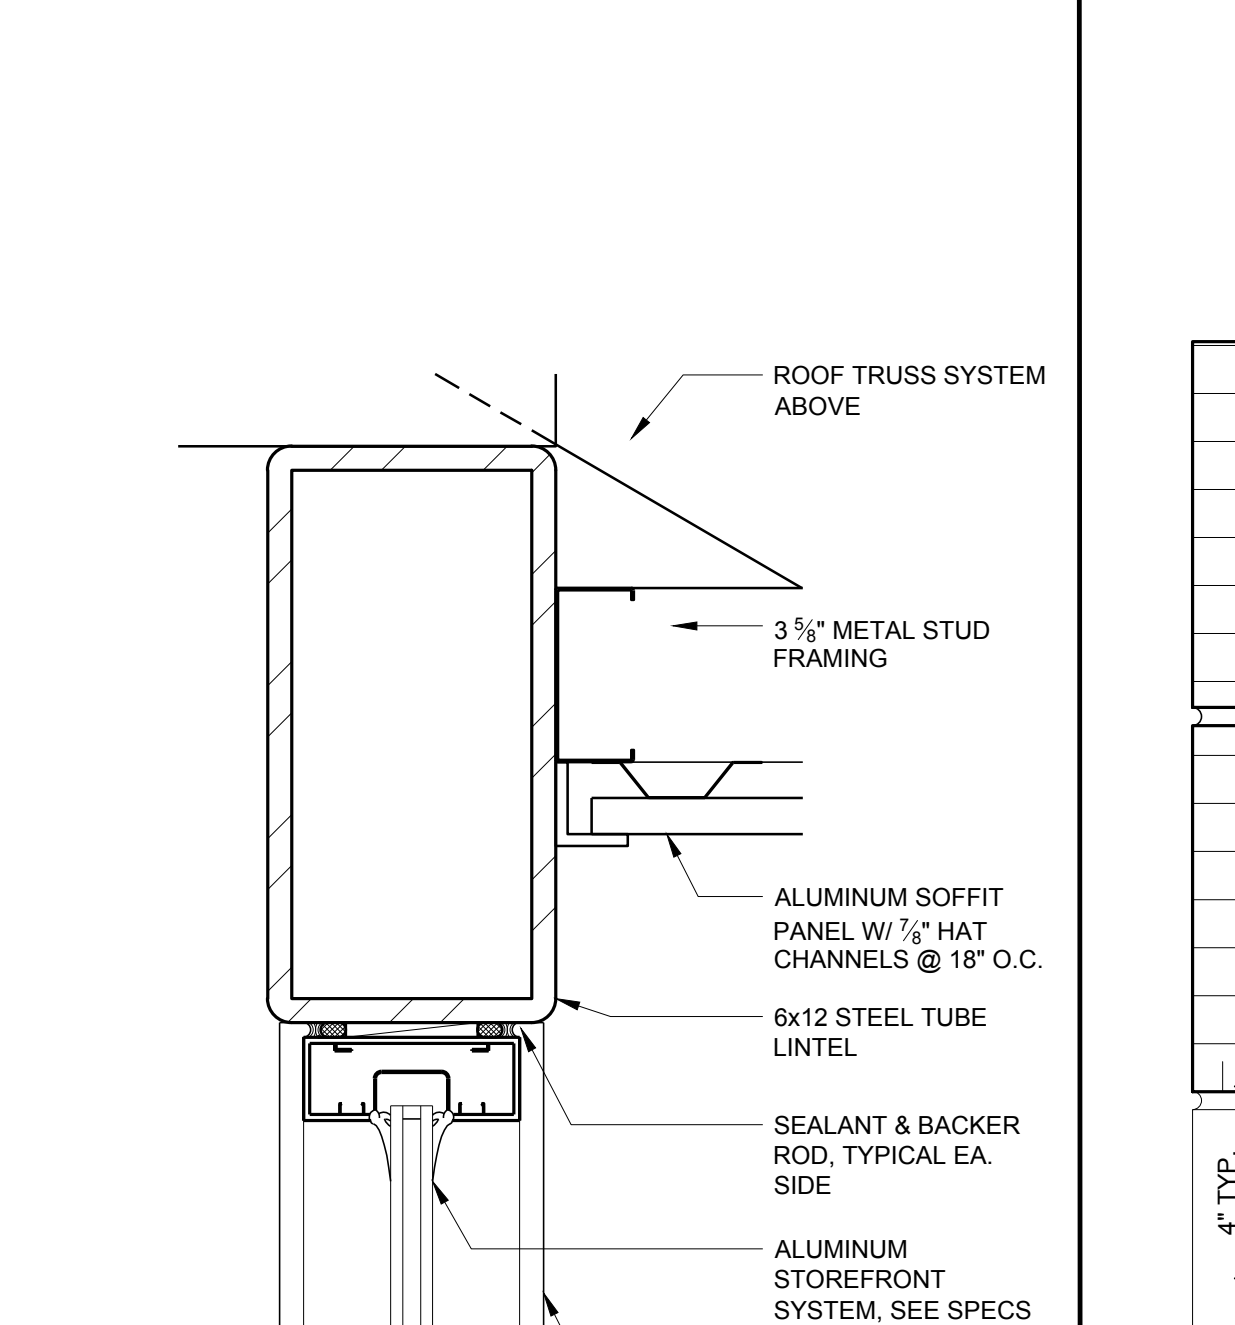


3 HEAD @ STOREFRONT
SCALE: 3" = 1'-0"

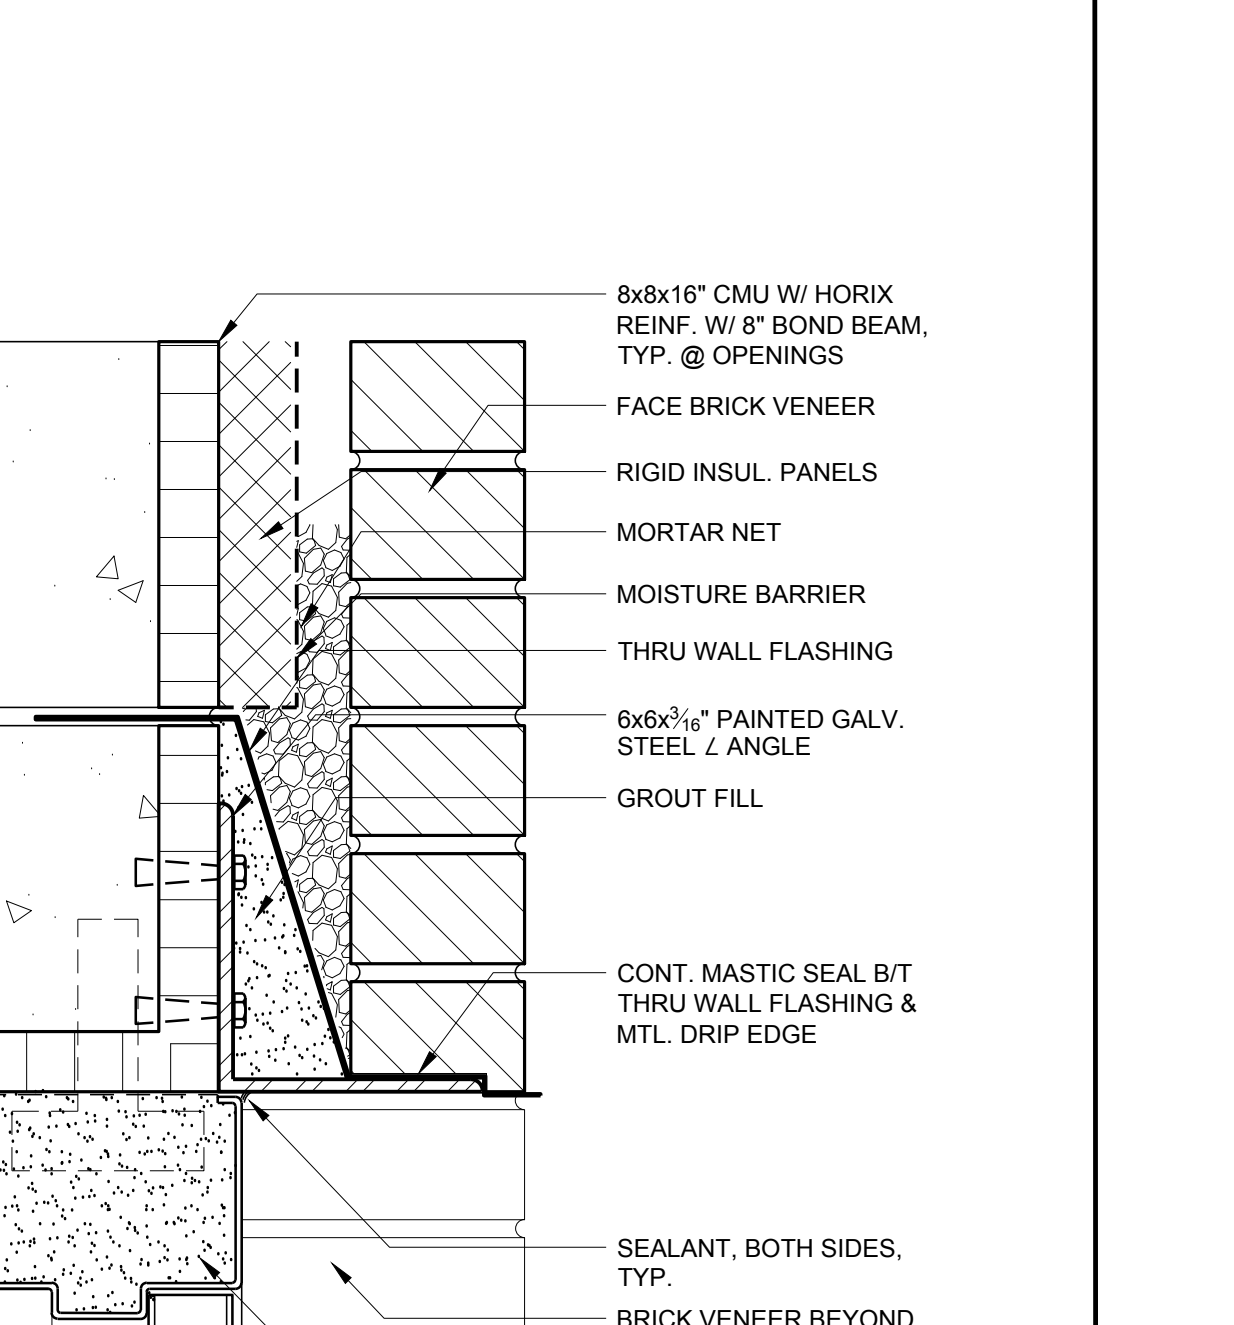


4 HEAD @ H.M. FRAME
SCALE: 3" = 1'-0"

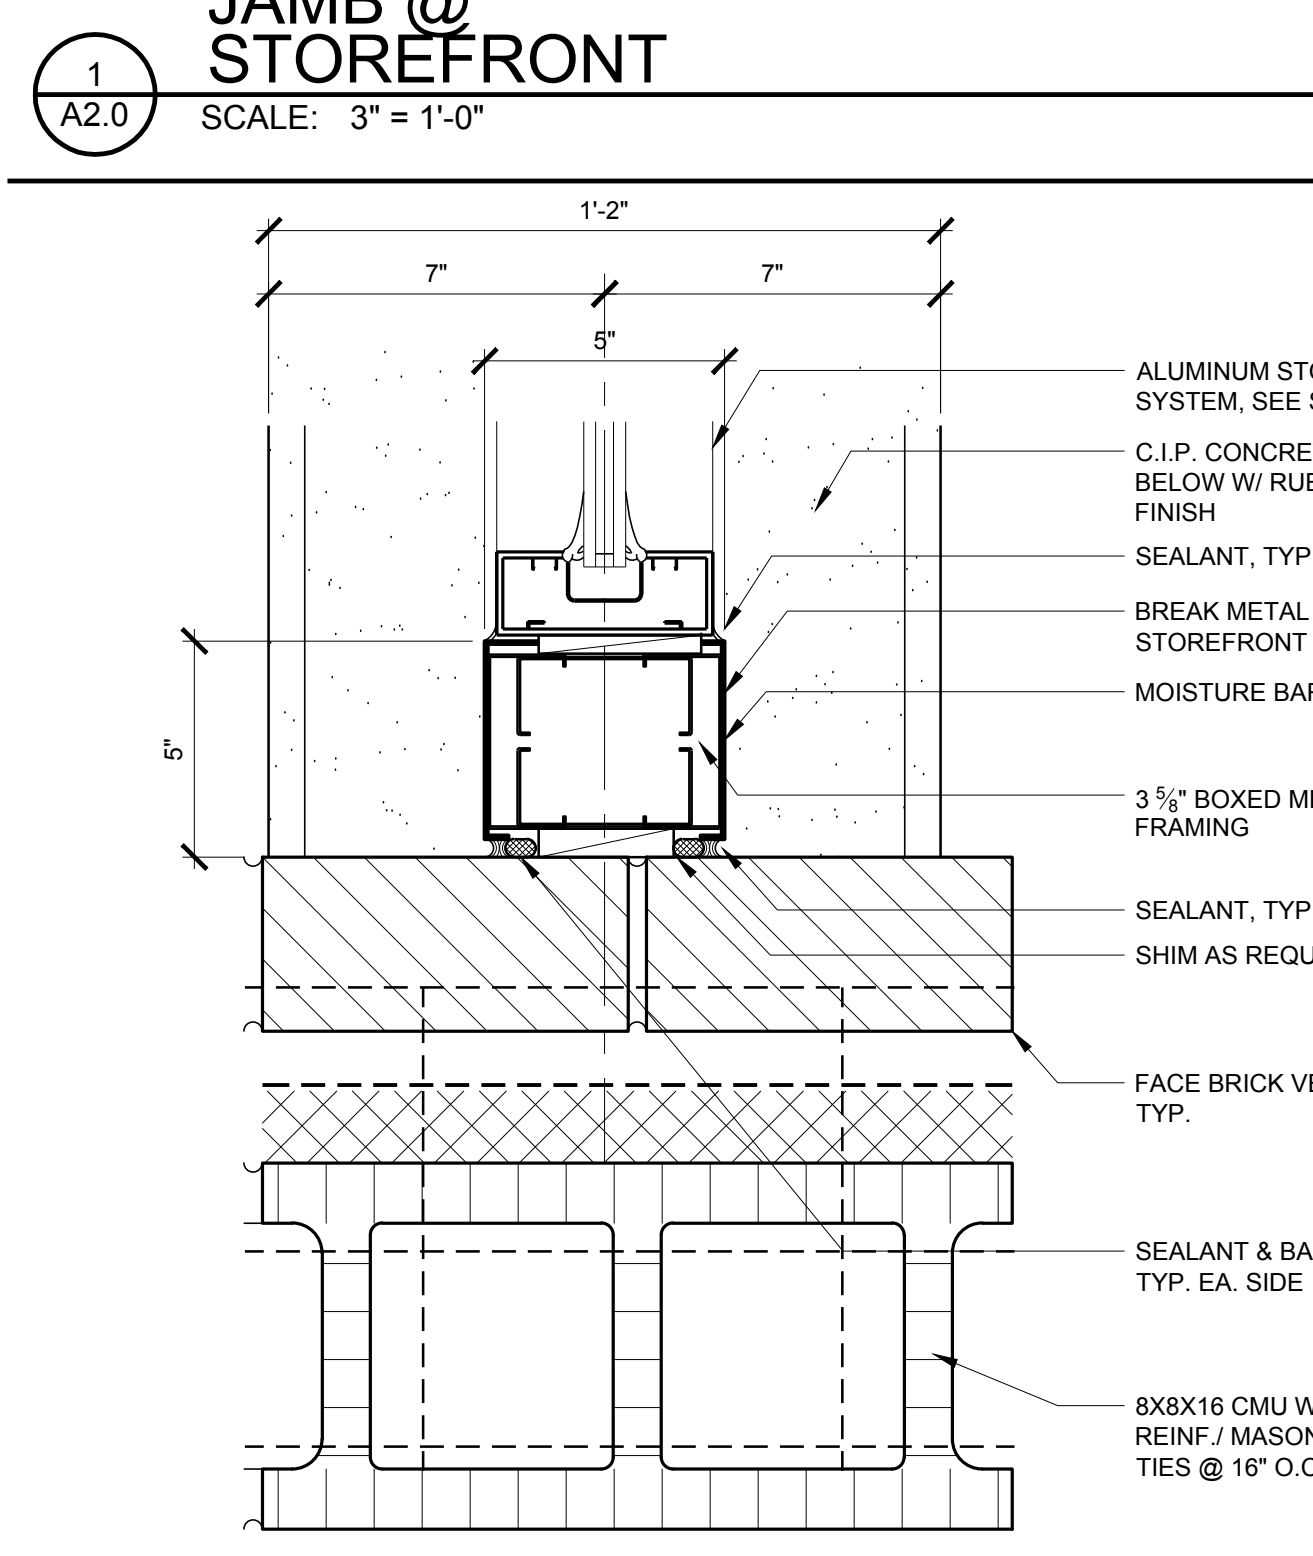


5 JAMB @ STOREFRONT
SCALE: 3" = 1'-0"

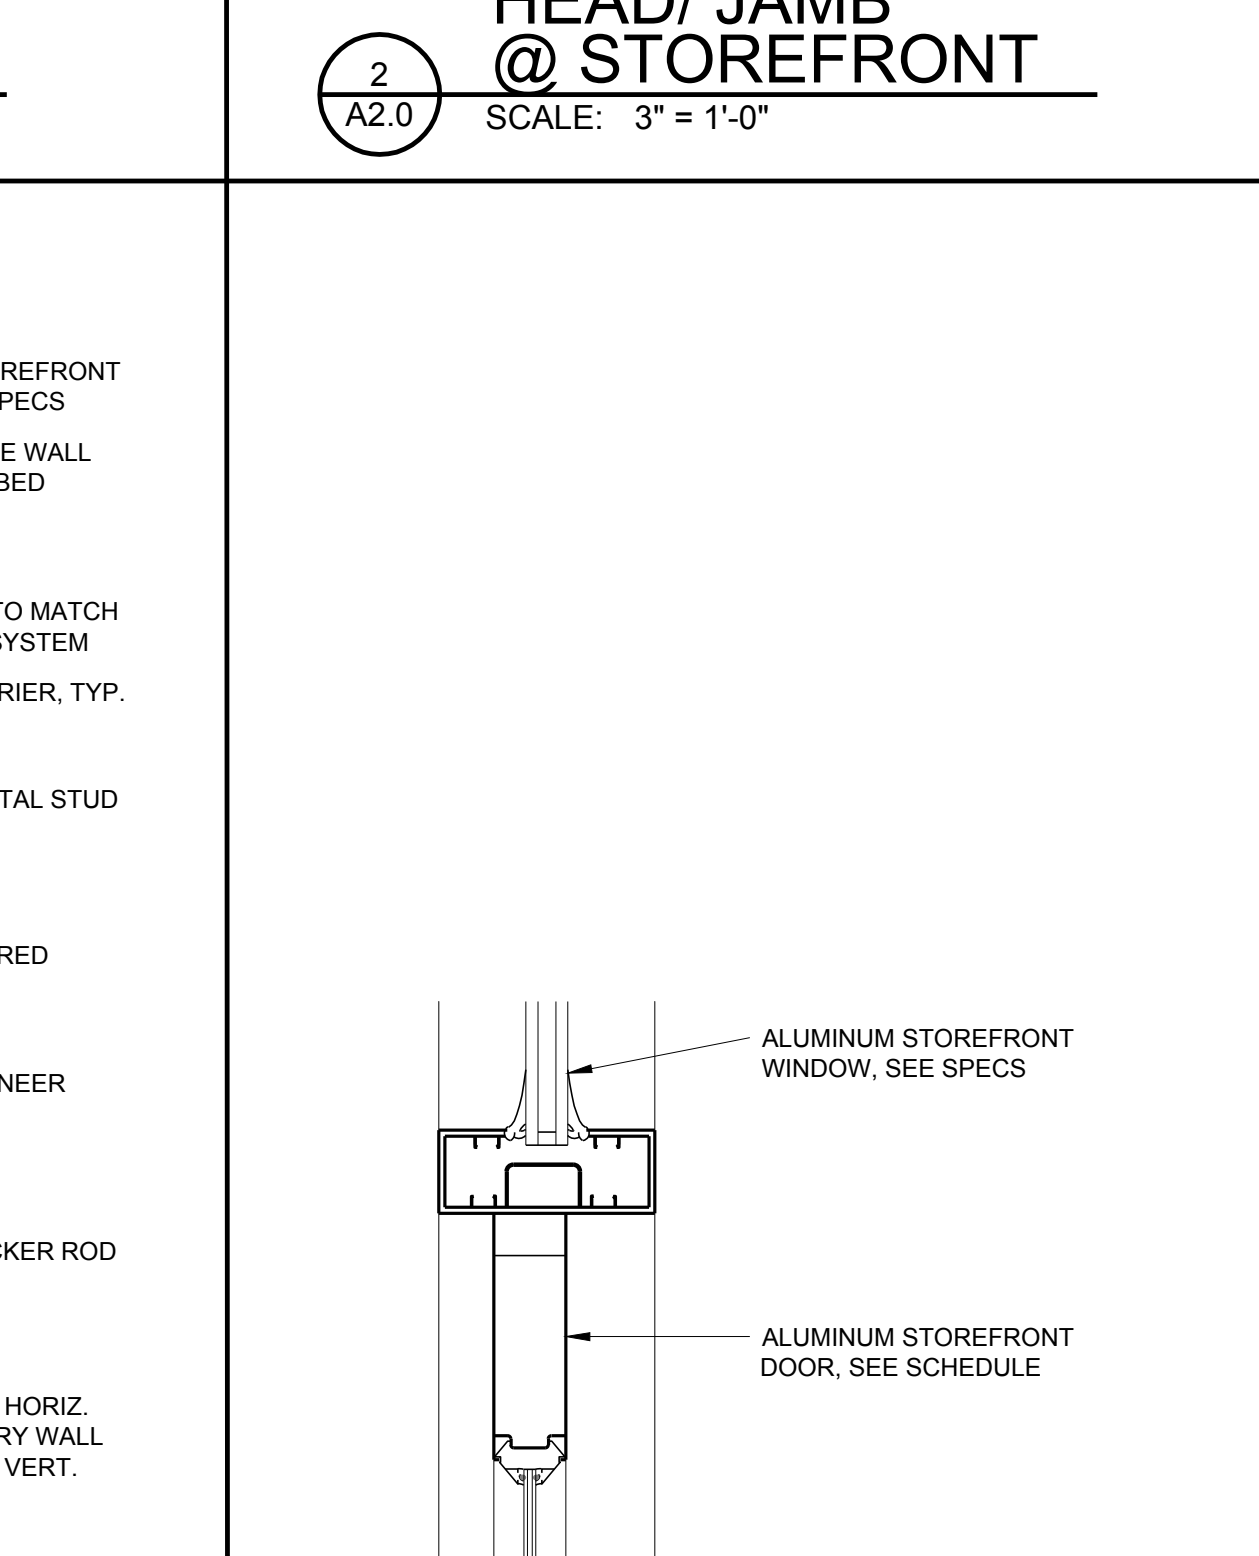


6 HEAD/JAMB @ STOREFRONT
SCALE: 3" = 1'-0"

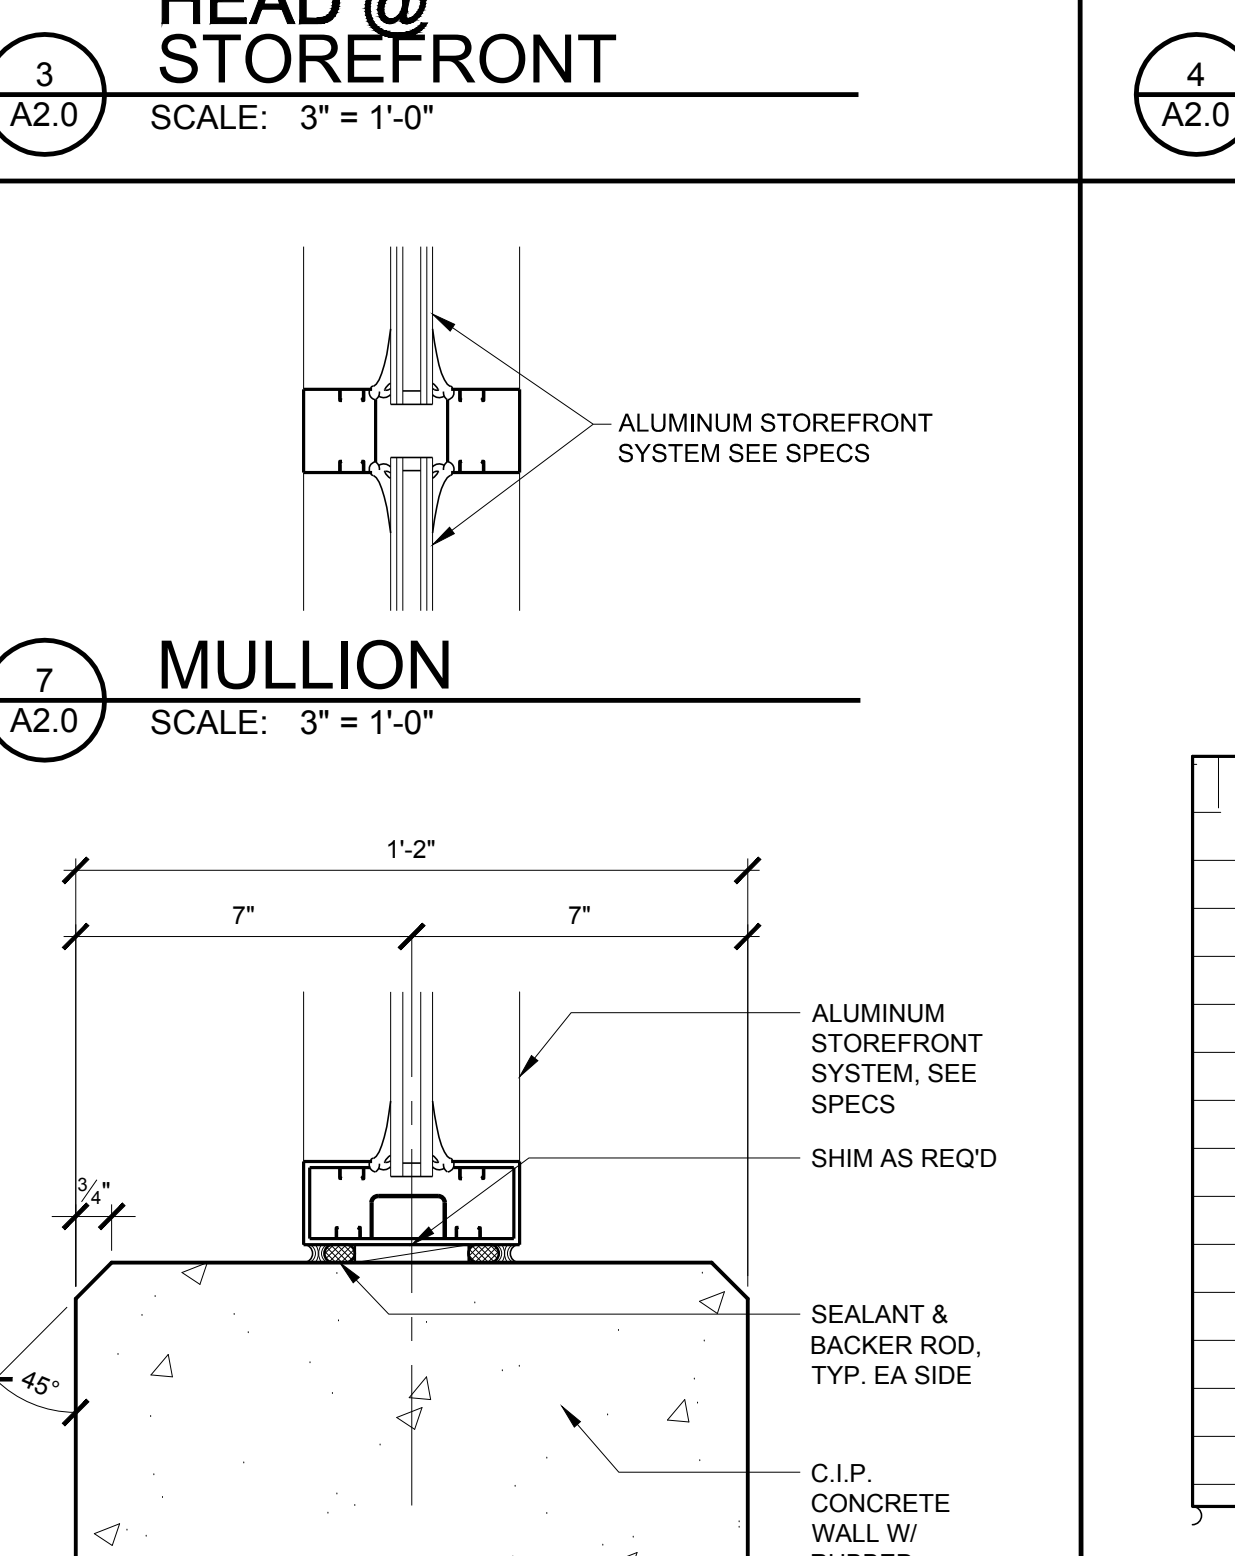

7 MULLION
SCALE: 3" = 1'-0"

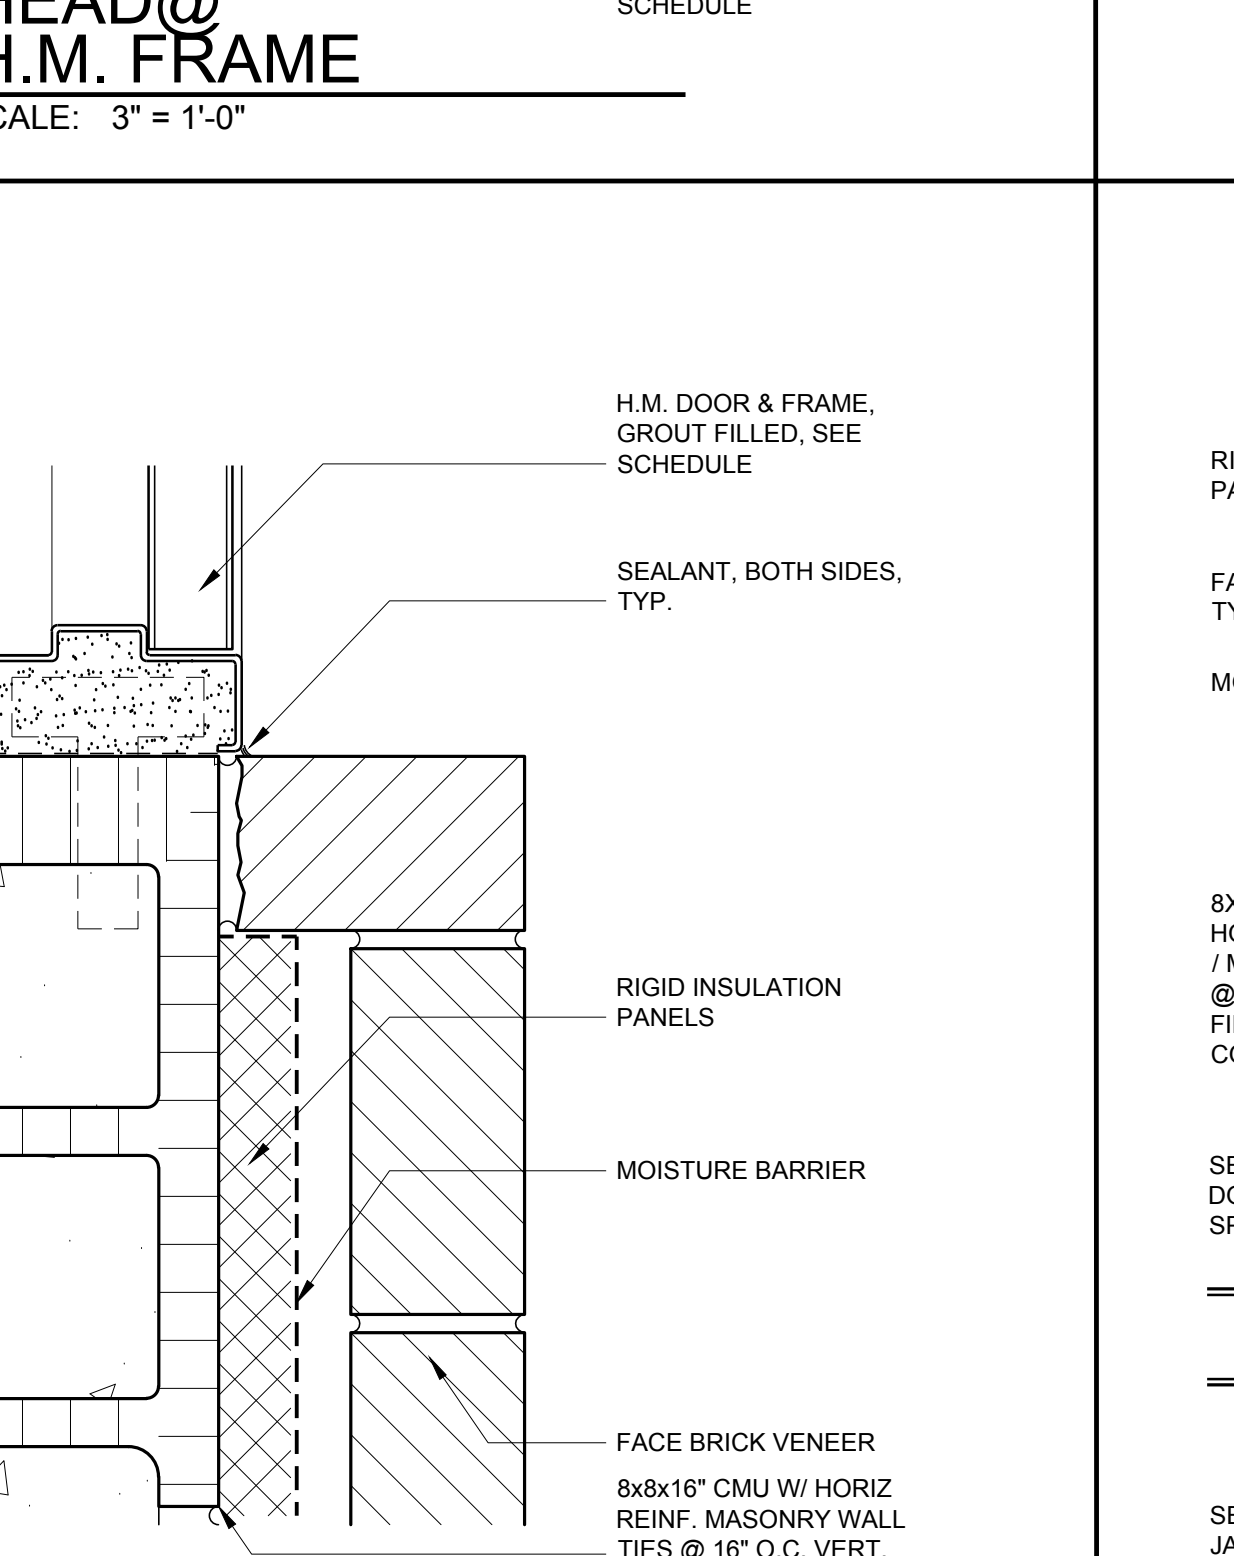


9 JAMB @ H.M. FRAME
SCALE: 3" = 1'-0"

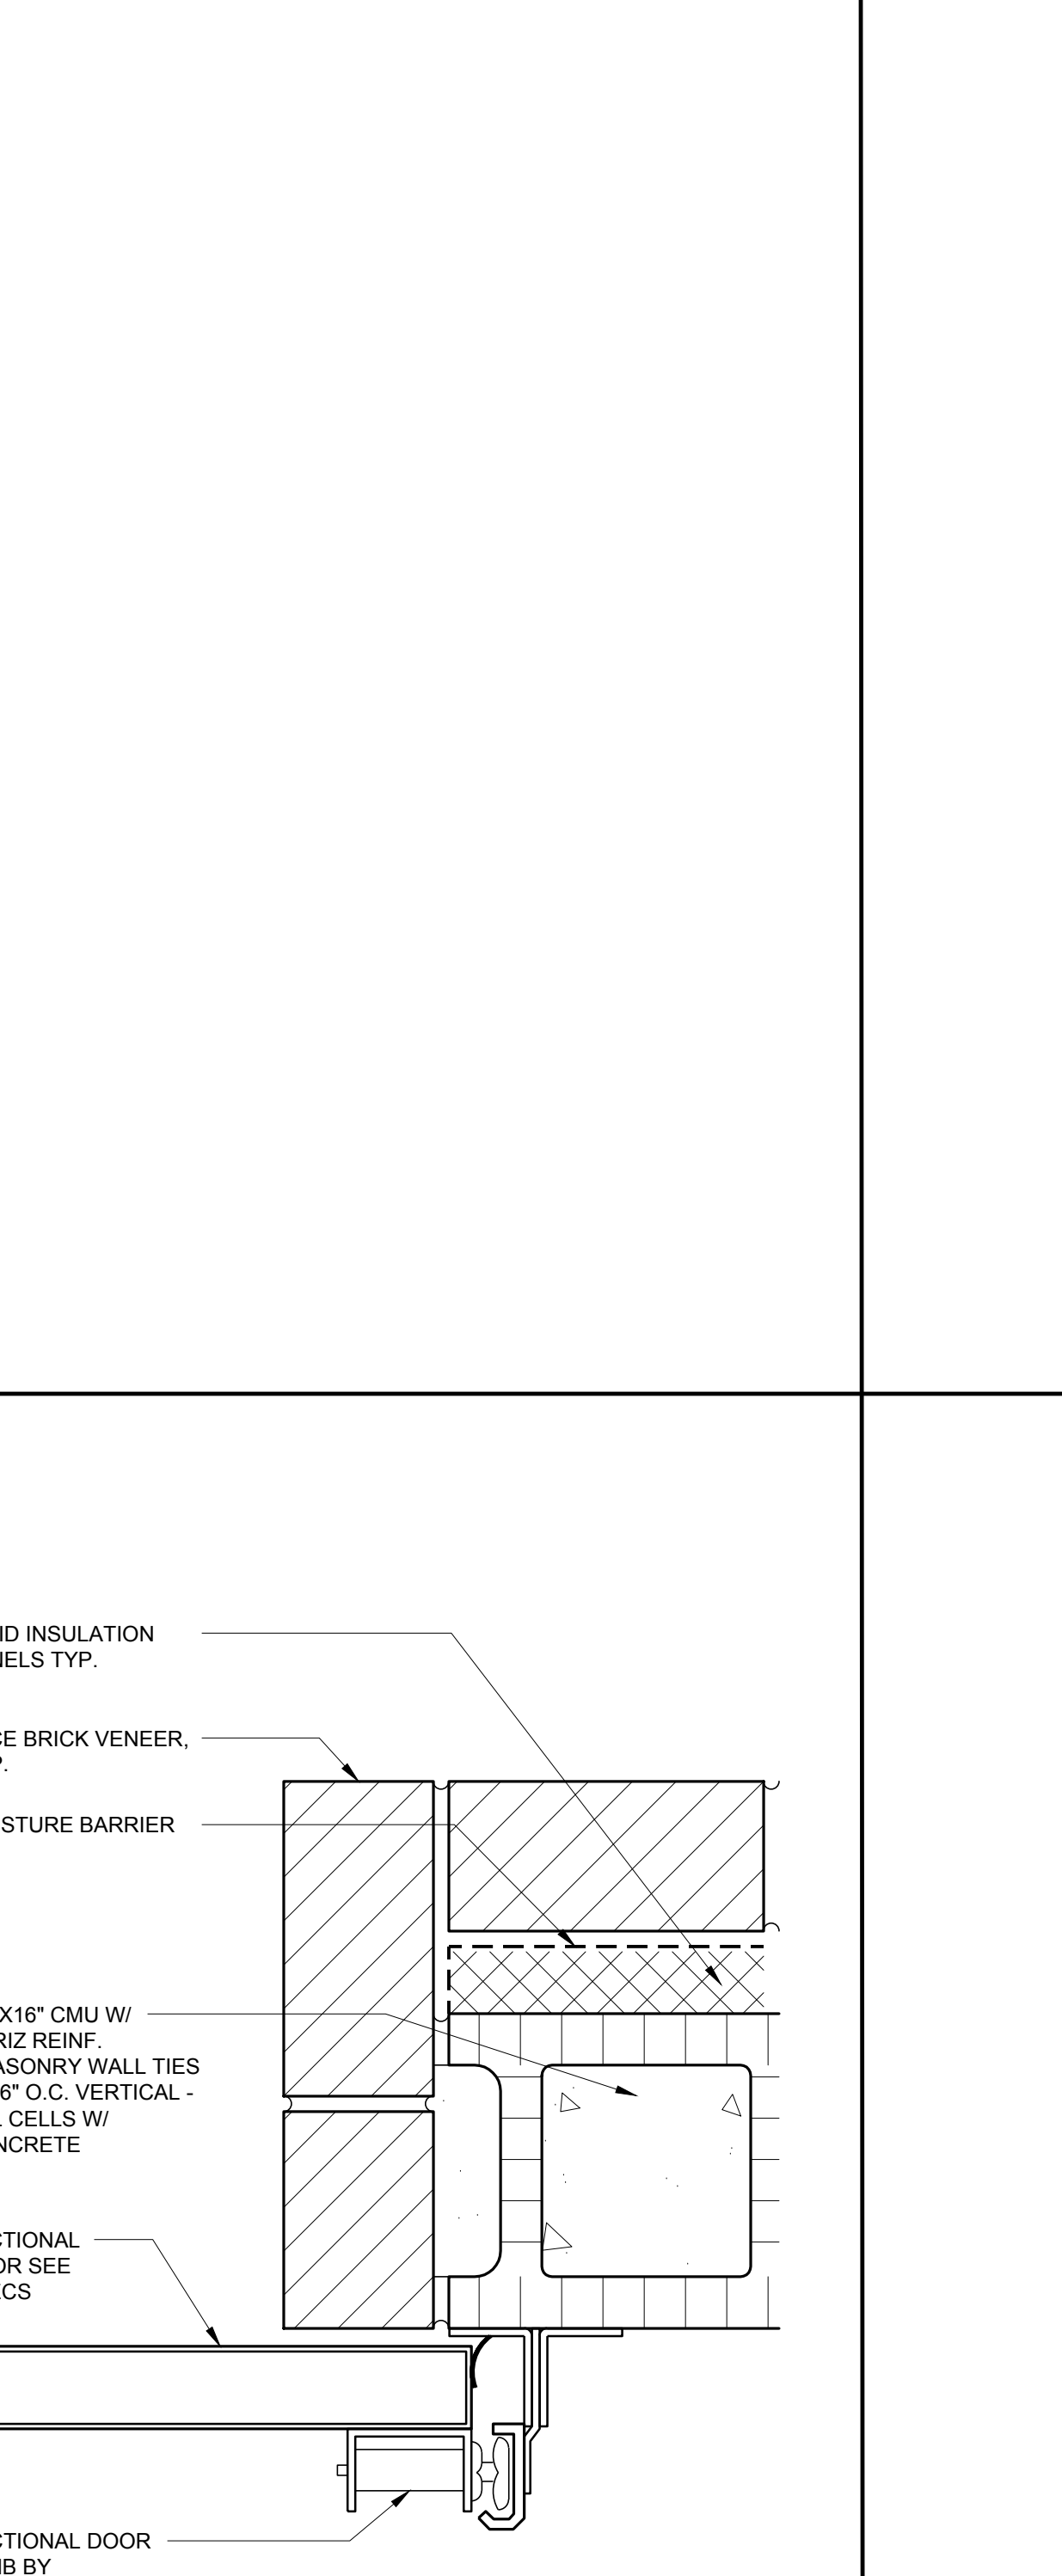

10 JAMB @ SECTIONAL DOOR
SCALE: 3" = 1'-0"

Revisions	Date

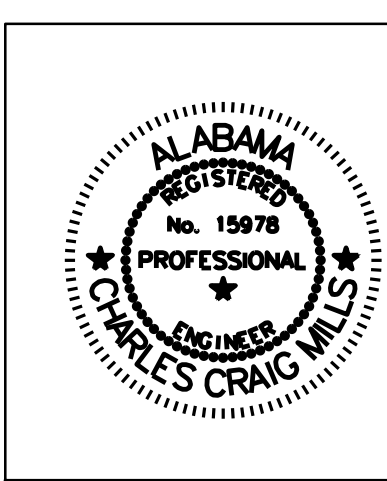

MCE MILLS-CONOLY ENGINEERING, P.C.
2818 Old Federal Road
TELEPHONE: (334) 270-0010
Montgomery, AL 36117
FAX: (334) 270-0040

CAVHCS
Central Alabama Veterans Health Care System

Approved:	
Approved:	
Approved:	
Approved:	

Approved:	
Approved:	
Approved:	
Approved:	

Drawing Title	SCHEDULES AND DETAILS
Safety Officer	
Clinical Representative	

Project Title	MODIFY FIRE BAY, B-15 CENTRAL ALABAMA VETERANS HEALTH CARE SYSTEM TUSKEGEE, ALABAMA
Building Number	15
Location	East Campus, Tuskegee, AL

Date	7/01/11
Project No.	619-10-455
DRAWING NO.	A2.0
Drawn	TH
NS	
Dep. 5	0116

Veterans Administration