

MODIFY FIRE BAY, B-15
CENTRAL ALABAMA VETERANS HEALTH CARE SYSTEM
EAST CAMPUS, TUSKEGEE, ALABAMA
PROJECT NO. 619-10-455


DRAWING INDEX

SHEET	SEQUENCE	SHEET TITLE
T1.0	1 of 16	TITLE SHEET, DRAWING INDEX AND PROJECT VICINITY MAPS
C-1	2 of 16	SITE DEMOLITION PLAN
C-2	3 of 16	SITE LAYOUT PLAN
A1.0	4 of 16	FLOOR PLAN
A2.0	5 of 16	SCHEDULES & DETAILS
A3.0	6 of 16	ELEVATIONS & DETAILS
A4.0	7 of 16	PLUMBING SECTIONS & DETAILS
SI.1	8 of 16	GENERAL NOTES AND TYPICAL DETAILS
SI.2	9 of 16	PLUMBING SITE PLAN
PI.1	10 of 16	WATER AND GAS PLUMBING PLAN
P2.1	11 of 16	WASTE PLUMBING PLAN
SP1.1	12 of 16	FIRE SPRINKLER PLAN
M1.1	13 of 16	HVAC PLAN
E1.0	14 of 16	ELECTRICAL PLAN
E1.1	15 of 16	SCHEDULES AND DETAILS

BASE BID: CONSTRUCTION OF A NEW FIRE BAY AS SHOWN ON THE PLANS AND AS SPECIFIED.
BASE BID INCLUDES CONCRETE PAVING FOR PAVED AREAS, SIDEWALKS AND STOOPS.
ALL WORK ASSOCIATED WITH TRENCH DRAIN WITH OIL/GRASE/SAND TRAP AND PIPING
FOR A COMPLETE AND OPERATIONAL OIL/GRASE DRAINAGE SYSTEM.

DEDUCTIVE ALTERNATE NO. 1 DELETE TRENCH DRAIN, OIL/GRASE/SAND TRAP AND ASSOCIATED PIPING AND ACCESSORIES.
CONCRETE FLOOR IN FIRE BAY SHALL BE LEVEL AND NOT STOPPED AS INDICATED.

DEDUCTIVE ALTERNATE NO. 2 PROVIDE ASPHALT PAVING IN LIEU OF CONCRETE PAVING AS SHOWN ON DRAWINGS. WALKWAYS
AND STOOPS TO REMAIN CONCRETE AS INDICATED.

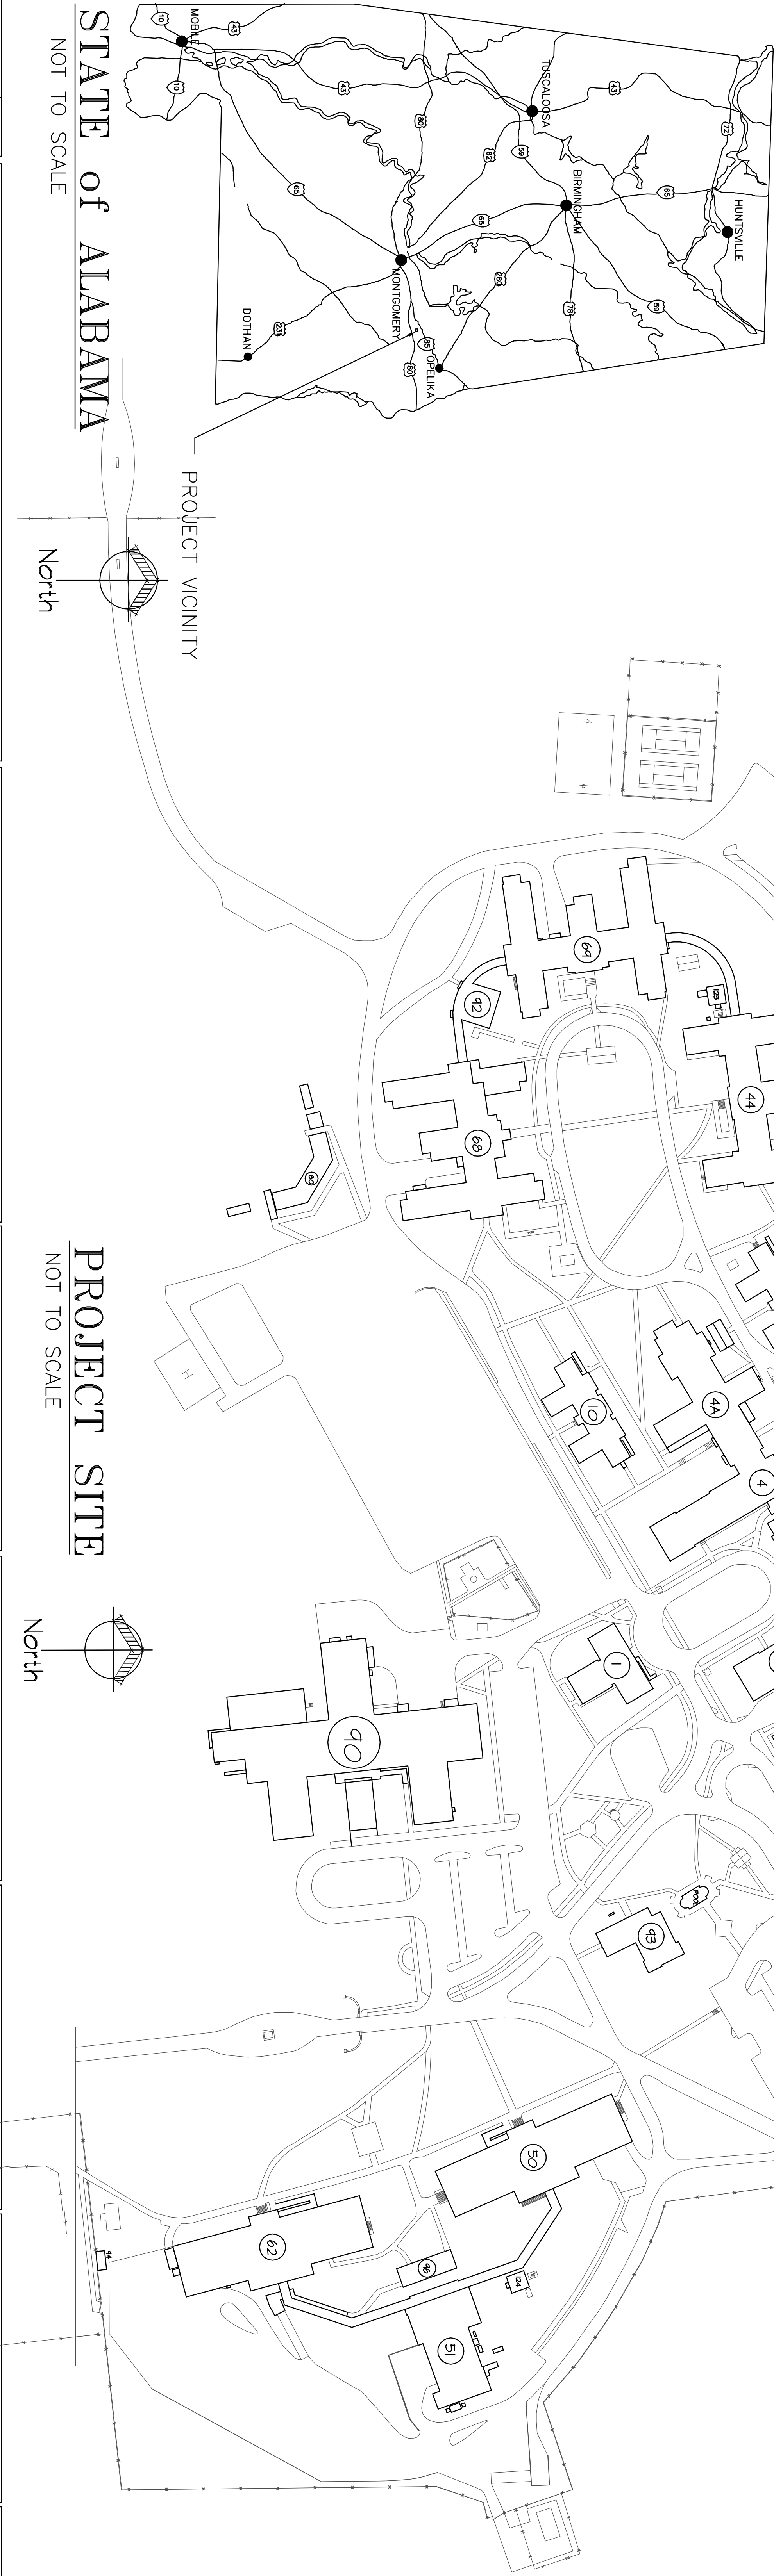

STATE of ALABAMA
NOT TO SCALE

PROJECT SITE
NOT TO SCALE

Drawing No.		Revision	
ALABAMA PROFESSIONAL ENGINEERING BOARD		MCE ENGINEERING, P.C.	
8218 Old Federal Road Montgomery, AL 36117 TELEPHONE: (334) 270-0010		FAX: (334) 270-0040	
Central Alabama Veterans Health Care System			
Approved	Approved	Drawing Title	Project Title
Approved	Approved	TITLE SHEET, DRAWING INDEX AND PROJECT VICINITY MAPS	MODIFY FIRE BAY, B-15 CENTRAL ALABAMA VETERANS HEALTH CARE SYSTEM TUSKEGEE, ALABAMA
Approved	Approved	Building Officer	Building Number
Approved	Approved	Official Representative	CCM
Approved	Approved		Division
Approved	Approved		ACM
Drawing No.		Drawing Date	
T1.0		7/01/11	
Day 1 of 16		619-10-455	
Veterans Administration			

ONE INCH = ONE FOOT

ONE INCH = ONE FOOT

F

E

D

C

B

A