


| | |
|-------------------------------|----------|
| Final-issued For Construction | 08/29/16 |
| REVISIONS | Date |
| | |
| | |
| | |
| | |
| | |
| | |
| | |

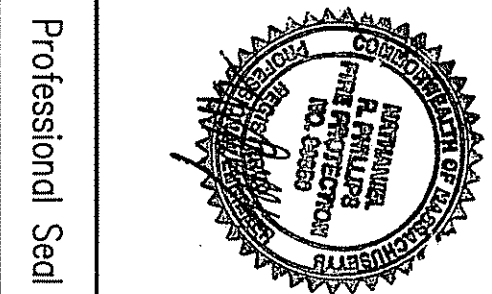

DCS INFRASTRUCTURE, LLC
DESIGN & CONSTRUCTION SERVICES
12 ELM STREET
PORT JEFFERSON, N.Y. 11777
631-320-1706

1756 BON OX ROAD
NEW OXFORD, PA 17350
717-634-6876

Drawing Title
**FIRE PROTECTION
BASEMENT PLAN**

Approved: _____
Approved: _____

Project Title
**VSN I FCA Laundry Building 45
Upgrade**

Building Number
45


Location
VAMC Brockton Campus

Date
August 29, 2016

Project No.
52345-10-316


Drawing No.
45-FA-2

Dwg. 71 of 96

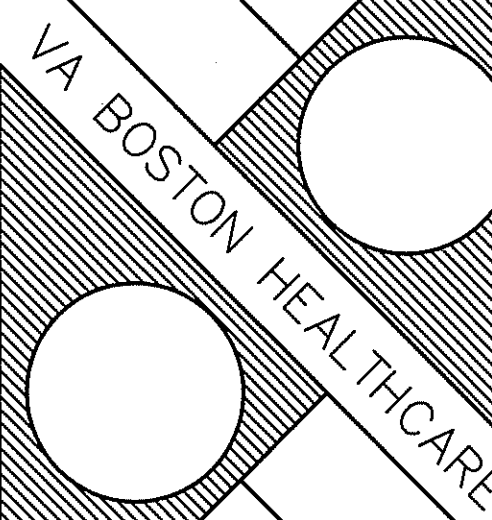

Department of
Veterans Affairs


1 BASEMENT PLAN
45-FA-2 SCALE: 1/8" = 1'-0"

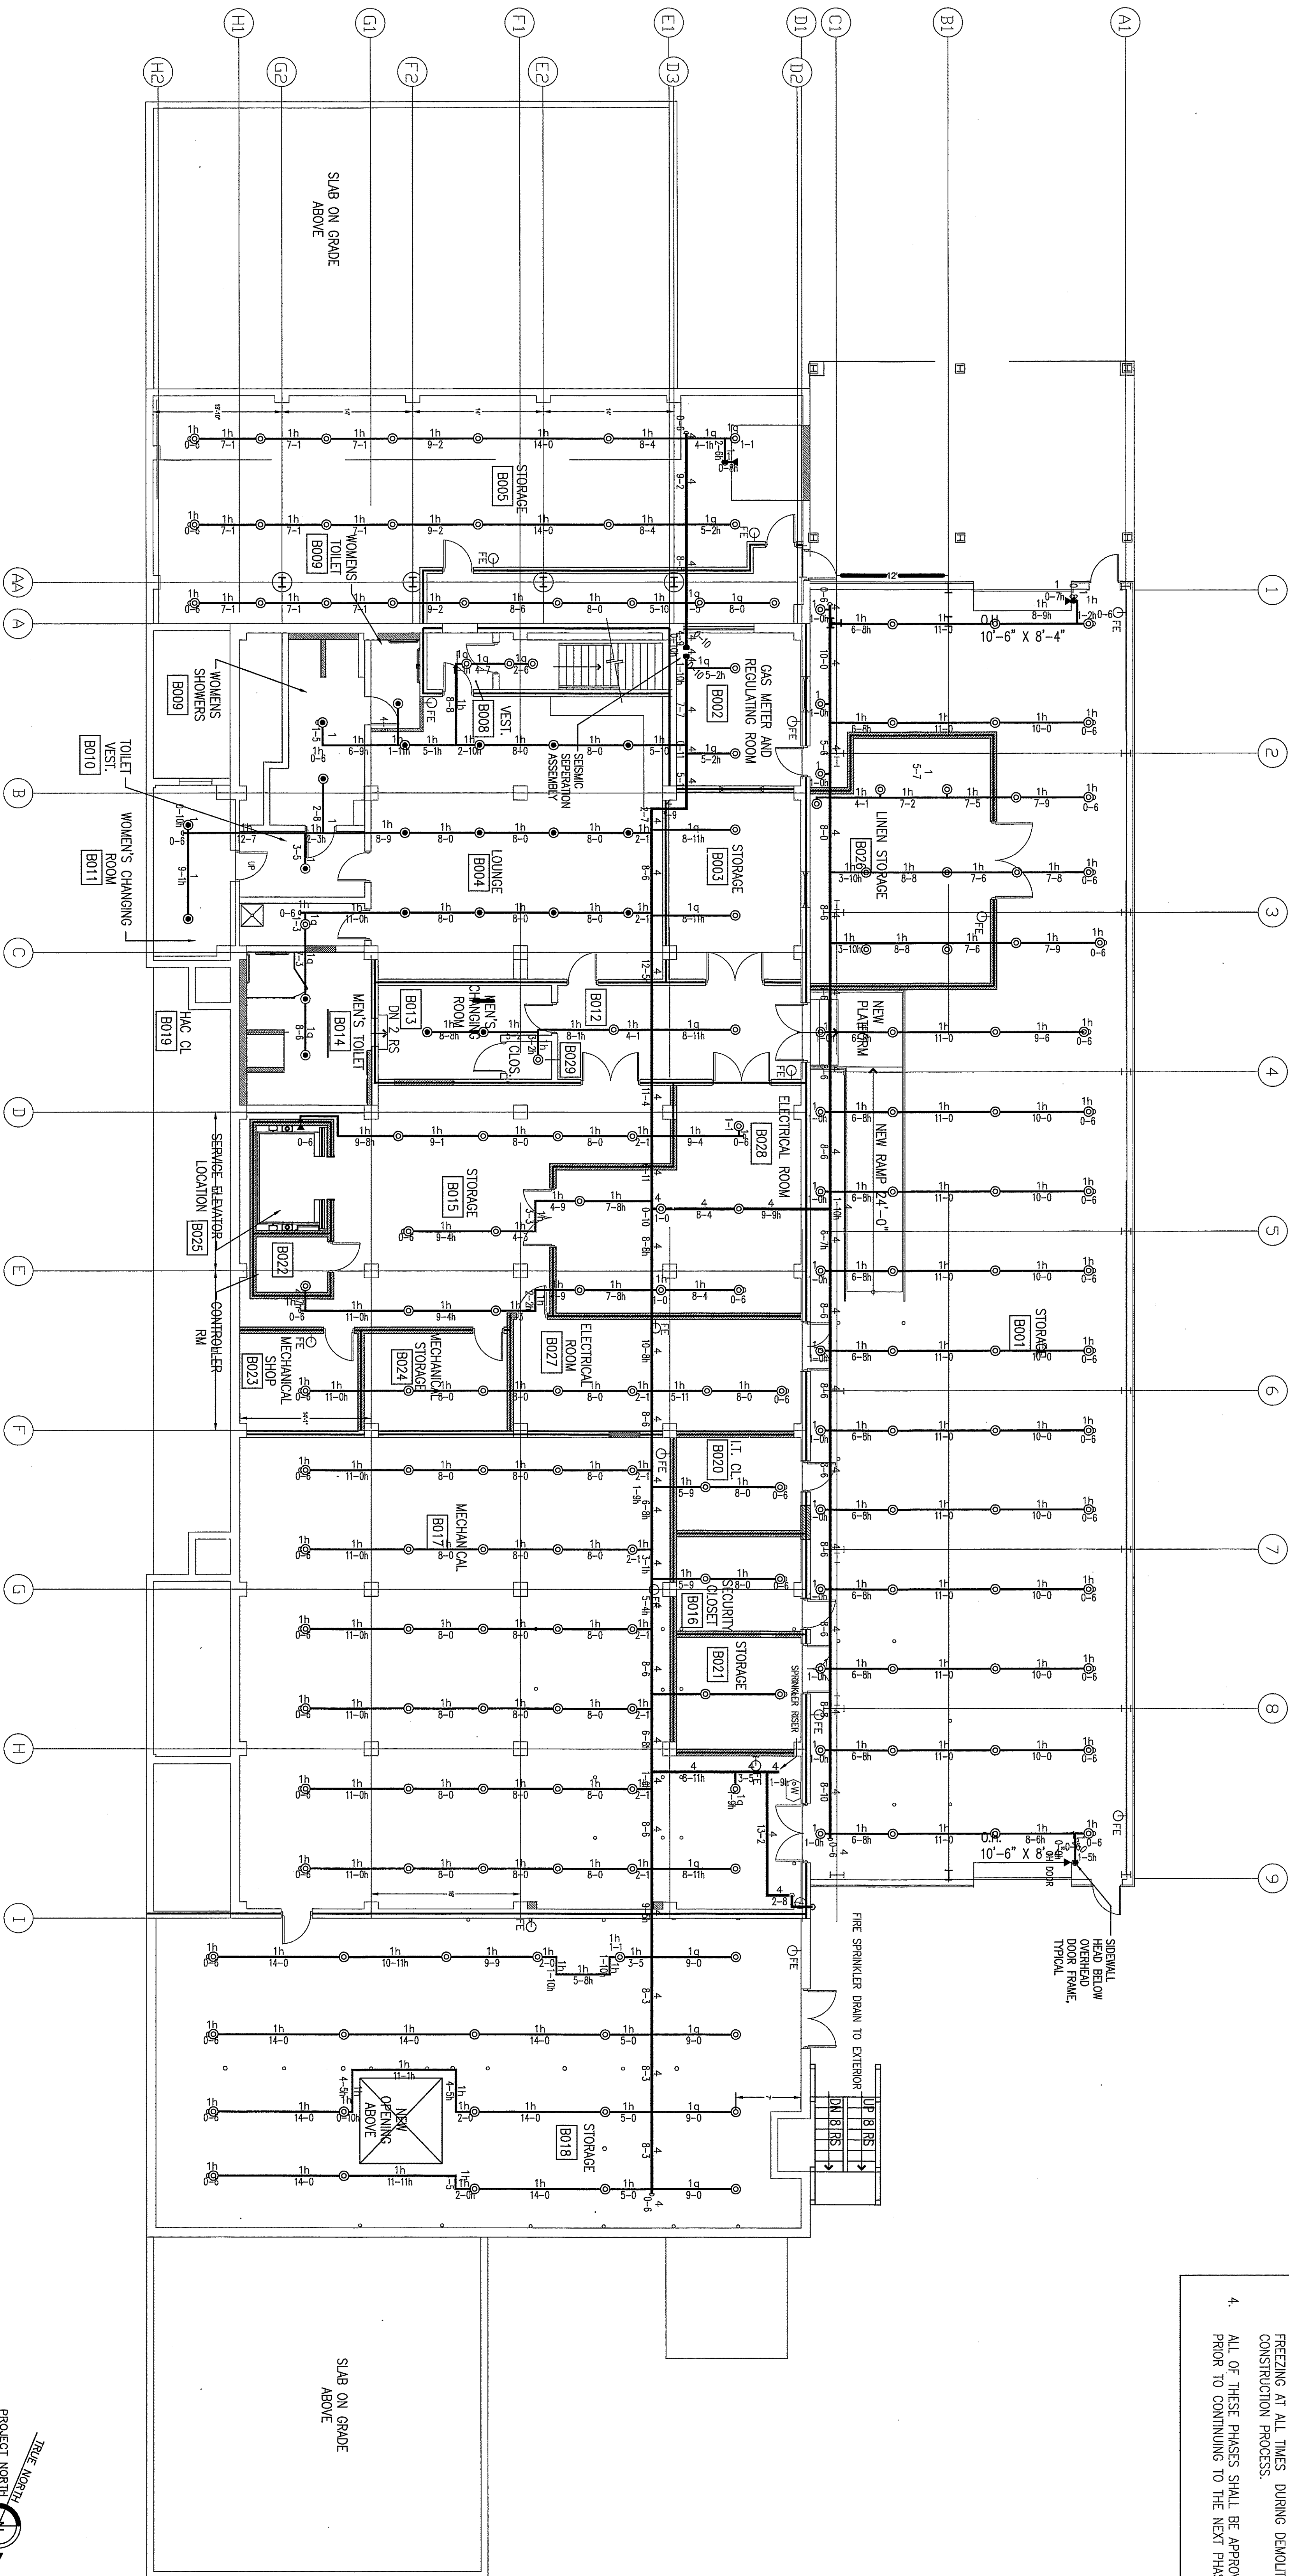


NOTE: SPRINKLER CONTRACTOR TO
PROVIDE SHOP DRAWINGS FOR ALL
NEW WORK AND MAKE AVAILABLE TO
ALL TRADES. NEW WORK TO BE
DIRECTLY COORDINATED WITH MEP
TRADES.


- FIRE PROTECTION PHASING NOTES:**
1. FIRE SPRINKLER SYSTEM SHALL REMAIN IN PLACE UNTIL THE FINAL PHASE OF DEMOLITION IS TO BEGIN.
 2. AS SOON AS BOTH THE FIRE ALARM SYSTEM AND SPRINKLER SYSTEM ARE NOT OPERATIONAL A 24 HOUR FIRE WATCH SHALL BE REQUIRED.
 3. THE FIRE SPRINKLER SYSTEM IS TO BE PROTECTED FROM FREEZING AT ALL TIMES DURING DEMOLITION AND CONSTRUCTION PROCESS.
 4. ALL OF THESE PHASES SHALL BE APPROVED BY THE COR PRIOR TO CONTINUING TO THE NEXT PHASE.

FINAL-ISSUED FOR CONSTRUCTION
Fully Sprinklered

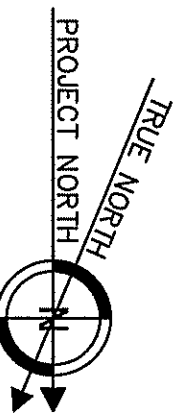

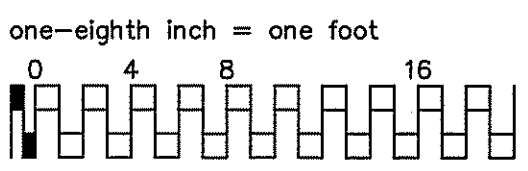

NOTE:
SPRINKLER CONTRACTOR TO
PROVIDE SHOP DRAWINGS FOR ALL
NEW WORK AND MAKE AVAILABLE TO
ALL TRADES. NEW WORK TO BE
DIRECTLY COORDINATED WITH MEP
TRADES.

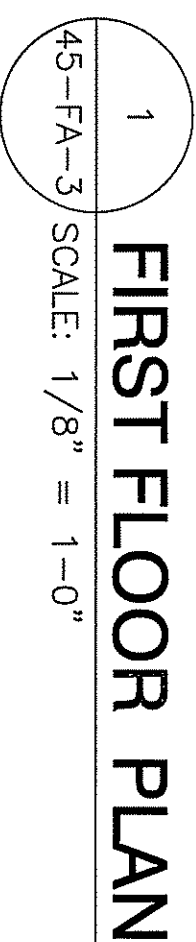 Department of
Veterans Affairs