

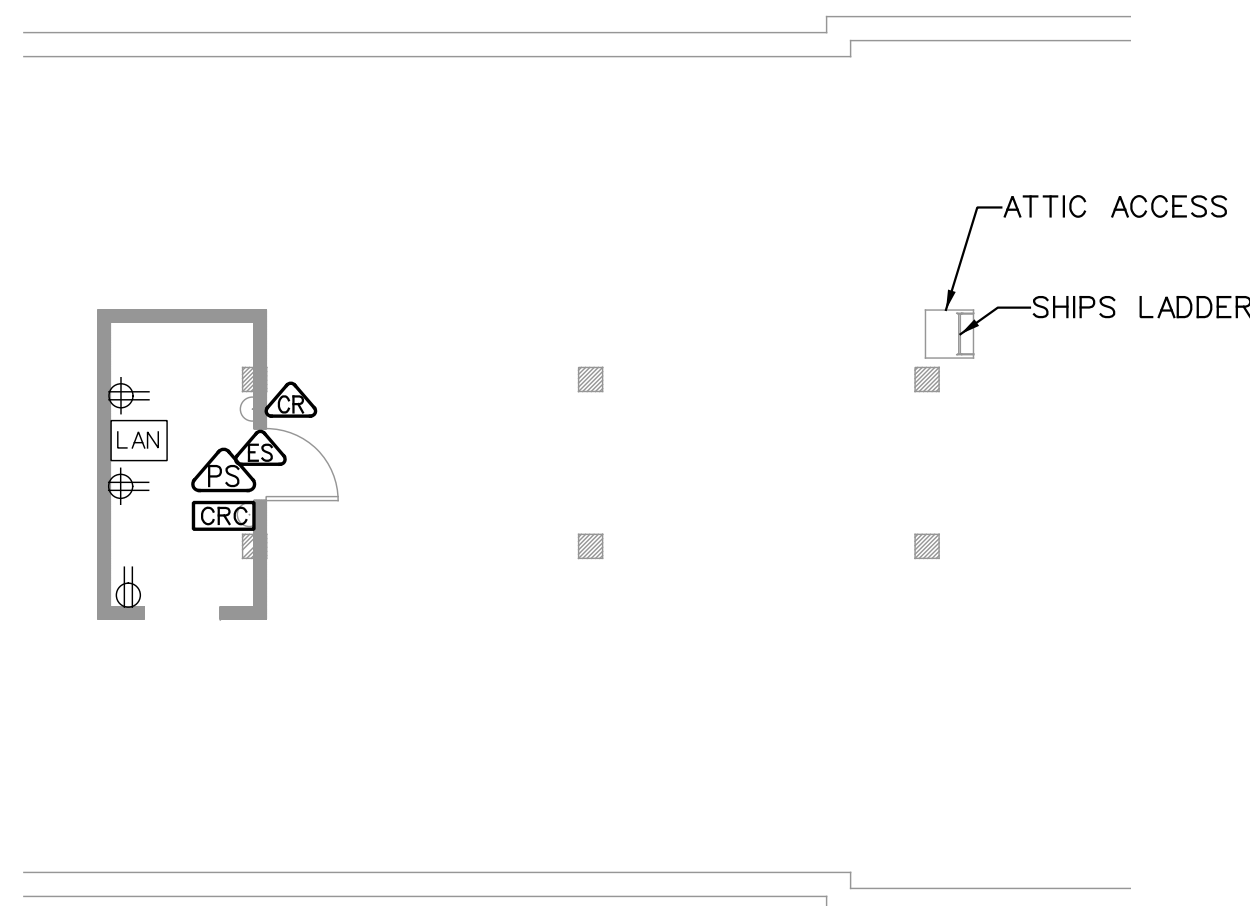



 **BUILDING 1 – BASEMENT ROOM 001E**  
SCALE: 1/4" = 1'-0"

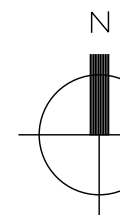


 **BUILDING 1 – ATTIC**  
SCALE: 1/8" = 1'-0"

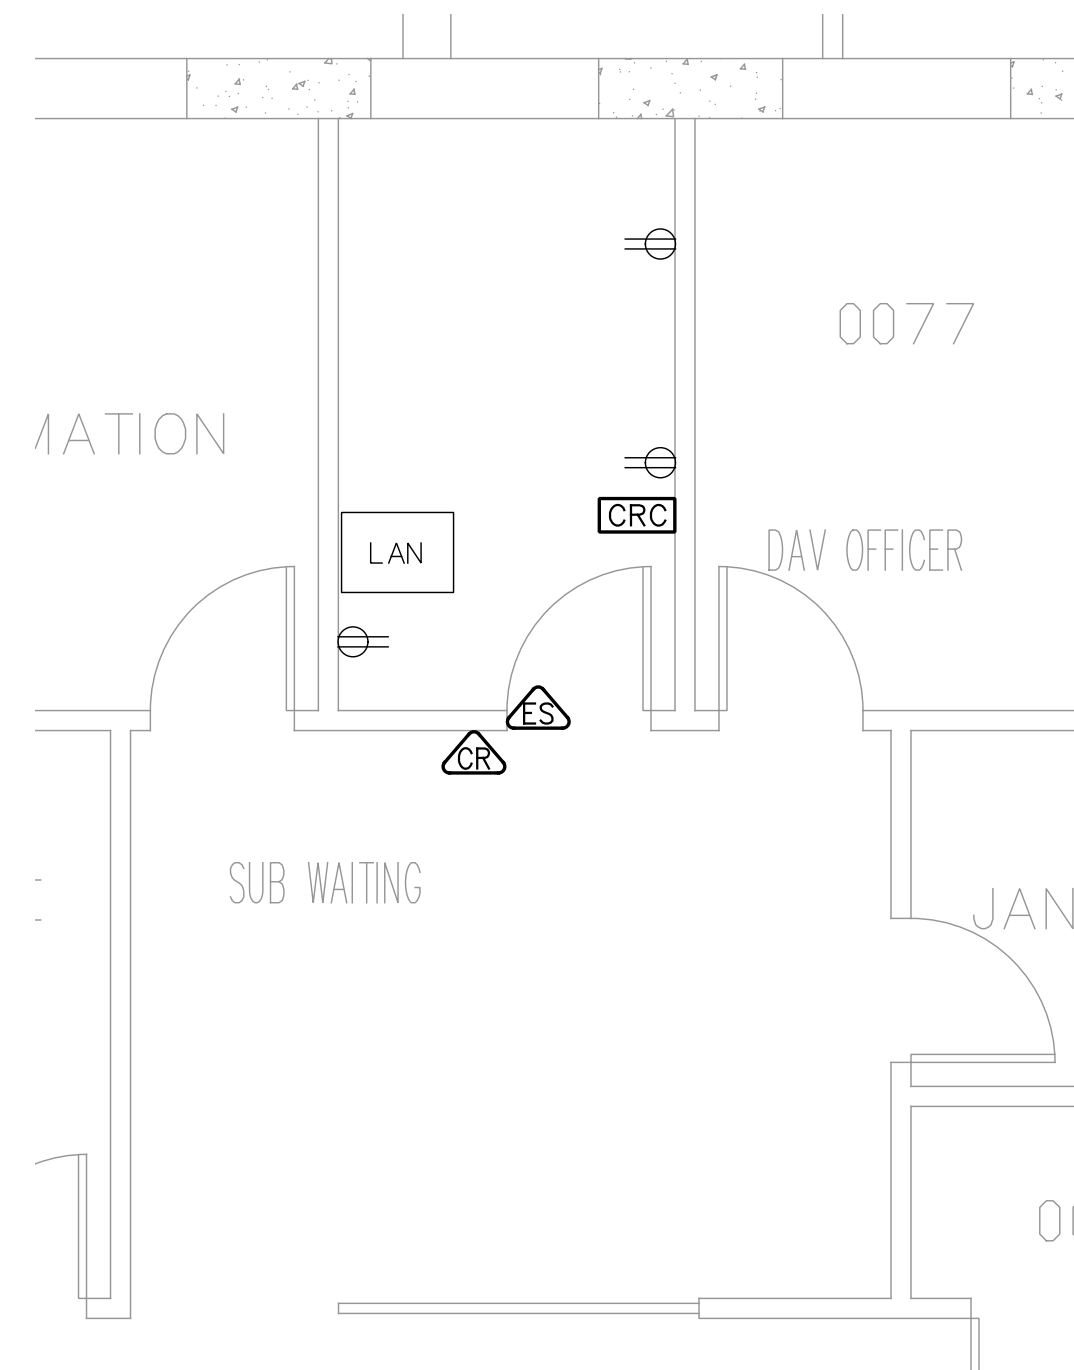


 **BUILDING 2 – GROUND FLOOR – ROOM 0076**  
SCALE: 1/4" = 1'-0"

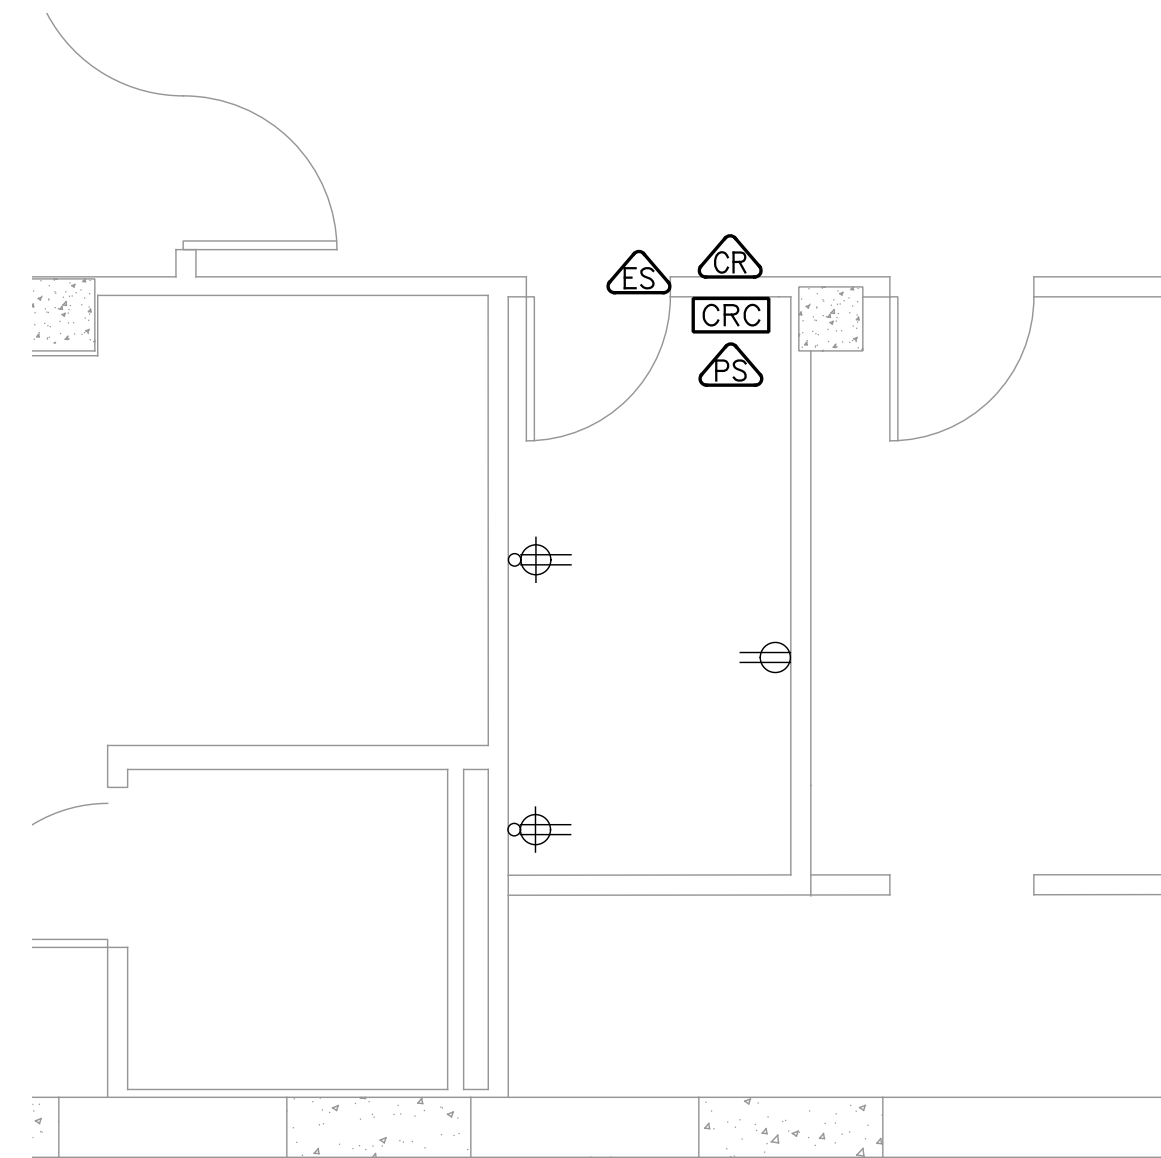



 **BUILDING 2 – GROUND FLOOR – ROOM 0050E**  
SCALE: 1/4" = 1'-0"

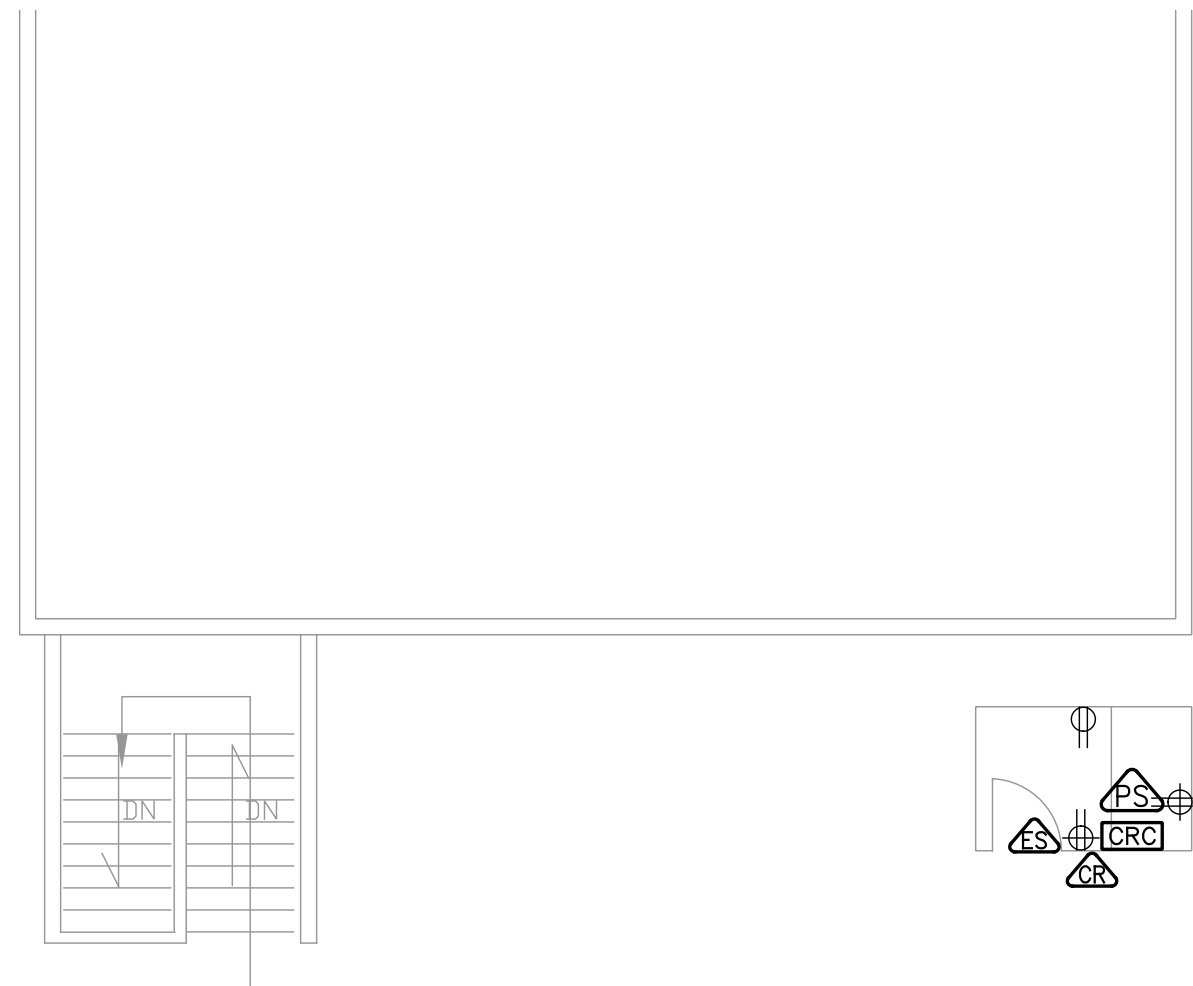


 **BUILDING 2 – ATTIC – ROOM A303**  
SCALE: 1/8" = 1'-0"

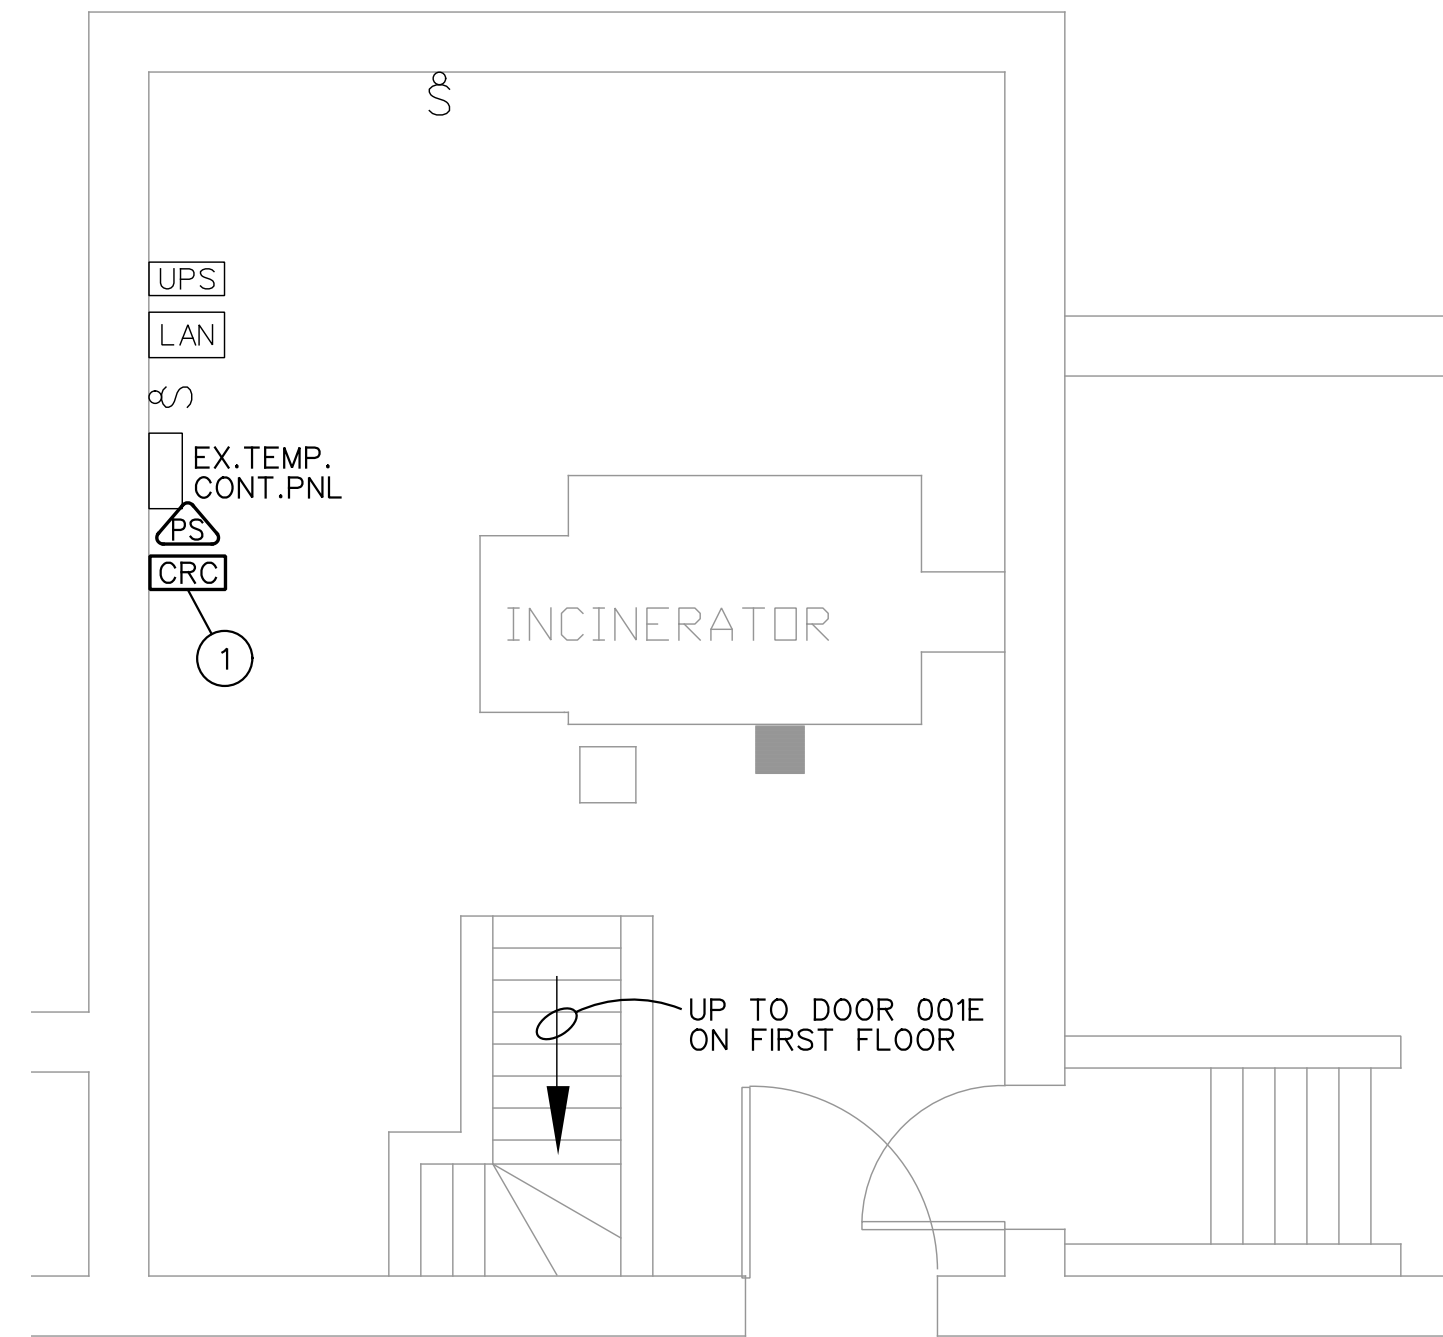

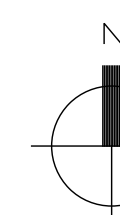
 **BUILDING 3 – BASEMENT – ROOM 001E**  
SCALE: 1/4" = 1'-0"

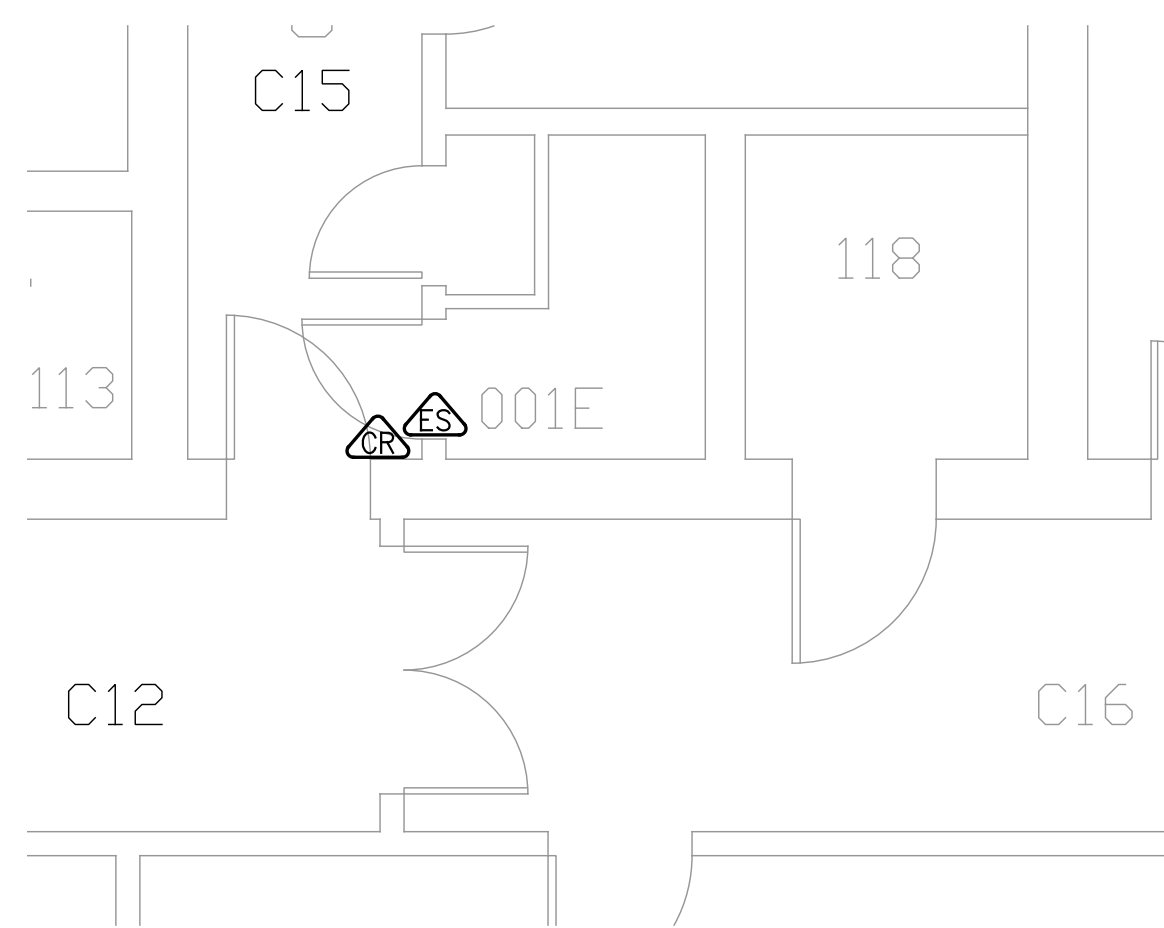


 **BUILDING 3 – FIRST FLOOR – ROOM 00E1**  
SCALE: 1/4" = 1'-0"  
(ACCESS TO BASEMENT ROOM 001E)

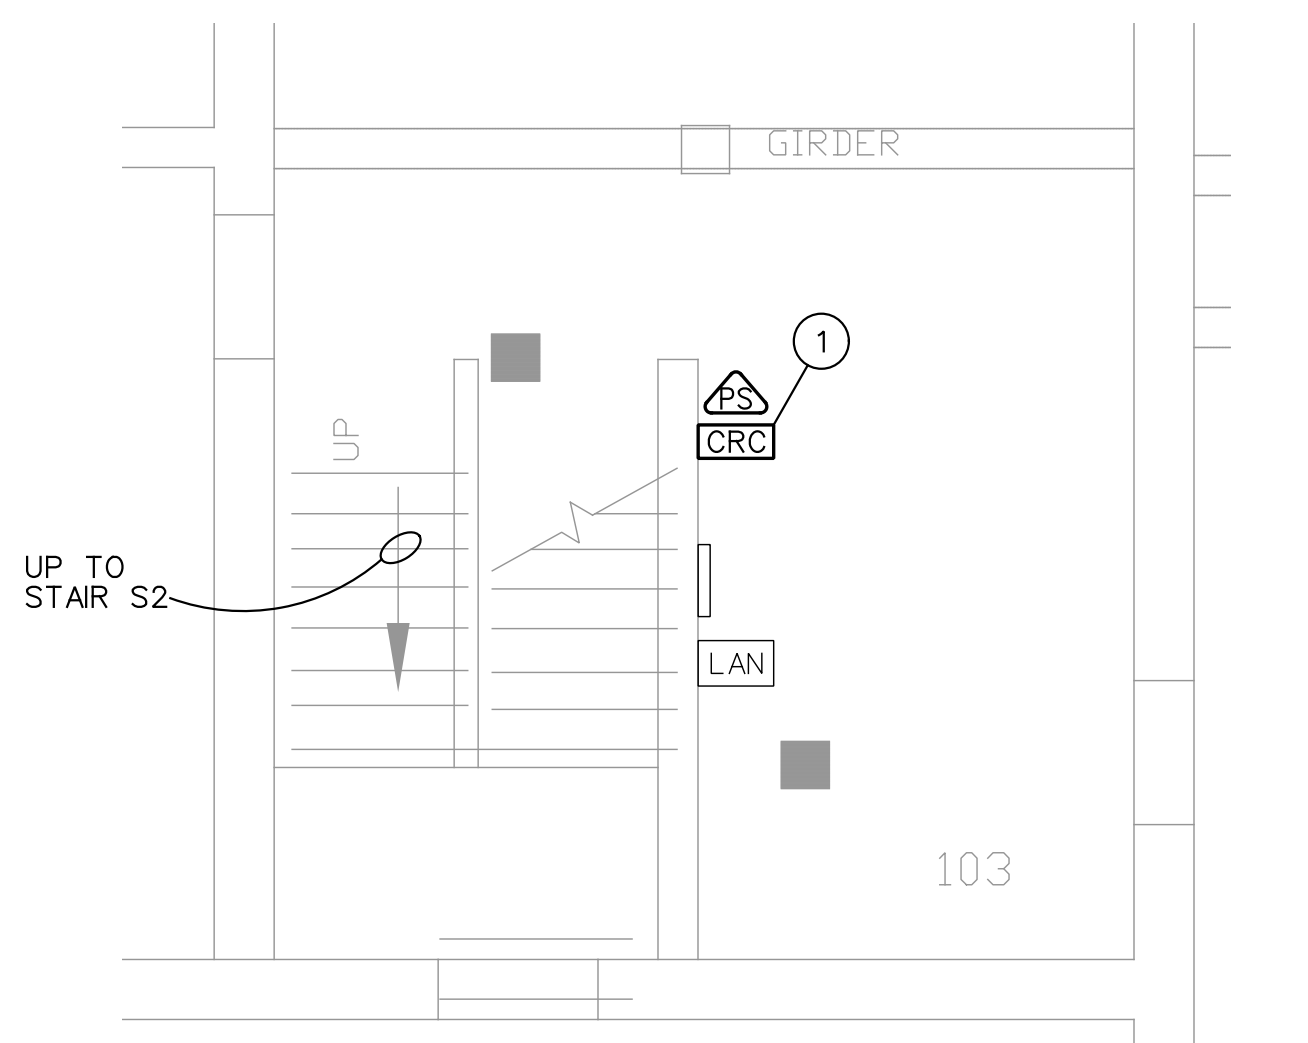

 **BUILDING 4 – BASEMENT – ROOM 103**  
SCALE: 1/4" = 1'-0"

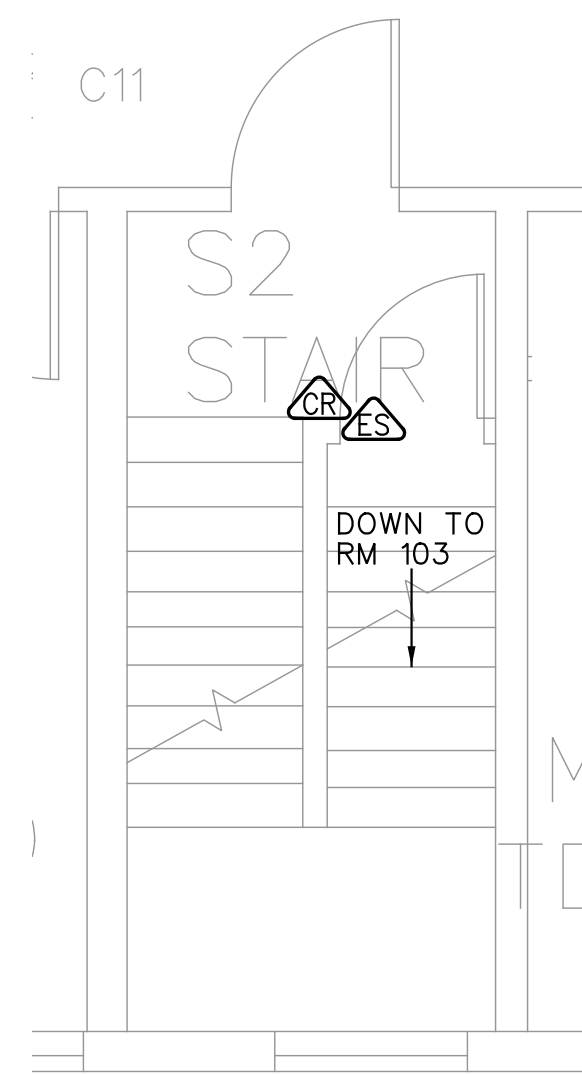

 **BUILDING 4 – FIRST FLOOR – STAIR S2**  
SCALE: 1/4" = 1'-0"  
(ACCESS TO BASEMENT ROOM 103)

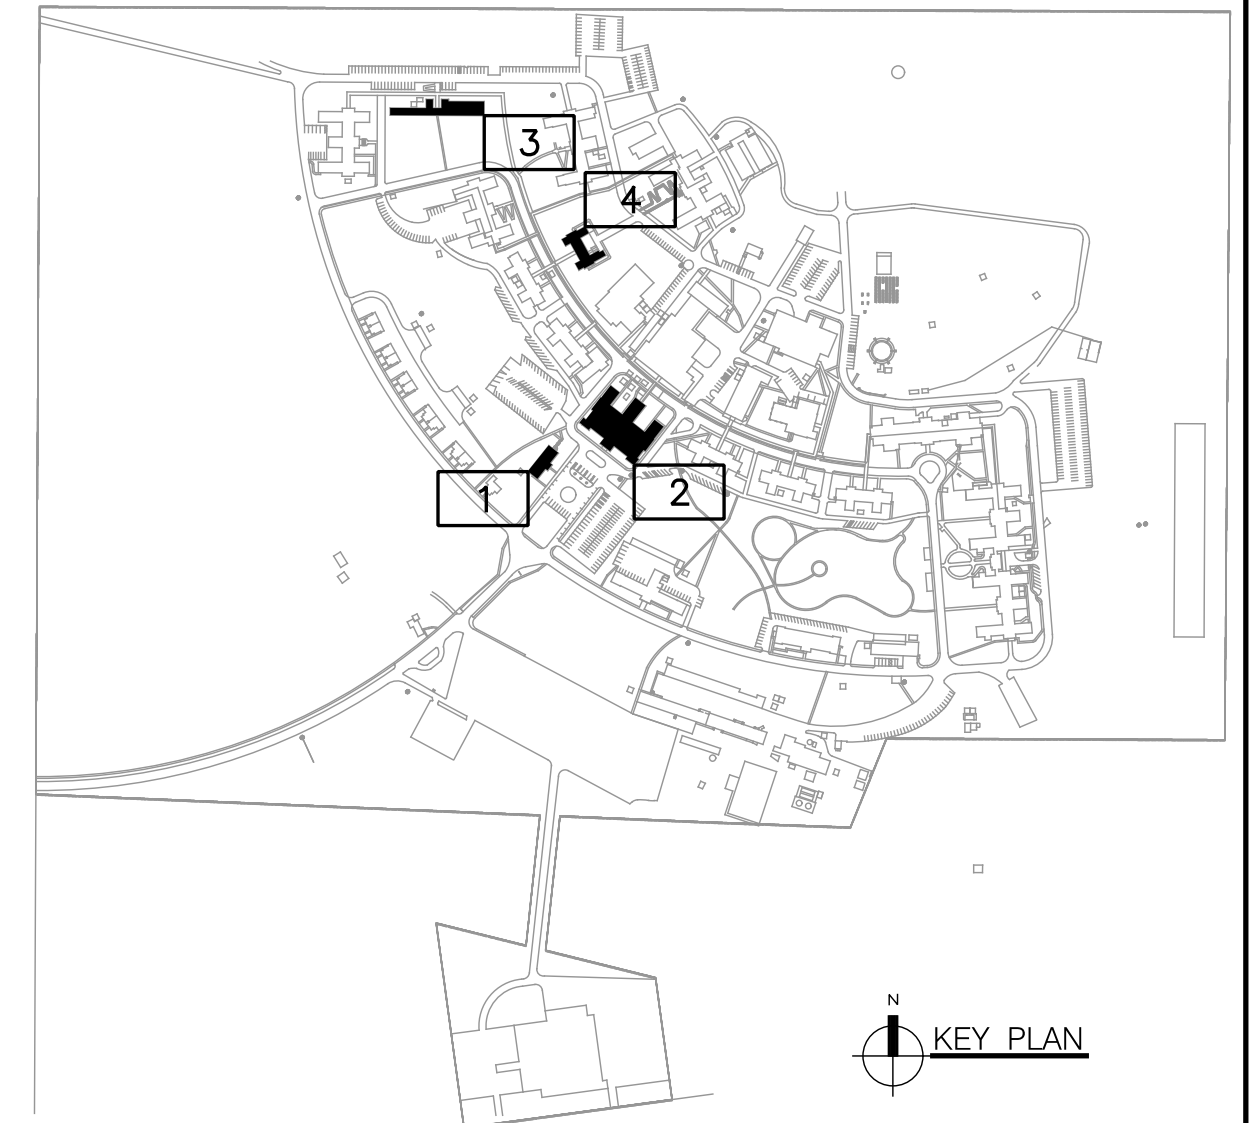

OUT FOR BIDS

## COMPREHENSIVE ENGINEERING

4653 Plainfield Avenue, NE  
Grand Rapids, MI 49505  
Phone: (616) 365-9953  
Fax: (616) 365-9957  
CE #10087

APPROVED: DIRECTOR

APPROVED: ASSOCIATE DIRECTOR

APPROVED: CHIEF OF STAFF

APPROVED: CHIEF, FACILITIES MANAGEMENT SERVICE

APPROVED: CHIEF, IMS

APPROVED: PROTECTIVE SERVICE

APPROVED: INDUSTRIAL HYGIENIST

APPROVED: SAFETY MANAGER

APPROVED: CHIEF, PROJECT SECTION

APPROVED:

APPROVED:

APPROVED:

VA PROJECT NAME:

Information Management Safety  
& Security Upgrades

DATE:

23 MAR 11

PLOT SCALE:

AS NOTED

BUILDING NUMBER:

1 THRU 4

A/E PROJECT NUMBER:

10087

LOCATION:

BATTLE CREEK VAMC

DRAWING TITLE:

ELECTRICAL PLANS

VA PROJECT NUMBER:

515-10-120

DWG NUMBER:

E1 OF 11

DEPARTMENT OF  
VETERANS AFFAIRS