
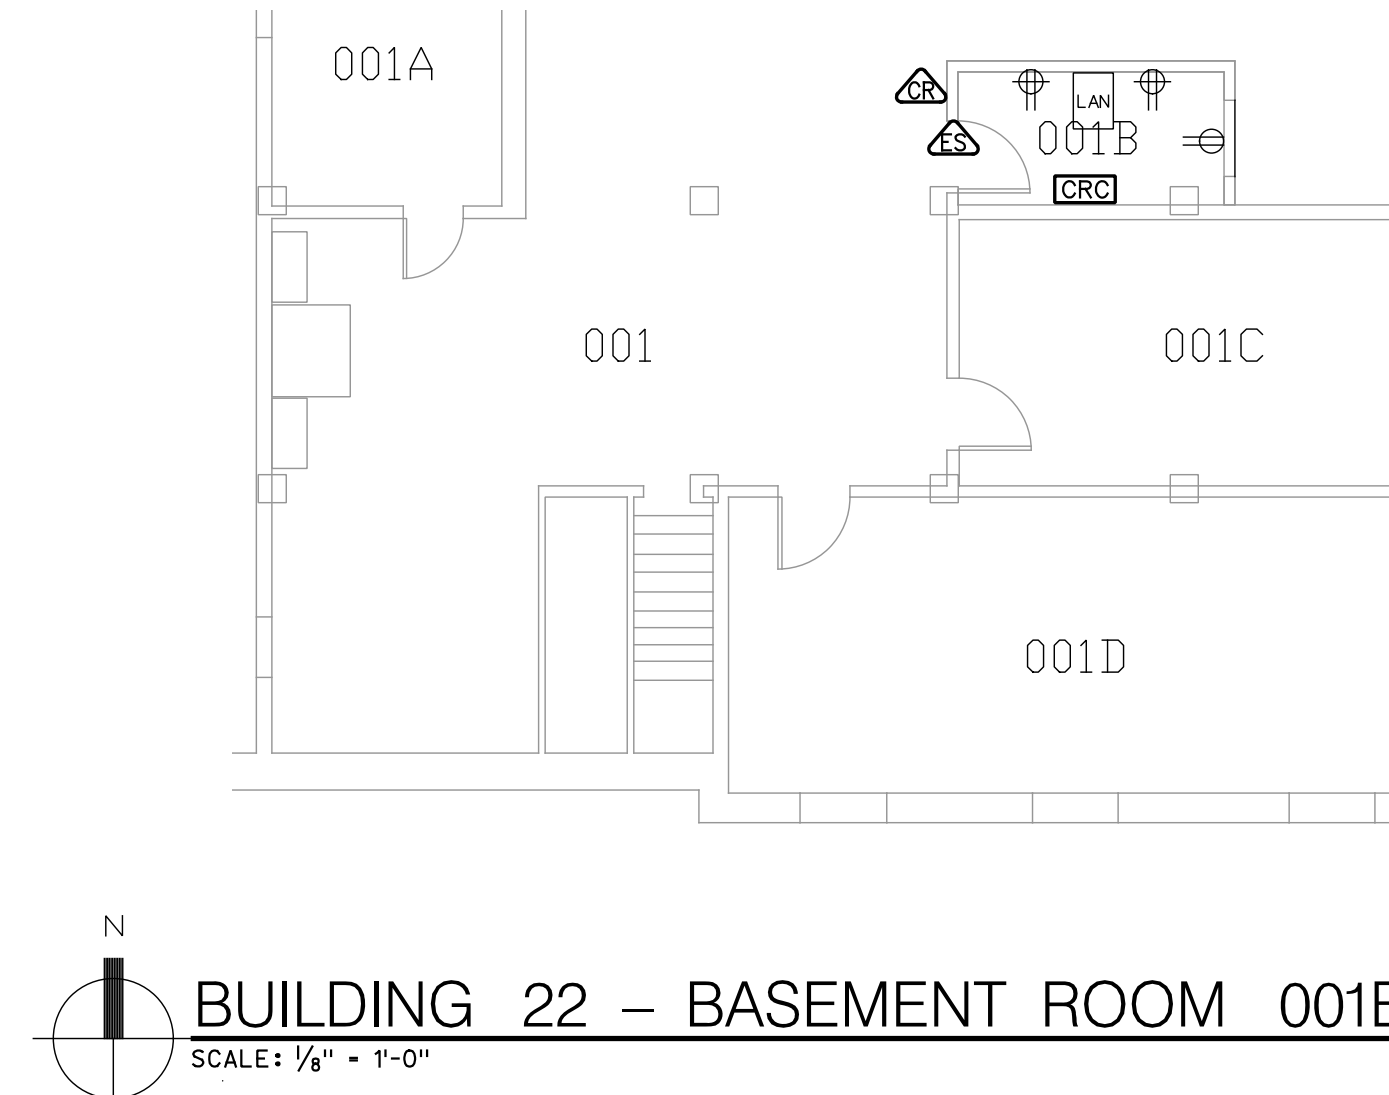
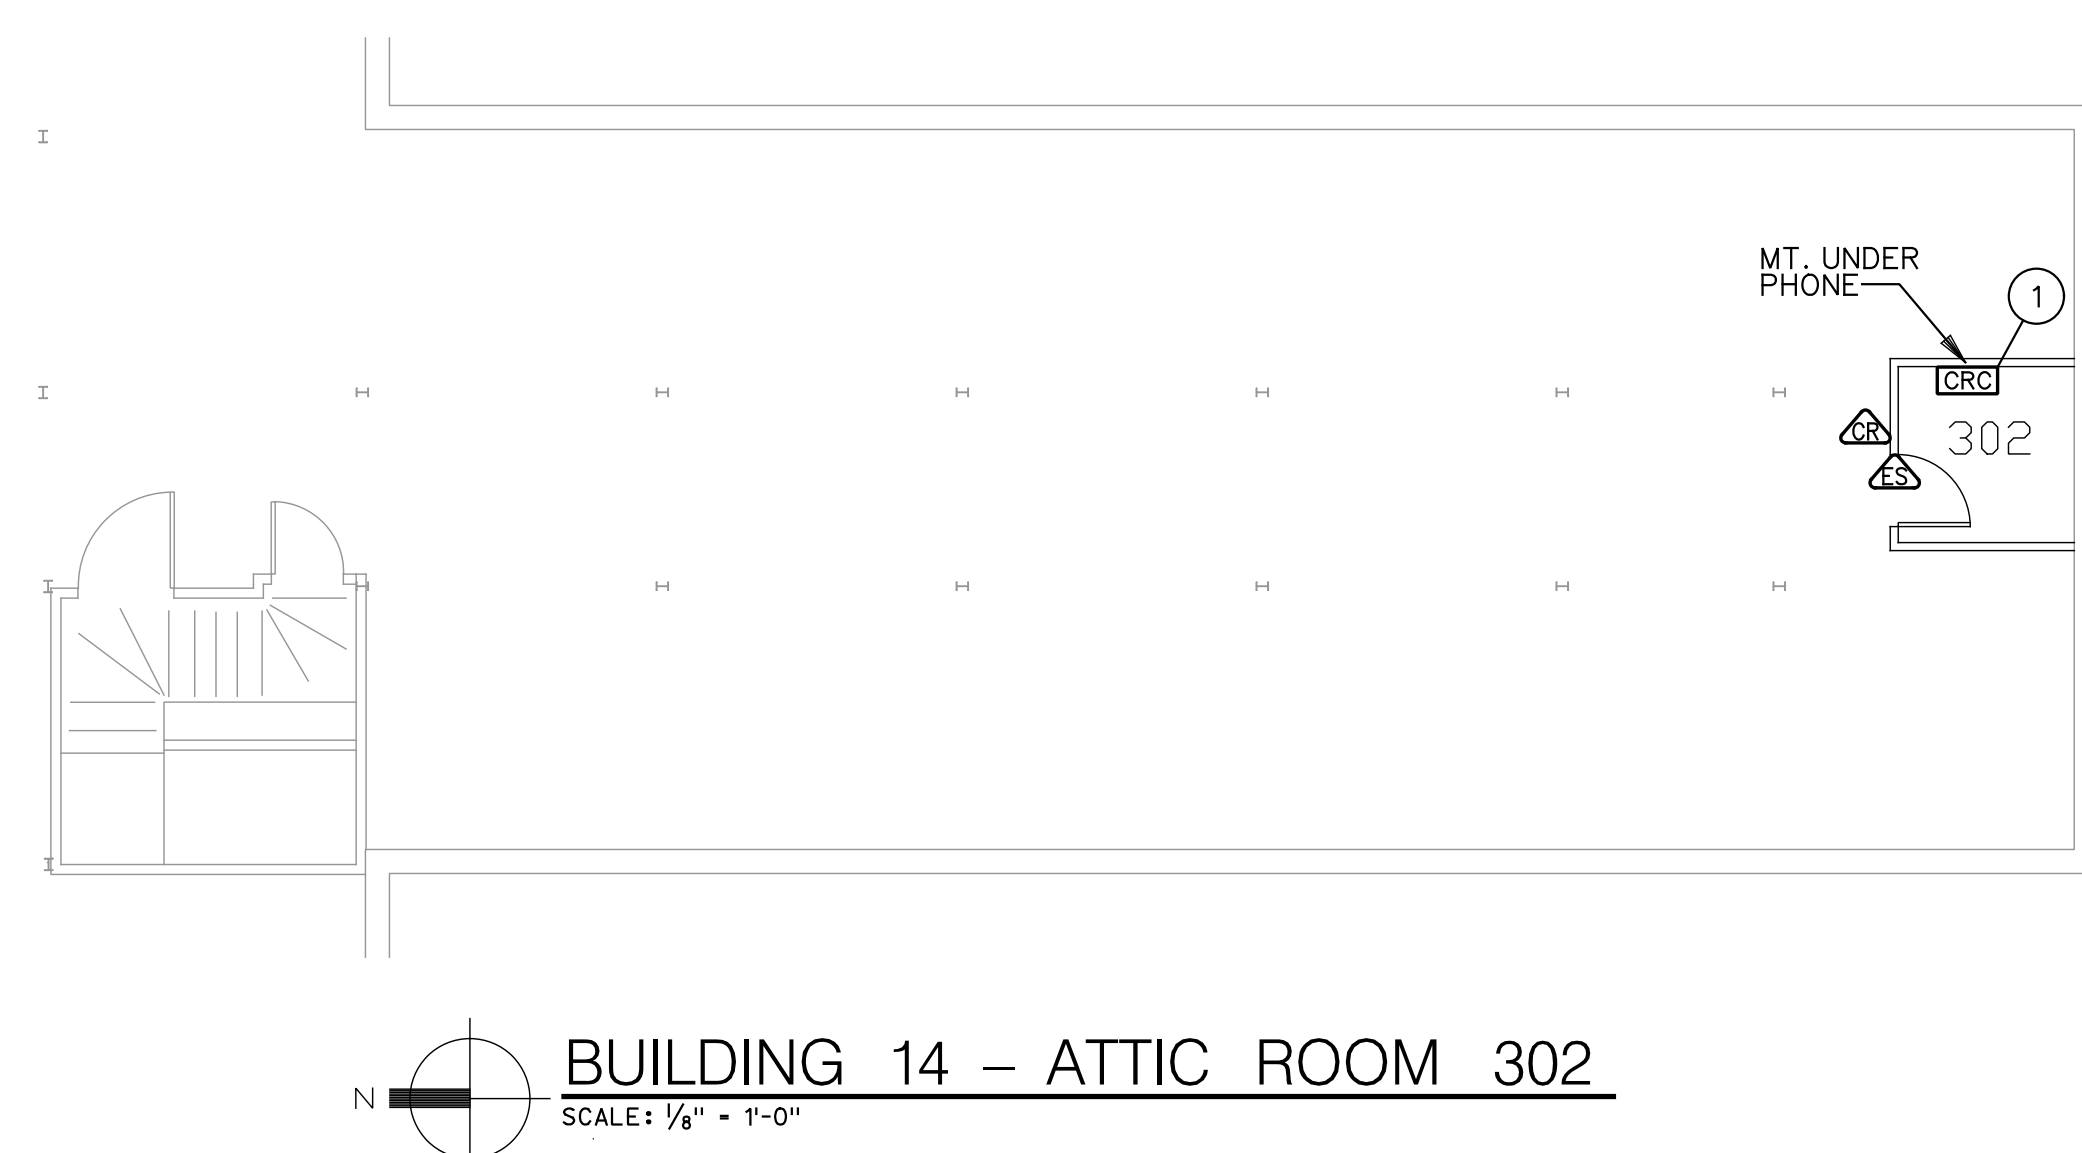


- NOTES:**
1. CONTRACTOR TO PROVIDE POWER FOR THIS CRC FROM NEAREST 120V CIRCUIT. FIELD VERIFY LOCATION.
 2. MAINTAIN FIRE RATINGS OF EXISTING WALLS, CEILINGS AND FLOORS BY SEALING ANY NEW PENETRATIONS. SEE DETAILS ON DRWG E-7. VERIFY WHICH WALLS REQUIRE SEALING WITH OWNER.

BUILDING 12 – BASEMENT – ROOM 001
SCALE: 1/4" = 1'-0"





BUILDING 13 – BASEMENT – ROOM 002E
SCALE: 1/4" = 1'-0"

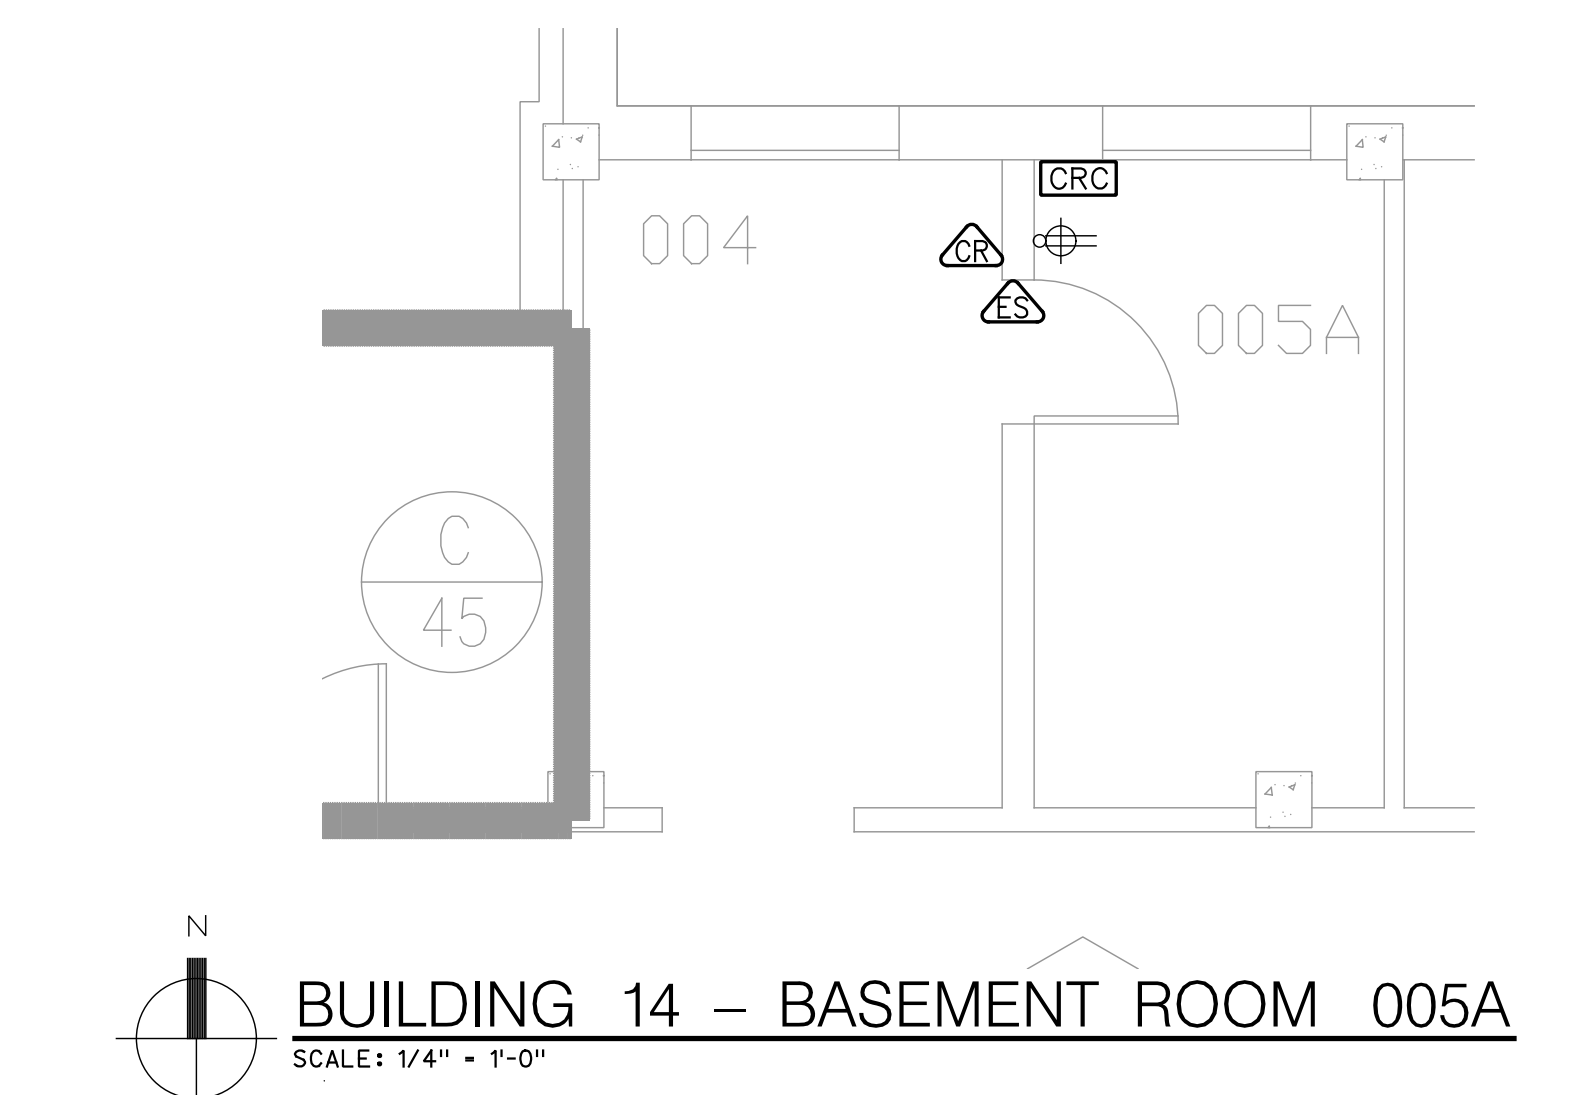

BUILDING 14 – BASEMENT ROOM 005A
SCALE: 1/4" = 1'-0"

BUILDING 14 – ATTIC ROOM 302
SCALE: 1/8" = 1'-0"

BUILDING 22 – BASEMENT ROOM 001B
SCALE: 1/8" = 1'-0"

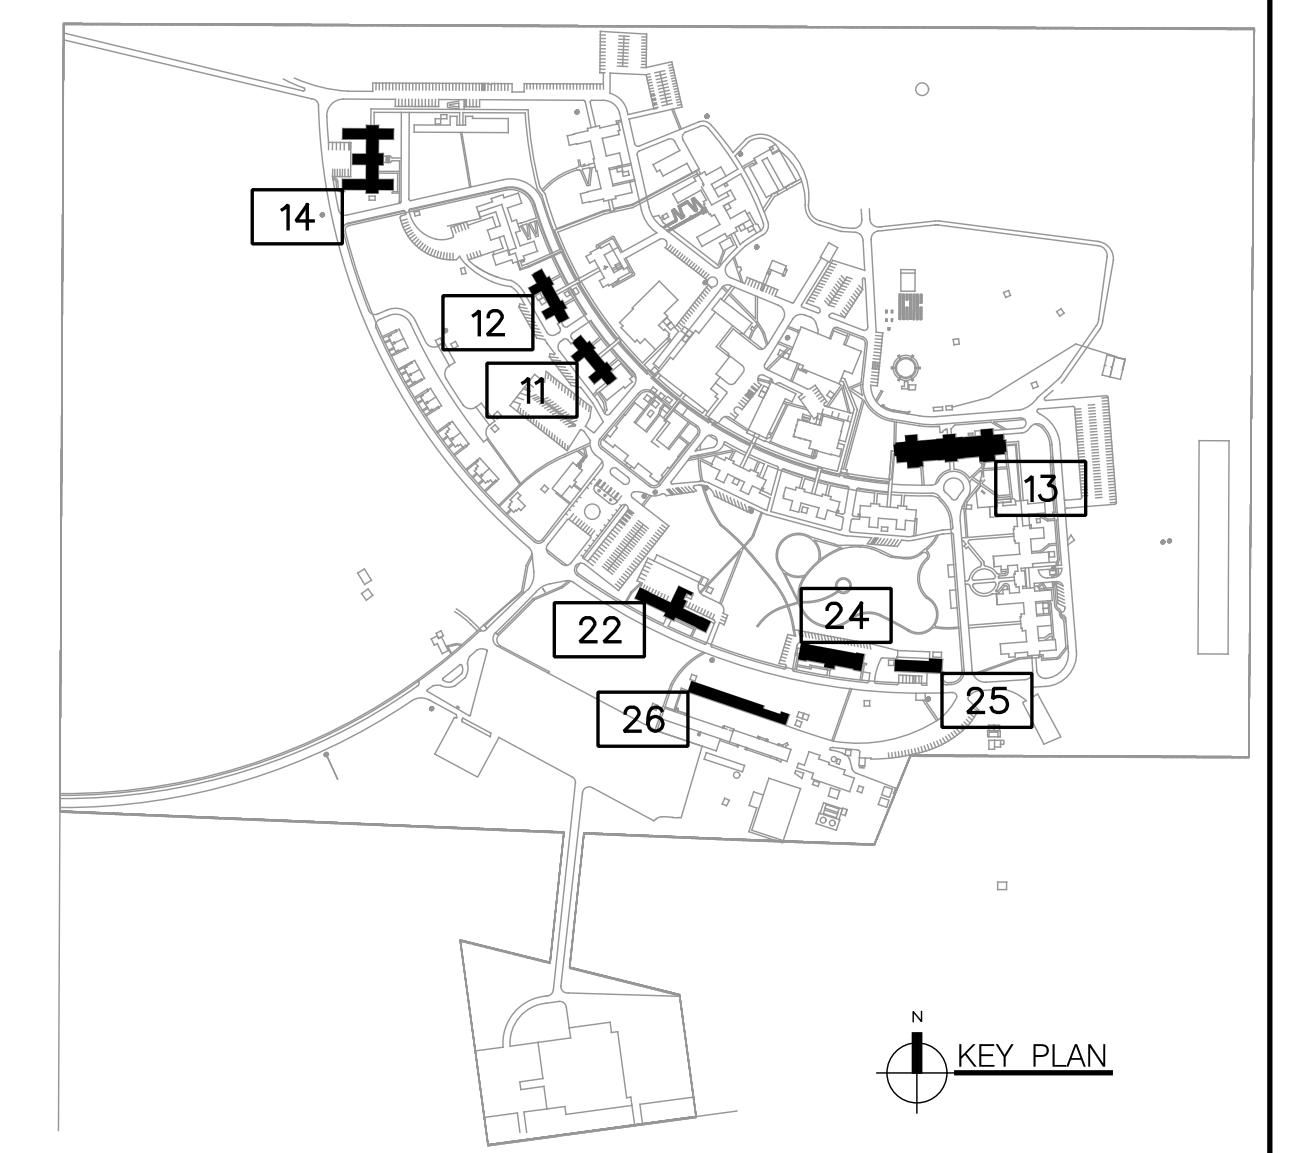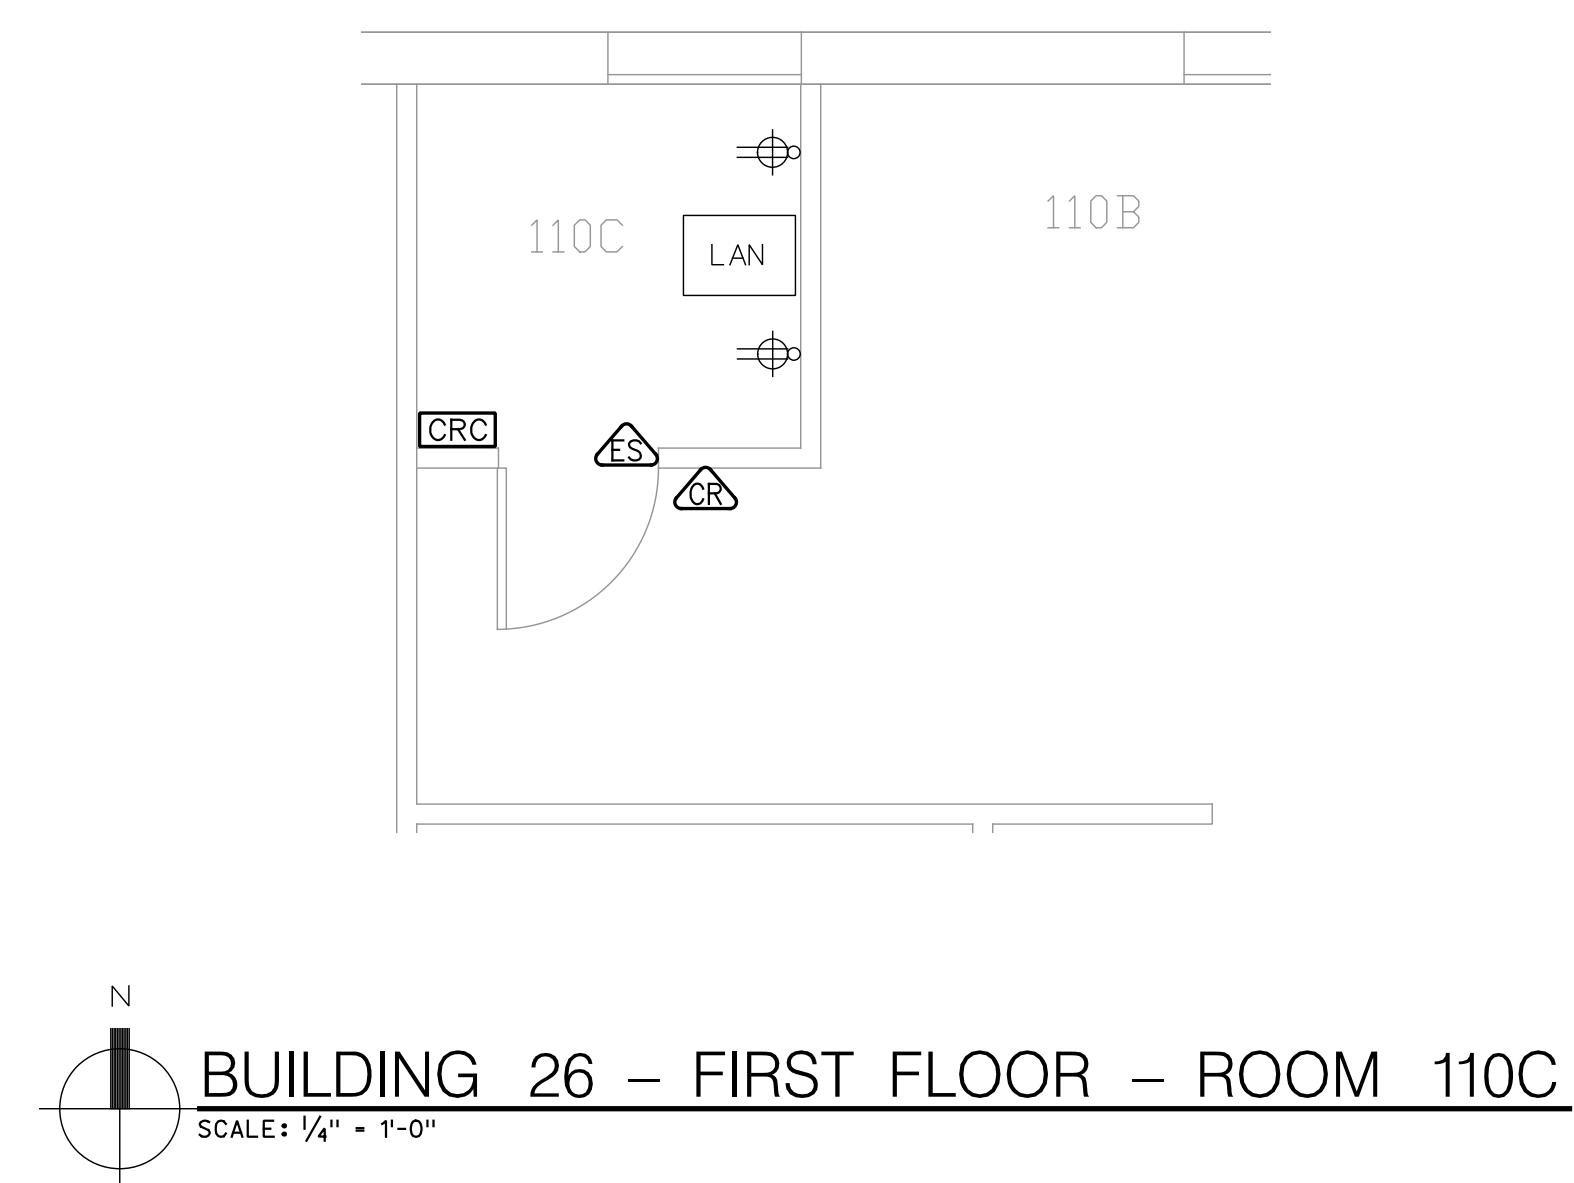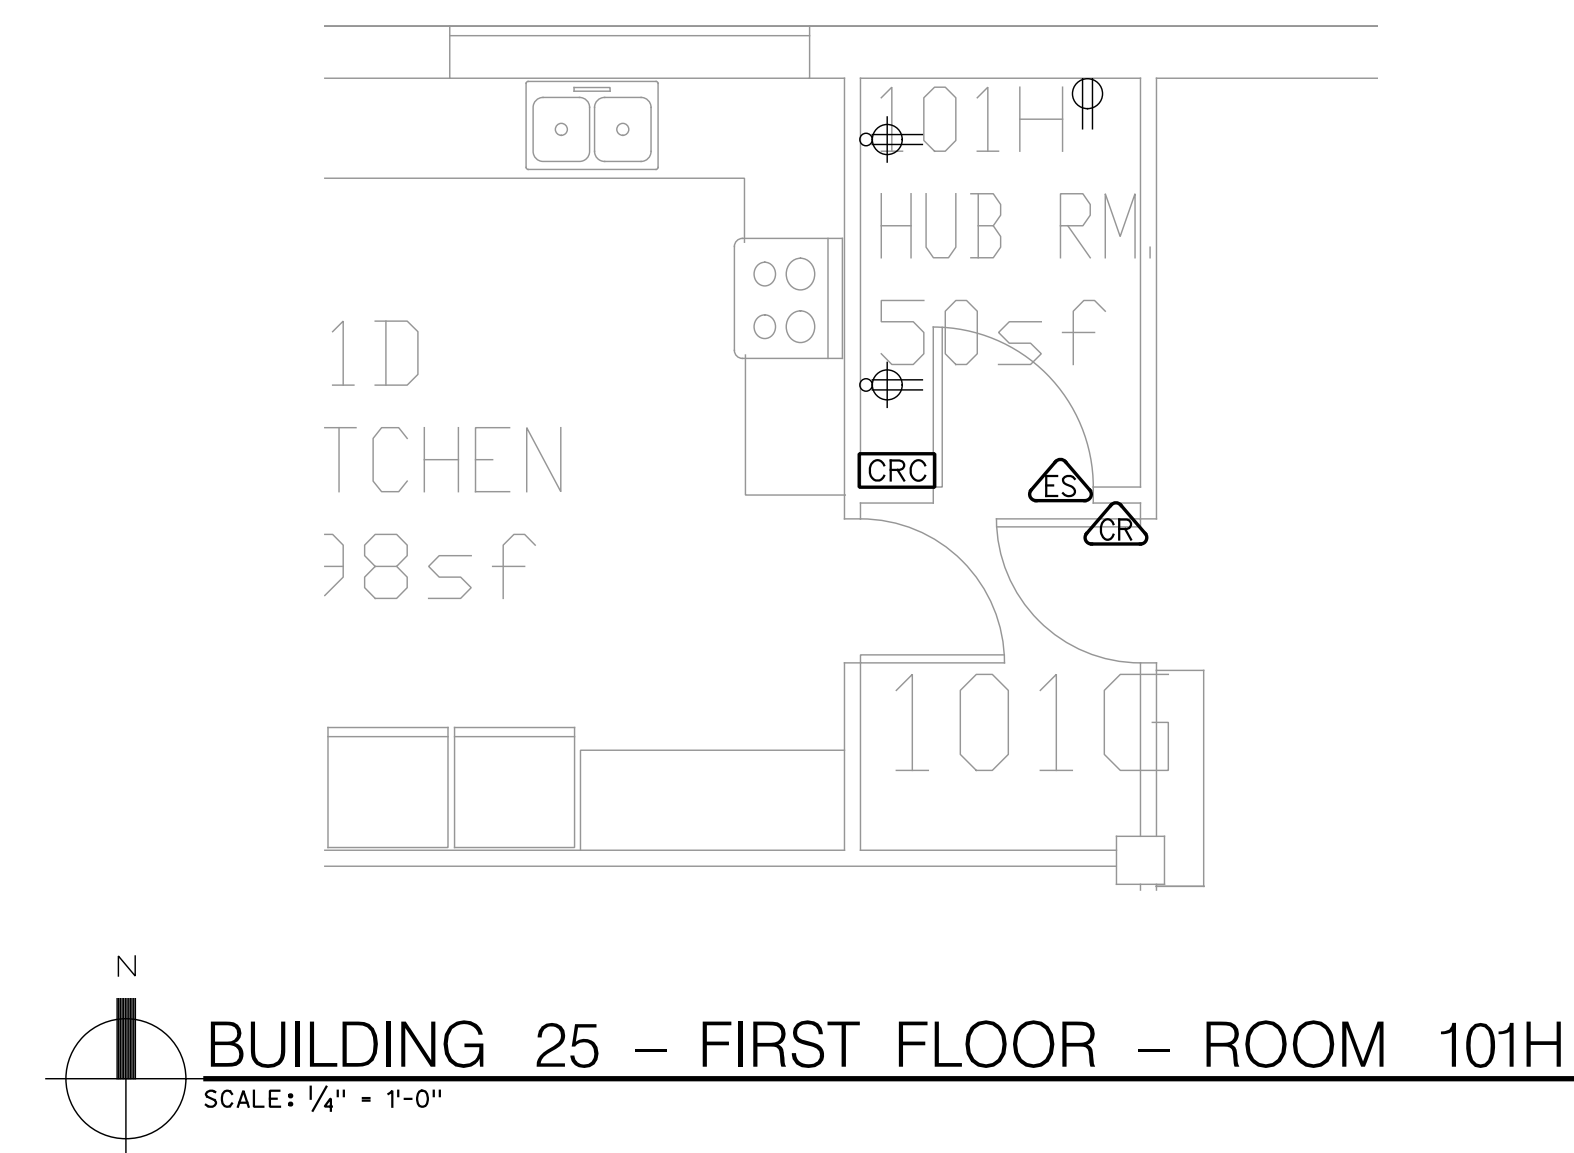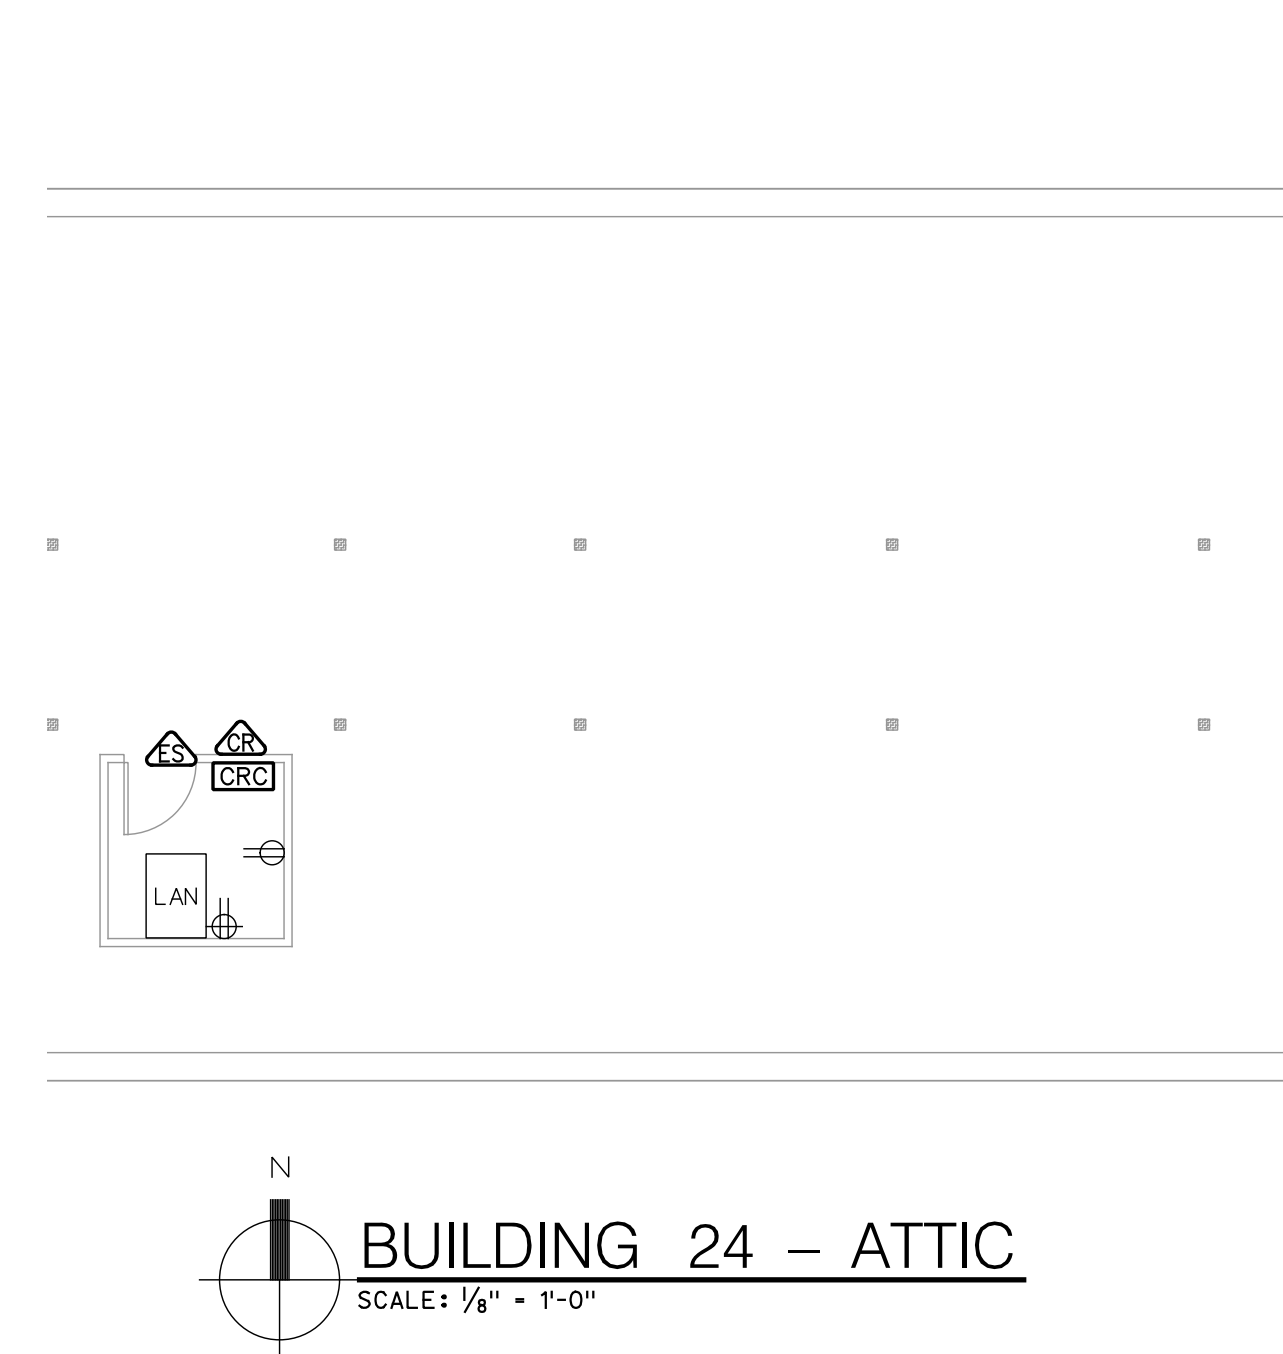

KEY PLAN

100% SUBMISSION

COMPREHENSIVE ENGINEERING 4653 Plainfield Avenue, NE Grand Rapids, MI 49505 Phone: (616) 365-9933 Fax: (616) 365-9937 CE #10087	APPROVED: DIRECTOR	APPROVED: CHIEF, SPD	APPROVED: CHIEF, PROJECT SECTION	VA PROJECT NAME: Information Management Safety & Security Upgrades	DRAWING TITLE: ELECTRICAL PLANS
	APPROVED: ASSOCIATE DIRECTOR	APPROVED: PROTECTIVE SERVICE	APPROVED:	VA PROJECT NUMBER: 515-10-120	VA PROJECT NUMBER: 515-10-120
	APPROVED: CHIEF OF STAFF	APPROVED: INDUSTRIAL HYGIENIST	APPROVED:	DATE: 15 FEB 2011	PLOT SCALE: AS NOTED
	APPROVED: CHIEF, FACILITIES MANAGEMENT SERVICE	APPROVED: SAFETY MANAGER	APPROVED:	BUILDING NUMBER: 11 THRU 26	A/E PROJECT NUMBER: 10087
				LOCATION: BATTLE CREEK VAMC	DRAWING NUMBER: DWG E3 OF 11

DEPARTMENT OF
VETERANS AFFAIRS