

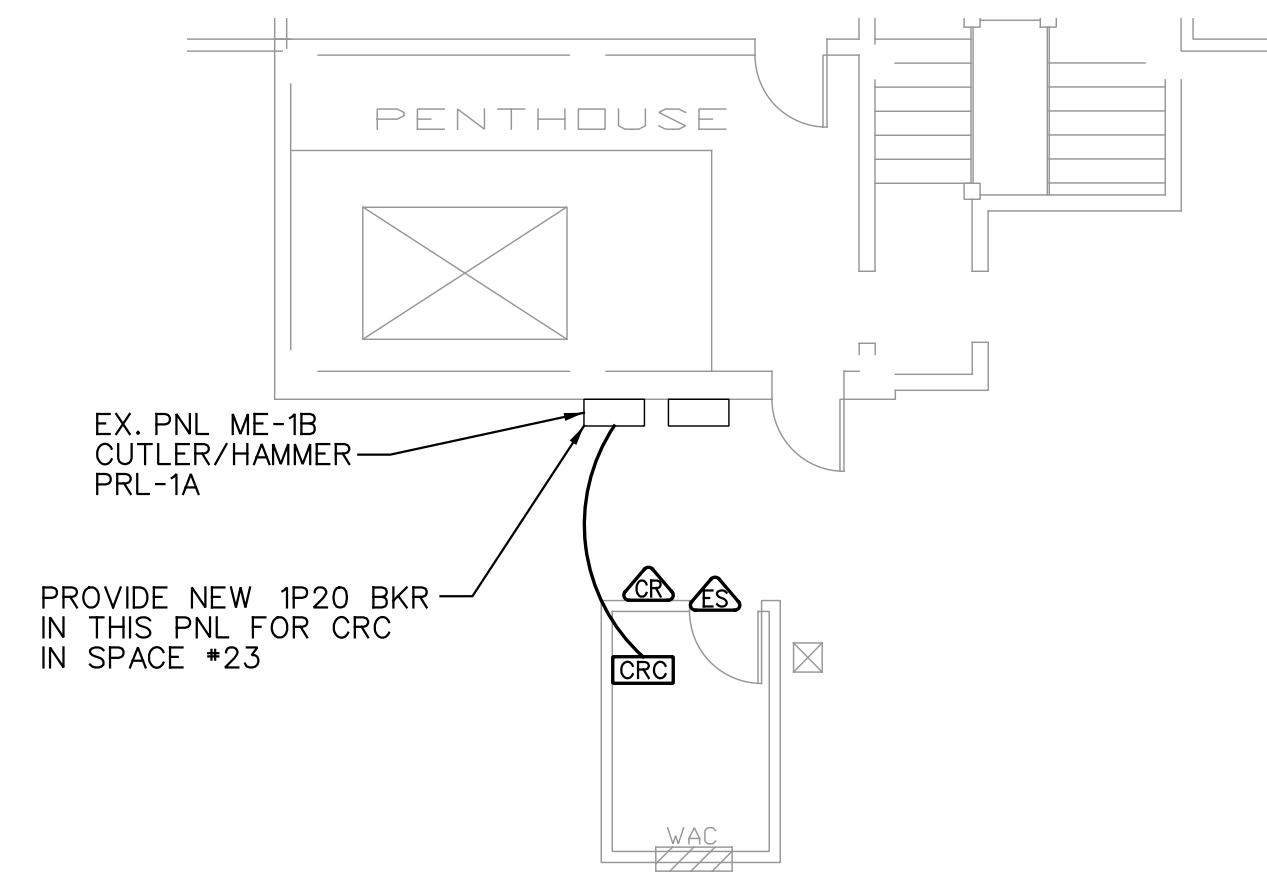
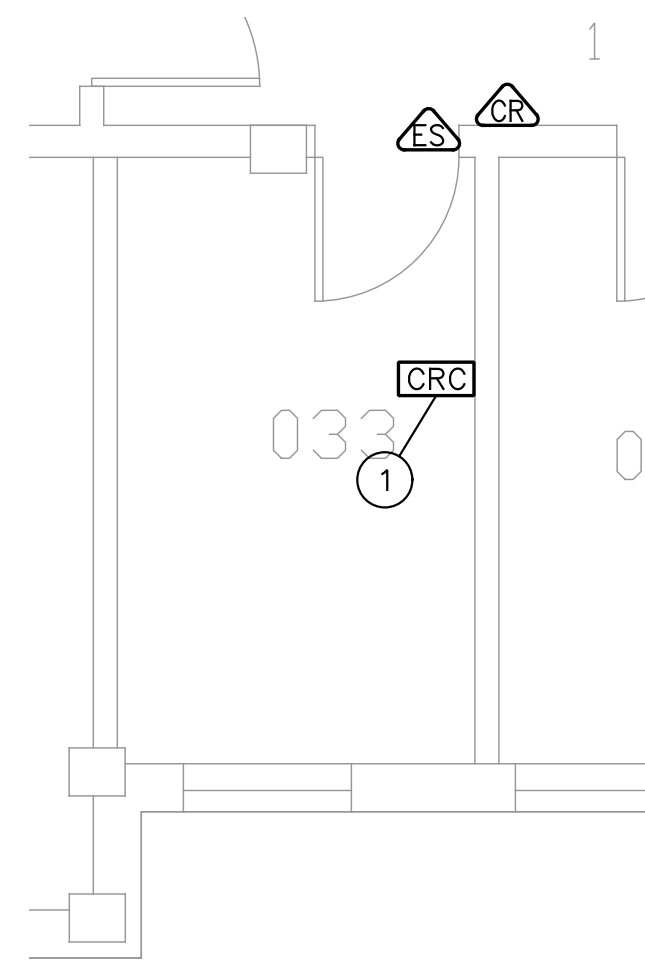


- NOTES:
- 1 CONTRACTOR TO PROVIDE POWER FOR THIS CRC FROM NEAREST 120V CIRCUIT. FIELD VERIFY LOCATION.
 - 2 MAINTAIN FIRE RATINGS OF EXISTING WALLS, CEILINGS AND FLOORS BY SEALING ANY NEW PENETRATIONS. SEE DETAILS ON DRWG E-7. VERIFY WHICH WALLS REQUIRE SEALING WITH OWNER.

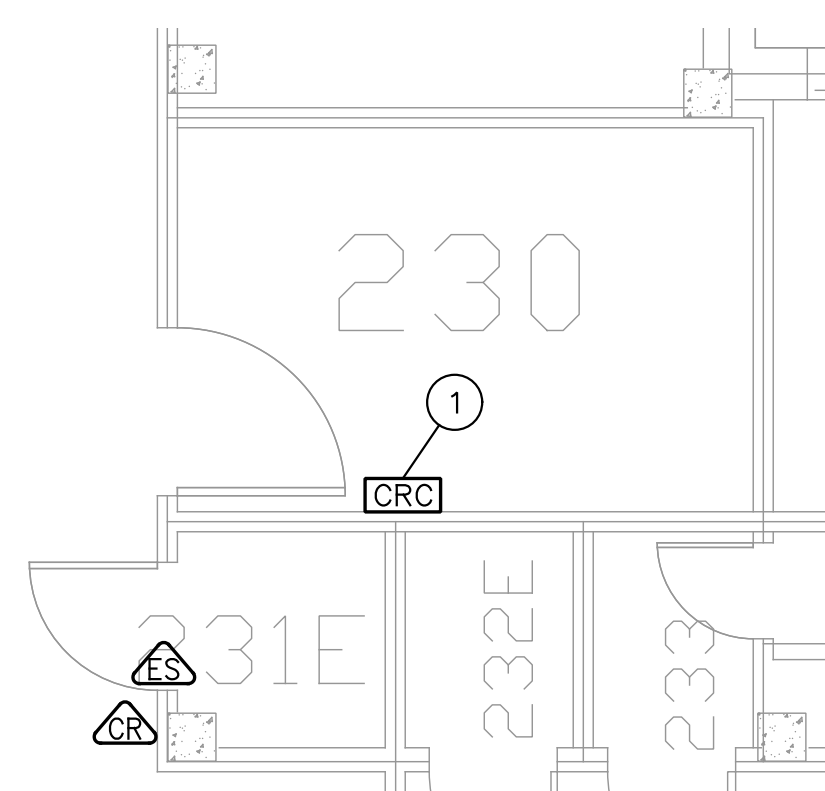


BUILDING 39 – BASEMENT – ROOM 033
SCALE: 1/4" = 1'-0"

BUILDING 39 – ATTIC – ROOM 302
SCALE: 1/4" = 1'-0"

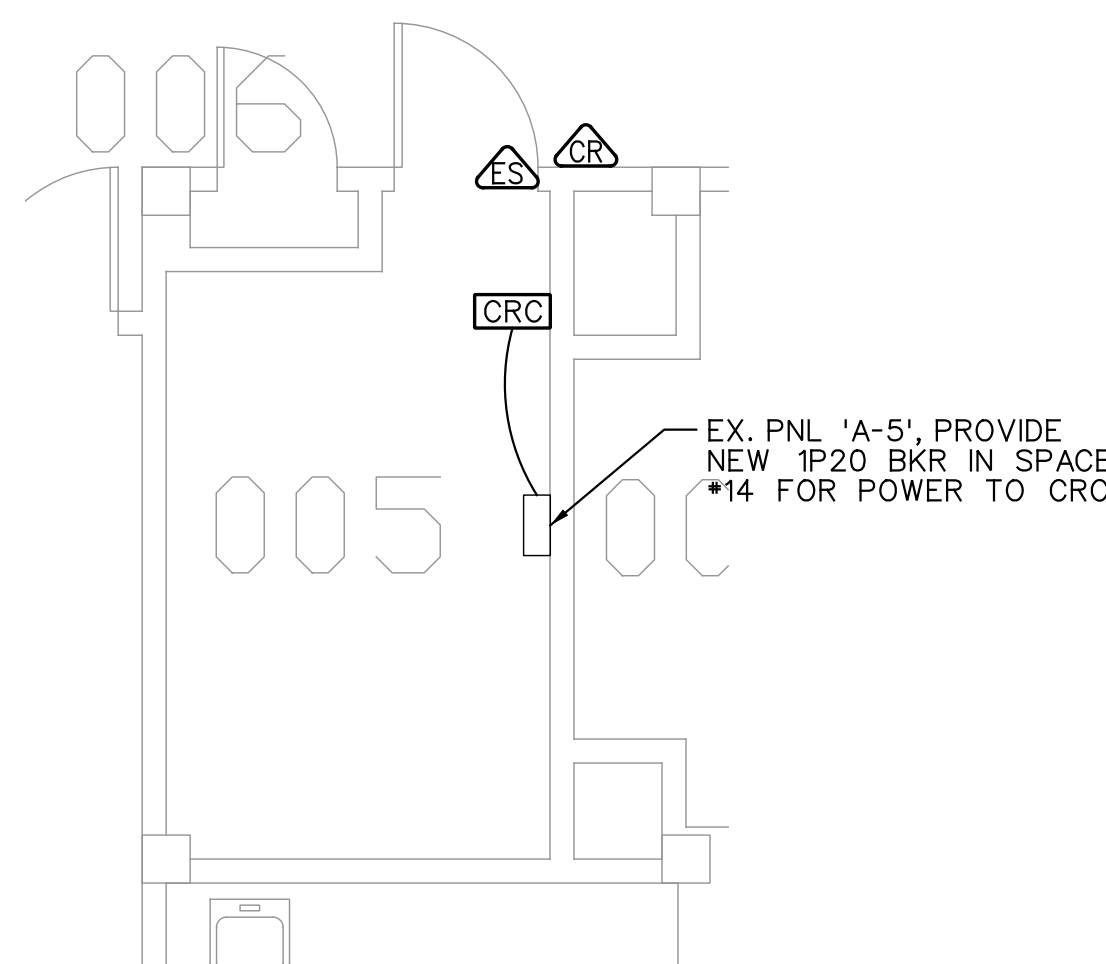


BUILDING 82 – BASEMENT – ROOM 005
SCALE: 1/4" = 1'-0"

BUILDING 82 – SECOND FLOOR – ROOM 231E
SCALE: 1/4" = 1'-0"

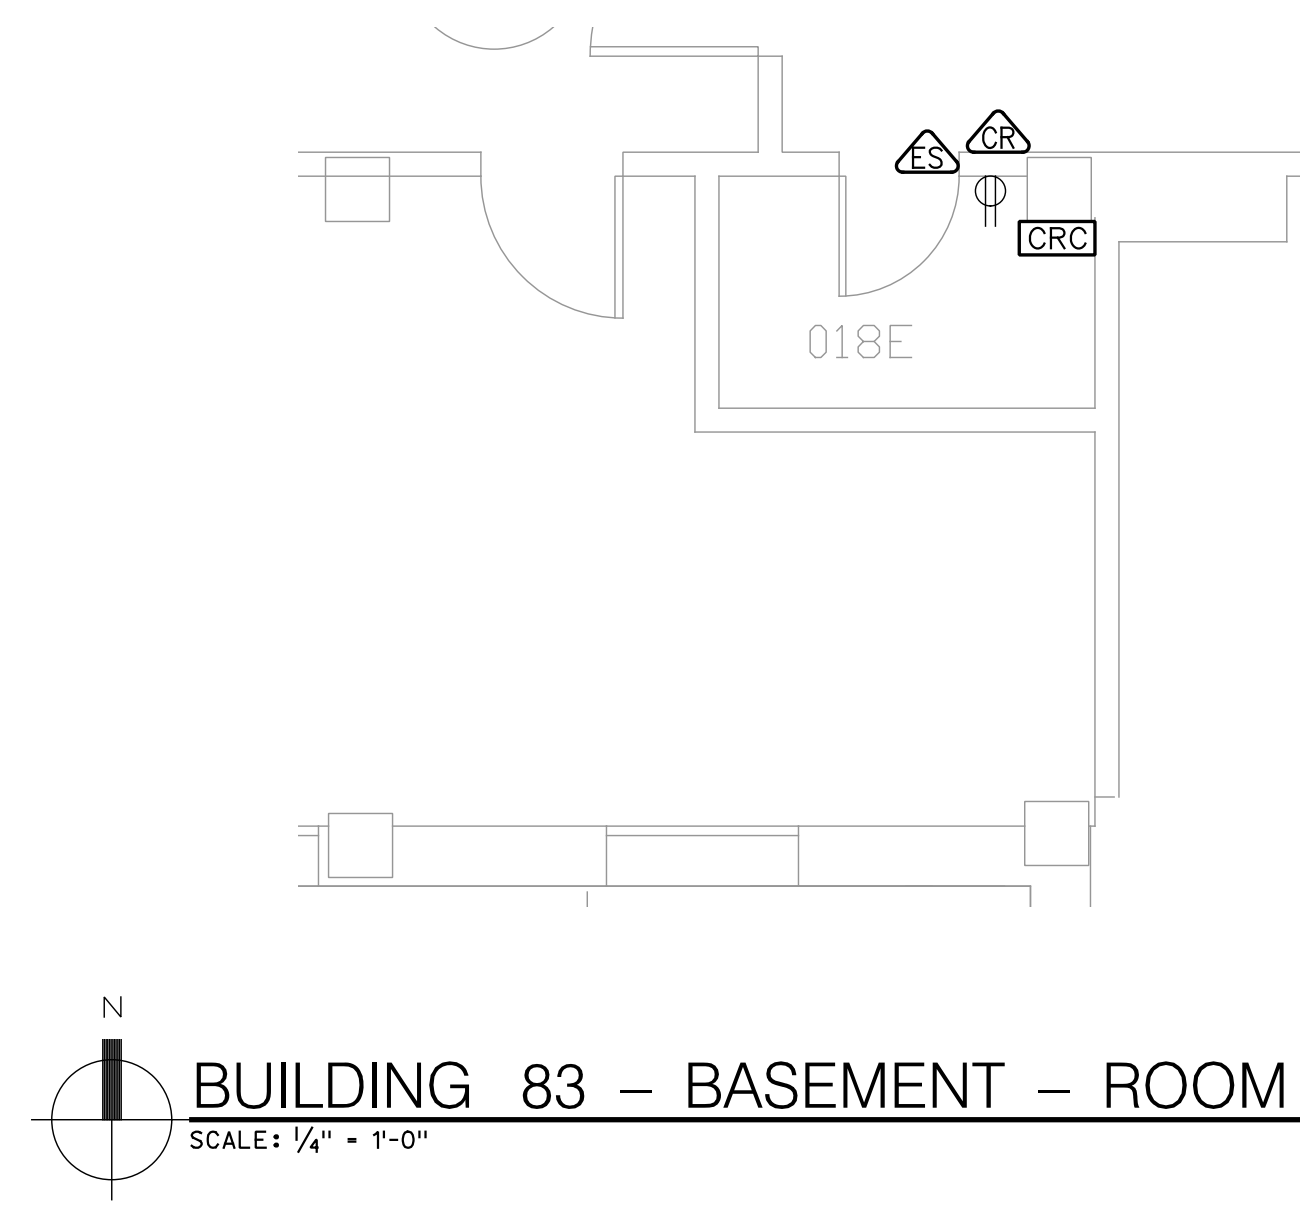

BUILDING 83 – BASEMENT – ROOM 018E
SCALE: 1/4" = 1'-0"

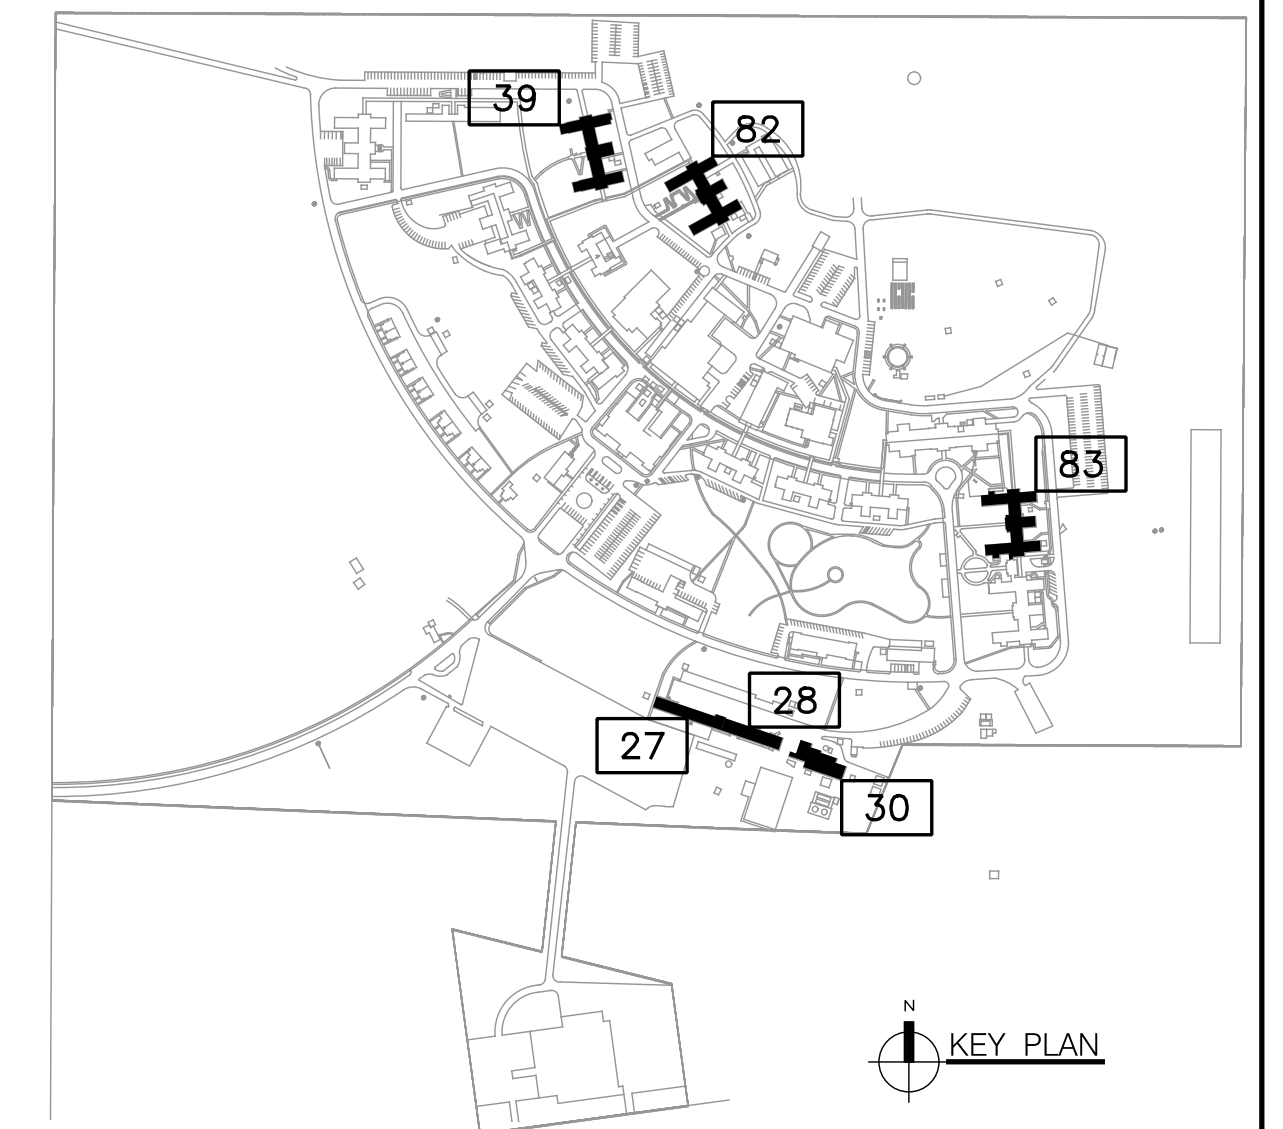

100% SUBMISSION

COMPREHENSIVE ENGINEERING

4653 Plainfield Avenue, NE
Grand Rapids, MI 49505
Phone: (616) 365-9953
Fax: (616) 365-9957
CE #10087

APPROVED: DIRECTOR

APPROVED: ASSOCIATE DIRECTOR

APPROVED: CHIEF OF STAFF

APPROVED: CHIEF, FACILITIES MANAGEMENT SERVICE

APPROVED: CHIEF, SPD

APPROVED: PROTECTIVE SERVICE

APPROVED: INDUSTRIAL HYGIENIST

APPROVED: SAFETY MANAGER

APPROVED: CHIEF, PROJECT SECTION

APPROVED:

APPROVED:

APPROVED:

VA PROJECT NAME:

Information Management Safety
& Security Upgrades

DATE:

15 FEB 2011

PLOT SCALE:

AS NOTED

BUILDING NUMBER:

27 THRU 83

A/E PROJECT NUMBER:

10087

LOCATION:

BATTLE CREEK VAMC

DRAWING TITLE:

ELECTRICAL PLANS

VA PROJECT NUMBER:

515-10-120

DWG

E4

OF 11

DEPARTMENT OF
VETERANS AFFAIRS