


DEPARTMENT OF VETERANS AFFAIRS MALCOM RANDALL VA MEDICAL CENTER

Update Site for Compliance with VA Barrier Free Guide

PROJECT # 573-13-601 Revised 100% Construction Drawings

Vicinity Map

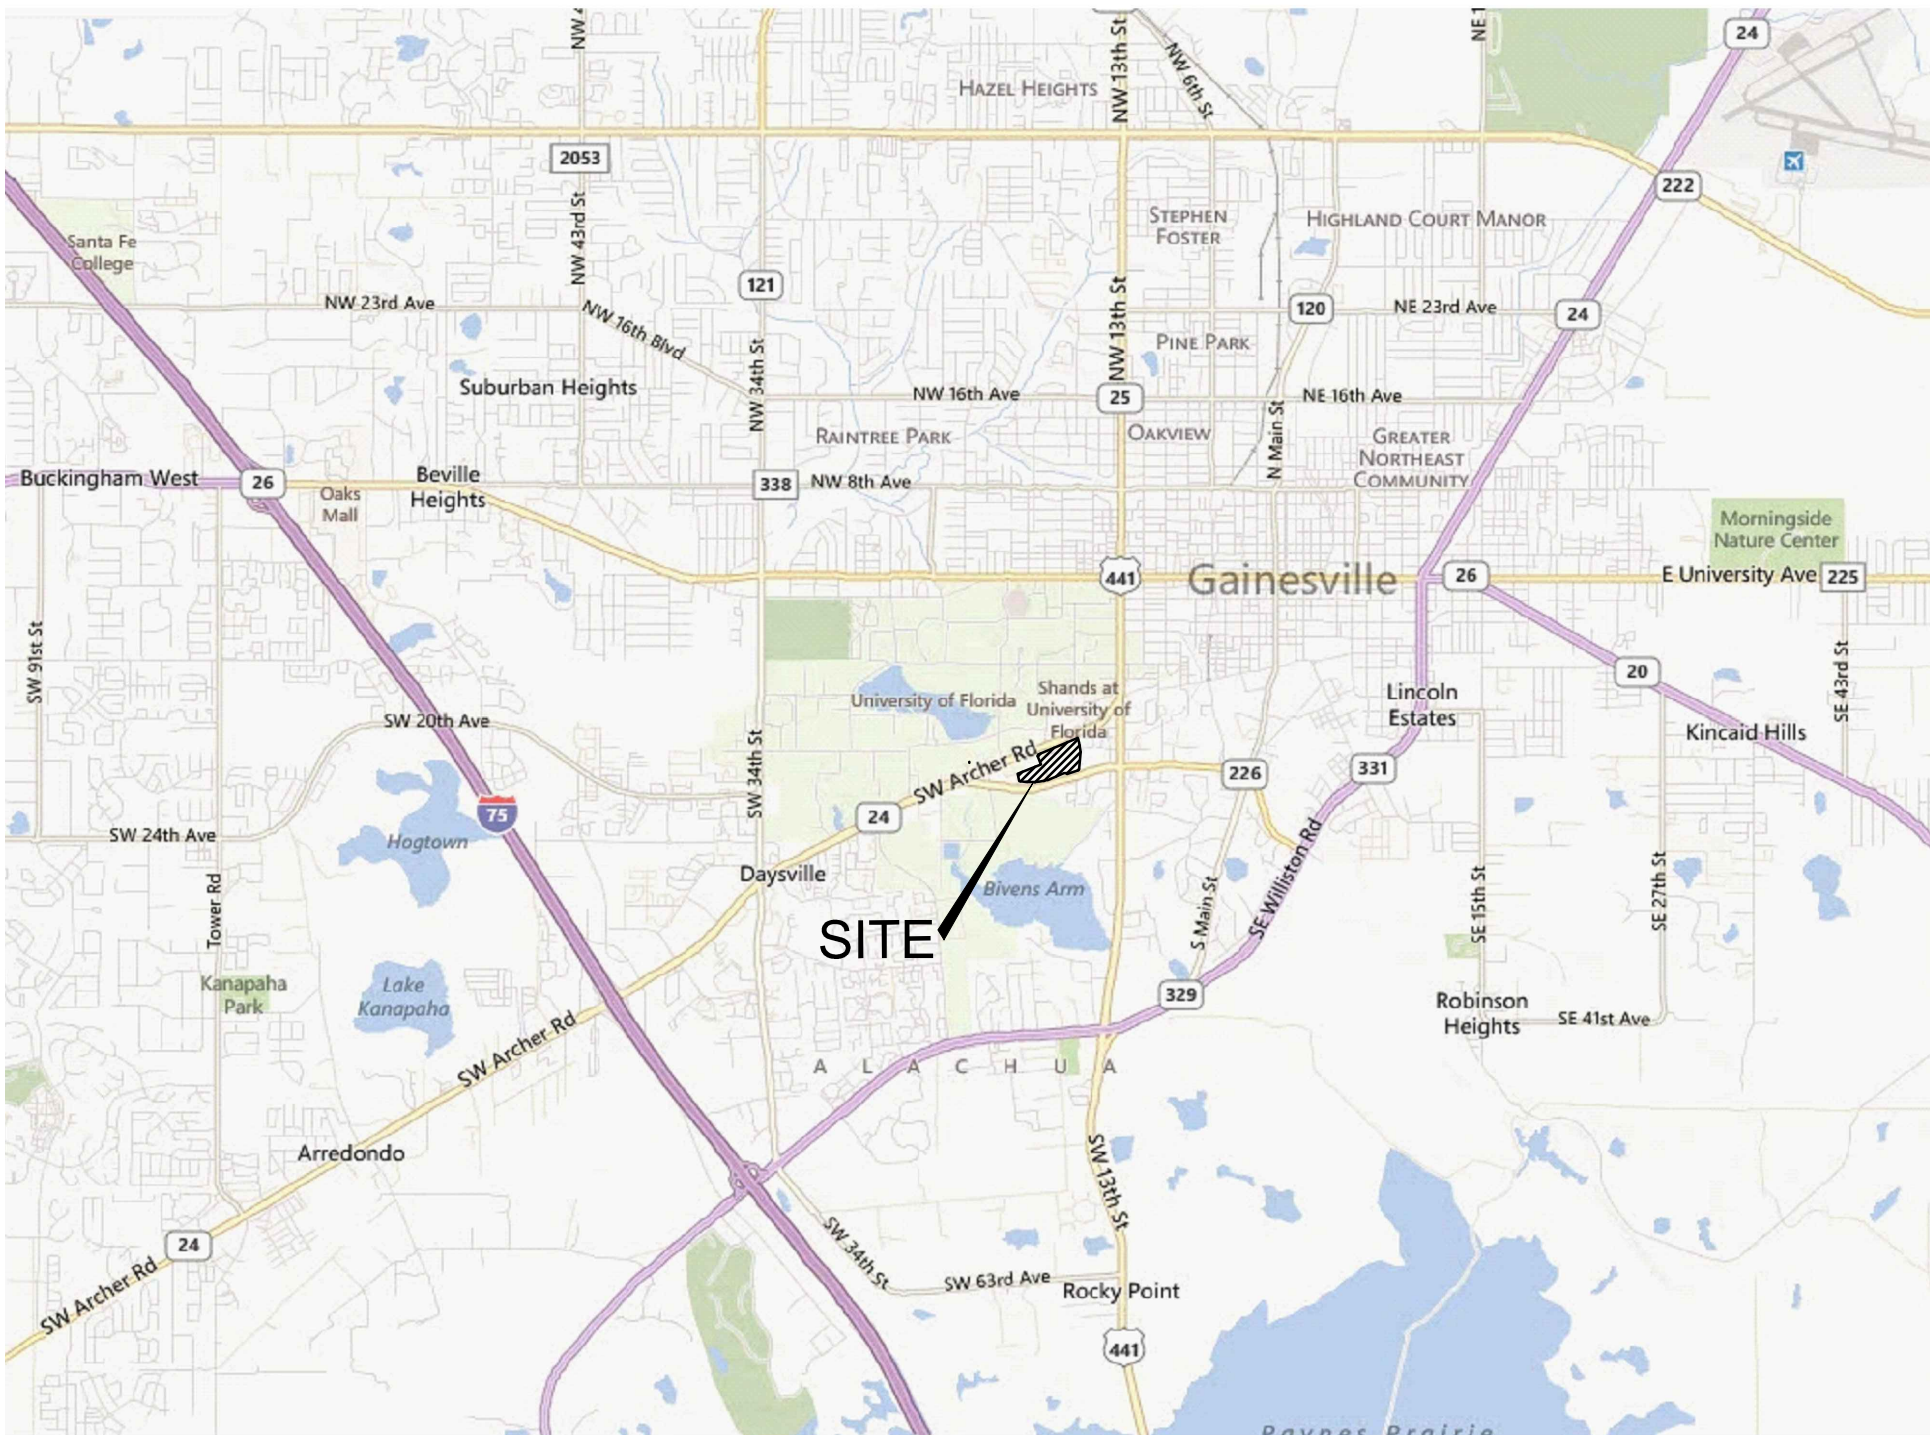

06/15/2016

SPRINKLE CONSULTING PROJECT # 1425-13



Index of Drawings	
Number	Title
GC.01	Cover Sheet
GC.02	Existing Parking & Accessibility Routes
GC.03	Proposed Parking & Accessibility Routes
GC.04	Phasing Plan
CS.01	Area 1A - Maintenance of Traffic & Erosion Control Plan
CD.01	Area 1A - Demolition Plan
CI.01	Area 1A - Proposed Improvements Plan
CG.01	Area 1A - Paving, Grading & Drainage Plan
CS.02	Area 1B - Maintenance of Traffic & Erosion Control Plan
CD.02	Area 1B - Demolition Plan
CI.02	Area 1B - Proposed Improvements Plan
CG.02	Area 1B - Paving, Grading & Drainage Plan
CS.03	Area 1C - Maintenance of Traffic & Erosion Control Plan
CD.03	Area 1C - Demolition Plan
CI.03	Area 1C - Proposed Improvements Plan
CG.03	Area 1C - Paving, Grading & Drainage Plan
CS.04	Area 3 - Maintenance of Traffic & Erosion Control Plan
CD.04	Area 3 - Demolition Plan
CI.04	Area 3 - Proposed Improvements Plan
CG.04	Area 3 - Paving, Grading & Drainage Plan
CS.05	Area 4 - Maintenance of Traffic & Erosion Control Plan
CD.05	Area 4 - Demolition Plan
CI.05	Area 4 - Proposed Improvements Plan
CG.05	Area 4 - Paving, Grading & Drainage Plan
CS.06	Area 5 - Maintenance of Traffic & Erosion Control Plan
CD.06	Area 5 - Demolition Plan
CI.06	Area 5 - Proposed Improvements Plan
CG.06	Area 5 - Paving, Grading & Drainage Plan
CS.07	Area 6 - Maintenance of Traffic & Erosion Control Plan
CD.07	Area 6 - Demolition Plan
CI.07	Area 6 - Proposed Improvements Plan
CG.07	Area 6 - Paving, Grading & Drainage Plan
CD.08	Areas 7A & 7B - Demolition Plan
CI.08	Areas 7A & 7B - Proposed Improvements Plan
CD.09	Area 8 - Demolition Plan
CI.09	Area 8 - Proposed Improvements Plan
CI.10	Area 4 - Concrete Ramp to Building T10 Plan, Sections & Details
CI.11	Areas 3 & 4 - Concrete Ramp to Building T1 Plan, Sections & Details
CI.12	Site Details A
CI.13	Site Details B
CI.14	Site Details C
E-001	Proposed Improvements Plan A
ED-101	Areas 5, 6, 7A, & 7B - Demolition Plan
ED-102	Areas 1A, 1B, 2, 3, & 5 - Demolition Plan
ED-103	Areas 3 & 4 - Demolition Plan
ED-104	Area 8 - Demolition Plan
E-201	Areas 5, 6, 7A, & 7B - Proposed Improvements Plan
E-202	Areas 1A, 1B, 2, 3, & 5 - Proposed Improvements Plan
E-203	Areas 3 & 4 - Proposed Improvements Plan
E-204	Area 8 - Proposed Improvements Plan

IPT TEAM DRAWING REVIEW			
IPT TEAM MEMBERS		APPROVED	DISAPPROVED
PHARMACY:			
M&O SUPERVISOR:			
M&R SUPERVISOR:			
PROJECT SECTION:			
BIOMED:			
SAFETY OFFICE:			
INDUSTRIAL HYGIENIST:			
PATIENT SAFETY:			
INFECTION CONTROL:			
EMS CHIEF:			
EMS CHIEF:			
DEPUTY DIRECTOR:			

Number	Description	Date
1	REVISED 100% CONSTRUCTION DRAWINGS	6/15/2016
2	REVISED SIDEWALKS AND CROSSWALKS	2/3/2017
3	REVISED 100% CONSTRUCTION DRAWINGS	3/7/2017

MECHANICAL / ELECTRICAL ENGINEERS:

MES GROUP

MES GROUP
550 NORTH REO STREET, SUITE 203
TAMPA, FL 33609
PHONE: (813) 289-4700
FAX: (813) 289-1041
WWW.MESGROUPINC.COM

J. DALLAS EVANS, P.E.
FLORIDA LICENSE # 72691

CIVIL ENGINEERS:

Sprinkle CONSULTING
Planners + Engineers
18115 U.S. HWY. 41 NORTH SUITE 600
LUTZ, FL 33549
PHONE: (813) 949-7449 FAX: (813) 909-9840
WWW.SPRINKLECONSULTING.COM
BOARD OF ENGINEERS CERTIFICATE OF AUTHORIZATION #4548

Drawing Title
COVER SHEET

Approved: Project Director

Project Status: REVISED 100% CONSTRUCTION DRAWINGS

Project Title
UPDATE SITE FOR COMPLIANCE WITH VA BARRIER FREE GUIDE

Location
GAINESVILLE, FL
PROJECT #573-13-601

Date
06/15/2016

Checked

Drawn

Project Number
573-13-601

Building Number
N/A

Drawing Number
GC.01
Dwg. 1 of 50

Office of Construction and Facilities Management

Department of Veterans Affairs