

VA MEDICAL CENTER BUILDING AUTOMATION SYSTEM UPGRADE - PHASE 2


Fargo, North Dakota

Project Number: 437-12-106

GENERAL
X1 COVER SHEET

MECHANICAL
H1 PARTIAL BASEMENT AND FIRST FLOOR PLANS
H2 OVERALL SECOND FLOOR PLAN
H3 OVERALL THIRD FLOOR PLAN
H4 OVERALL FOURTH FLOOR PLAN
H5 OVERALL PENTHOUSE/ATTIC PLAN
H6 BASEMENT, SECOND FLOOR AND THIRD FLOOR LARGE SCALE PLANS
H7 FOURTH FLOOR, ATTIC SPACE AND PENTHOUSE LARGE SCALE PLANS
H8 CONTROL DIAGRAM
H9 AIR HANDLER INFORMATION SCHEDULE

ELECTRICAL
E1 OVERALL BASEMENT PLANS - ELECTRICAL REVISIONS
E2 OVERALL THIRD FLOOR PLAN - ELECTRICAL REVISIONS
E3 OVERALL FOURTH FLOOR PLAN - ELECTRICAL REVISIONS
E4 OVERALL PENTHOUSE AND ATTIC PLANS - ELECTRICAL REVISIONS

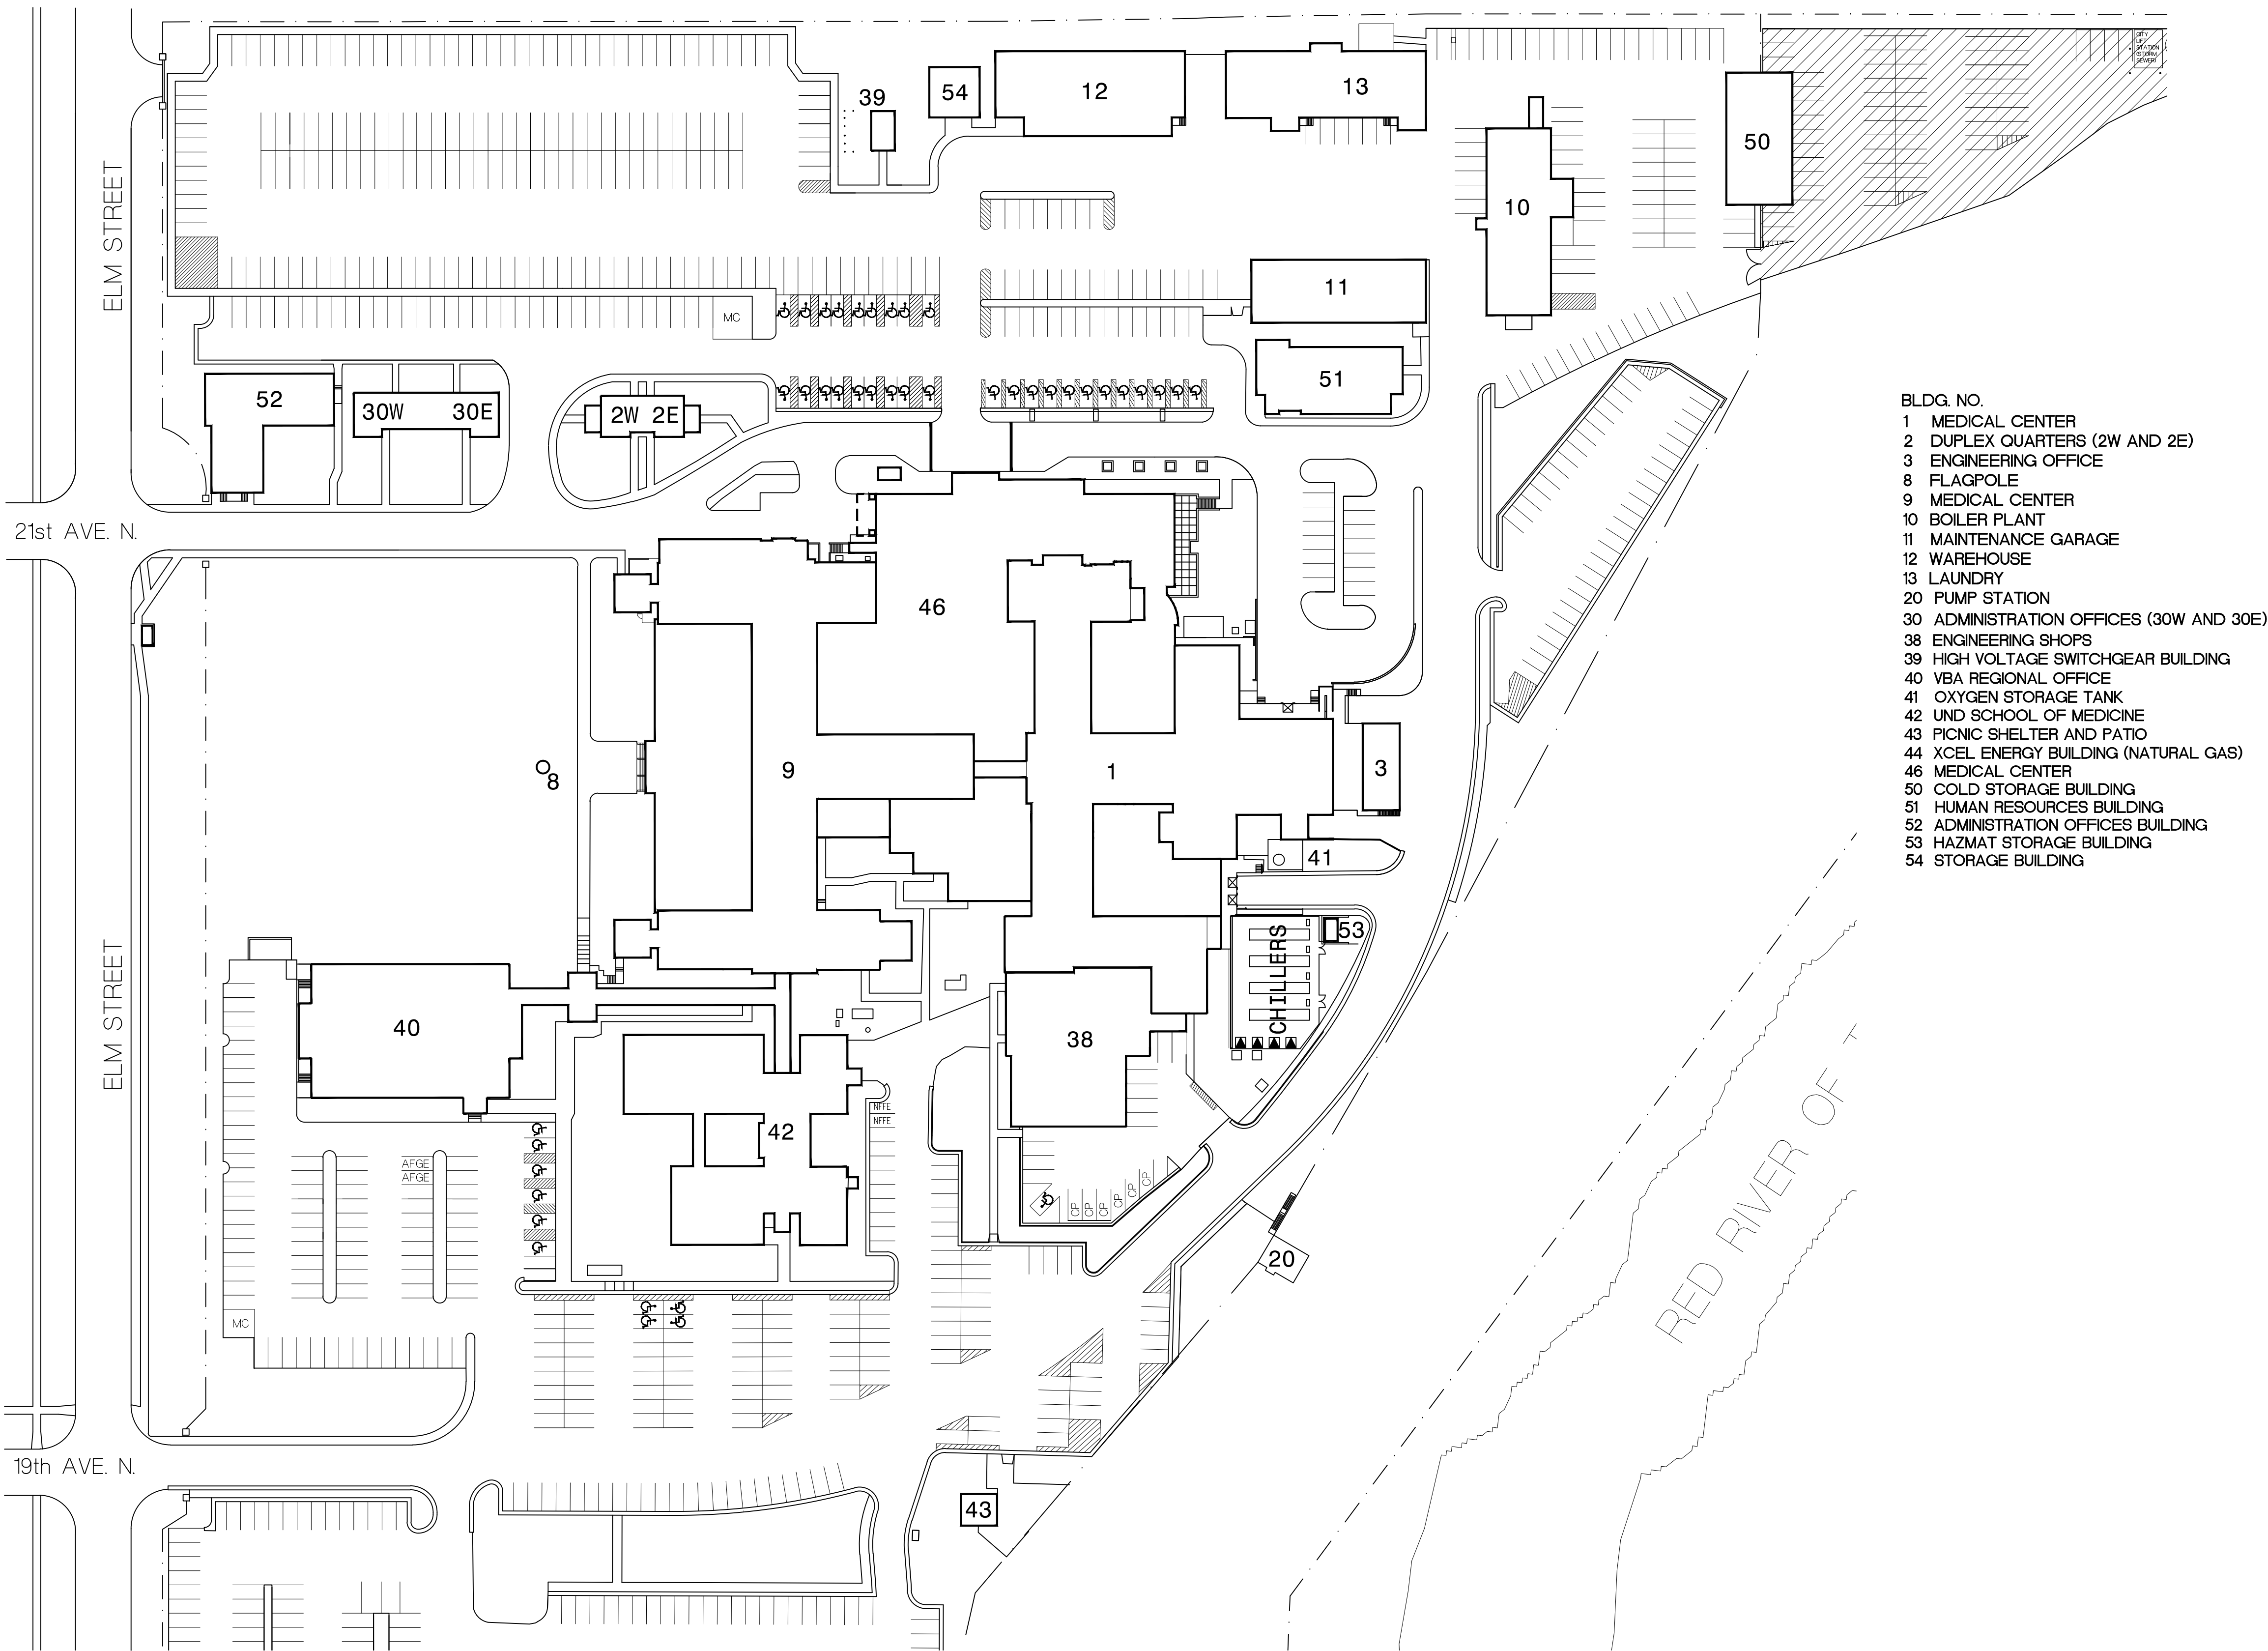

- BLDG. NO.
- 1 MEDICAL CENTER
 - 2 DUPLEX QUARTERS (2W AND 2E)
 - 3 ENGINEERING OFFICE
 - 8 FLAGPOLE
 - 9 MEDICAL CENTER
 - 10 BOILER PLANT
 - 11 MAINTENANCE GARAGE
 - 12 WAREHOUSE
 - 13 LAUNDRY
 - 20 PUMP STATION
 - 30 ADMINISTRATION OFFICES (30W AND 30E)
 - 38 ENGINEERING SHOPS
 - 39 HIGH VOLTAGE SWITCHGEAR BUILDING
 - 40 VBA REGIONAL OFFICE
 - 41 OXYGEN STORAGE TANK
 - 42 UND SCHOOL OF MEDICINE
 - 43 PICNIC SHELTER AND PATIO
 - 44 XCEL ENERGY BUILDING (NATURAL GAS)
 - 46 MEDICAL CENTER
 - 50 COLD STORAGE BUILDING
 - 51 HUMAN RESOURCES BUILDING
 - 52 ADMINISTRATION OFFICES BUILDING
 - 53 HAZMAT STORAGE BUILDING
 - 54 STORAGE BUILDING

KEY TO SITE PLAN
CONTRACTOR STAGING AREA. SHARED WITH VA AND OTHER CONTRACTORS.

SITE PLAN
T-60'-0"



Dept. of Veterans Affairs
Medical Center
2101 Elm Street North
Fargo, ND 58102



IMAGE GROUP INC.
403 CENTER AVENUE, SUITE 300
MOOREHEAD, MN 56560



ONE
BUILDING SYSTEMS CONSULTANTS
Fargo, ND • Grand Forks, ND • Alexandria, MN
701.280.9500 • 701.775.2594 • 338.846.0300

IMAGE GROUP INC, Architecture & Interiors
OSBERMILLER NELSON ENGINEERING, Mechanical Engineers
MEN ENGINEERING, Electrical Engineers

I hereby certify that this plan specification, or report was prepared by me or under my direct supervision, and that I am duly Registered Architect under the laws of the State of North Dakota.

Date 3/30/2012 Reg. No. 378

Drawing Title COVER SHEET		Project Title VA MEDICAL CENTER BUILDING AUTOMATION SYSTEM UPGRADE - PHASE 2		Date APRIL 18, 2012
VA Project No. 437-12-106		Contract No. VA263-P-1217 VA263-C-		Scale 1"=60'-0"
Building No. 1, 9, 38, 46		AutoCAD File Name COVER.DWG		Drawing No. X1
		Designed By RM		Checked By RM
		Drawn By KS		Dwg. 1 of 14
		Location VA MEDICAL CENTER FARGO, ND		

