




three inches = one foot
one and one half inches = one foot
one inch = one foot
three quarters inch = one foot
one half inch = one foot
three eighths inch = one foot
one quarter inch = one foot
one eighth inch = one foot

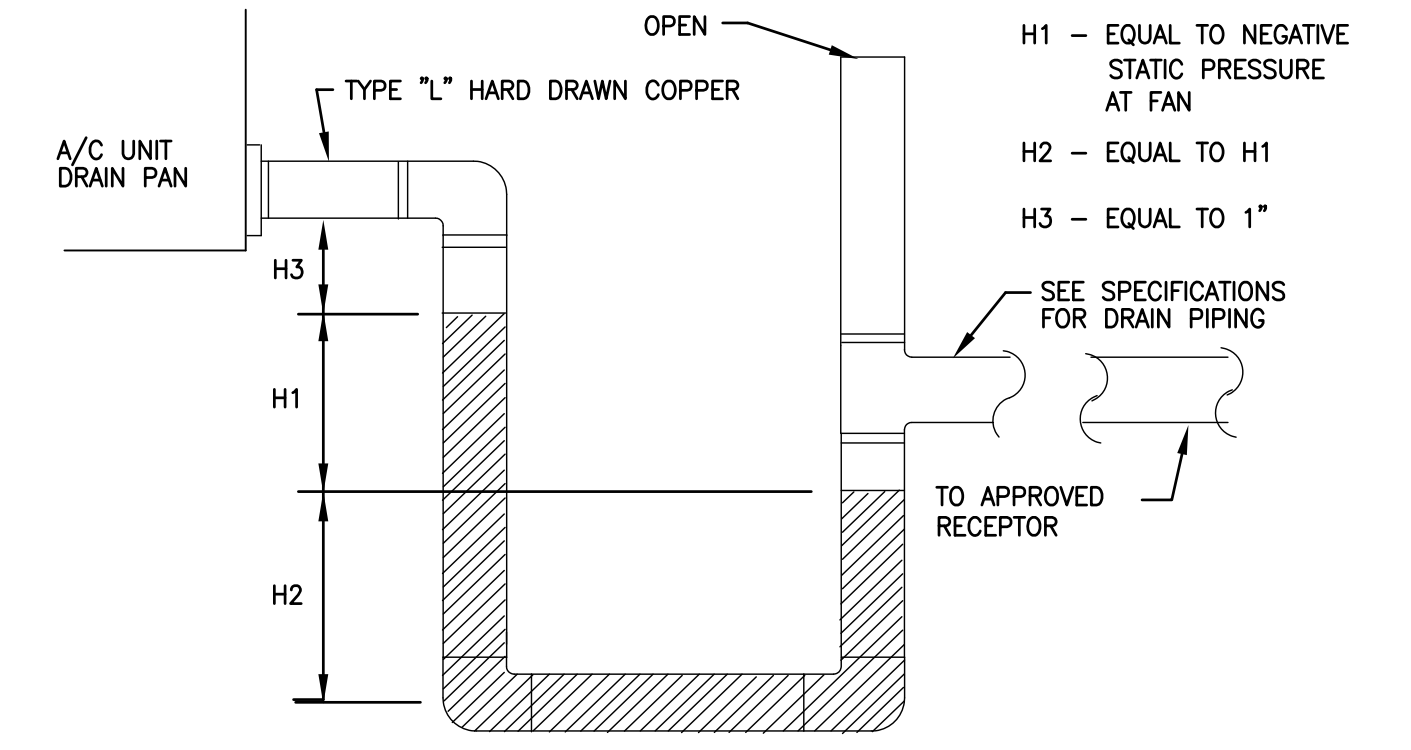



1 CONDENSATE DRAIN DETAIL
NOT TO SCALE

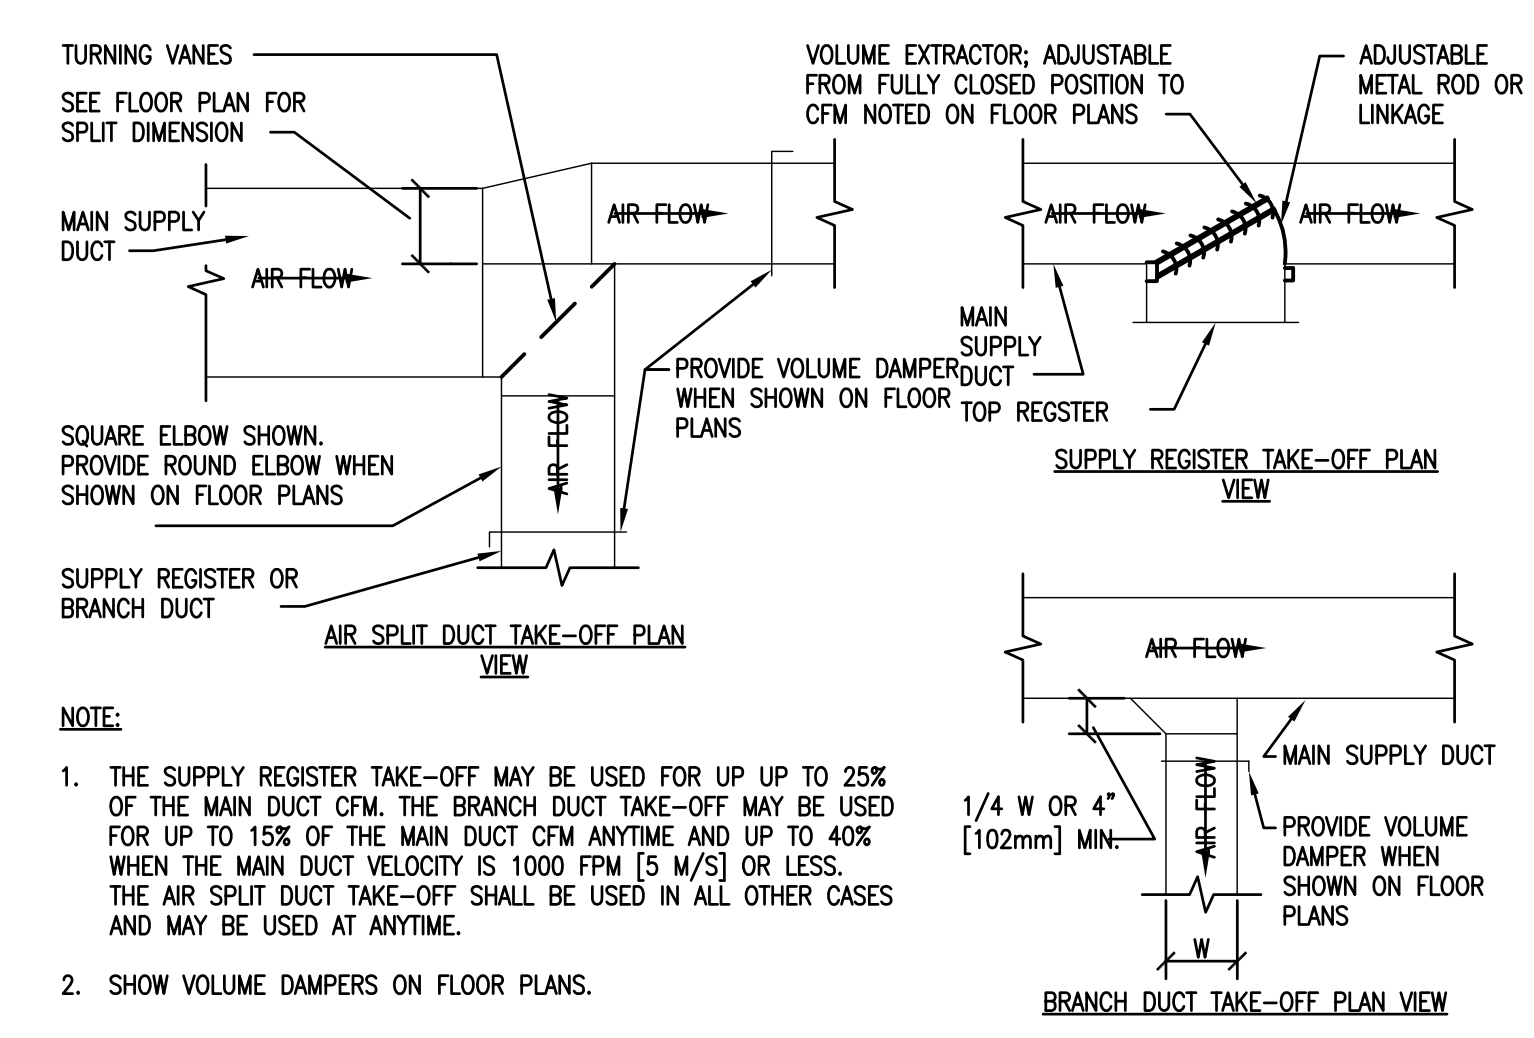

2 FLEXIBLE DUCT TAP DETAIL
NOT TO SCALE

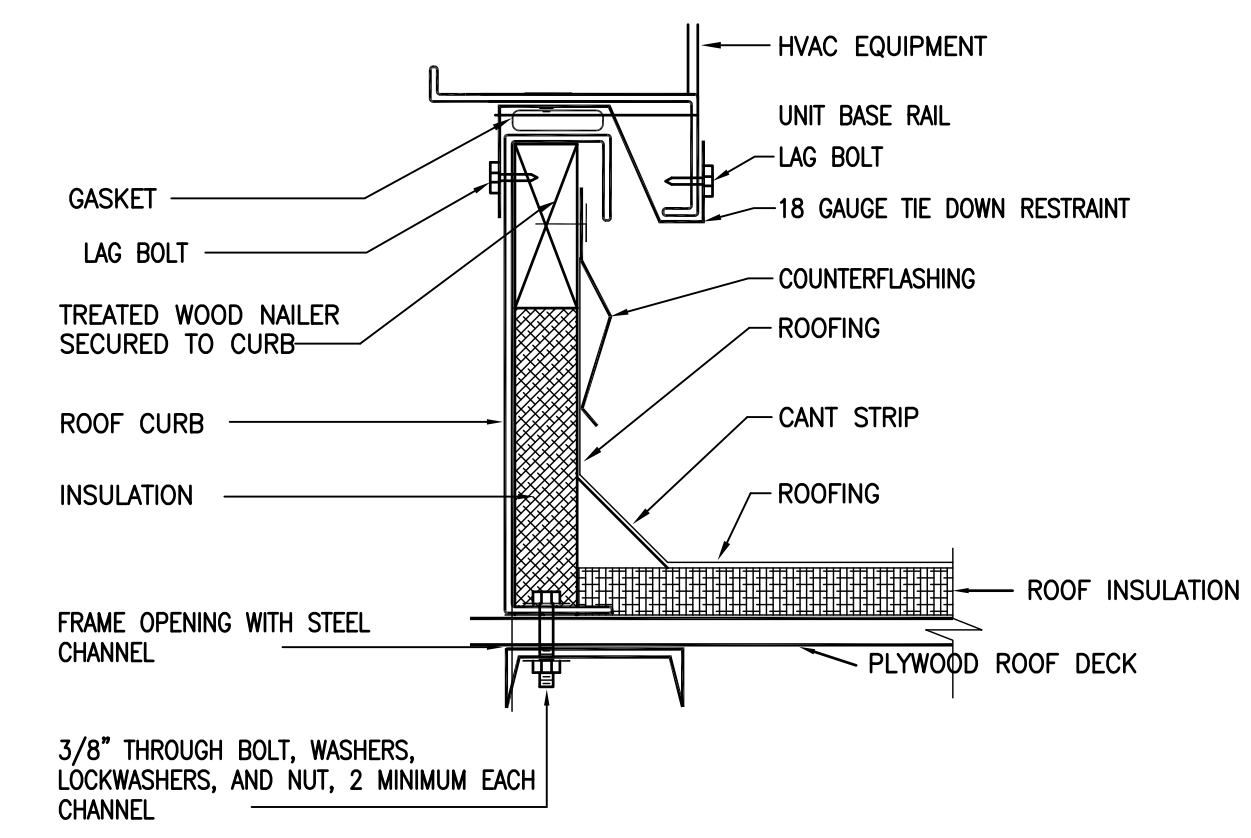


3 ROOFTOP EQUIP. CURB DETAIL
SCALE: NO SCALE

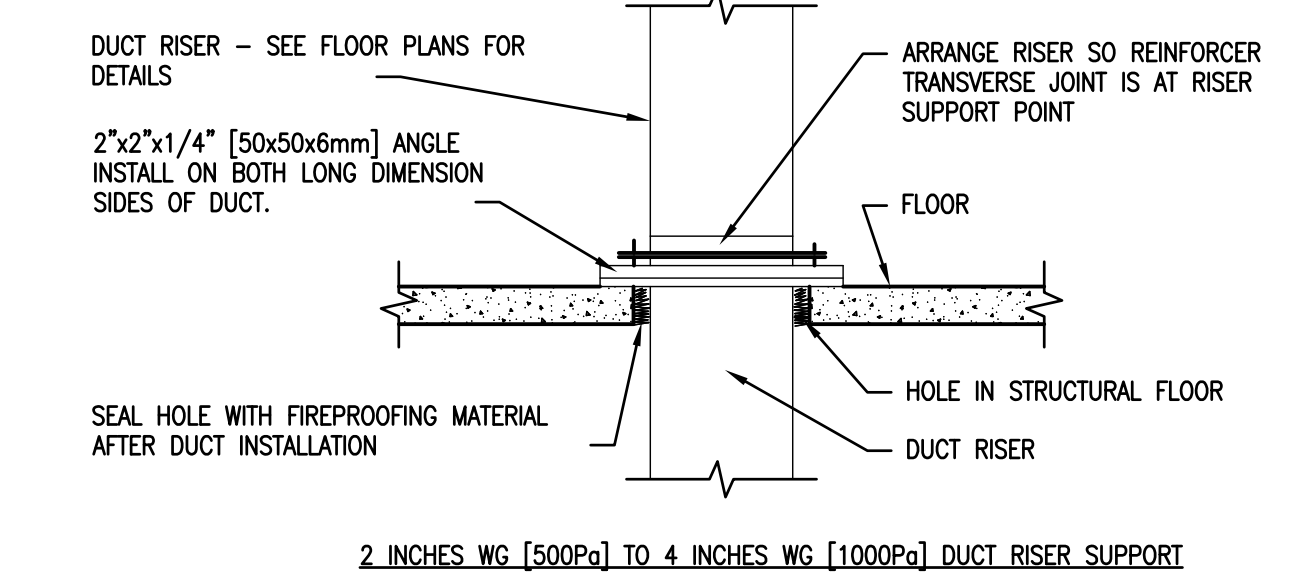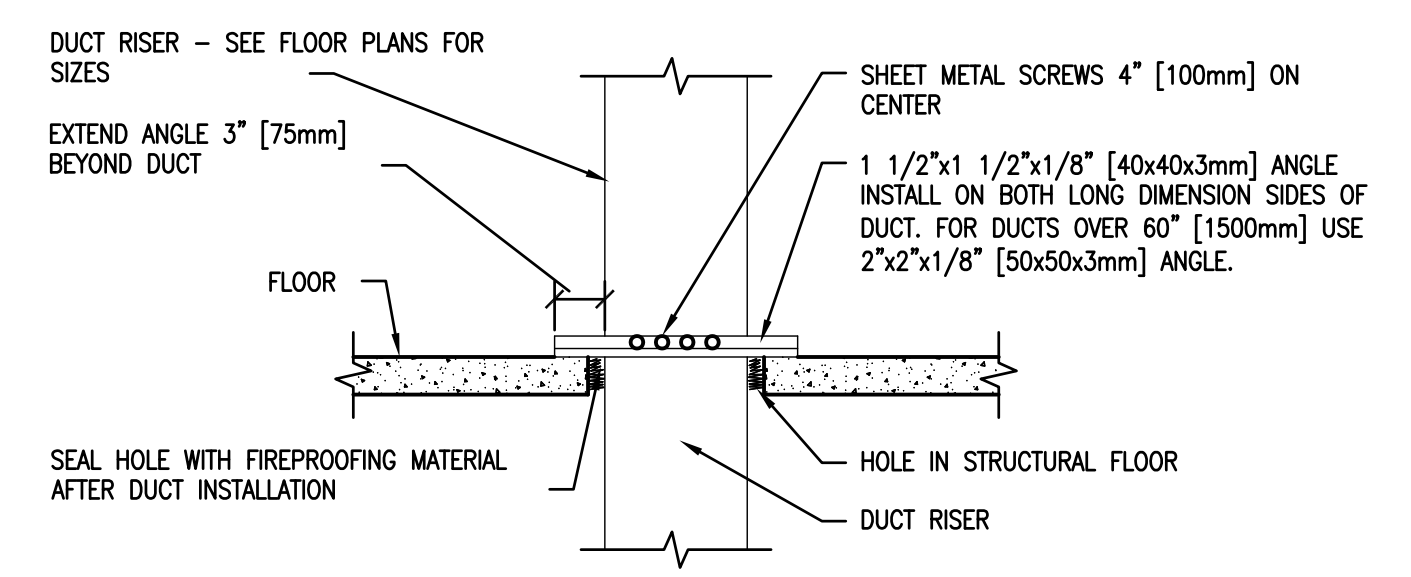

NOTE:
ALL DUCT WORK RISERS WHICH ARE RUN EXPOSED, SUCH AS THRU ATTIC FLOORS AND FAN ROOM FLOORS SHALL BE PROVIDED WITH A 3" [75mm] HIGH CONCRETE CURB AROUND OPENING FOR DUCT.


4 DUCT RISER SUPPORTS
SCALE: NO SCALE

5 SUPPLY DUCTWORK TAKE-OFFS
NOT TO SCALE

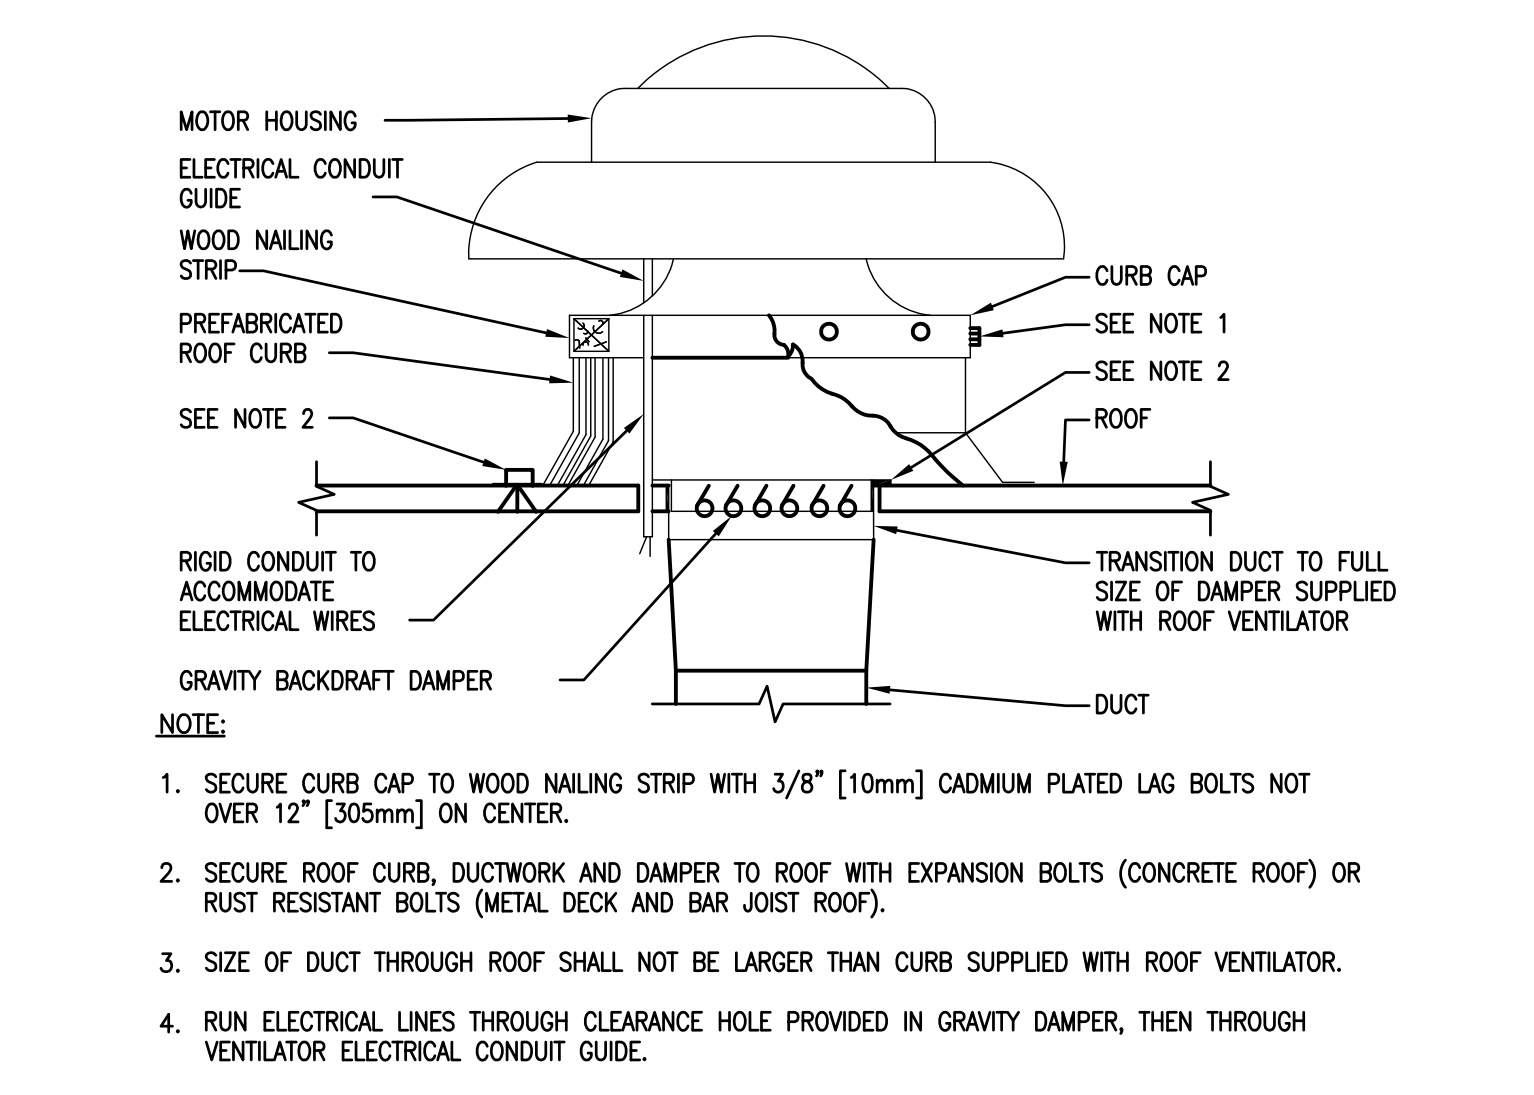



9 TYPICAL POWER TYPE ROOF VENTILATOR
SCALE: NO SCALE

6 ROOFTOP UNIT MOUNTING DETAIL
SCALE: NO SCALE

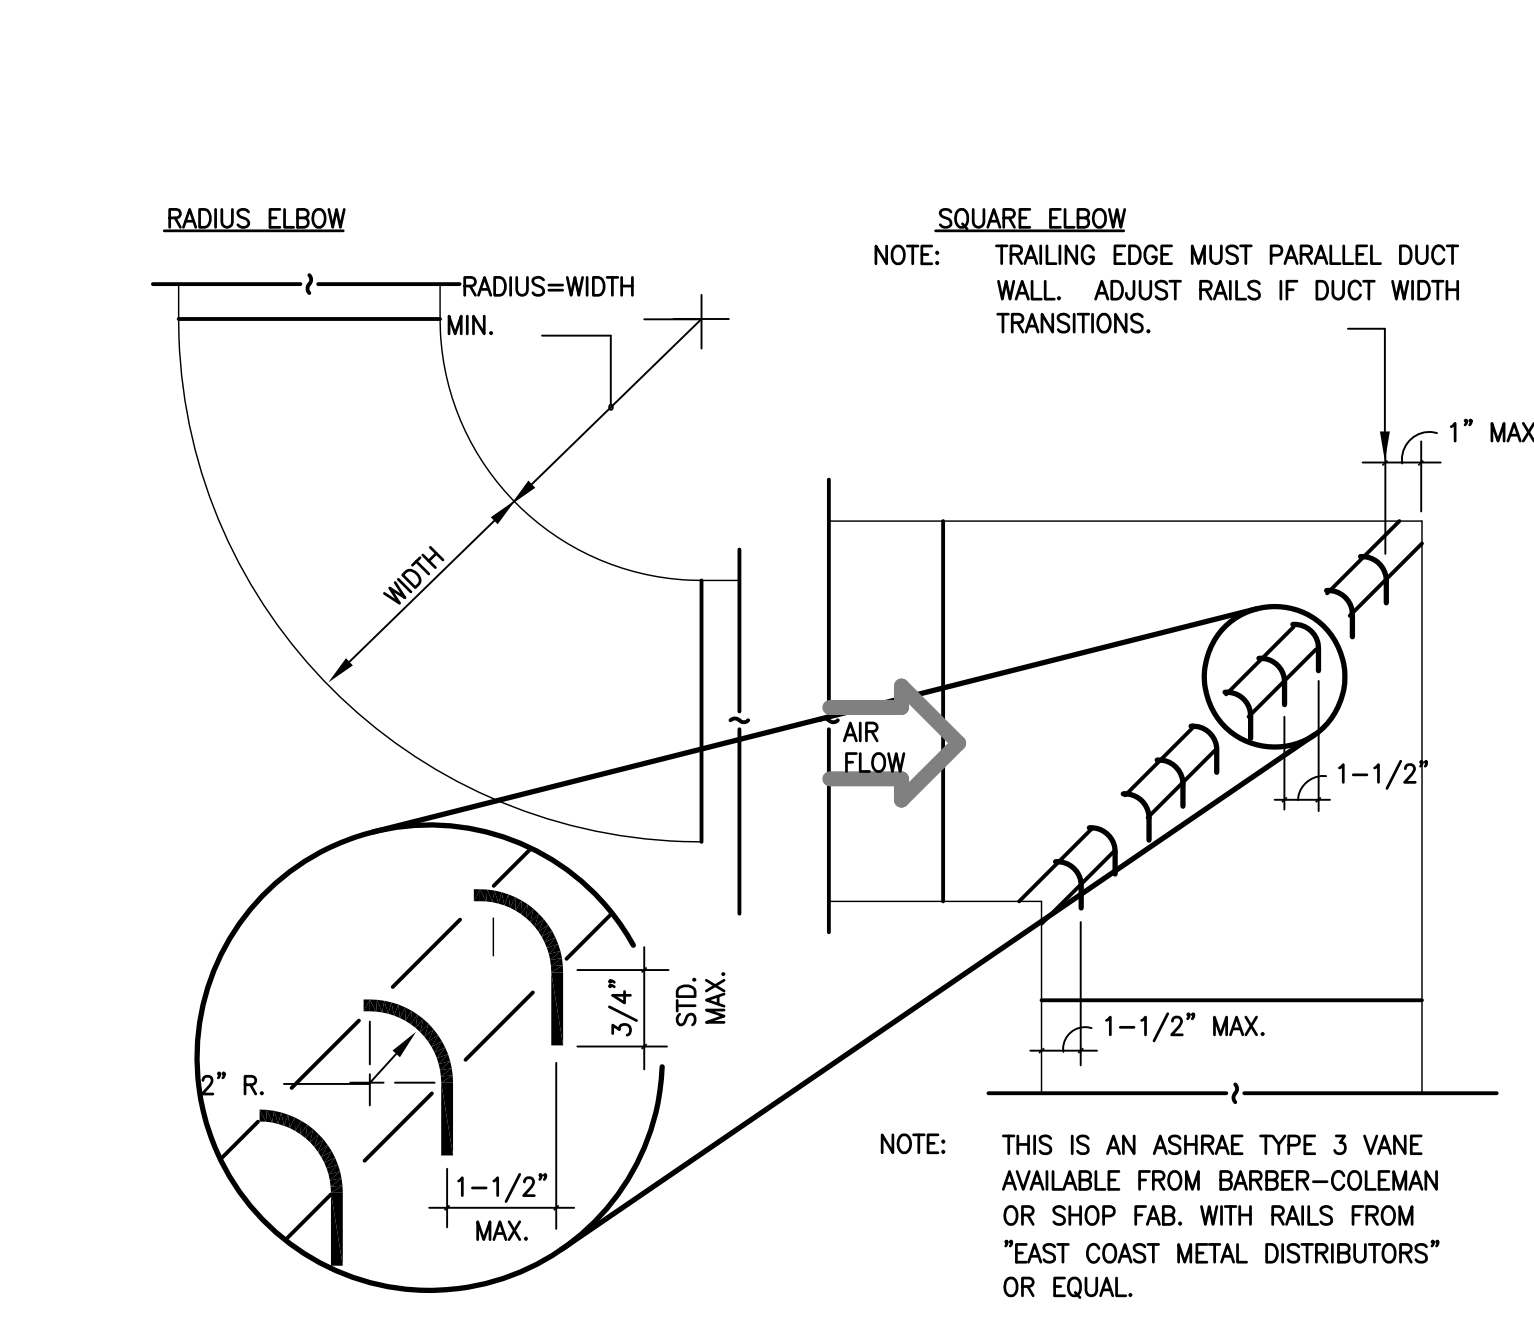

10 TYPICAL DUCT ELBOW
NOT TO SCALE

7 DUCTWORK RADIUS ELBOWS
SCALE: NO SCALE

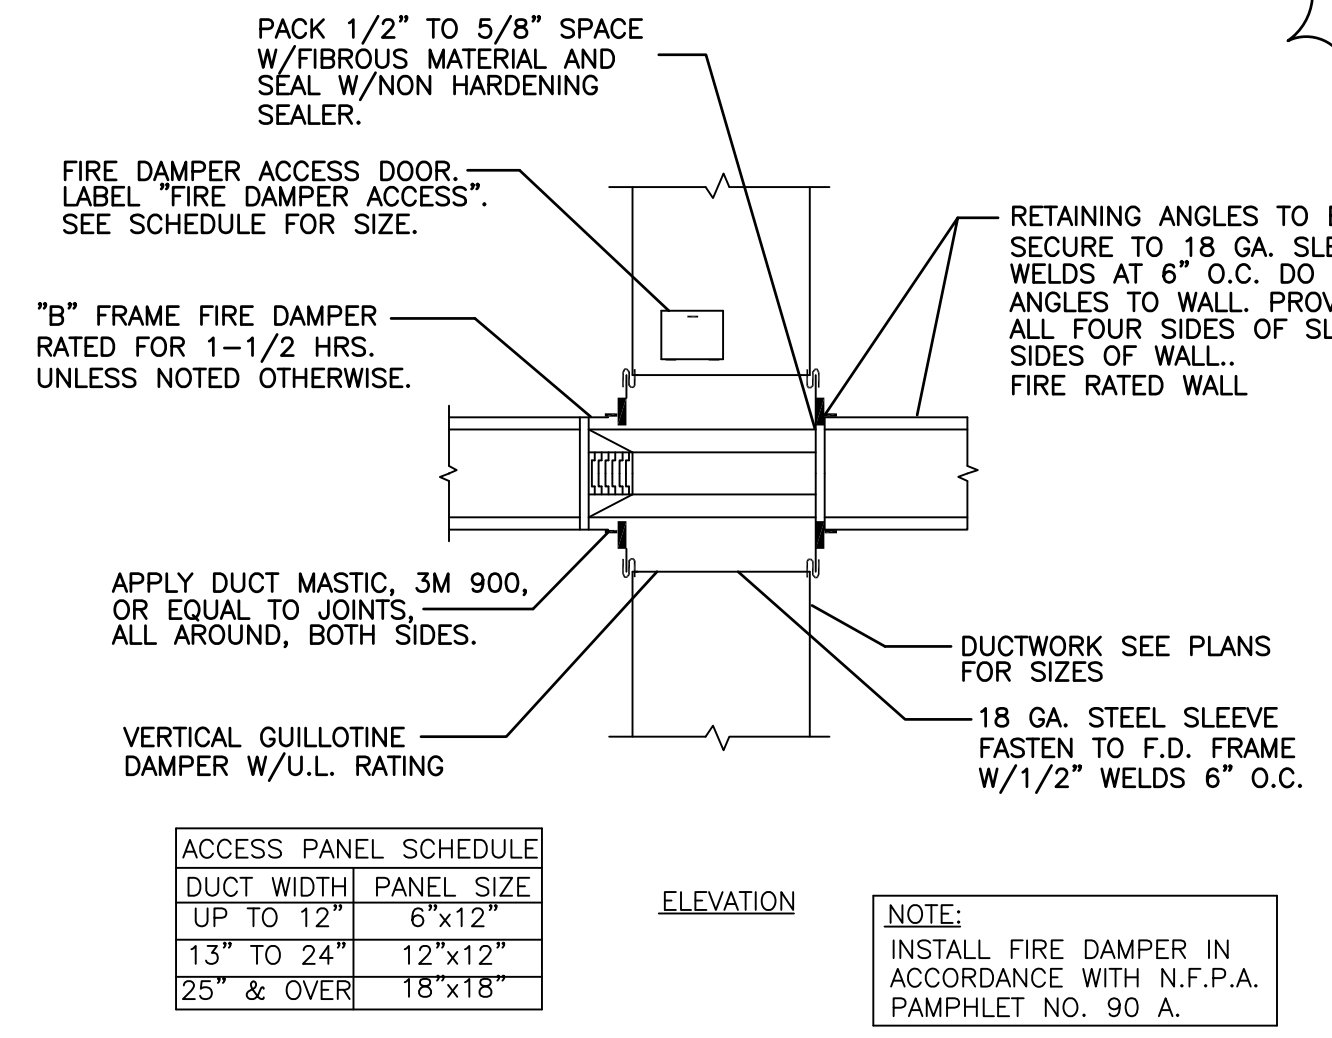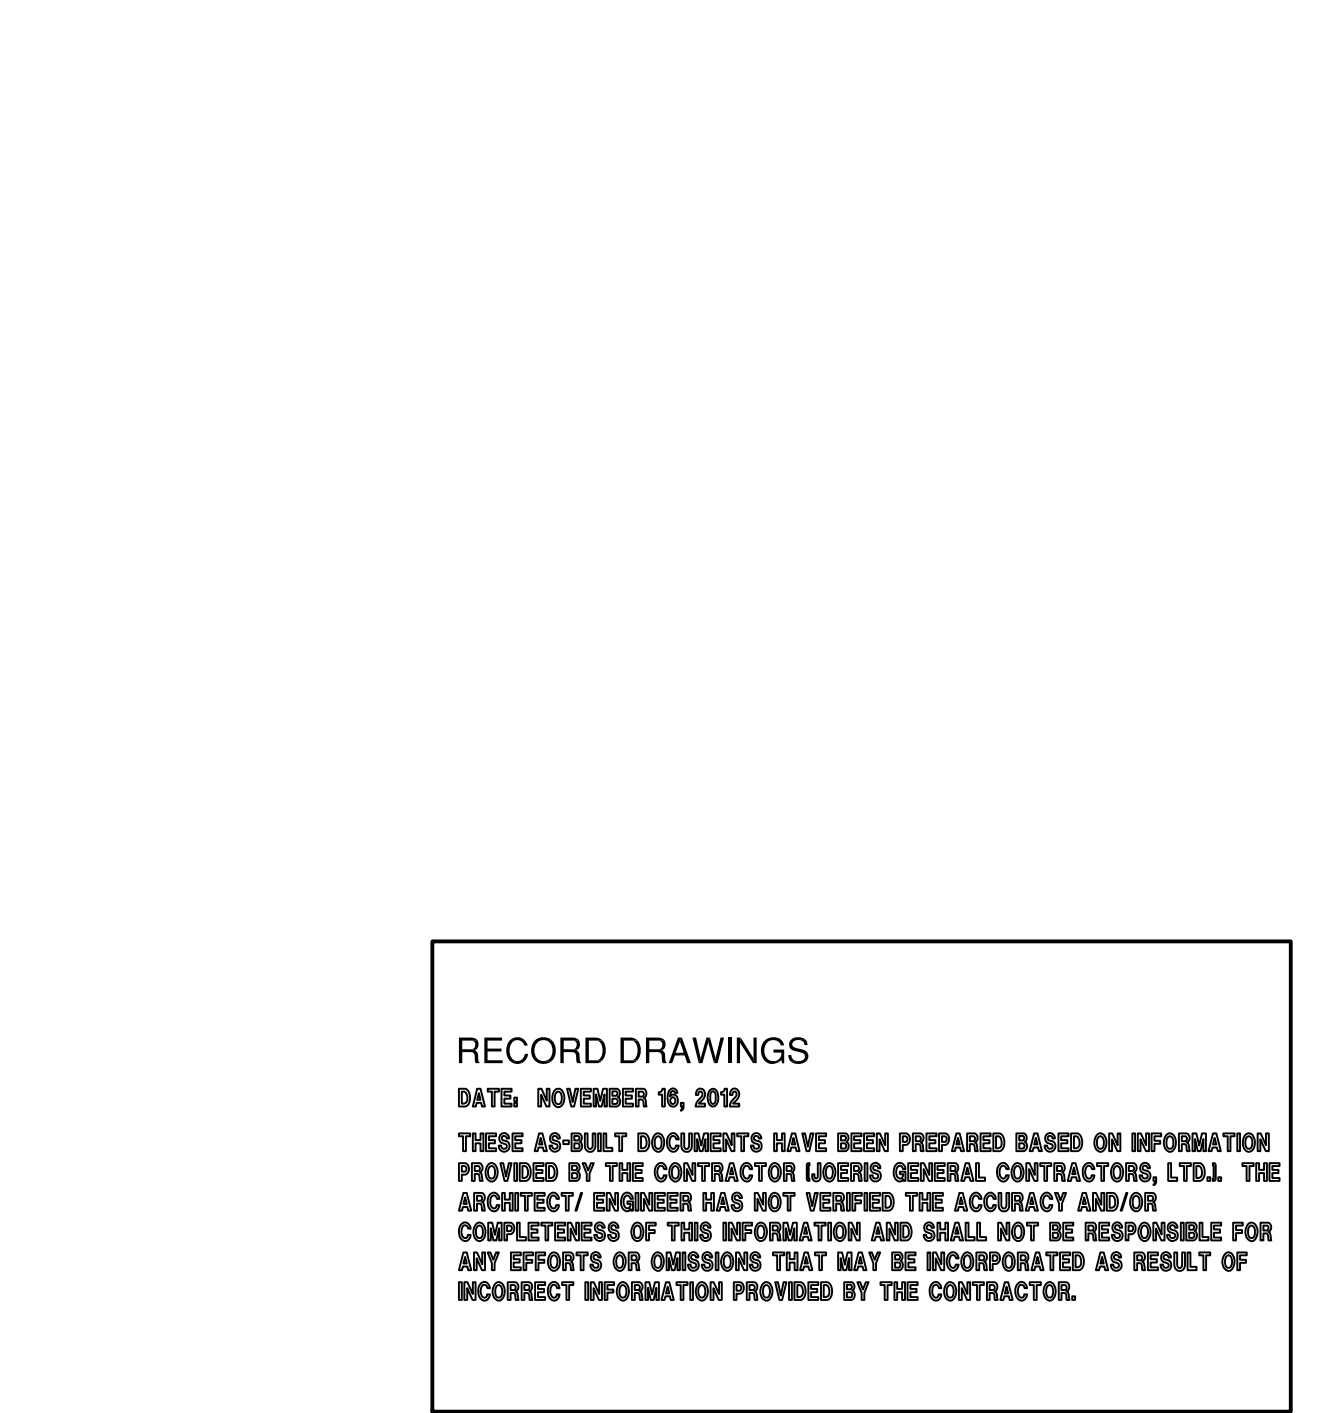

11 FIRE DAMPER DETAIL
NOT TO SCALE

AS/4		04/04/11	CONSULTANTS:			Approved: Assistant Director			Approved: Chief of Staff			Approved: Chief, Engineering			ARCHITECT:			Drawing Title			Project Title			Project Number			Office of Facilities Management					
			TEXAS REGISTERED ENGINEERING FIRM F-10487 700 N. ST. MARY'S SUITE 1225 SAN ANTONIO, TX 78205 WWW.RDMENGINEERING.NET PHONE: 210.299.4522 FAX: 210.299.4525			Approved: Service Chief			Approved: Service Chief			Approved: Service Chief			WEST EAST DESIGN GROUP  1617 E. COMMERCE ST., SUITE 7102, SAN ANTONIO, TEXAS 78205 USA 210.530.0755 FAX 210.530.9427			MECHANICAL DETAILS			POLYTRAUMA TRANSITIONAL HOUSING			671-237								
						Approved: Chief, Biomed			Approved: Chief, EMS			Approved: Chief, Infection Control												Building Number								
						Approved: Chief, IT			Approved: Chief, M & O			Approved: Chief, Police												1								
						Approved: Chief, Safety			Approved: Chief			Approved: Chief						Approved Project Director			Location			Drawing Number								
																					Audie L. Murphy Memorial Veterans Hospital San Antonio, Texas			MH3.2								
																					Date			Checked			Drawn			Dwg. 7 of 10		
																					28 JULY 2010									 Department Veterans A		
Revisions:		Date																														