



three inches = one foot
one and one half inches = one foot
one inch = one foot
three quarters inch = one foot
one half inch = one foot
three eighths inch = one foot
one quarter inch = one foot
one eighth inch = one foot

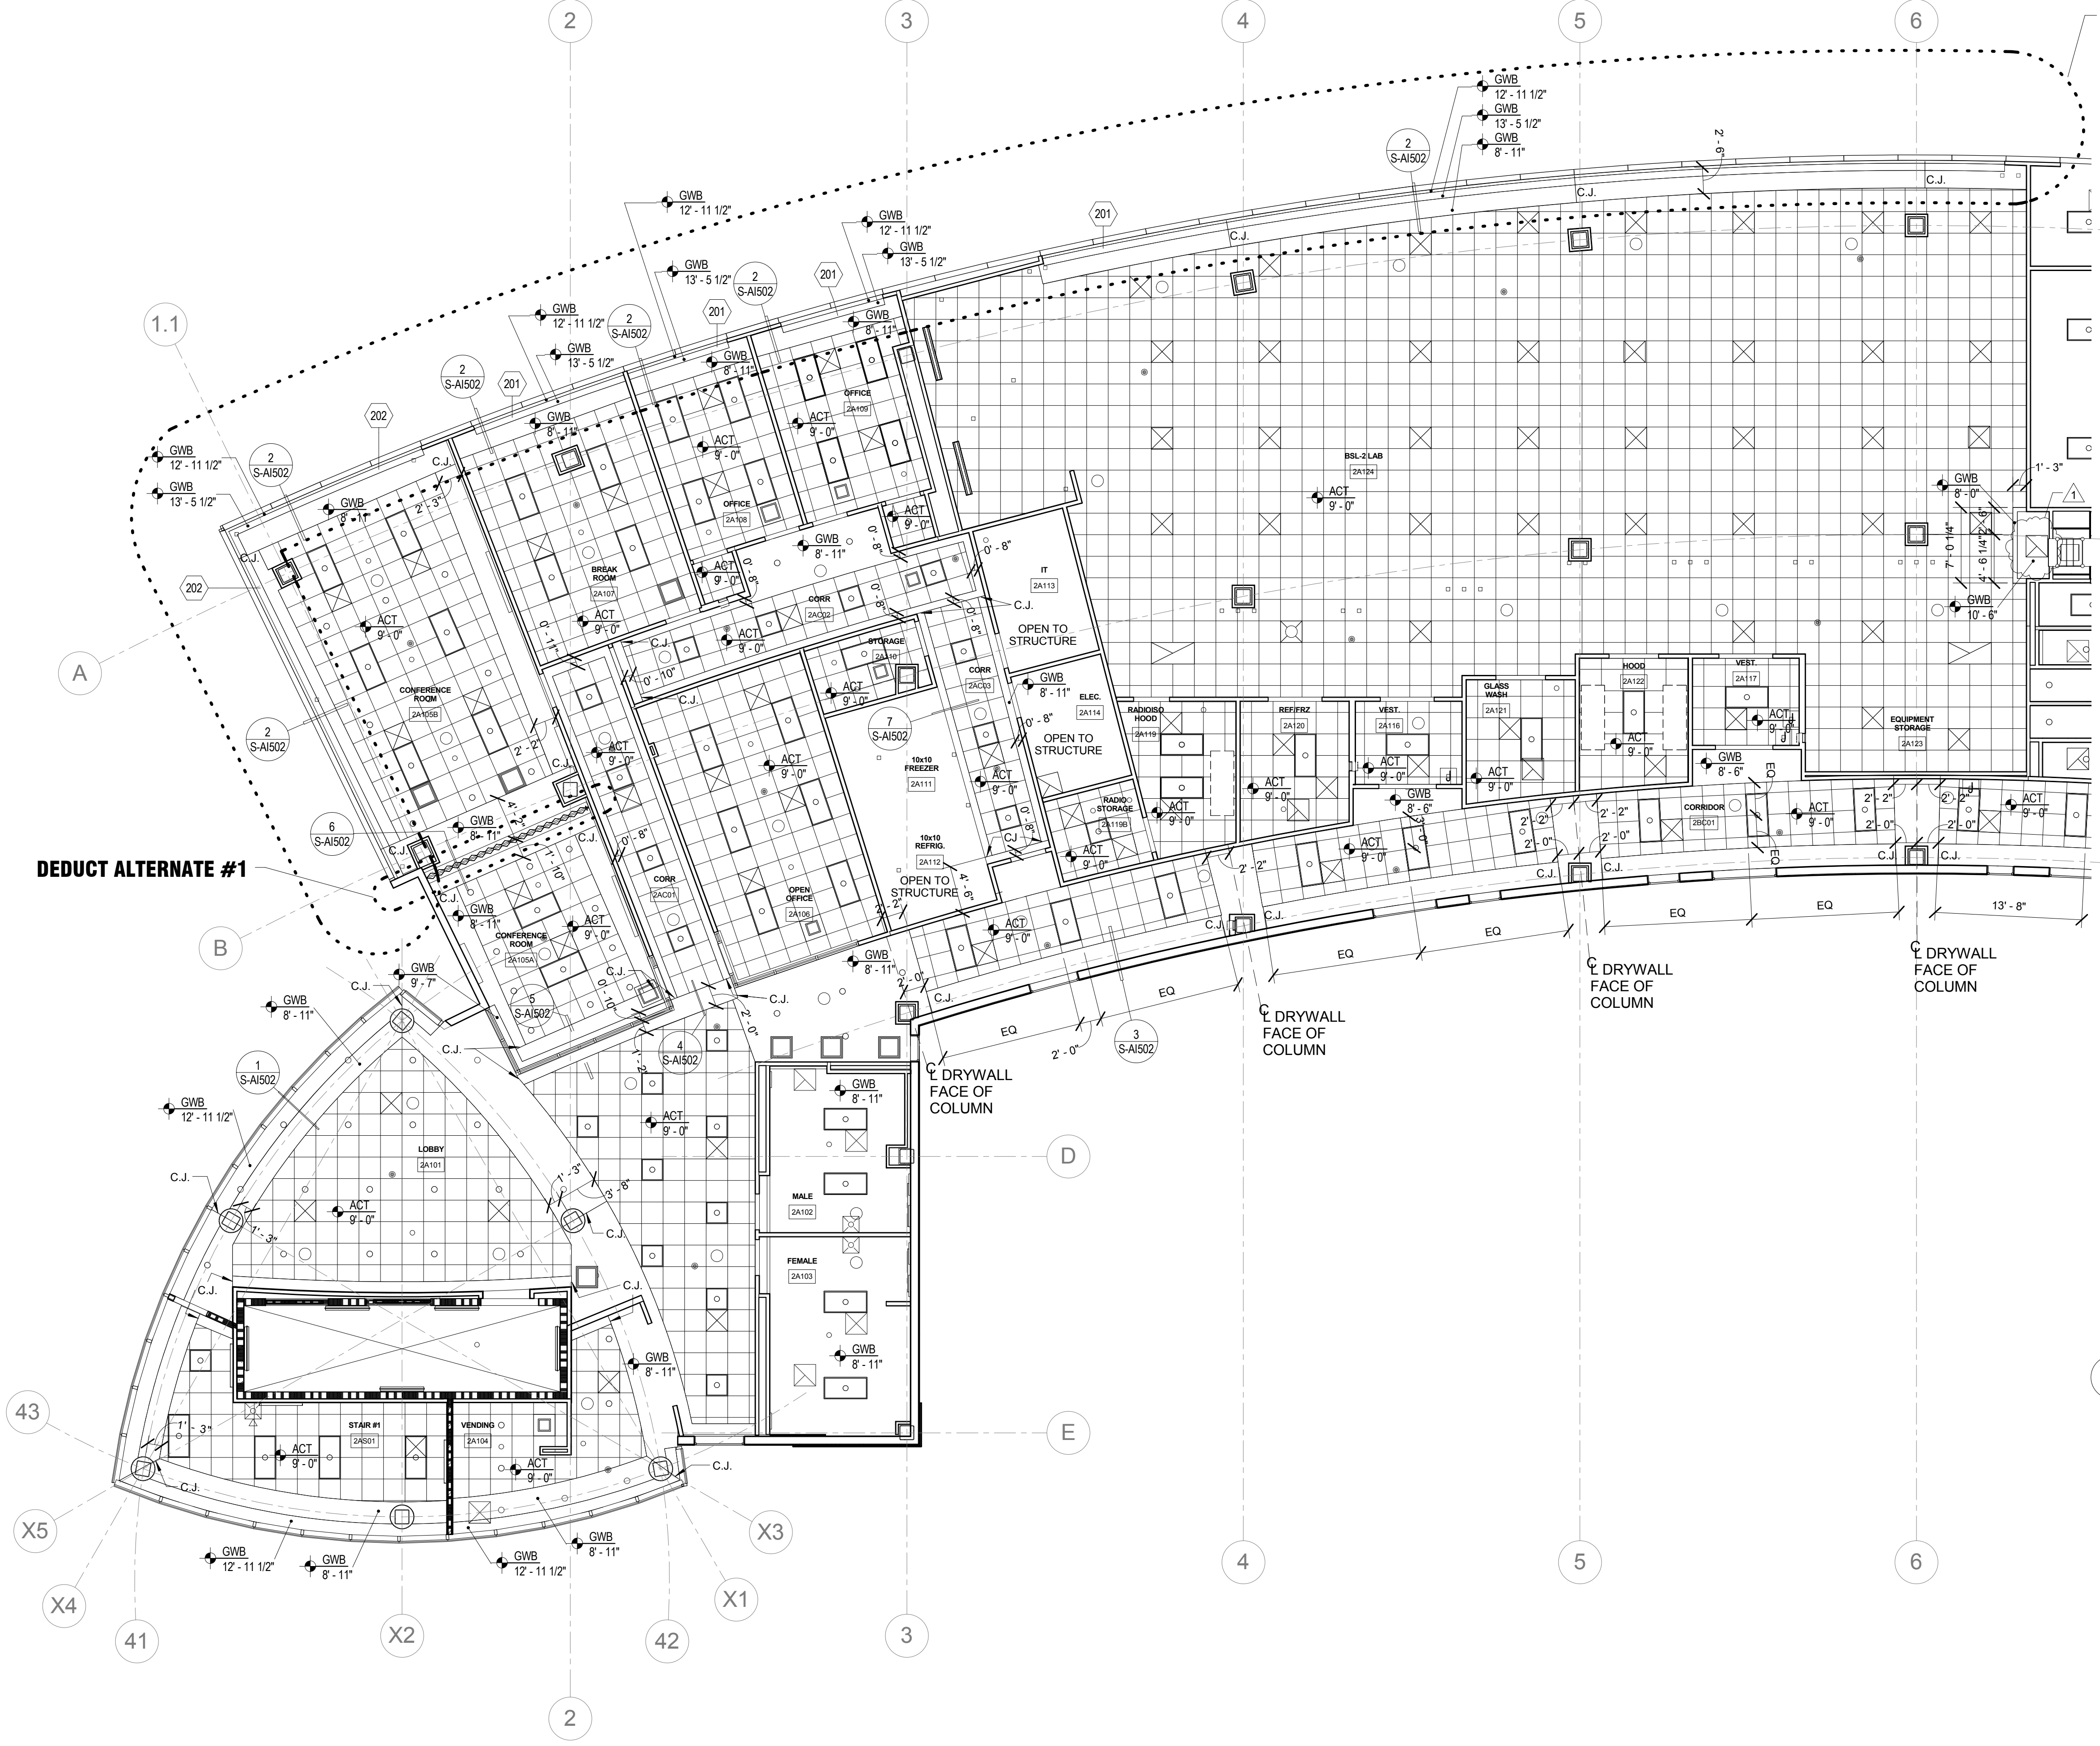

1 SECOND FLOOR RCP - NORTH
1/8" = 1'-0"

DEDUCT ALTERNATE #7
OMIT GYPSUM BOARD SOFFIT AT EXTERIOR WALL. EXTEND ACT TO WALL INSTEAD.

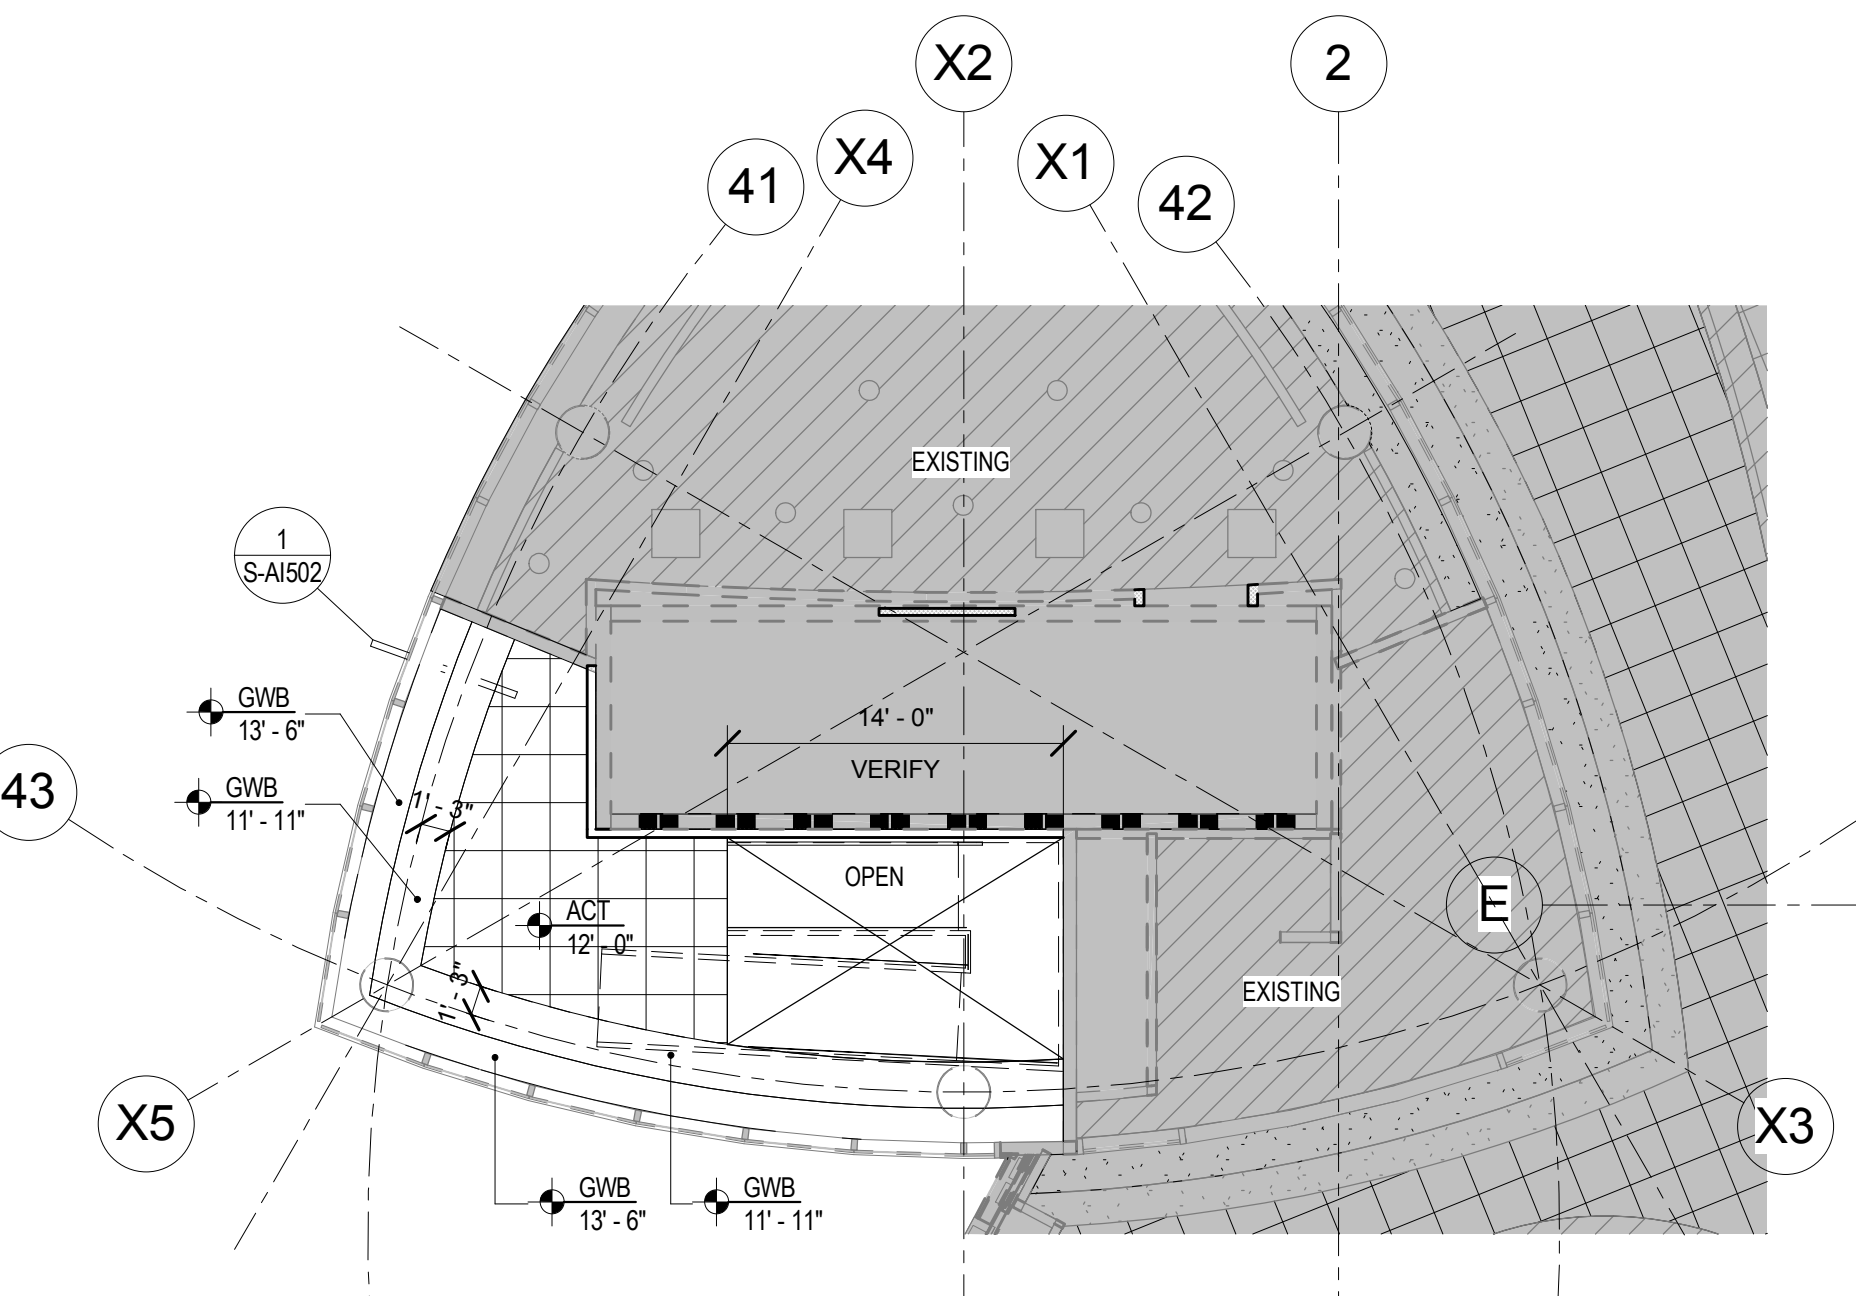

2 FIRST FLOOR RCP - NORTH
1/8" = 1'-0"

CEILING PLAN NOTES


- REFER TO SPECIFICATIONS FOR PRODUCT AND MATERIAL INFORMATION. REFER TO INDIVIDUAL SECTIONS FOR MATERIAL SELECTION KEY CODES AND COLOR SCHEDULE(S).
- REFER TO ENGINEERING DRAWINGS AND SPECIFICATIONS FOR FIXTURE AND EQUIPMENT SCHEDULES.
- CEILING MOUNTED DEVICES (LIGHT FIXTURES, DIFFUSERS, SPRINKLER HEADS, ETC.) TO BE CENTERED IN CEILING TILES UNLESS NOTED OTHERWISE.
- SEE S-AI502 FOR TYPICAL CEILING DETAILS.

SHEET KEYNOTES



- | | |
|-----|---|
| 201 | WS-1, MANUAL OPERATION, FULL WIDTH OF WINDOW. SEE SPECIFICATION. |
| 202 | WS-2, WITH ADDED ROOM DARKENING, MANUAL OPERATION, FULL WIDTH OF WINDOW. SEE SPECIFICATION. |

REFLECTED CEILING PLAN SYMBOLS

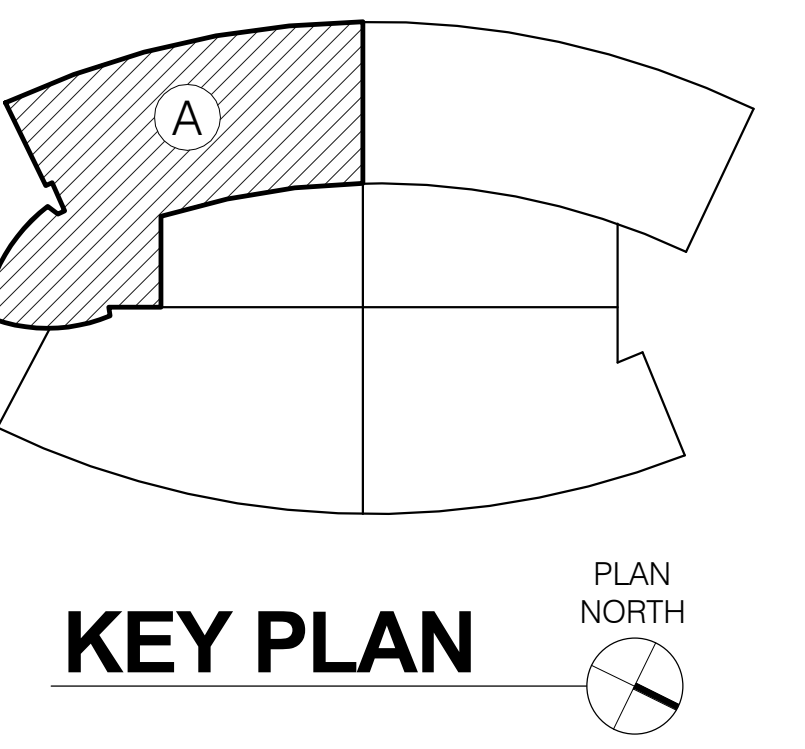- | | |
|----------|---|
| ACT | CEILING TAG WITH CEILING HEIGHT, HEIGHT INDICATED IS ABOVE FINISH FLOOR. SEE ROOM FINISH SCHEDULE FOR ACT TYPE. |
| [Symbol] | 2'x2' RECESSED LIGHT FIXTURE |
| [Symbol] | 2'x4' RECESSED LIGHT FIXTURE |
| [Symbol] | 1'x4' RECESSED LIGHT FIXTURE |
| [Symbol] | RECESSED DOWNLIGHT |
| [Symbol] | FIRE PROTECTION-SPRINKLER HEAD |
| [Symbol] | FIRE PROTECTION-FIRE ALARM DEVICE |
| [Symbol] | PENDANT / SUSPENDED LIGHT FIXTURE |
| [Symbol] | HVAC SUPPLY GRILLE |
| [Symbol] | HVAC RETURN GRILLE |
| [Symbol] | HVAC SWITCHED EXHAUST GRILLE |
| [Symbol] | HVAC SUPPLY/RETURN LINEAR DIFFUSER |
| [Symbol] | ACCESS PANEL |
| [Symbol] | EXIT SIGN, SINGLE-SIDED |
| [Symbol] | EXIT SIGN, DOUBLE-SIDED |
| CJ | CONTROL JOINT |



FINAL DESIGN
APPROVED FOR CONSTRUCTION

<div>▲</div> ADDENDUM 1		April 7, 2017	CONSULTANTS:		<div>ARCHITECT-OF-RECORD THOMAS H. GYLLSTROM</div> <div>FL REG. NO. 9598</div> <div></div>		ARCHITECT/ENGINEERS:		<div>Drawing Title</div> <div>LEVEL 2 - AREA A - REFLECTED CEILING PLAN</div> <div>Approved: Project Director</div>		<div>Project Title</div> <div>VAMC AT LAKE NONA BUILD NEW RESEARCH SPACE</div> <div>Location Orlando, Florida</div> <div><div>Date JUNE 17, 2016</div><div>Checked TW</div><div>Drawn JH</div></div>		<div>Project Number</div> <div>675-900</div> <div>Building Number</div> <div>13</div> <div>Drawing Number</div> <div>S-AI122A</div> <div>22 OF 176</div>		<div>Office of Construction and Facilities Management</div> <div> Department of Veterans Affairs</div>	
							<div>AKEA INC.</div> <div>3603 NW 98th Street, Suite B Gainesville, FL 32606 Phone: (352) 474-6124 Fax: (352) 474-6324 AKEA Project No. 039-12</div>									
Revisions:			Date													