


2 ROOF PLAN  
SCALE: 1/8" = 1'-0"

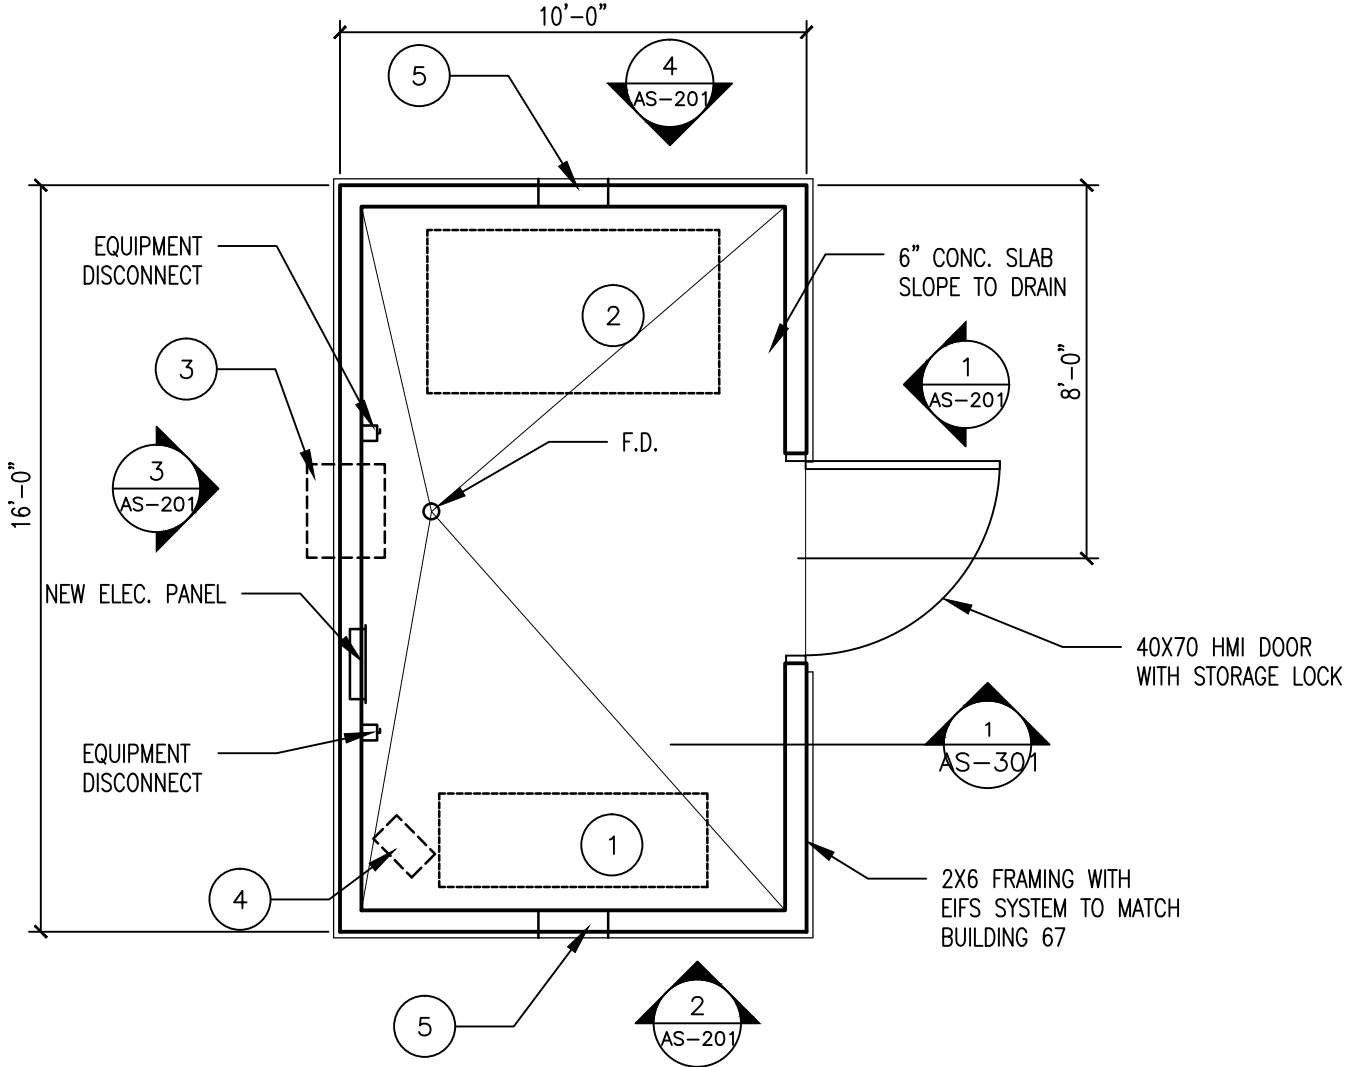

1 FLOOR PLAN  
SCALE: 1/4" = 1'-0"

EQUIPMENT SCHEDULE

ITEM	DESCRIPTION	TANK	SCFM		INLET	OUTLET	HP		POWER	COOLING	HEATING	NOTES	REMARKS
			EA	PKG			EA	PKG					
1	MEDICAL COMPRESSOR	80 GAL	15.7	31.4	1"	1/2"	5	10	208 3φ			1	SCFM @ 50 PSI
2	MEDICAL VACUUM	120 GAL	37	74	2"	2"	5	10	208 3φ			1	SCFM @ 19" HG
3	THRU WALL A/C								120 V	12,000 BTU		2	W/THERMOSTAT
4	UNIT HEATER								208		3.0 KW	-	W/ THERMOSTAT
4	EXHAUST WITH LOUVER								115 V			-	W/THERMOSTAT

- NOTES:
- 1. PACKAGE UNIT AS SPECIFIED TO INCLUDE FILTER SYSTEM
  - 2. INCLUDE ACCESSORIES AS SPECIFIED

CONSTRUCTION DOCUMENTS 4-9-2012

		<b>CONSULTANTS:</b>				<b>ARCHITECT/ENGINEERS:</b>		Drawing Title FLOOR PLAN		Project Title EQUIPMENT BUILDING FOR SUPPORT OF RESEARCH LAB BUILDING 67		Project Number 501-10-916 Building Number 67/67A		Office of Construction and Facilities Management	
								Approved Project Director		Location NEW MEXICO VHACS		Drawing Number AS-102			
										Date -		Checked -			