




one eighth inch = one foot
0 4 8 16
one quarter inch = one foot
0 4 8
one half inch = one foot
0 4
three eighths inch = one foot
0 4
one half inch = one foot
0 4
three quarters inch = one foot
0 2
one inch = one foot
0 6
one and one half inches = one foot
0 6
two inches = one foot
0 6
three inches = one foot
0 6

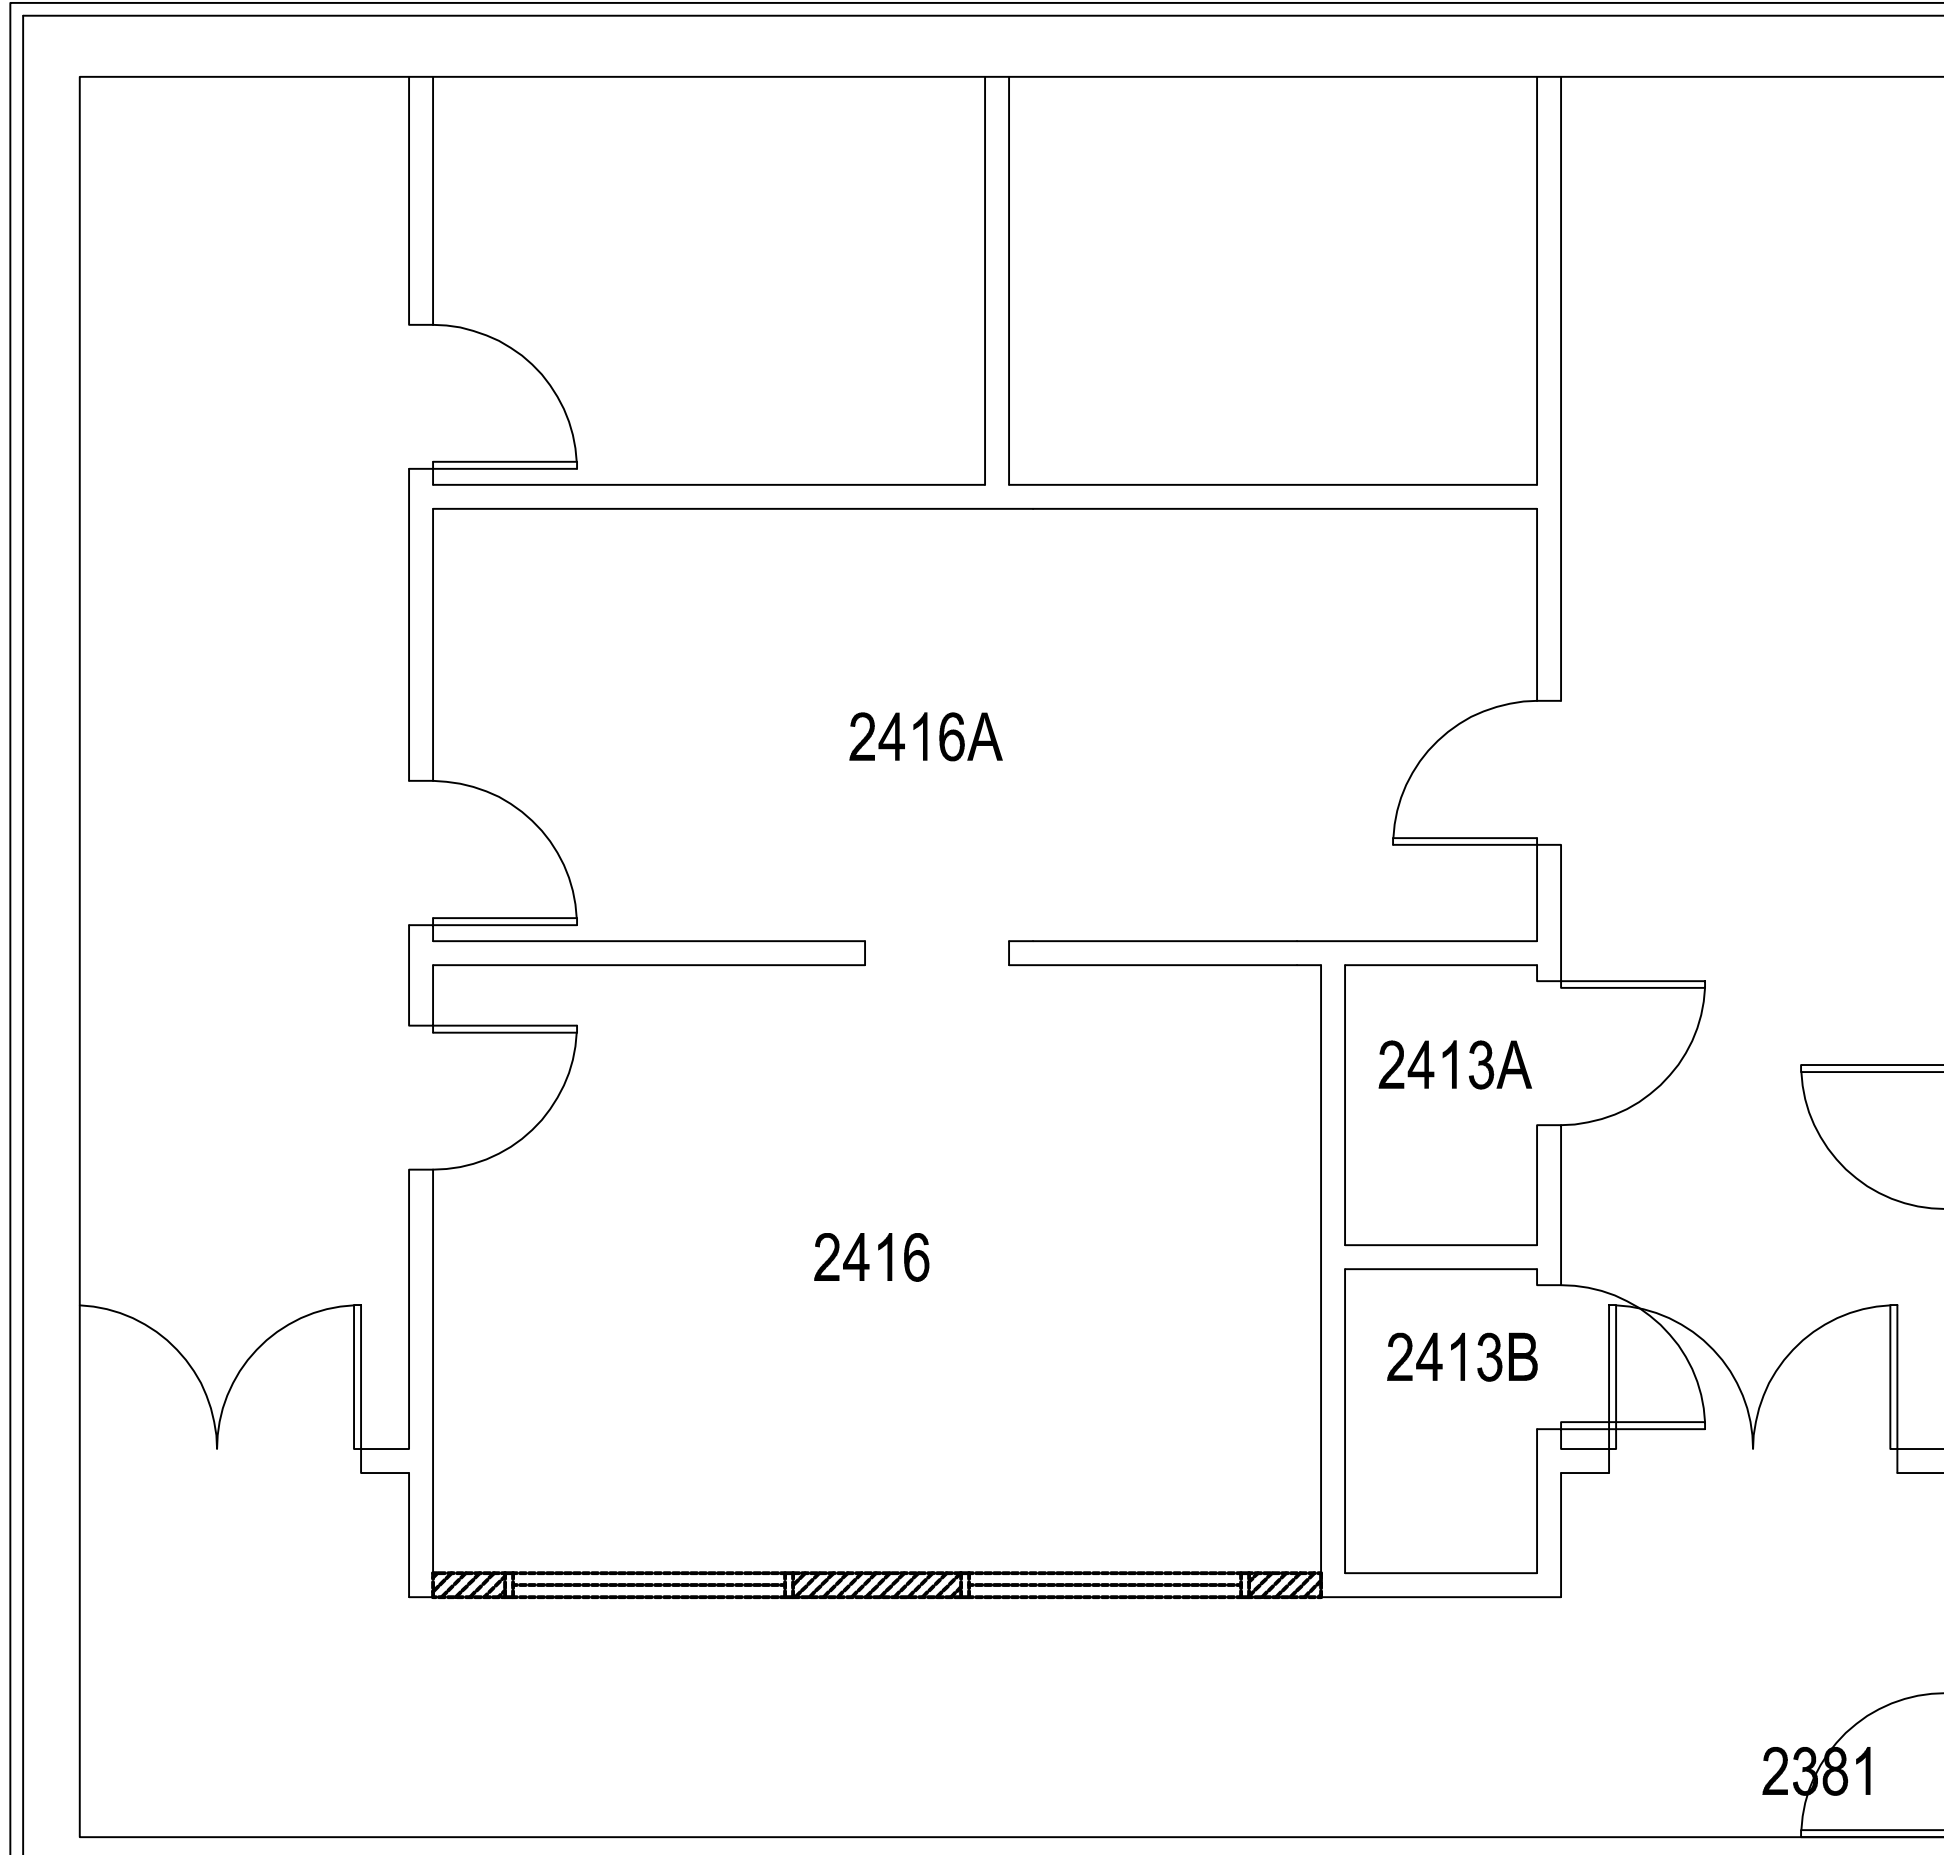


ARCHITECTURE DEMO PLAN

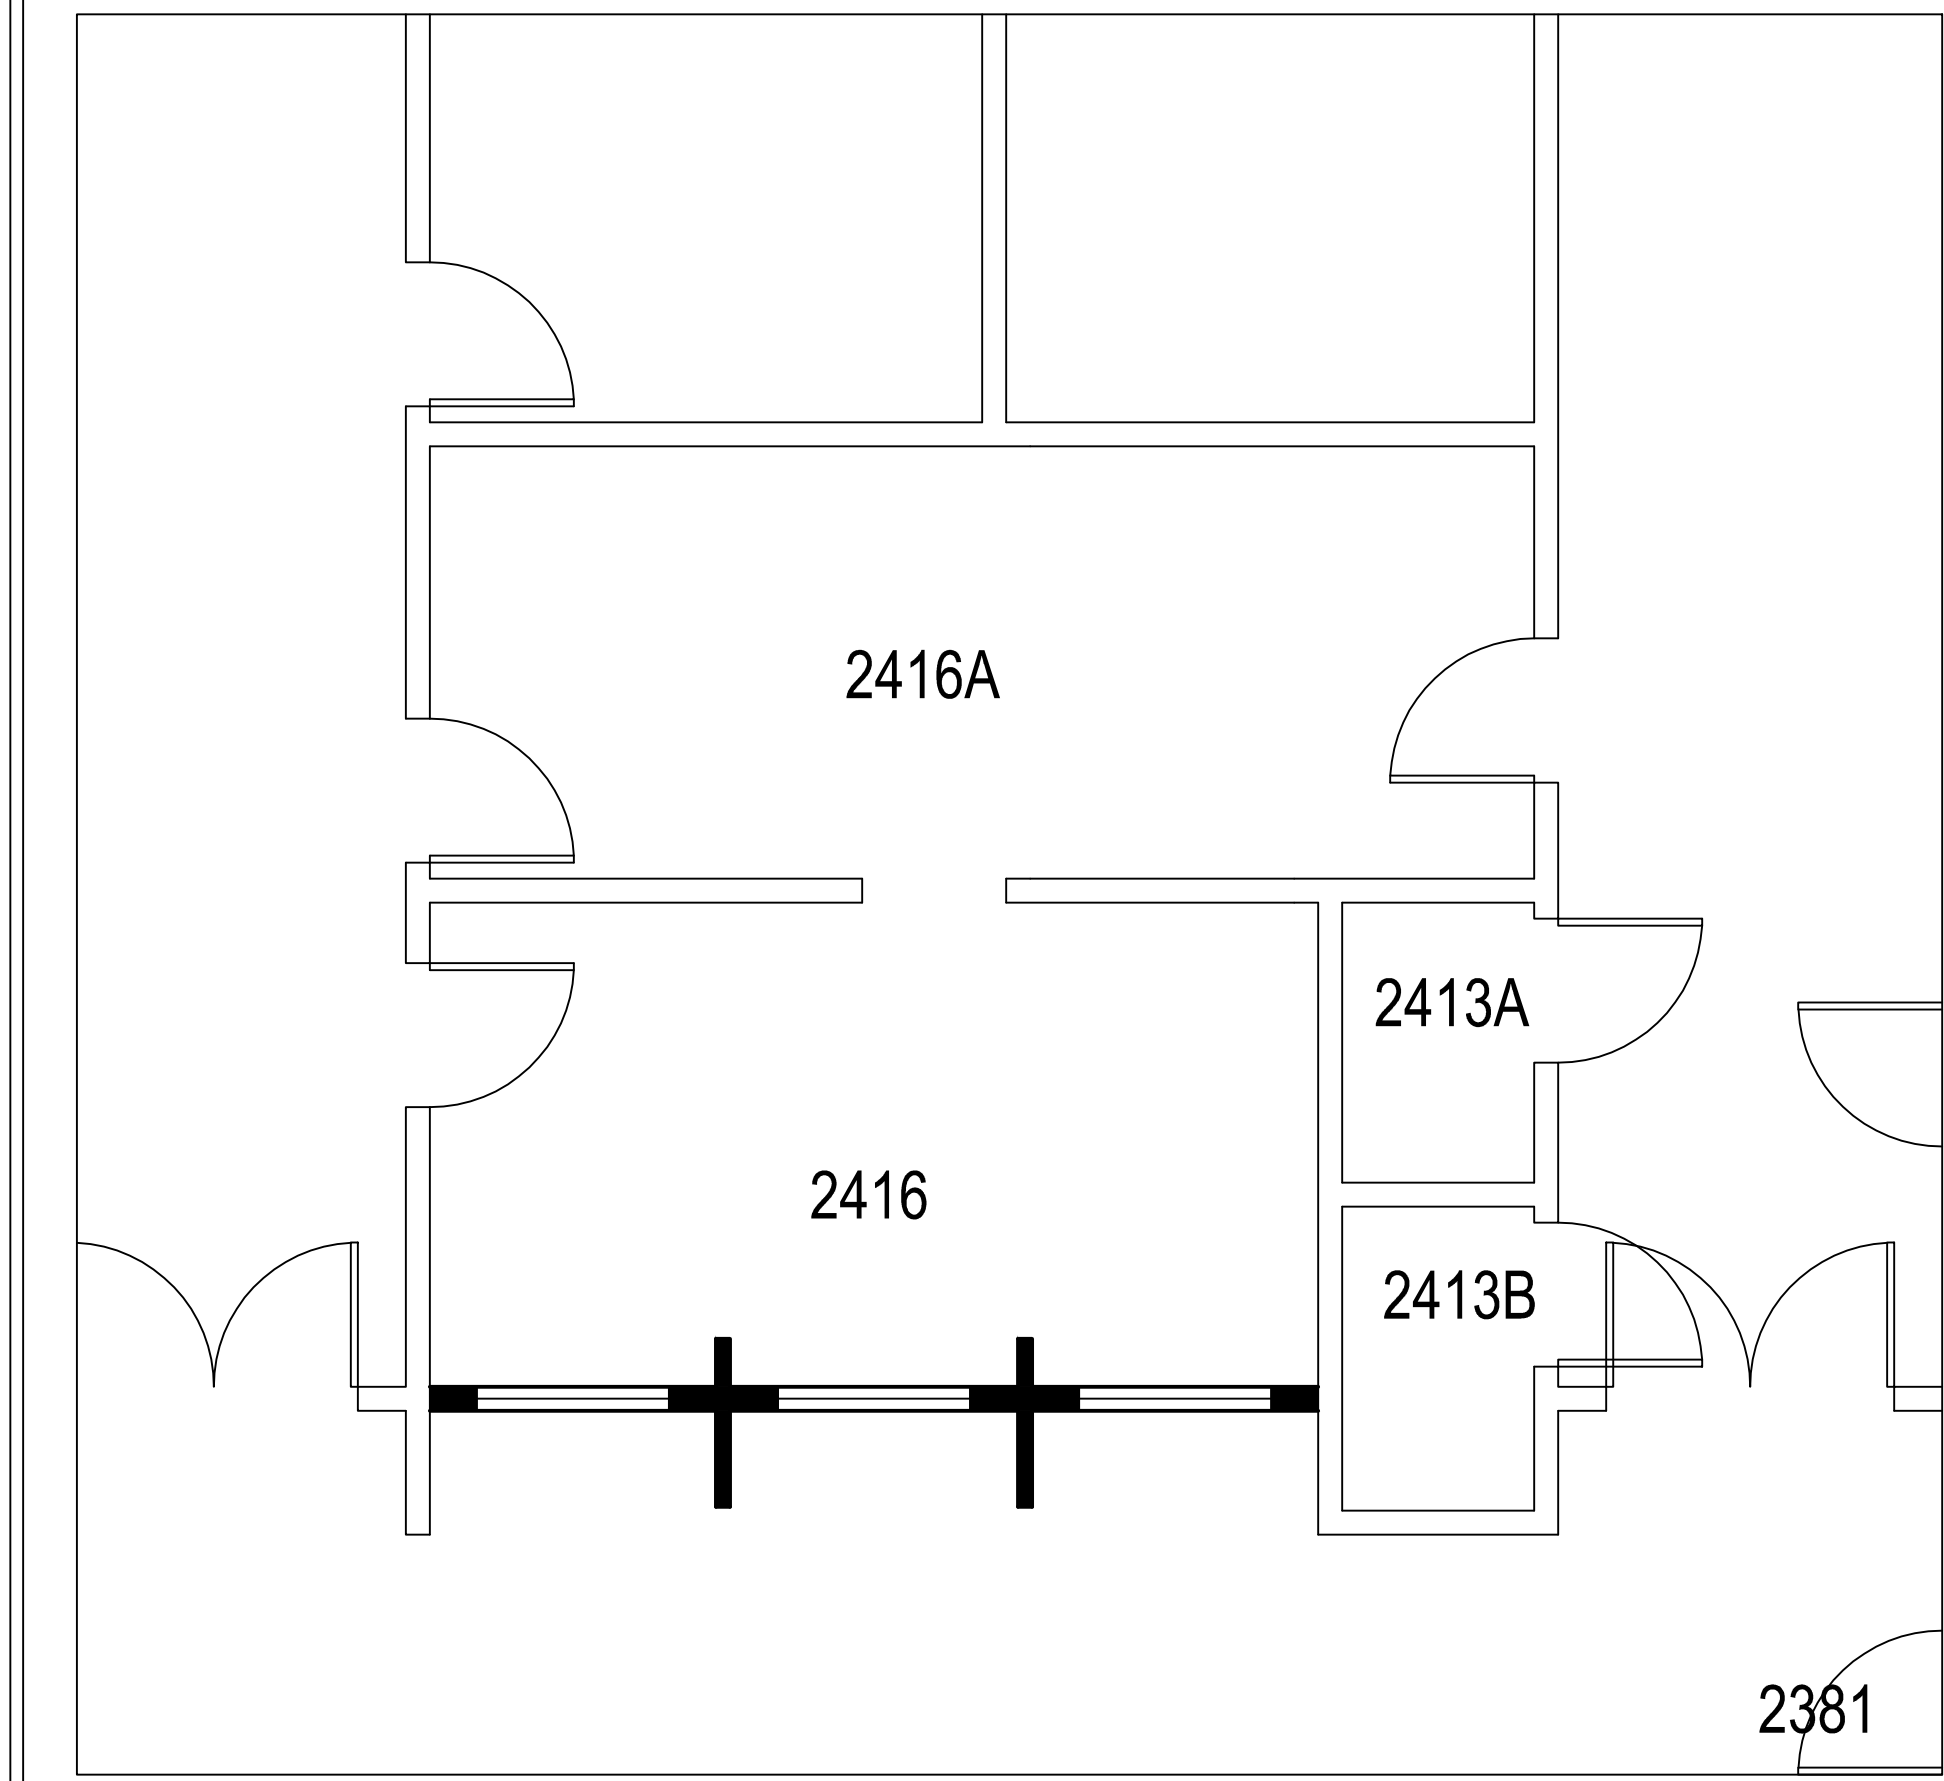


NEW ARCHITECTURE PLAN

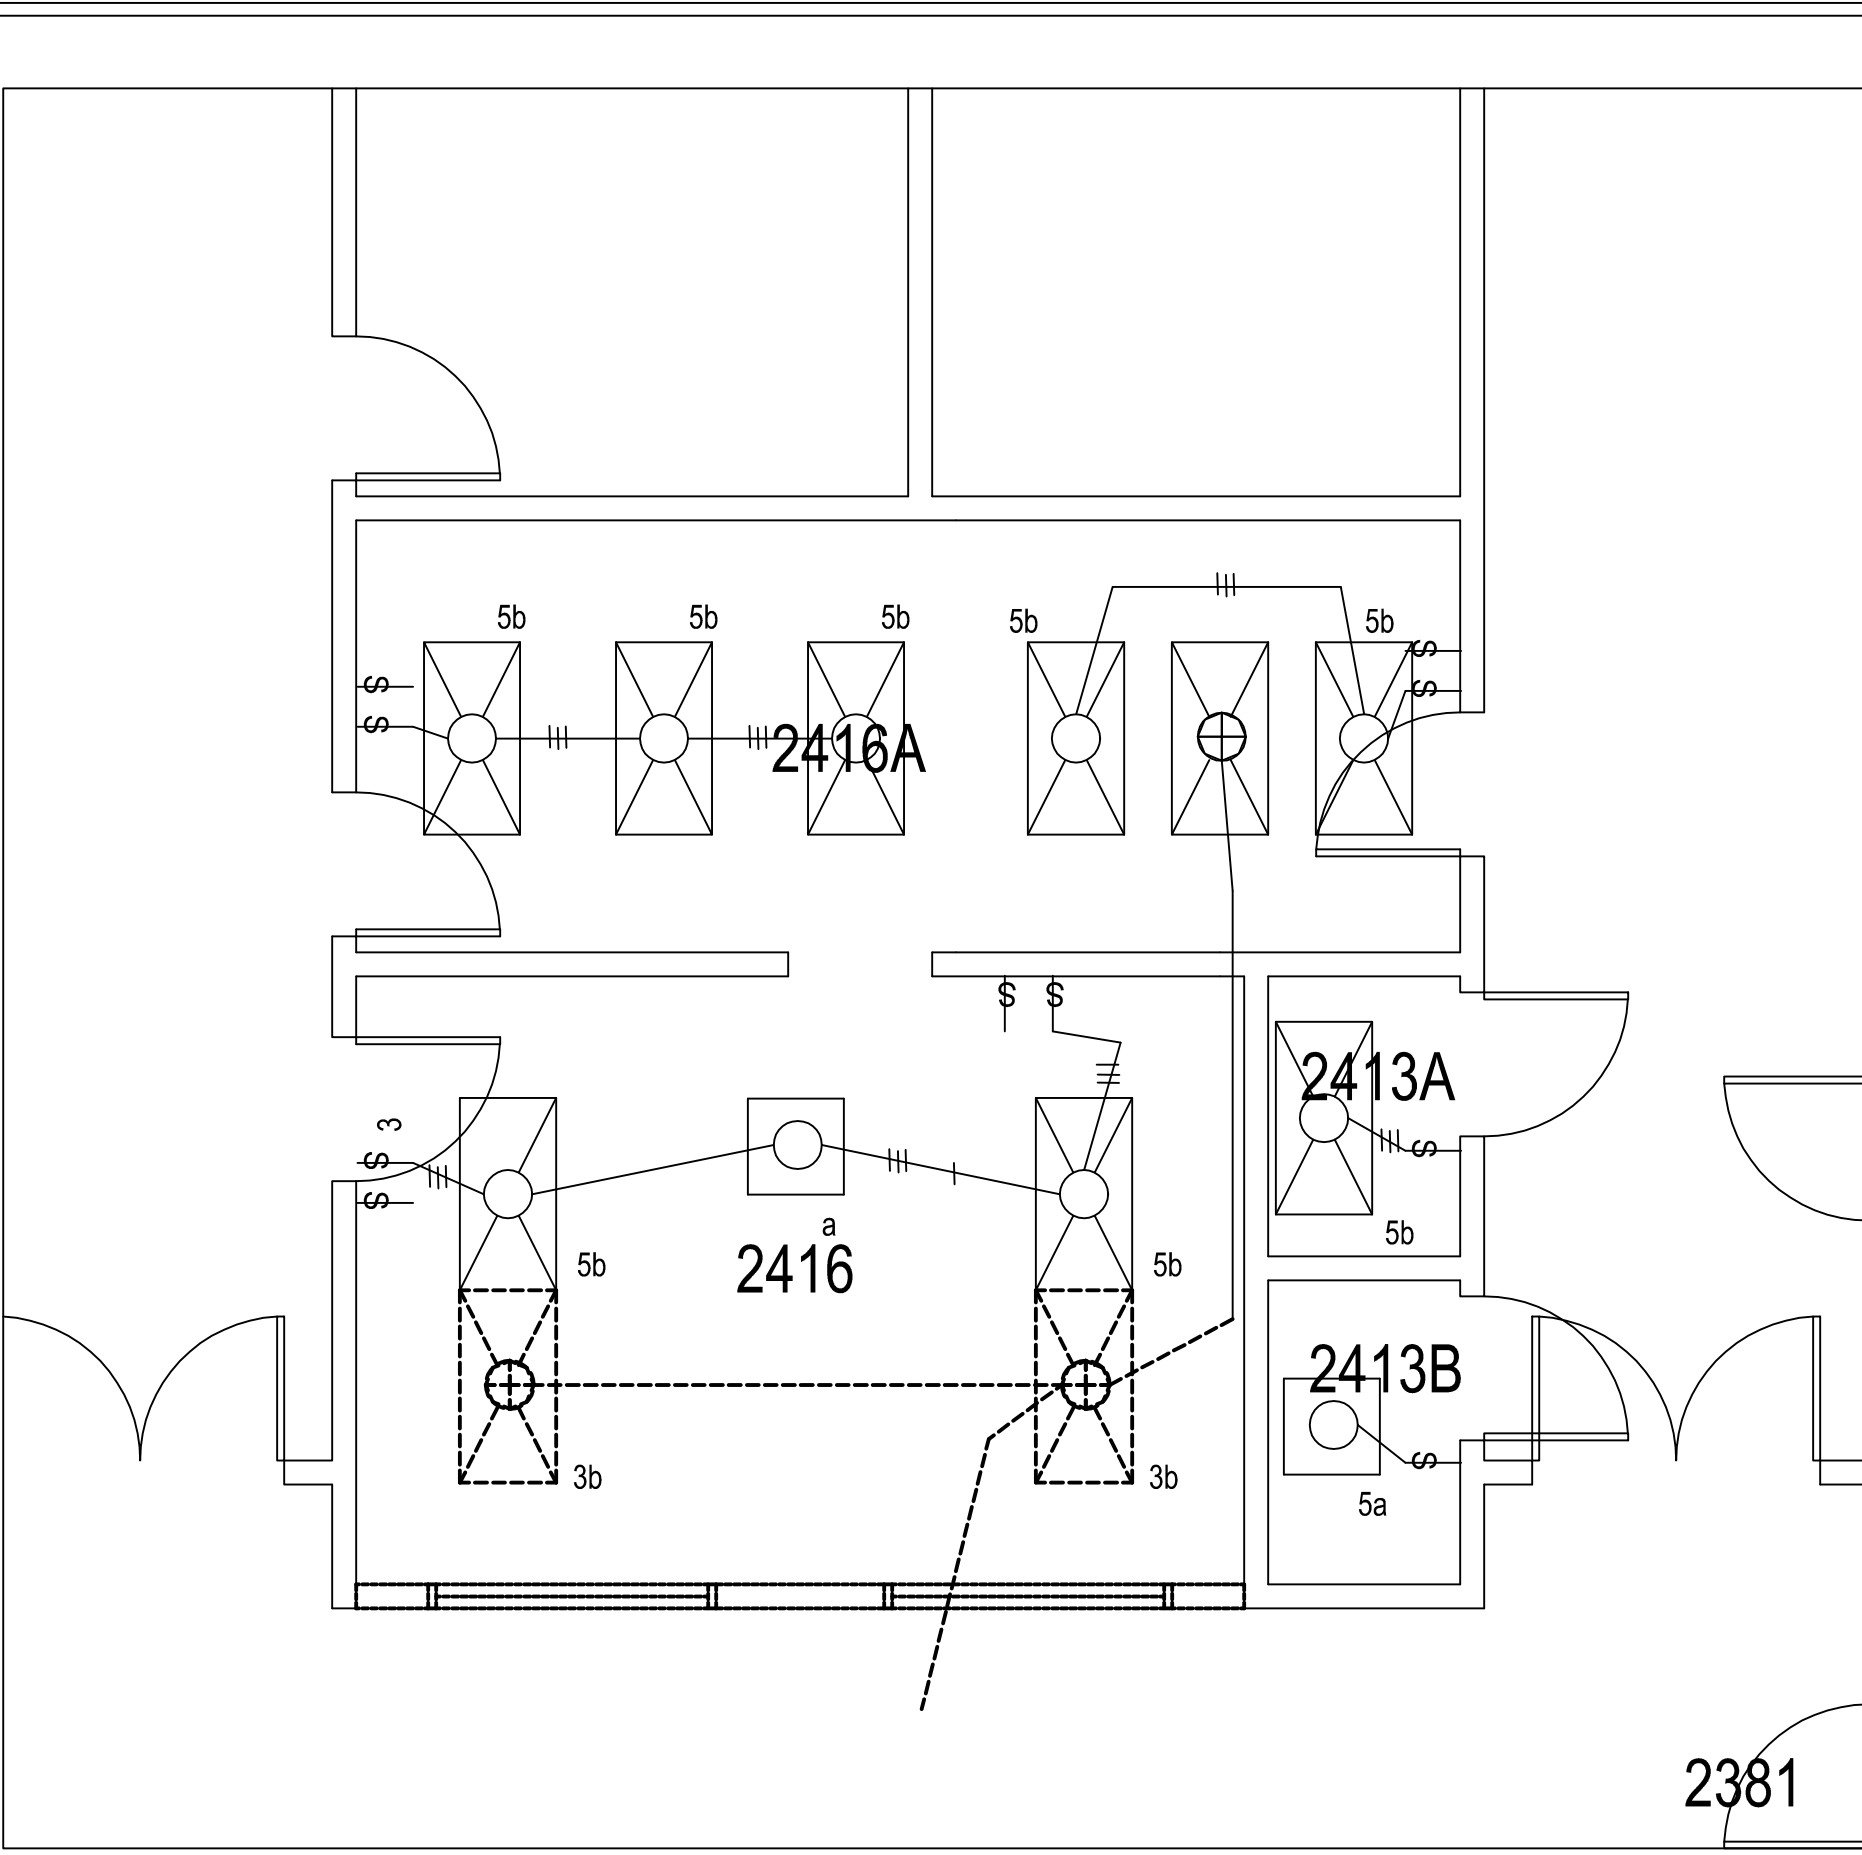


REFLECTIVE CEILING DEMO PLAN

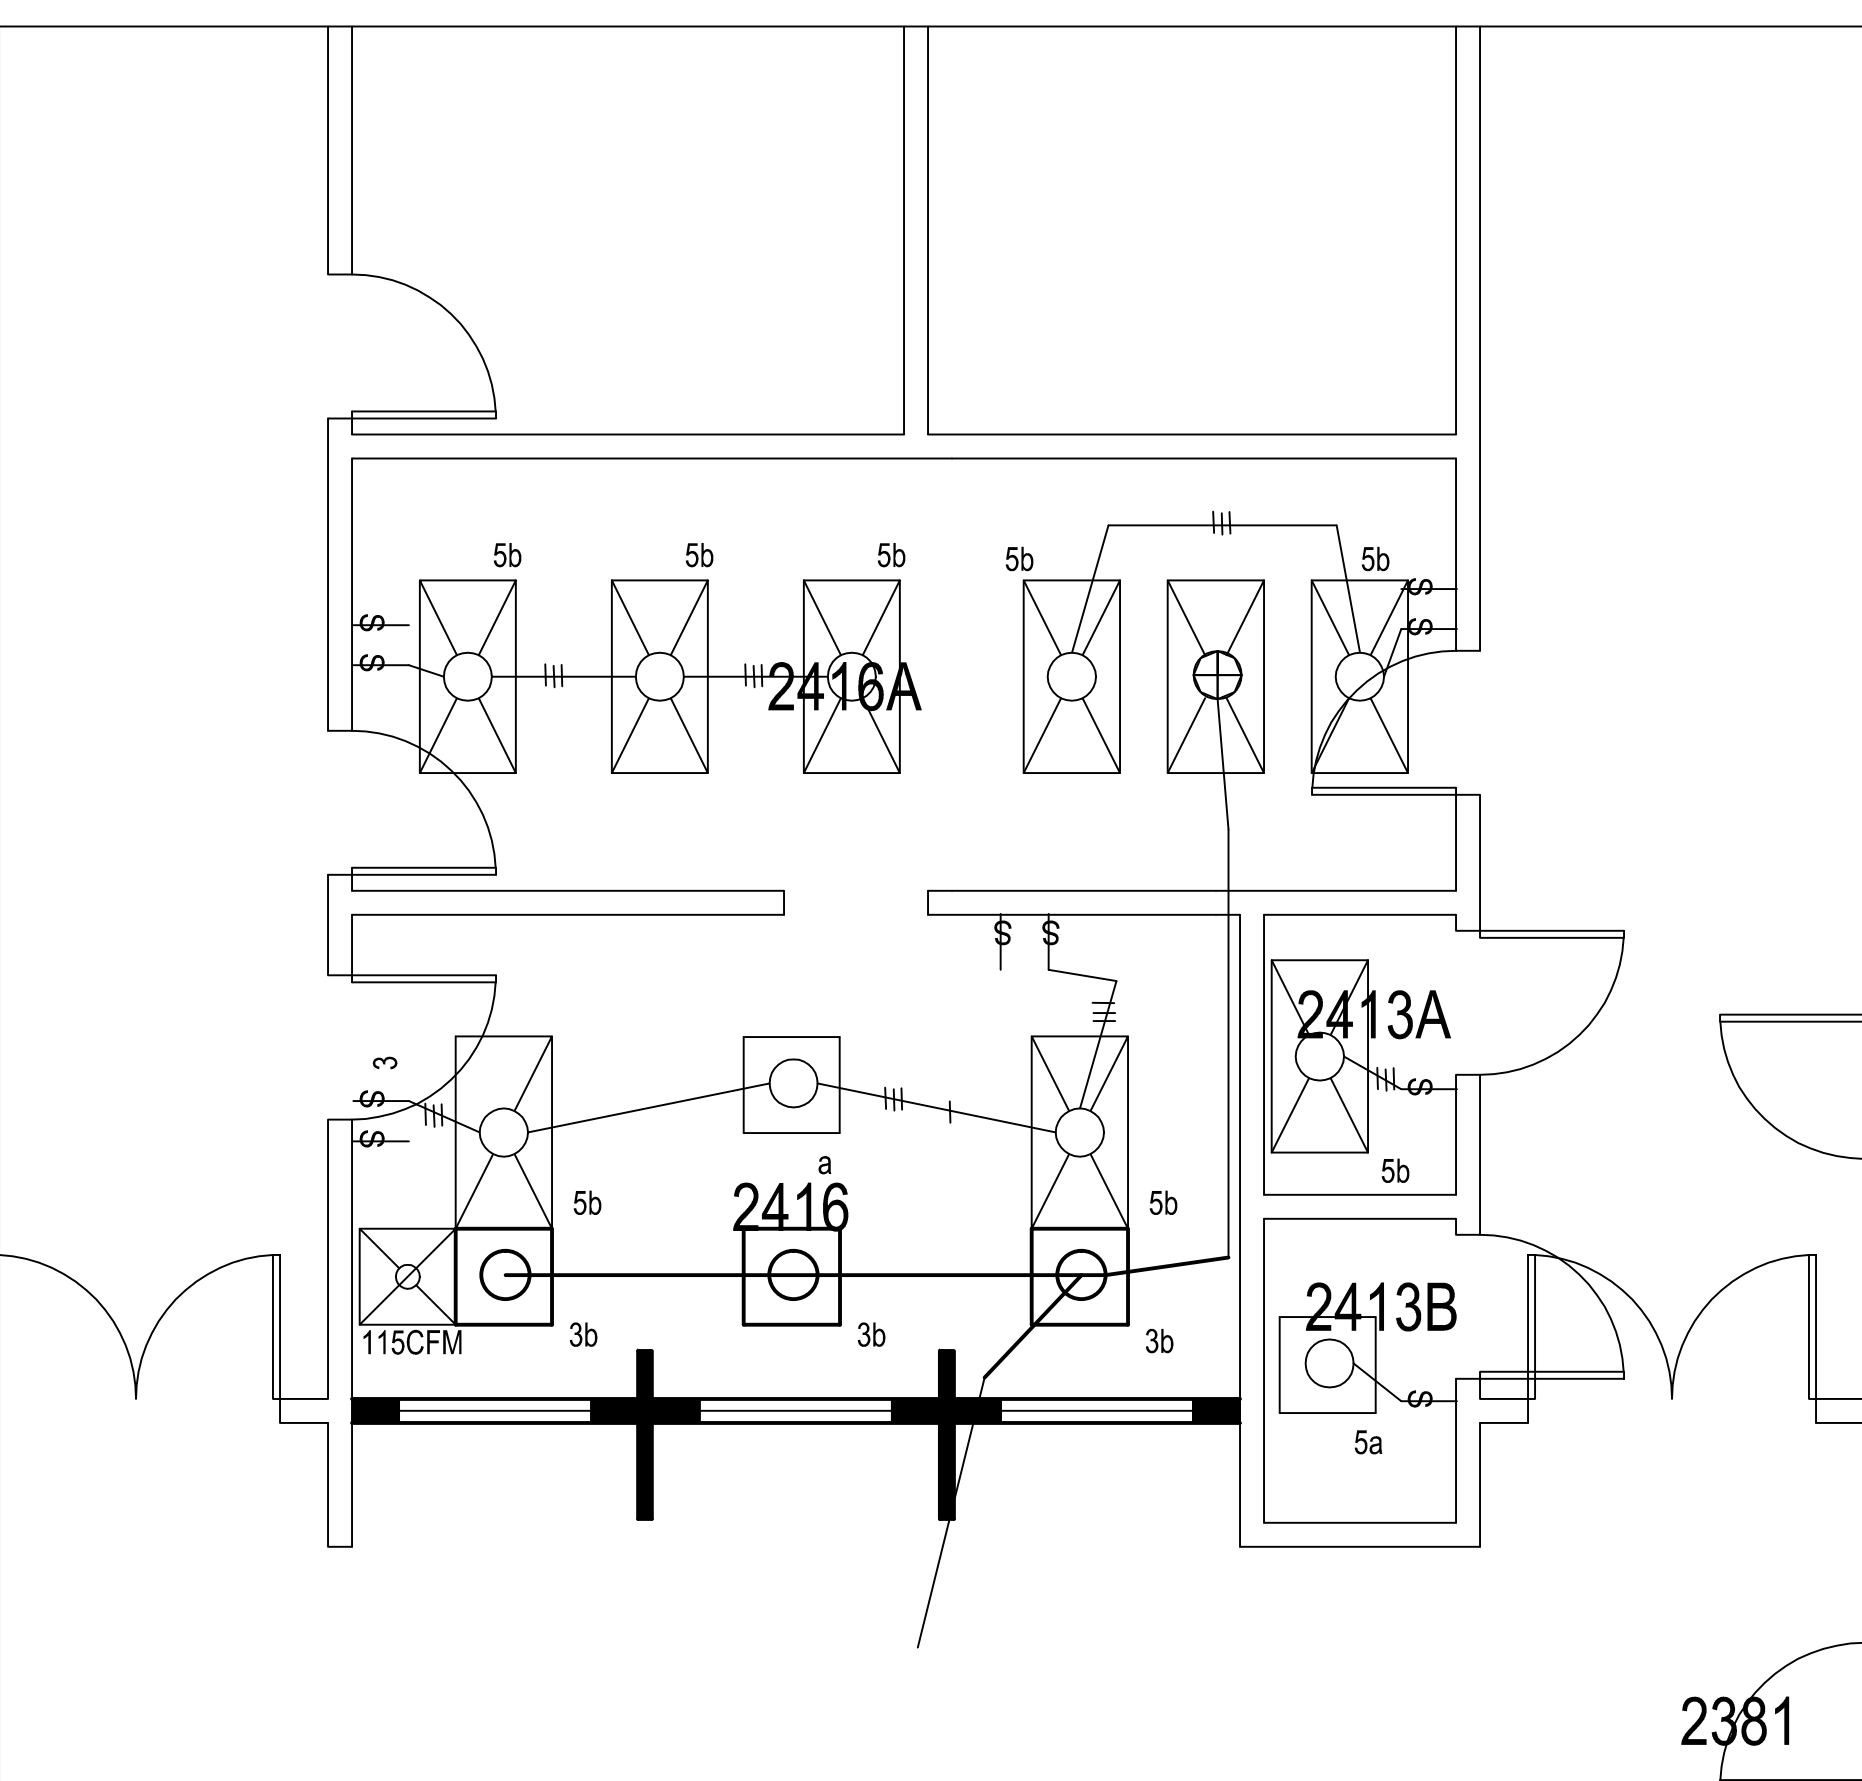


NEW REFLECTIVE CEILING PLAN

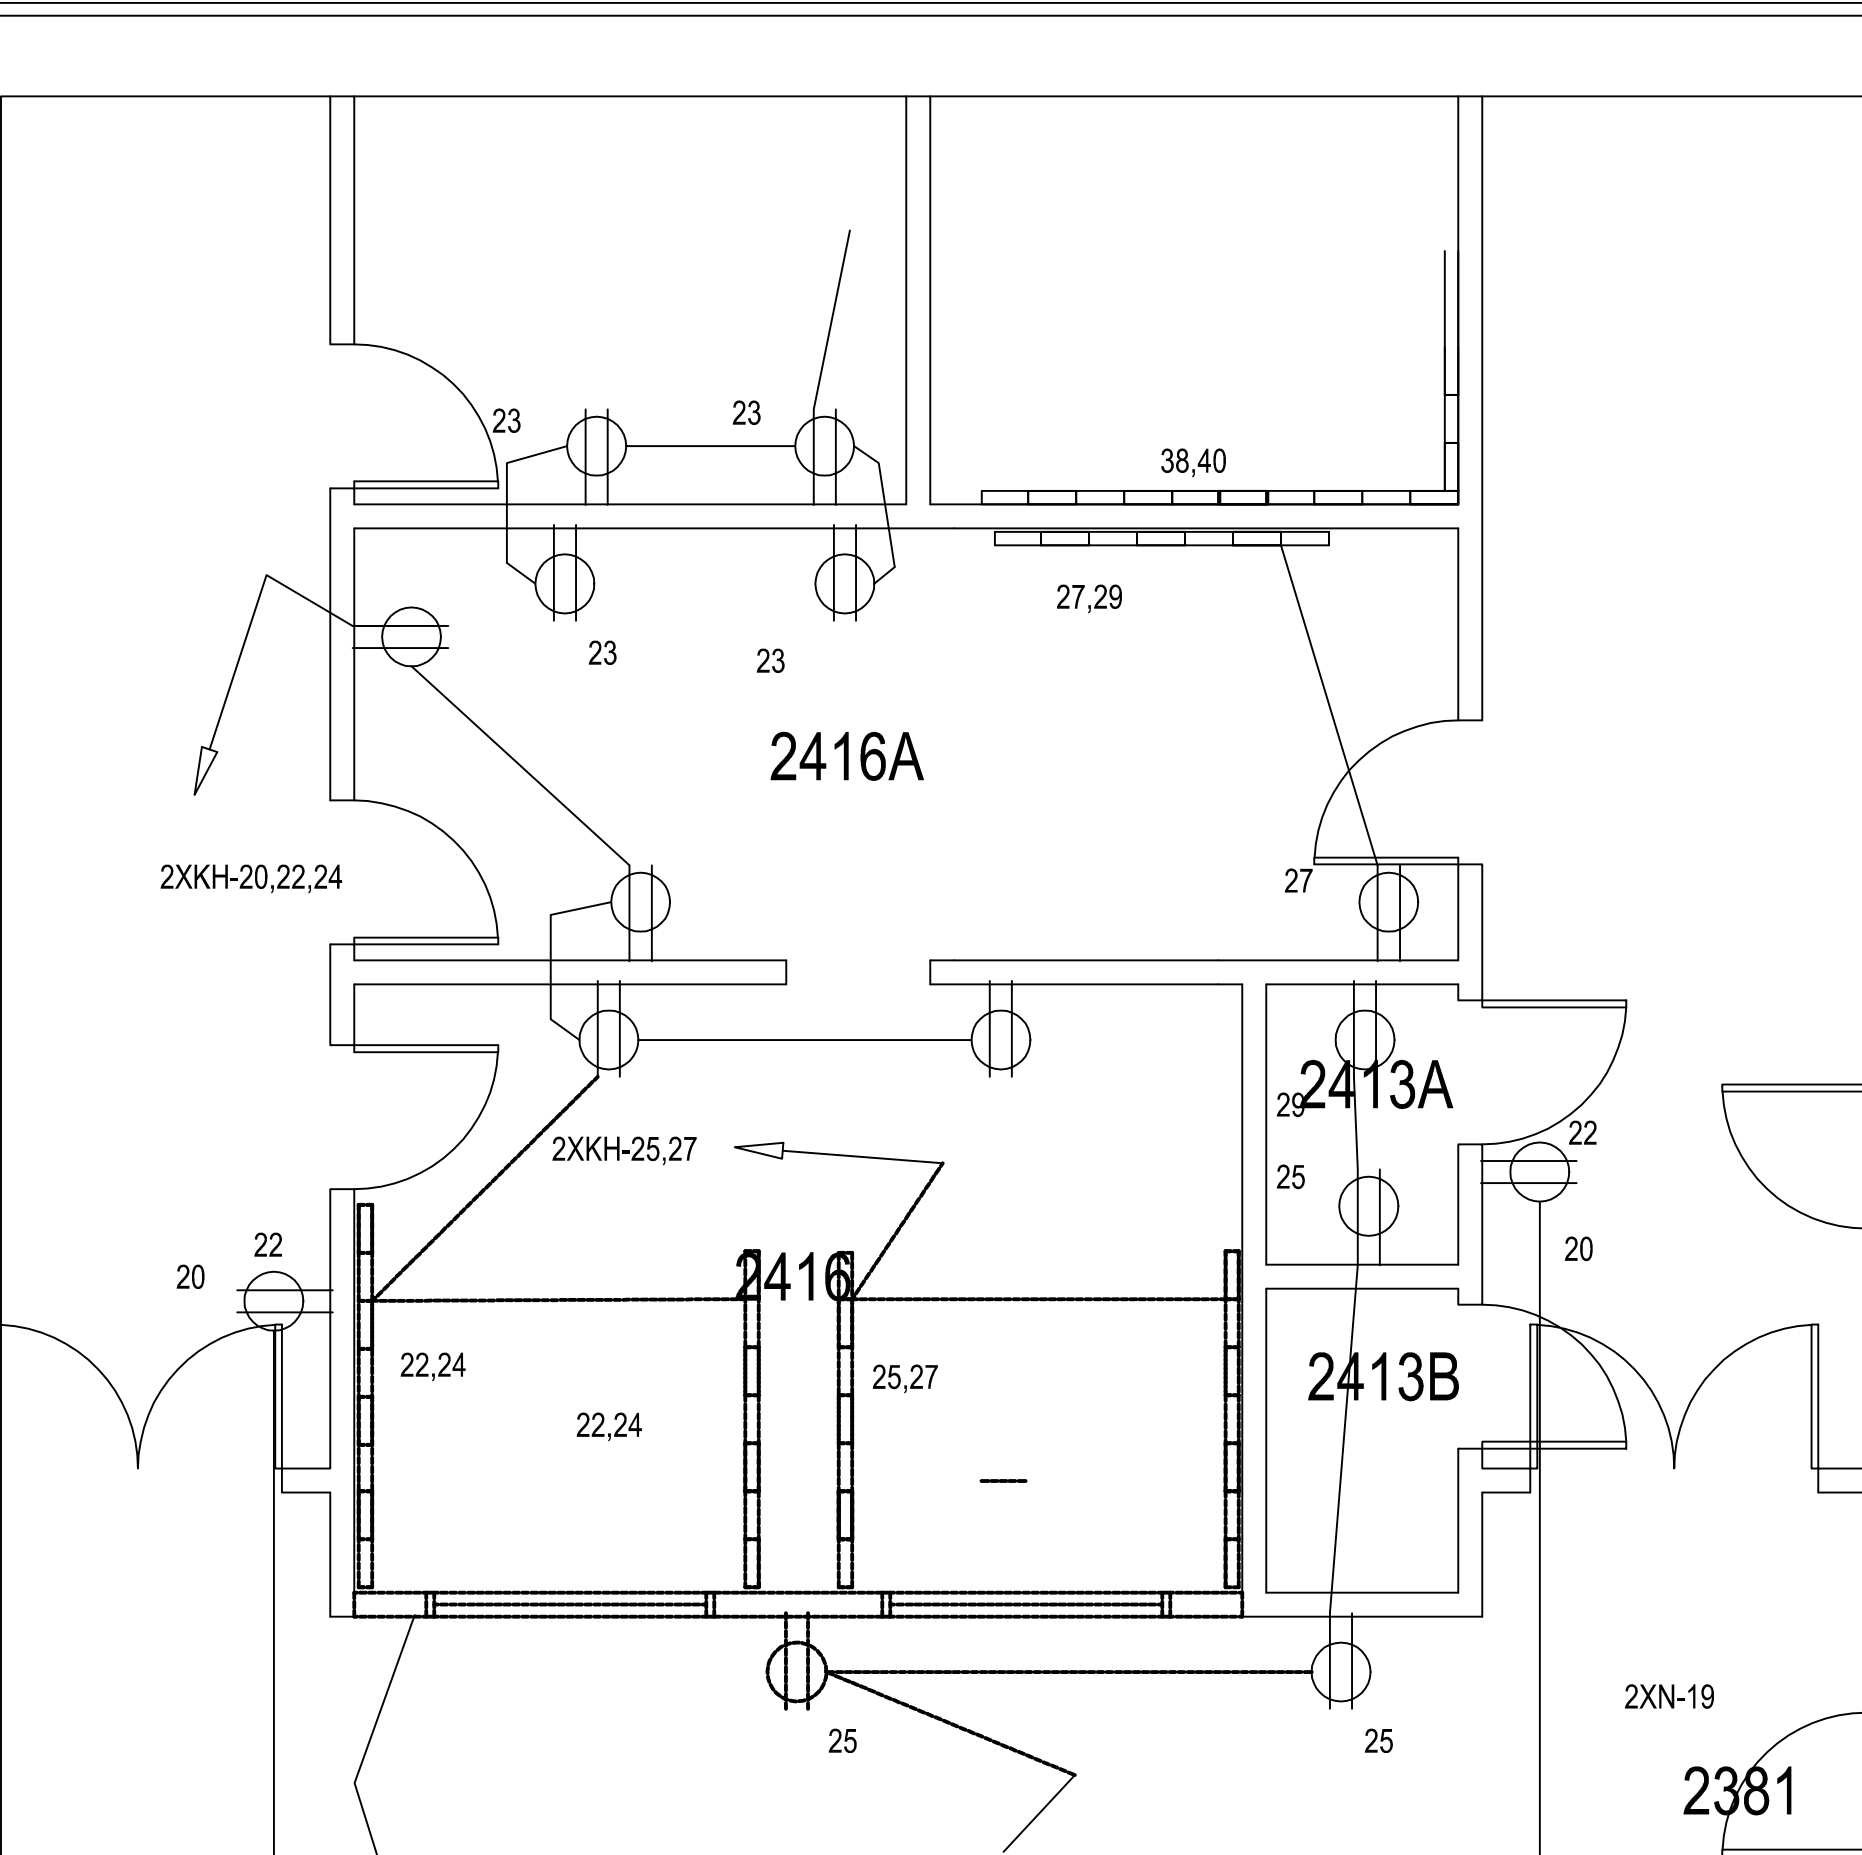

ELECTRICAL DEMO PLAN

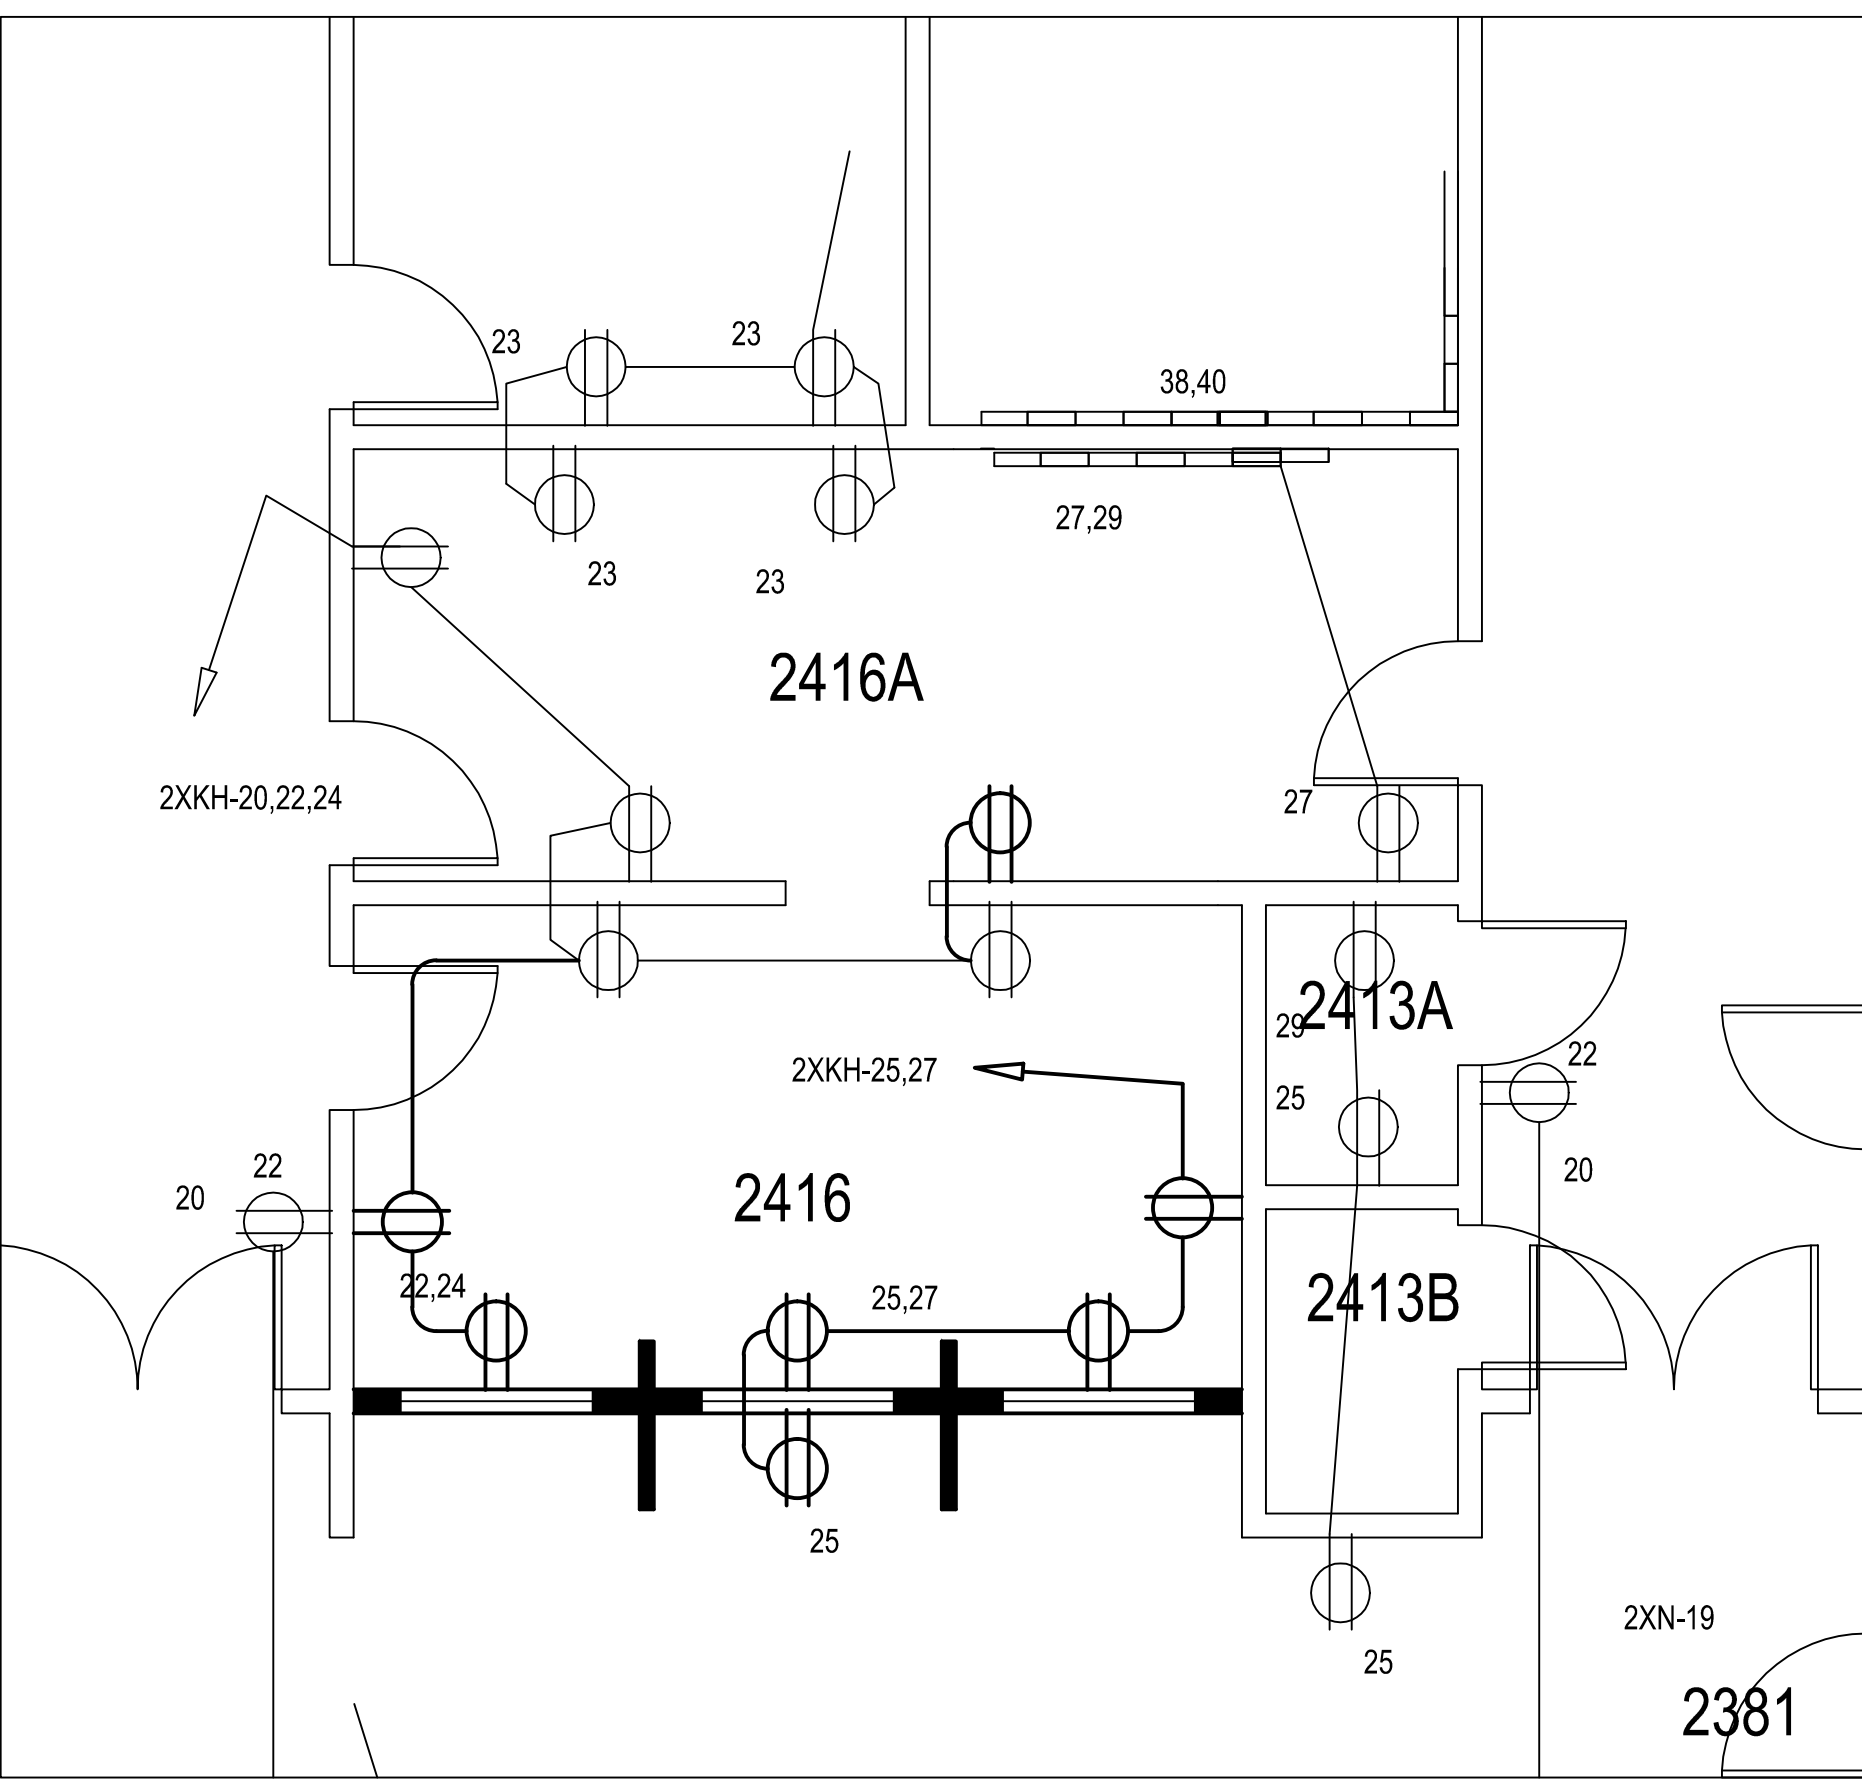

NEW ELECTRICAL PLAN

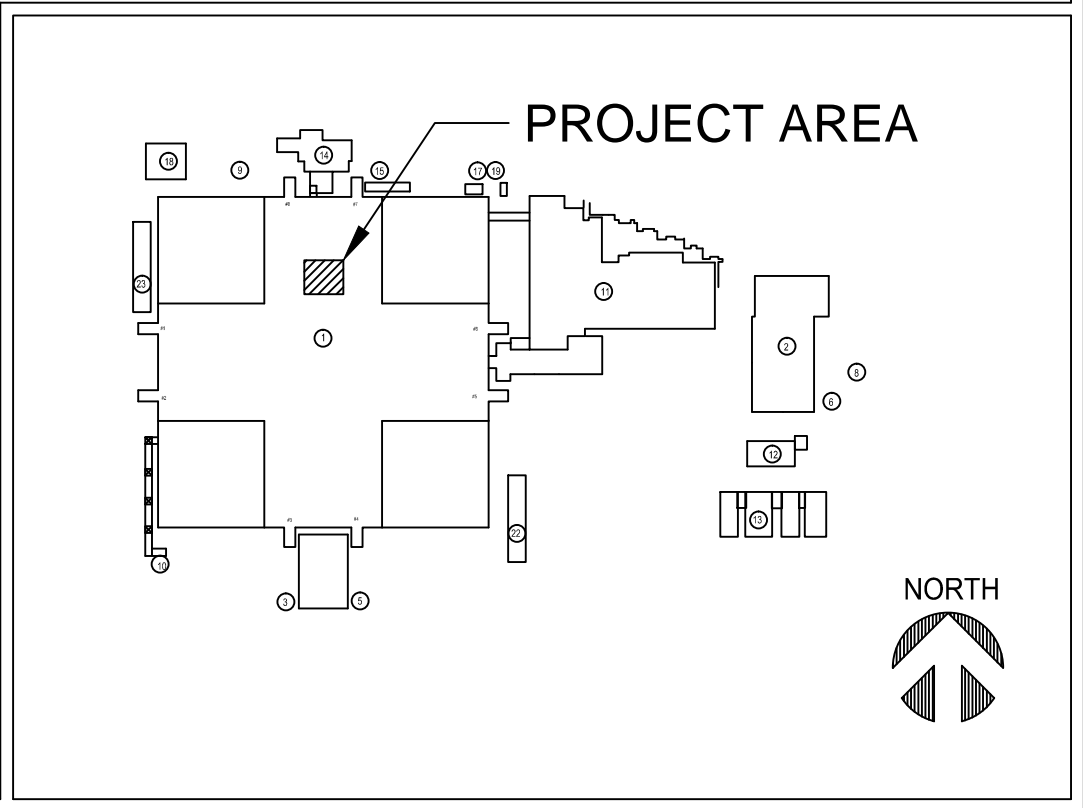

Revisions	Date

CONSULTANTS:

ARCHITECT/ENGINEERS:

Drawing Title

Project Title
- XXXX
-
-
-
Location - 3350 LA JOLLA VILLAGE DR. SAN DIEGO CA. 92161
Date - 11/06/2010
Checked
Drawn

Project Number
-XXX-XX-XXX
Building Number
-XX
Drawing Number
X-XX-X
Dwg. 1 of -

Office of Construction and Facilities Management

Department of Veterans Affairs