[illegible]


## DOOR SCHEDULE

## **5** DOOR SCHEDULE


ROOM FINISH SCHEDULE				
LOCATION	FLOOR	BASE	WALLS	CEILING
NRS ROOM 103	SC	N/A	CMU-P/D	PLANK/P/D
NORMAL SUBSTATION 200	SC	N/A	CMU-P/D	PLANK/P/D
CORROD. 201	TERRAZO TILE	TERRAZO	CMU/GYP-P/D	ACT/GYP
CORROD. SUBSTATION 202	SC	N/A	CMU-T/D	PLANK/T/D

## ROOM FINISH SCHEDULE

## 6 FINISH SCHEDULE

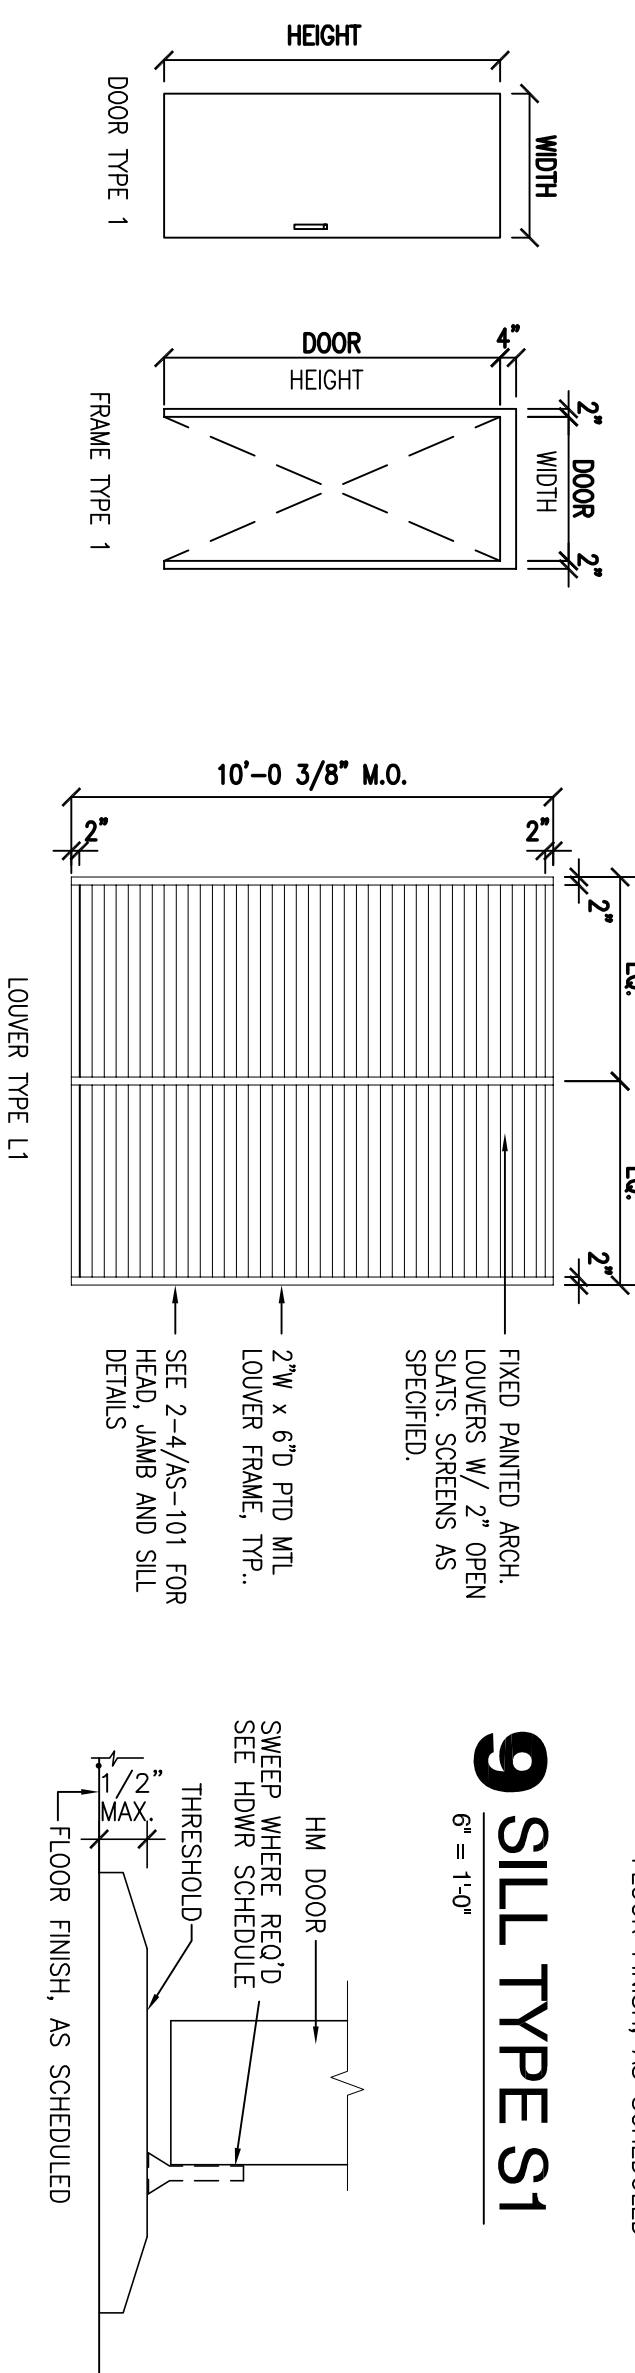

## 9 SILL TYPE S1

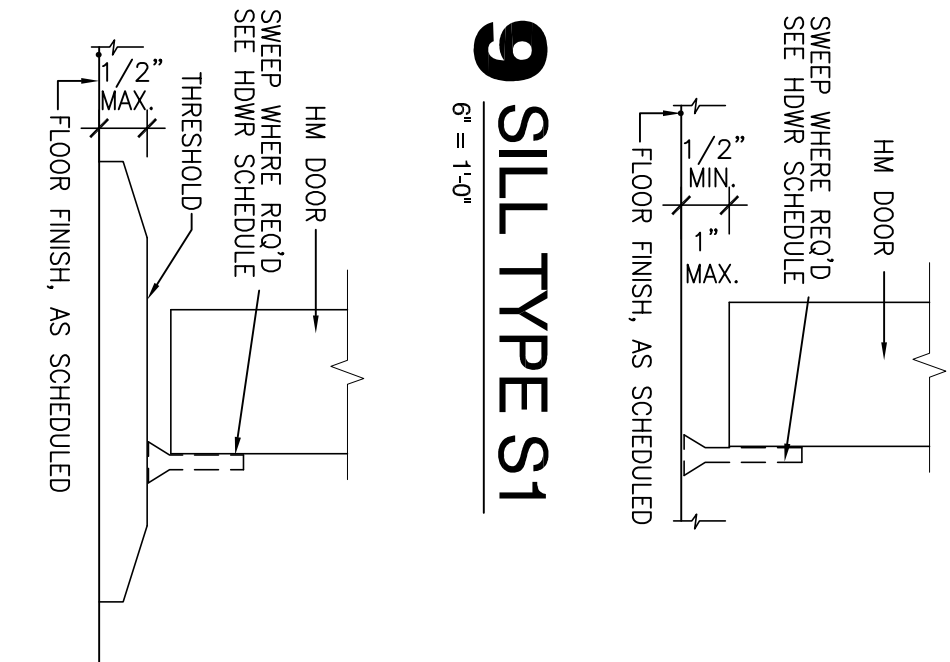

## 7 DOOR & FRAME TYPES

## 8 LOWER TYPES

## 10 SIL TYPE S2

### JAMB TYPE J1

**14** JAMB TYPE J2

CONSULTANTS:	
ADDENDUM A	5/24/2012
ISSUED FOR SOLICITATION	4/24/2012
100% COORDINATION	2/15/2012
100% DESIGN SUBMITTAL REVIEW	2/1/2012
75% DESIGN SUBMITTAL REVIEW	1/13/2012
SCHEMATIC DESIGN SUBMITTAL	1/30/2011
Revisions	Date


## CONSULTANTS:

--

## ARCHITECT/ENGINEERS


# TENG

**TENG & ASSOCIATES, INC.**  
ENGINEERS/ARCHITECTS/PLANNERS  
205 N. MICHIGAN AVE. CHICAGO, IL 60601  
TELEPHONE: 312/616-0000

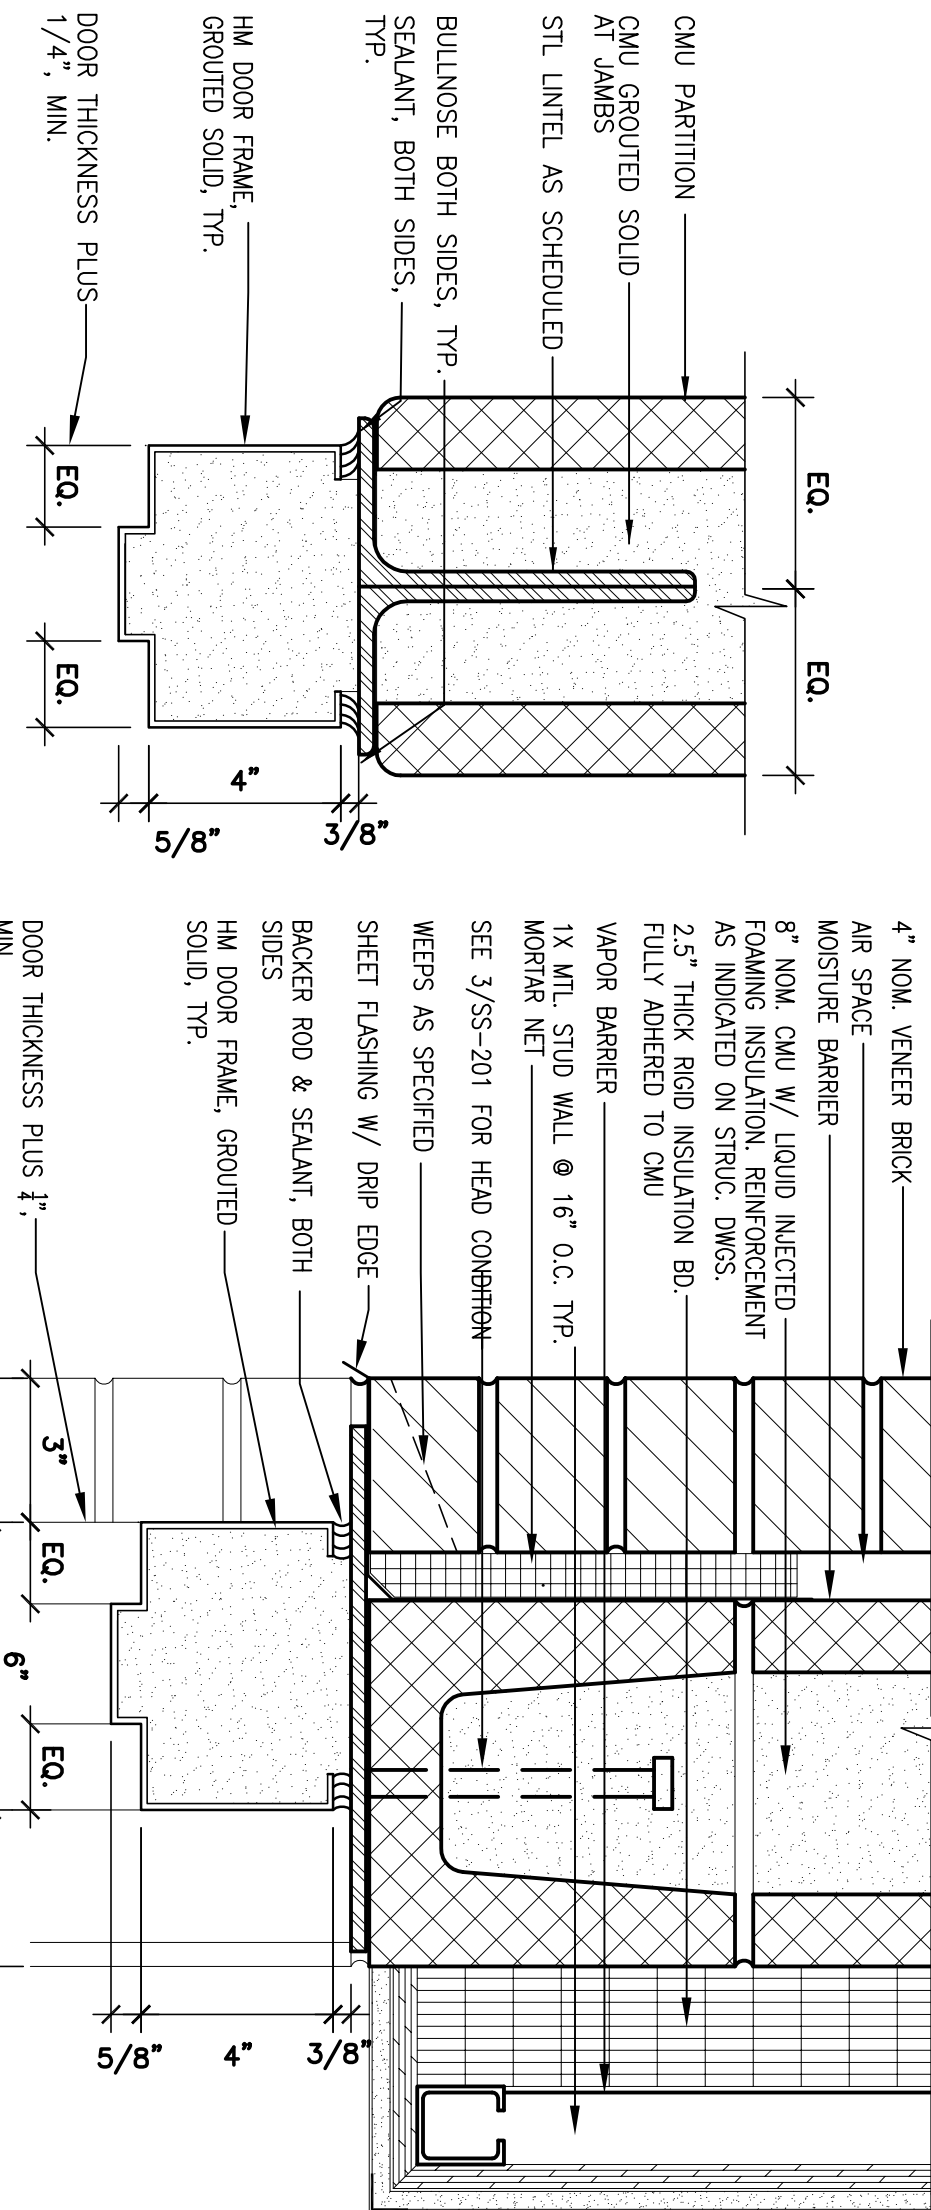


# HEAD TYPE H1

## 12 HEAD TYPE H2

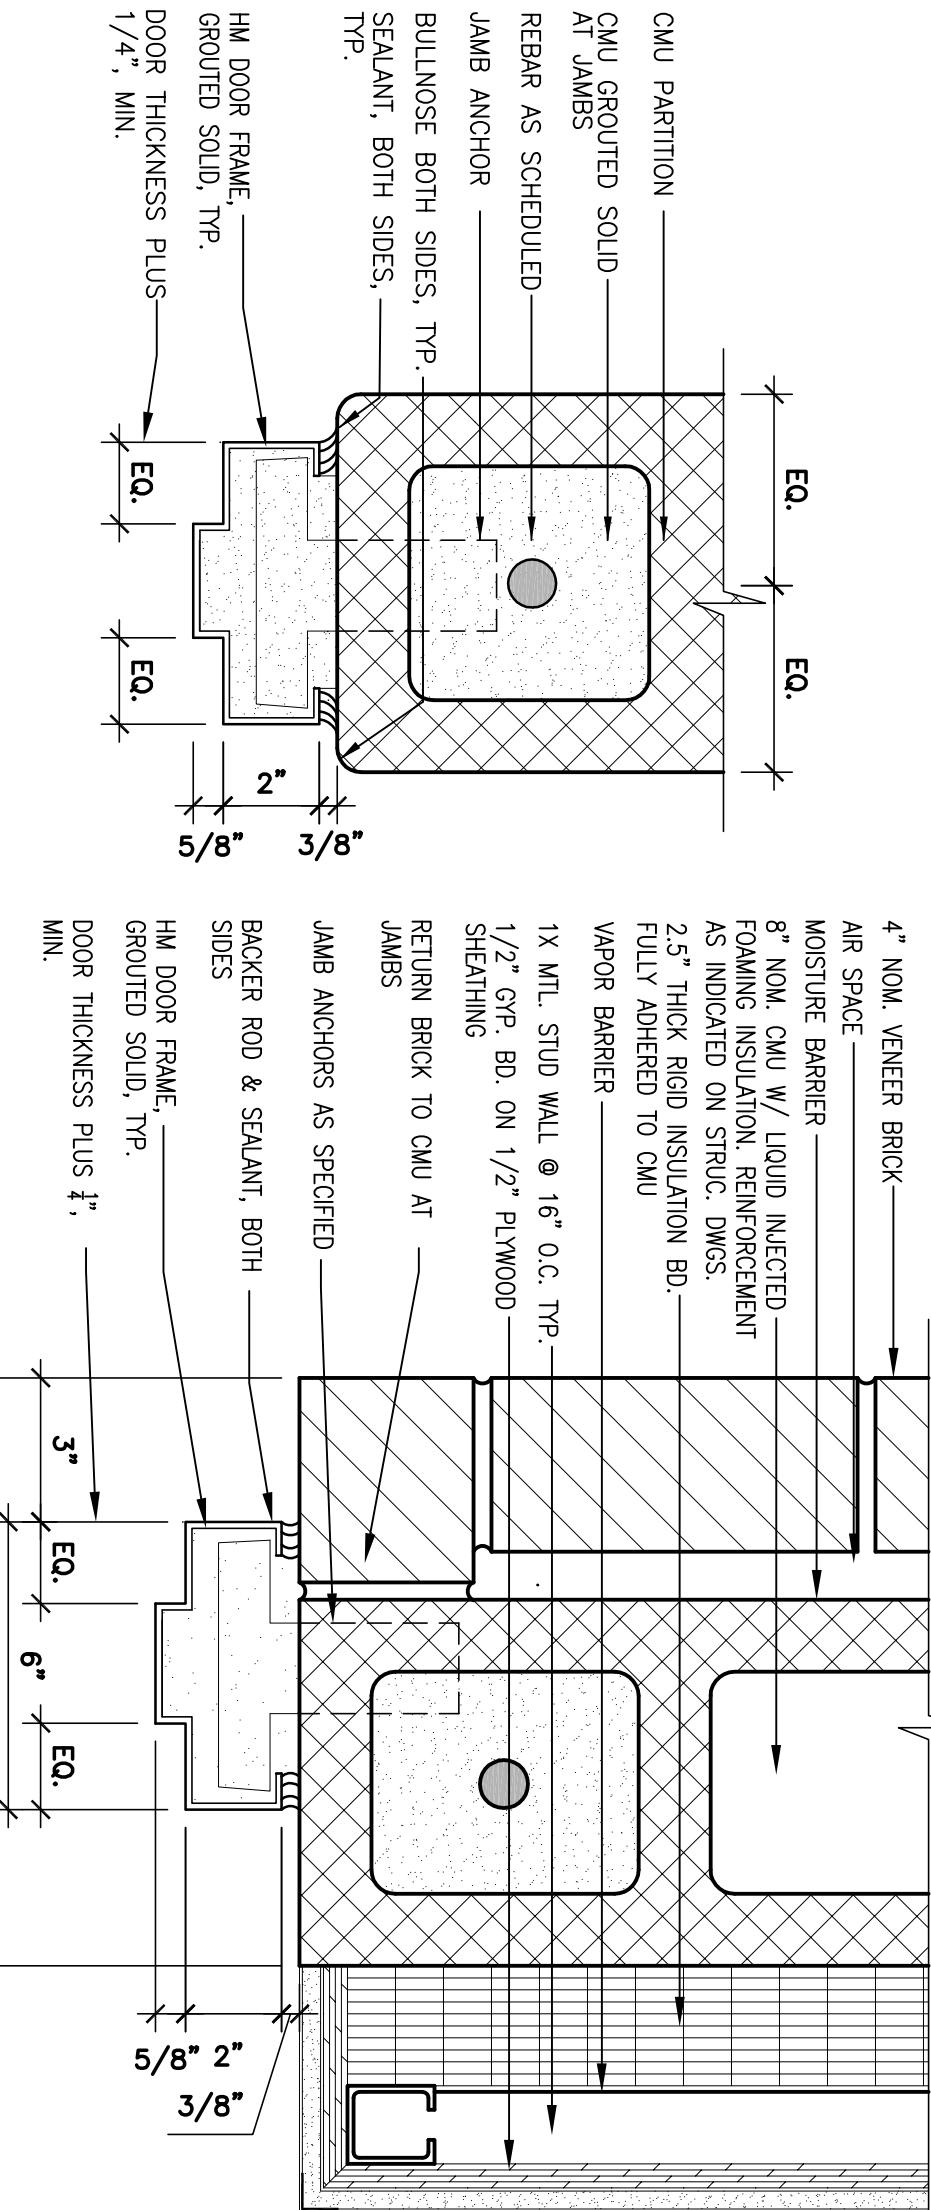


### 13 JAMB TYPE J1



**14** JAMB TYPE J2

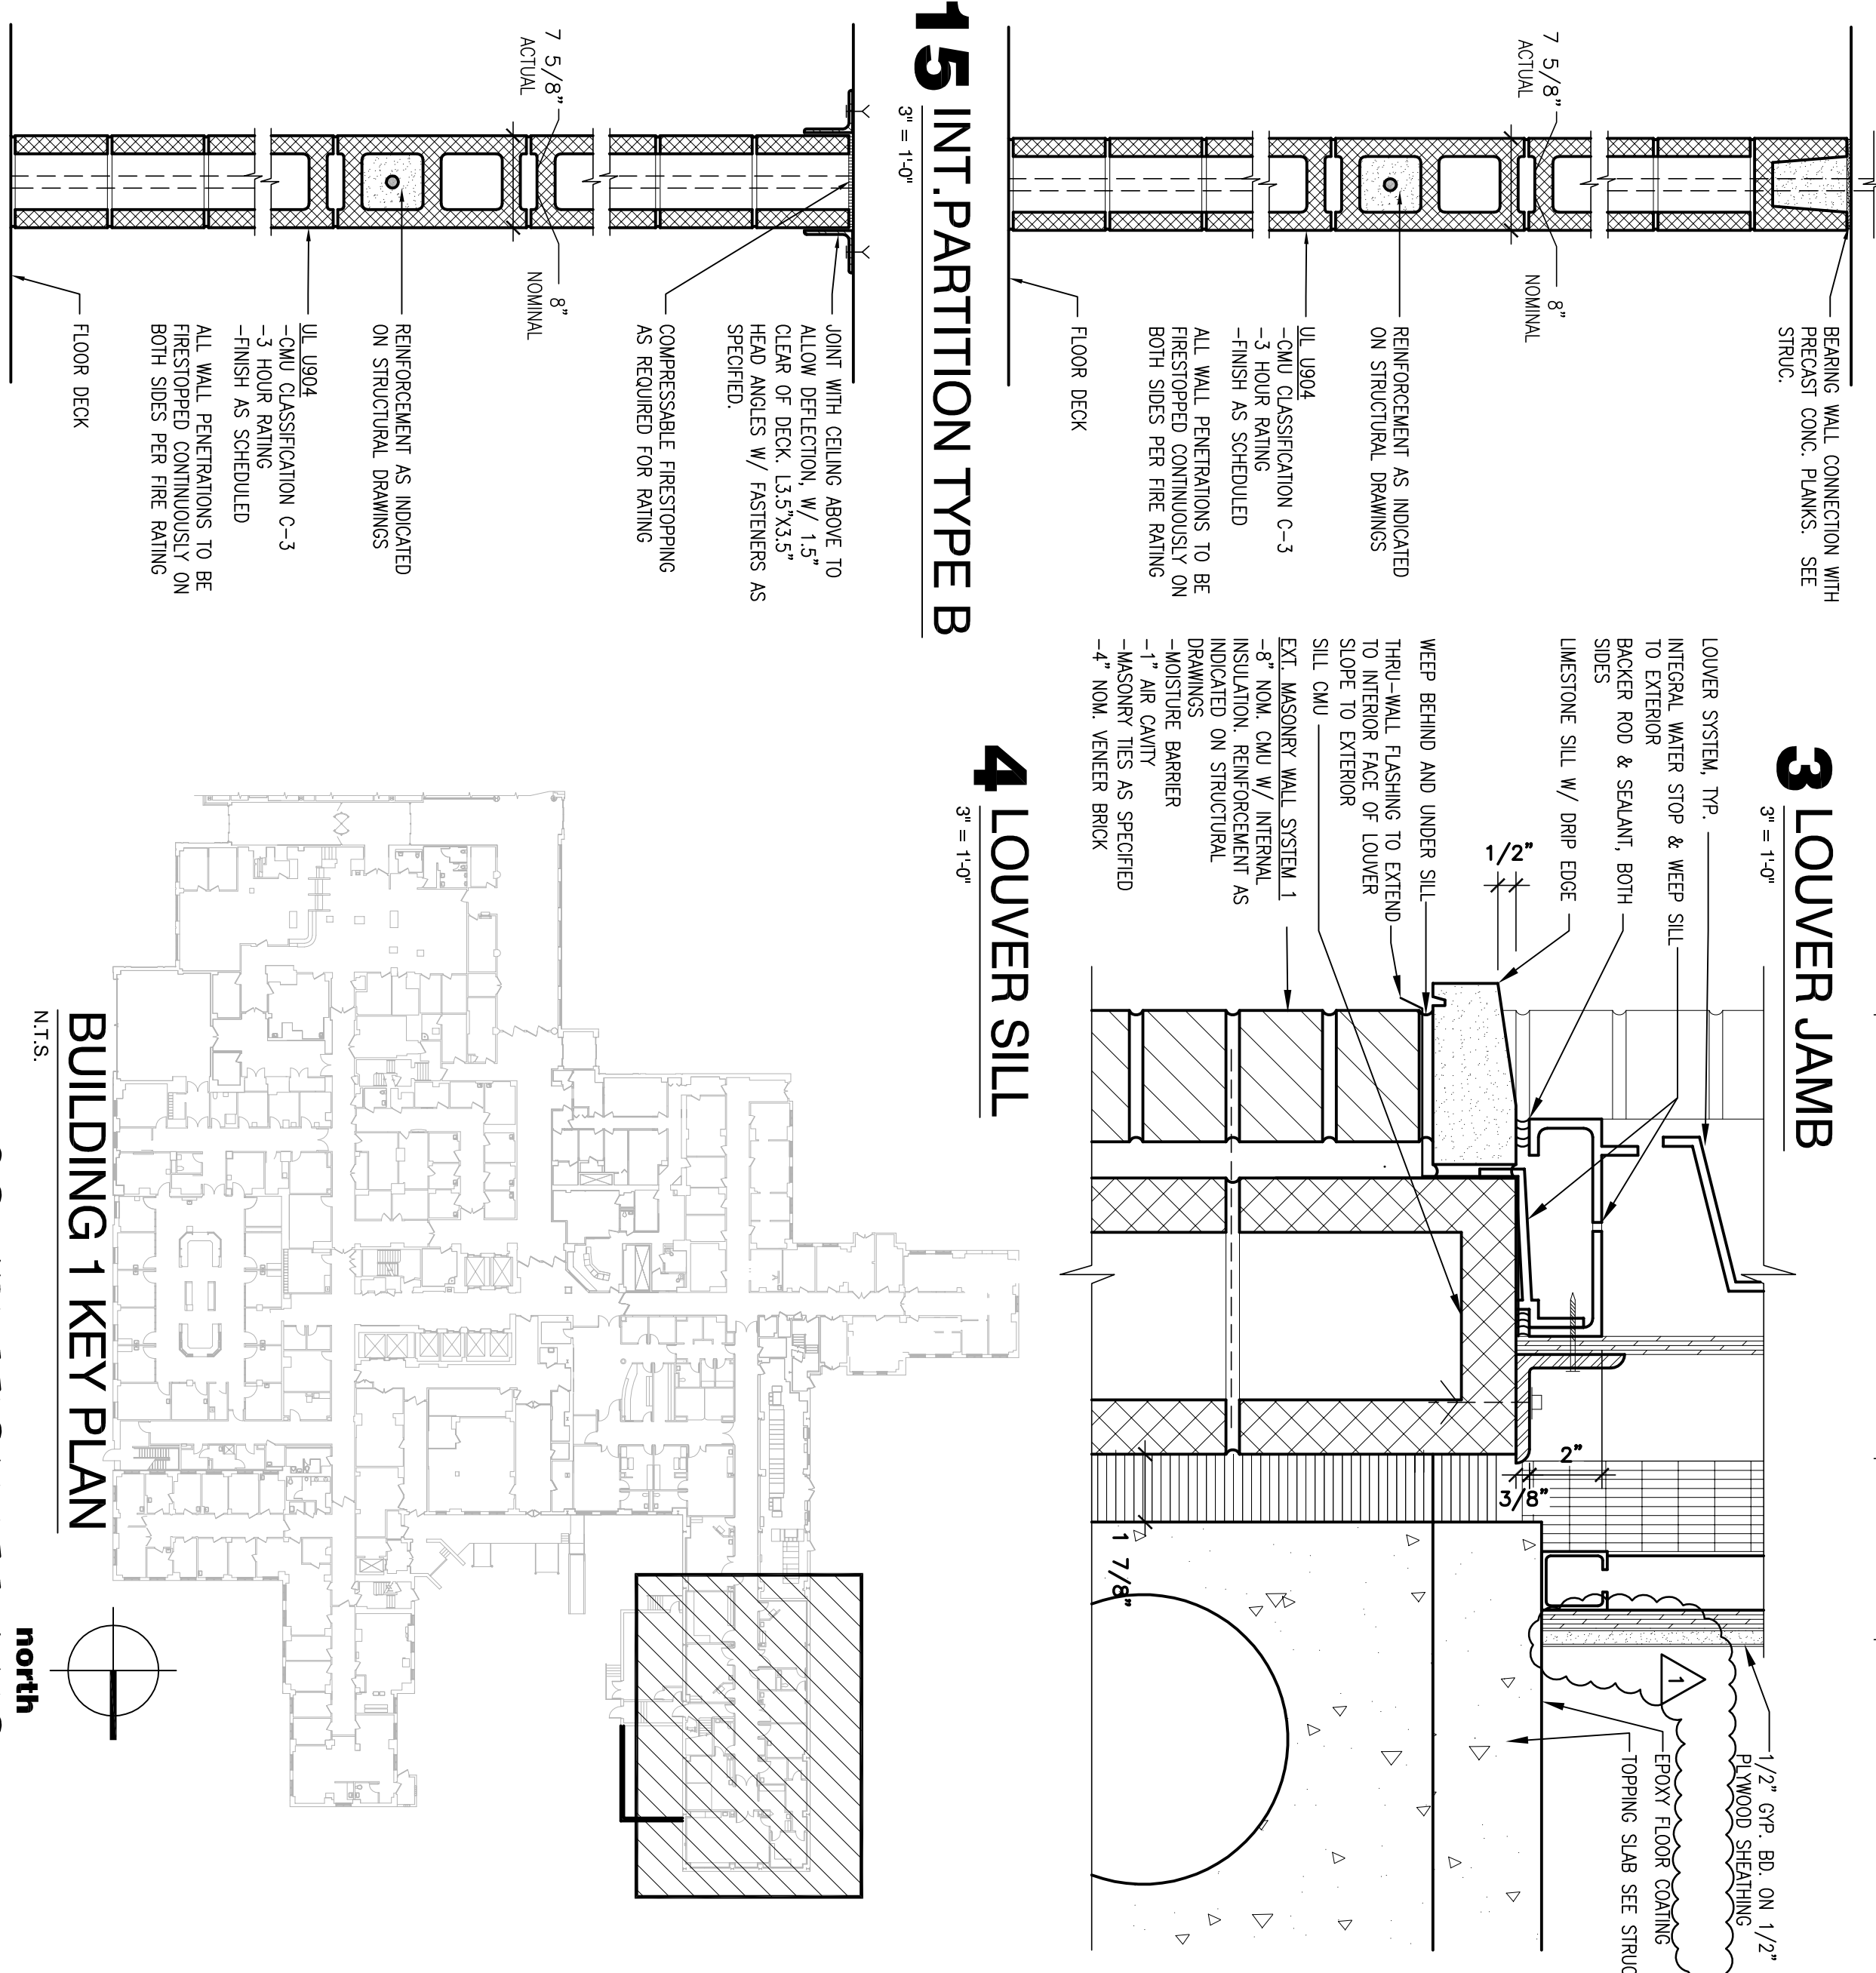


### 3 LOUVER JAMB

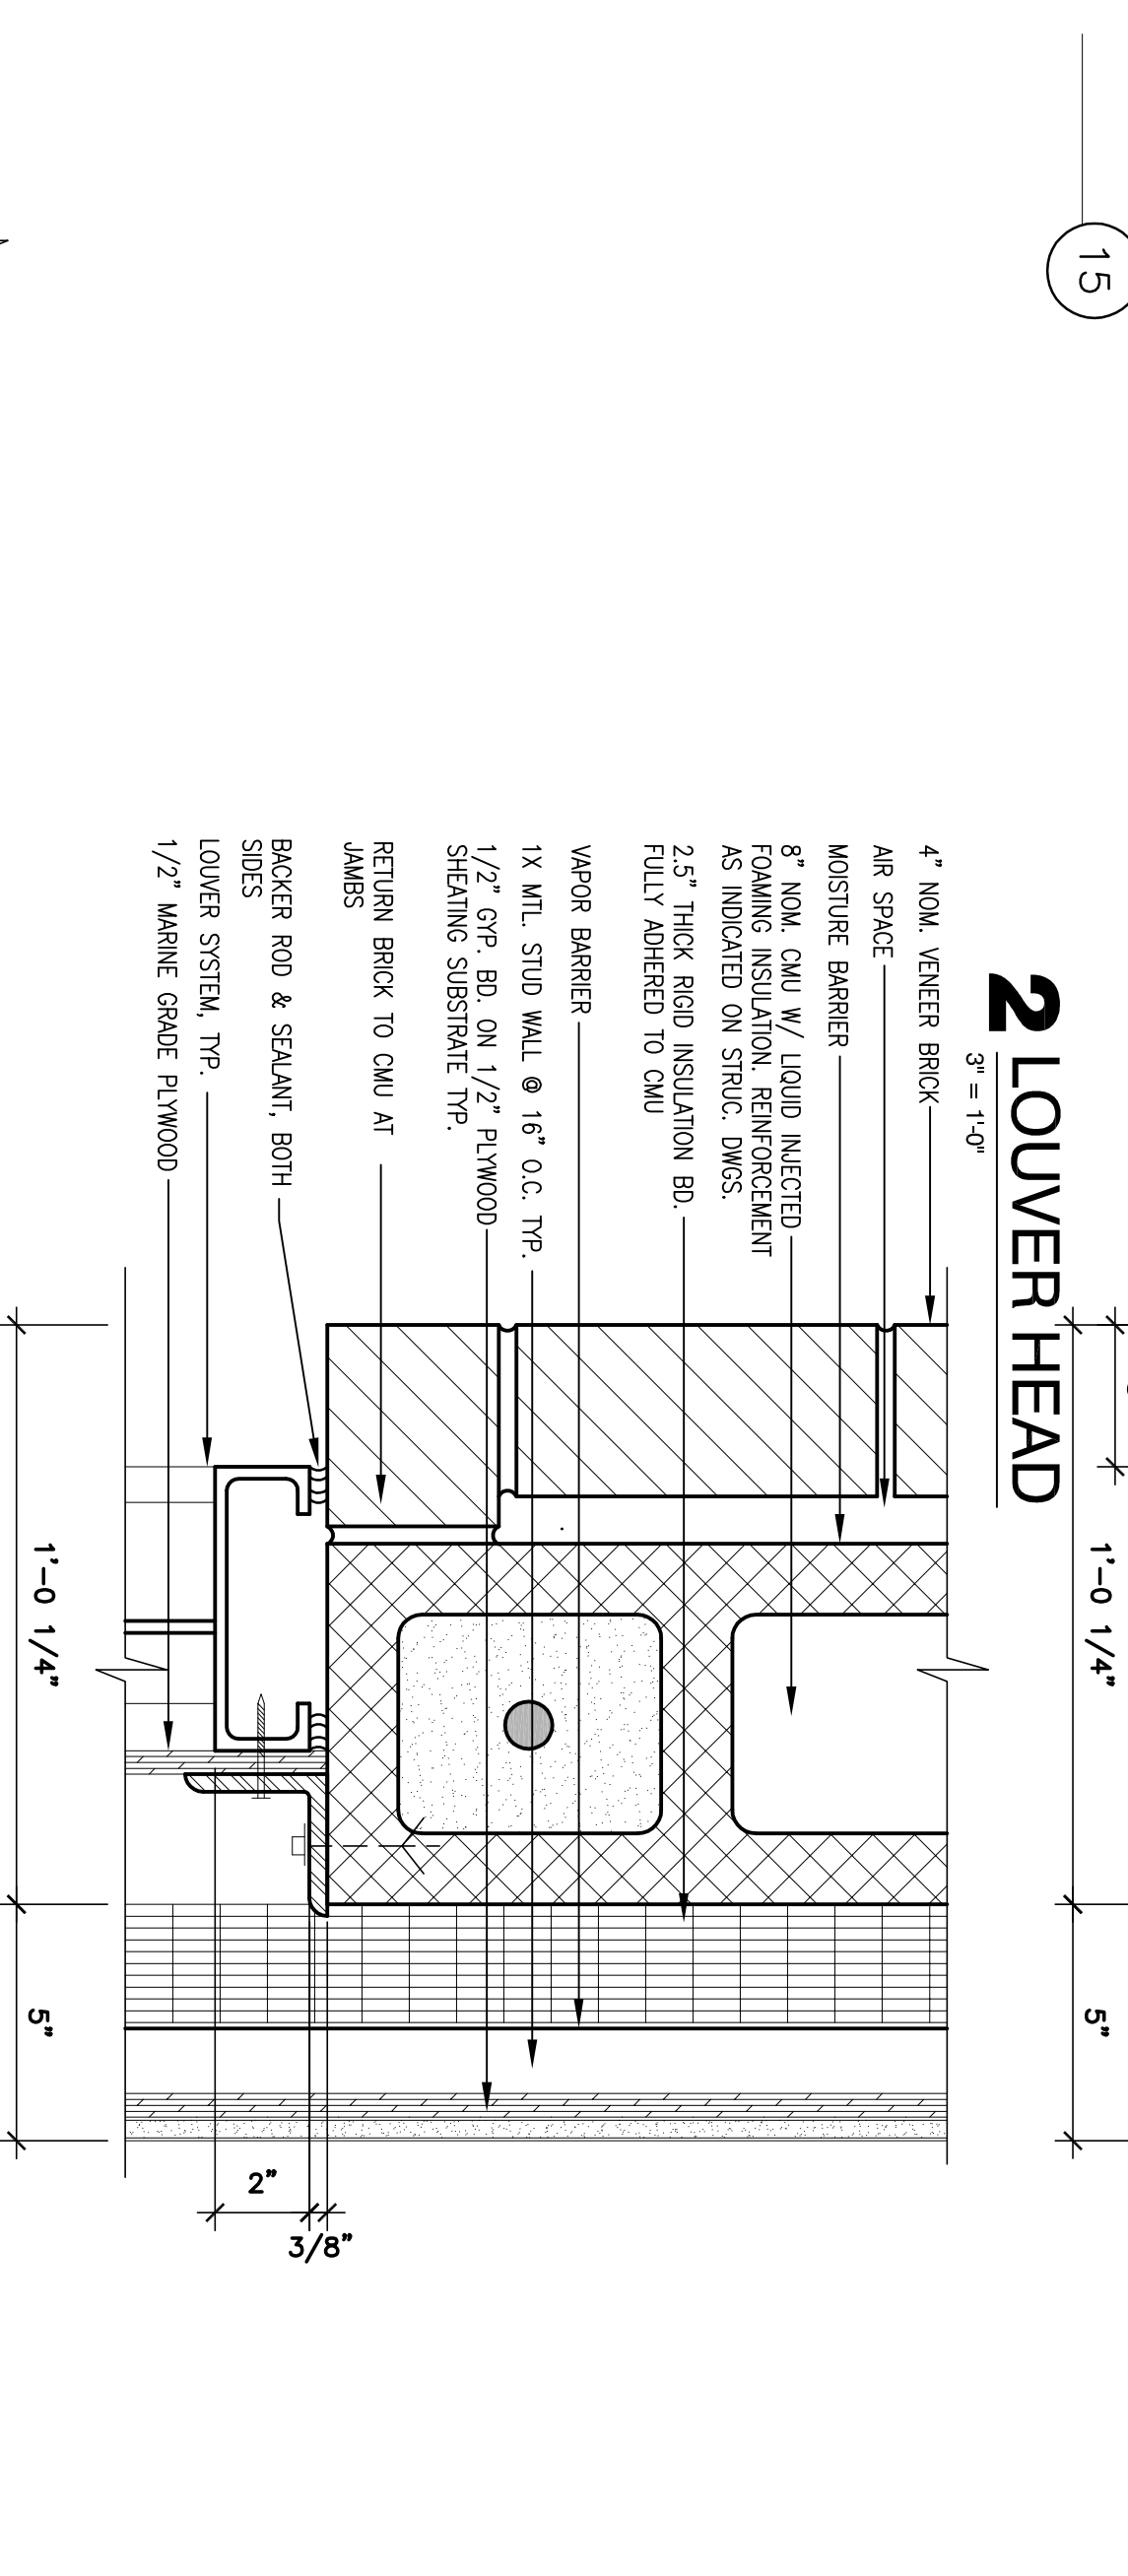

## 2 LOUVER HEAD

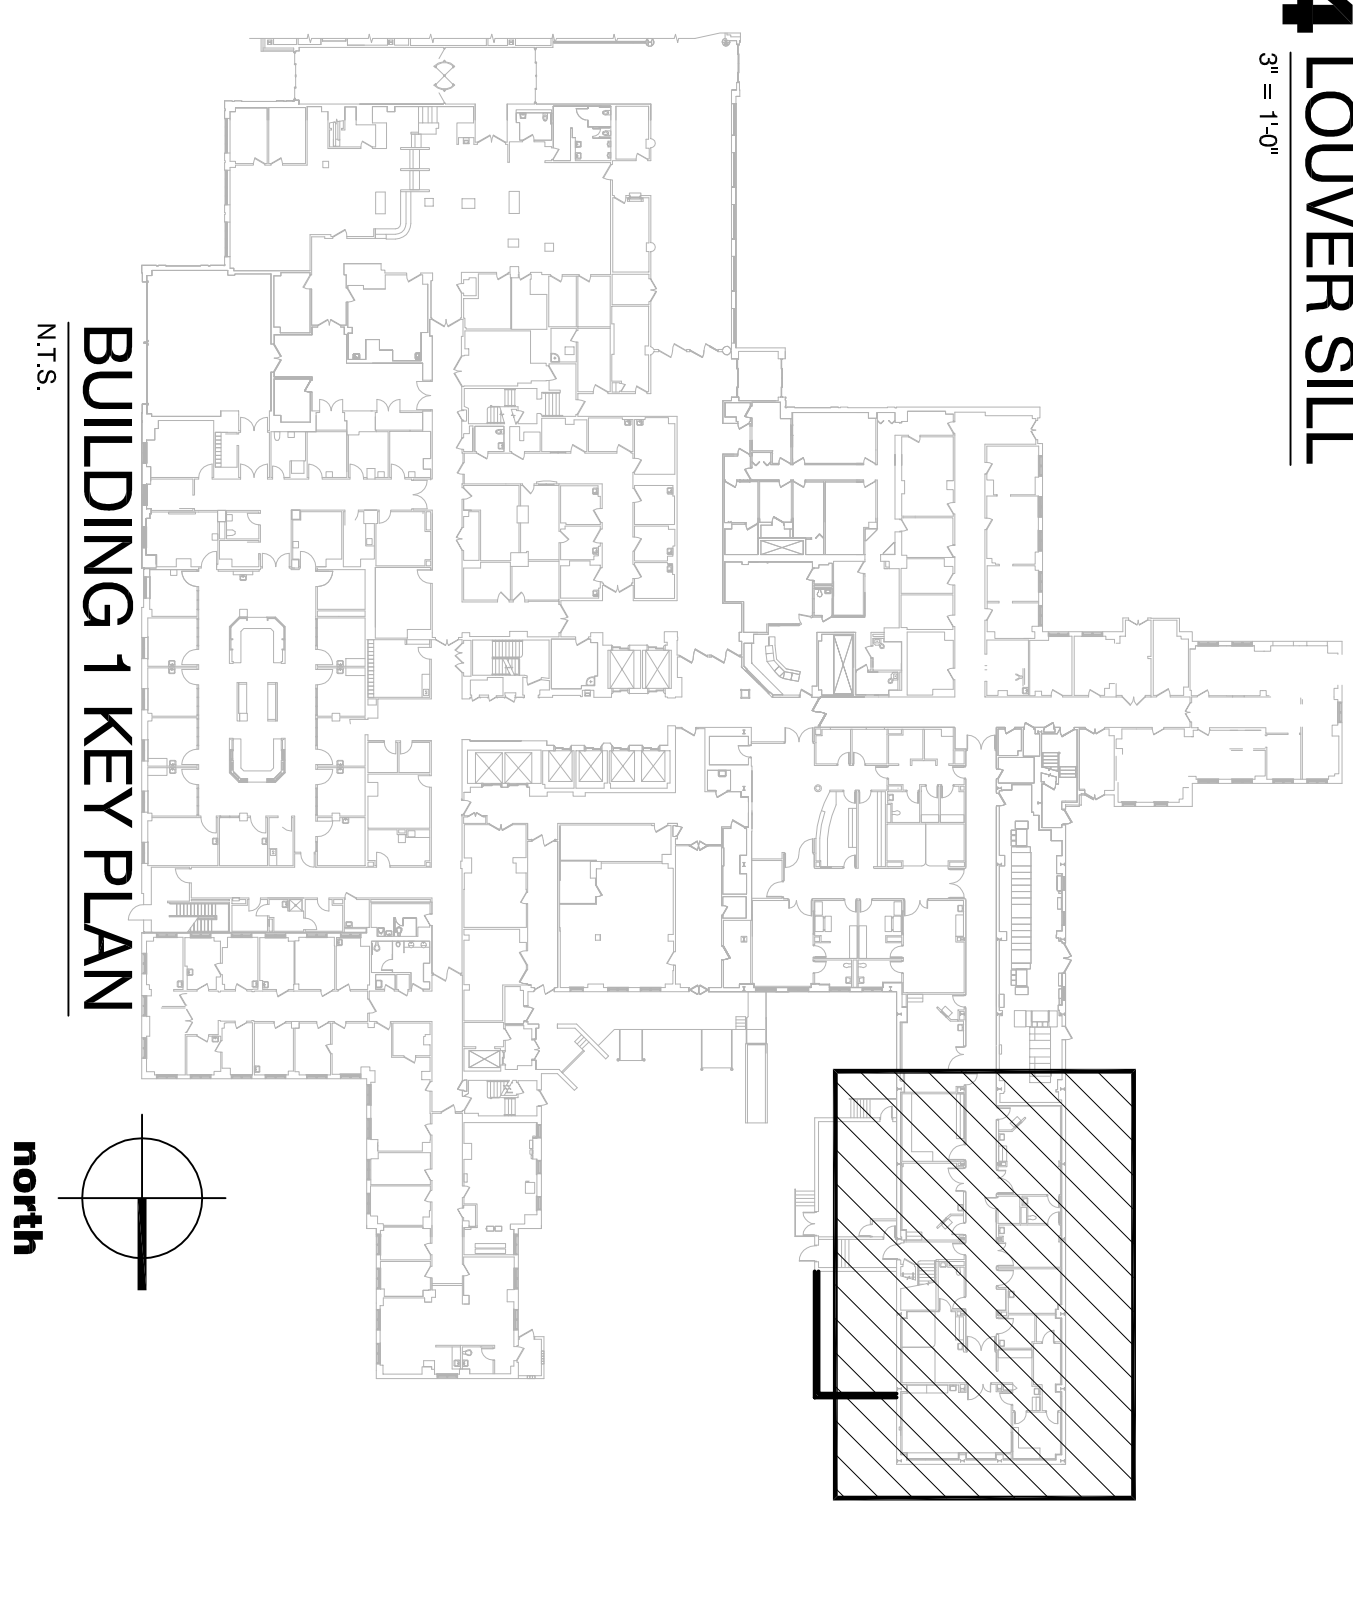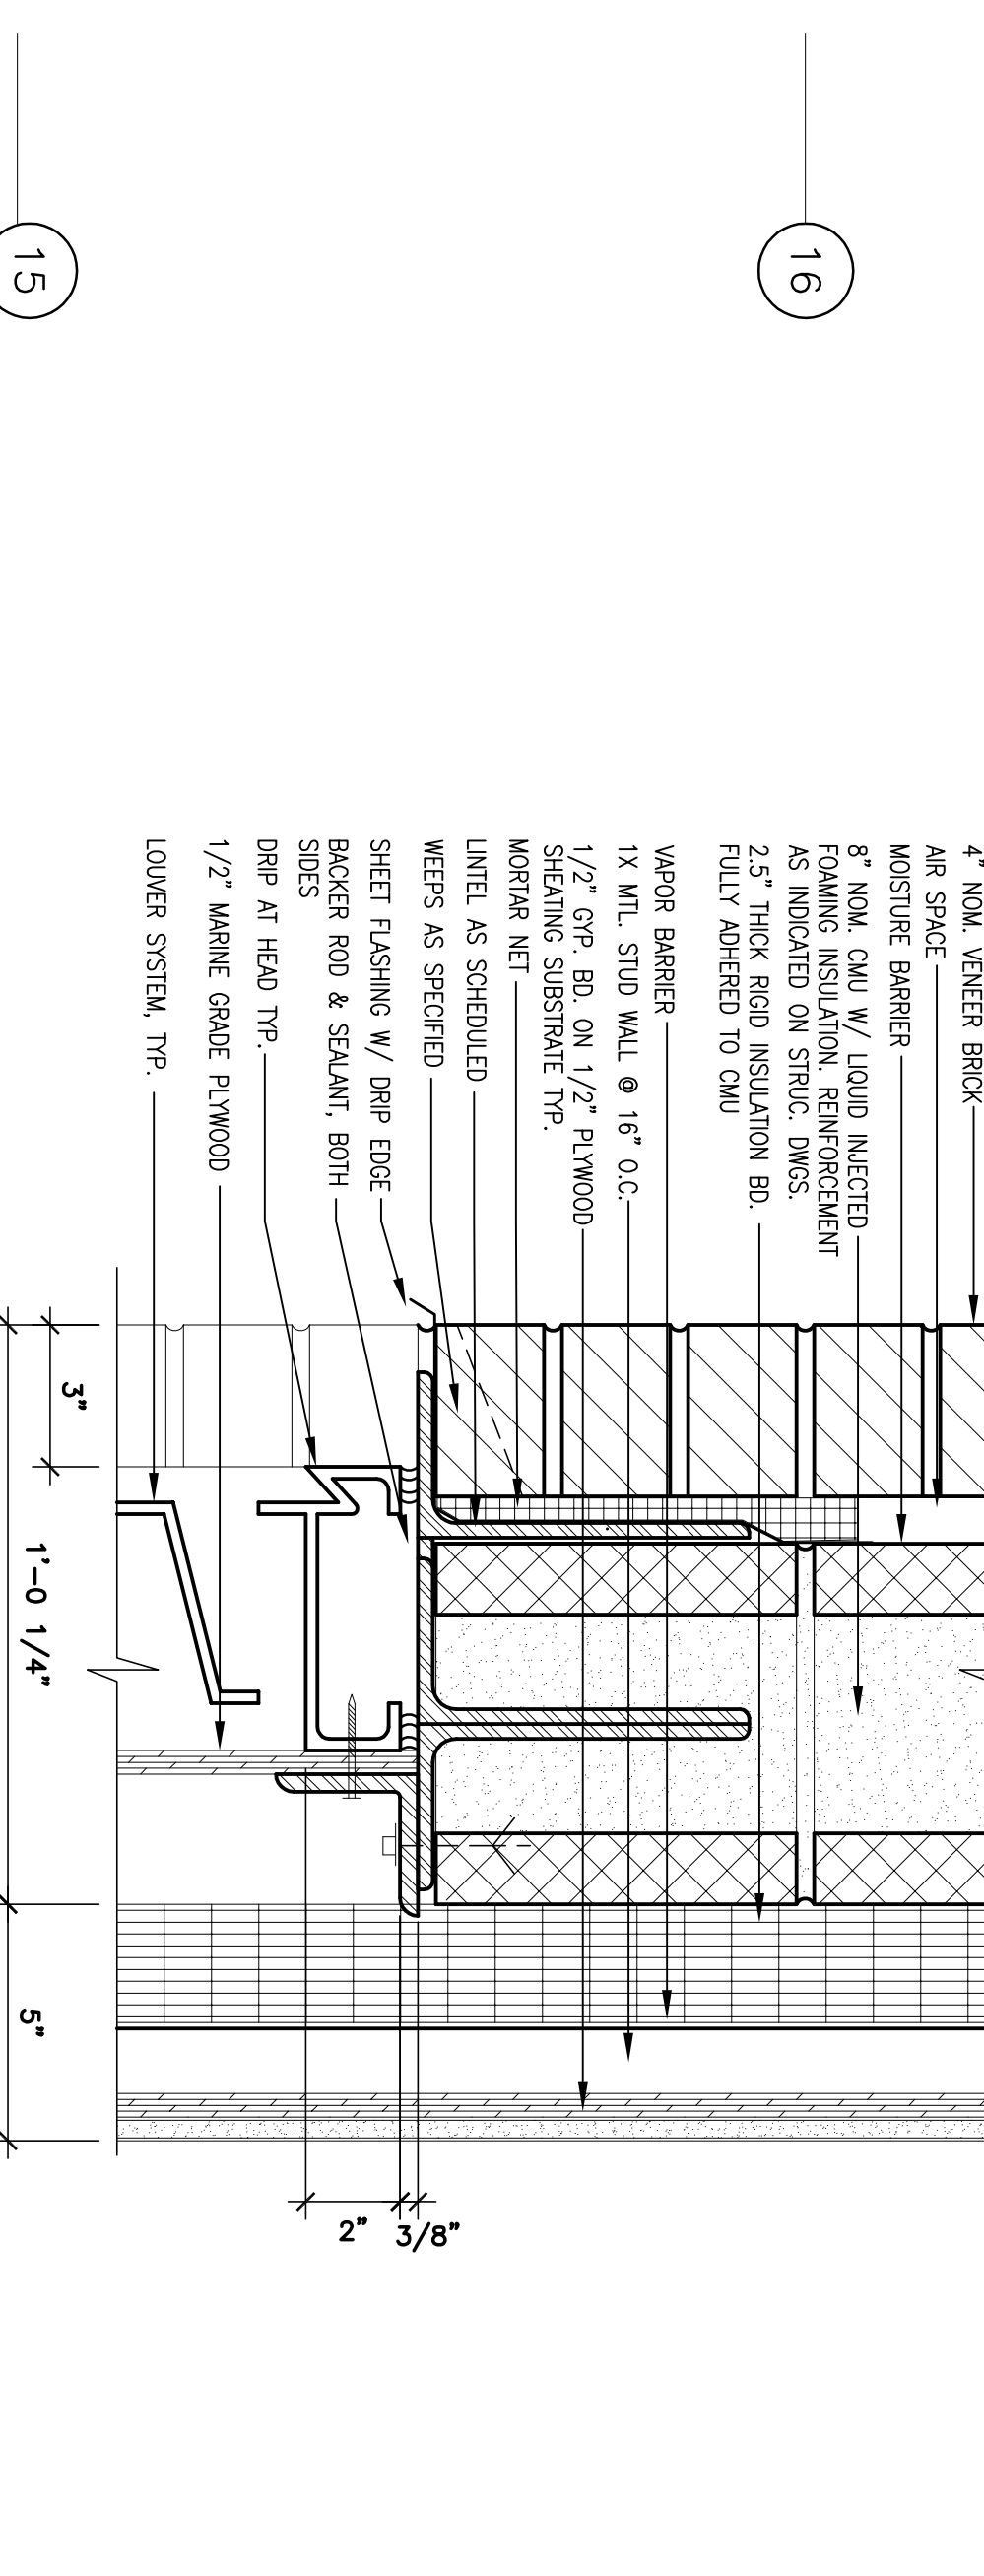


#### 4 LOUVER SILL

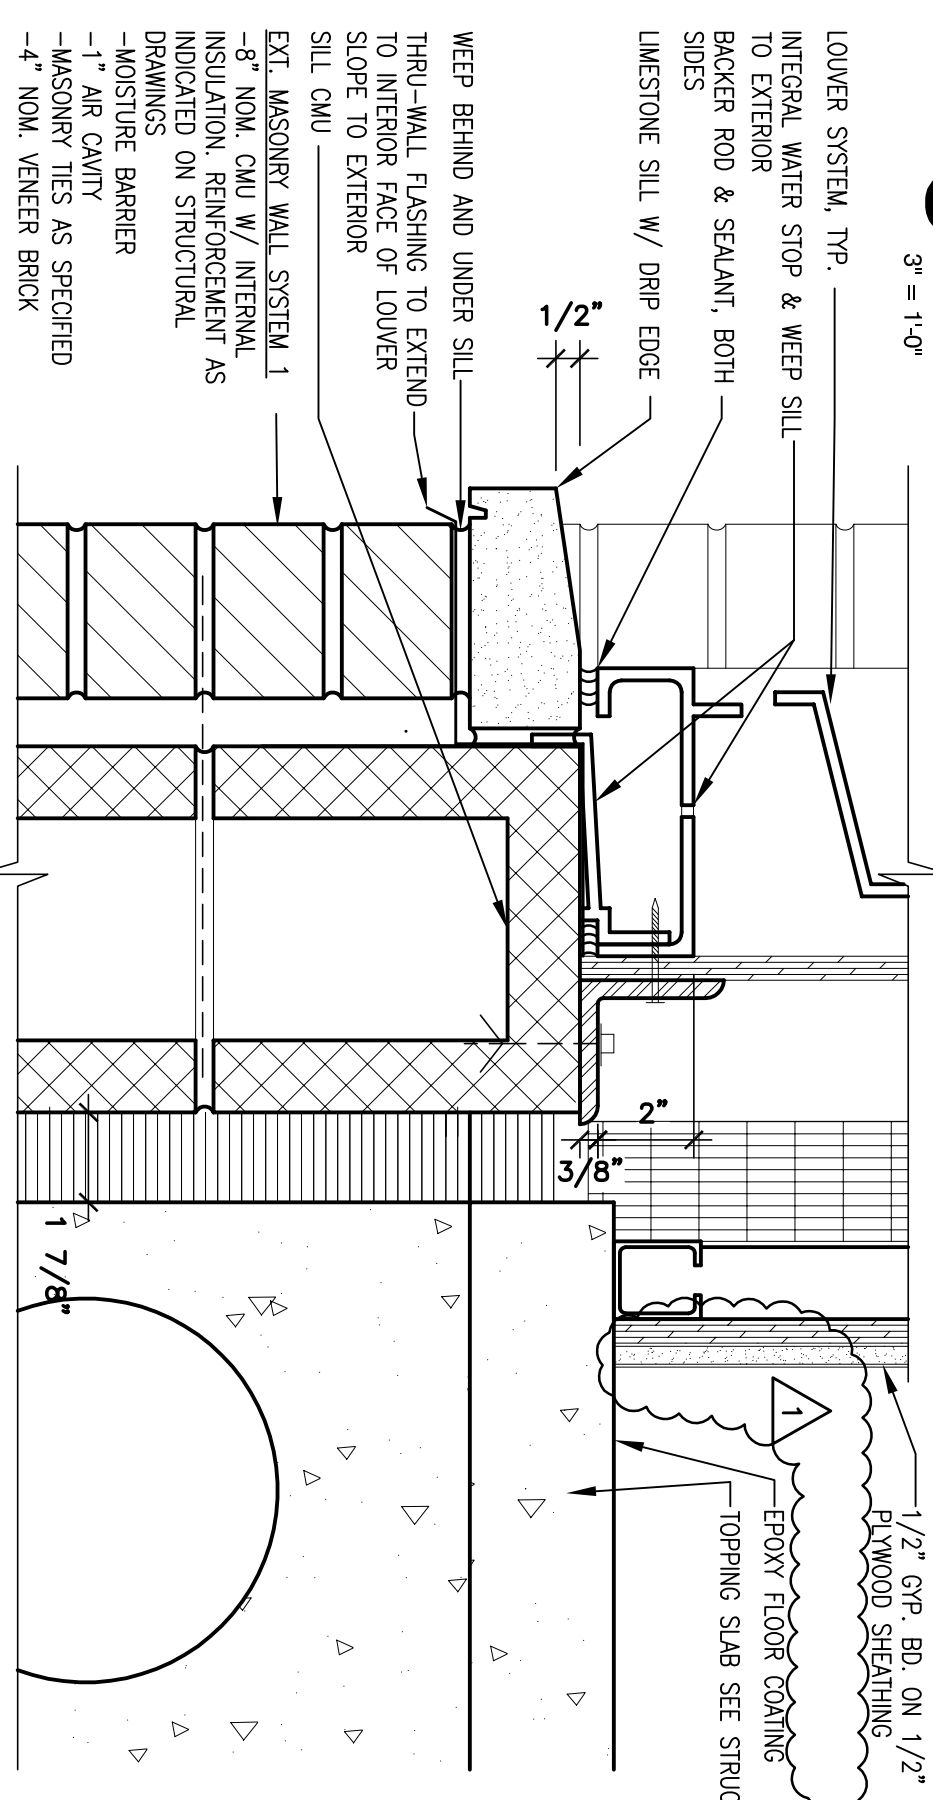

## COMPLETION ITEM NO.

# FULLY SPRINKLERED

Drawing Title <b>FIRST FLOOR PLAN</b>	Project Title <b>UPGRADE NORMAL AND EMERGENCY POWER SUB-STATIONS</b>	Project Number <b>537-11-144</b>	Office of Construction and Facilities Management
		Building Number <b>1C</b>	
Approved Project Director	Location <b>JESSE BROWN V.A.M.C.</b>	Drawing Number <b>537-1C-AS-101</b>	 Departmental Veterans Affairs
	Date <b>FEBRUARY 1, 2012</b>	Checked <b>JJC</b>	