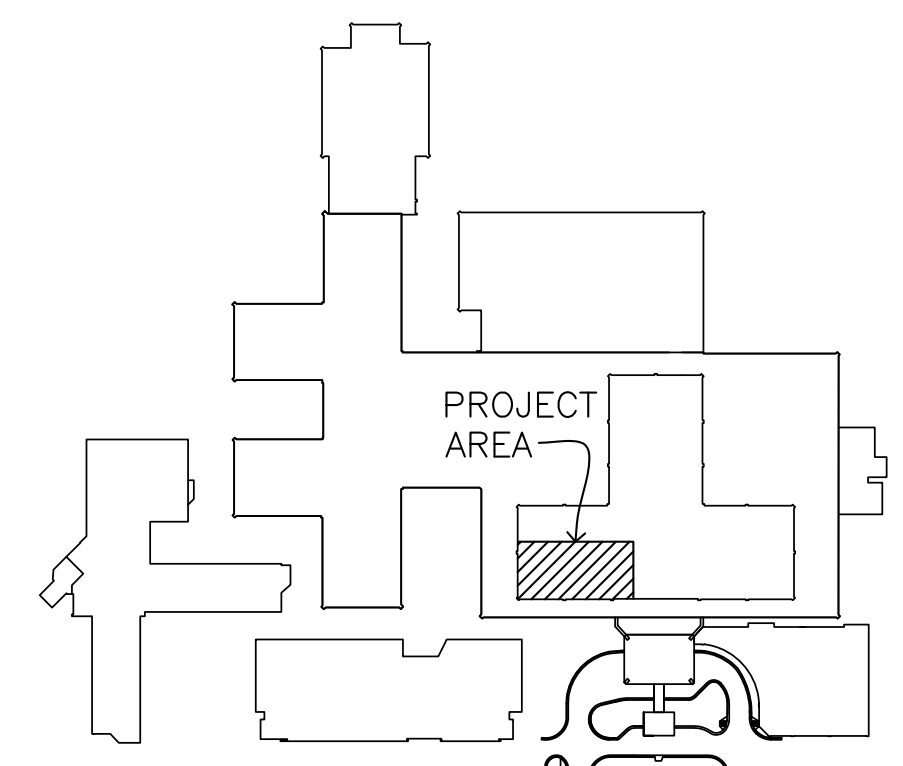
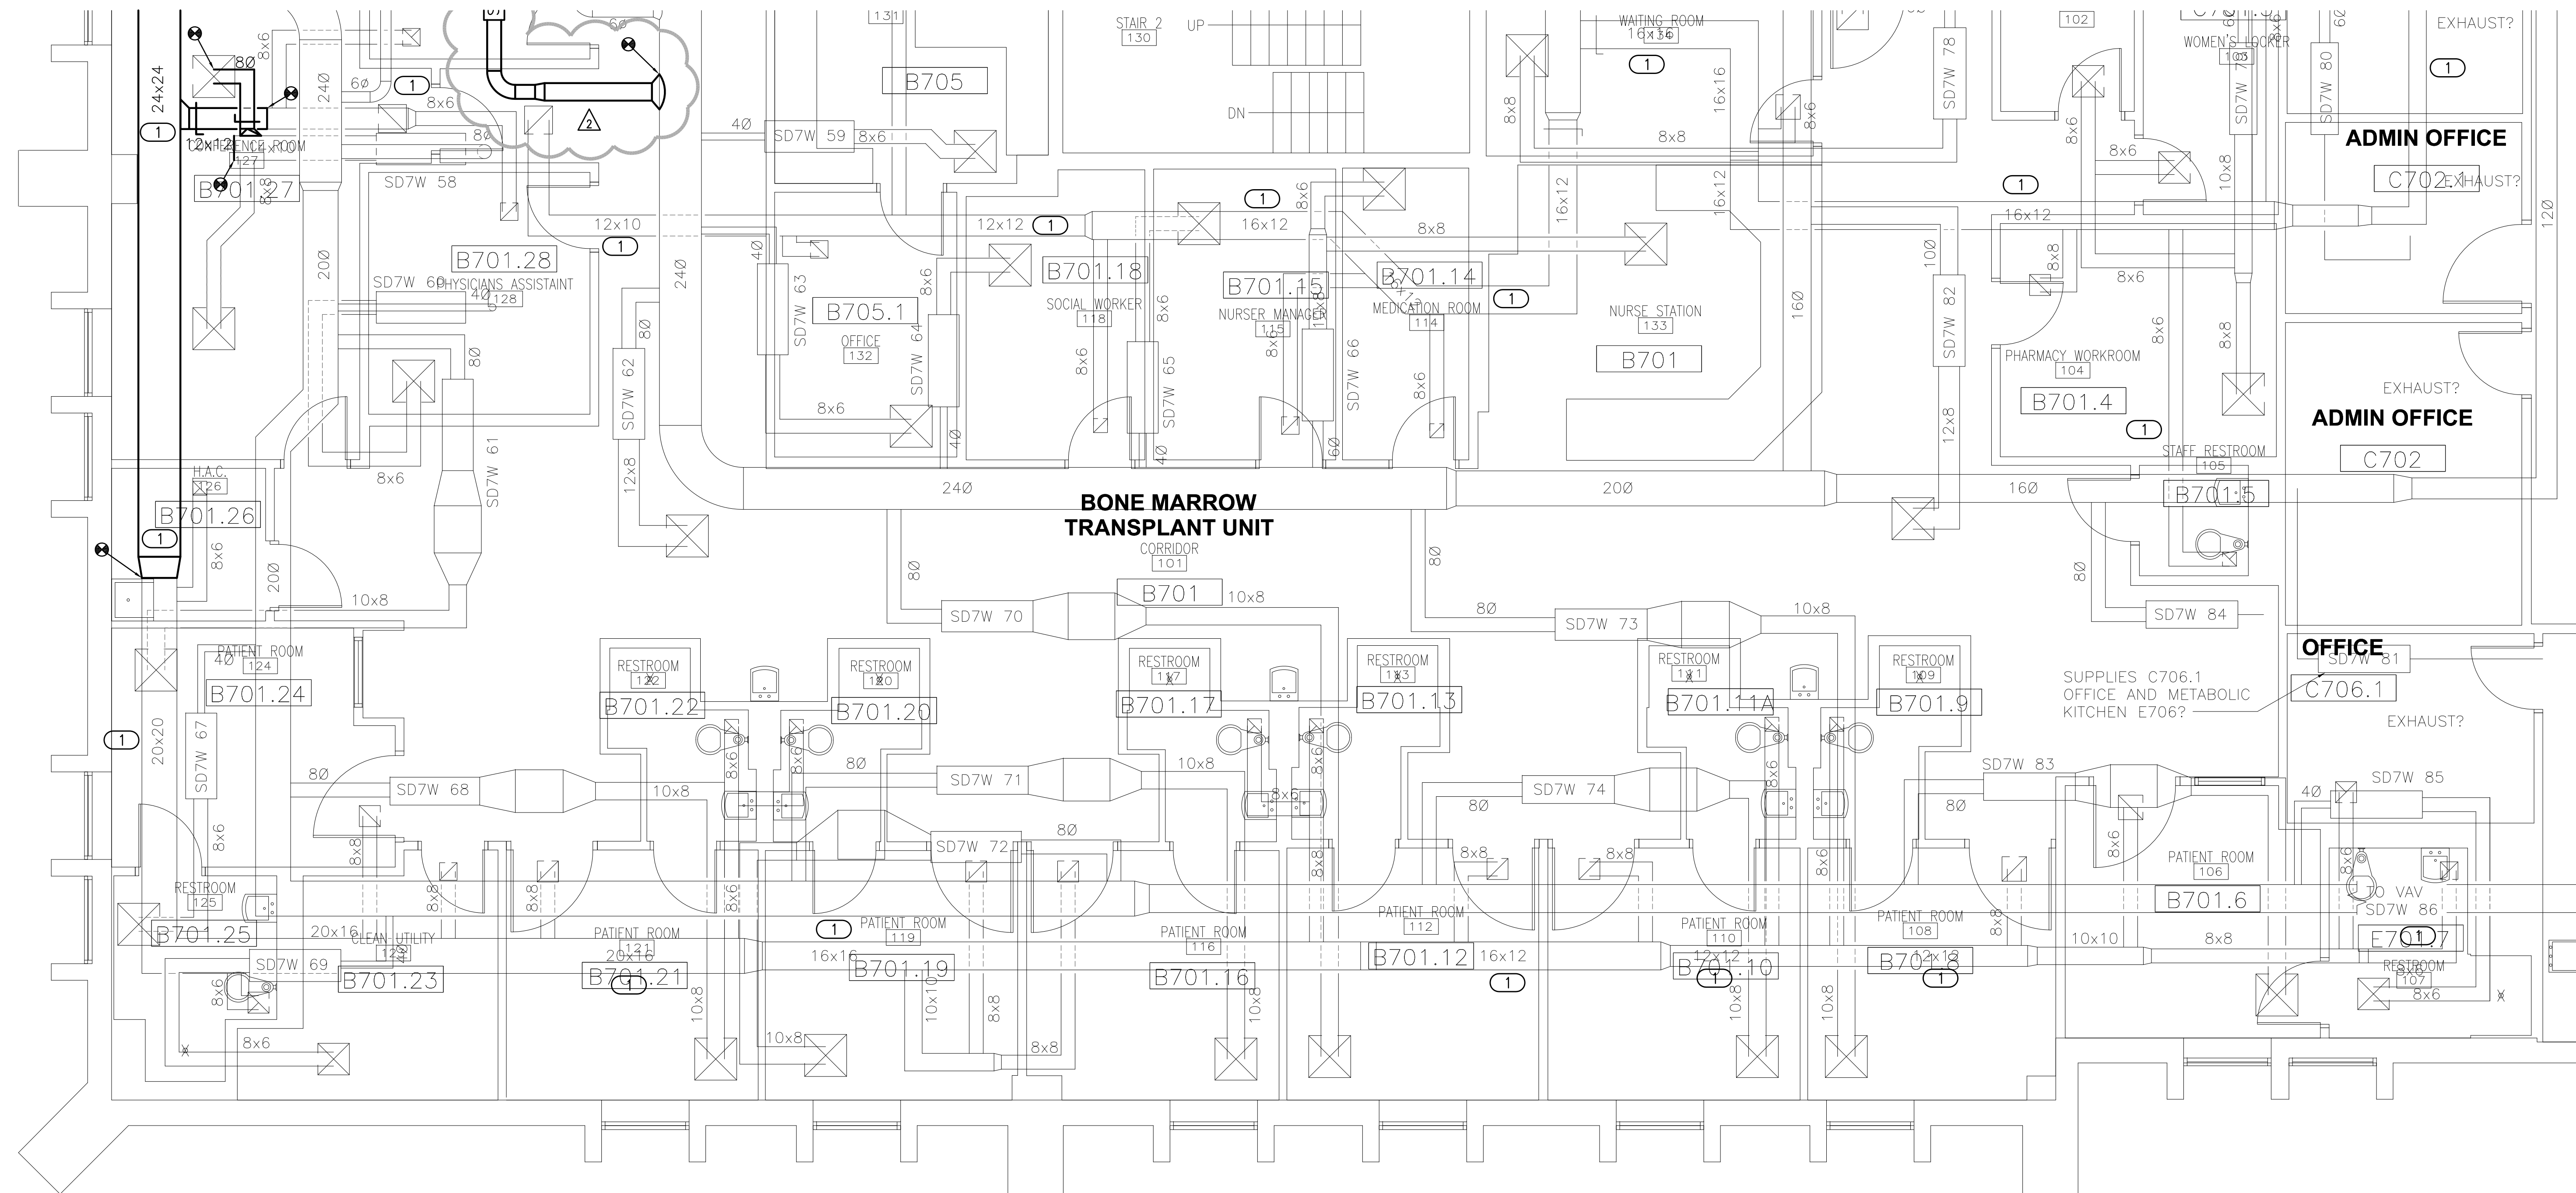


## GENERAL NOTES

1. CUT, PATCH AND REPAIR ALL DUCTWORK AS REQUIRED FOR CONSTRUCTION COMPLETION.
2. COORDINATE NEW DUCTWORK INSTALLATION WITH EXISTING UTILITIES. PROVIDE DUCTWORK OFFSETS AS REQUIRED TO COMPLETE INSTALLATION.
3. PROVIDE TRANSITIONS AND OFFSETS AS REQUIRED FOR CONNECTION TO EXISTING DUCTWORK, GRILLES, REGISTERS AND DIFFUSERS.
4. PROVIDE VOLUME DAMPERS IN EXISTING DUCTWORK AS REQUIRED FOR SYSTEM BALANCING.
5. SEAL COMPLETED AHU-72A DUCTWORK SYSTEM FROM THE INSIDE USING AUTOMATED AEROSOLIZED SEALANT INJECTION. SEE SPECIFICATION 23 33 53 FOR ADDITIONAL INFORMATION.
6. INSTALL ACCESS DOORS AT 20 FOOT INTERVALS AND AT EACH CHANGE IN DIRECTION FOR ALL NEW SUPPLY AND RETURN/EXHAUST DUCTWORK. SEE SPECIFICATION FOR ACCESS DOOR SIZE.


 


## KEYED NOTES

- ① INSULATE ALL EXISTING AND NEW EXHAUST/RETURN DUCT MAINS AND DUCTWORK RUNOUTS.



**KEY PLAN**  
NOT TO SCALE

1 MECHANICAL - DUCTWORK PLAN 7TH FLOOR WEST BMT  
1/4" = 1'-0"

		CONSULTANTS:		 <p>engineers   consultants   commissioning 2800 West Bonham Street, Suite 2004   Houston, TX 77057 P: 409.364.9326   mep@meconsultants.com CNA: 5173      Expiration Date: 06/30/2017 MEP PROJECT NO.: P14.15.01</p>		 <p>17/13/15</p>		ARCHITECT/ENGINEERS:		 <p>1144 AIRPORT BLVD. SUITE 260 AUSTIN, TX. 78702 (866) 226-8071 TELE. (866) 226-9969 FAX</p> <p>WWW.PRIME-ARCH.COM</p>		Drawing Title MECHANICAL - DUCTWORK PLAN 7TH FLOOR WEST BMT		Project Title REFURBISH BONE MARROW TRANSPLANT UNIT		Project Number 671-15-100		Office of Construction and Facilities Management  Department of Veterans Affairs	
										Building Number 1		Drawing Number MH-103 Dwg. 30 of 45							
Addendum 03 Revisions		04/12/17 Date						Approved: Project Director _____ _____ _____		Location VAMC SAN ANTONIO TX		Date NOVEMBER 12, 2015		Checked JAU		Drawn JRM			