


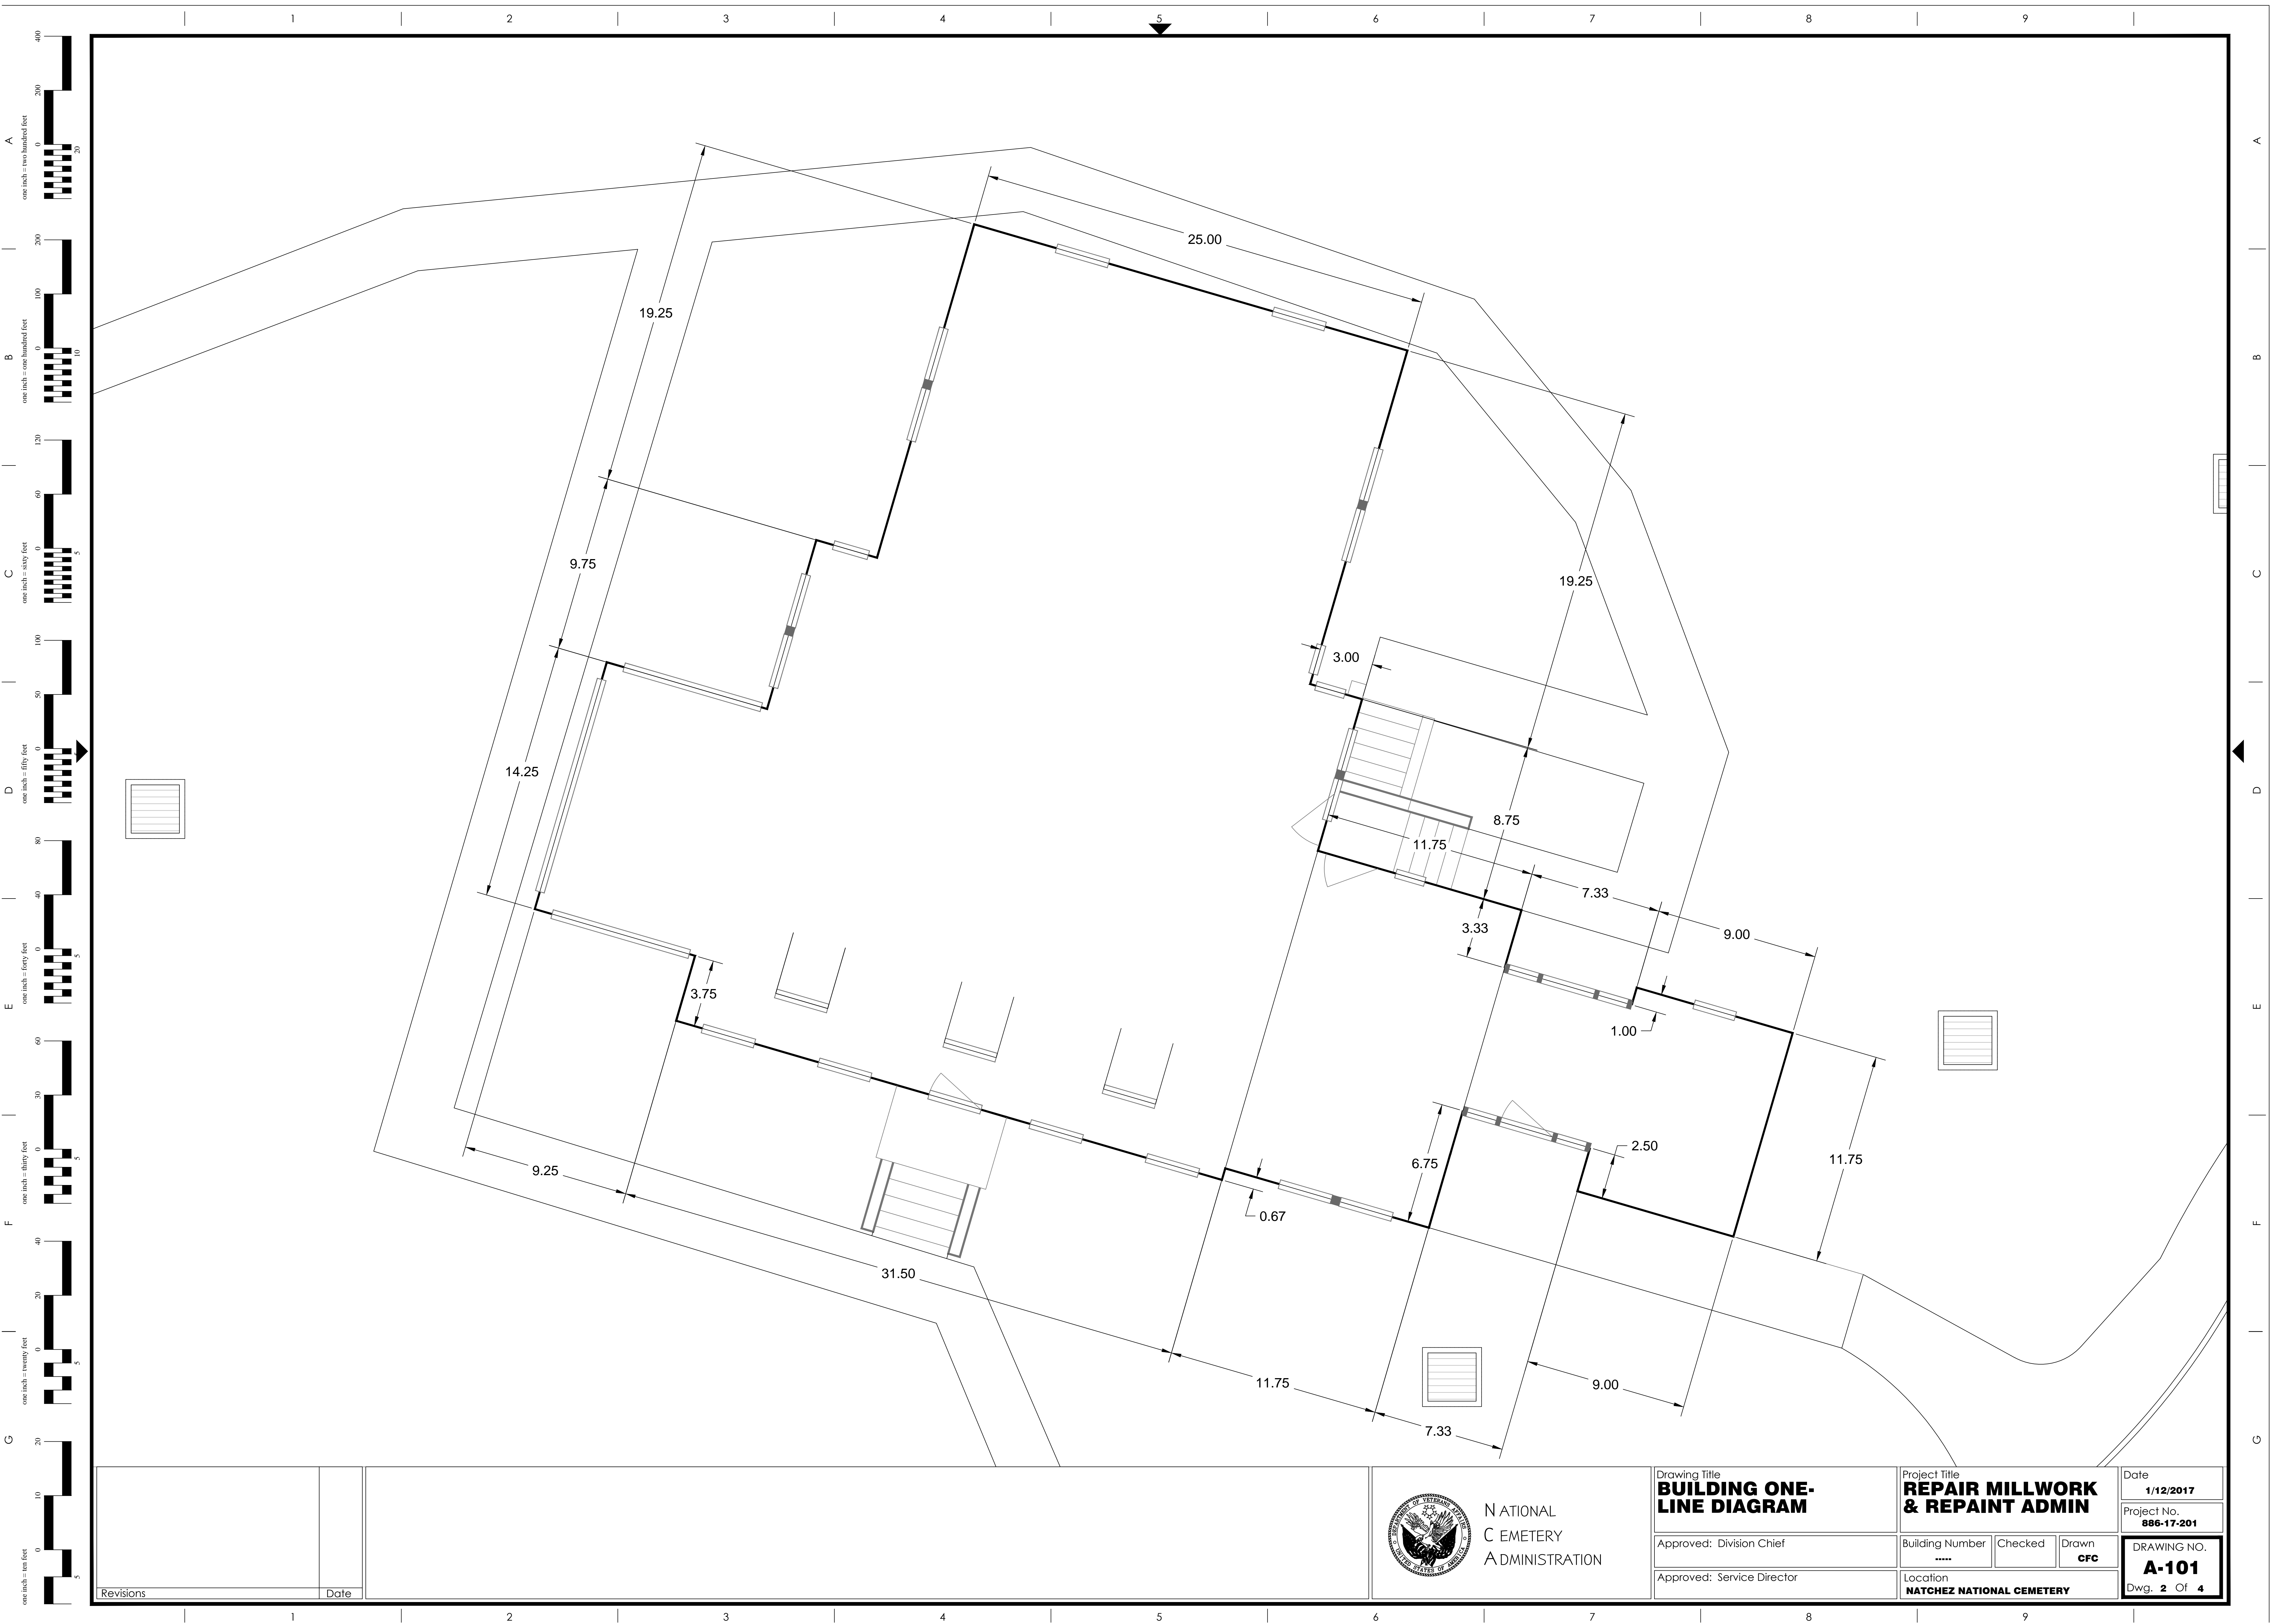
Department Of
Veterans Affairs

NATCHEZ NATIONAL CEMETERY
NATCHEZ, MISSISSIPPI
REPAIR MILLWORK AND
REPAINT ADMINISTRATION BUILDING
PROJECT NUMBER 886-17-201

SHEET INDEX:

X-101	TITLE SHEET
A-101	ONE-LINE DIAGRAM
A-102	REGLAZING FLOOR PLAN
A-103	MILLWORK ROOF PLAN

<div>Revisions</div>		<div>Date</div>				<div> NATIONAL CEMETERY ADMINISTRATION</div>	<div>Drawing Title COVER SHEET & SHEET INDEX</div> <div>Approved: Division Chief</div> <div>Approved: Service Director</div>	<div>Project Title REPAIR MILLWORK & REPAINT ADMIN</div> <div>Building Number *****</div> <div>Location NATCHEZ NATIONAL CEMETERY</div>	<div>Date 1/12/2017</div> <div>Project No. 886-17-201</div>	<div>DRAWING NO. X-101</div> <div>Dwg. 1 Of 4</div>
----------------------	--	-----------------	--	--	--	---	---	---	---	--



Revisions	Date



NATONAL
CEMETERY
ADMINISTRATION

Drawing Title
**BUILDING ONE-
LINE DIAGRAM**

Approved: Division Chief

Approved: Service Director

Project Title
**REPAIR MILLWORK
& REPAINT ADMIN**

Building Number

Checked

Drawn

CFC

Location
NATCHEZ NATIONAL CEMETERY

Date

1/12/2017


Project No.

886-17-201


DRAWING NO.

A-101

Dwg. 2 Of 4

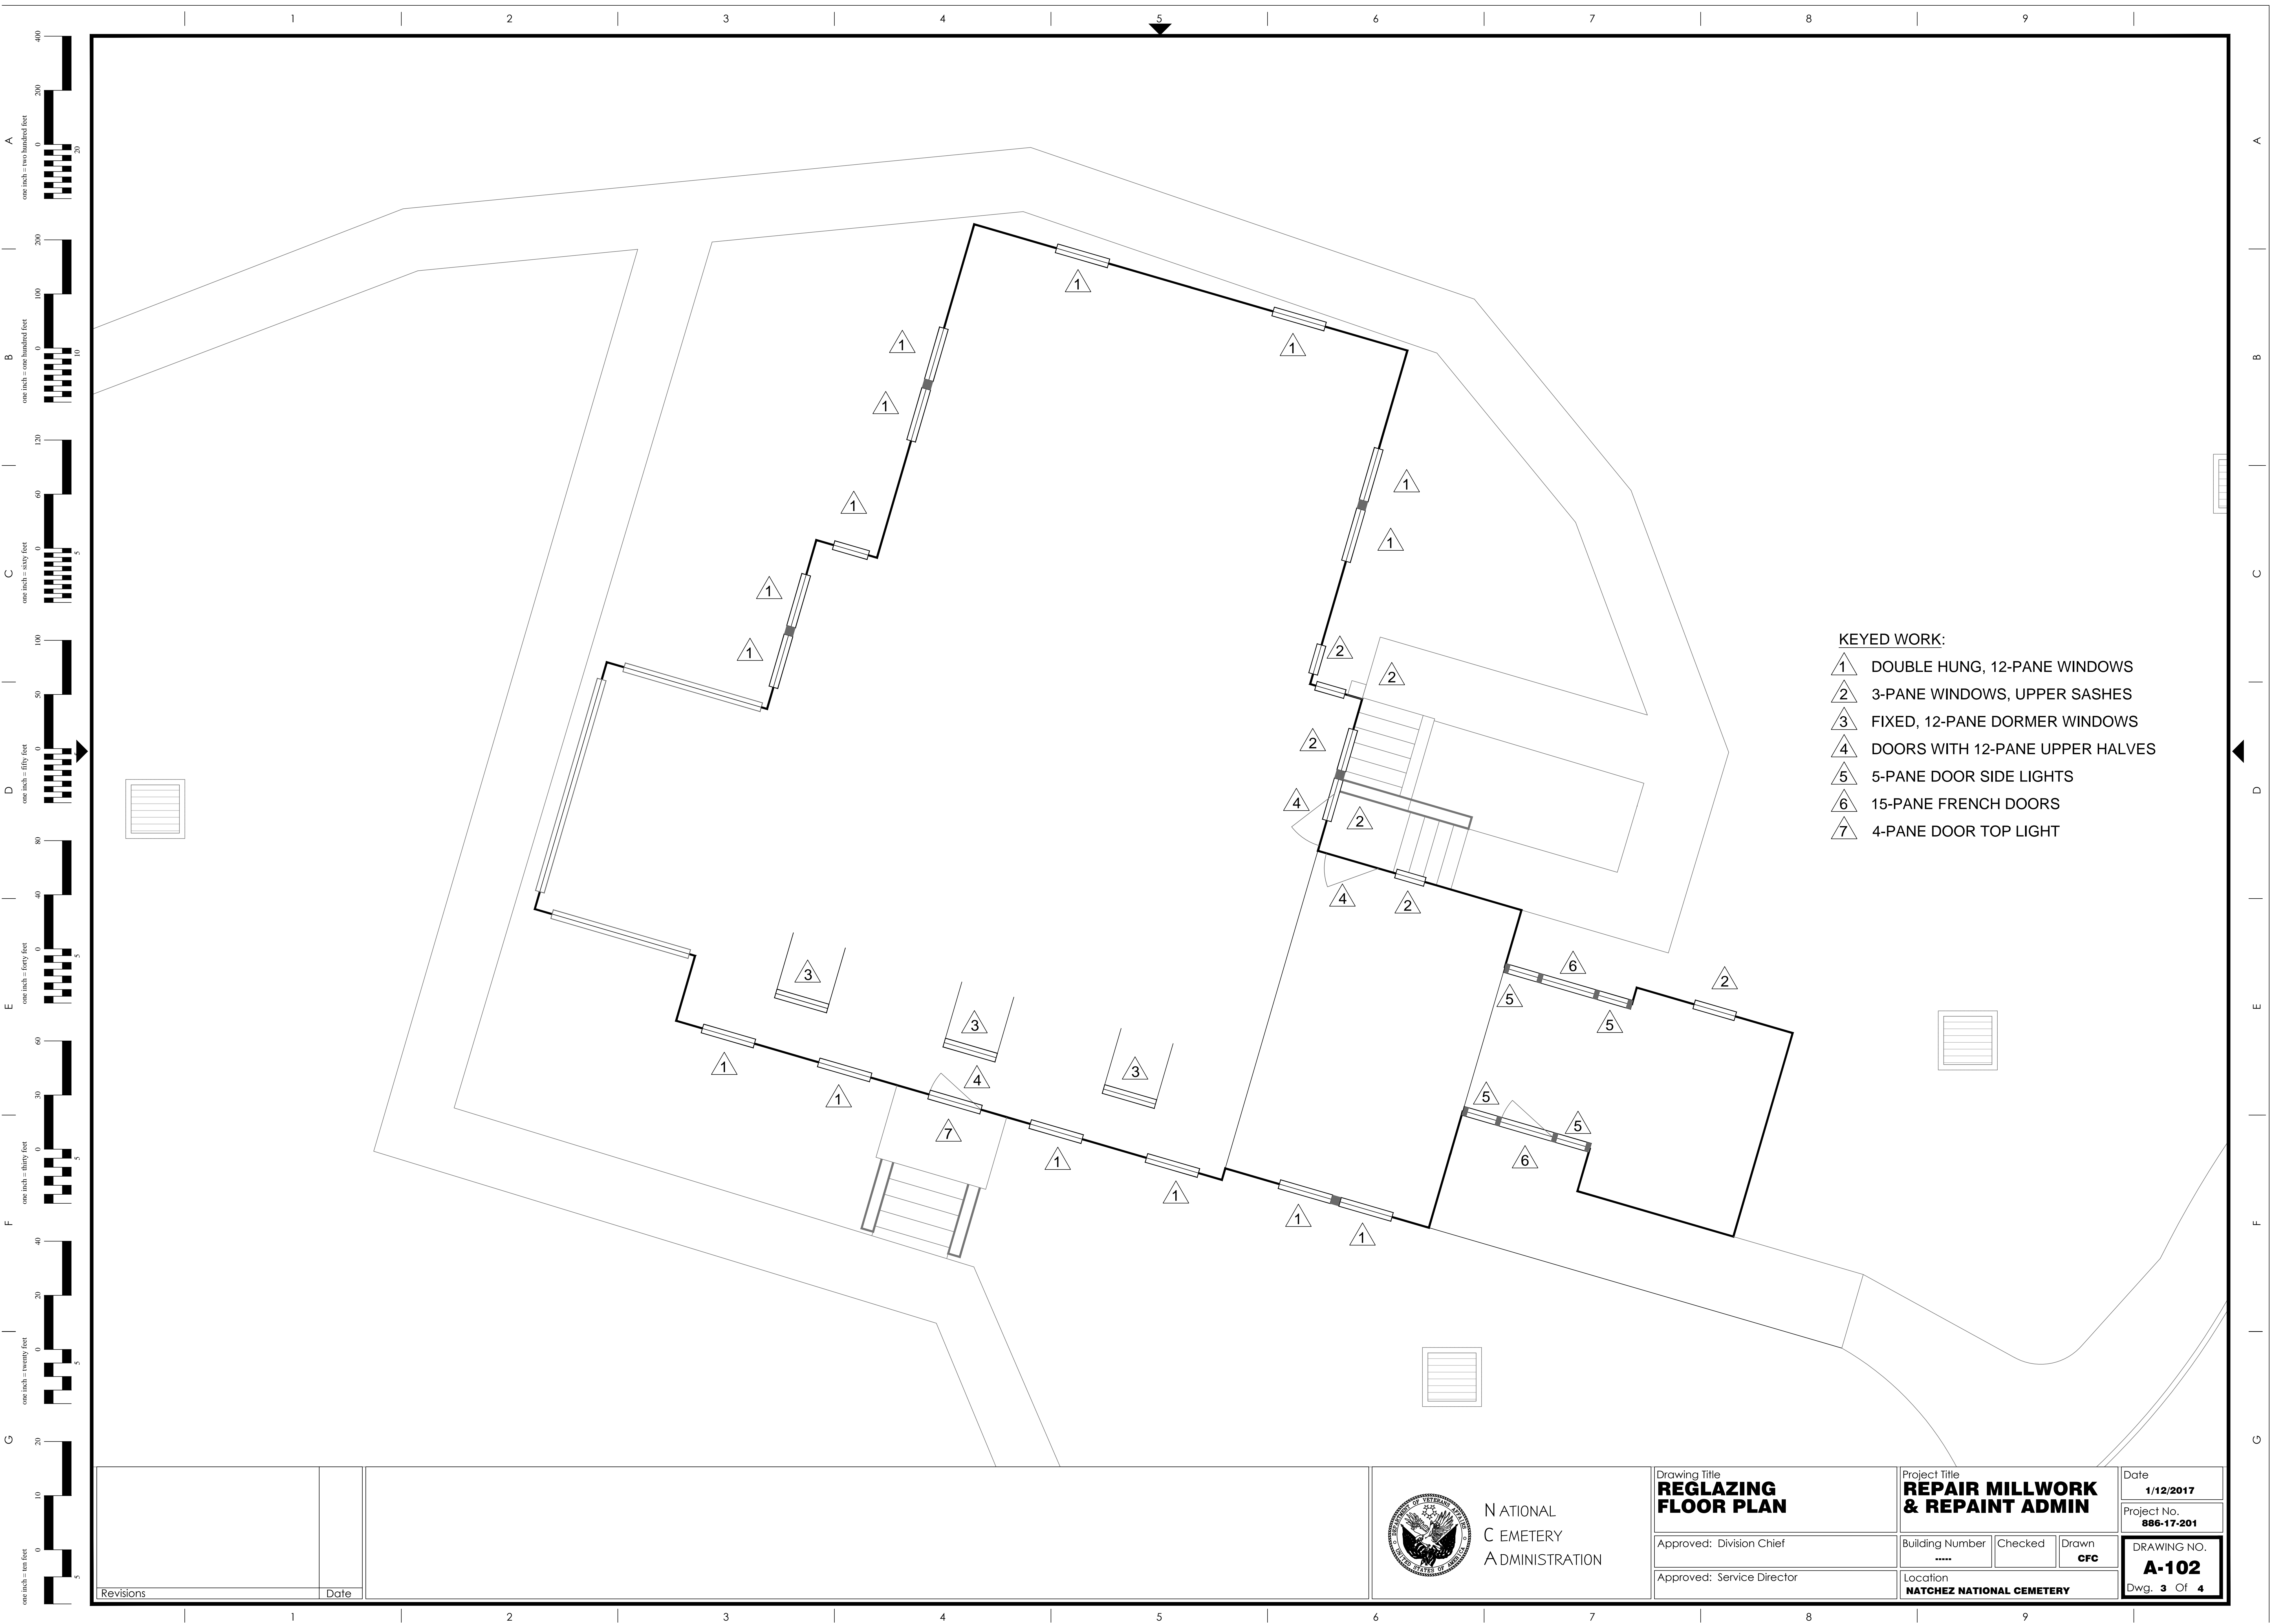

- KEYED WORK:
- 1 DOUBLE HUNG, 12-PANE WINDOWS
 - 2 3-PANE WINDOWS, UPPER SASHES
 - 3 FIXED, 12-PANE DORMER WINDOWS
 - 4 DOORS WITH 12-PANE UPPER HALVES
 - 5 5-PANE DOOR SIDE LIGHTS
 - 6 15-PANE FRENCH DOORS
 - 7 4-PANE DOOR TOP LIGHT

<div>Revisions</div> <div>Date</div>		 <div>NATIONAL CEMETERY ADMINISTRATION</div>	<div>Drawing Title</div> <div>REGLAZING FLOOR PLAN</div>		<div>Project Title</div> <div>REPAIR MILLWORK & REPAINT ADMIN</div>		<div>Date</div> <div>1/12/2017</div>
			<div>Approved: Division Chief</div>	<div>Building Number</div> <div>*****</div>	<div>Checked</div>	<div>Drawn</div> <div>CFC</div>	<div>Project No.</div> <div>886-17-201</div>
			<div>Approved: Service Director</div>	<div>Location</div> <div>NATCHEZ NATIONAL CEMETERY</div>		<div>DRAWING NO.</div> <div>A-102</div>	
							<div>Dwg.</div> <div>3 Of 4</div>

