



1 SECOND FLOOR PLAN
1/8" = 1'-0"

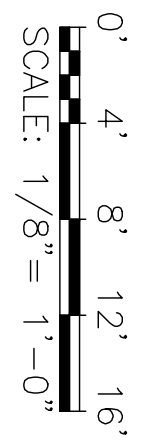

KEY PLAN
N

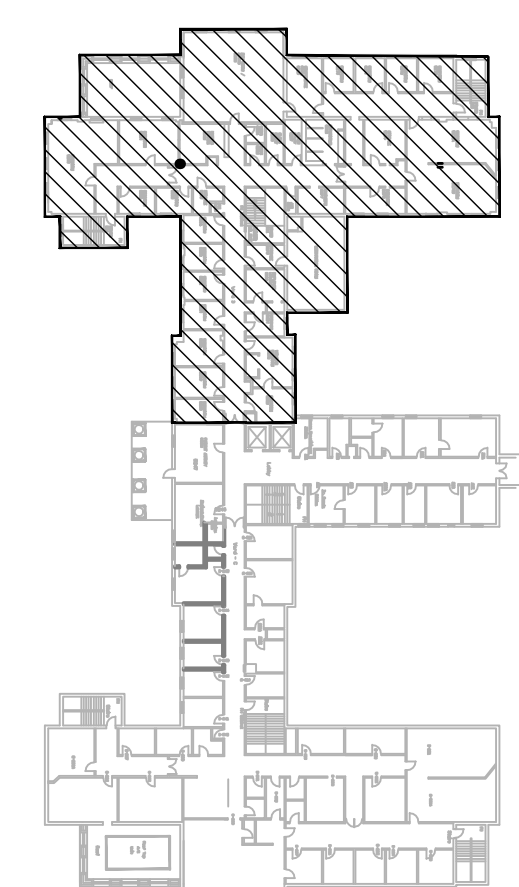

100% Submission	7/22/10
90% Submission	6/27/10
60% Submission	4/22/10
Revisions	Date

VA WESTERN NEW YORK HEALTHCARE SYSTEM
3495 BAILEY AVENUE
BUFFALO, NEW YORK 14215

URS
BUFFALO, NY
77 GOODELL ST
716-656-5636

stamp

CARDIOLOGY	DATE
INFECTION CONTROL	DATE

ENGINEERING MANAGER	DATE
CARELINE MANAGER	DATE

SAFETY OFFICER	DATE
CHIEF OF STAFF	DATE

Drawing Title	DATE
SECOND FLOOR ("WARD B") MECHANICAL DUCTWORK PLAN	DATE

Project Title	Building Number	Checked	Drawn
RENOVATION OF BLDG #1, 2ND FLOOR, B-WARD	1		

Date	Station No.
JULY 2, 2010 (UPDATED 10/07/10)	588

09-352 MH-202

Office of Facilities

Department of Veterans Affairs