

100% Submittal	7/02/10
90% Submittal	6/27/10
60% Submittal	4/22/10
Revisions	Date

VA WESTERN NEW YORK HEALTHCARE SYSTEM  
3495 BAILEY AVENUE  
BUFFALO, NEW YORK 14215

**URS** BUFFALO, NY,  
77 GOODELL ST  
716-856-5636

Architect




stomp

CARDIOLOGY	DATE	ENGINEERING MANAGER	DATE
INFECTION CONTROL	DATE	CARELINE MANAGER	DATE
SAFETY OFFICER	DATE	CHIEF OF STAFF	DATE

Drawing Title	
ELECTRICAL SINGLE LINE DIAGRAM	

Project Title	
RENOVATION OF BLDG. #1, 2ND FLOOR, B-WARD	
Building Number	Checked
	Drawn

Date	July 2, 2010 (UPDATED 10/07/10)
Section No.	528
09-352 E-500	

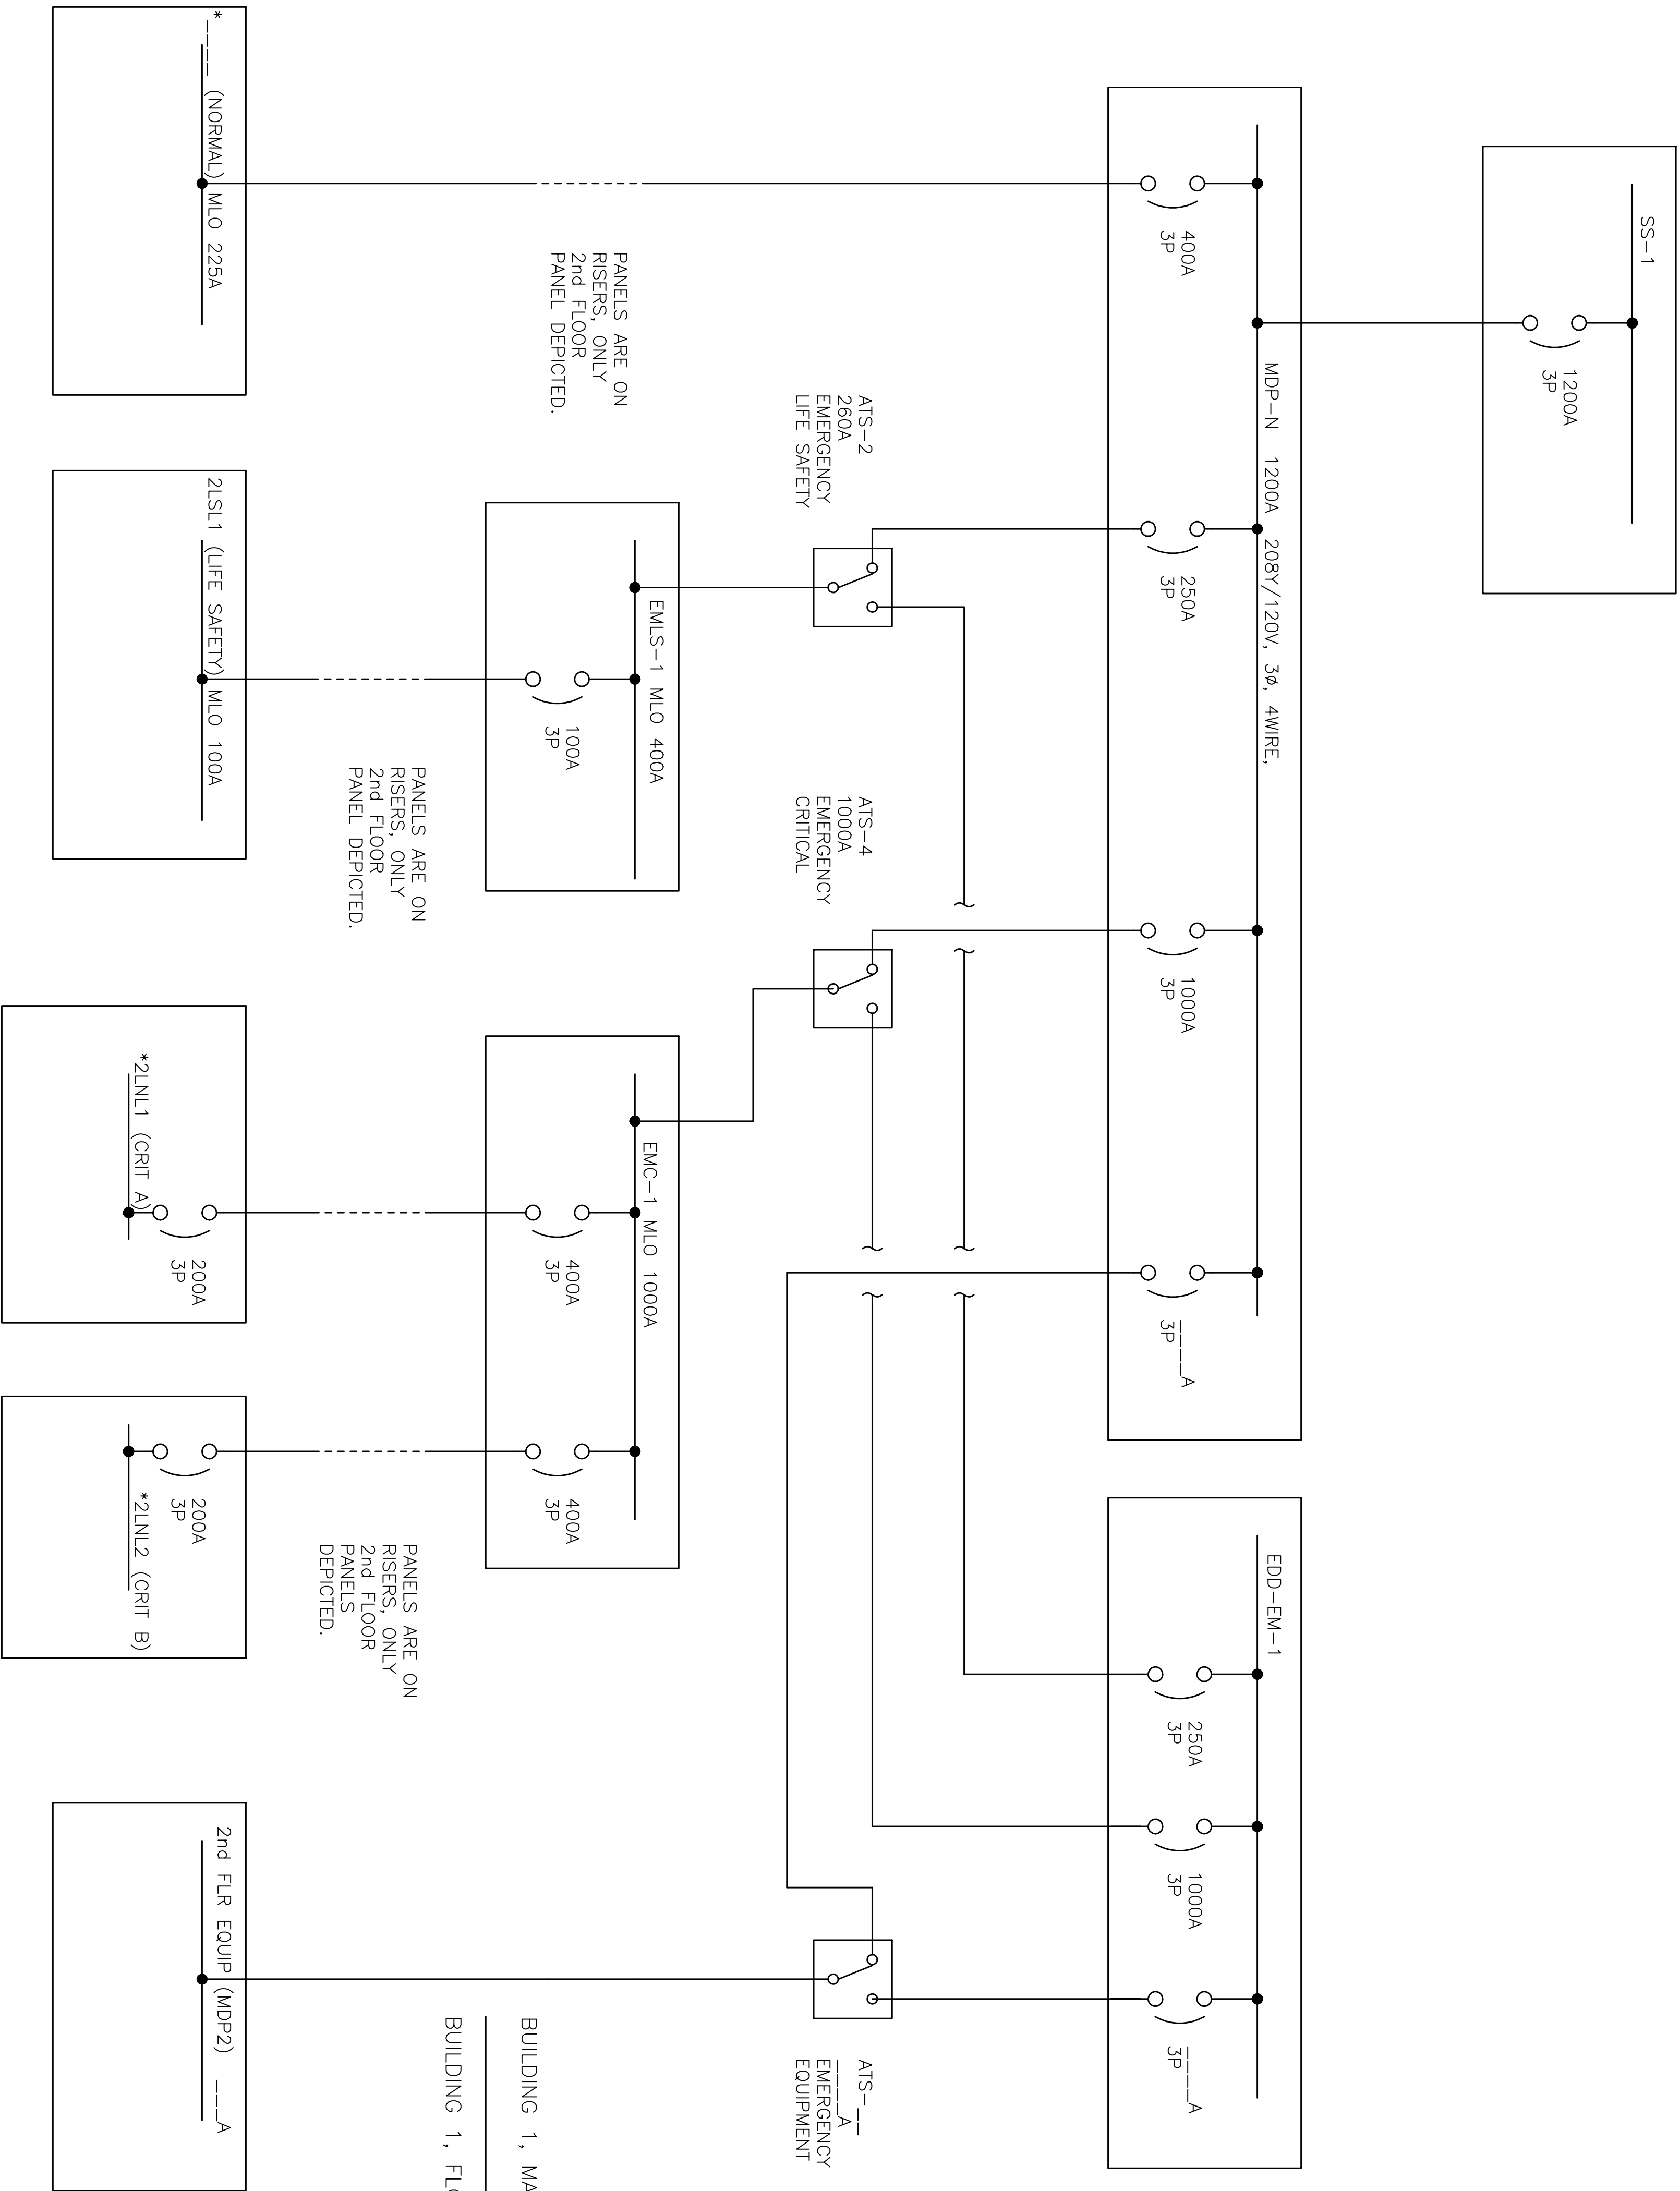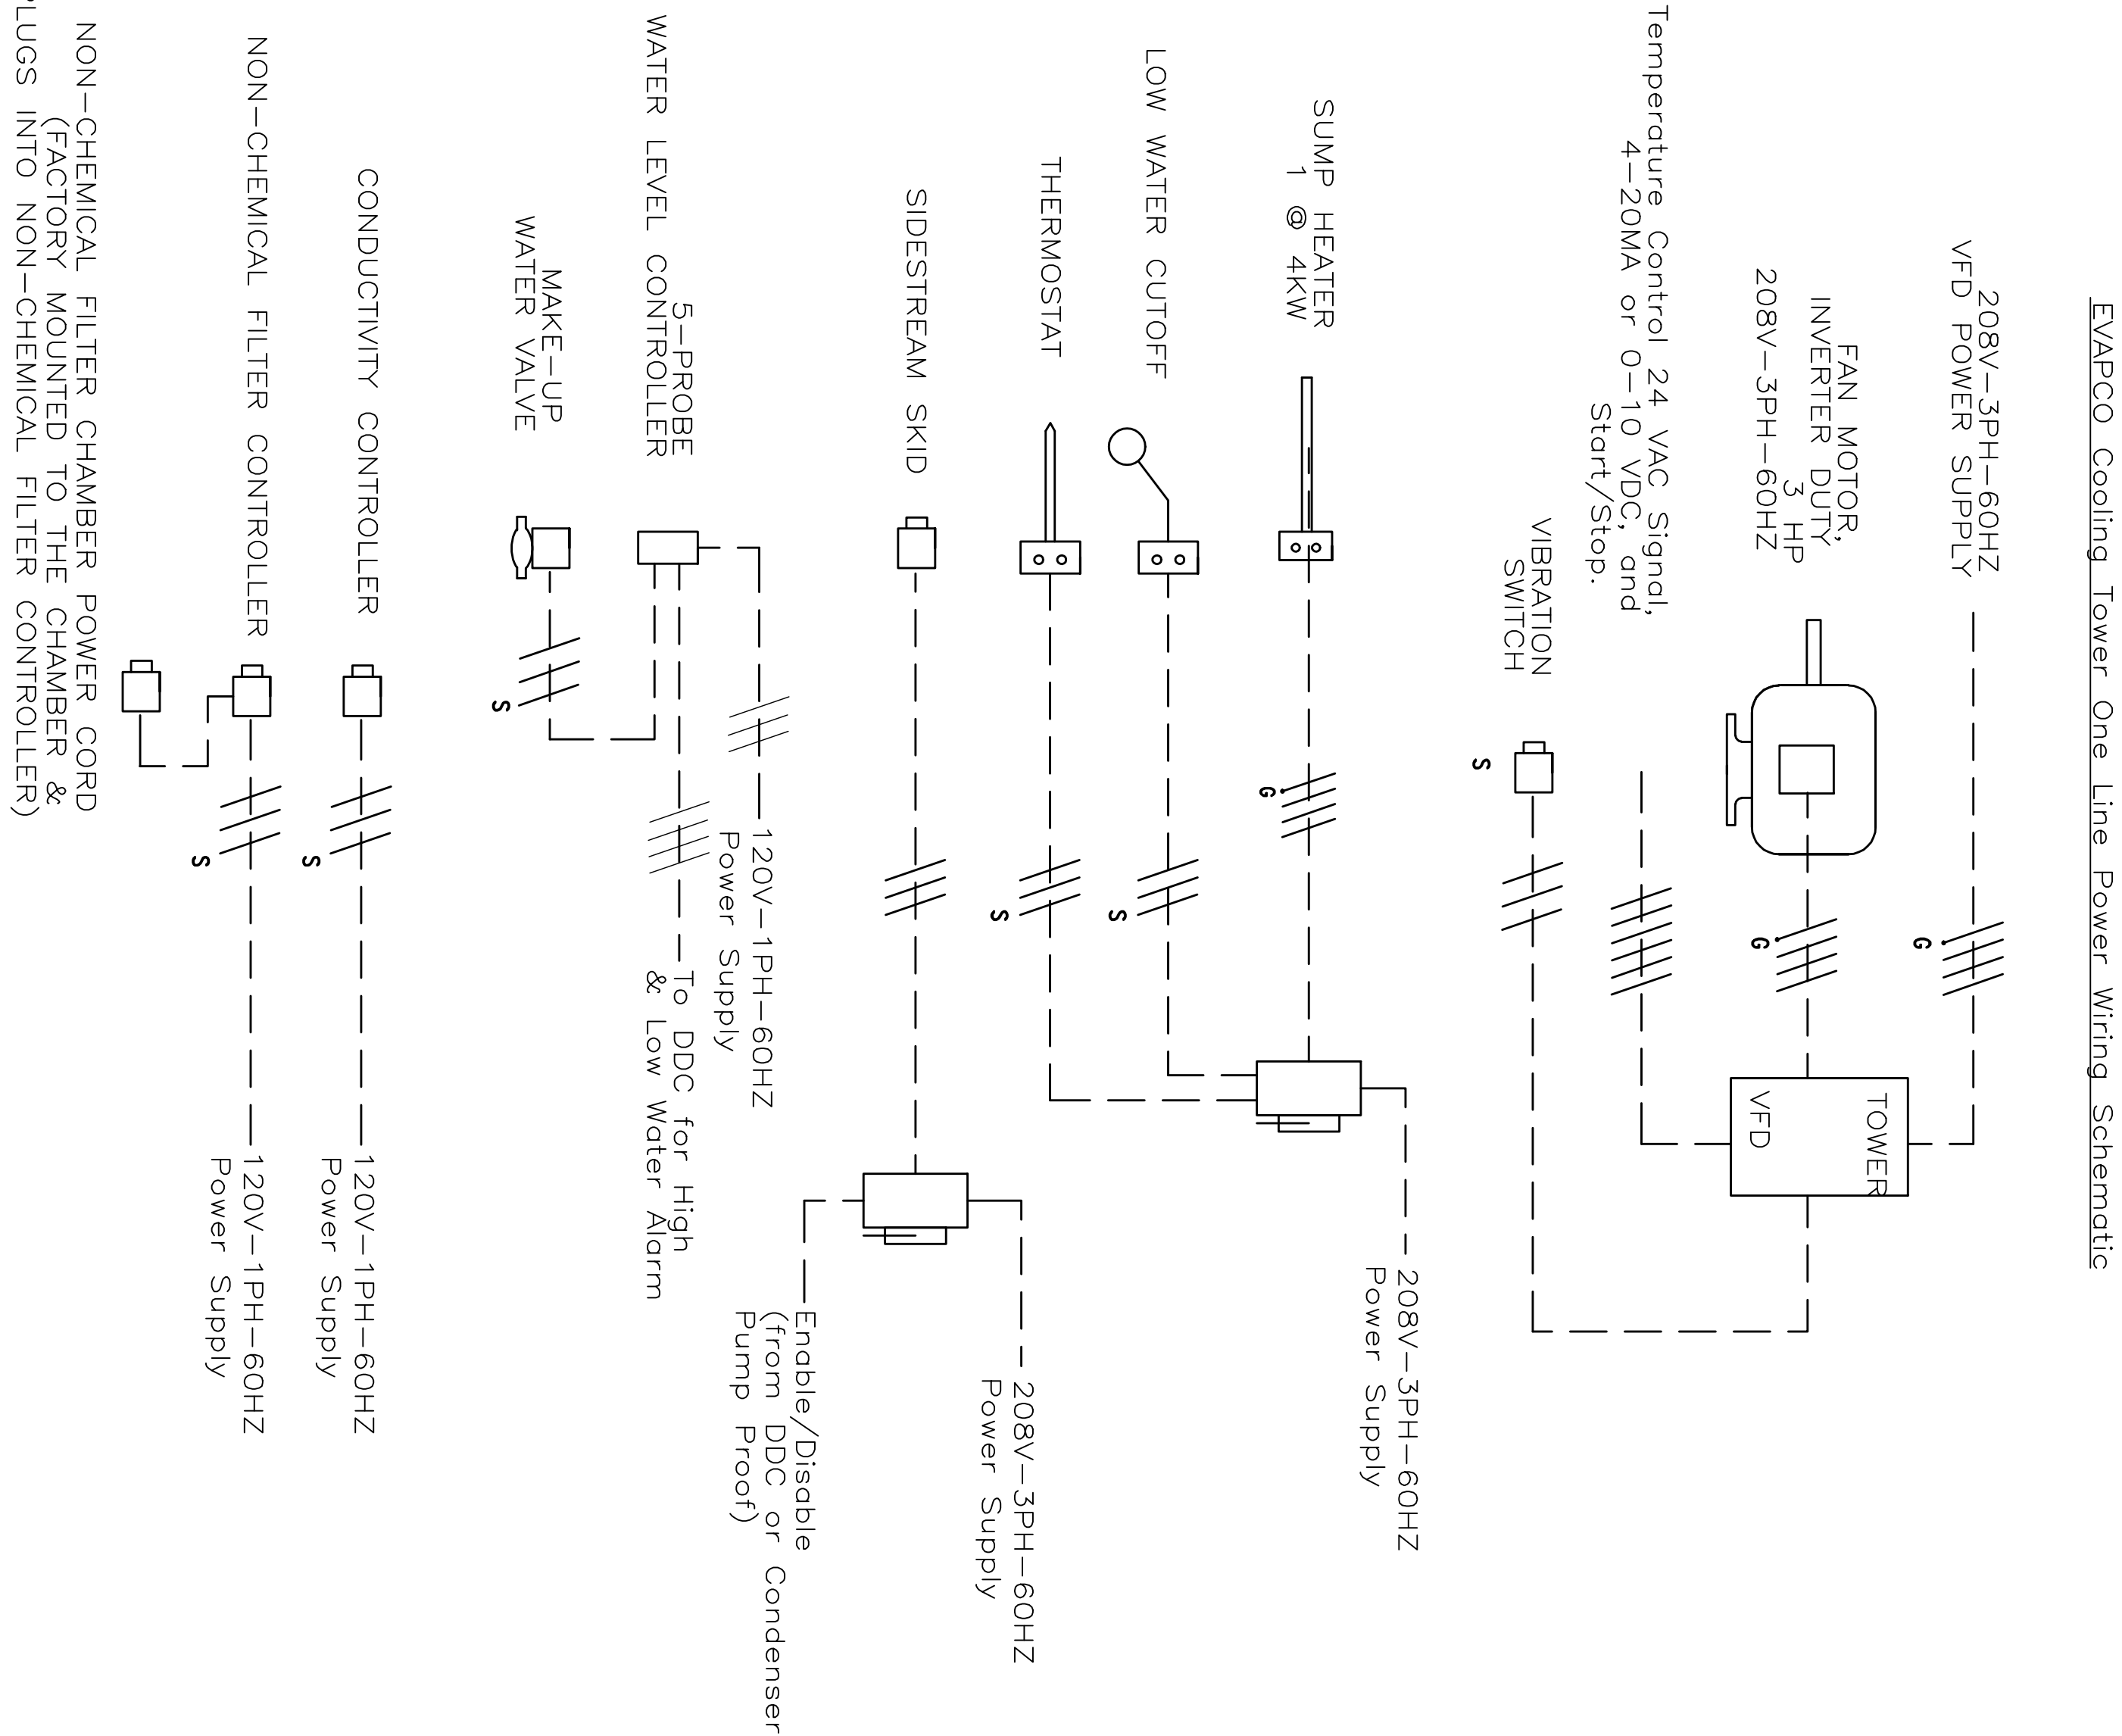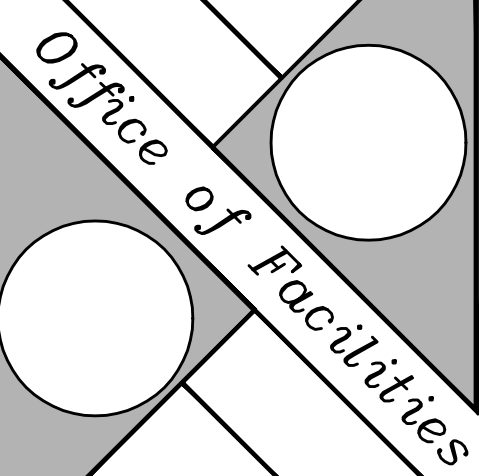

\* - THE NAMES OF THE PANELS SHALL BE  
CHANGED TO REFLECT THE FINAL PANEL  
DESIGNATIONS ONCE THE DISTRIBUTION  
SYSTEM UPGRADES ARE COMPLETE

#### GENERAL NOTES

A. THE BUILDING DISTRIBUTION ONE-LINE IS FOR  
REFERENCE. DISTRIBUTION SYSTEM WILL BE EXISTING.  
DEMOLITION WILL REMOVE EXISTING CIRCUITS BACK TO  
PANELS. ELECTRICAL CONTRACTOR IS TO VERIFY ALL  
EXISTING PANEL DESIGNATIONS, LOCATIONS AND CONNECT  
NEW DEVICES TO THE APPROPRIATE DRAWINGS. CONNECT  
NEW DEVICES TO THE APPROPRIATE SYSTEMS AND  
PANELS. COORDINATE WITH OWNER.