


Revisions		
100% Submission	7/02/10	
90% Submission	5/27/10	
60% Submission	4/28/10	

VA WESTERN NEW YORK HEALTHCARE SYSTEM  
3495 BAILEY AVENUE  
BUFFALO, NEW YORK 14215

Architect

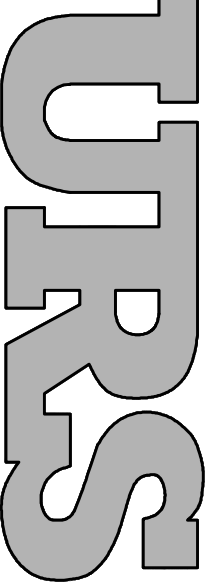

URS  
BUFFALO, NY  
77 GOODILL ST  
716-856-5636

stamp


CARDIOLOGY	DATE
INFECTION CONTROL	DATE
SAFETY OFFICER	DATE

ENGINEERING MANAGER	DATE
CARELINE MANAGER	DATE
CHIEF OF STAFF	DATE

Drawing Title	Project Title	Date
SECOND FLOOR ("WARD B") HVAC DEMOLITION PLAN	RENOVATION OF BLDG #1, 2ND FLOOR, B-WARD	JULY 2, 2010 (UPDATED 10/07/10)
MEDICAL CENTER DIRECTOR	Building Number	Section No.
ASSOCIATE MEDICAL CENTER DIRECTOR	1	328
DATE	Checked	Drawn



Location	DATE
V.A.M.C. BATAVIA, NEW YORK	09-352 MD-201

Office of Facilities



Department of  
Veterans Affairs

1 SECOND FLOOR PLAN  
1/8" = 1'-0"

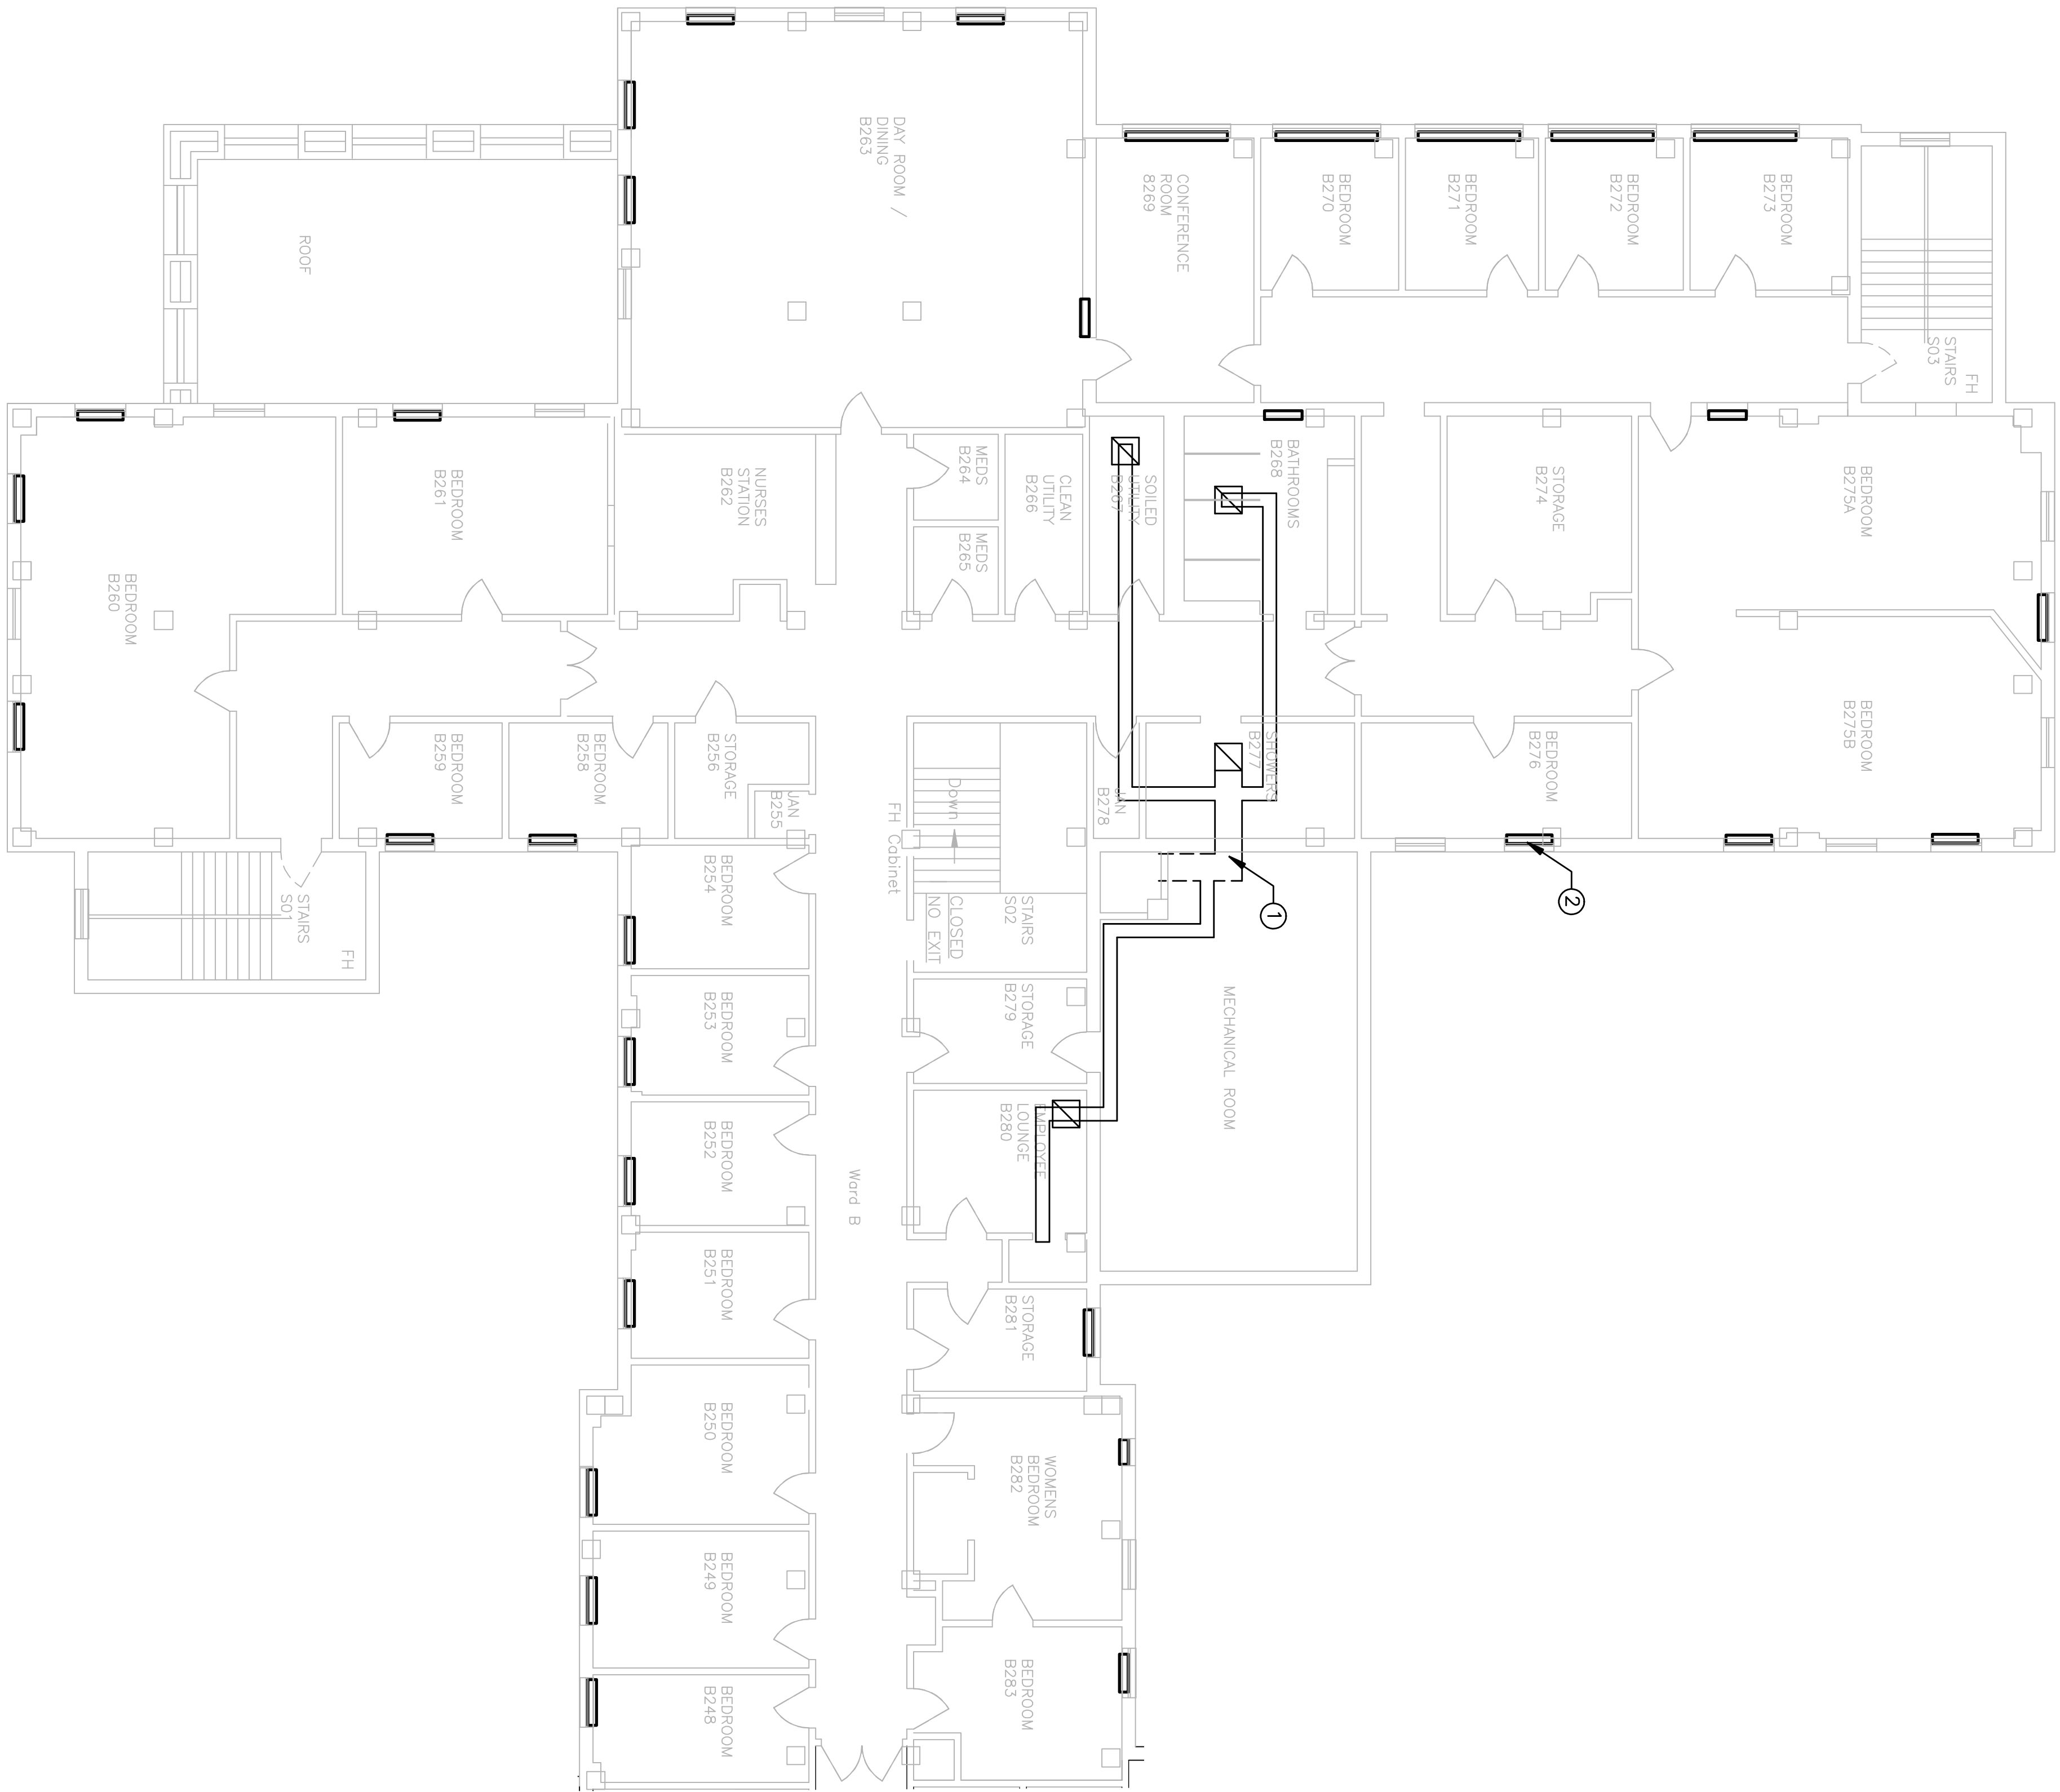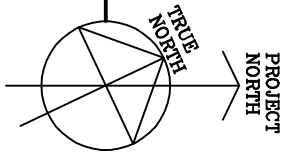

- DEMOLITION NOTES:**
- DISCONNECT AND REMOVE ALL EXISTING EXHAUST DUCTWORK TO CHASE. NOTE-ALL DUCTS SHOWN ARE DIAGRAMATIC.
  - DISCONNECT AND REMOVE STEAM RADIATORS AND ASSOCIATED TRAPS AND CONTROLS (TYP. OF ALL IN WARD B)
- GENERAL NOTES:**
- HVAC CONTRACTOR SHALL REINSULATE EXISTING STEAM LINES IN WARD 'B' WHERE ASBESTOS CONTAINING INSULATION WAS REMOVED BY THE ASBESTOS ABATEMENT CONTRACTOR. REFER TO ASBESTOS DRAWINGS LOCATIONS AND QUANTITIES.

