
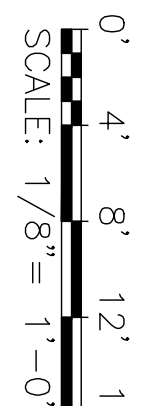


NOTES:
1. REFER TO ENLARGED PLAN ON DRAWING
M1001 FOR MECHANICAL ROOM DETAILS.

1 SECOND FLOOR PLAN
1/8" = 1'-0"

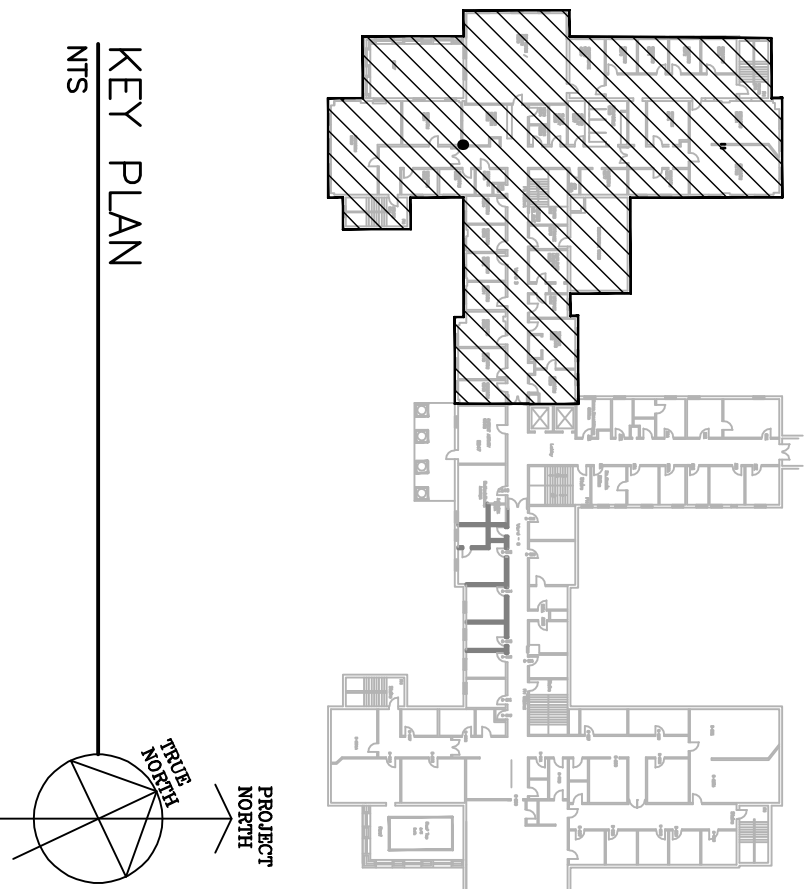

100% Submission 6/27/10		7/02/10	
60% Submission 4/22/10		6/27/10	
Revisions		Date	

VA WESTERN NEW YORK HEALTHCARE SYSTEM 3495 BAILEY AVENUE BUFFALO, NEW YORK 14215		URS BUFFALO, NY 77 GOODELL ST 716-856-5636		stamp	
--	--	--	--	-------	--

CARDIOLOGY	DATE	ENGINEERING MANAGER	DATE
INFECTION CONTROL	DATE	CARELINE MANAGER	DATE
SAFETY OFFICER	DATE	CHIEF OF STAFF	DATE

Drawing Title SECOND FLOOR ("WARD B") HVAC ZONE PLAN		Project Title RENOVATION OF BLDG #1, 2ND FLOOR, B-WARD		Date JULY 2, 2010 (UPDATED 10/07/10)	
MEDICAL CENTER DIRECTOR	DATE	Building Number 1	Checked	Drawn	Station No. 568
ASSOCIATE MEDICAL CENTER DIRECTOR	DATE	Location V.A.M.C. BATAVIA, NEW YORK	09-352 MH-201		

Office of Facilities		Department of Veterans Affairs	
----------------------	--	-----------------------------------	--