




1
CHILLED WATER COIL -
PIPING CONNECTIONS
NTS

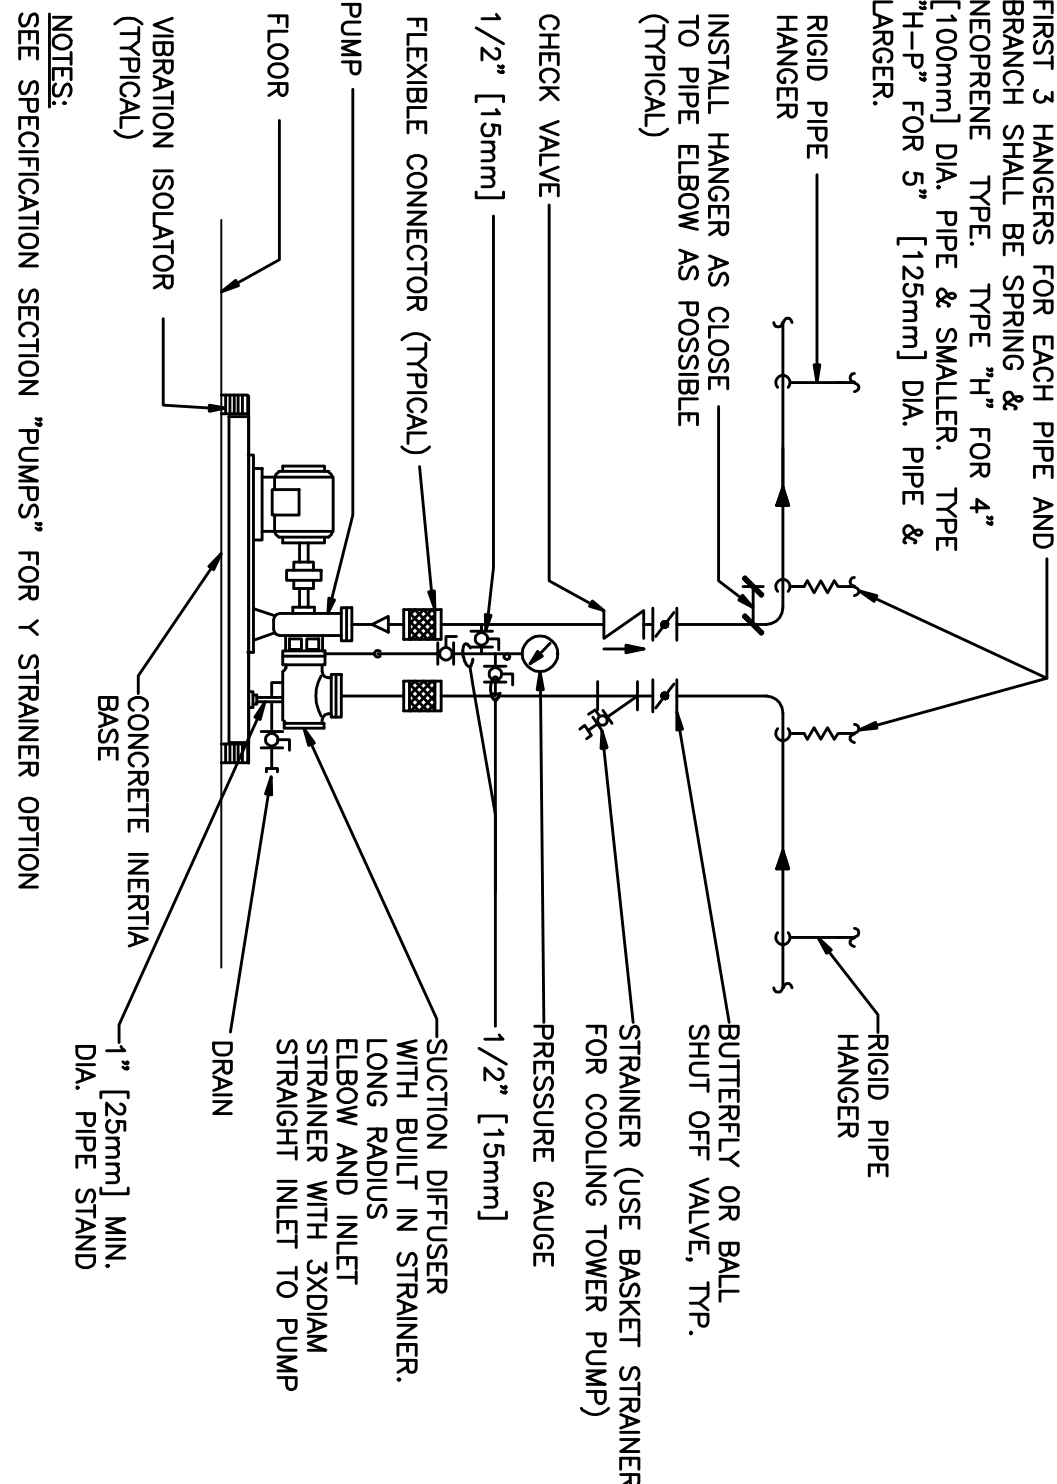

2
SINGLE SUCTION FLOOR-MOUNTED PUMPS -
CONNECTIONS WITH FLEXIBLE CONNECTORS
NTS

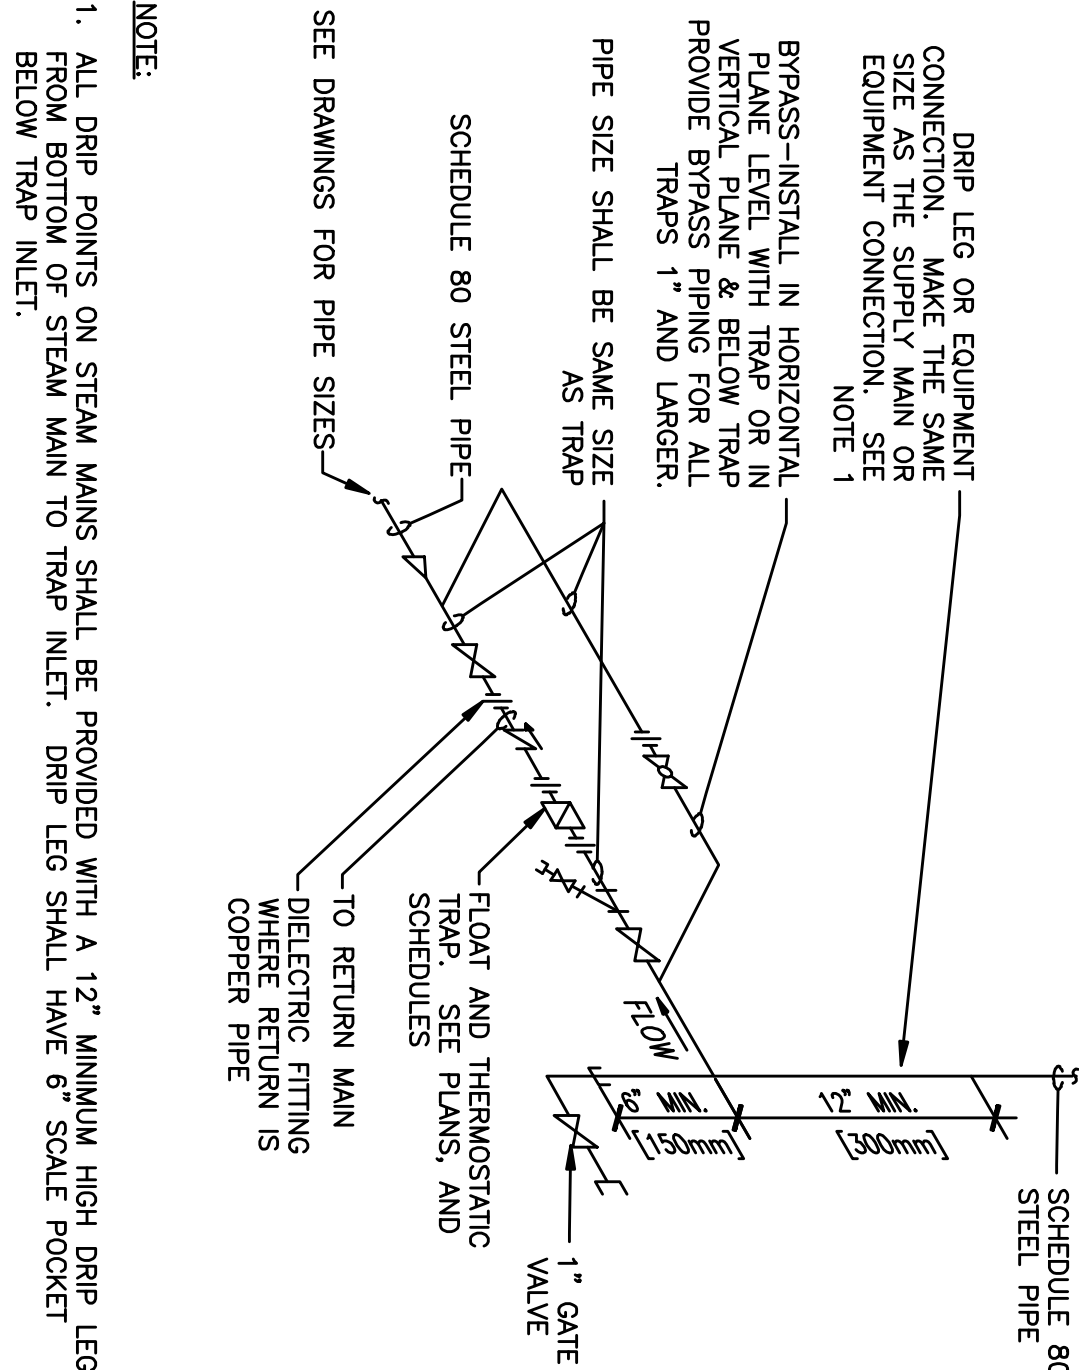

3
FLOAT AND THERMOSTATIC STEAM TRAP
ASSEMBLY
NTS

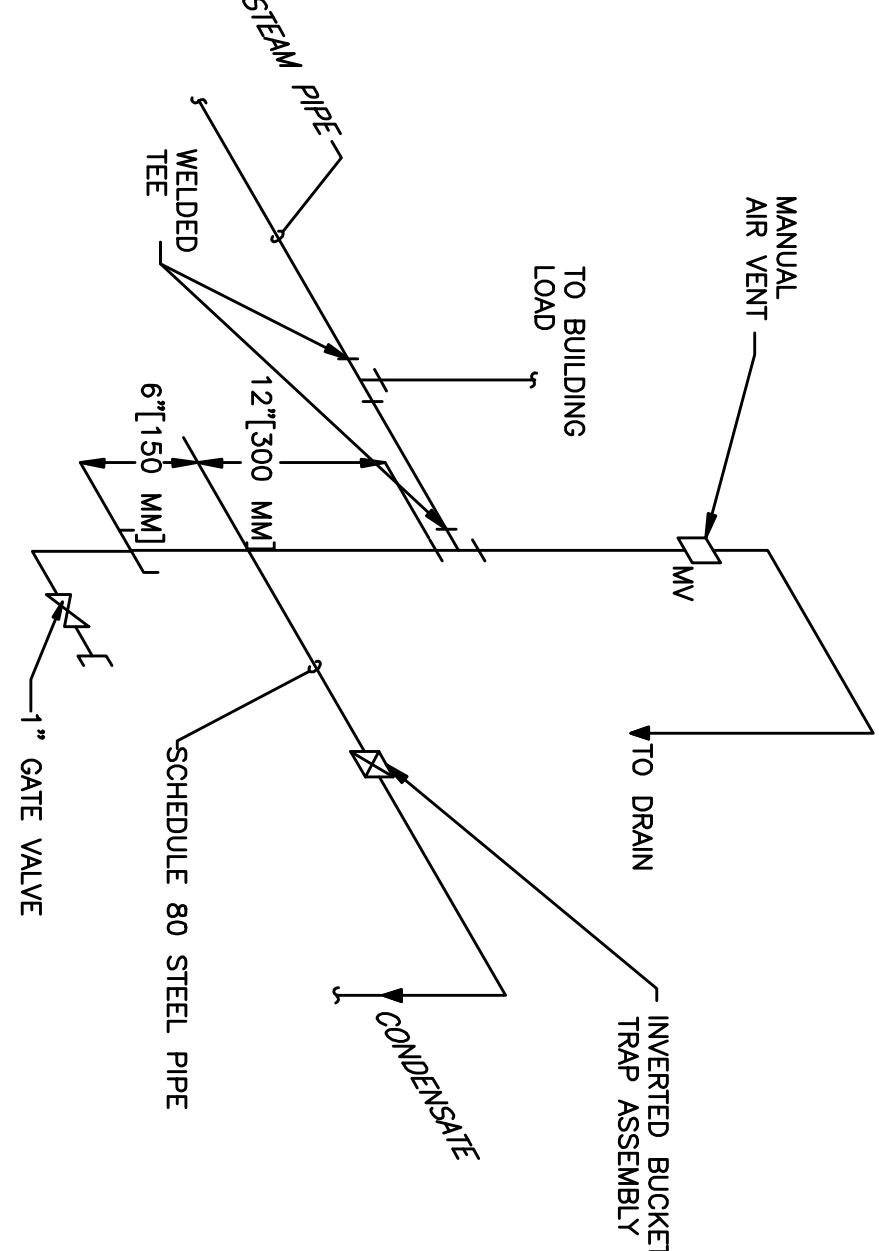

4
END OF STEAM LINE DRIP TRAP
NTS

Revisions		Date	
100% Submission	7/02/10		
90% Submission	5/27/10		
60% Submission	4/28/10		
VA WESTERN NEW YORK HEALTHCARE SYSTEM 3495 BAILEY AVENUE BUFFALO, NEW YORK 14215			
Architect		stamp	
SAFETY OFFICER		DATE	
CHIEF OF STAFF		DATE	
ASSOCIATE MEDICAL CENTER DIRECTOR		DATE	
Drawing Title		Project Title	
MECHANICAL DETAILS (SHEET 4 OF 8)		RENOVATION OF BLDG #1, 2ND FLOOR, B-WARD	
DATE		DATE	
CARELINE MANAGER		DATE	
DATE		DATE	
MEDICAL CENTER DIRECTOR		DATE	
DATE		DATE	
Location		Date	
V.A.M.C. BATAVIA, NEW YORK		JULY 2, 2010 (UPDATED 10/07/10)	
Building Number		Section No.	
1		528	
Checked		Date	
Drawn		09-352 MH-605	
Office of Facilities			
Department of Veterans Affairs			