
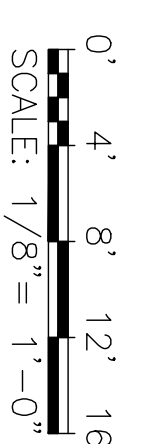
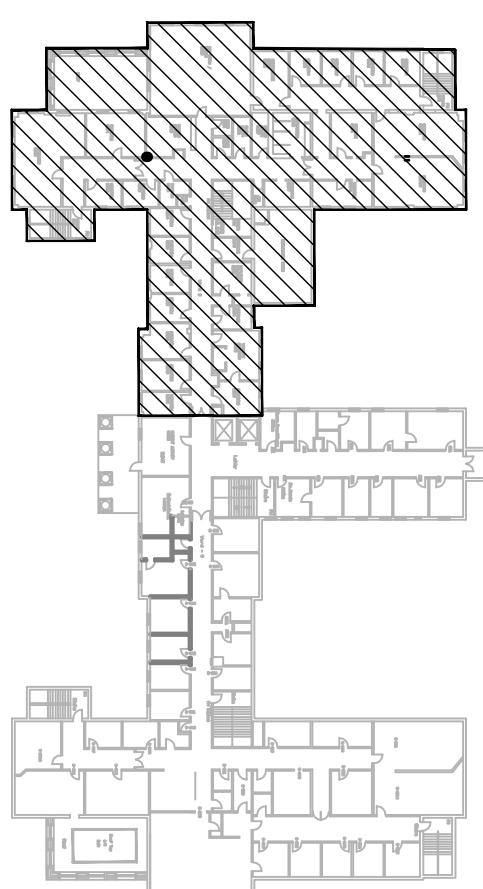
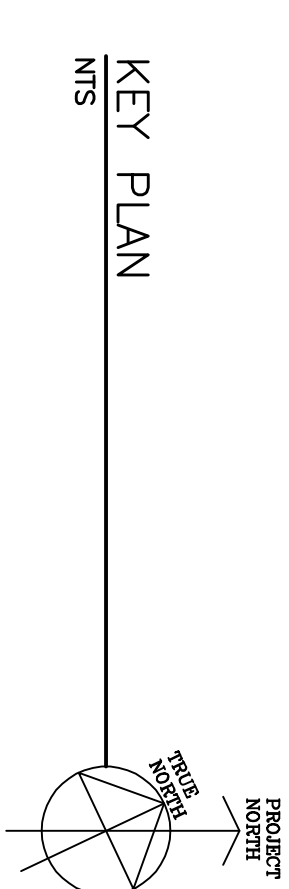


1 SECOND FLOOR PLAN
1/8" = 1'-0"

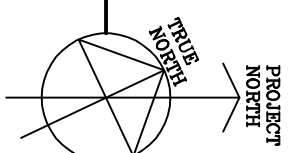

100% Submission	7/02/10
50% Submission	5/27/10
60% Submission	4/22/10
Revisions	Date

VA WESTERN NEW YORK HEALTHCARE SYSTEM
3495 BAILEY AVENUE
BUFFALO, NEW YORK 14215

URS
BUFFALO, NY,
77 GOODELL ST
716-856-5636

Architect


stamp

CARDIOLOGY	DATE	ENGINEERING MANAGER	DATE
INFECTION CONTROL	DATE	CARELINE MANAGER	DATE
SAFETY OFFICER	DATE	CHIEF OF STAFF	DATE

Drawing Title	SECOND FLOOR ("WARD B") MEDICAL GAS PLAN
MEDICAL CENTER DIRECTOR	DATE
ASSOCIATE MEDICAL CENTER DIRECTOR	DATE

<div>Project Title</div> <div>RENOVATION OF BLDG #1, 2ND FLOOR, B-WARD</div>		
<div>Building Number</div> <div>1</div>	<div>Checked</div>	<div>Drawn</div>
<div>Location</div> <div>V.A.M.C. BATAVIA, NEW YORK</div>		

Date	JULY 2, 2010 (UPDATED 10/07/10)
Station No.	528
09-352 PL-204	

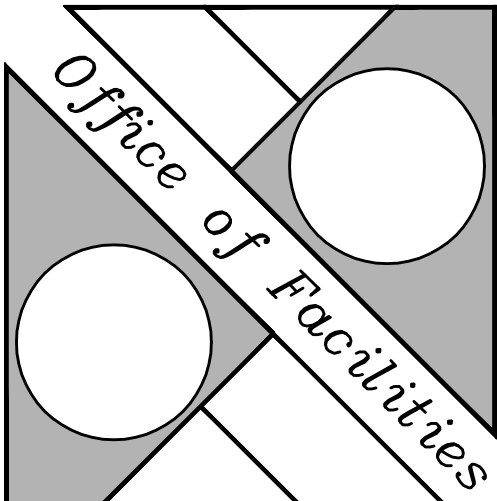 Department of
Veterans Affairs