




1 BACKFLOW PREVENTER PIPING DETAIL FOR HVAC MAKEUP

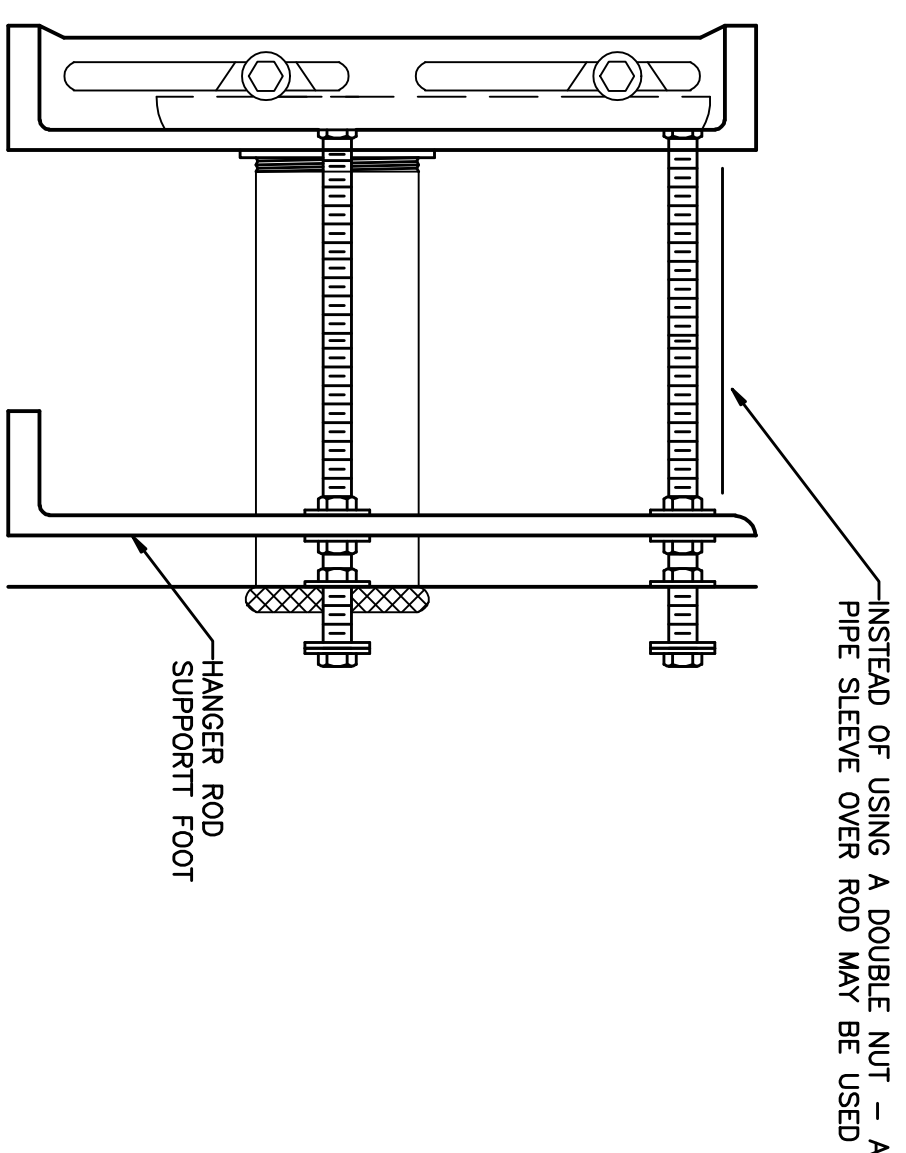

2 INSTALLATION OF HANGER SUPPORT FOOT

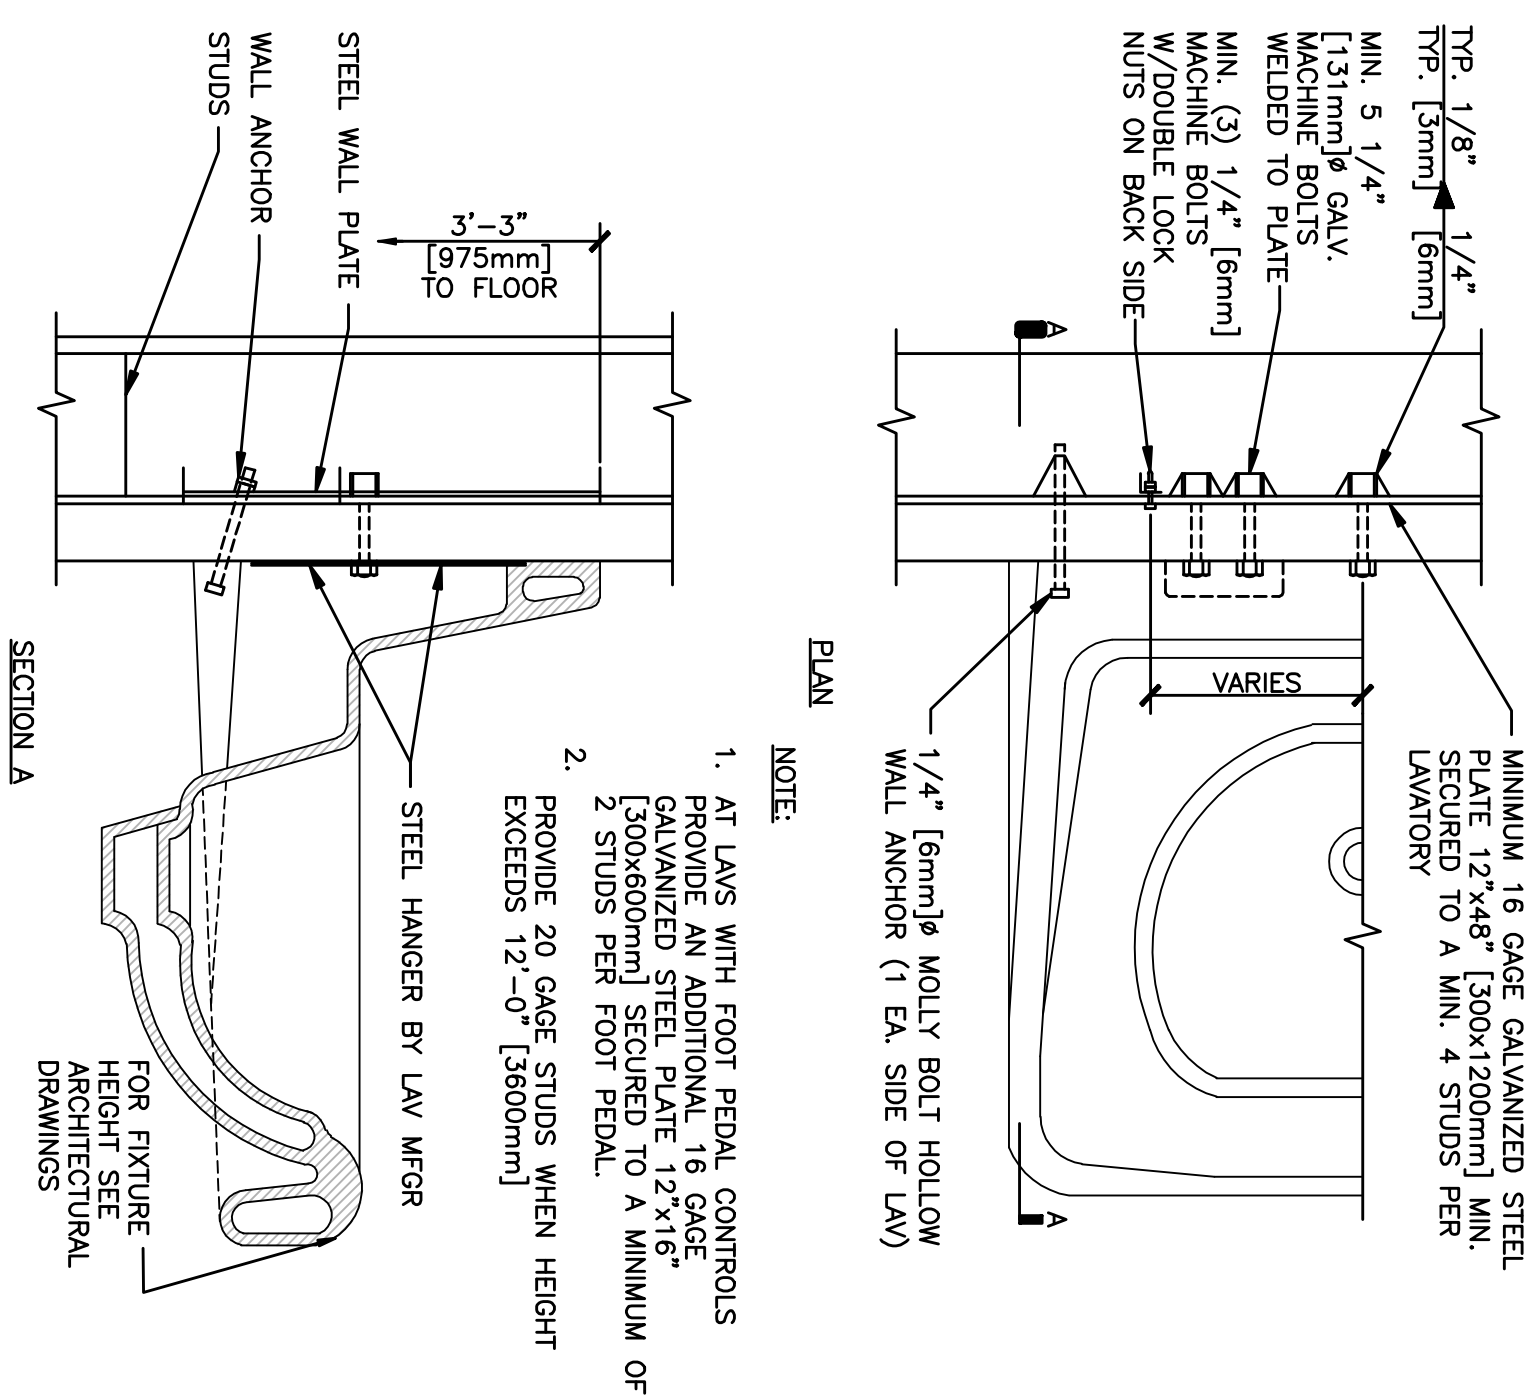

4 LAVATORY MOUNTING DETAIL
NTS

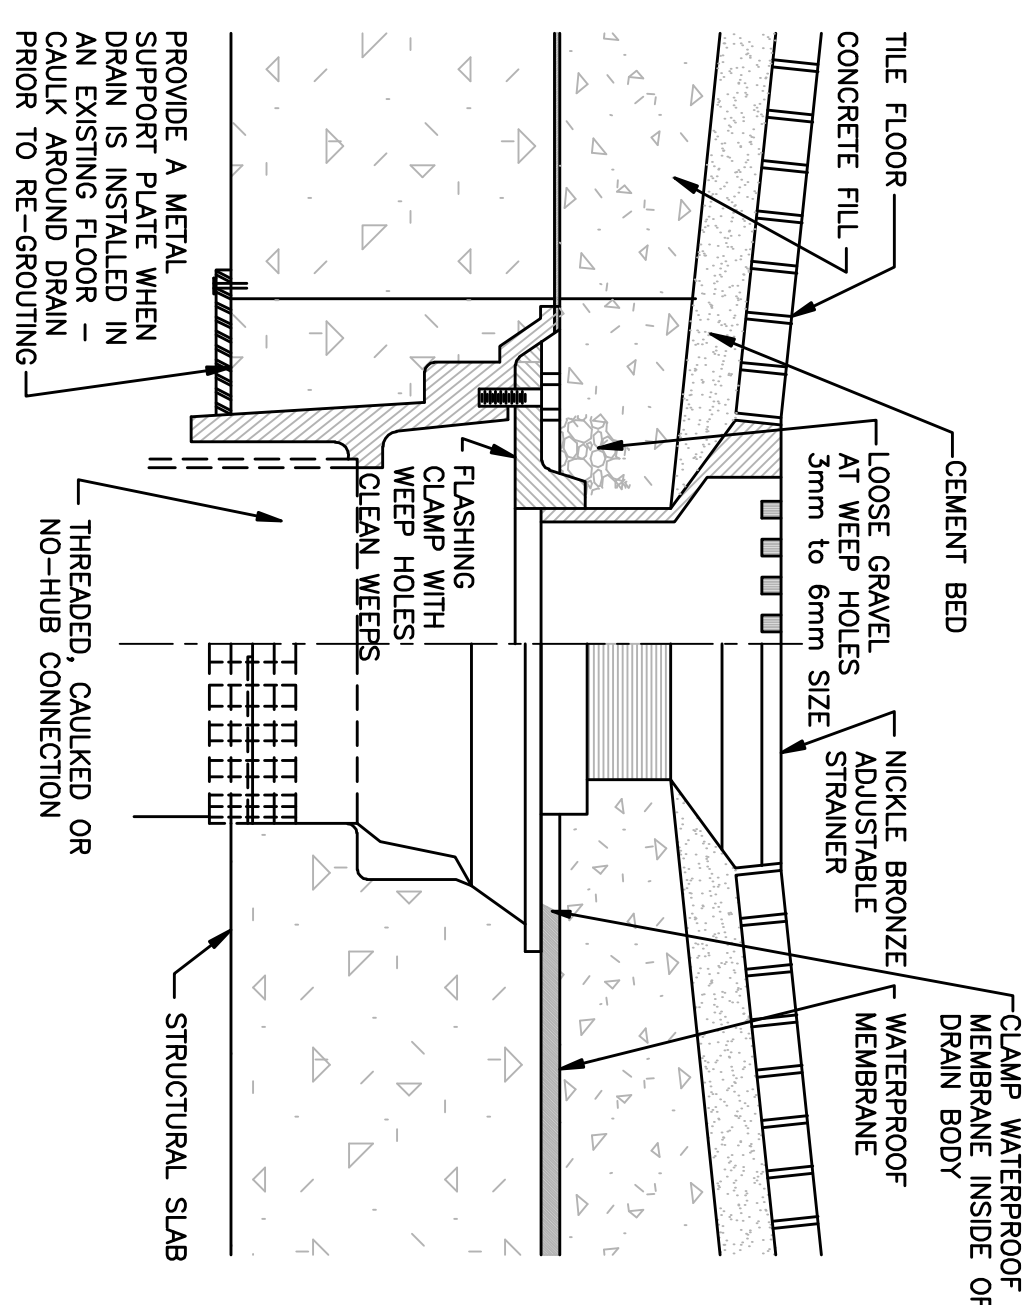

3 TYPE "C" FLOOR DRAIN DETAIL

Revisions	Date
100% Submission	7/02/10
90% Submission	5/27/10
60% Submission	4/22/10

VA WESTERN NEW YORK HEALTHCARE SYSTEM
3495 BAILEY AVENUE
BUFFALO, NEW YORK 14215

URS
BUFFALO, NY.,
77 GOODELL ST
716-856-5636

stamp

CARDIOLOGY	DATE	ENGINEERING MANAGER	DATE
INFECTION CONTROL	DATE	CARELINE MANAGER	DATE
SAFETY OFFICER	DATE	CHIEF OF STAFF	DATE

Drawing Title	
PLUMBING DETAILS (SHEET 1 OF 2)	
MEDICAL CENTER DIRECTOR	DATE
ASSOCIATE MEDICAL CENTER DIRECTOR	DATE

Project Title	RENOVATION OF BLDG. #1, 2ND FLOOR, B-WARD		
Building Number 1	Chested	Drawn	
Location V.A.M.C. BATAVIA, NEW YORK			

Date	JULY 2, 2010 (UPDATED 10/07/10)
Station No.	528
	09-352 PL-601

