



1 P-103 WATER CLOSET DETAIL  
NTS

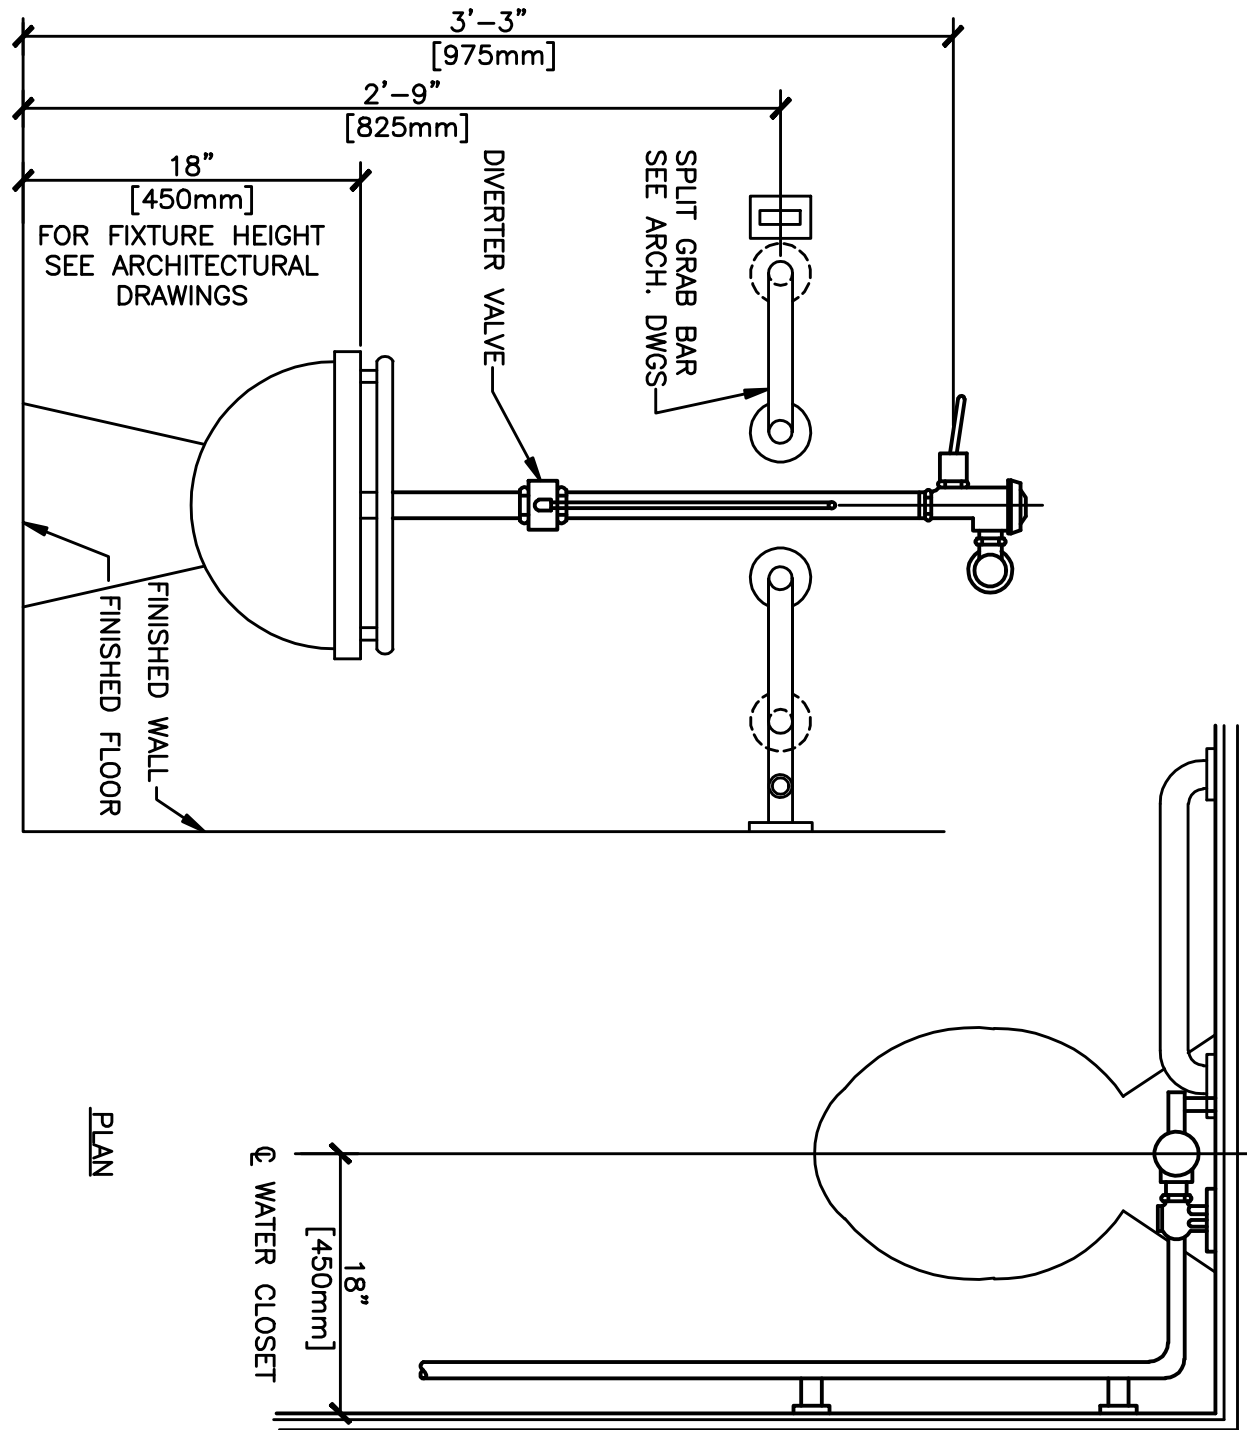


2 P-101 WATER CLOSET DETAIL  
NTS


NOTE:  
P-201 PATIENT SHOWERS SHOWN IN BARRIAC BARROOMS  
BARRIAC BARROOMS ARE EQUIPPED WITH SHOWER  
HEAD, SHOWER CONTROLS, AND A HOSE OF SUFFICIENT  
LENGTH TO REACH ALL PORTIONS OF THE ROOM.

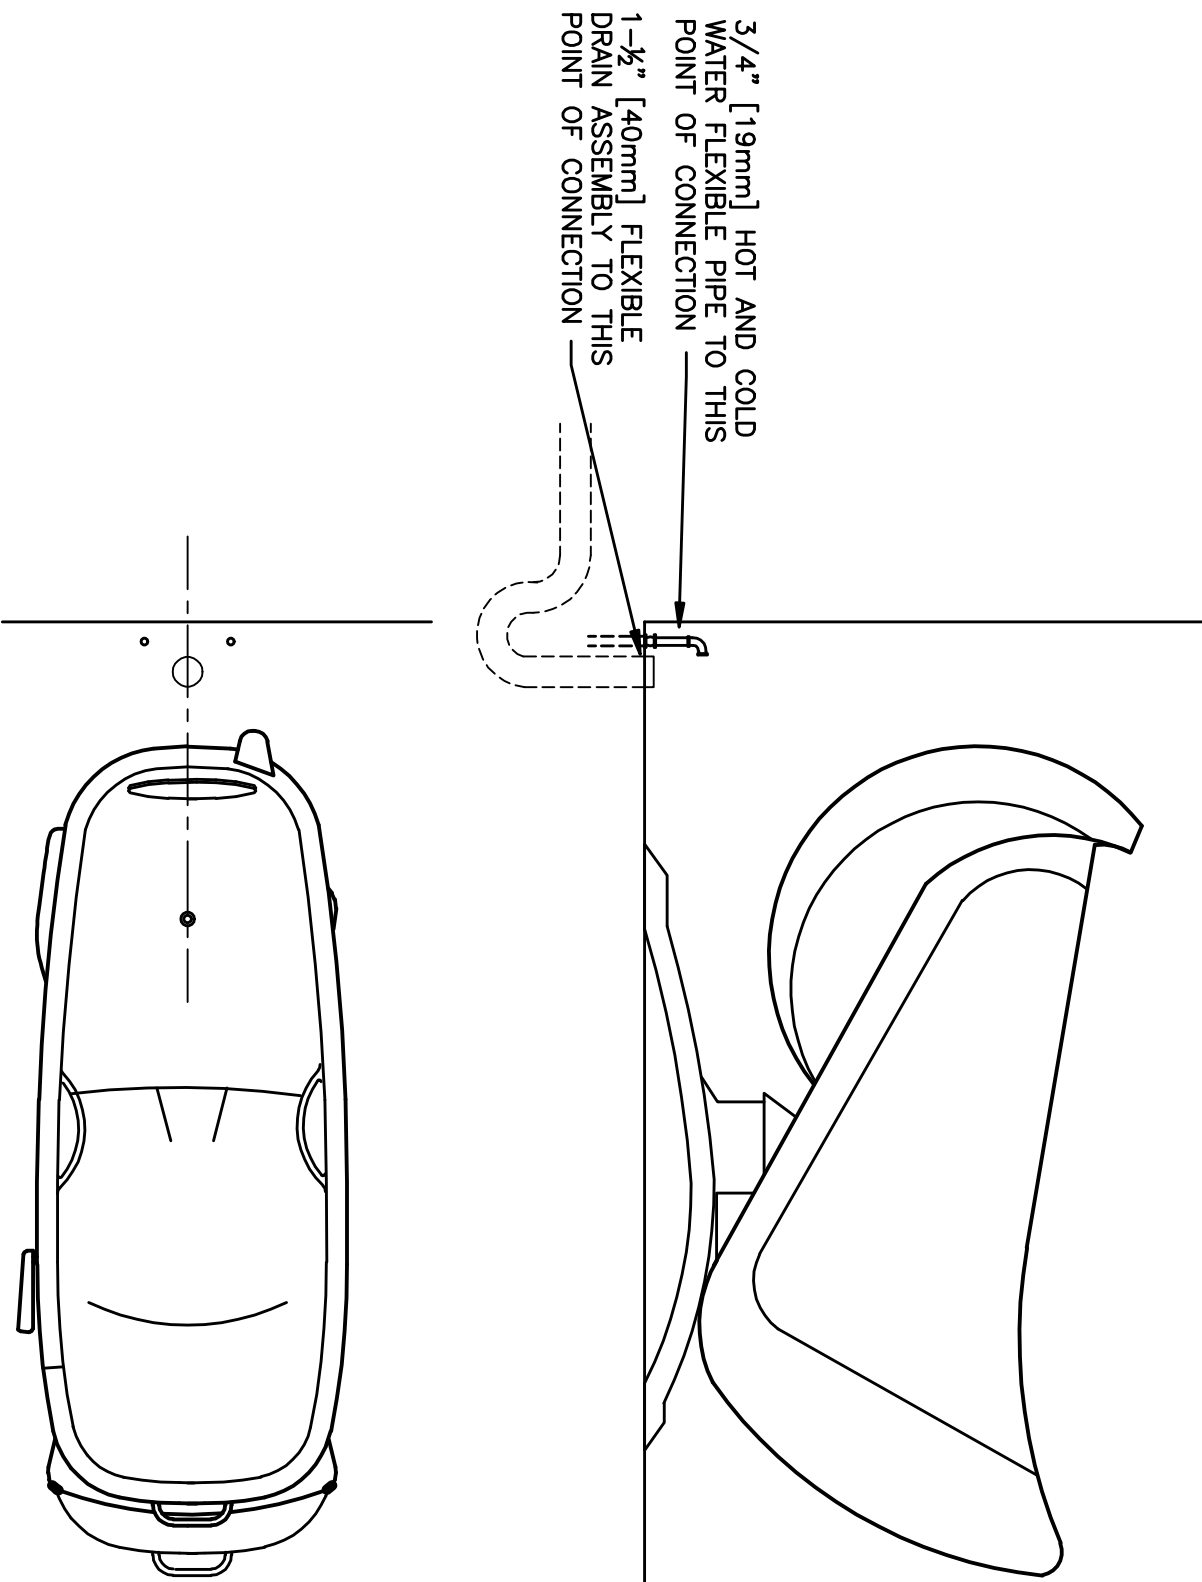


3 CONGREGATE BATH TUB ROUGH-IN  
NTS

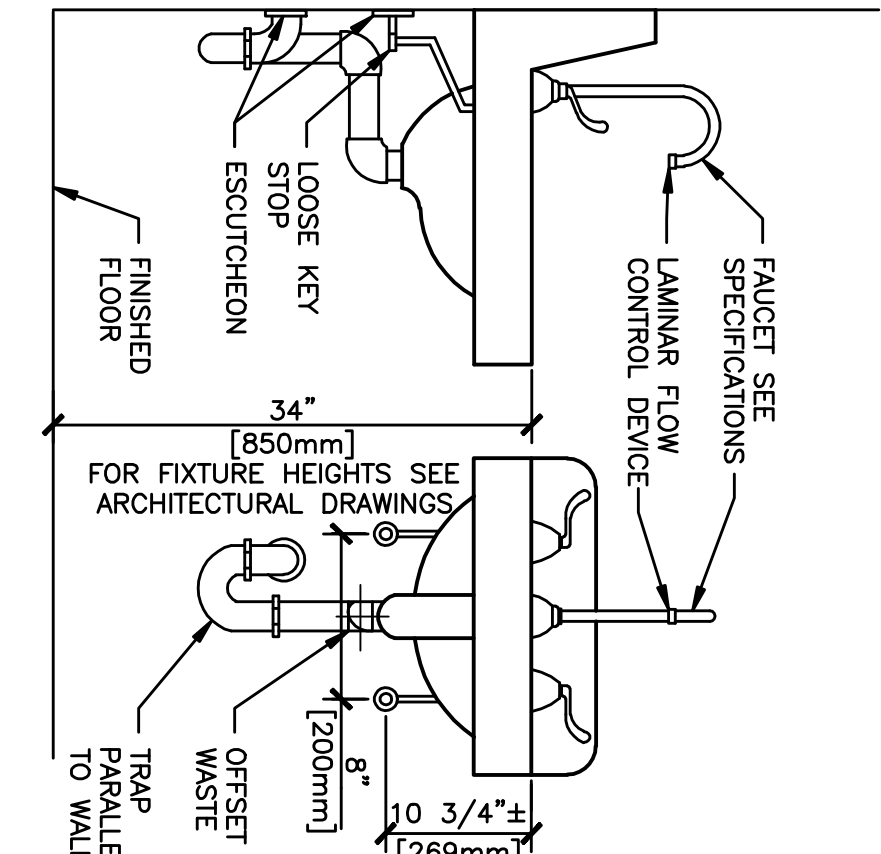

4 TYPICAL WHEELCHAIR LAVATORY DETAIL  
NTS

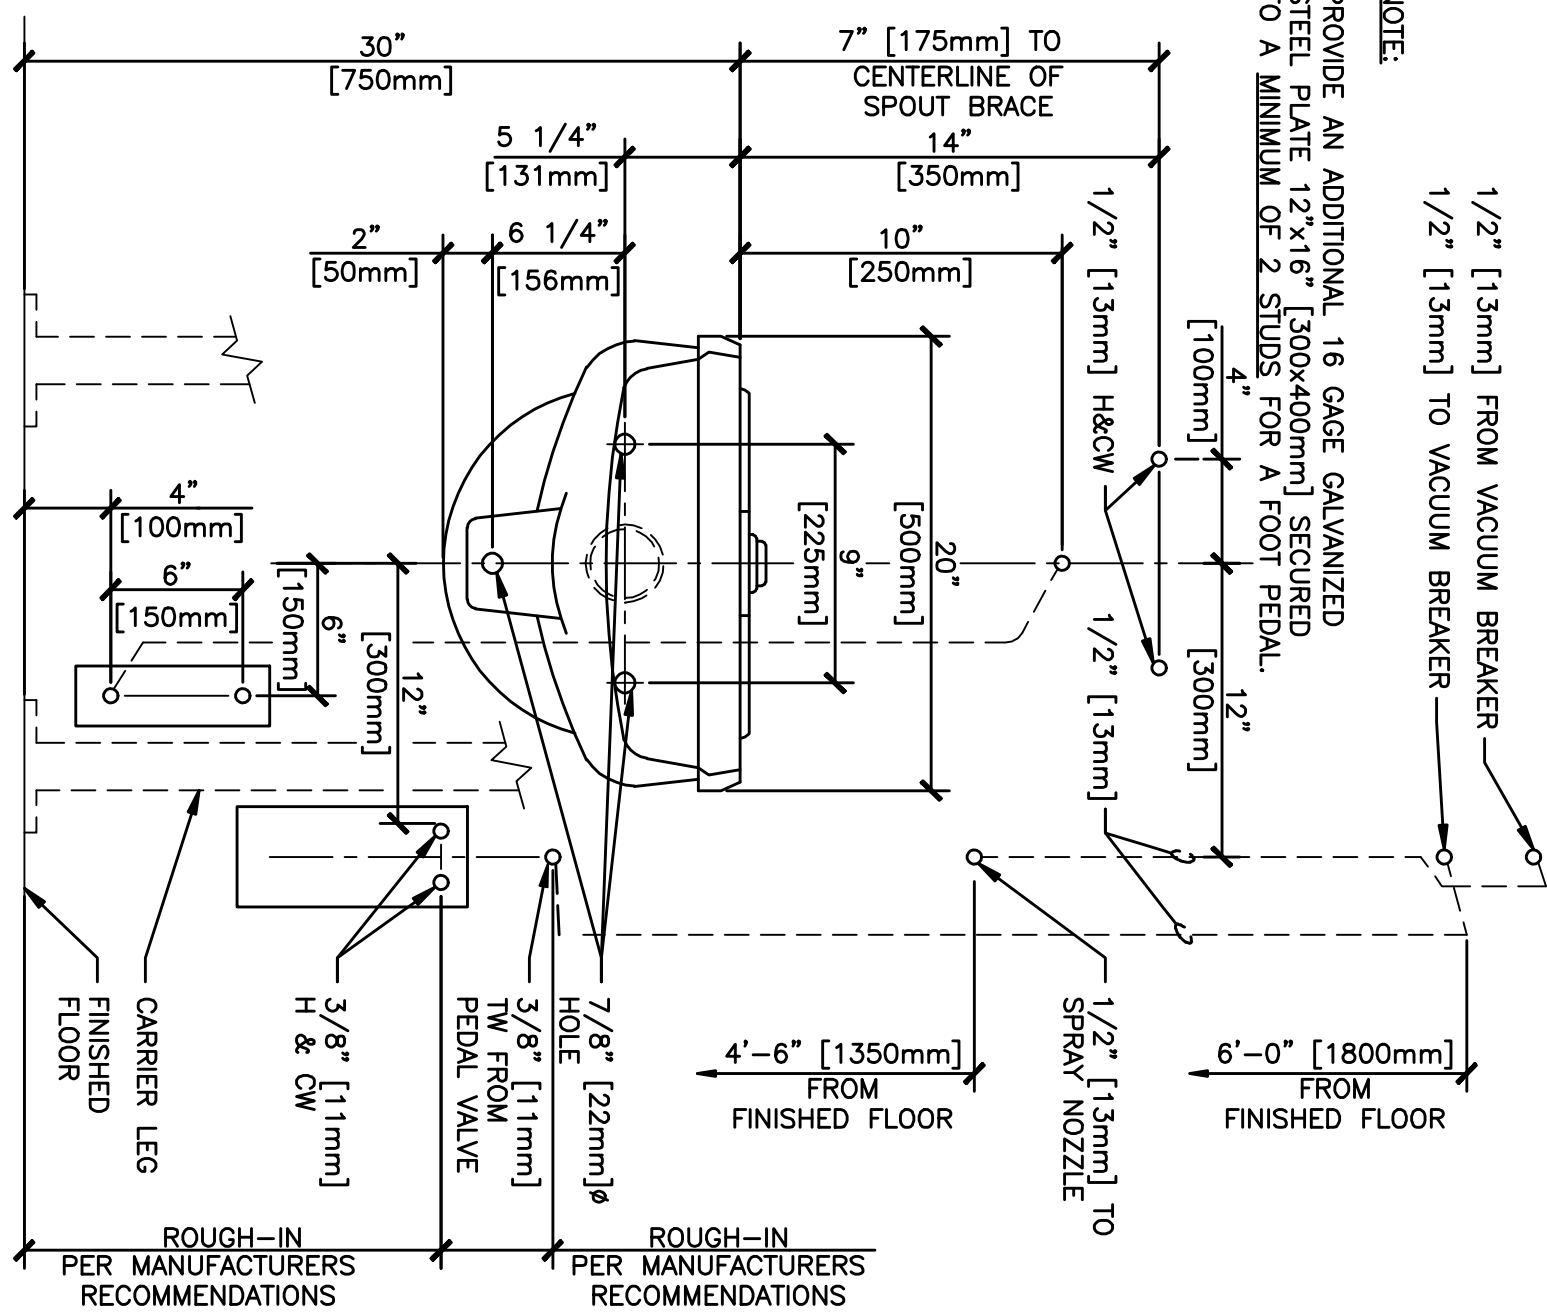

5 P-505 CLINIC SERVICE SINK ROUGH-IN DETAIL  
NTS

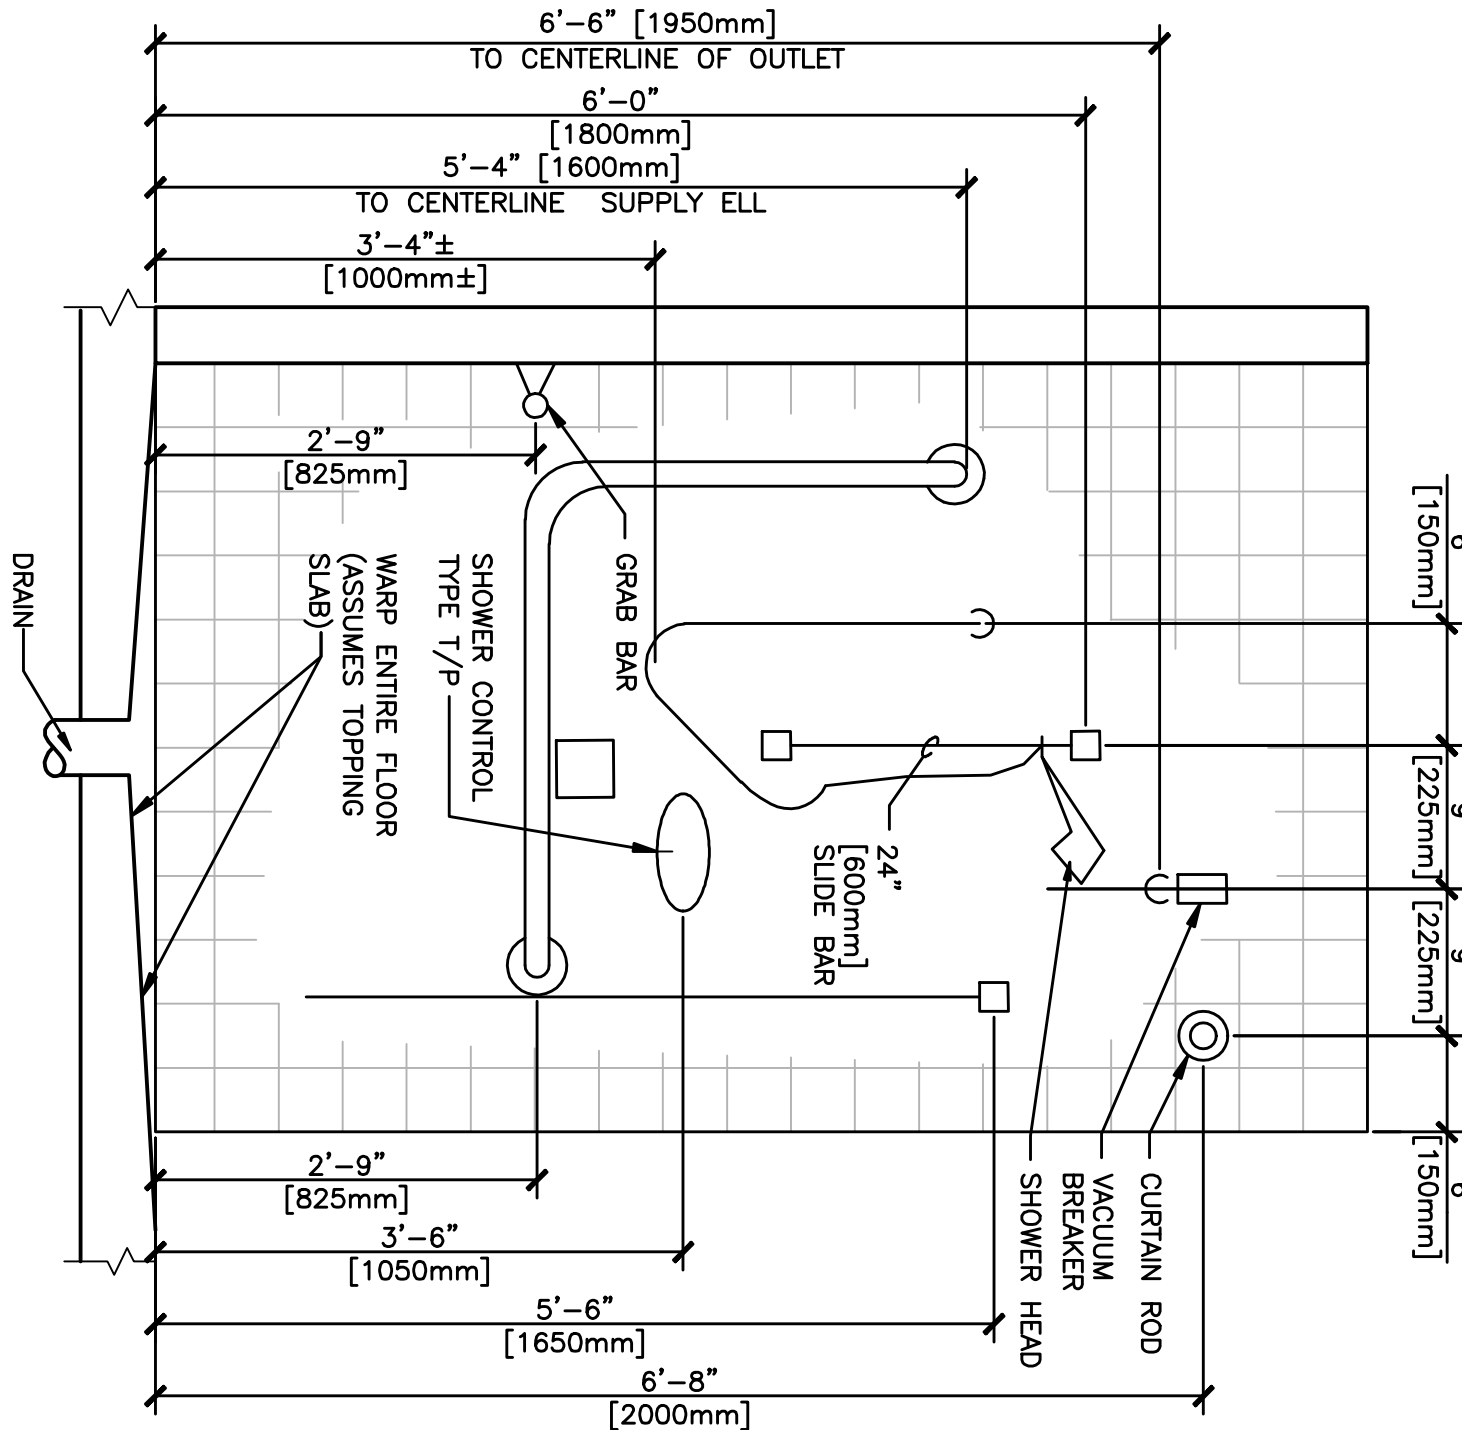

6 P-701 PATIENT SHOWER  
NTS

Revisions		
100% Submission	7/02/10	
90% Submission	5/27/10	
60% Submission	4/28/10	
Date		

VA WESTERN NEW YORK HEALTHCARE SYSTEM  
3495 BAILEY AVENUE  
BUFFALO, NEW YORK 14215

**URS**  
BUFFALO, NY  
77 GOODELL ST  
716-856-5636

Architect

stamp


CARDIOLOGY	DATE
INFECTION CONTROL	DATE
SAFETY OFFICER	DATE

ENGINEERING MANAGER	DATE
CARELINE MANAGER	DATE
CHIEF OF STAFF	DATE

Drawing Title	DATE
PLUMBING DETAILS (SHEET 2 OF 2)	DATE
MEDICAL CENTER DIRECTOR	DATE
ASSOCIATE MEDICAL CENTER DIRECTOR	DATE

Project Title	Building Number	Checked	Drawn
RENOVATION OF BLDG #1, 2ND FLOOR, B-WARD	1		
Location	VA M.C. BATHYIA, NEW YORK		

Date	July 2, 2010 (UPDATED 10/07/10)
Section No.	528
09-352 PL-602	

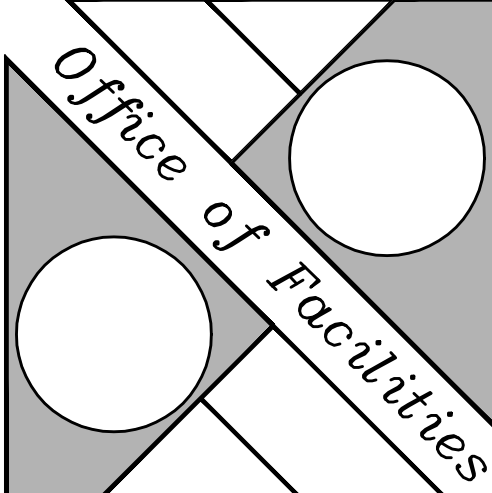

Department of Veterans Affairs