


# SAINT CLOUD, MINNESOTA

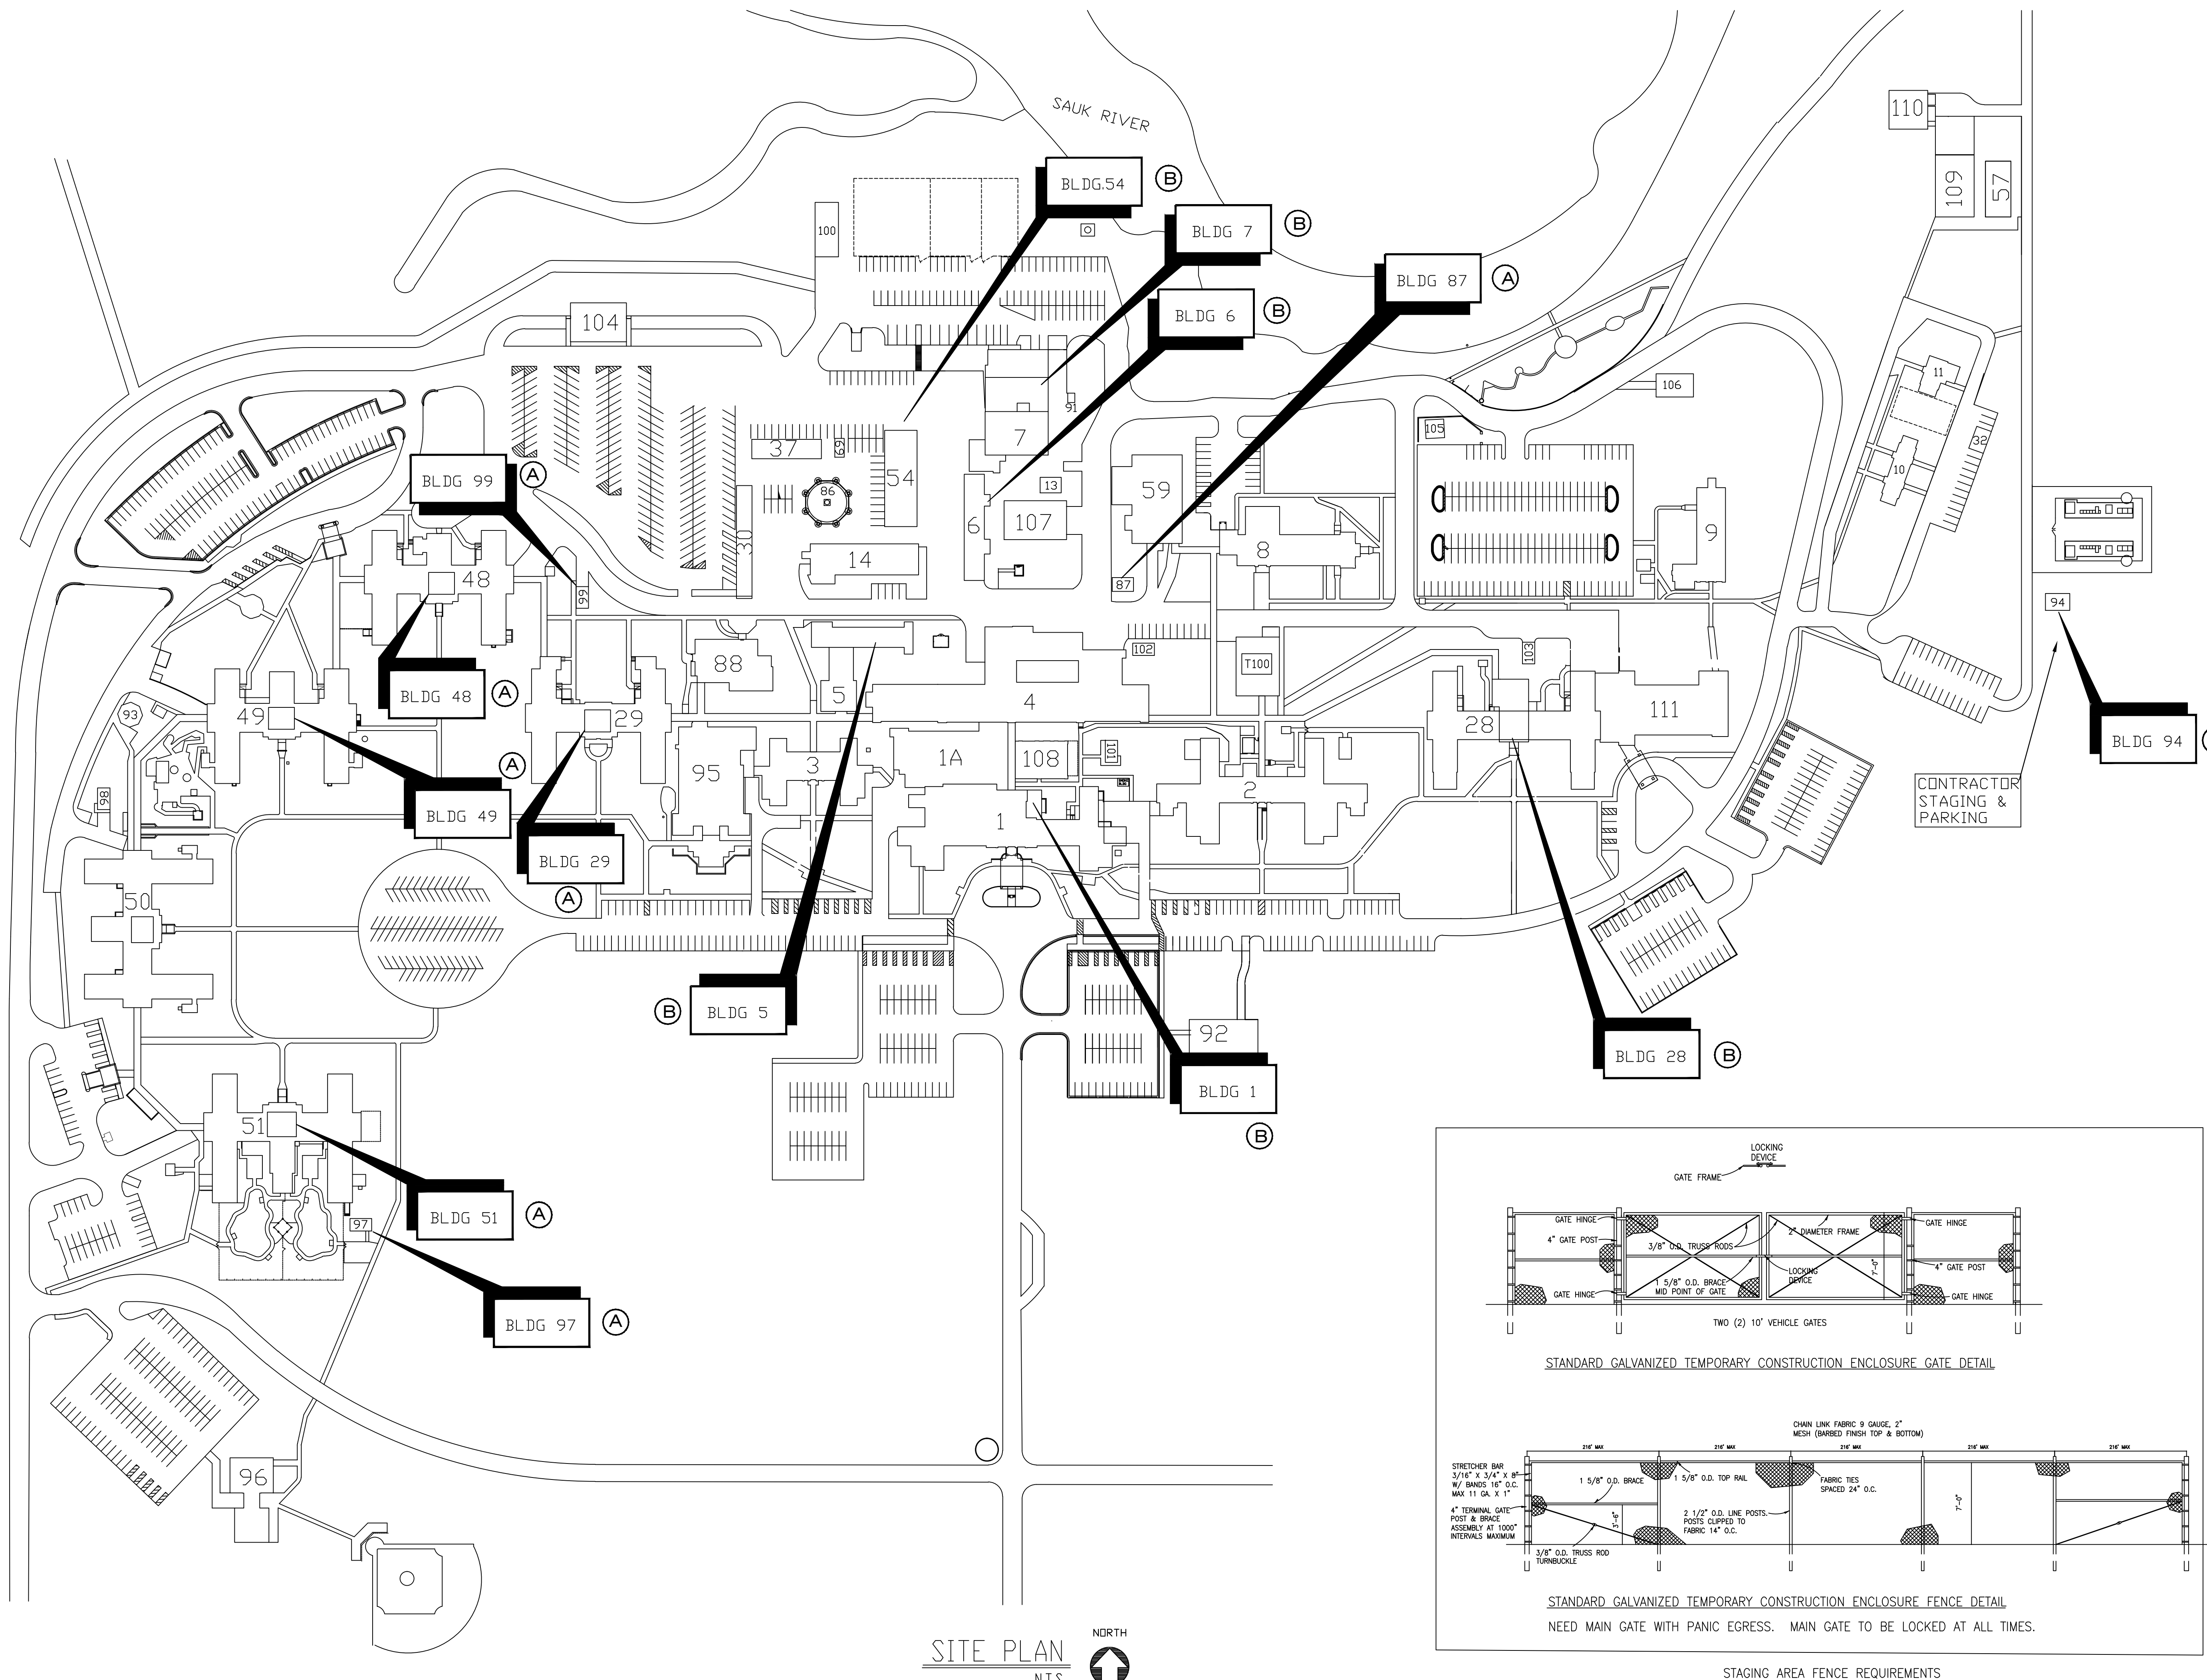

**St. Cloud VA**  
Health Care System  
Brainerd | Montevideo | Alexandria



APPROVED SERVICE LINE DIRECTOR	DATE:	APPROVED INFECTION CONTROL NURSE	DATE:	DRAWING TITLE	PROJECT TITLE	DATE			
						2/9/12			
APPROVED GEN. COORDINATOR	DATE:	APPROVED PATIENT SAFETY	DATE:			DATE			
						AS NOTED			
APPROVED PROJECTS SECTION MANAGER	DATE:	APPROVED CHIEF OF POLICE	DATE:	APPROVED CHIEF SAFETY SECTION	DATE:	BUILDING NUMBER	CHECKED	DRAWN	CAD FILE
						SITE PLAN		RLC	10020-1
APPROVED DIRECTOR FMS	DATE:	APPROVED SAFETY MANAGER	DATE:	APPROVED DIRECTOR FLS	DATE:	LOCATION			
						VIA MEDICAL CENTER			