

VA MEDICAL CENTER REPLACE PHYSICAL ACCESS SECURITY SYSTEM


Fargo, North Dakota

Project Number: 437-12-105

GENERAL
X1 COVER SHEET

ARCHITECTURAL
A1 BASEMENT PLAN
A2 FIRST FLOOR PLANS - BUILDINGS 9, 39 AND 51
A3 FIRST FLOOR PLANS - BUILDINGS 12 AND 13

ELECTRICAL
E1 BASEMENT REMODELING PLAN - ELECTRICAL
E2 BUILDING 9 AND BUILDING 46 FIRST FLOOR REMODELING PLAN - ELECTRICAL
E3 BUILDING 51 FIRST FLOOR REMODELING PLAN - ELECTRICAL
E4 BUILDING 12 AND 13 REMODELING PLAN - ELECTRICAL
E5 BUILDING 39 REMODELING PLAN - ELECTRICAL
E6 ELECTRICAL DETAILS
E7 ELECTRICAL DETAILS

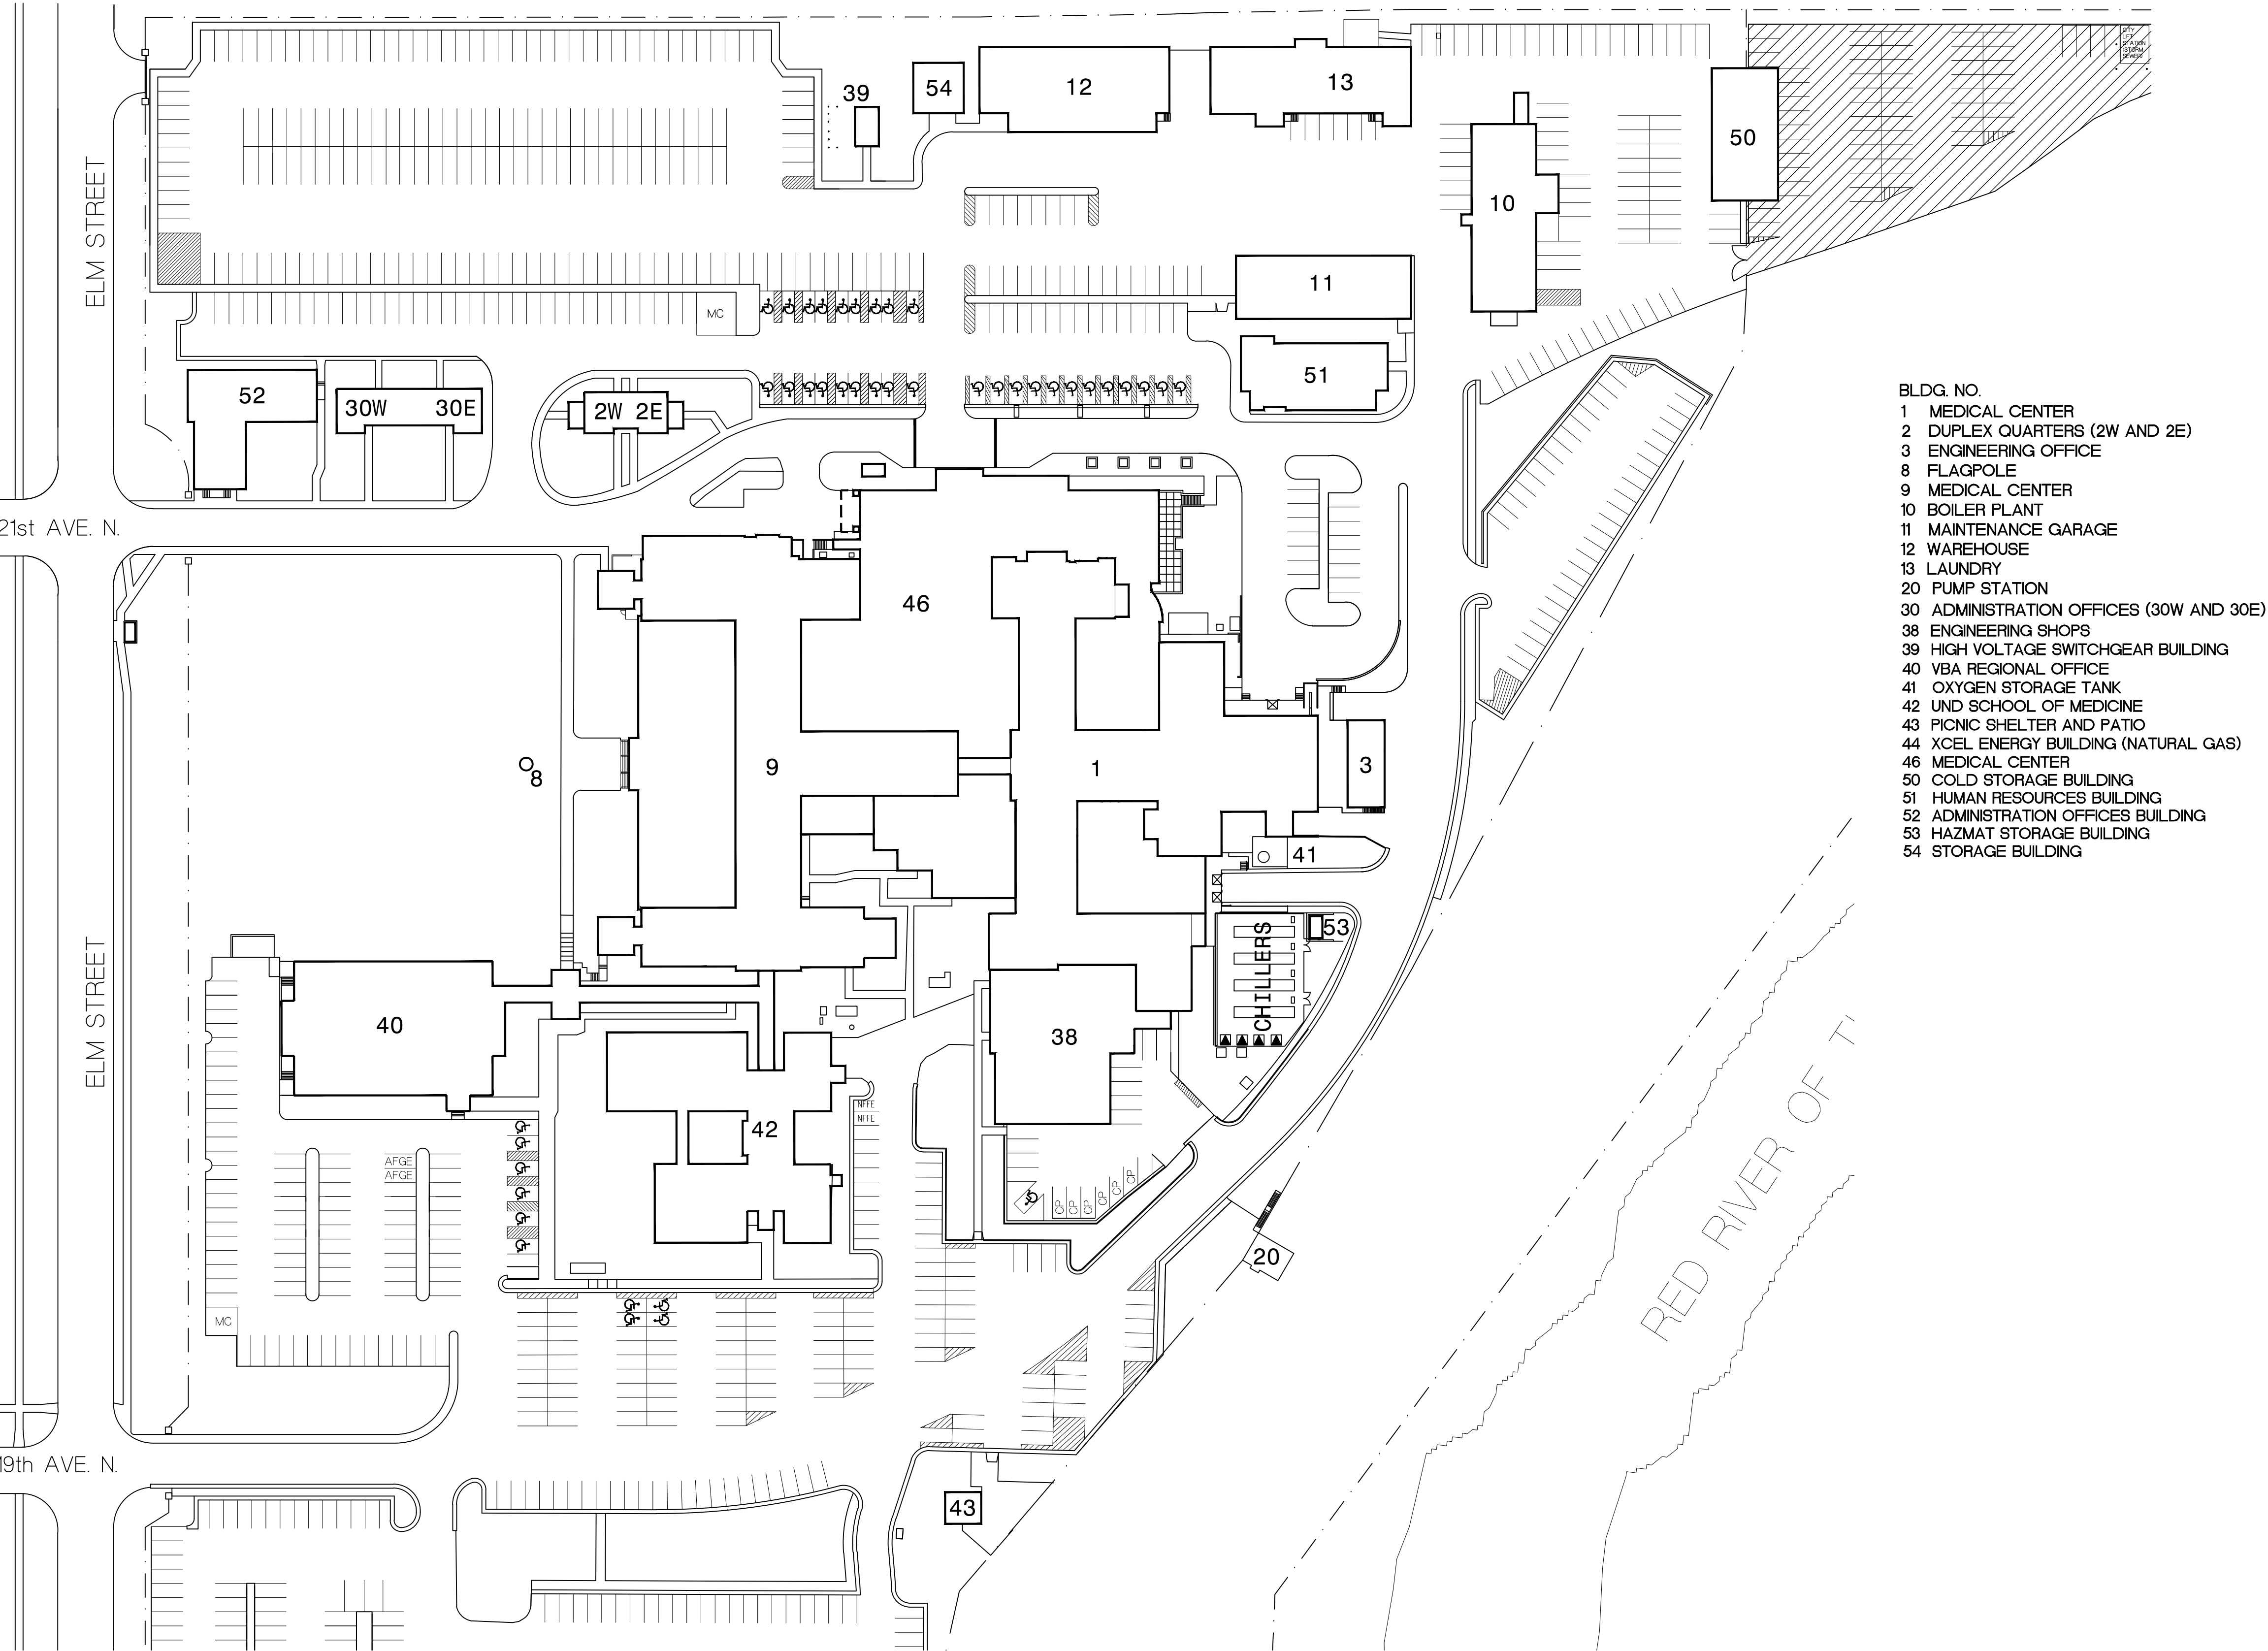

KEY TO SITE PLAN
CONTRACTOR STAGING AREA. SHARED WITH VA AND OTHER CONTRACTORS.

SITE PLAN
1"=60'-0"



Dept. of Veterans Affairs
Medical Center
2101 Elm Street North
Fargo, ND 58102



IMAGE GROUP INC. Architecture & Interiors
MEN ENGINEERING, Electrical Engineers

I hereby certify that this plan specification, or report was prepared by me or under my direct supervision, and that I am duly Registered Architect under the laws of the State of North Dakota.
Date: 5/4/2012 Reg. No. 378

Drawing Title COVER SHEET		Project Title VA MEDICAL CENTER REPLACE PHYSICAL ACCESS SECURITY SYSTEM		Date MAY 4, 2012
VA Project No. 437-12-105		Contract No. VA263-P-1217 VA263-C-		Scale 1"=60'-0"
Building No.		Designed By RM	Checked By RM	Drawn By KS
AutoCAD File Name COVERDWG		Location VA MEDICAL CENTER FARGO, ND		Drawing No. X1
				Dwg. 1 of 9

