

VA MEDICAL CENTER INSTALL ETO ABATER

Fargo, North Dakota

Project Number: 437-12-101

GENERAL NOTES

1. CONTRACTOR SHALL CLOSELY COORDINATE THE WORK UNDER THIS CONTRACT AT BASEMENT, FIRST AND SECOND FLOORS WITH THE VA PROJECT ENGINEER AND WITH THE WORK POTENTIALLY STILL IN PROGRESS UNDER SEPARATE REPLACEMENT OPERATING ROOMS PROJECT.
2. BOTH STERILIZERS IN ROOM B21B SHALL REMAIN IN OPERATION FROM 3:30PM TO 10:30AM OVERNIGHT WEEKDAYS DURING CONSTRUCTION. CONSTRUCTION TO INCLUDE STERILIZER CONNECTIONS, ETC. SHALL BE LIMITED TO WEEKDAYS 10:30AM UNTIL 3:30PM AND WEEKENDS AS SCHEDULED. ALL OPENINGS SHALL BE SEALED WITH PLASTIC AND TAPE AT END OF CONSTRUCTION WORK SHIFT TO ALLOW STERILIZATION, PROCESSING AND DISTRIBUTION ACTIVITIES TO BE CARRIED ON WEEKDAY EVENINGS AND OVERNIGHTS. CONSTRUCTION ACTIVITIES WILL NOT BE ALLOWED WEEKDAY EVENINGS AND OVERNIGHTS.

GENERAL

X1 COVER SHEET

ARCHITECTURAL


A1 PLANS AND DETAILS

MECHANICAL


H1 ETO ABATER MECHANICAL DRAWINGS
H2 ETO ABATER MECHANICAL DRAWINGS

ELECTRICAL


E1 BASEMENT PLAN - ELECTRICAL
SECOND FLOOR PLAN - ELECTRICAL
ATTIC PLAN - ELECTRICAL

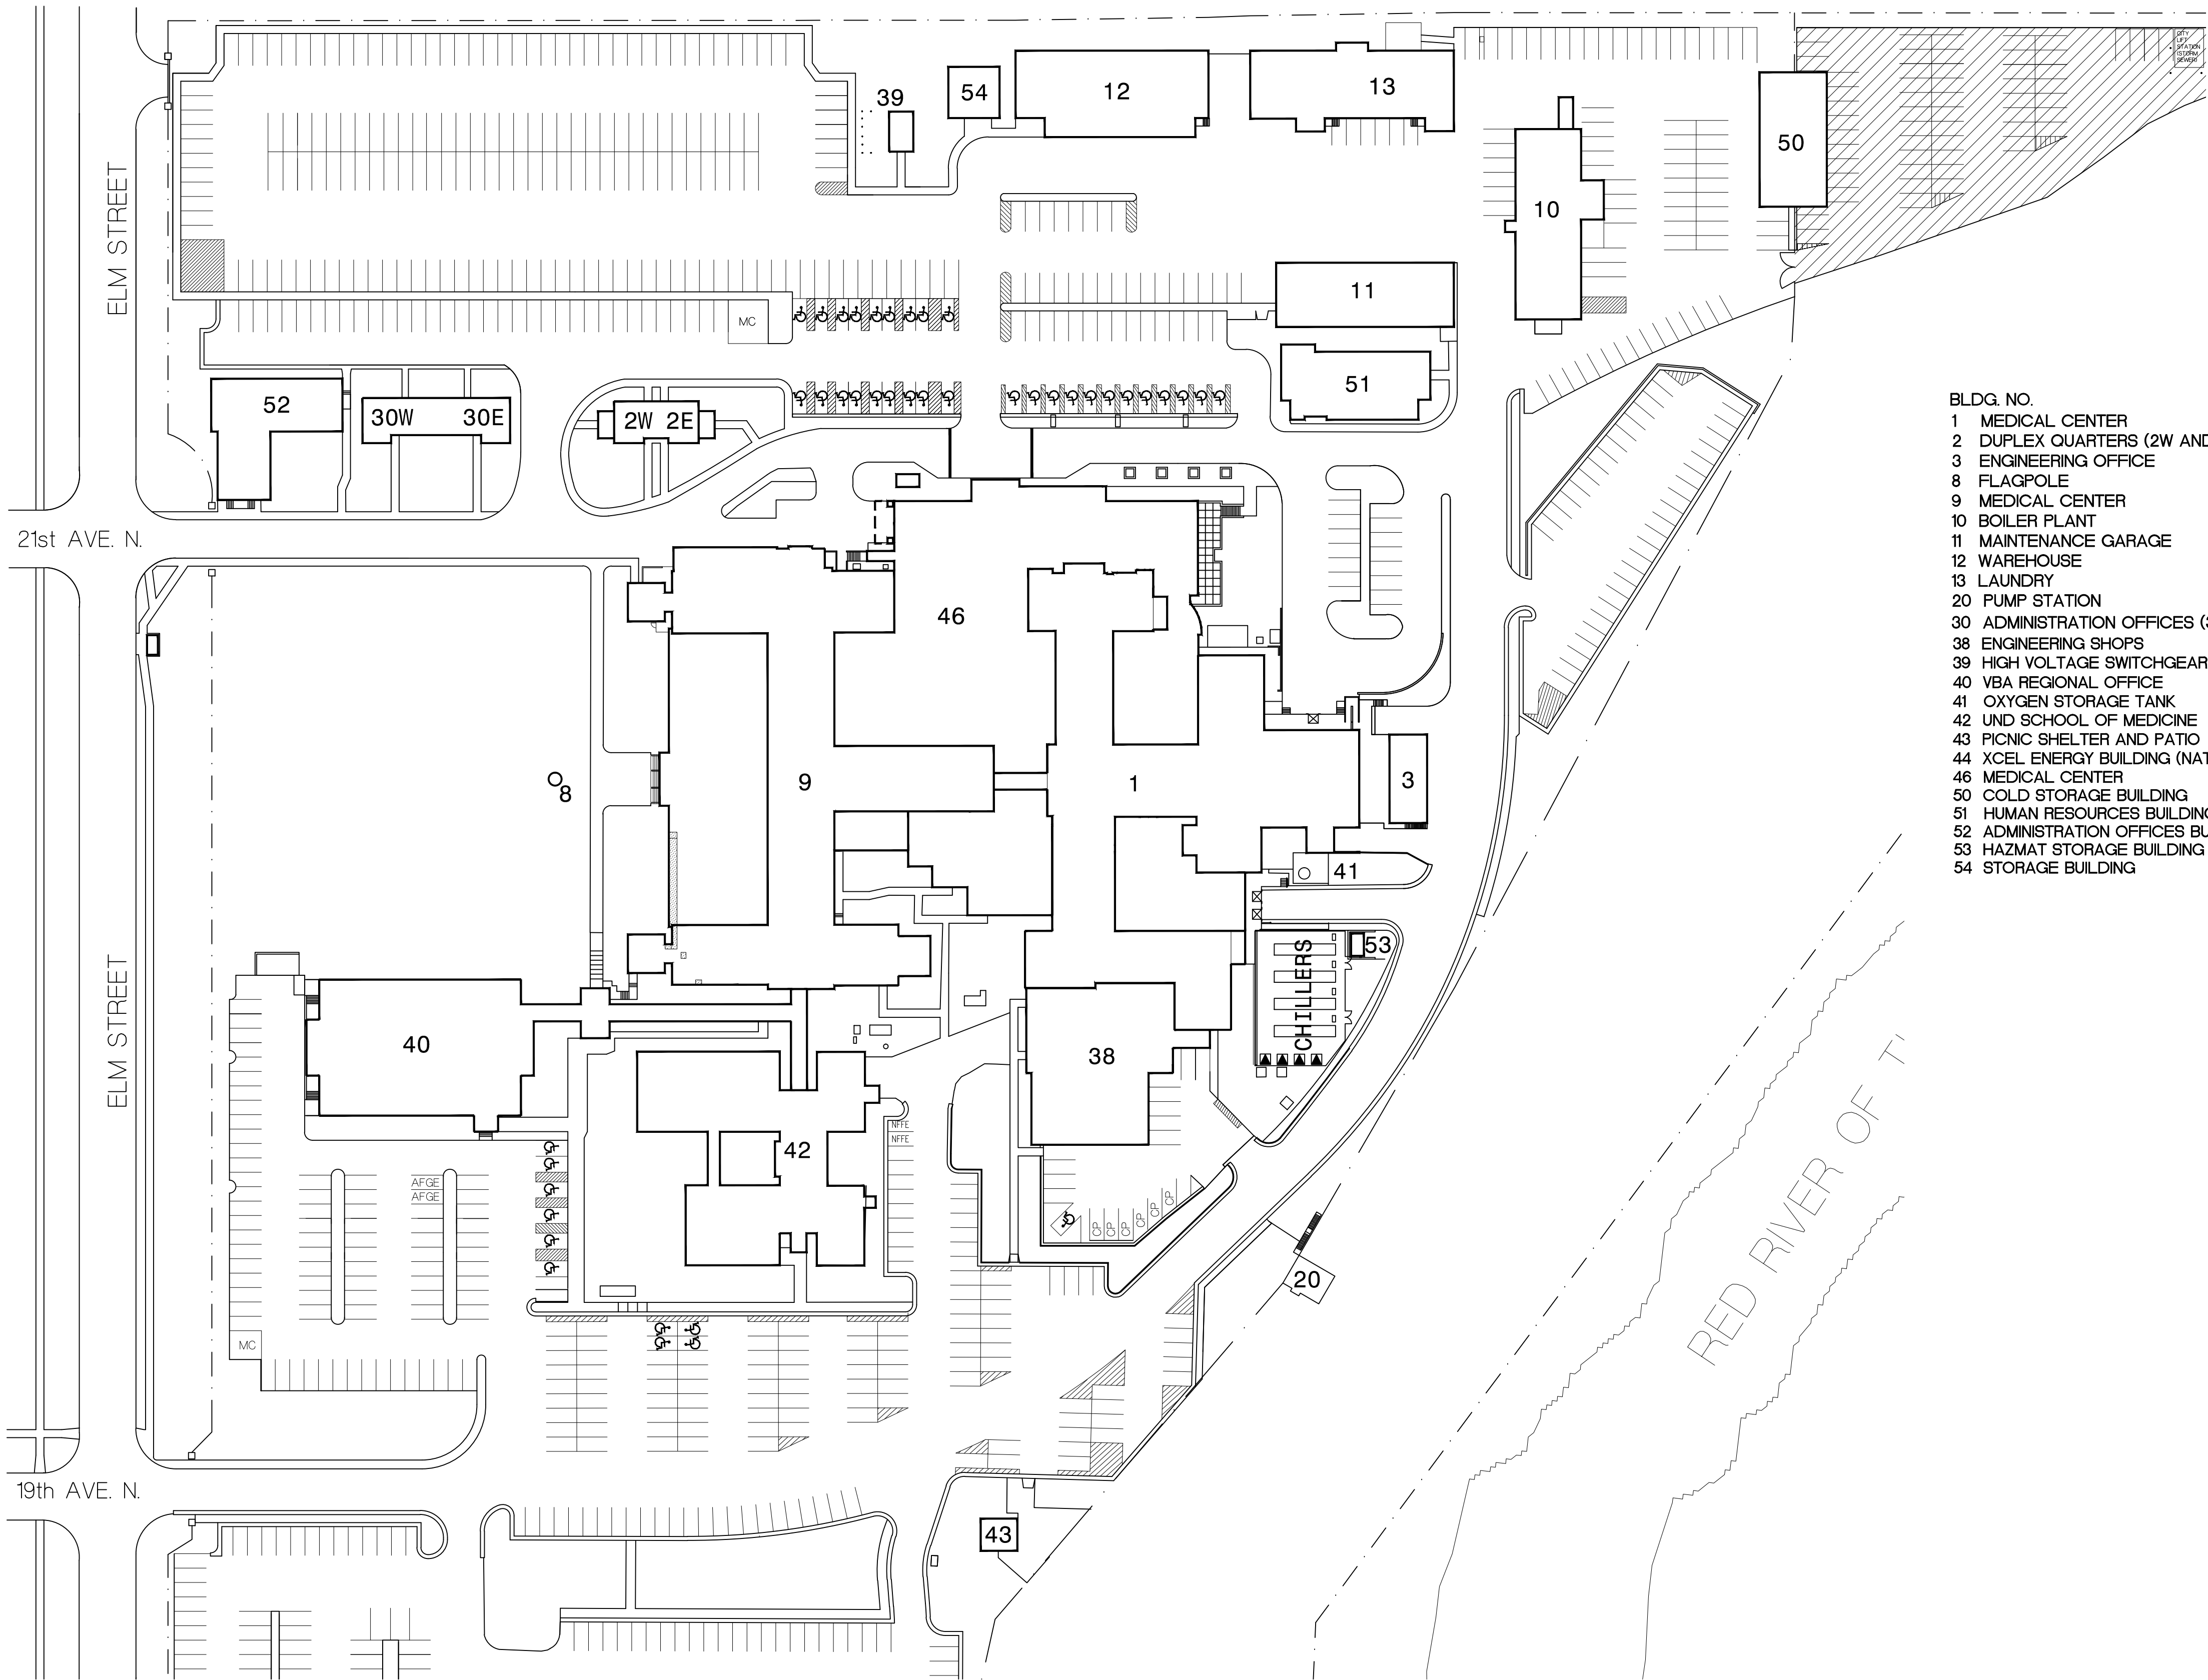

- BLDG. NO.
- 1 MEDICAL CENTER
 - 2 DUPLEX QUARTERS (2W AND 2E)
 - 3 ENGINEERING OFFICE
 - 8 FLAGPOLE
 - 9 MEDICAL CENTER
 - 10 BOILER PLANT
 - 11 MAINTENANCE GARAGE
 - 12 WAREHOUSE
 - 13 LAUNDRY
 - 20 PUMP STATION
 - 30 ADMINISTRATION OFFICES (30W AND 30E)
 - 38 ENGINEERING SHOPS
 - 39 HIGH VOLTAGE SWITCHGEAR BUILDING
 - 40 VBA REGIONAL OFFICE
 - 41 OXYGEN STORAGE TANK
 - 42 UNID SCHOOL OF MEDICINE
 - 43 PICNIC SHELTER AND PATIO
 - 44 XCEL ENERGY BUILDING (NATURAL GAS)
 - 46 MEDICAL CENTER
 - 50 COLD STORAGE BUILDING
 - 51 HUMAN RESOURCES BUILDING
 - 52 ADMINISTRATION OFFICES BUILDING
 - 53 HAZMAT STORAGE BUILDING
 - 54 STORAGE BUILDING

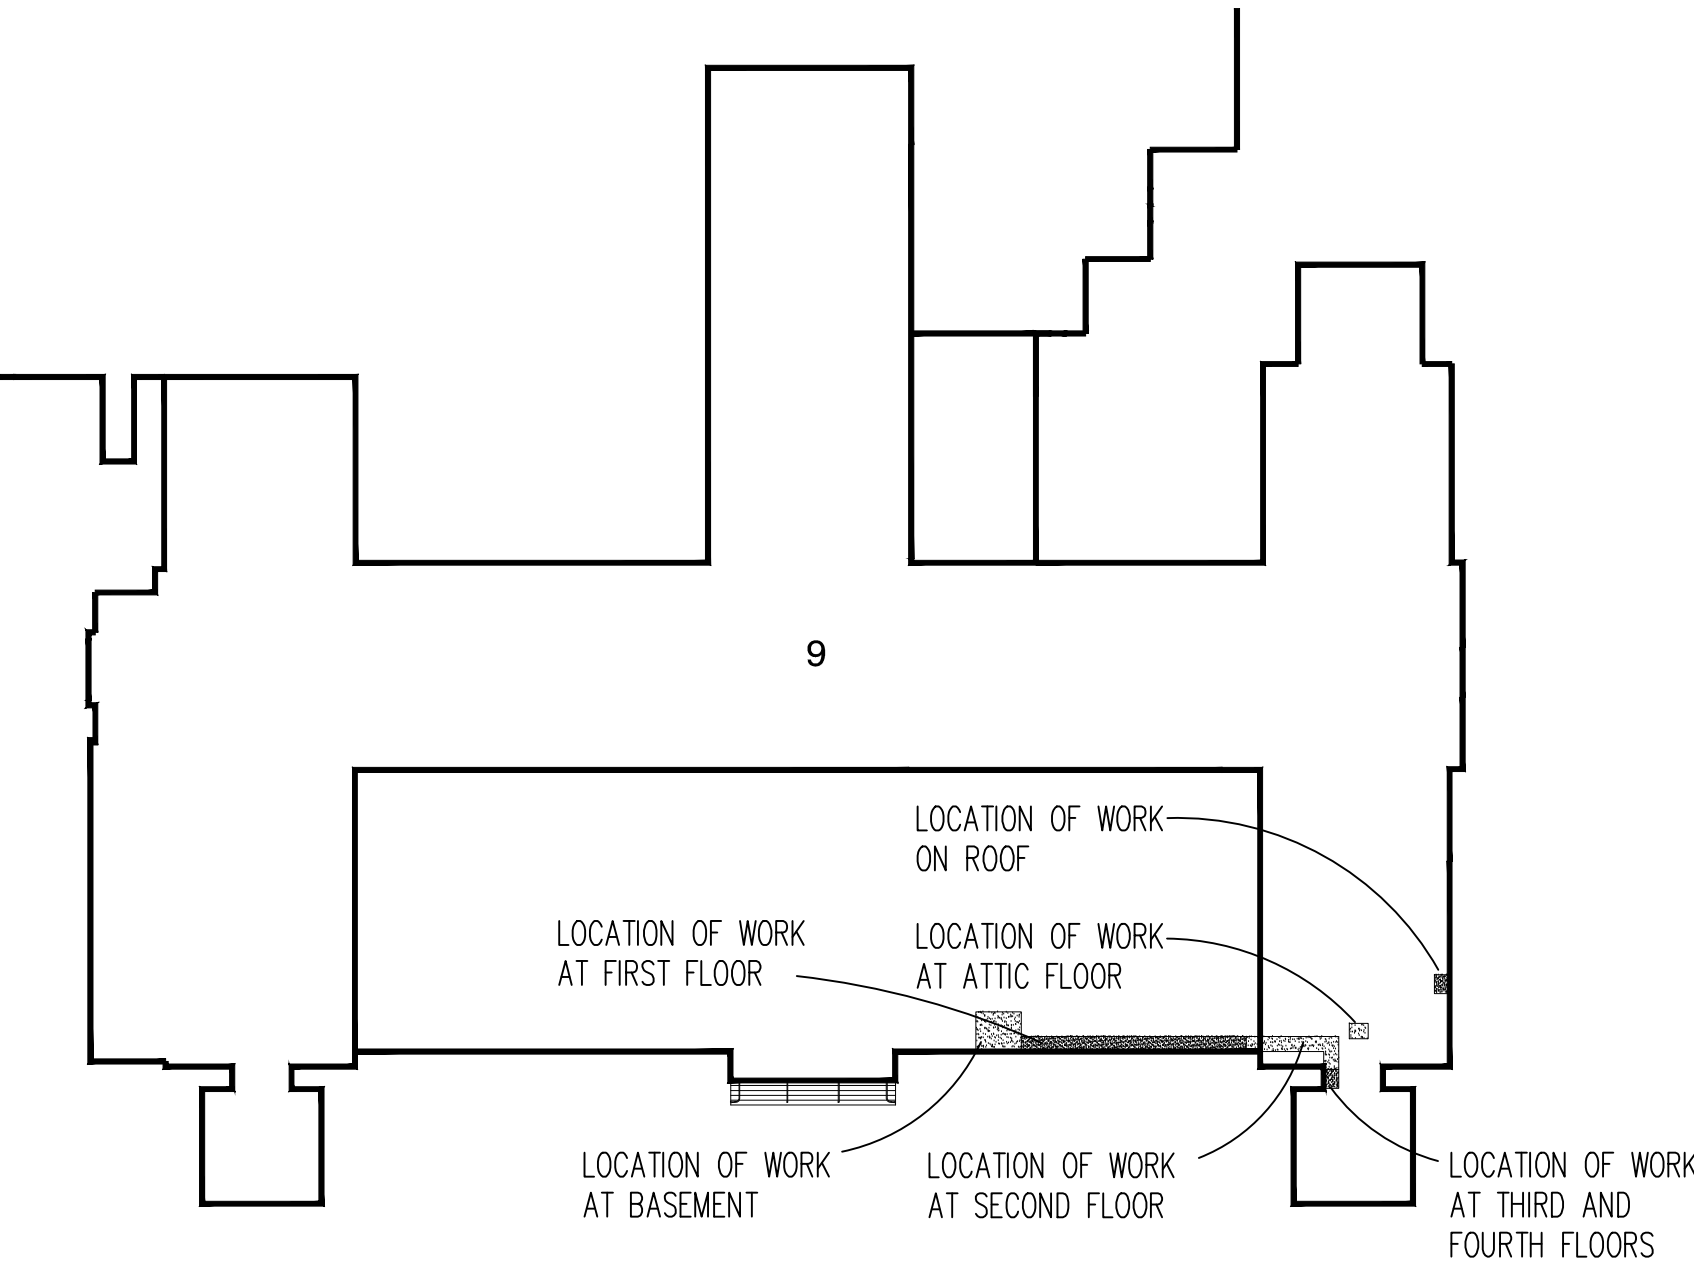

LOCATION PLAN

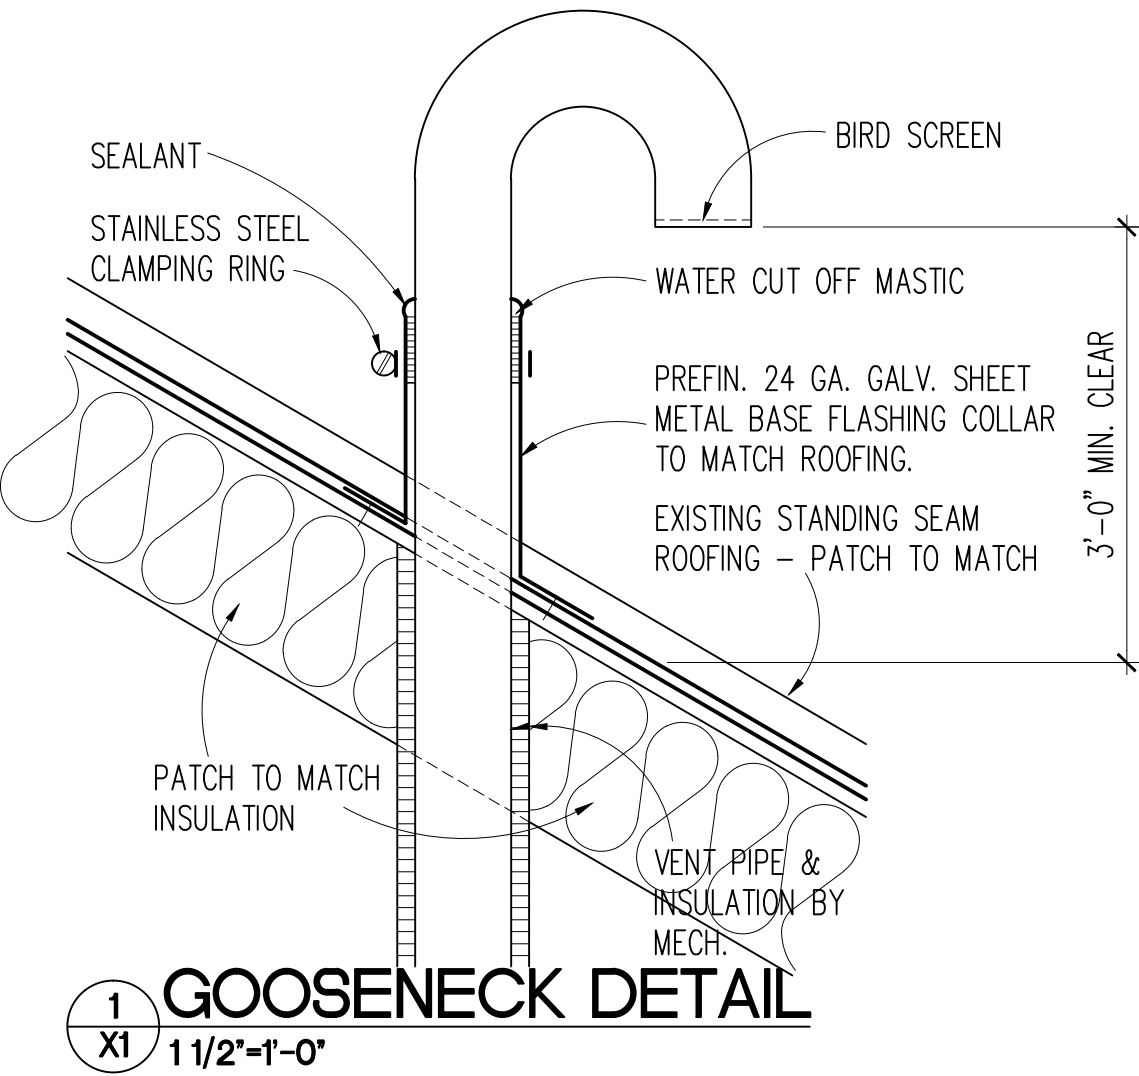

GOOSENECK DETAIL

KEY TO SITE PLAN

- CONTRACTOR STAGING AREA. SHARED WITH VA AND OTHER CONTRACTORS.
- CONSTRUCTION AREA

SITE PLAN

1"=60'-0"



Dept. of Veterans Affairs
Medical Center
2101 Elm Street North
Fargo, ND 58102



IMAGE GROUP INC.
403 CENTER AVENUE, SUITE 300
MOORHEAD, MN 56560

IMAGE GROUP INC., Architecture & Interiors
OBERMILLER NELSON ENGINEERING, Mechanical Engineers
MEN ENGINEERING, Electrical Engineers

I hereby certify that this plan specification, or report was prepared by me or under my direct supervision, and that I am duly Registered Architect under the laws of the State of North Dakota

Date: 5/4/2012 Reg. No. 378

Drawing Title COVER SHEET		Project Title VA MEDICAL CENTER INSTALL ETO ABATER		Date MAY 4, 2012
VA Project No. 437-12-101	Contract No. VA263-P-1217 VA263-C-	Designed By RM	Checked By RM	Scale 1"=60'-0"
Building No. 9	AutoCAD File Name COVER.DWG	Drawn By KS	Location VA MEDICAL CENTER FARGO, ND	Drawing No. X1
				Dwg. 1 of 5

