
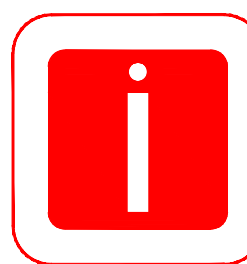


SYMBOL	DESCRIPTION
	SUPPLY DIFFUSER
	RETURN DIFFUSER
	EXHAUST DIFFUSER
	LINEAR DIFFUSER
	FIRE DAMPER
	SMOKE DAMPER
	FIRE DAMPER AT FLOOR PENETRATION
	VOLUME DAMPER
	MOTOR OPERATED DAMPER
	SPIN FITTING WITH VOLUME DAMPER
	STATIC PRESSURE SENSOR
	HUMIDITY SENSOR
	TEMPERATURE SENSOR
	REHEAT COIL
	CONSTANT VOLUME BOX WITH REHEAT COIL
	VARIABLE VOLUME BOX WITH REHEAT COIL
	FINNED TUBE RADIATOR
	UNIT HEATER
	AIR FLOW MEASURING DEVICE
	FILTER
	FAN
	FLEXIBLE CONNECTOR
	LOUVER
	ACCESS DOOR
	DOOR UNDERCUT
	ANCHOR
	SOUND ATTENUATING UNIT
	EXHAUST BOX
	TERMINAL UNIT
	AIR HANDLING UNIT
	MECHANICAL EQUIPMENT
	DISCHARGE CONTROLLER
	PRESSURE GAUGE
	HUMIDISTAT
	ROOM CONTROL THERMOSTAT
	CIRCUIT SETTER
	FAN COIL UNIT
	PIPE GUIDE OR SLEEVE
	CAP
	UNION
	AIR FLOW DIRECTION(SUPPLY/RETURN)
	FLOW DIRECTION IN PIPE
	Continuation
	HPR
	EXHAUST ARROW
	PUMP
	2 WAY MODULATING CONTROL VALVE
	GATE VALVE
	BALL VALVE
	SERVICE VALVE
	RISER
	PIPE UP
	ELBOW DOWN
	BOTTOM CONNECTION

PIPING	
	HIGH PRESSURE STEAM (60 PSIG & ABOVE)
	HIGH PRESSURE STEAM CONDENSATE RETURN
	MEDIUM PRESSURE STEAM (16 PSIG THRU 59 PSIG)
	MEDIUM PRESSURE STEAM CONDENSATE RETURN
	LOW PRESSURE STEAM (15 PSIG & BELOW)
	LOW PRESSURE STEAM CONDENSATE RETURN
	CONDENSATE PUMP DISCHARGE
	HOT WATER HEATING SUPPLY
	HOT WATER HEATING RETURN
	VARIABLE TEMP. HOT WATER HEATING
	VARIABLE TEMP. HOT WATER RETURN
	REFRIGERANT LIQUID
	REFRIGERANT SUCTION
	REFRIGERANT HOT GAS
	CRITICAL CHILLED WATER SUPPLY
	CRITICAL CHILLED WATER RETURN
	CHILLED WATER SUPPLY
	CHILLED WATER RETURN
	MAKE-UP WATER
	DRAIN LINE
	GLYCOL-WATER RUN AROUND SUPPLY
	GLYCOL-WATER RUN AROUND RETURN
	HOT WATER SUPPLY
	HOT WATER RETURN
	MEDIUM PRESSURE STEAM
	MEDIUM PRESSURE CONDENSATE
	CHILLED WATER SUPPLY
	CHILLED WATER RETURN

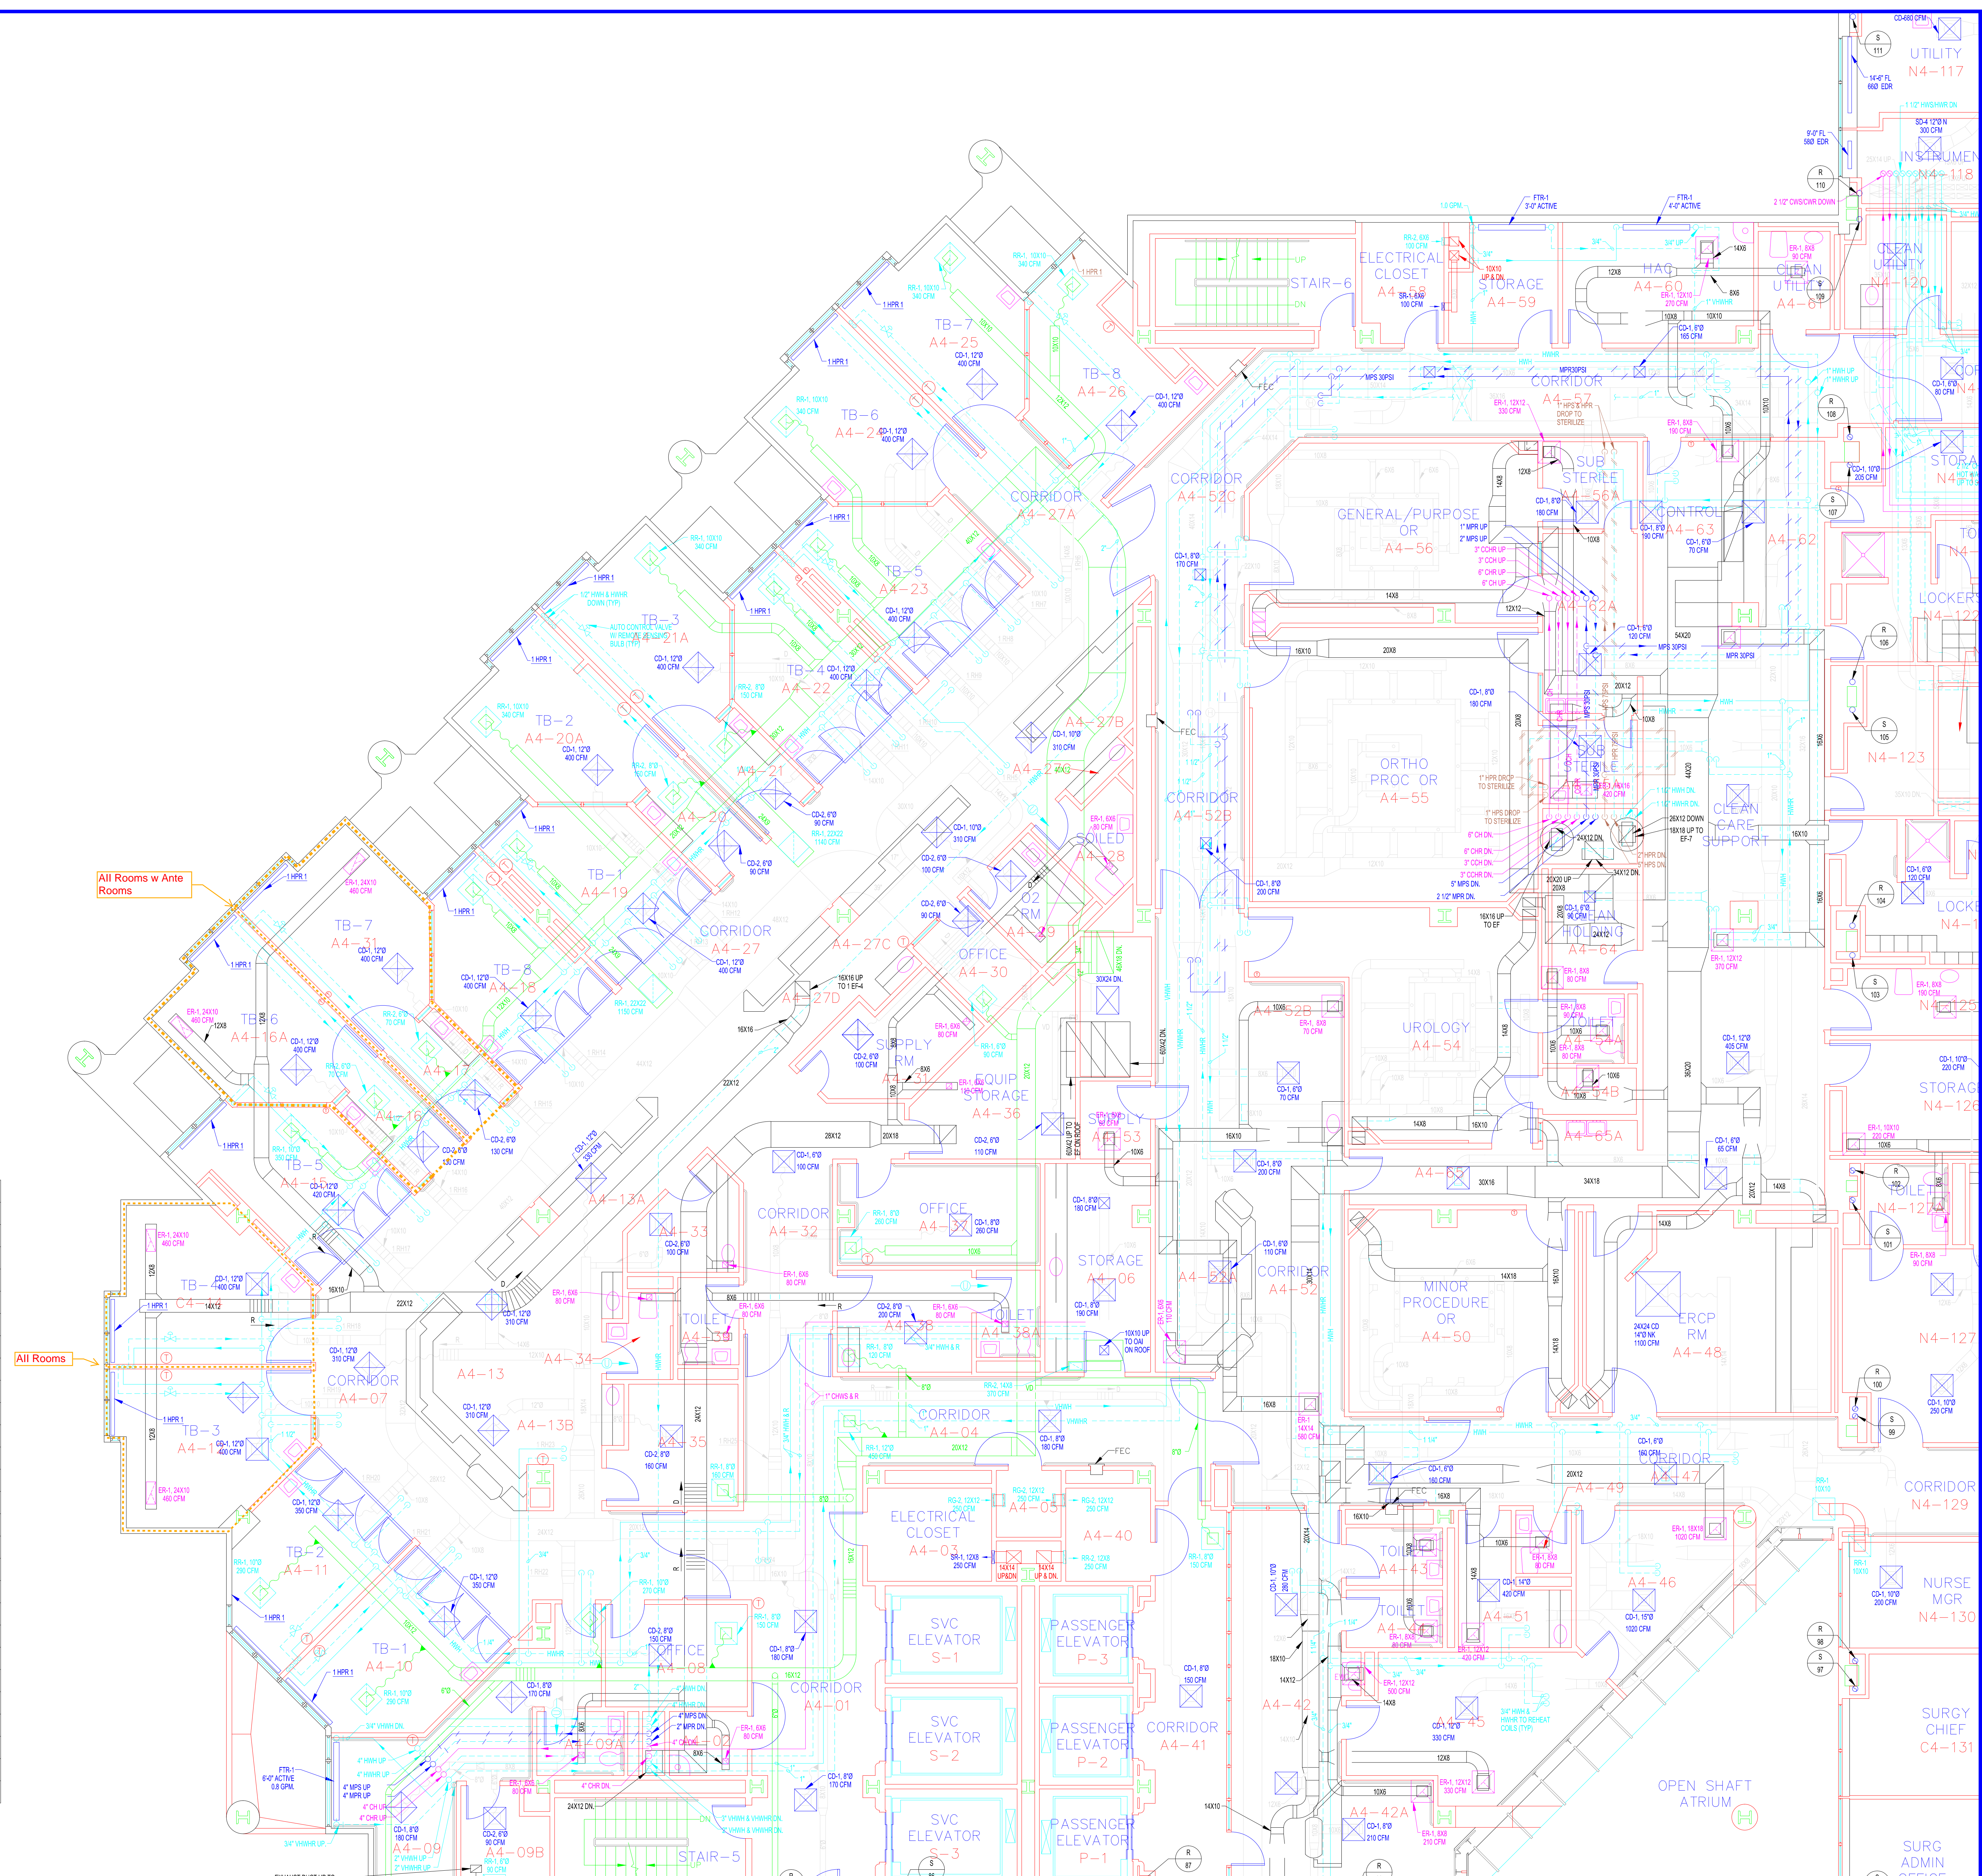

Indus Systems, Inc.
2352, Main Street, Concord MA 01742
Tel: 978-461-0555
www.indus-systems.com

Drawing Title
FOURTH FLOOR PLAN
MECHANICAL

Site: WILKES BARRE
Building: 01
Location: VAMC, WILKES BARRE
PENNSYLVANIA


Project Title
AS-BUILT Drawings

Drawn: _____
Checked: _____
Approved: _____

Date
04-08-2014

Project No.

Drawing No.

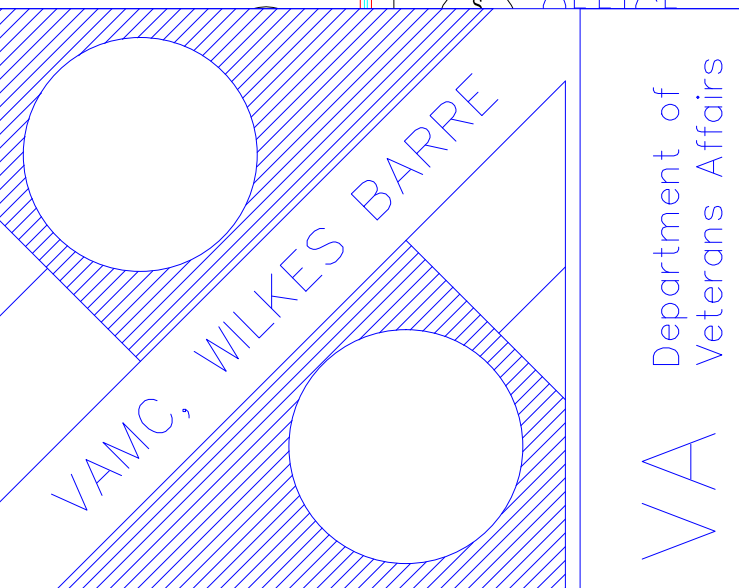

Department of
Veterans Affairs
VA