


VA MEDICAL CENTER HUNTINGTON, WEST VIRGINIA


PROJECT NO: 10-106
MORQUE IMPROVEMENTS
BUILDING 1, GROUND FLOOR

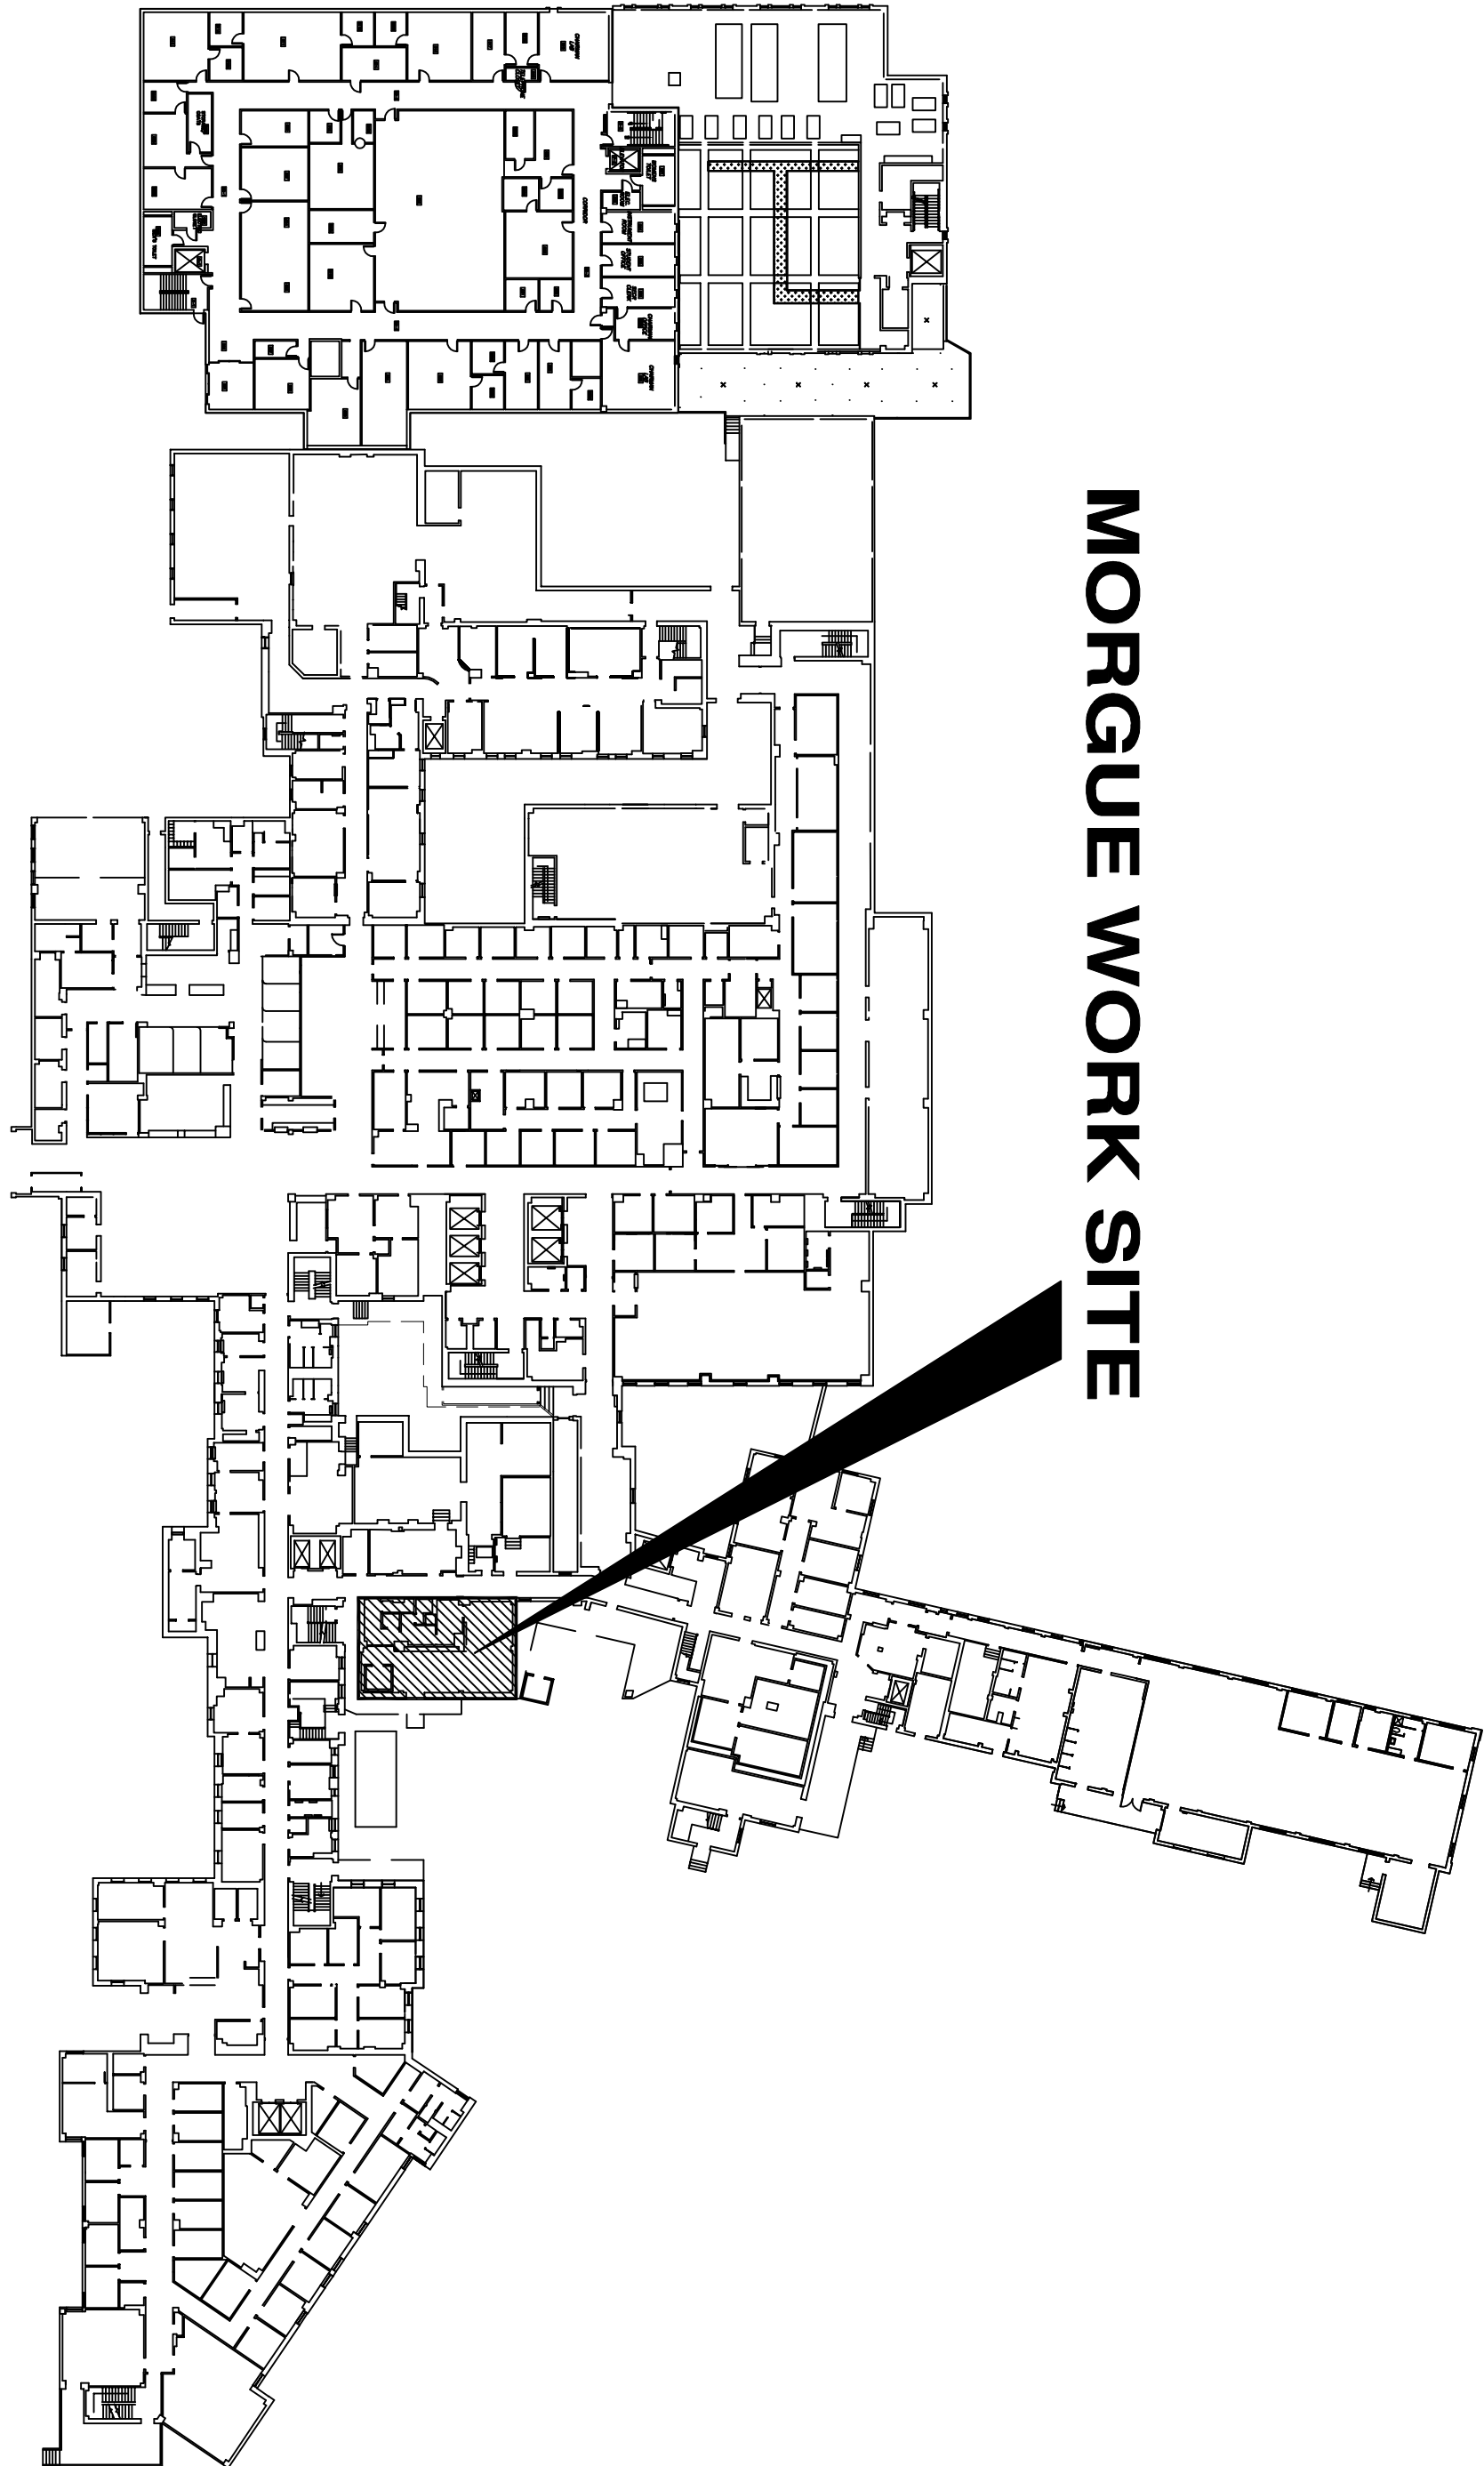


LOCATION MAP
SCALE: 1" = 600'
NORTH

GENERAL NOTES APPLICABLE TO THIS PROJECT

- A. CONTRACTOR SHALL VERIFY WORK AREA CONDITIONS AND REQUIREMENTS. PROVIDE SUBMITTALS OF ALL PRODUCTS UNLESS BRAND SPECIFIED HERE-IN.
- B. ALL TOOLS USED IN THIS PROJECT SHALL BE PROPERLY SECURED AT ALL TIMES BY THE CONTRACTOR TO PREVENT ANY OF THESE TOOLS BEING A HAZARD TO PATIENTS.
- C. THE CONTRACTOR AT HIS EXPENSE WILL BE RESPONSIBLE FOR ACQUIRING VA PICTURE I.D. BADGES FOR EACH MEMBER OF HIS WORK FORCE BEFORE ANY MEMBER WILL BE ALLOWED TO PERFORM WORK IN VA PREMISES. PROCESS I.D. APPLICATIONS THROUGH COR.
- D. LABOR RATE TO BE POSTED IN WORK AREA.
- E. ABSOLUTELY NO VA TOOLS, MATERIALS WILL BE LOANED OR GIVEN BY THE VA TO ANY MEMBER OF THE CONTRACTOR'S WORK FORCE AT ANY TIME.
- G. CONTRACTOR SHALL COORDINATE ONLY WITH THE COR.
- H. EACH WORKER WILL BE REQUIRED TO WEAR APPROPRIATE SAFETY EQUIPMENT AT ALL TIMES (I.E. SAFETY SHOES, EAR PLUGS, SAFETY GLASSES, SAFETY HELMET ETC.) AND IS RESPONSIBLE TO ENSURE THAT NON-WORKERS ARE PREVENTED FROM INJURING THEMSELVES IN ANY WORK AREA.
- I. DO NOT ALLOW DEMOLITION DEBRIS TO ACCUMULATE ON JOB SITE. DO NOT LEAVE TOOLS UNATTENDED. DEBRIS SHALL BE DAMPENED AND COVERED. DAMP MOP OCCUPIED FLOOR AREAS AS REQUIRED. PROVIDE WALK OFF MATS AS REQUIRED. PROVIDE NEGATIVE AIR VENTILATION TO THE EXTERIOR OF WORK AREA AS DIRECTED BY COR. INSTALL DUST PROTECTION WALLS BETWEEN AREAS IN USE BY VA. EXCESSIVE NOISE TRANSMISSION OF WORK SHALL BE ACCOMPLISHED IN OTHER THAN NORMAL WORKING HOURS (7:00AM TO 4:30PM).
- J. CONTRACTOR SHALL BE RESPONSIBLE FOR RENTING A WALK-IN COOLER AND HAVE IT DELIVERED TO LOCATION DESIGNATED BY COR.

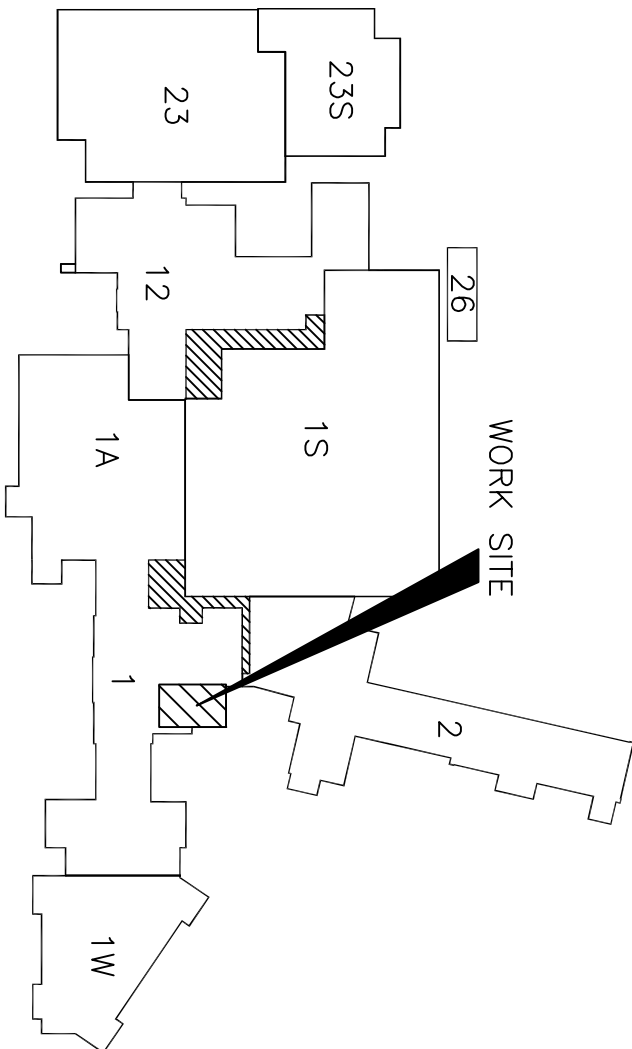

INDEX TO DRAWINGS	
SHT.NO.	DESCRIPTION
T1	TITLE SHEET & GENERAL NOTES
A1	DEMOLITION PLAN
A2	PROPOSED WORK PLAN
A3	ELEVATIONS, SCHEDULES & ACCESSORY LIST
E1	POWER, DATA AND LIGHTING PLAN
P1	MECHANICAL AND PLUMBING PLAN



UNITED STATES DEPARTMENT OF VETERANS AFFAIRS
VA MEDICAL CENTER - 1540 SPRING VALLEY DRIVE - HUNTINGTON WV 25704

DRAWING TITLE:
TITLE SHEET, INDEX &
GENERAL NOTES

PROJECT TITLE:
MORQUE IMPROVEMENTS

APPROVED:
CHRIS ECKLES
ASST. CHIEF, ENGINEERING

BUILDING:
1S

PROJECT NUMBER:
10-106

DRAWING NUMBER:
T1

DRAWN BY:
JOHN KLIM
CHIEF, ENGINEERING

DATE:
APR '12

DWG.