

# VA MEDICAL CENTER HUNTINGTON, WV

BUILDINGS: 1S

# PROJECT 581-12-108 REPLACE HOT WATERS HEATERS BLDG. 1S

SHEET INDEX		
	NUMBER	TITLE
1	X-1	TITLE SHEET
2	P1	PLUMBING GENERAL NOTES, LEGEND, ABBREVIATION & SCHEDULES
3	P2	PLUMBING DEMOLITION AND NEW WORK FLOOR PLAN DIAGRAMS
4	P3	WATER PIPING DEMOLITION DIAGRAMS & NEW WORK PLAN DIAGRAMS
5	E1	ELECTRICAL GENERAL NOTES, LEGEND, AND ABBREVIATION
6	E2	ELECTRICAL DEMOLITION AND NEW WORK PLAN

## GENERAL NOTES APPLICABLE TO THIS PROJECT

- A. CONTRACTOR SHALL VERIFY EXISTING CONDITION AND DIMENSION PRIOR TO BIDDING WORK

B. WORK SHALL BE PHASED TO MINIMIZE INTERRUPTIONS TO MEDICAL CENTER

C. NO AREAS OTHER THAN AREAS OFFICIALLY MARKED AS SMOKING AREAS WILL BE PERMITTED ON VA PREMISES.

D. THE CONTRACTOR SHALL STOP ANY WORK AND VACATE THE WORK AREA IF SO ASKED IN MEDICAL SITUATIONS REQUIRING SUCH ACTION.


E. ALL TOOLS USED IN THIS PROJECT SHALL BE PROPERLY SECURED AT ALL TIMES BY THE CONTRACTOR TO PREVENT ANY OF THESE TOOLS BEING A HAZARD TO PATIENTS.
- F. THE CONTRACTOR AT HIS EXPENSE WILL BE RESPONSIBLE FOR ACQUIRING PICTURE I.D. BADGES FOR EACH MEMBERS OF HIS WORK FORCE BEFORE ANY MEMBER WILL BE ALLOWED TO PERFORM WORK IN VA PREMISES

G. LABOR RATE TO POSTED IN EACH WORK AREA

H. CONTRACTOR SHALL COORDINATE ONLY WITH THE COR.

I. ALL VA PROPERTY THAT IS NOT PERMANENTLY REMOVED FROM VA PREMISES UNDER THIS PROJECT WHICH IS DAMAGED BY CONSTRUCTION OF THIS PROJECT SHALL BE REPLACED OR REPAIRED TO MATCH OR EXCEED THE QUALITY THAT EXISTED BEFORE DAMAGE.

J. EACH WORKER WILL BE REQUIRED TO WEAR APPROPRIATE SAFETY EQUIPMENT AT ALL TIMES (I.E. SAFETY SHOES, EAR PLUGS, SAFETY GLASSES, SAFETY HELMET ETC.) AND IS RESPONSIBLE TO ENSURE THAT NON-WORKERS ARE PREVENTED FROM INJURING THEMSELVES IN ANY WORK AREA.

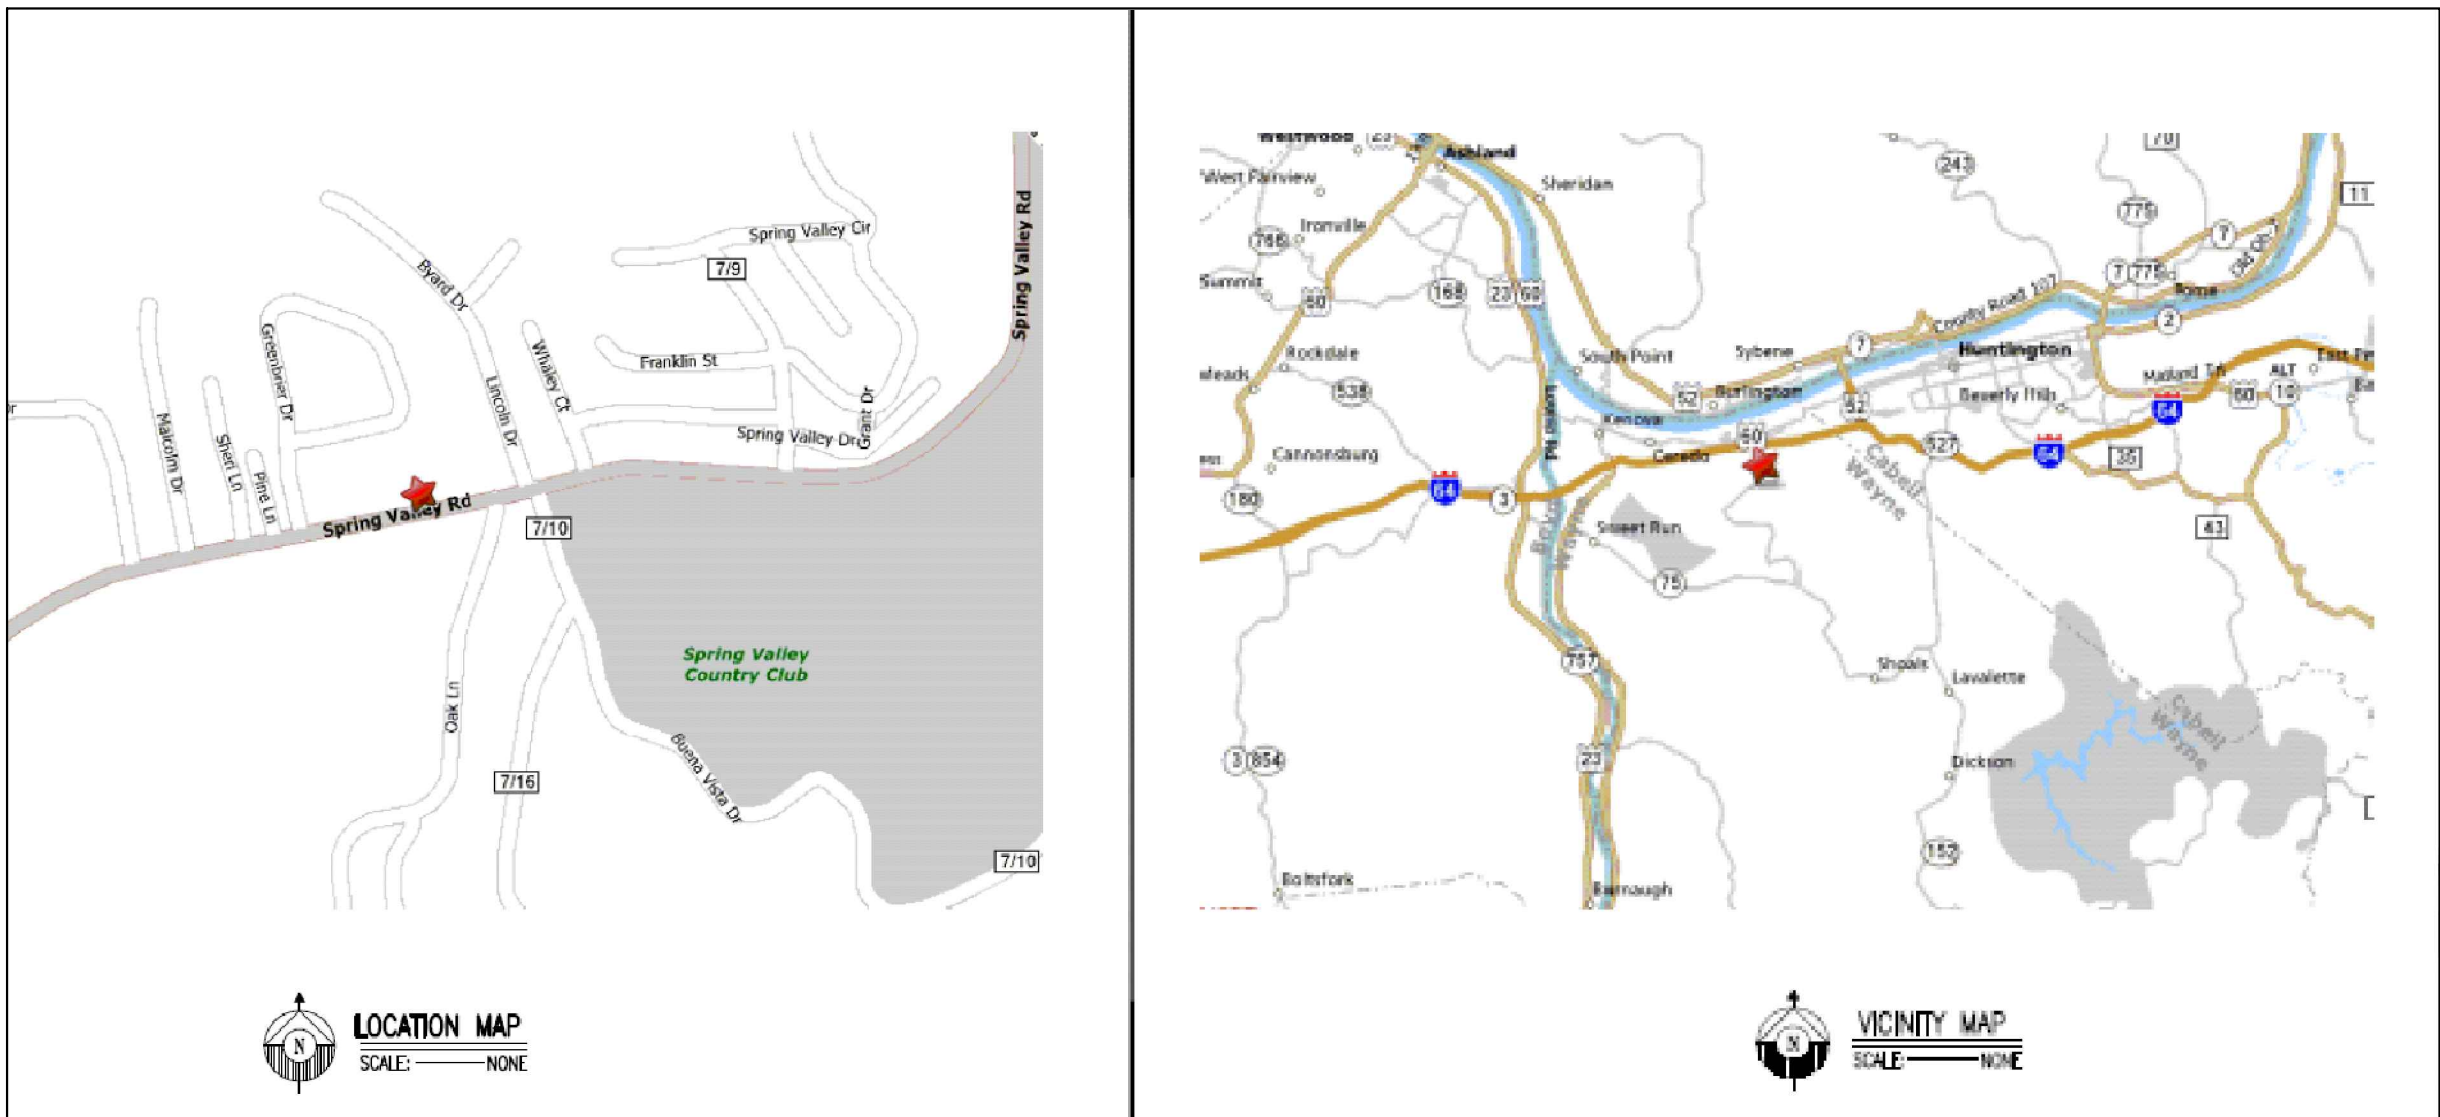

UNITED STATES DEPARTMENT OF VETERANS AFFAIRS VA MEDICAL CENTER - 1540 SPRING VALLEY DRIVE - HUNTINGTON WV 25704				
DRAWING TITLE: <b>GENERAL NOTES, MAPS DRAWING LIST</b>		PROJECT TITLE: <b>REPLACE HOT WATER HEATERS BLDG. 1S</b>		
APPROVED: CHRISTOHER ECKLES ASS'T CHIEF, ENGINEERING SERVICE	BUILDING: <b>1S</b>	PROJECT NUMBER: <b>581-12-108</b>	DRAWING NUMBER: <b>X-1</b>	
APPROVED: JOHN KLIM CHIEF, ENGINEERING SERVICE	DRAWN: KAZI HOSSAIN	DATE: <b>APR '12</b>	DWG. <b>1</b> OF <b>6</b>	