


THIRD FLOOR LIGHTING PLAN
SCALE: 1/16" = 1' - 0"

TOTAL 23(TWENTY THREE) 2X2 LIGHT FIXTURES
TOTAL 33(THIRTY THREE) 2X4 LIGHT FIXTURES

GENERAL NOTES

1. Coordinate all replacement work with Contracting Officer's Representative
2. Contractor shall remove and dispose of all existing fixtures and lamps identified
3. Contractor shall install new fixture in same location and in same mounting method as existing fixture except where noted.
4. All existing 2'x2' fixtures shown shall be replaced with fixture LF1
5. All existing 2'x4' fixtures shown shall be replaced with fixture LF2

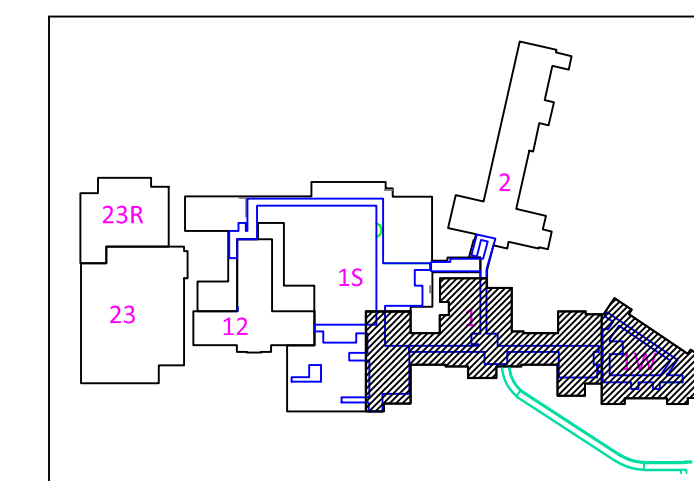

KEY PLAN
SCALE: NTS



UNITED STATES DEPARTMENT OF VETERANS AFFAIRS
VA MEDICAL CENTER - 1540 SPRING VALLEY DRIVE - HUNTINGTON WV 25704

DRAWING TITLE:		PROJECT TITLE:		
THIRD FLOOR LIGHTING		REPLACE LIGHTING PHASE 2		
APPROVED:	BUILDING:	PROJECT NUMBER:	DRAWING NUMBER:	
CHRISTOPHER ECKLES	1, 1W	581-12-109	E4	
ASS'T CHIEF, ENGINEERING SERVICE				
APPROVED:	DRAWN:	DATE:		
JOHN KLIM	KAZI HOSSAIN	MAY '12		
CHIEF, ENGINEERING SERVICE			DWG. 5 OF 8	