


TOTAL 27(TWENTY SEVEN) 2X4 LIGHT FIXTURES


**FIRST FLOOR LIGHTING PLAN**  
SCALE: 1/16" = 1' - 0"

GENERAL NOTES

- 1. Coordinate all replacement work with Contracting Officer's Representative
- 2. Contractor shall remove and dispose of all existing fixtures and lamps identified
- 3. Contractor shall install new fixture in same location and in same mounting method as existing fixture except where noted.
- 4. All existing 2'x2' fixtures shown shall be replaced with fixture LF1
- 5. All existing 2'x4' fixtures shown shall be replaced with fixture LF2

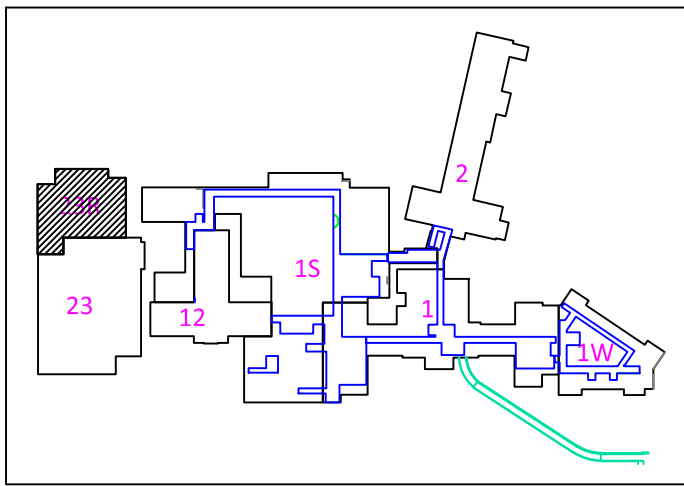

**KEY PLAN**  
SCALE: NTS

 <b>UNITED STATES DEPARTMENT OF VETERANS AFFAIRS</b> VA MEDICAL CENTER - 1540 SPRING VALLEY DRIVE - HUNTINGTON WV 25704			
DRAWING TITLE: <b>23R FIRST FLOOR LIGHTING</b>		PROJECT TITLE: <b>REPLACE LIGHTING PHASE 2</b>	
APPROVED: CHRISTOPHER ECKLES ASS'T CHIEF, ENGINEERING SERVICE	BUILDING: <b>23R</b>	PROJECT NUMBER: <b>581-12-109</b>	DRAWING NUMBER: <b>E6</b>
APPROVED: JOHN KLIM CHIEF, ENGINEERING SERVICE	DRAWN: KAZI HOSSAIN	DATE: <b>MAY '12</b>	DWG. <b>7</b> OF <b>8</b>