


TOTAL 27(TWENTY SEVEN) 2X4 LIGHT FIXTURES

 **SECOND FLOOR LIGHTING PLAN**
SCALE: 1/16" = 1' - 0"

GENERAL NOTES

1. Coordinate all replacement work with Contracting Officer's Representative
2. Contractor shall remove and dispose of all existing fixtures and lamps identified
3. Contractor shall install new fixture in same location and in same mounting method as existing fixture except where noted.
4. All existing 2'x2' fixtures shown shall be replaced with fixture LF1
5. All existing 2'x4' fixtures shown shall be replaced with fixture LF2

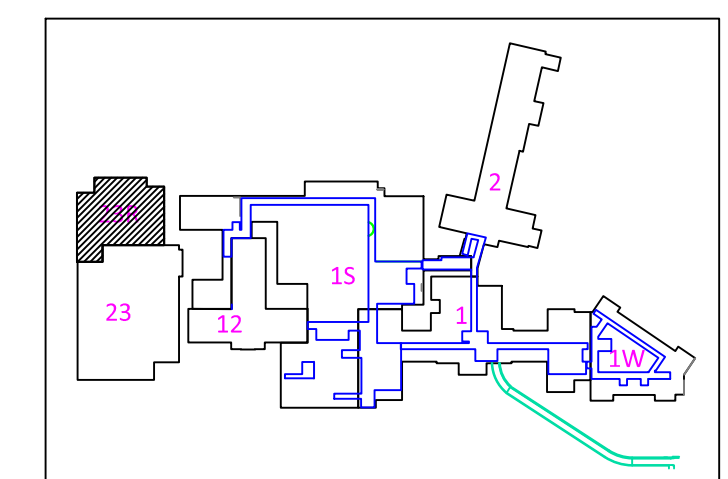

KEY PLAN
SCALE: NTS



UNITED STATES DEPARTMENT OF VETERANS AFFAIRS
VA MEDICAL CENTER - 1540 SPRING VALLEY DRIVE - HUNTINGTON WV 25704

DRAWING TITLE: 23R SECOND FLOOR LIGHTING		PROJECT TITLE: REPLACE LIGHTING PHASE 2			
APPROVED: CHRISTOPHER ECKLES ASS'T CHIEF, ENGINEERING SERVICE		BUILDING: 23R	PROJECT NUMBER: 581-12-109	DRAWING NUMBER: E7	
APPROVED: JOHN KUM CHIEF, ENGINEERING SERVICE		DRAWN: KAZI HOSSAIN	DATE: MAY '12 DWG. 8 OF 8		