



2 ENLARGED FIRST FLOOR PLAN

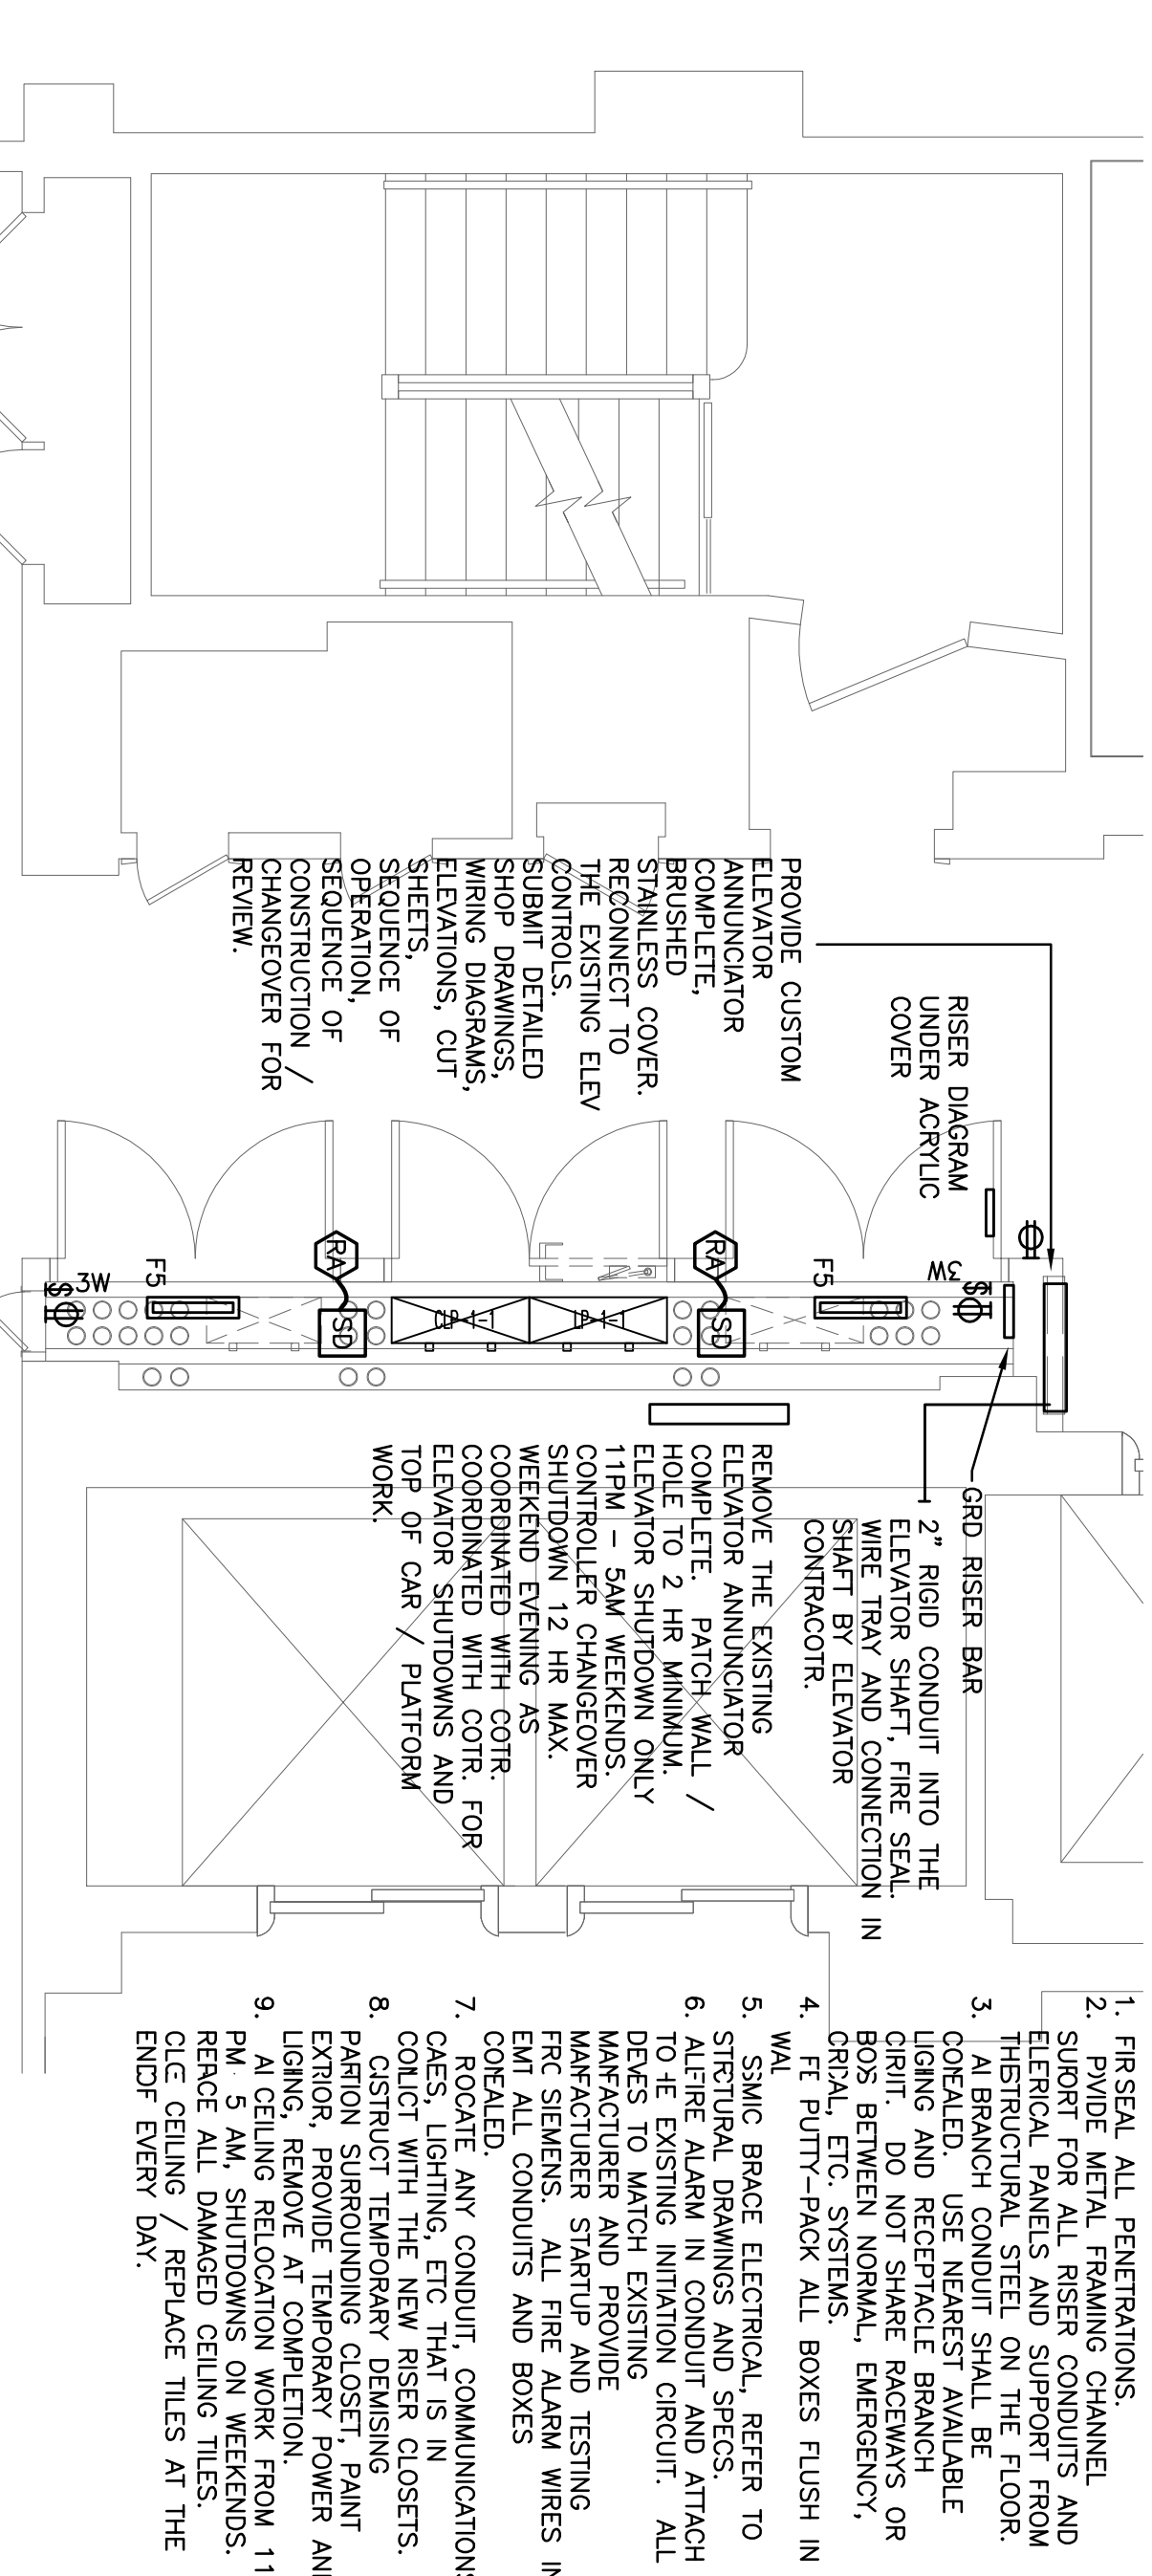


3 ENLARGED 1st FLR. ELECTRICAL PLAN

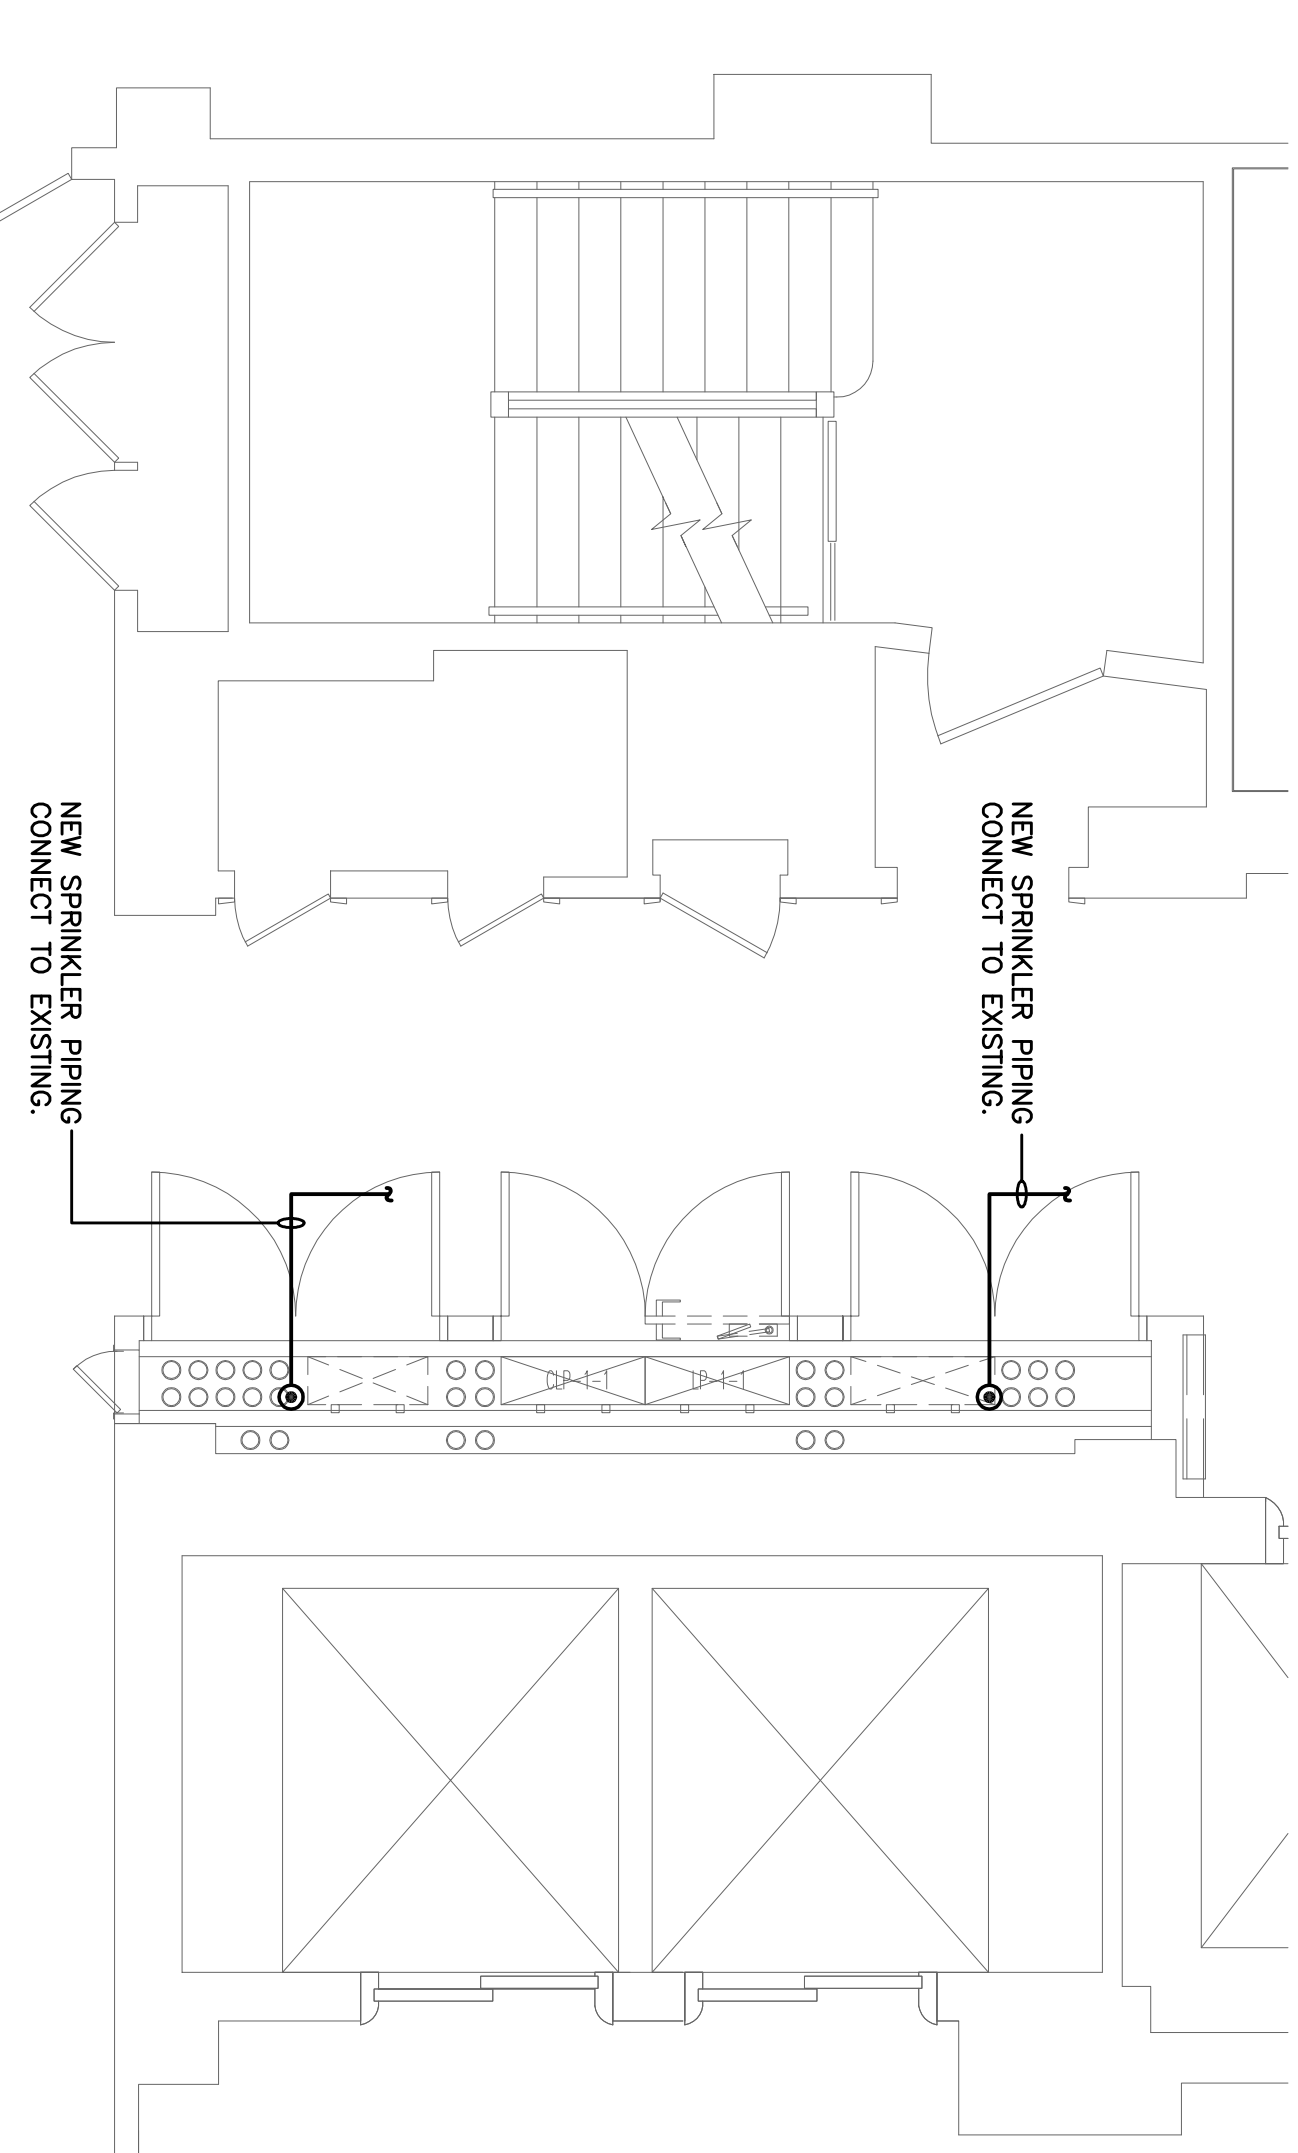

4 ENLARGED 1st FLR. FIRE PROTECTION PLAN

[illegible]

CONSULTANTS:

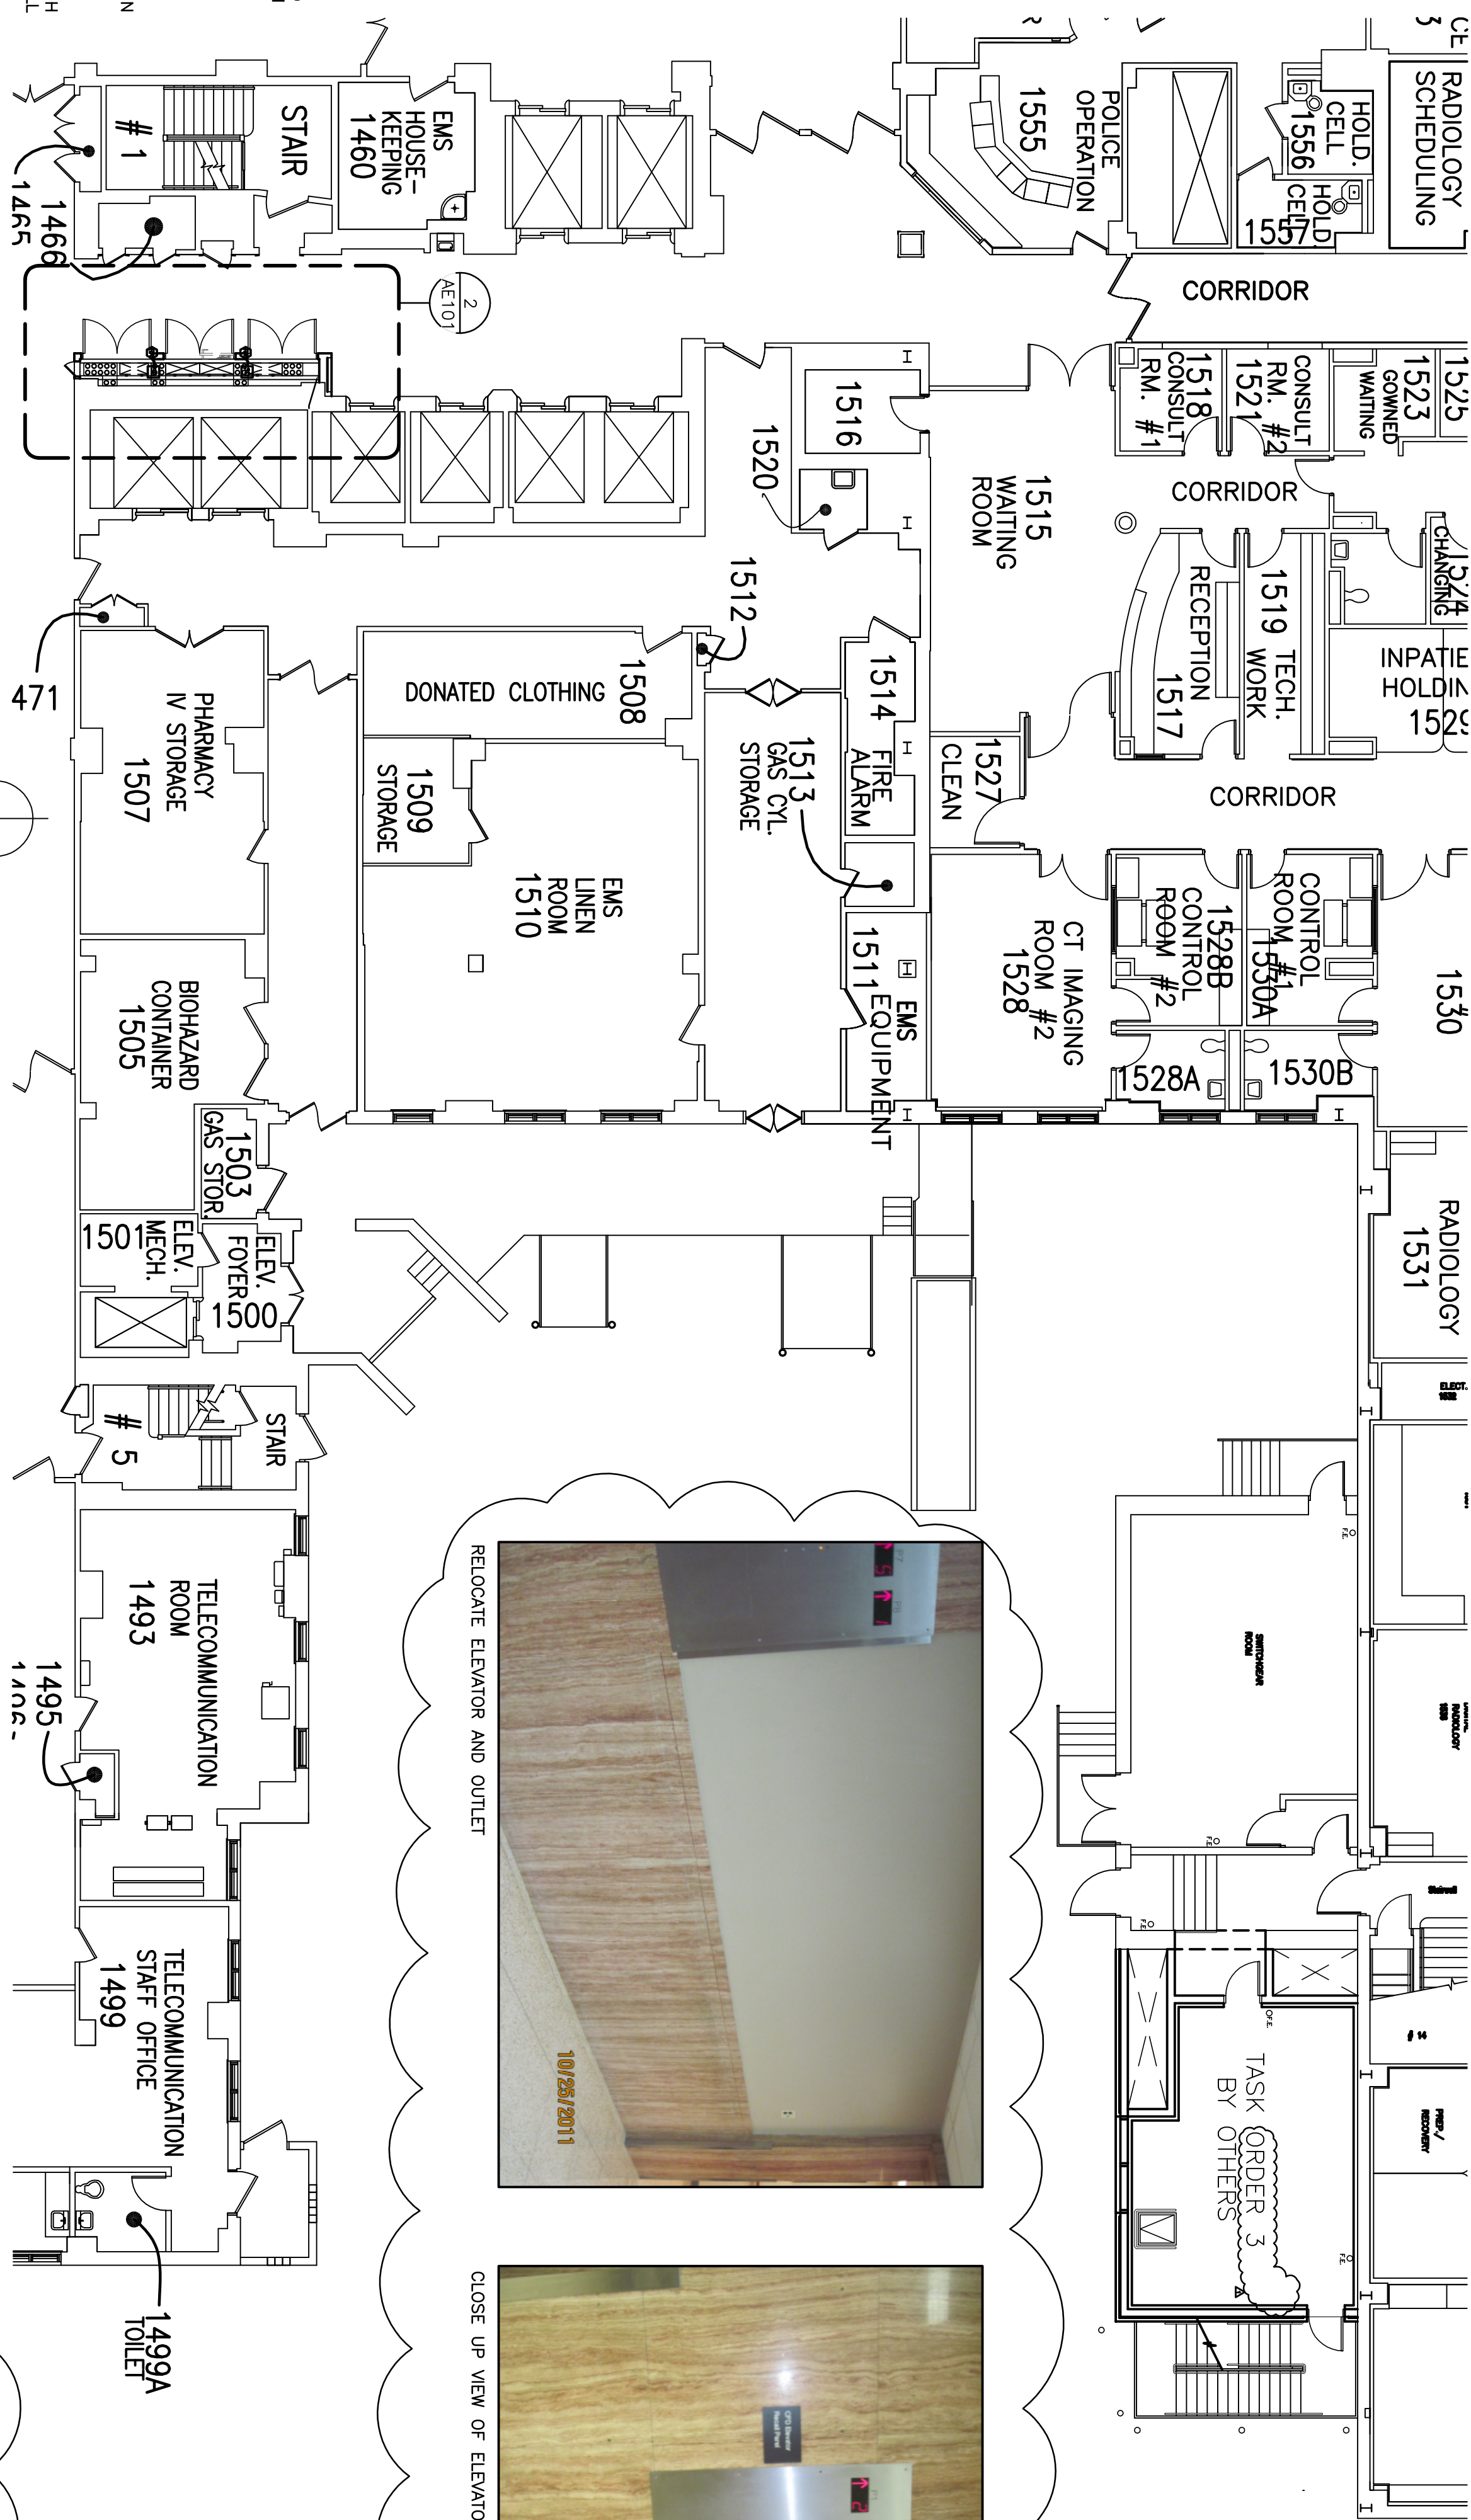


7 PARTIAL FIRST FLOOR PLAN

DOOR SCHEDULE

[illegible]

NOTE: DOOR INFORMATION SIMILAR FOR ELEC. CLOSET DOORS AT OTHER BUILDING LEVELS


5 DOOR SCHEDULE

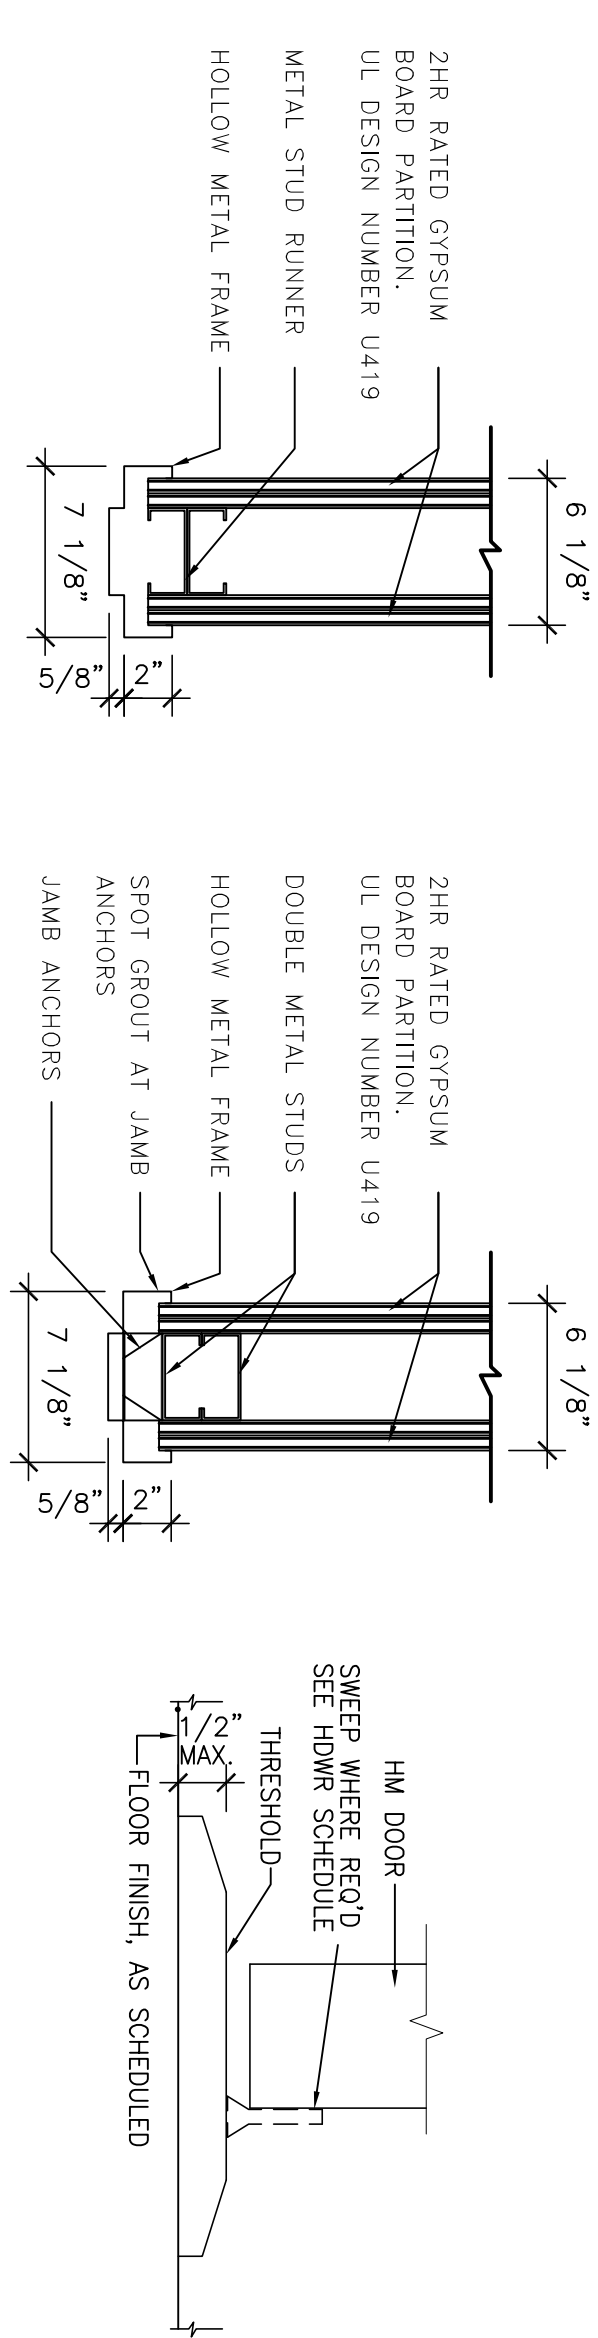

6 HEAD TYPE H1



JAMB TYPE J1
1 1/2" = 1'-0"

8 SIL TYPE ST $\epsilon^2 = 1.0^*$

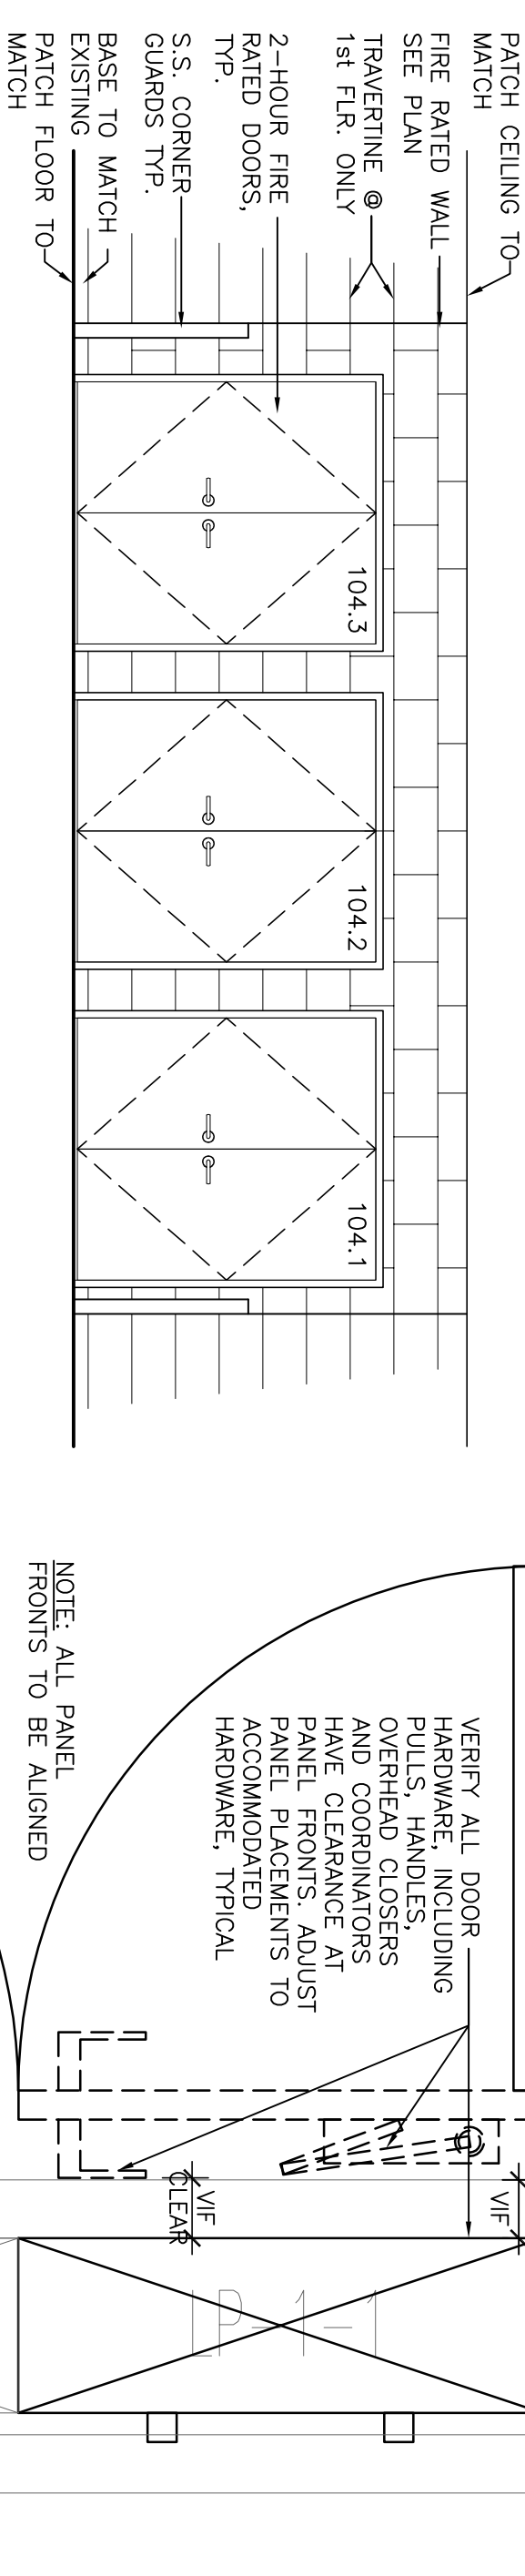

9 INTERIOR ELEVATION (TYP.)


10 TYPICAL DOOR HARDWARE CLEARANCE

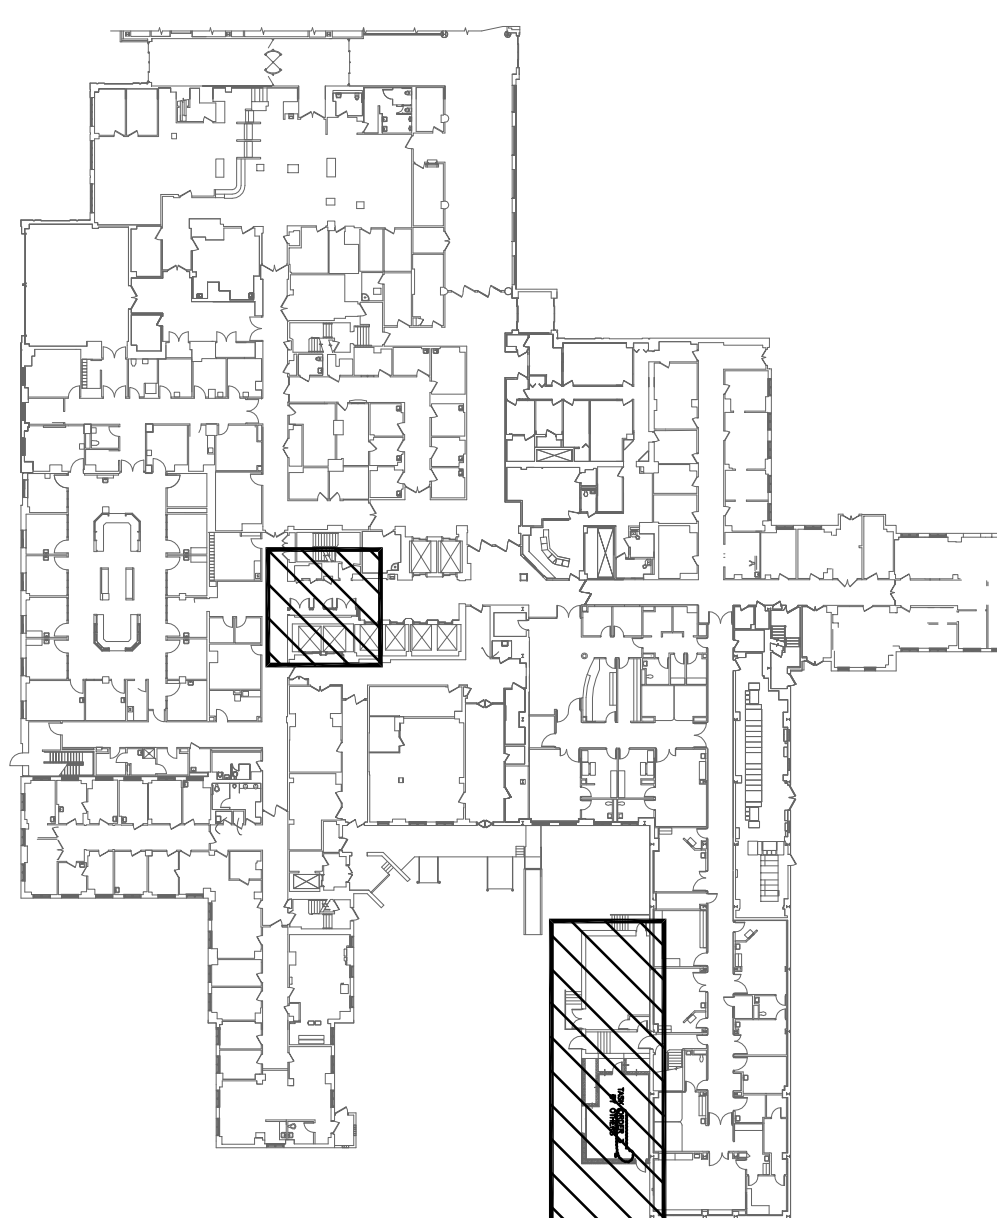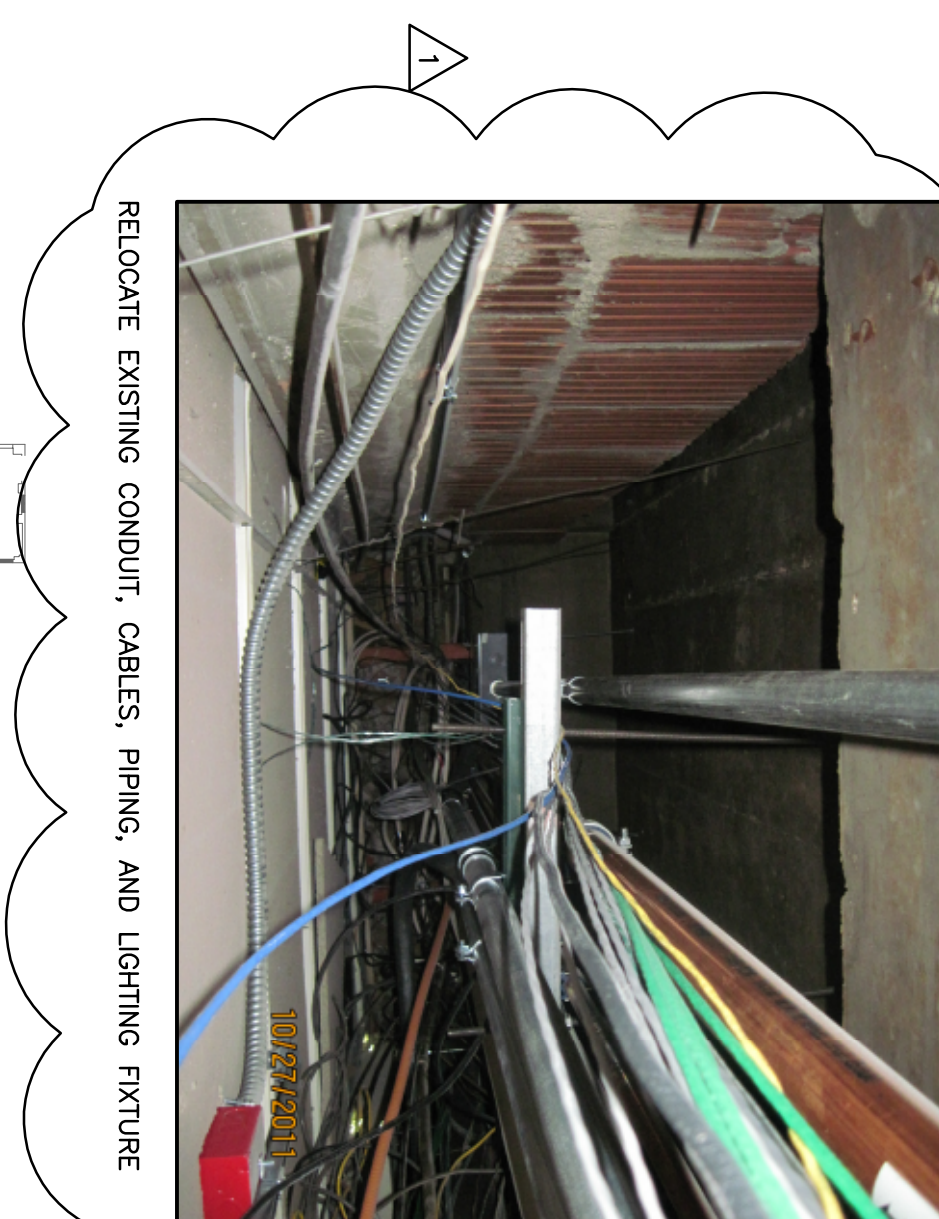

BUILDING 1 - 1st FLR. KEY PLAN

COMPLETION ITEM NO.

FULLY SPRINKLERED

Drawing Title FIRST FLOOR PLAN	Project Title EMERGENCY POWER DISTRIBUTION - BLDG 1	Project Number 537-11-139	Office of Construction and Facilities Management
		Bidding Number 1C	
Approved Project Director	Location JESSE BROWN V.A.M.C.	Drawing Number 537-1C-AE-101	 Department of Veterans Affairs
	Date FEBRUARY 1, 2012	Checked JJC	
		Drawn Dwg 3 of 7	