




## 2 ENLARGED SECOND FLOOR PLAN

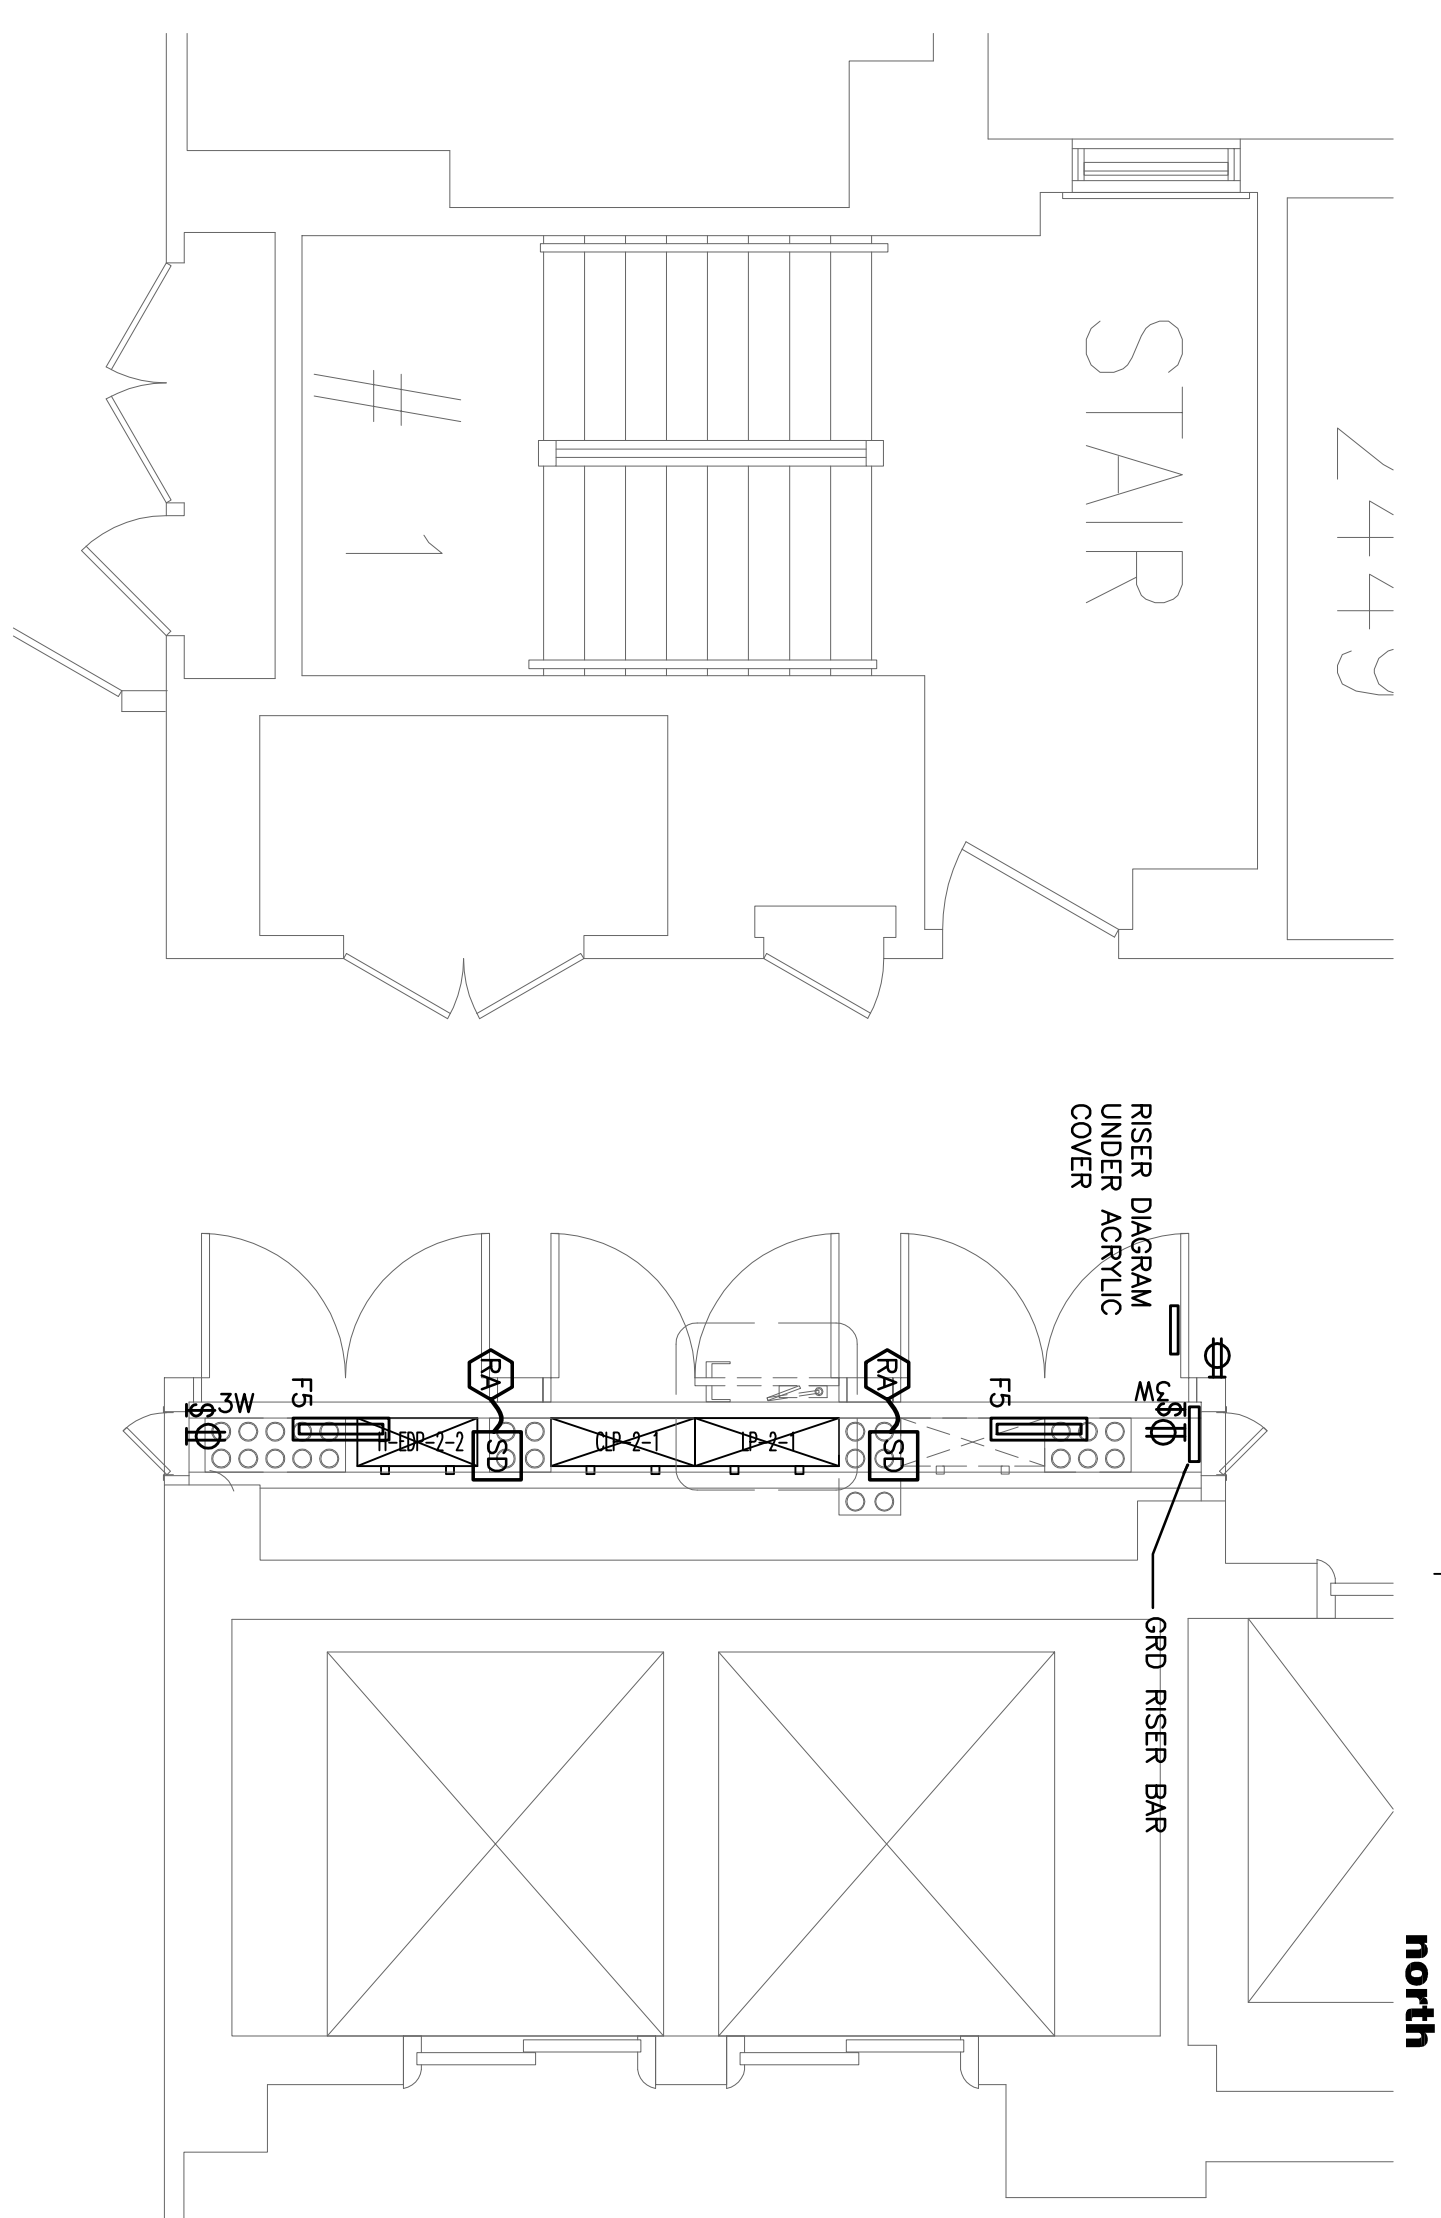

### 3 ENLARGED 2nd FLR. ELECTRICAL PLAN

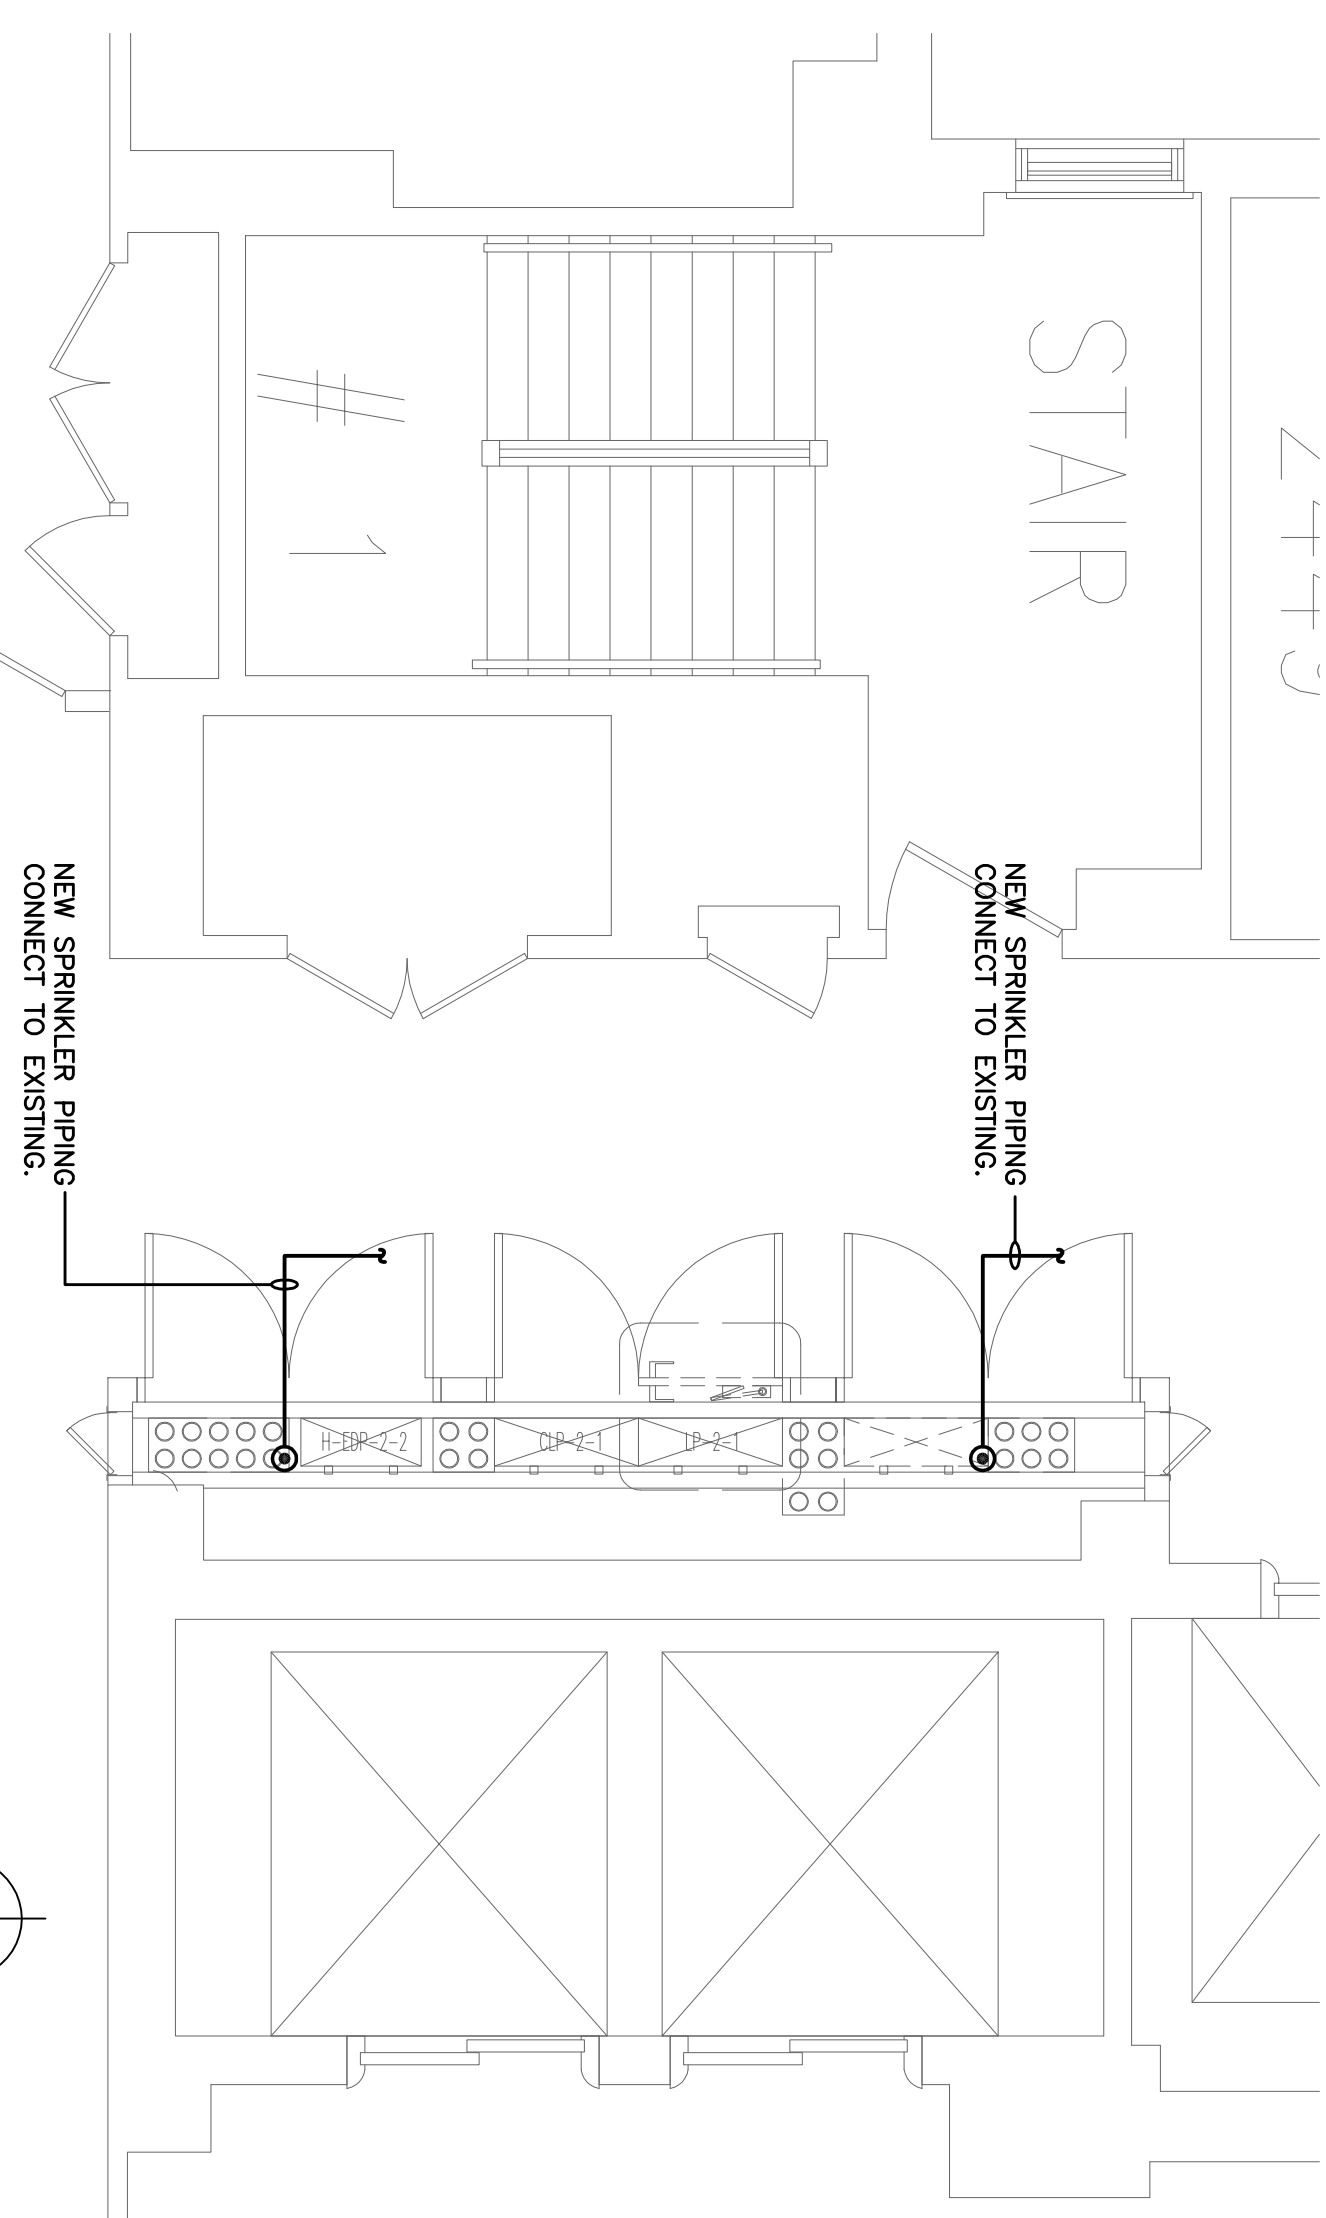

#### 4 ENLARGED 2ND FLR. FIRE PROTECTION PLAN

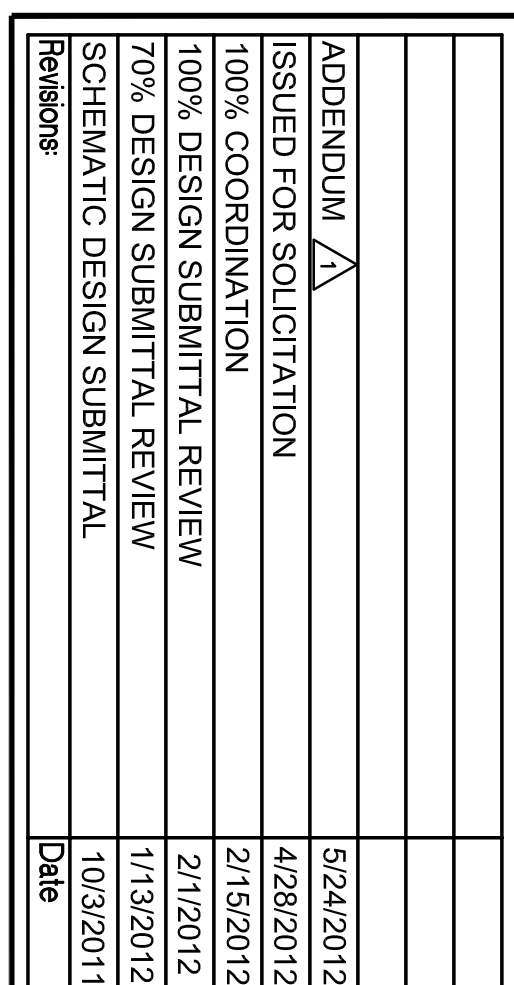

CONSULTANTS:

ARCHITECT/ENGINEERS:

**TENG**  
TENG & ASSOCIATES, INC.  
ENGINEERS/ARCHITECTS/P.L.L.C.  
205 N. MICHIGAN AVE. CHICAGO, IL 60601  
TELEPHONE: 312/616-0000

**TENG & ASSOCIATES, INC.**  
ENGINEERS/ARCHITECTS/PLANNERS  
205 N. MICHIGAN AVE. CHICAGO, IL 60601  
TELEPHONE: 312/616-0000

Drawing Title  
SECOND FLOOR PLAN

Project Title	EMERGENCY POWER
---------------	-----------------


Project Number	537-11-139
----------------	------------

COMPLETION ITEM NO. FULLY SPRINKLERED


## BUILDING 1 - 2nd FLR. KEY PLAN

---

N.T.S

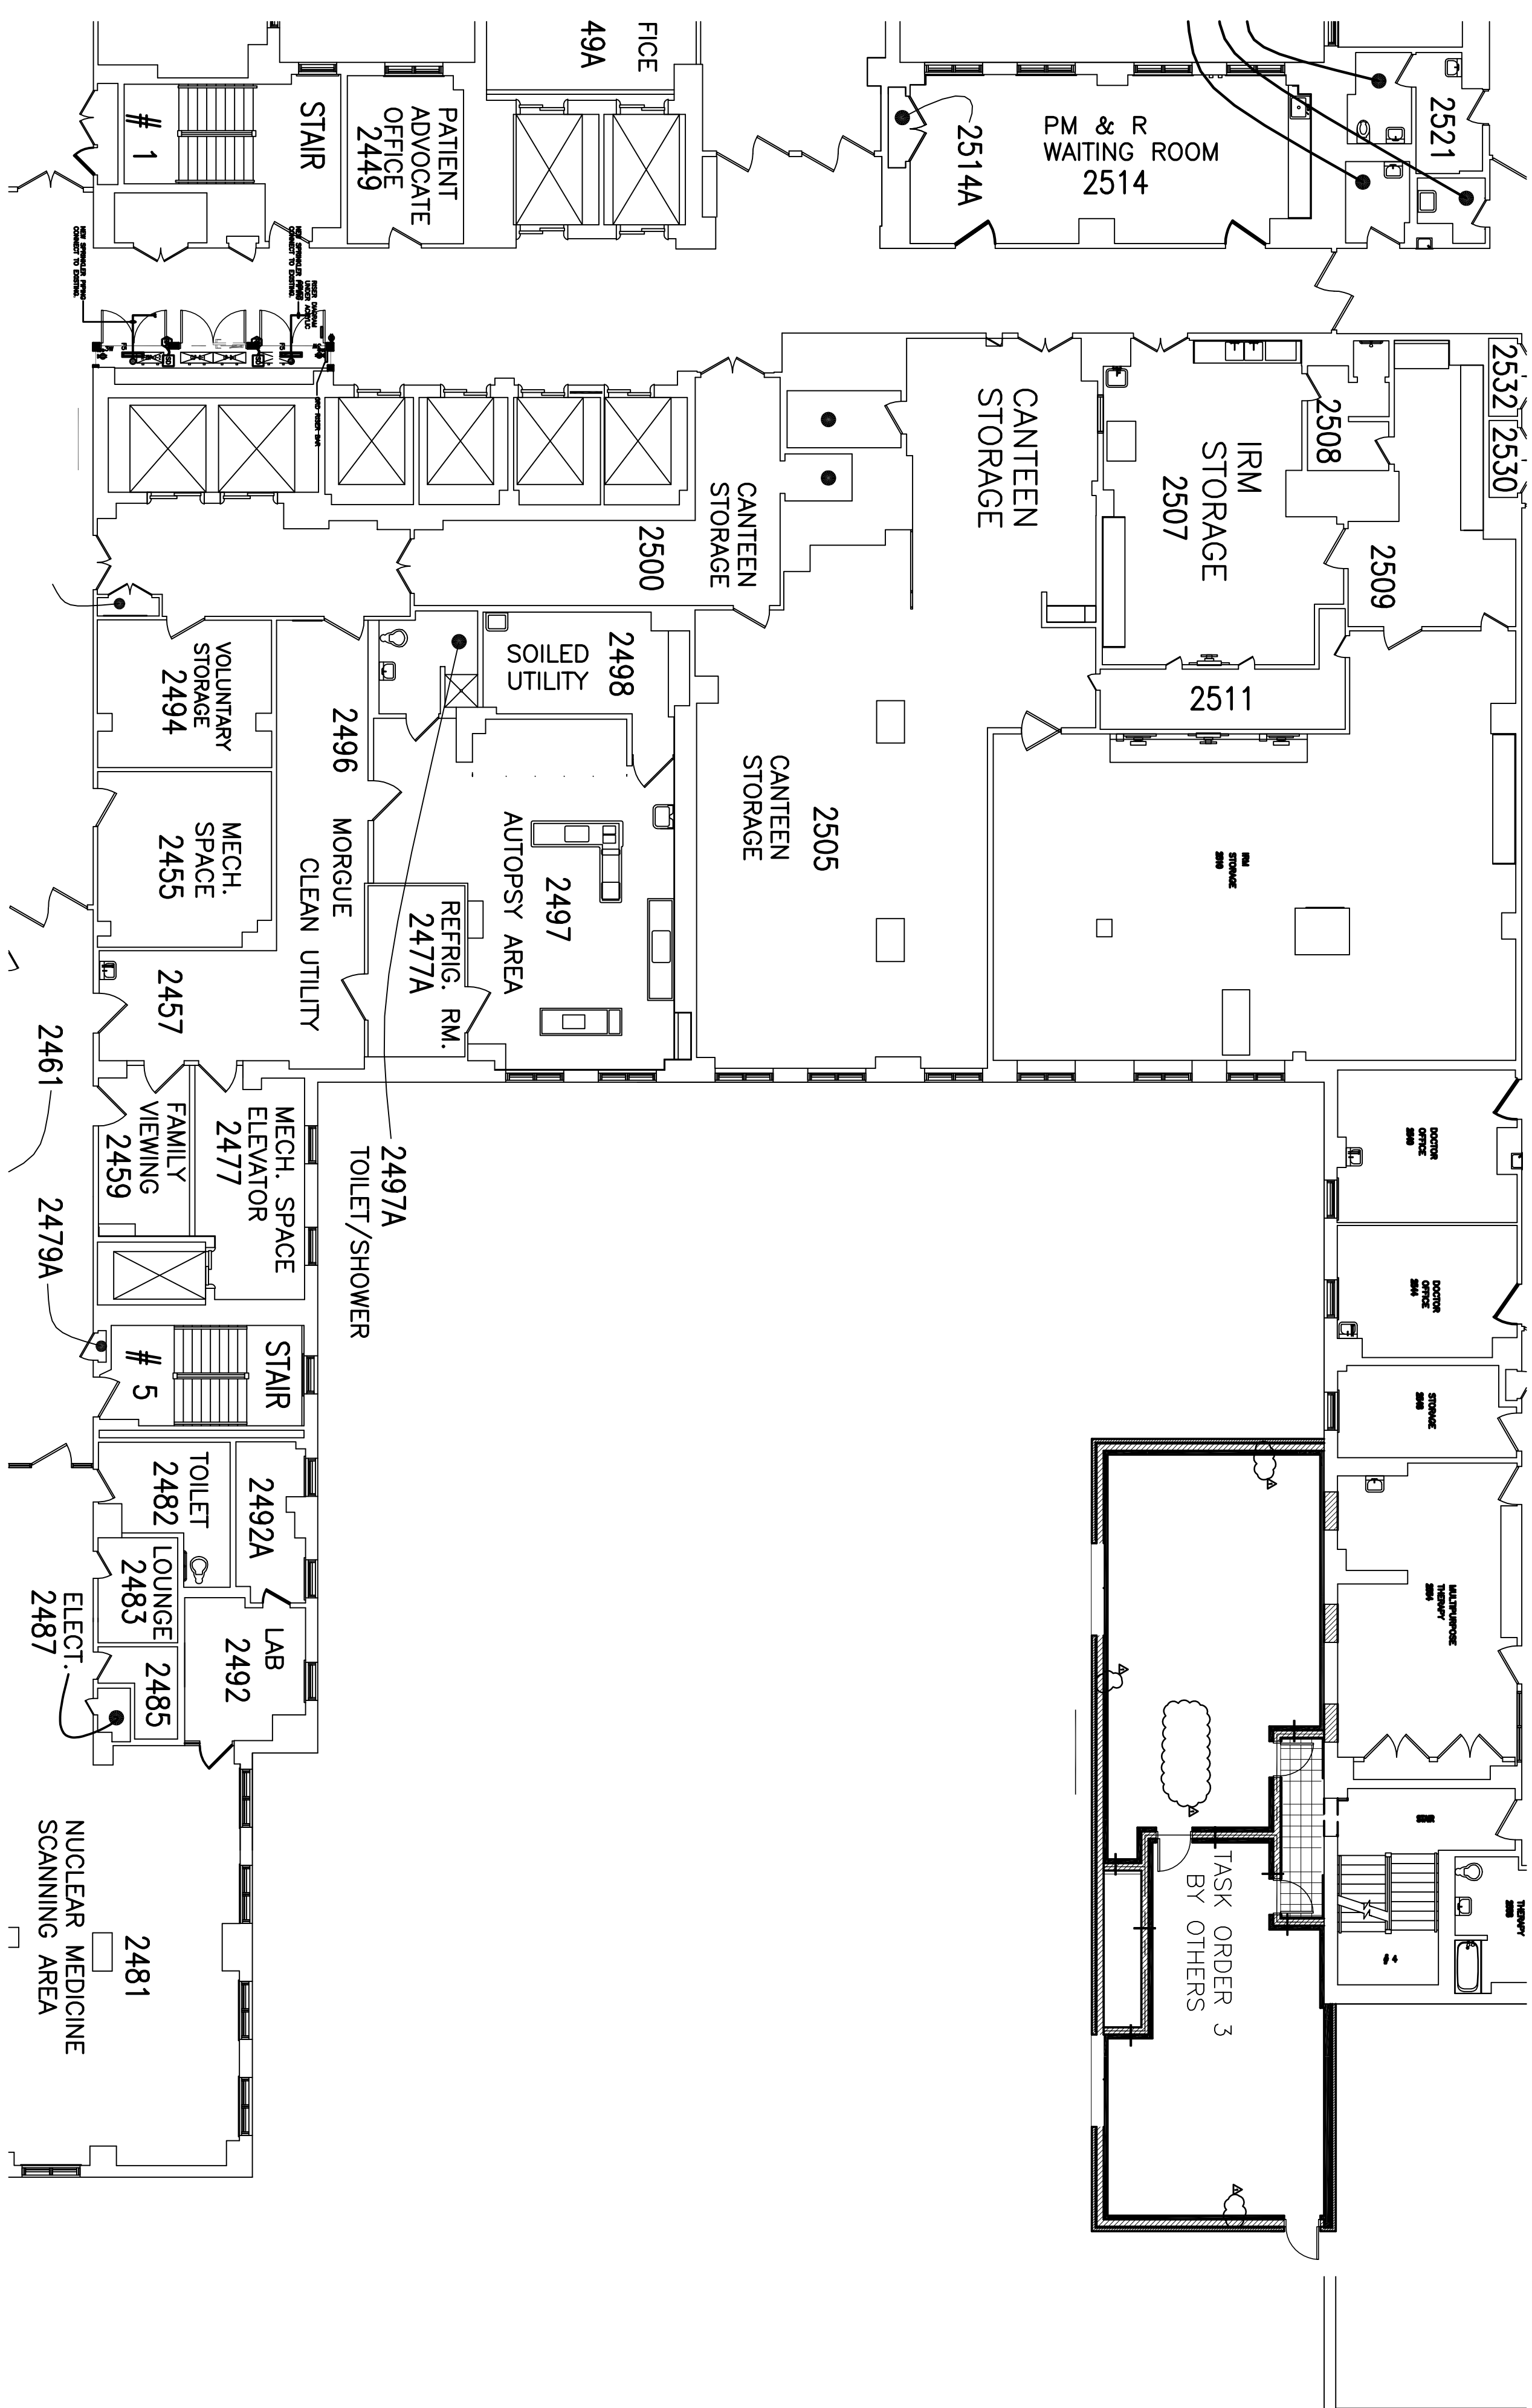

## 1 PARTIAL SECOND FLOOR PLAN

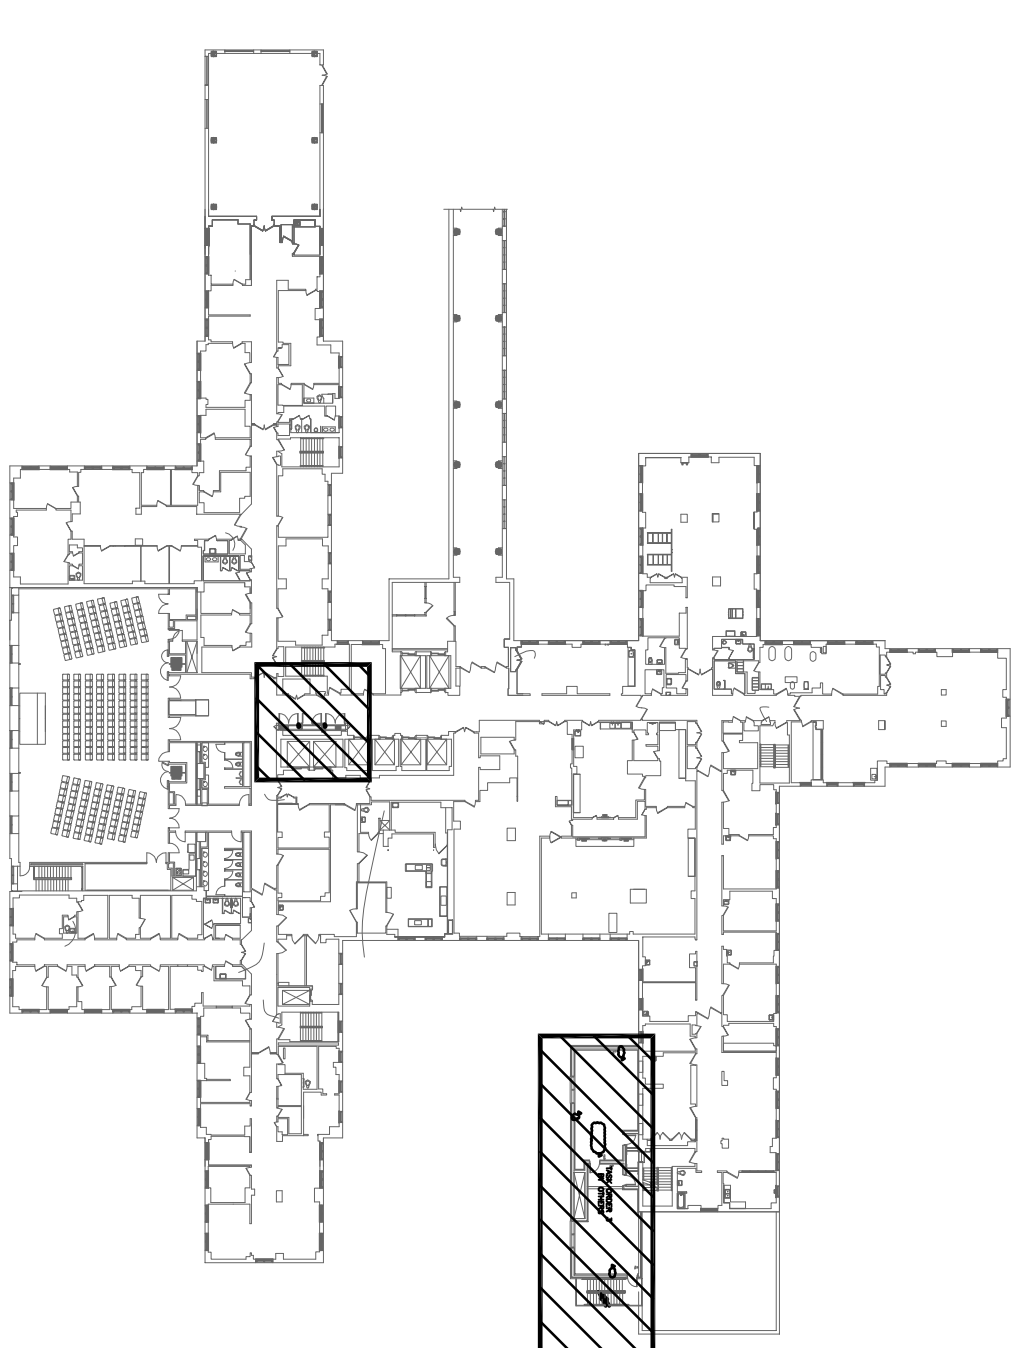

## BUILDING 1 - 2nd FLR. KEY PLAN

COMPLETION ITEM NO.

## FULLY SPRINKLERED

Drawing Title  
SECOND FLOOR PLAN

Project Title	EMERGENCY POWER
---------------	-----------------

Project Number	537-11-139
----------------	------------

Approved: Project Director

Location	JESSE BROWN V A.M.C.
----------	----------------------

— 11 —

Drawing Number	
----------------	--

Office of  
Construction  
and Facilities  
Management

 Department of  
Veterans Affairs