

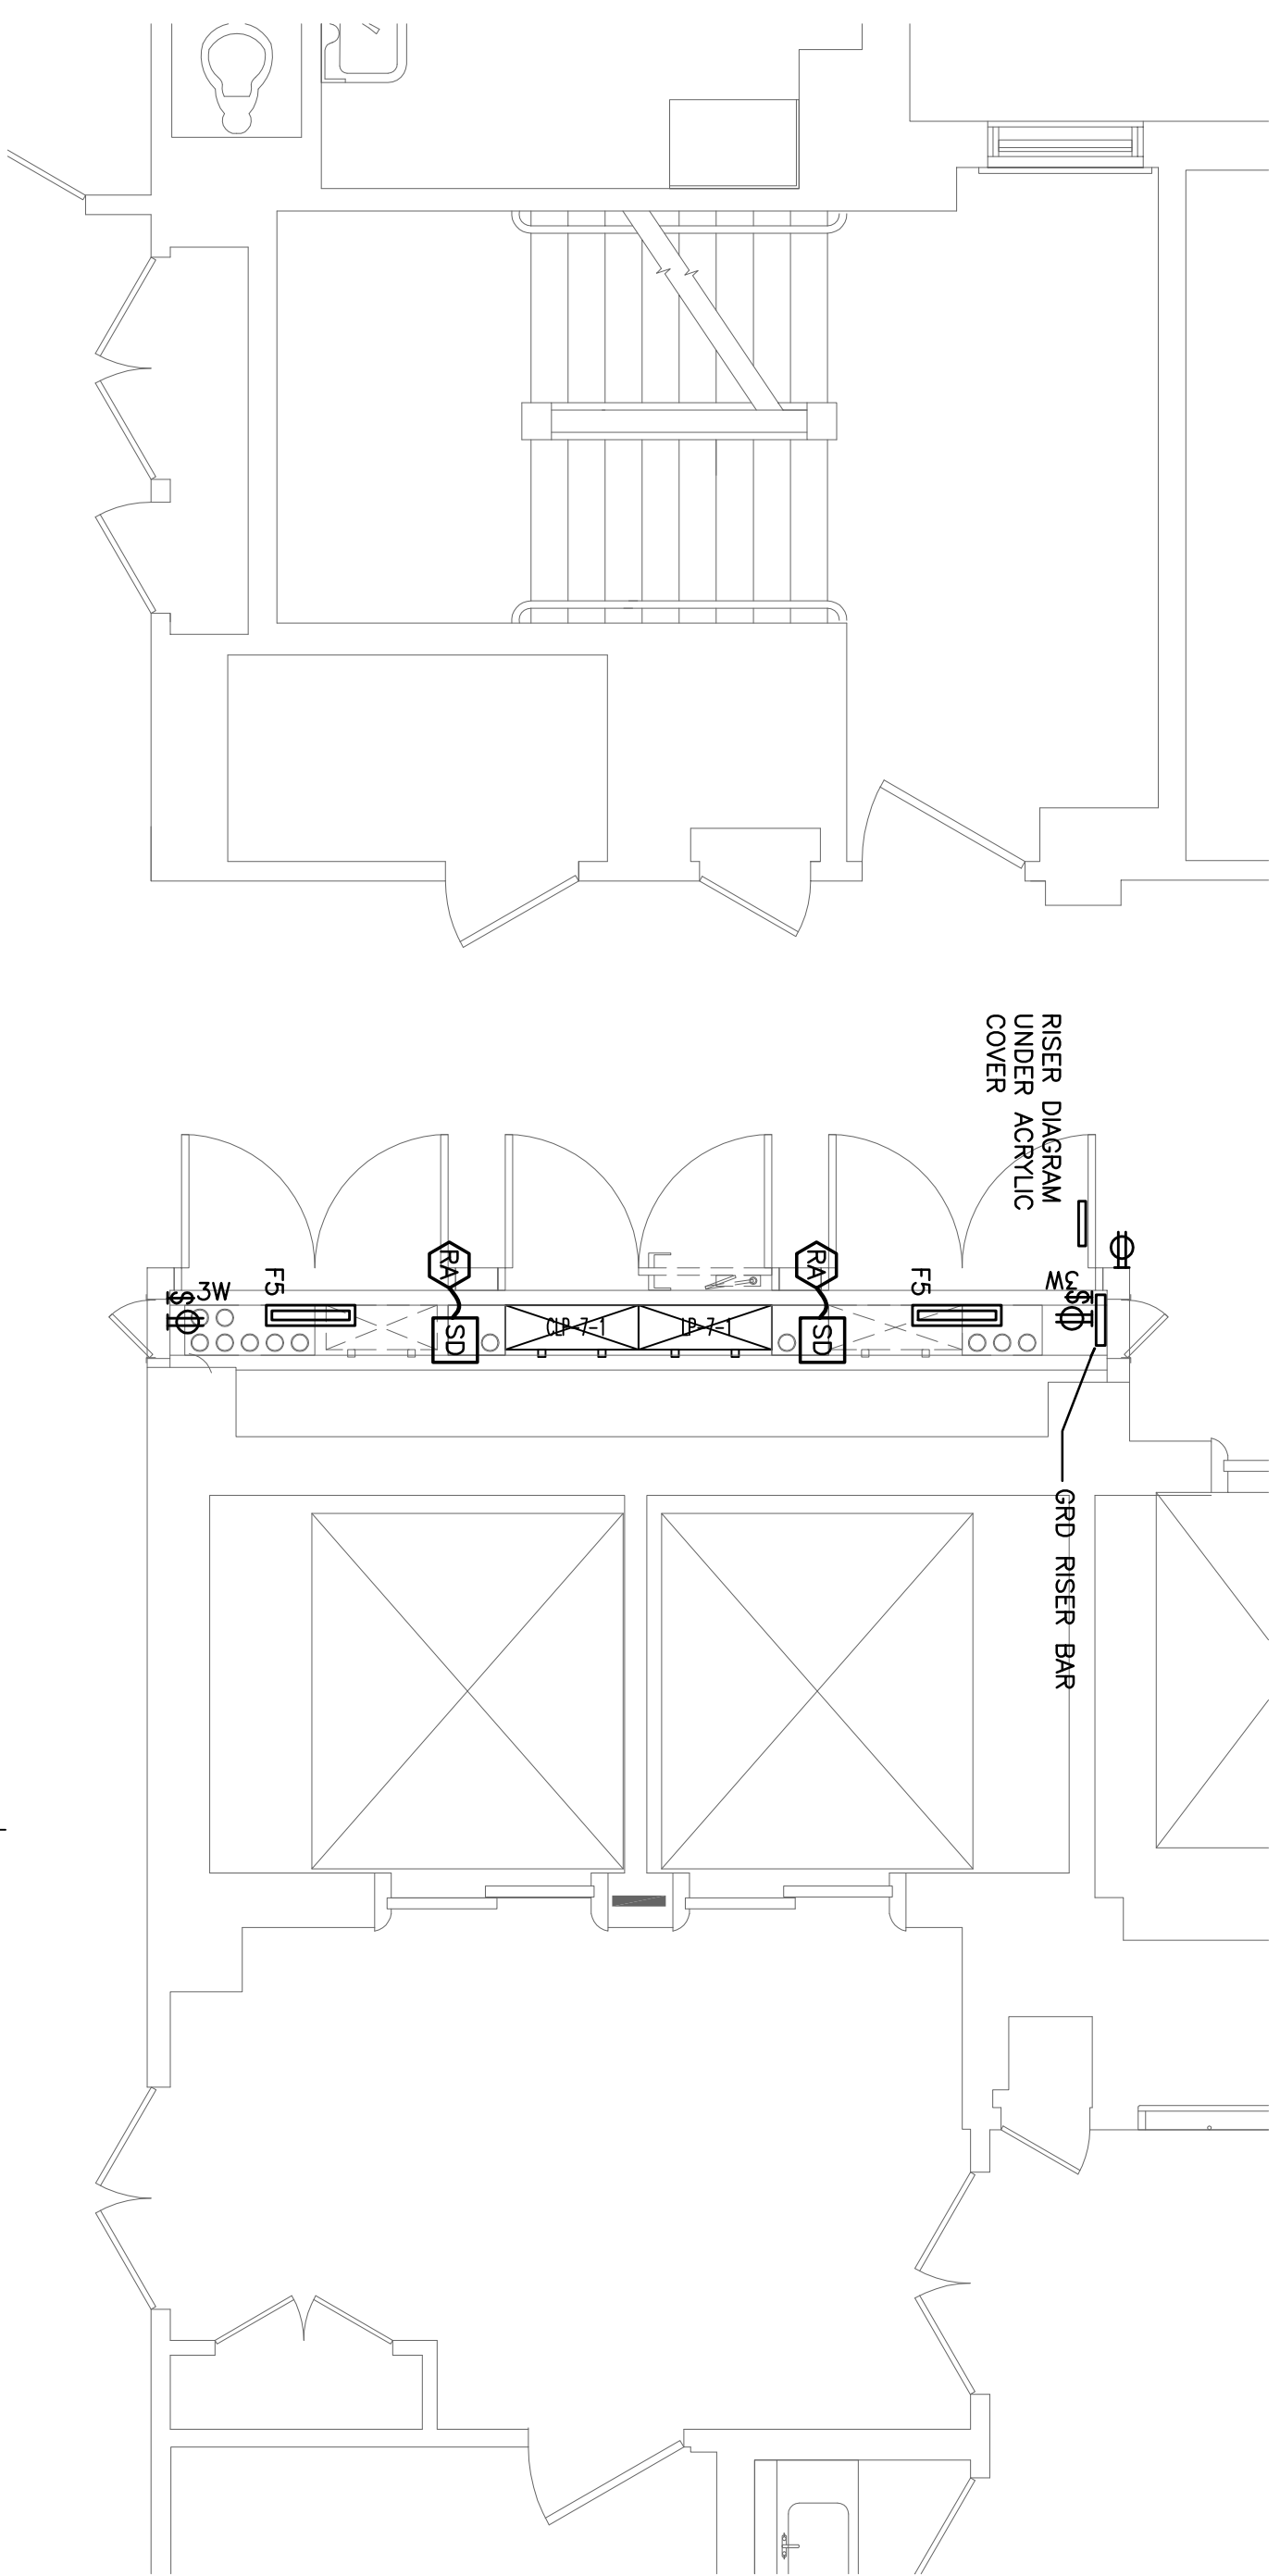
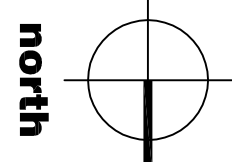



## 1 ENLARGED SEVENTH FLOOR PLAN

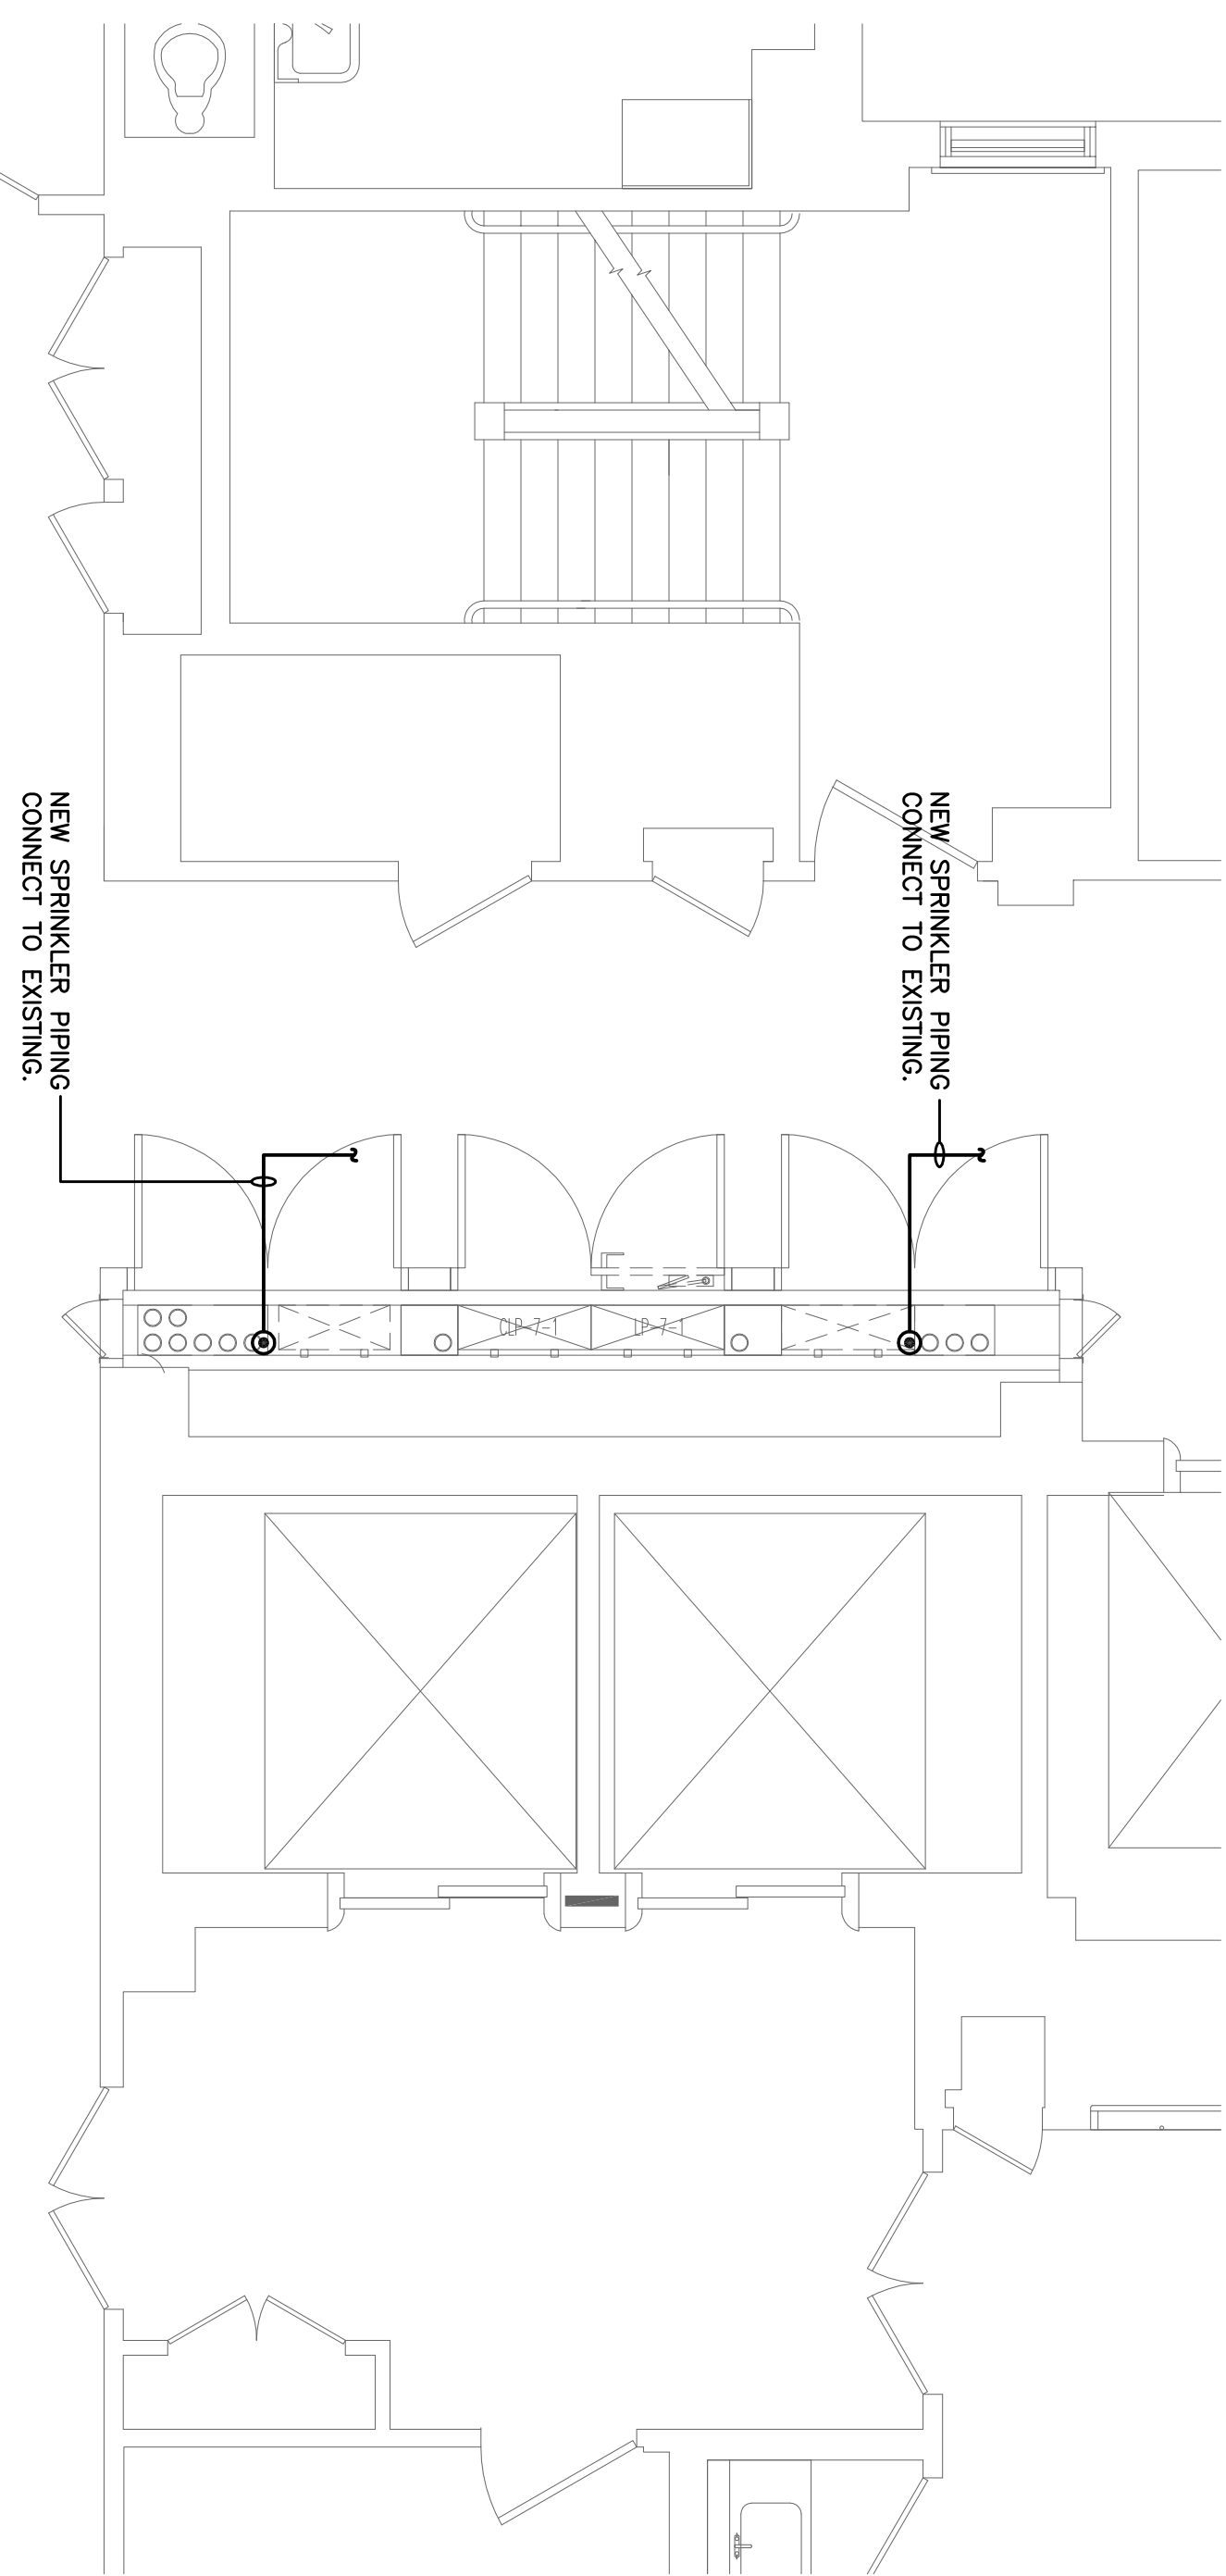


## 2 ENLARGED 7th FLR. ELECTRICAL PLAN

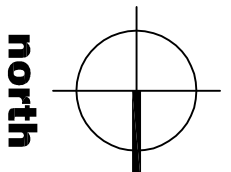


### 3 ENLARGED 7th FLR. FIRE PROTECTION PLAN

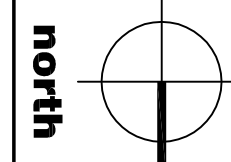[illegible]

Drawing Title <b>SEVENTH FLOOR PLAN</b>	Project Title <b>EMERGENCY POWER DISTRIBUTION - BLDG 1</b>	Project Number <b>537-11-139</b>	Office of Construction and Facilities Management
		Building Number <b>1C</b>	
Approved Project Director	Location <b>JESSE BROWN V.A.M.C.</b>	Drawing Number <b>537-1C-AE-107</b>	Department of Waterfronts
	Date <b>FEBRUARY 1, 2012</b>	Checked <b>JJC</b> Drawn <b>JJC</b> Date <b>Aug 9 of 17</b>	

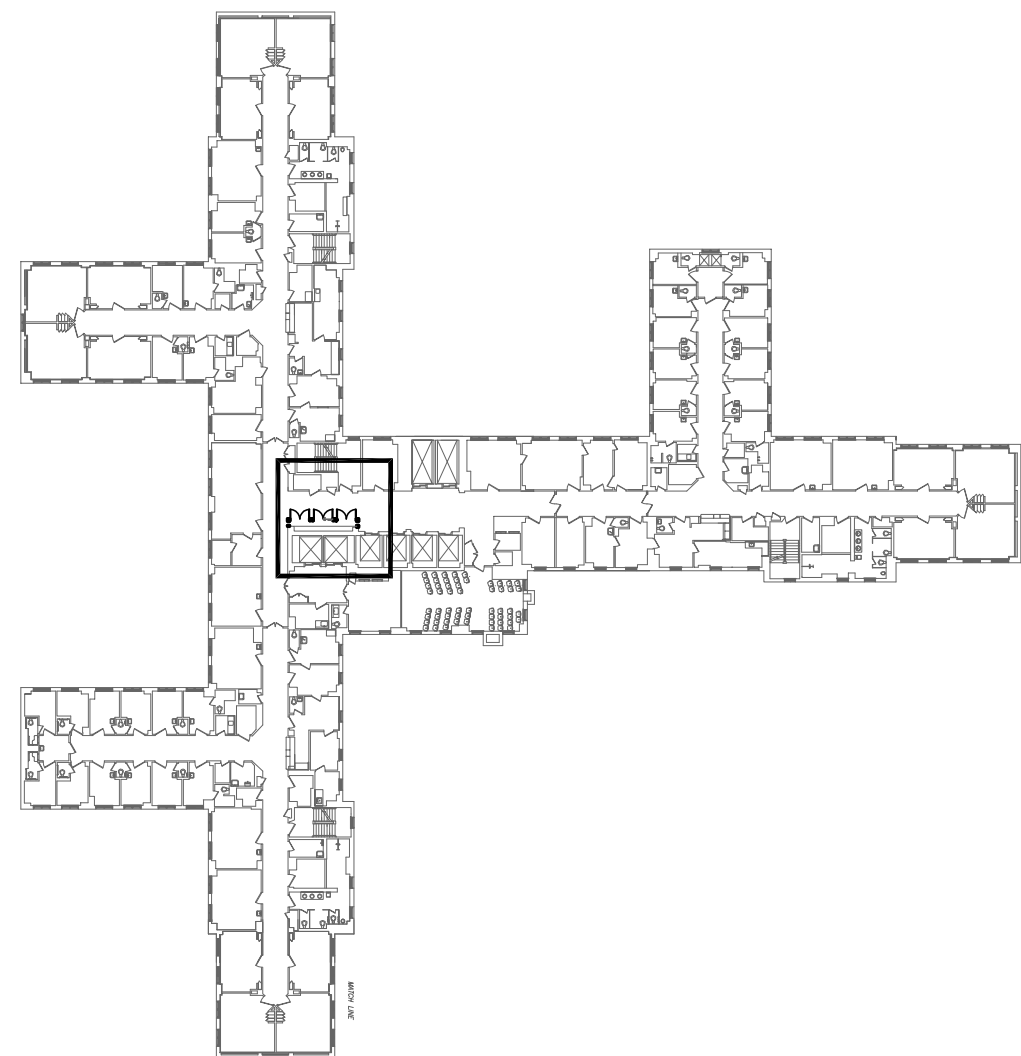

**BUILDING 1 - 7th FLR. KEY PLAN**

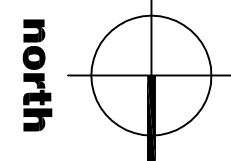

COMPLETION ITEM NO.

## FULLY SPRINKLERED



RELOCATE EXISTING CONDUIT, CABLES, PIPING,



RELOCATE EXISTING LIGHTING FIXTURE AND RECEPTACLES