

Frontal View

70" x 116" Capri Blue New VA Logo
Fabricated Aluminum Metal Logo with
Blue Translucent Face and
Internal Illuminated LED Lighting

30" Helvetica Bold Capri Blue
Fabricated Aluminum Metal Letters with
Blue Translucent Face and
Internal Illuminated LED Lighting

VAMC Dallas, TX		
Scale:	Designer: John T. Mayer	Drawn By: MEA
Date: 5.03.2016	Revised: 06.07.2016	
Type: Illuminated Channel Letters/Logo		


 
Note: All drawings, notations and design themes expressed herein remain the sole property of Creative Signage Systems and may not be reproduced without written consent.



CREATIVE SIGNAGE SYSTEMS

9101 51st PLACE COLLEGE PARK, MARYLAND 20740
 PHONE 301.345.3700 FAX 301.220.0289 WWW.CREATIVESIGNAGE.COM

North & South Elevations - Loc. AA, AA1

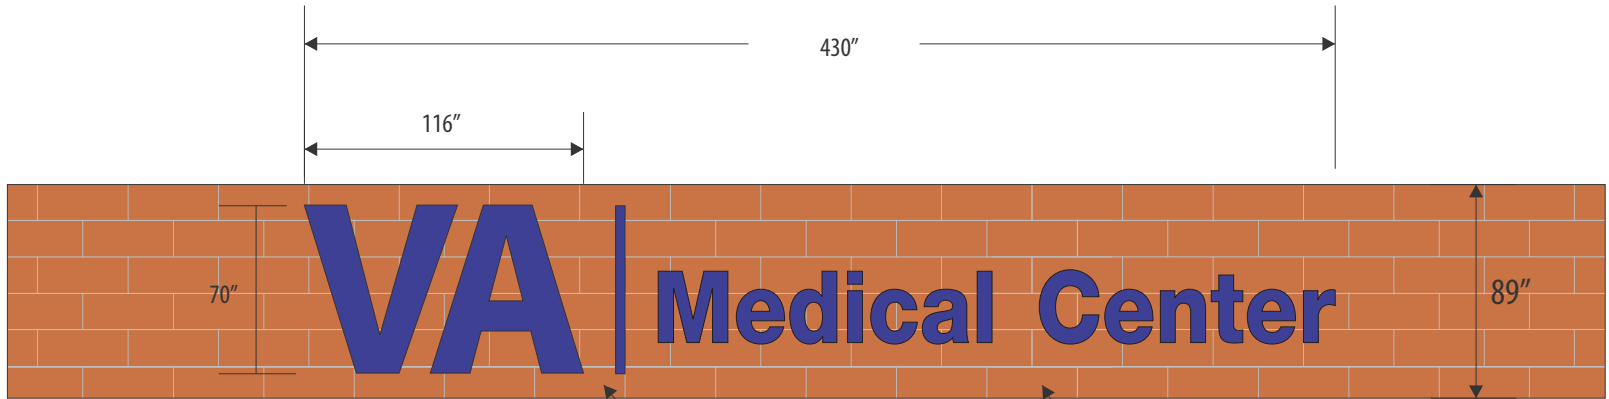

Frontal View

Side View

70" x 116" Capri Blue New VA Logo
Fabricated Aluminum Metal Logo with
Blue Translucent Face and
Internal Illuminated LED Lighting

30" Helvetica Bold Capri Blue
Fabricated Aluminum Metal Letters with
Blue Translucent Face and
Internal Illuminated LED Lighting

West Elevation - Loc. A

VAMC Dallas, TX

Scale: 1:80 Designer: John T. Mayer Drawn By: MEA


Date: 5.03.2016 Revised: 06.07.2016

Type: Illuminated Channel Letters/Logo

CREATIVE SIGNAGE SYSTEMS

9101 51st PLACE COLLEGE PARK, MARYLAND 20740
PHONE 301.345.3700 FAX 301.220.0289 WWW.CREATIVESIGNAGE.COM


Note: All drawings, notations and design themes expressed herein remain the sole property of Creative Signage Systems and may not be reproduced without written consent.

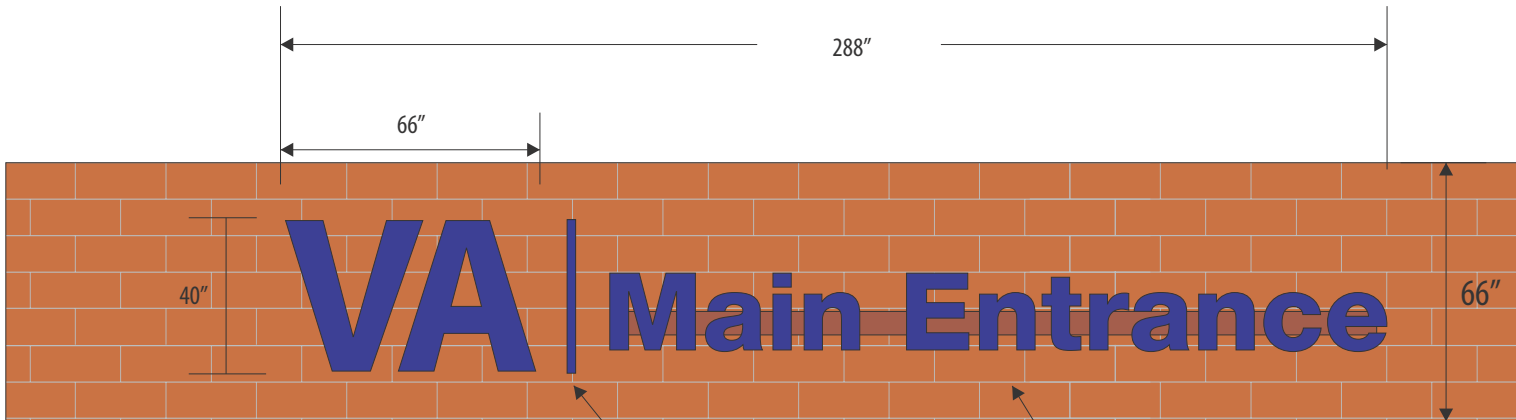

Frontal View
Not to VA scale ratio

40" x 66" Capri Blue New VA Logo
 Fabricated Aluminum Metal Logo with
 Blue Translucent Face and
 Internal Illuminated LED Lighting

 20" Helvetica Bold Capri Blue
 Fabricated Aluminum Metal Letters with
 Blue Translucent Face and
 Internal Illuminated LED Lighting




Side View

VAMC Dallas, TX		
Scale: 1:50	Designer: John T. Mayer	Drawn By: MEA
Date: 5.03.2016	Revised: 06.07.2016	
Type: Illuminated Channel Letters/Logo		



CREATIVE SIGNAGE SYSTEMS
 9101 51st PLACE COLLEGE PARK, MARYLAND 20740
 PHONE 301.345.3700 FAX 301.220.0289 WWW.CREATIVESIGNAGE.COM

Loc. AB1, AB2 & AB3

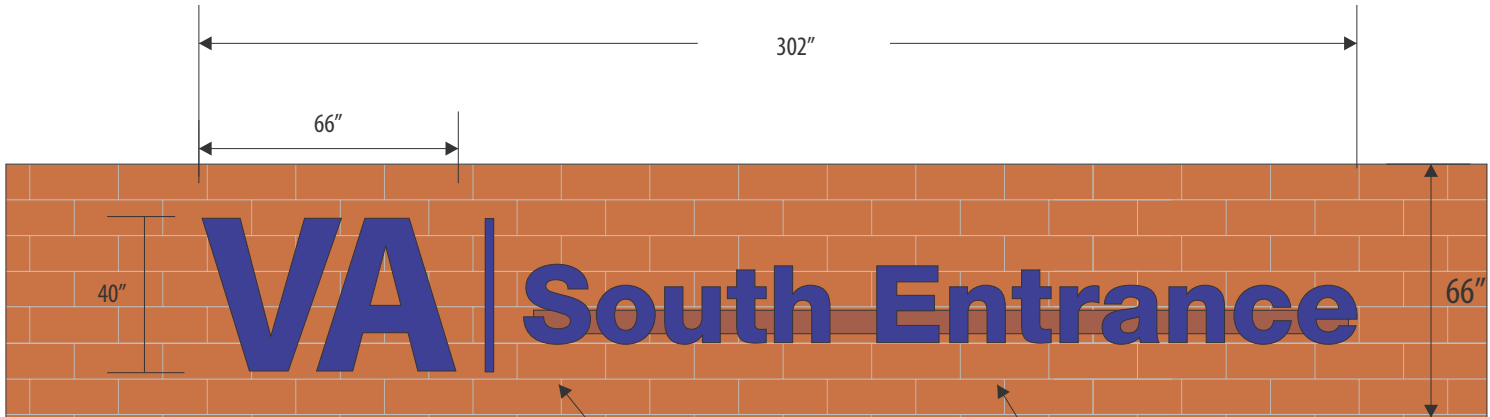


Frontal View

Not to VA scale ratio

40" x 66" Capri Blue New VA Logo
Fabricated Aluminum Metal Logo with
Blue Translucent Face and
Internal Illuminated LED Lighting

 20" Helvetica Bold Capri Blue
Fabricated Aluminum Metal Letters with
Blue Translucent Face and
Internal Illuminated LED Lighting



Side View


VAMC Dallas, TX		
Scale: 1:50	Designer: John T. Mayer	Drawn By: MEA
Date: 5.03.2016	Revised: 06.07.2016	
Type: Illuminated Channel Letters/Logo		

CREATIVE SIGNAGE SYSTEMS
9101 51st PLACE COLLEGE PARK, MARYLAND 20740
PHONE 301.345.3700 FAX 301.220.0289 WWW.CREATIVESIGNAGE.COM


Note: All drawings, notations and design themes expressed herein remain the sole property of Creative Signage Systems and may not be reproduced without written consent.

Scale: 1"=16'



NORTH ELEVATION Loc. AA

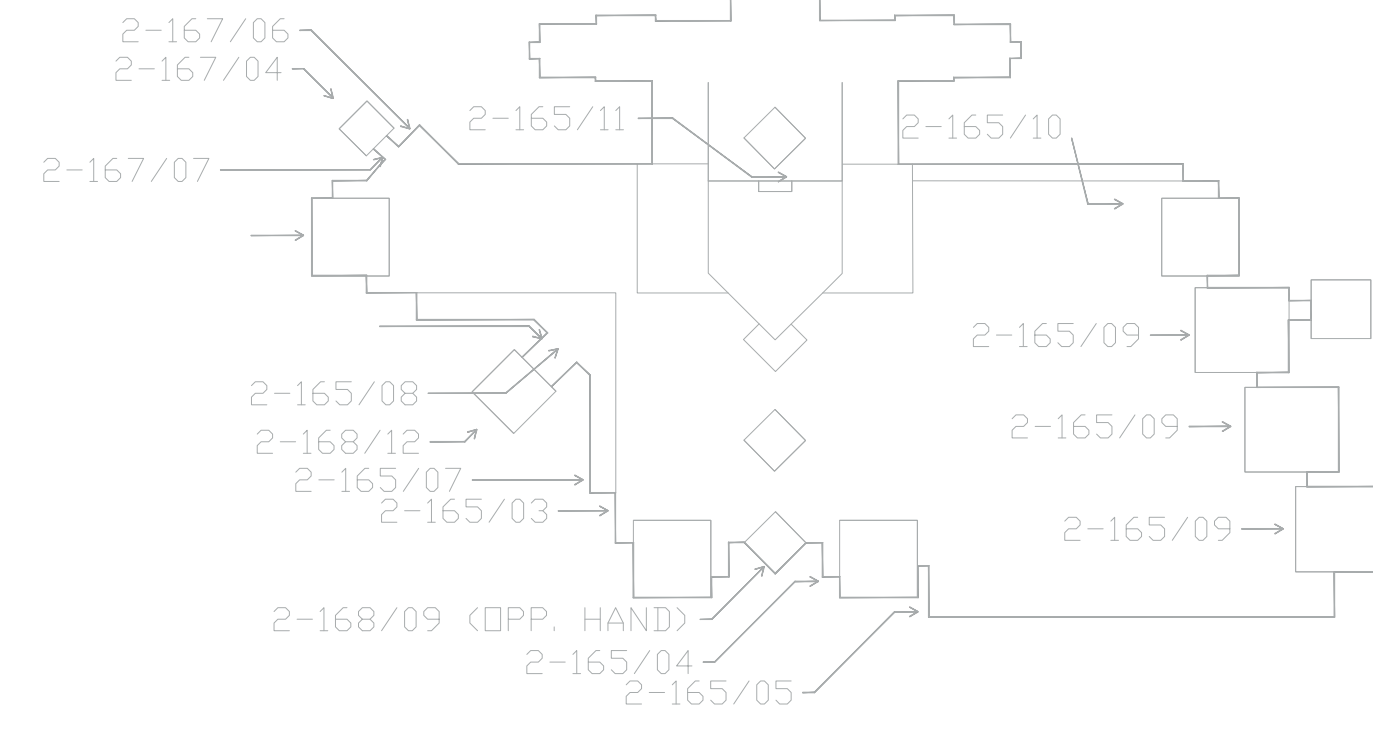

2-165|02 KEY PLAN
NOT TO SCALE

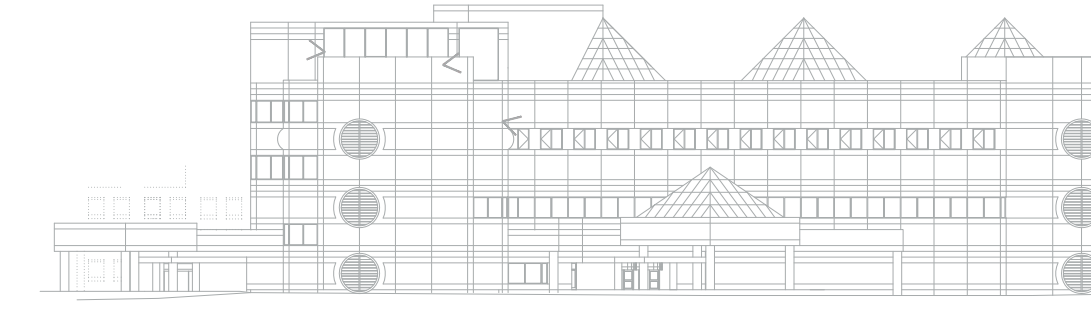



2-165|01 KEY ELEVATION
NOT TO SCALE

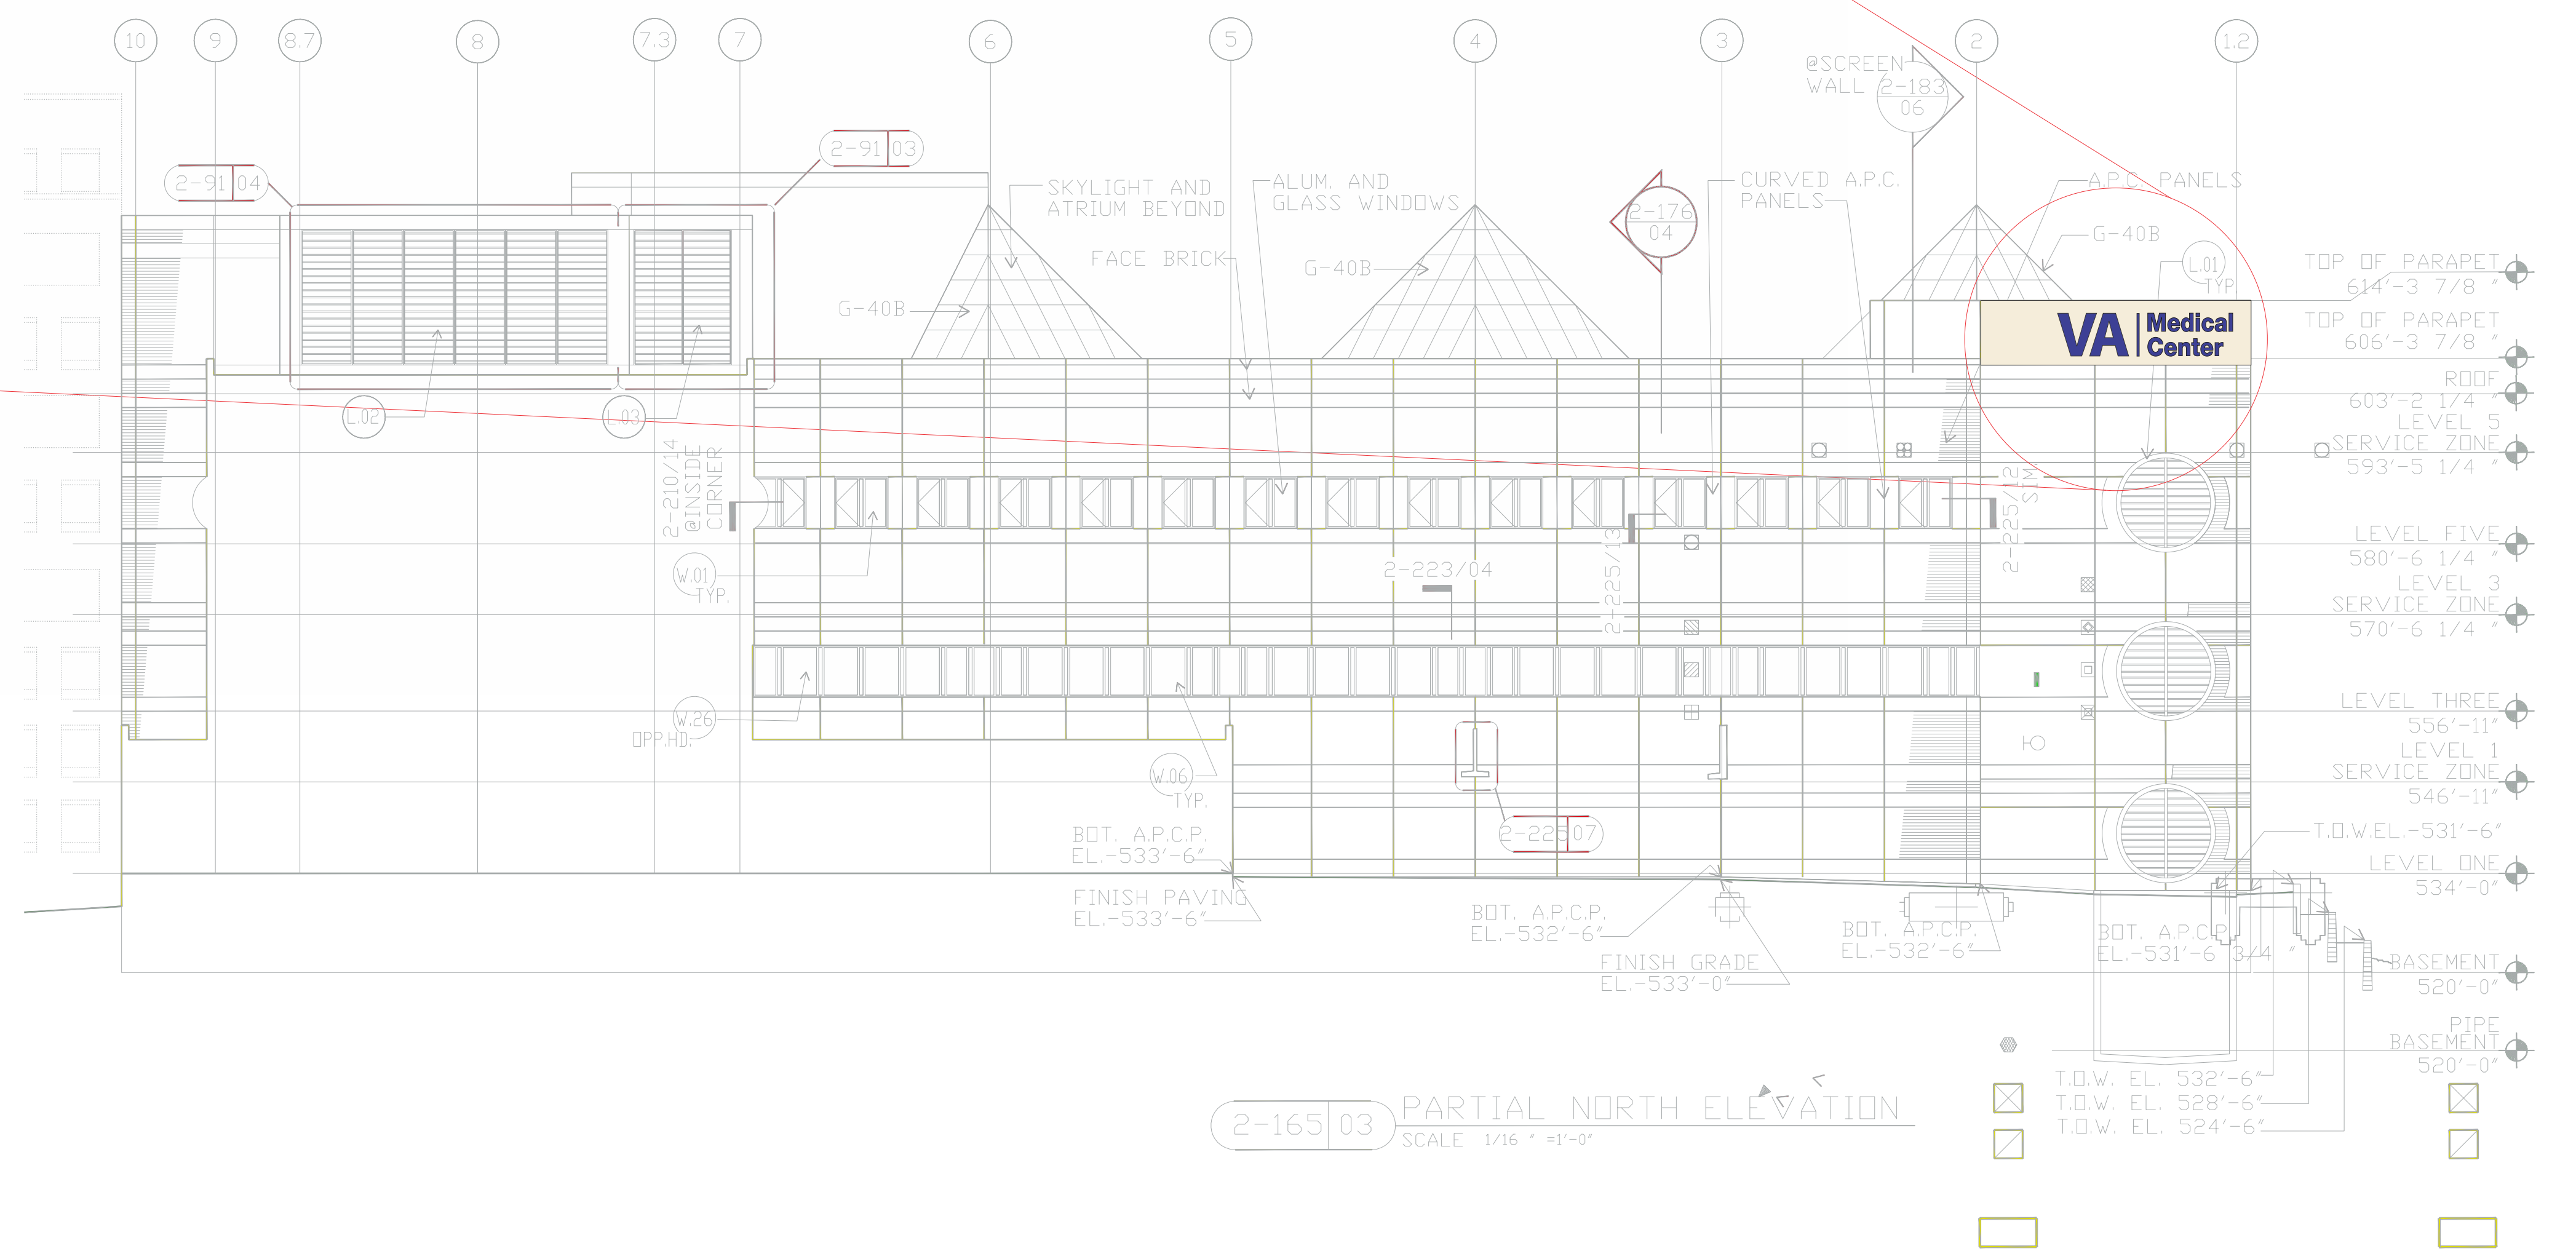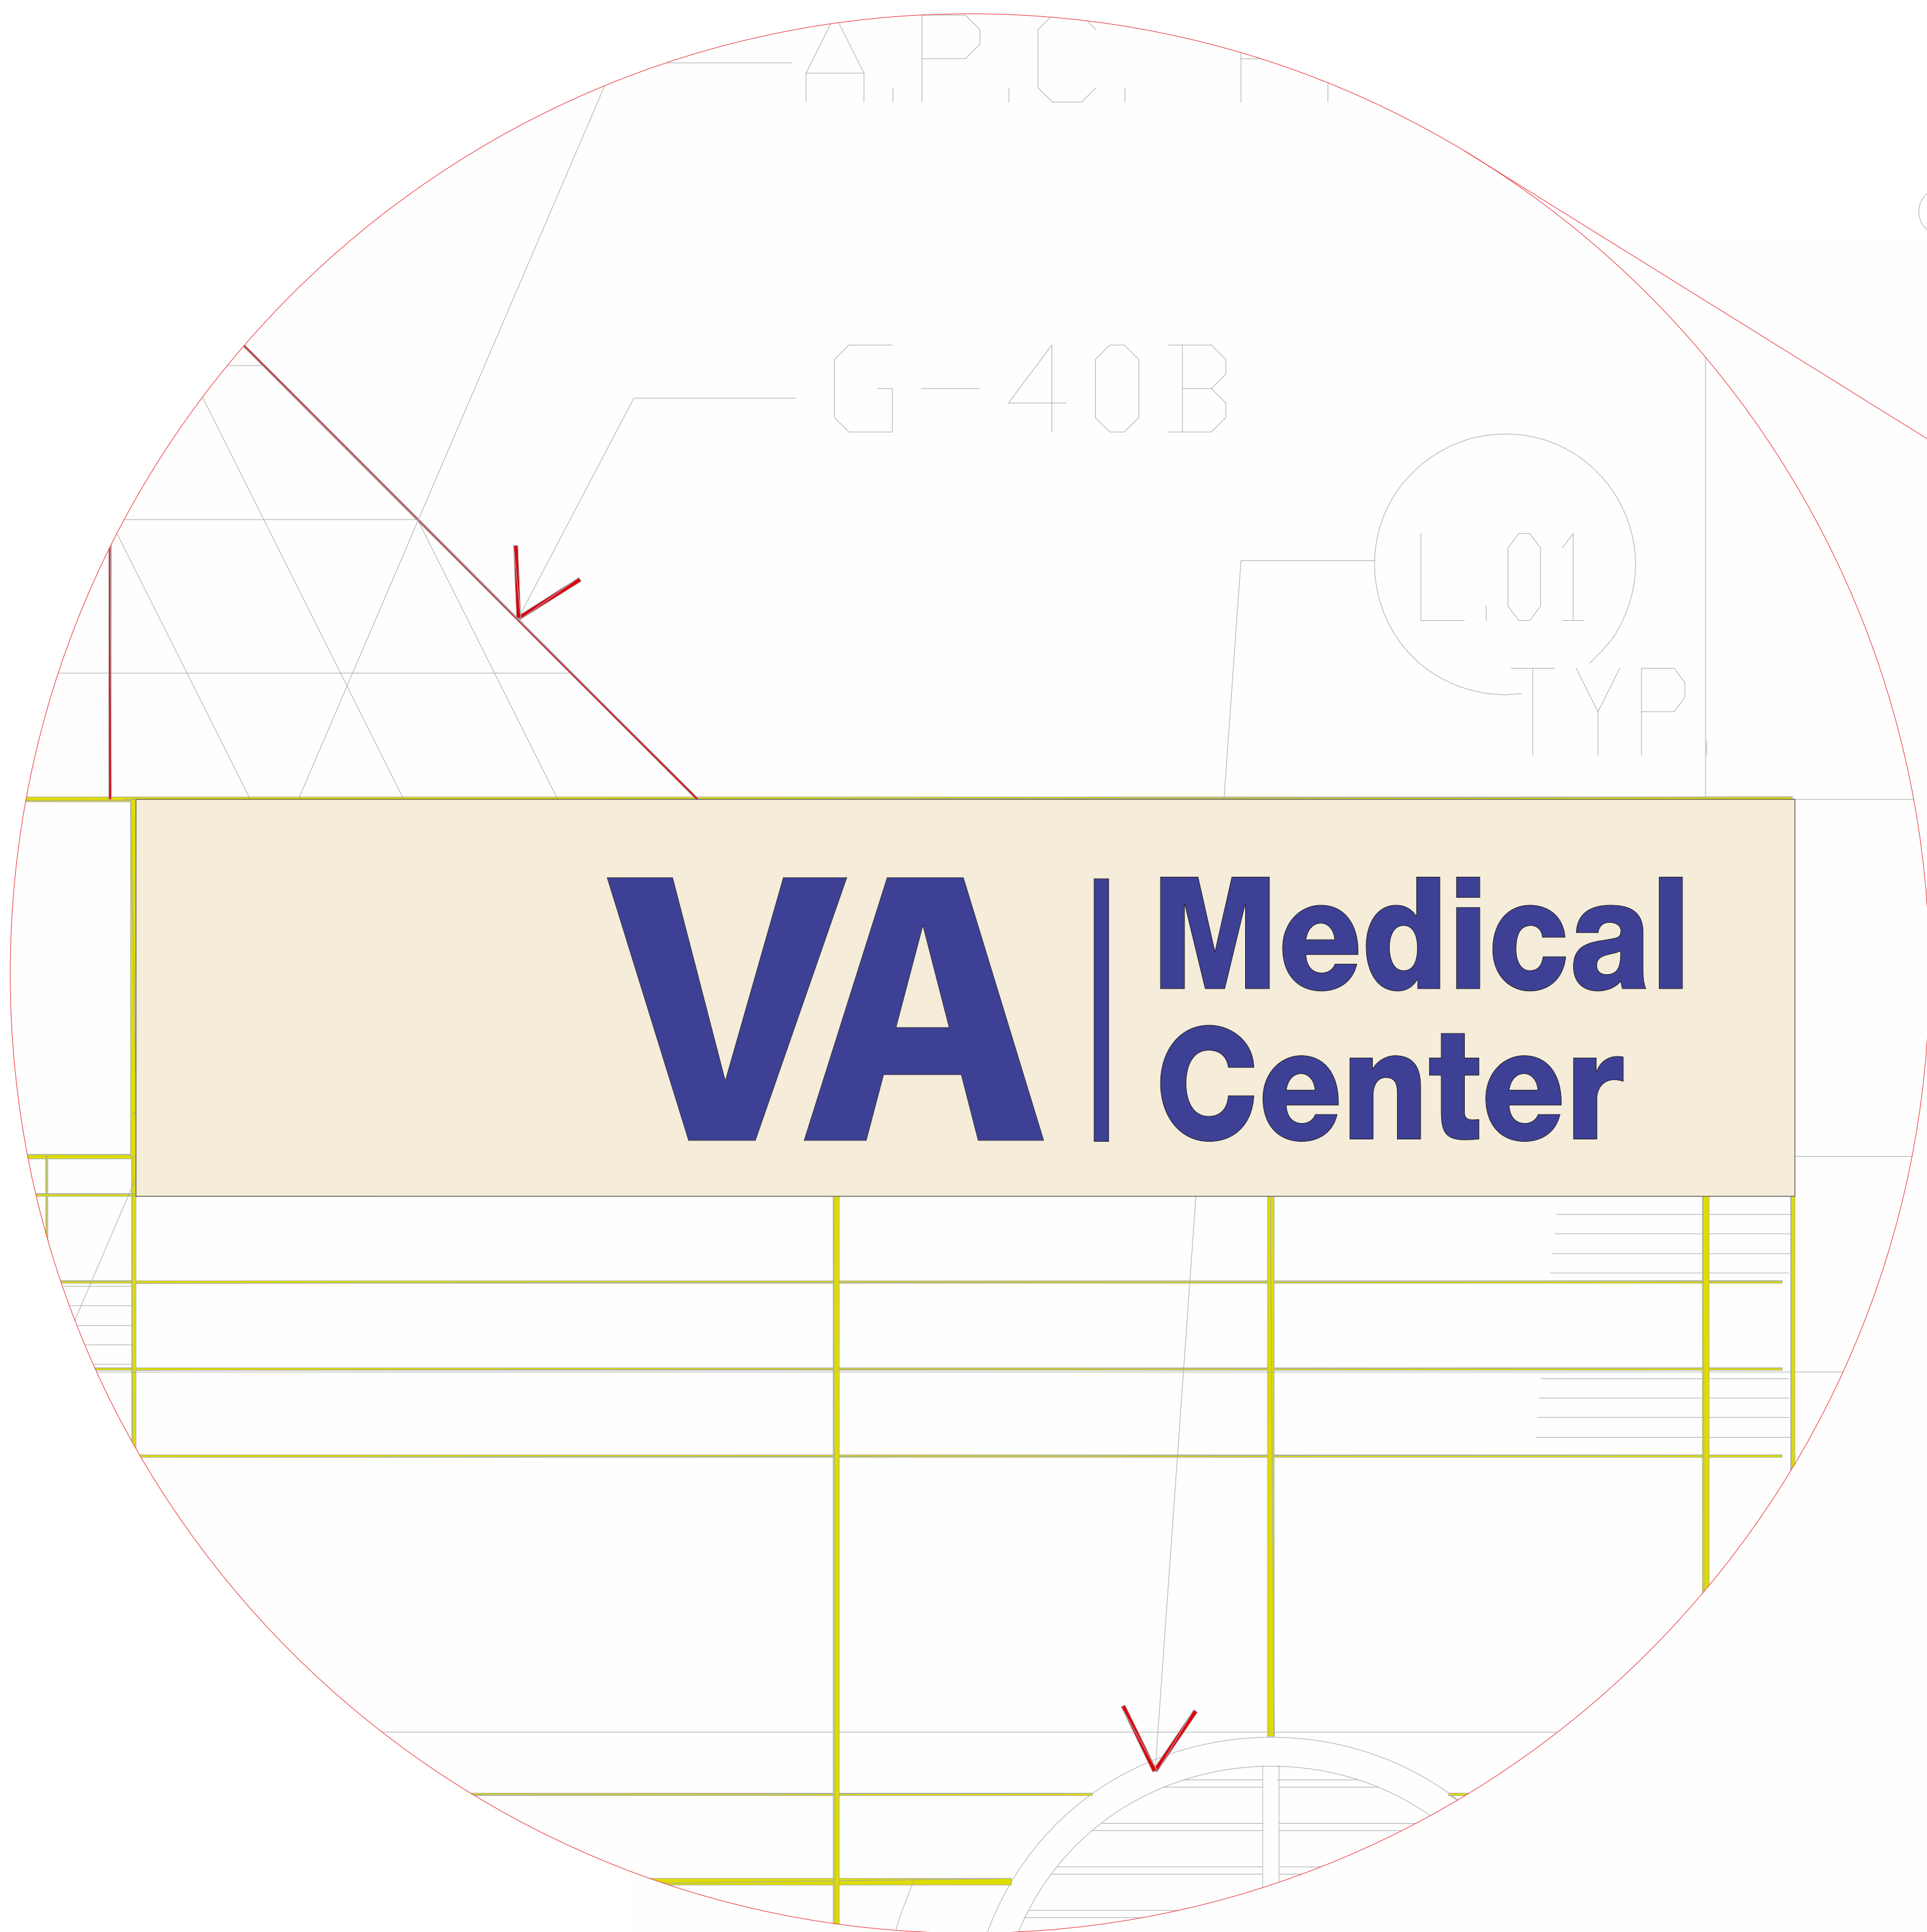


Scale: 1"=16'

SOUTH ELEVATION Loc. AA.1


ALL GLASS SHALL BE
GLASS TYPE G-56
UNLESS NOTED
OTHERWISE

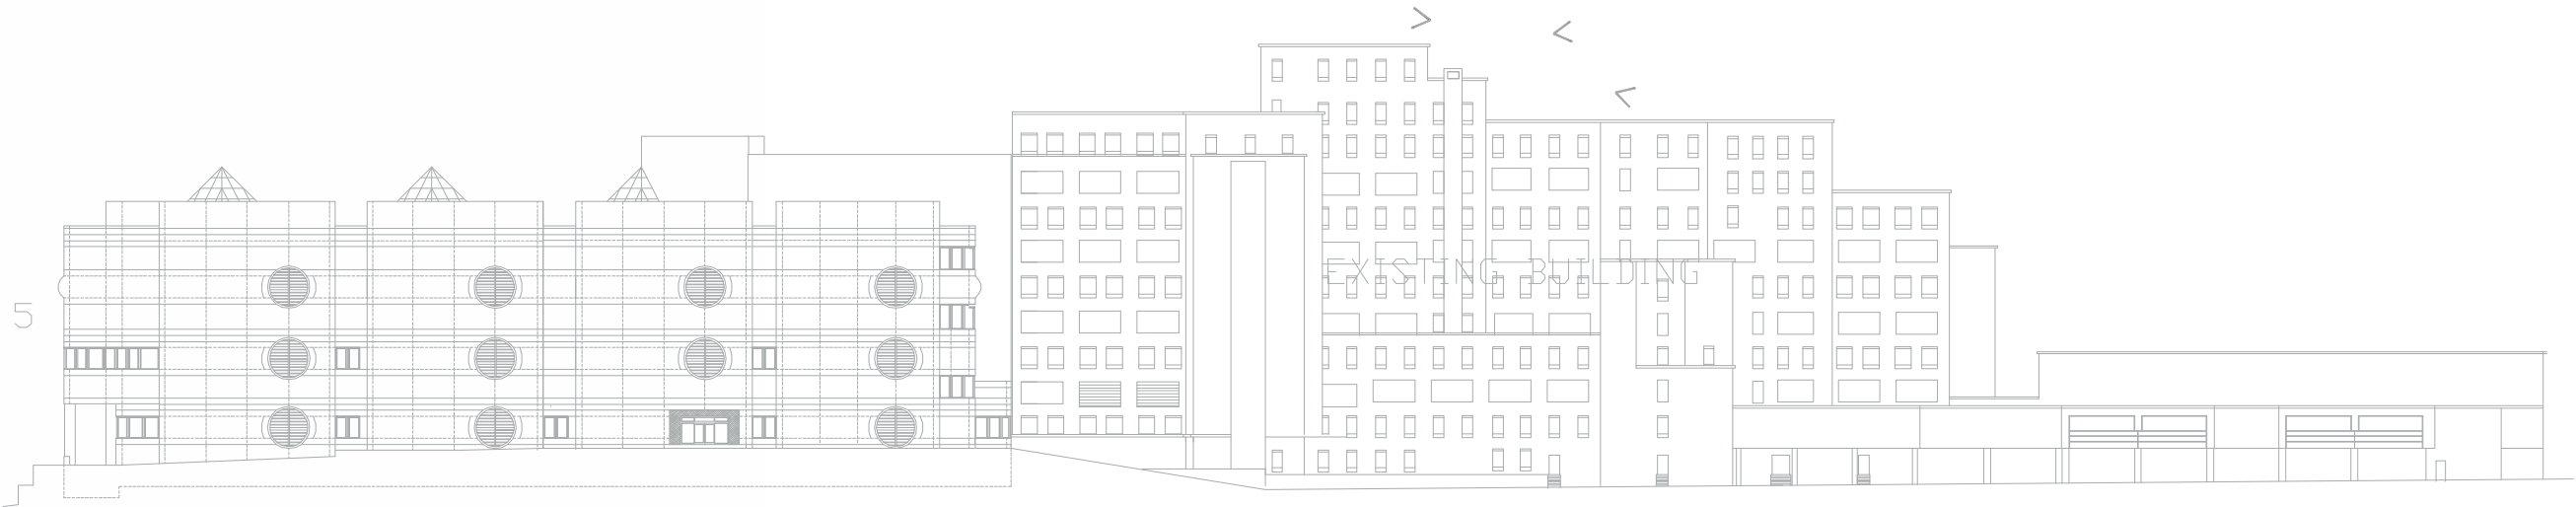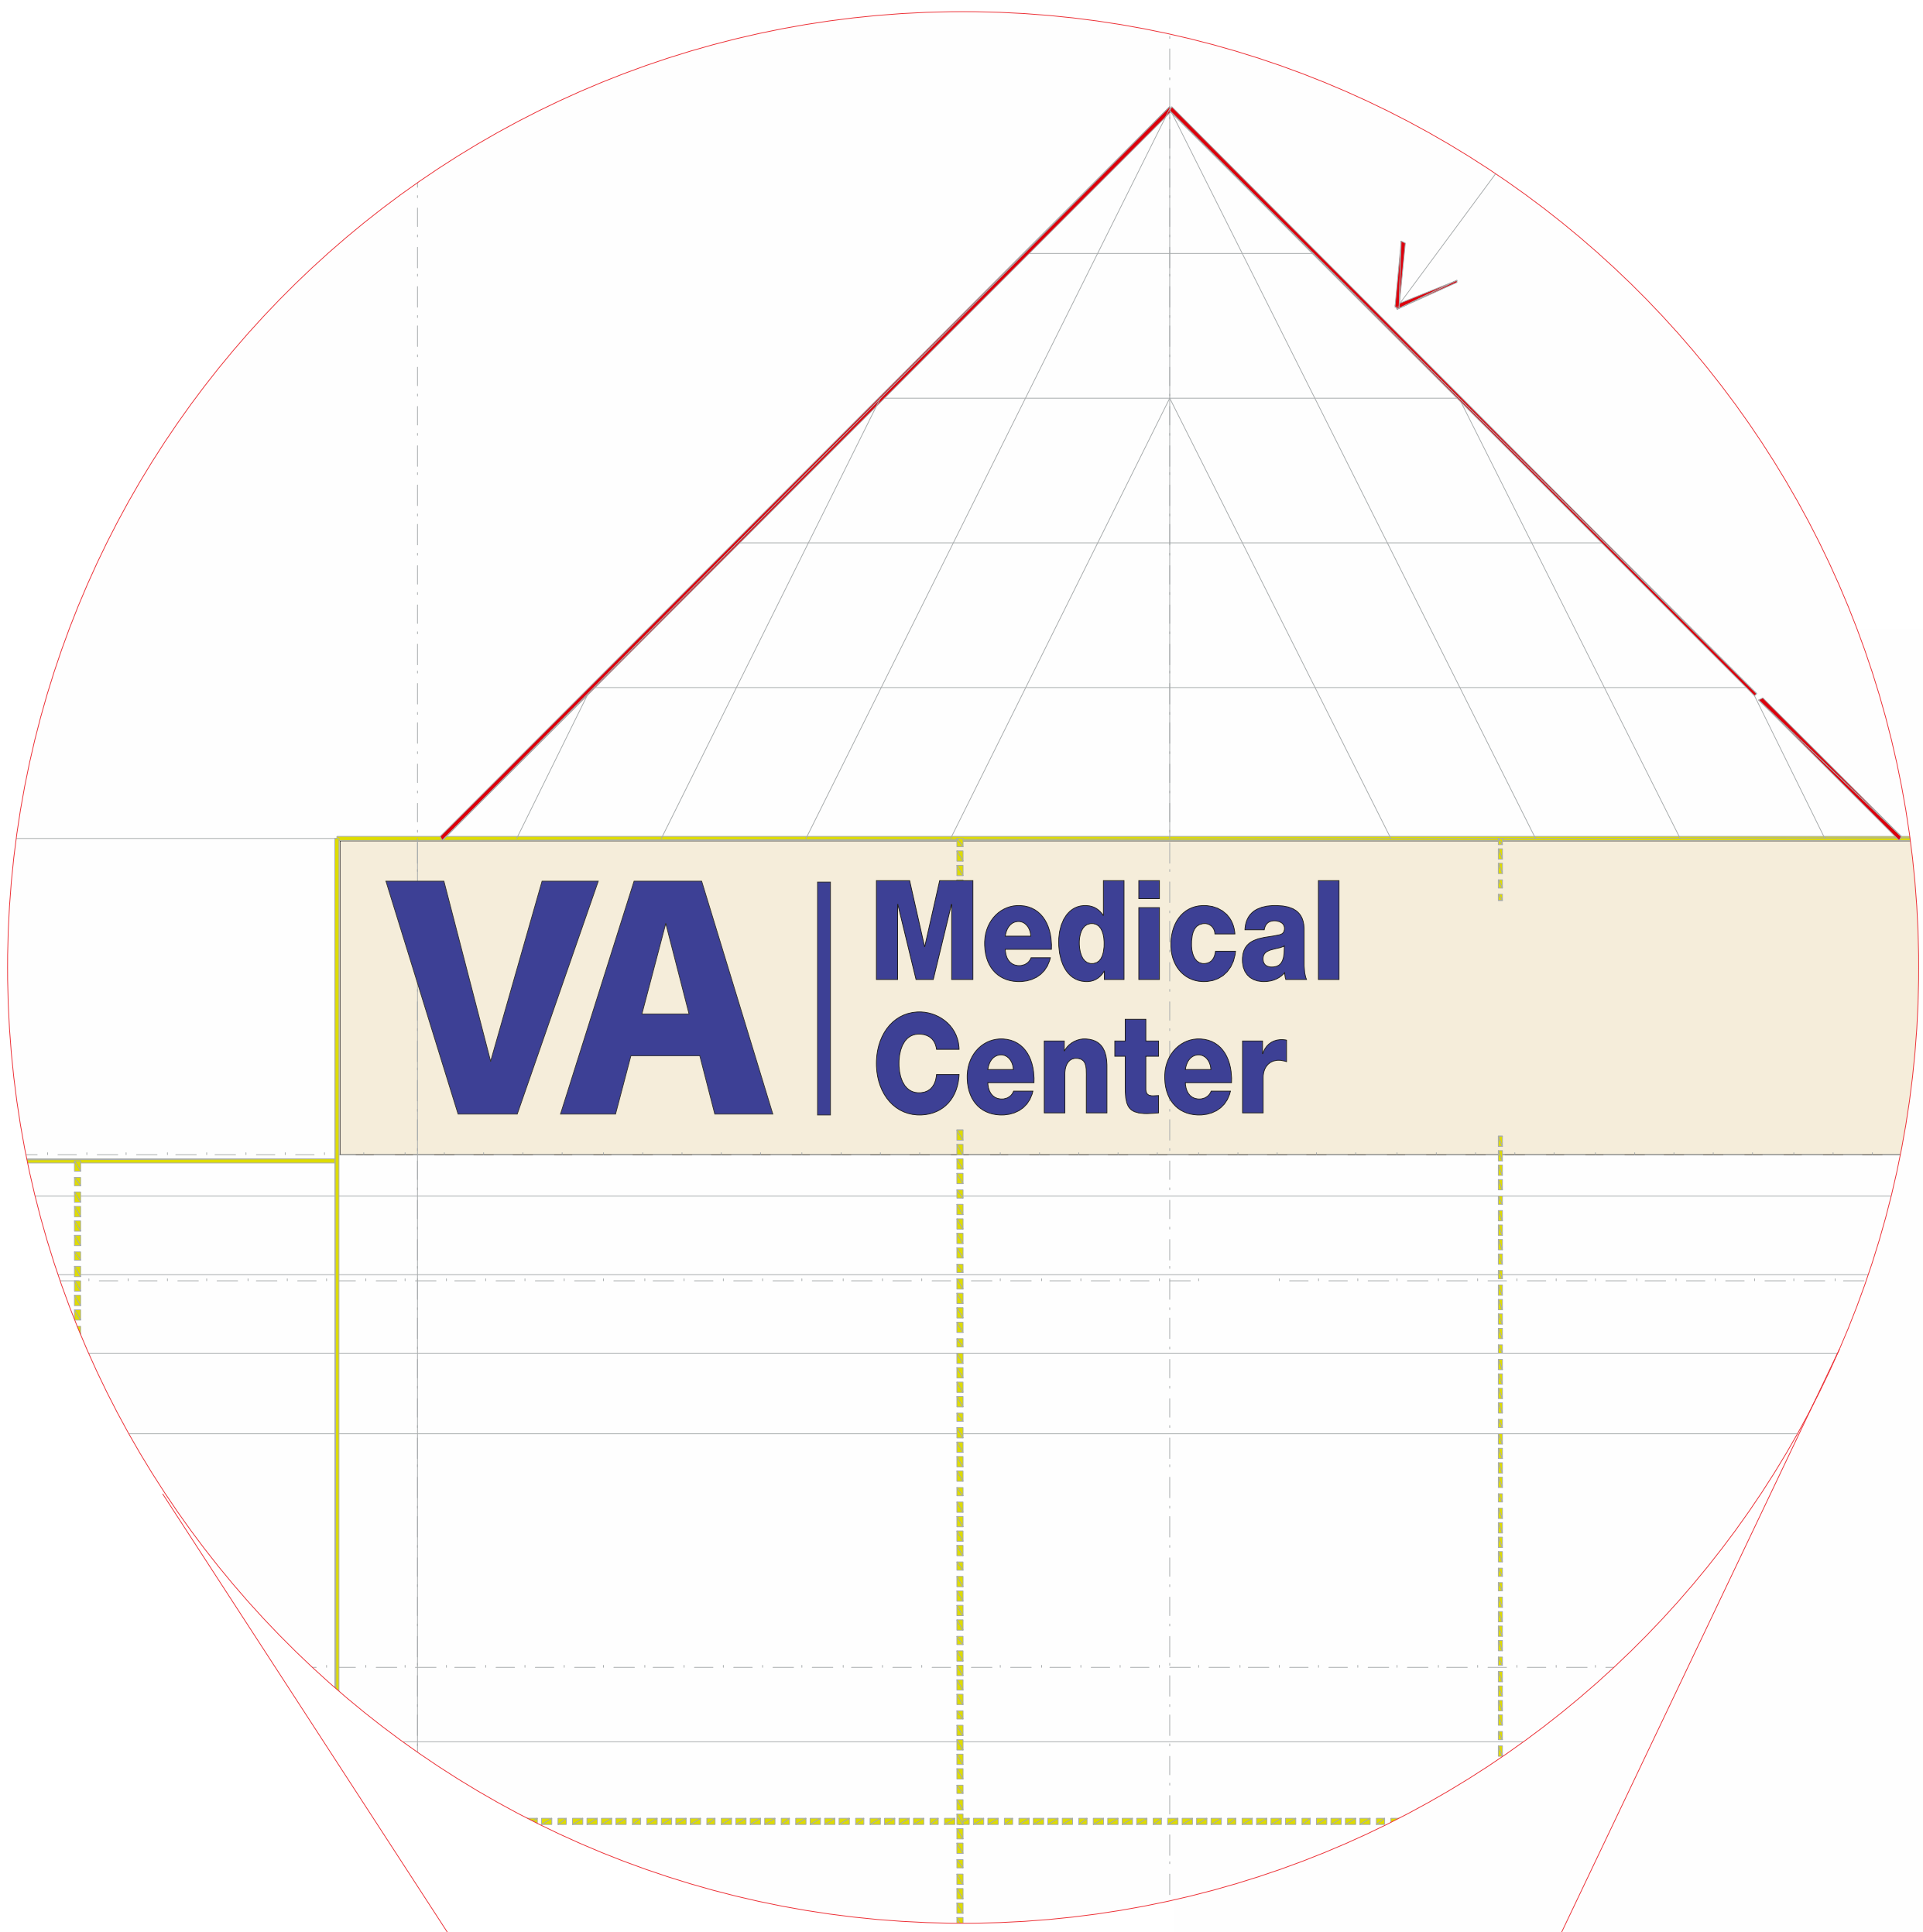

2-166 01 KEY ELEVATION
NOT TO SCALE

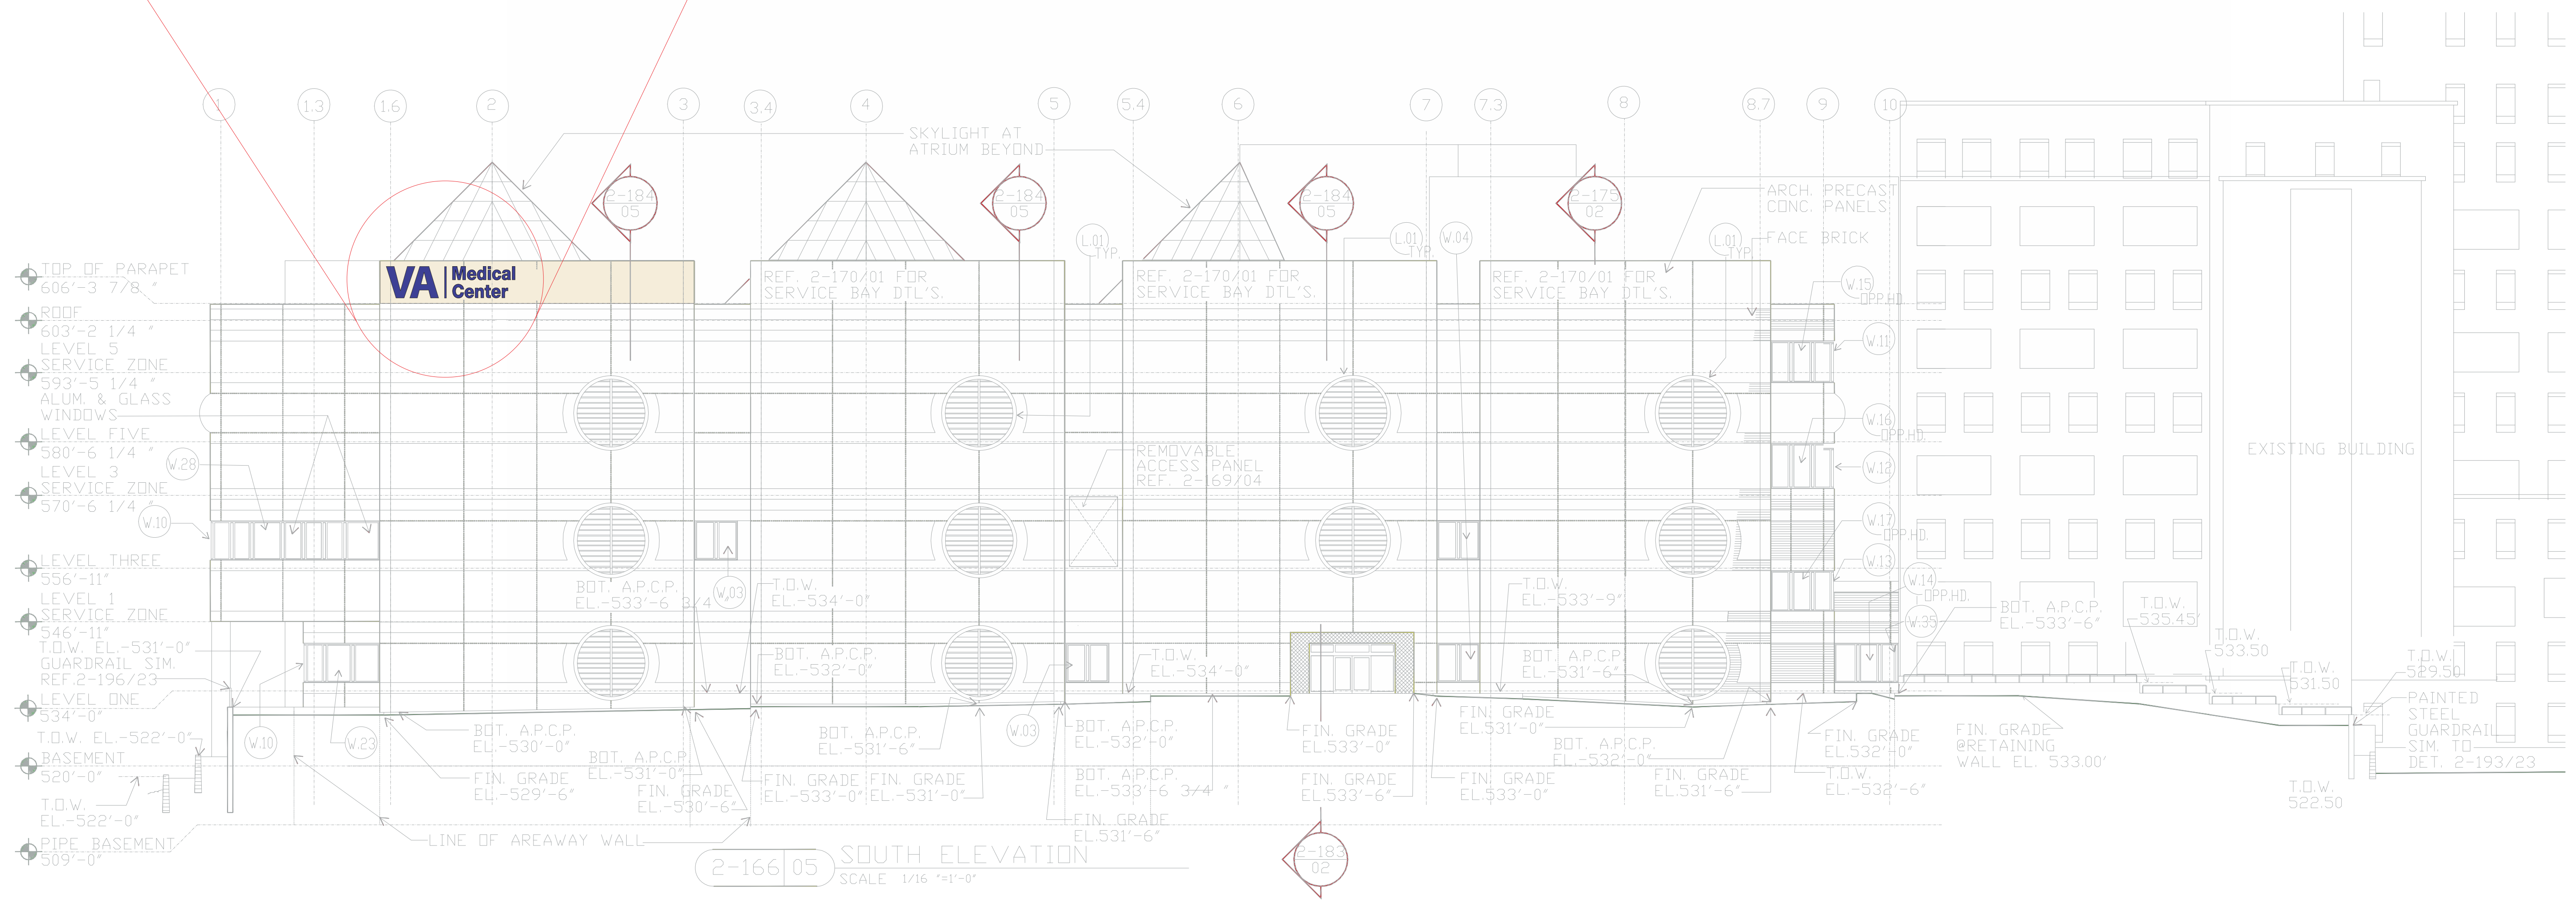

Scale: 1"=49"
Loc. AB.1, AB.2 & AB.3

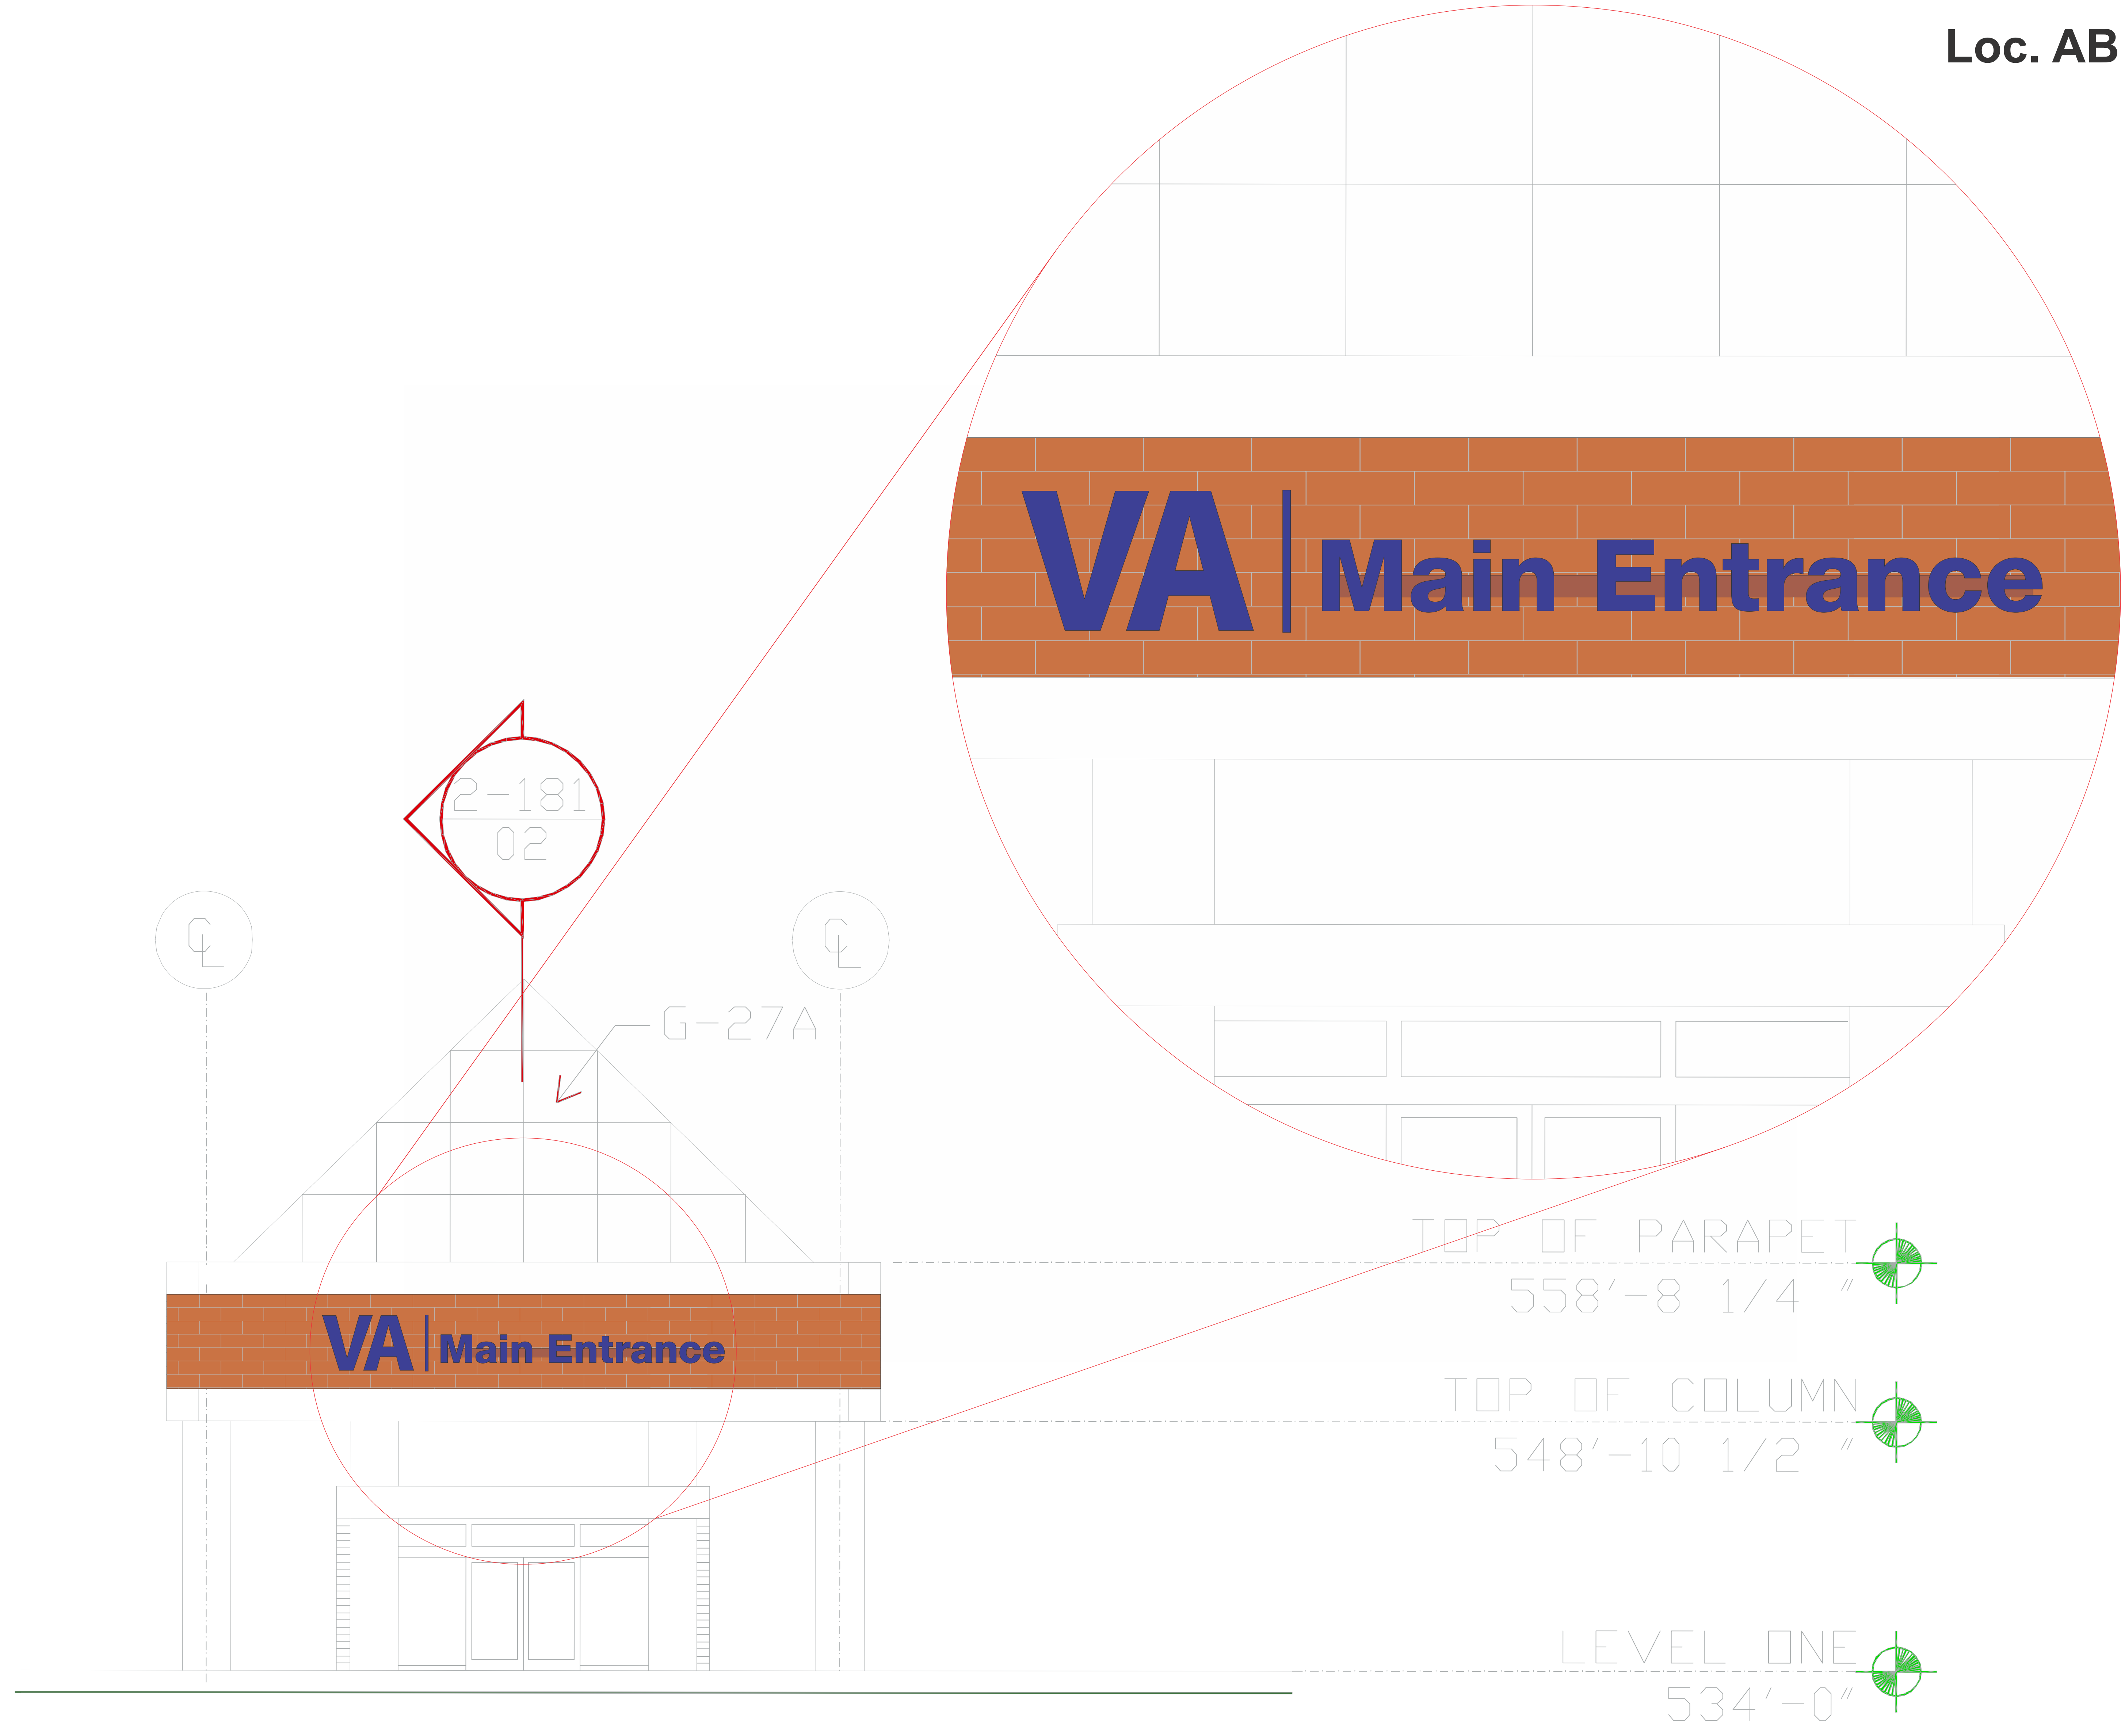

2-181
02

G-27A

VA | Main Entrance


TOP OF PARAPET
558'-8 1/4 "


TOP OF COLUMN
548'-10 1/2 "

LEVEL ONE
534'-0"

Scale: 1"=49"

Loc. AC

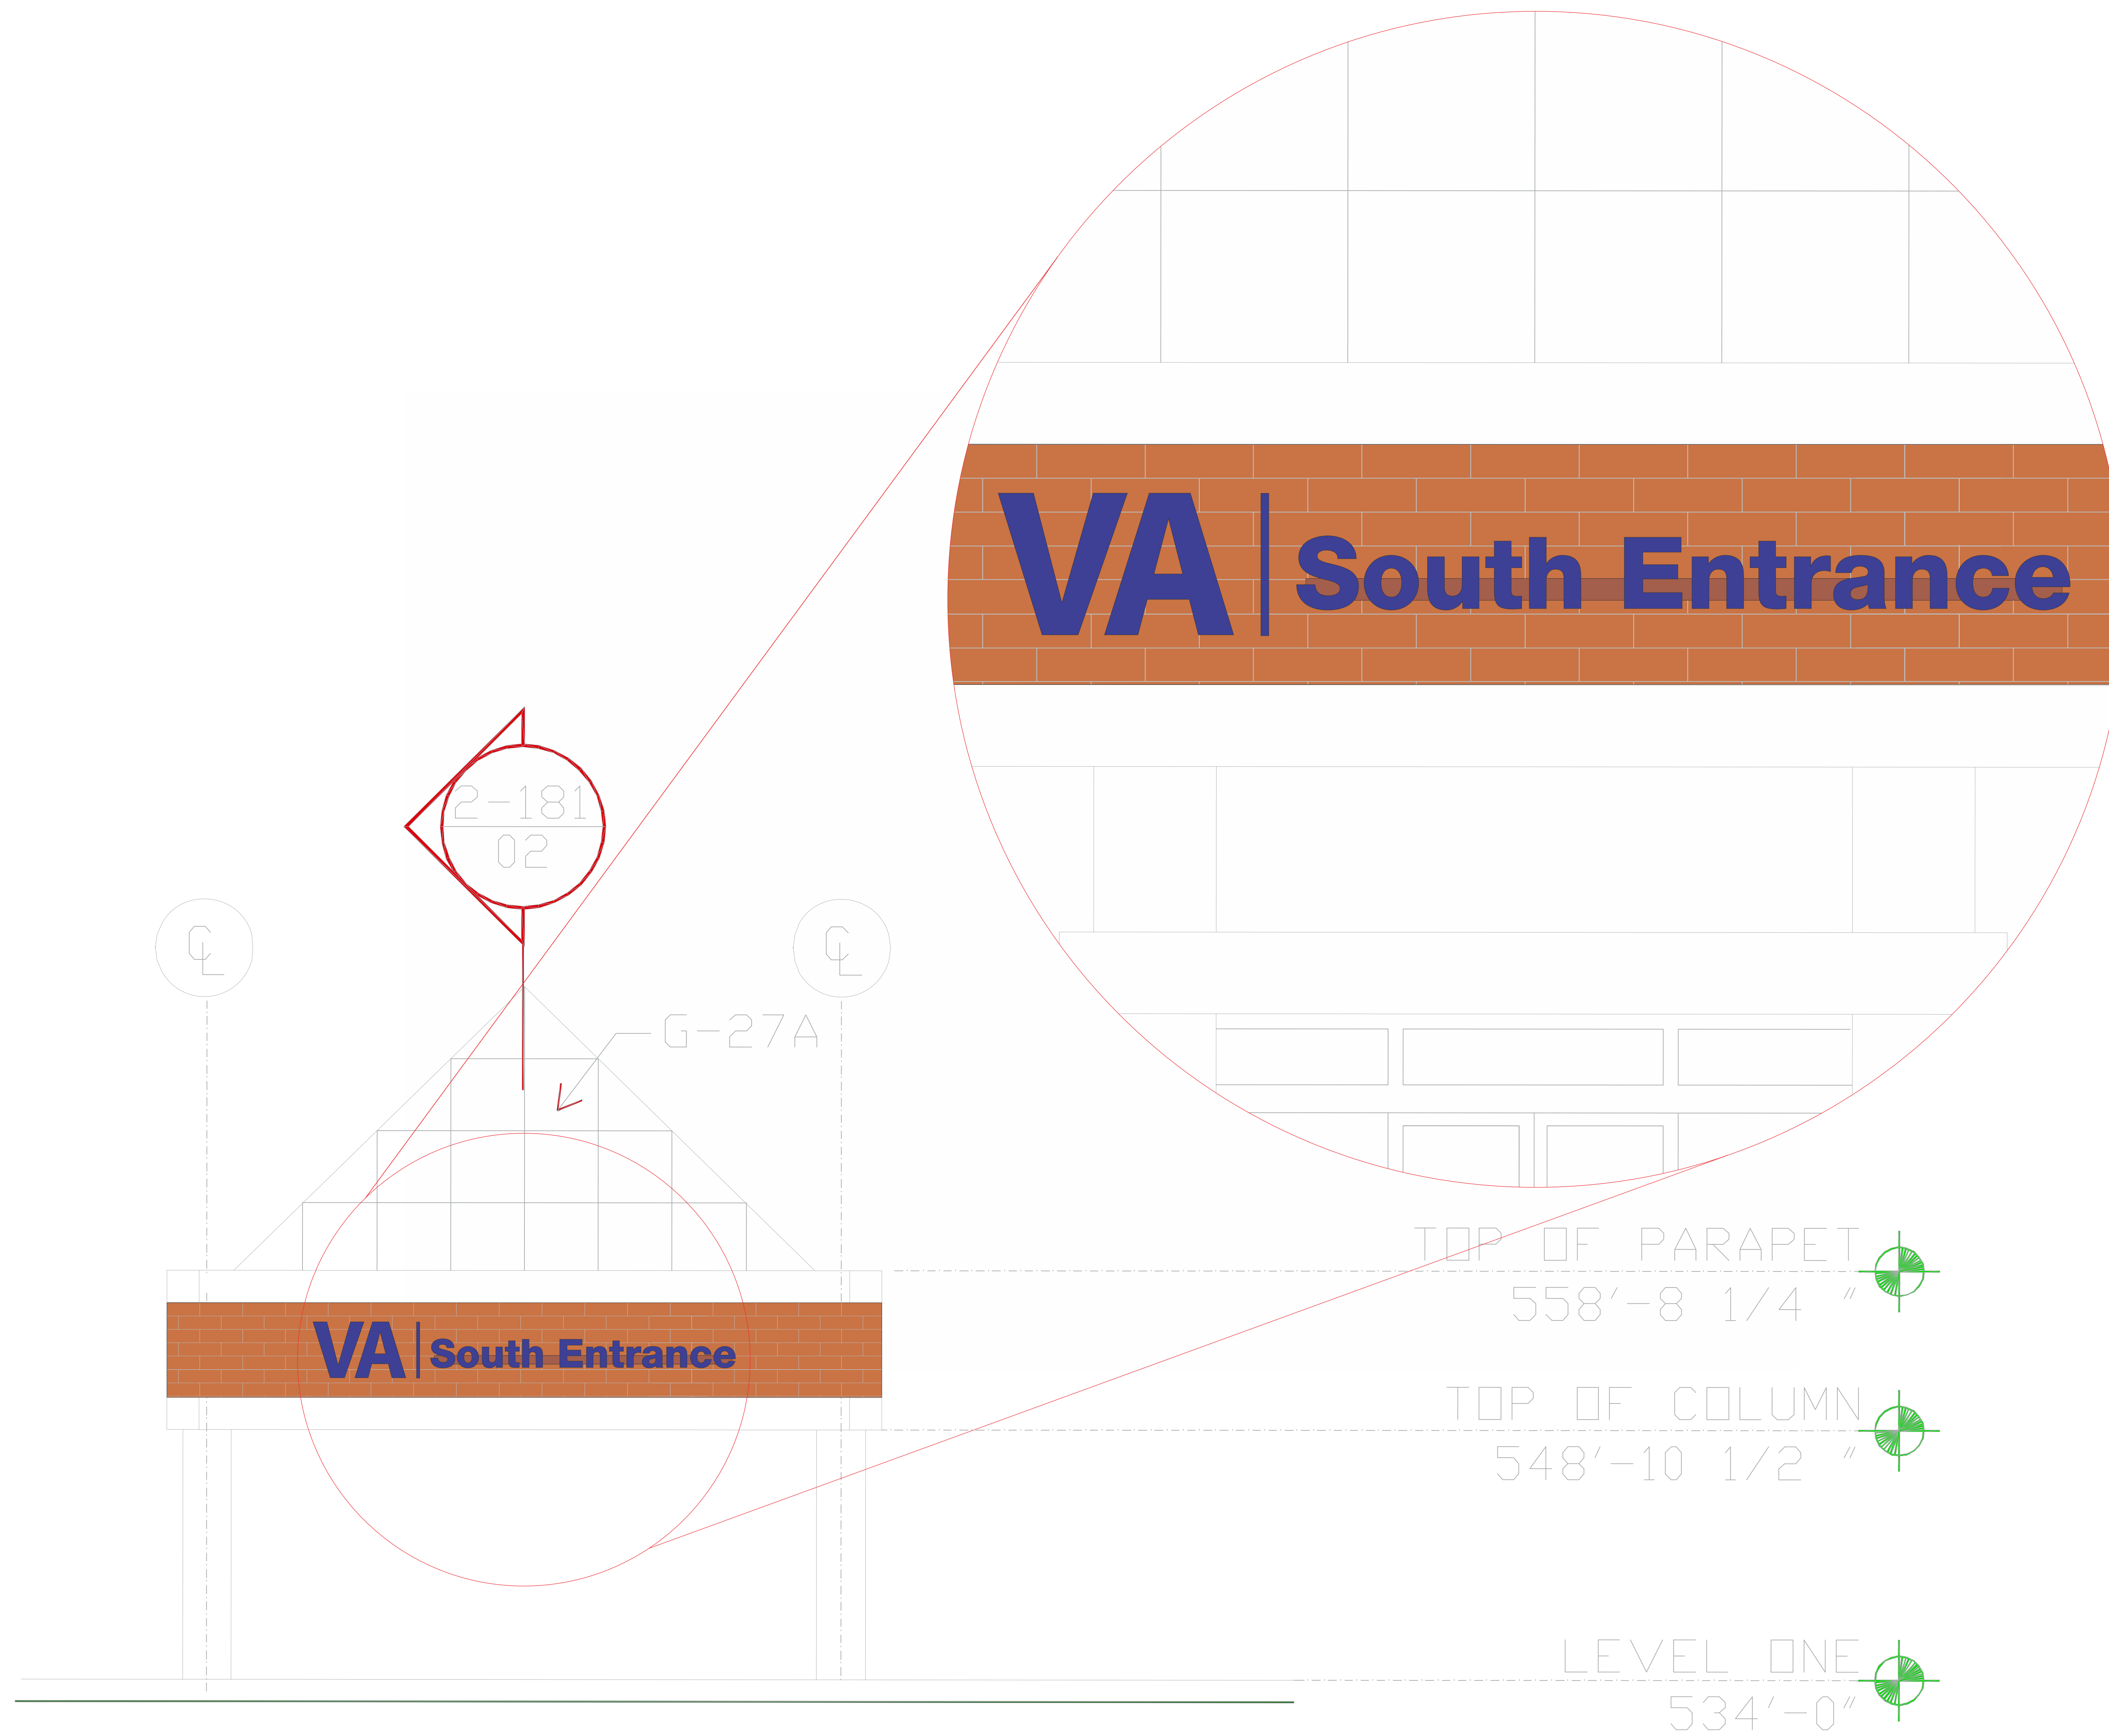

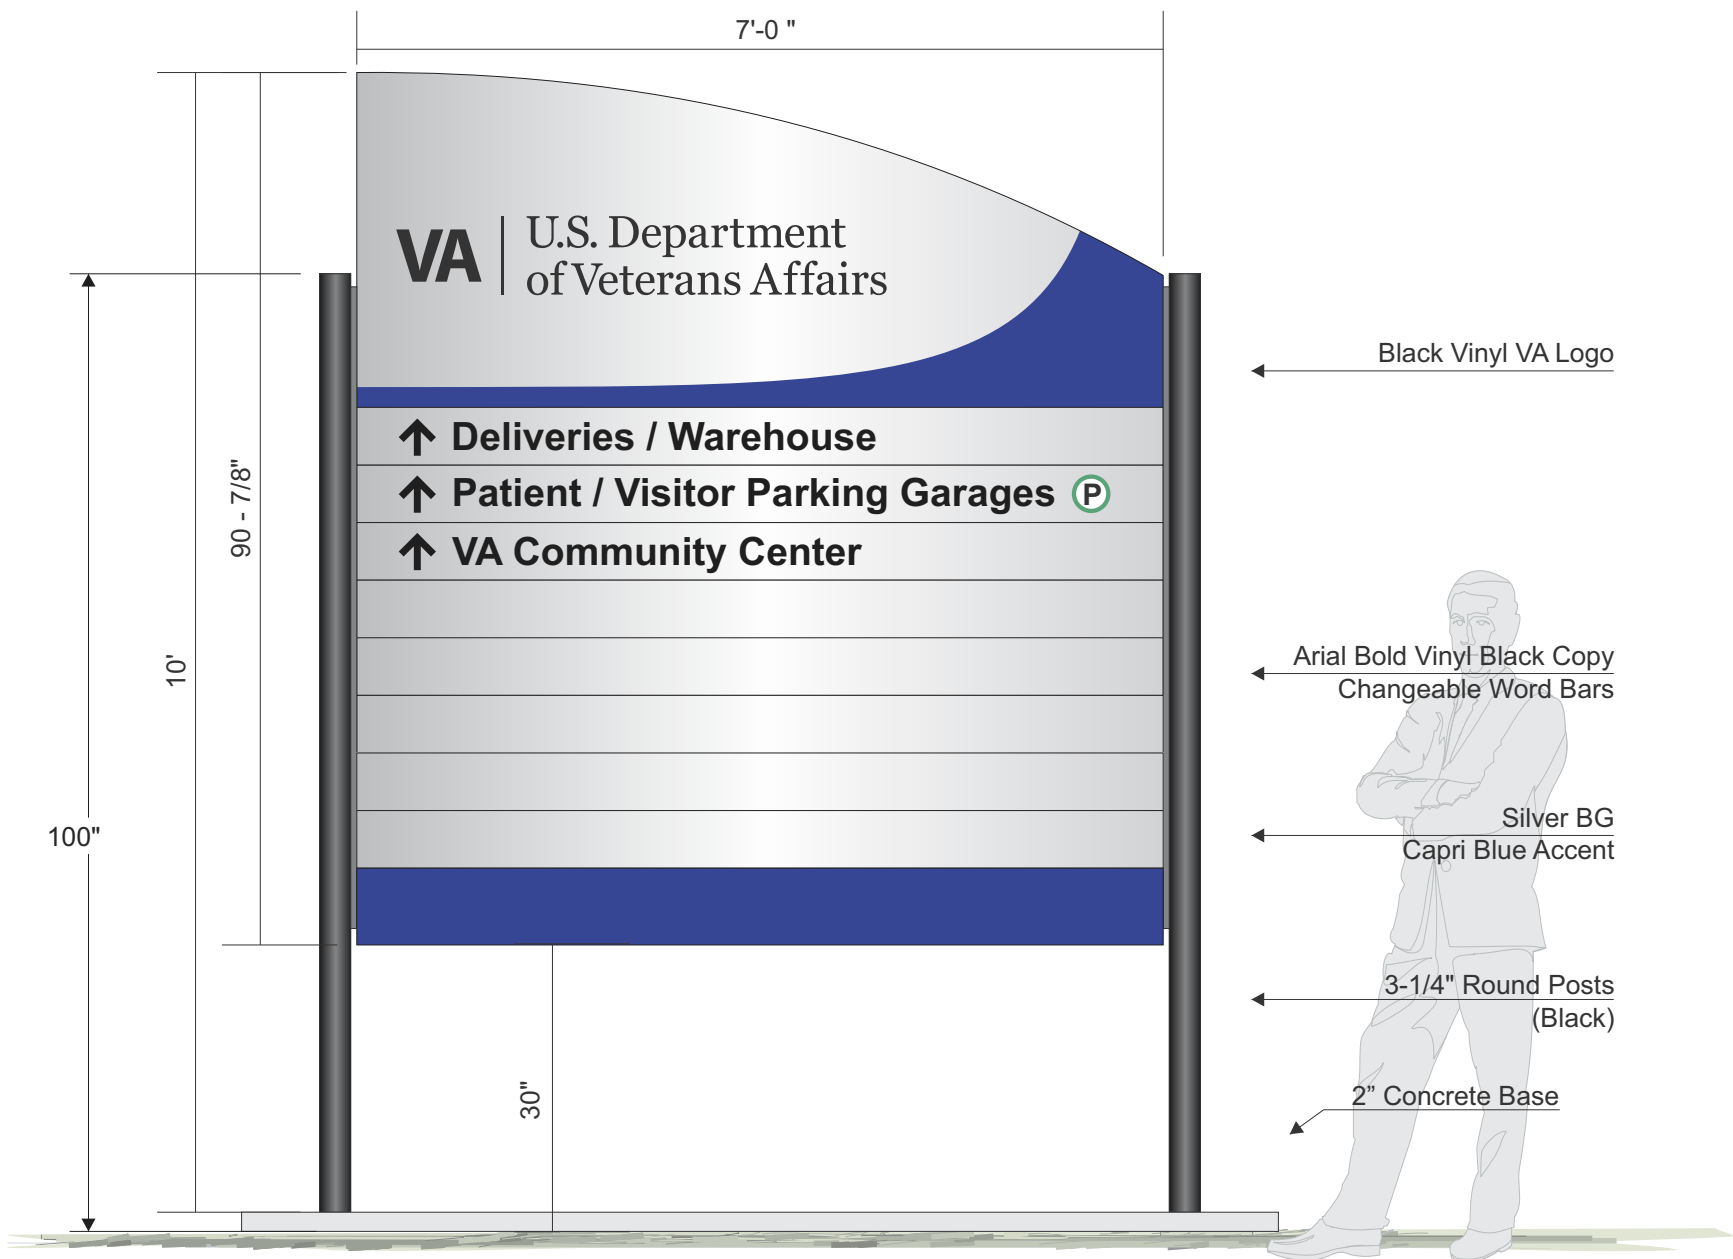

VAMC Dallas, TX

Scale: 1:20 Designer: John T. Mayer Drawn By: MEA
 Date: 5.03.2016 Revised: 06.07.2016

Type: 4/CWB Post & Panel S/F



CREATIVE SIGNAGE SYSTEMS
 9101 51st PLACE COLLEGE PARK, MARYLAND 20740
 PHONE 301.345.3700 FAX 301.220.0289 WWW.CREATIVESIGNAGE.COM

Note: All drawings, notations and design themes expressed herein remain the sole property of Creative Signage Systems and may not be reproduced without written consent.




← Black Vinyl VA Logo

← Arial Bold Vinyl Black Copy
Changeable Word Bars

← Silver BG
Capri Blue Accent

← 3-1/4" Round Posts
(Black)

← 2" Concrete Base

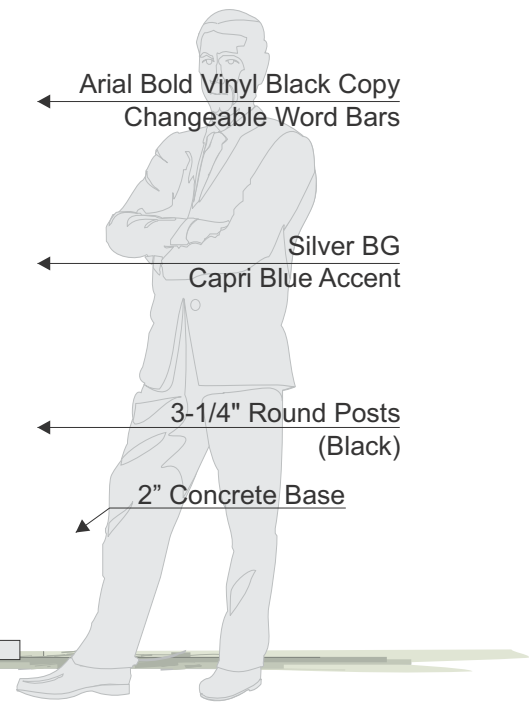


VAMC Dallas, TX		
Scale: 1:20	Designer: John T. Mayer	Drawn By: MEA
Date: 5.03.2016	Revised: 06.07.2016	
Type 4/CWB Post & Panel S/F		

CREATIVE SIGNAGE SYSTEMS

9101 51st PLACE COLLEGE PARK, MARYLAND 20740
 PHONE 301.345.3700 FAX 301.220.0289 WWW.CREATIVESIGNAGE.COM

Note: All drawings, notations and design themes expressed herein remain the sole property of Creative Signage Systems and may not be reproduced without written consent.

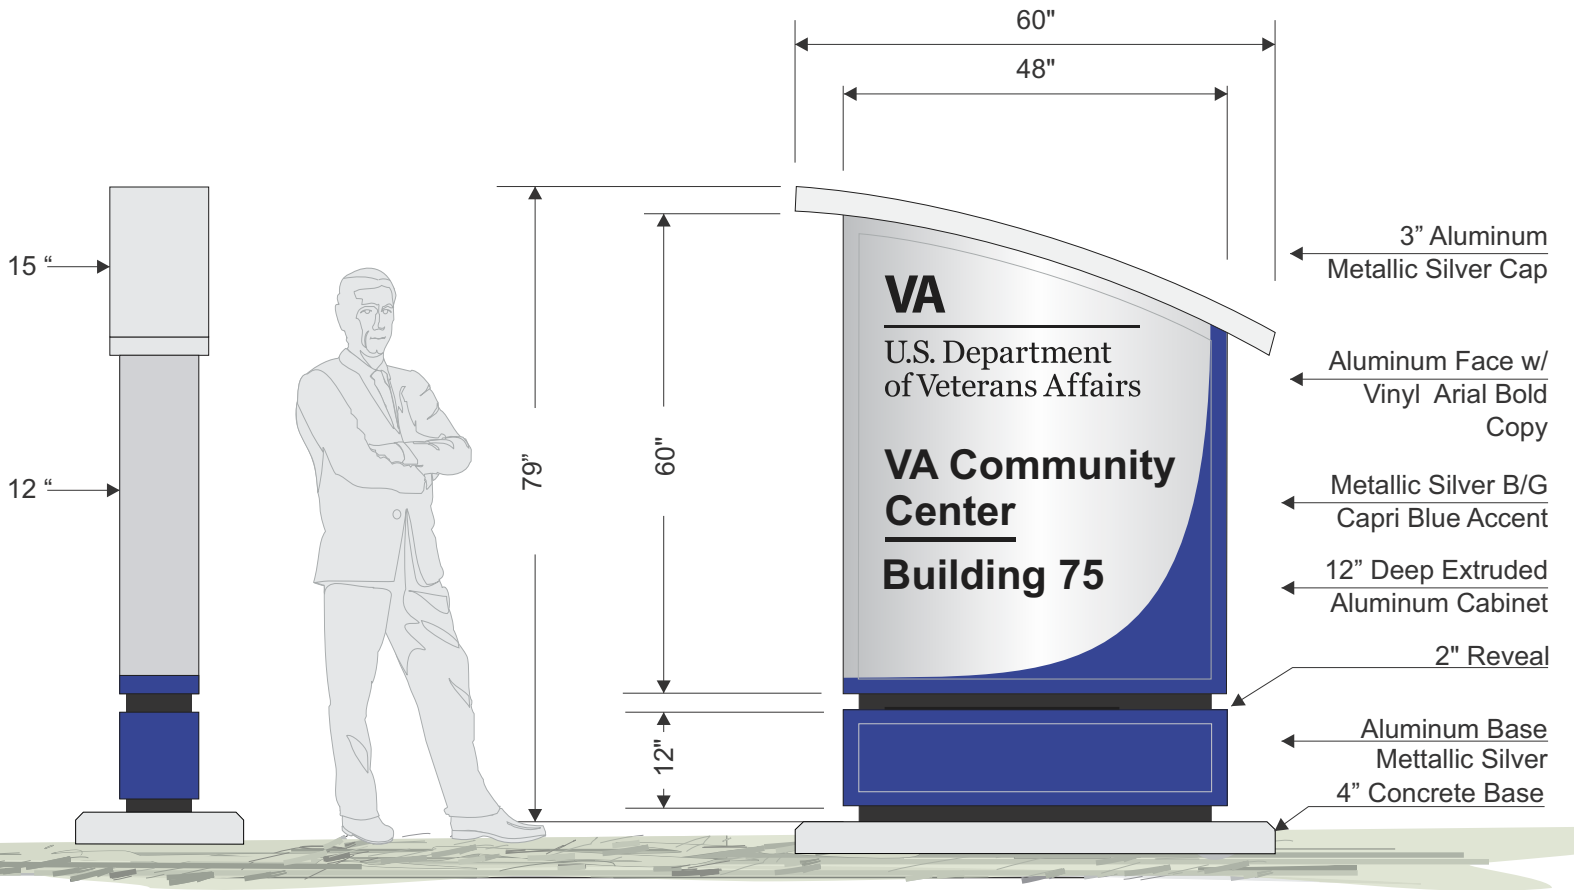

VAMC Dallas, TX

Scale: 1:24 Designer: John T. Mayer Drawn By: MEA

Date: 5.03.2016 Revised: 06.07.2016


Type 5/1200 D/F Non-Illuminated Pylon

CREATIVE SIGNAGE SYSTEMS

9101 51st PLACE COLLEGE PARK, MARYLAND 20740
 PHONE 301.345.3700 FAX 301.220.0289 WWW.CREATIVESIGNAGE.COM

Note: All drawings, notations and design themes expressed herein remain the sole property of Creative Signage Systems and may not be reproduced without written consent.

Aluminum Sign Extrusions to contain 75% Recycled Content.

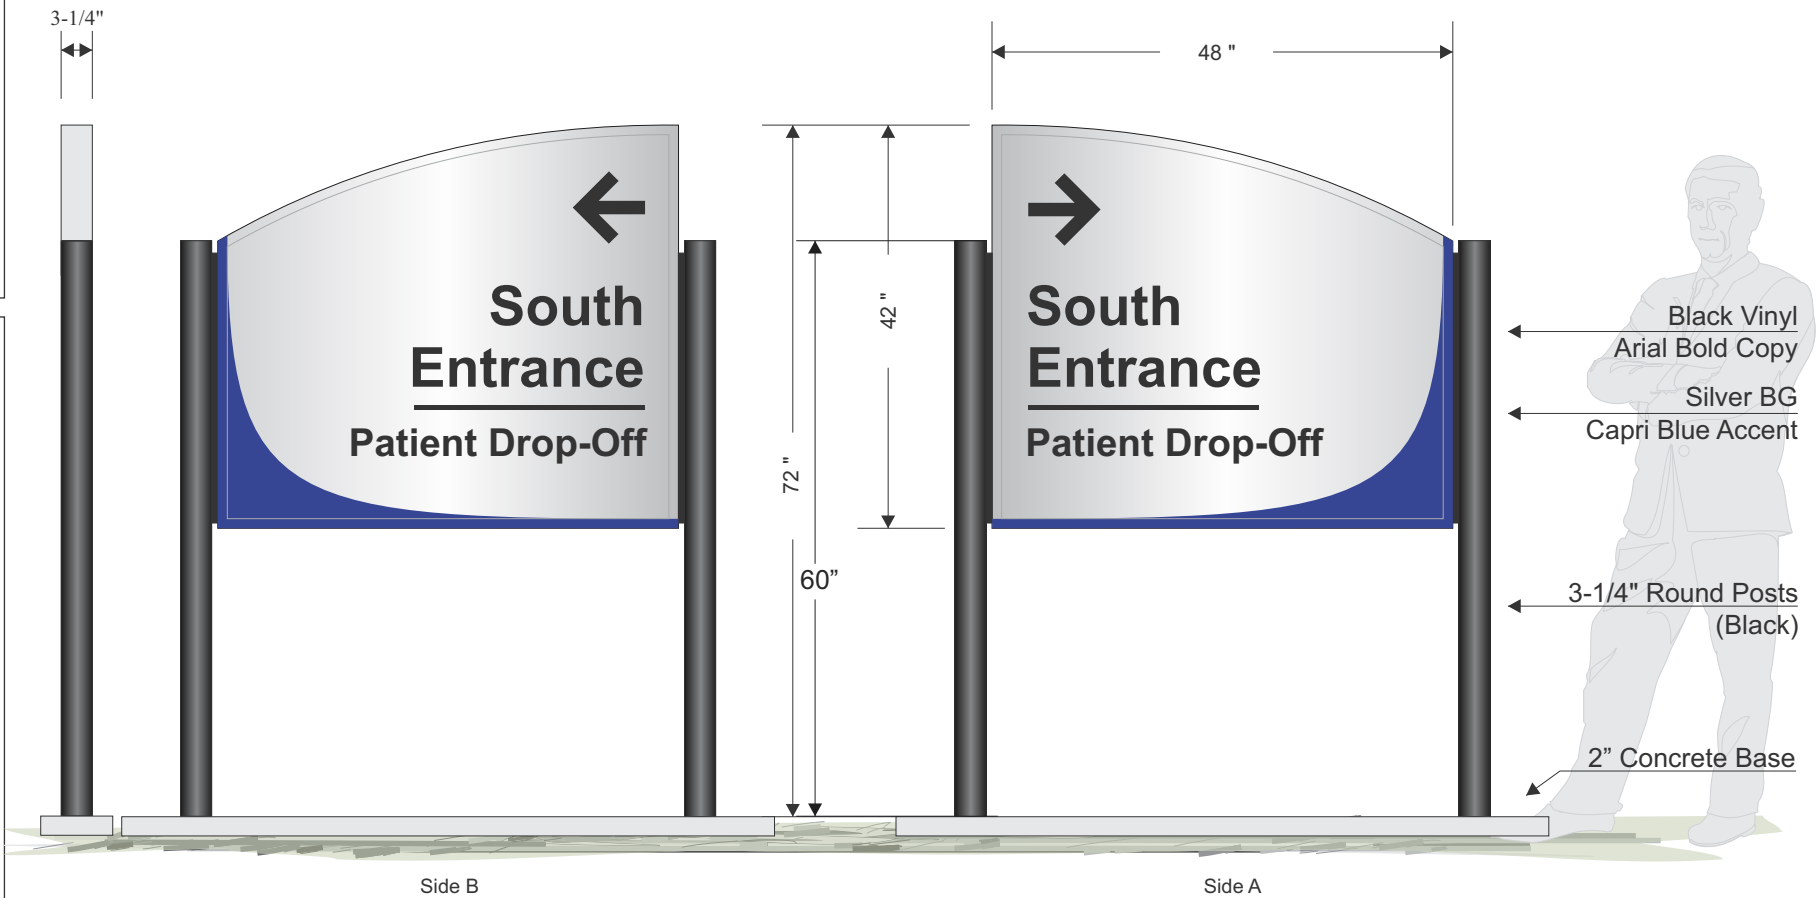

Loc. A.38

VAMC Dallas, TX

Scale: 1:20 Designer: John T. Mayer Drawn By: MEA

Date: 5.03.2016 Revised: 06.07.2016


Type 6/325 D/F Post & Panel

CREATIVE SIGNAGE SYSTEMS

9101 51st PLACE COLLEGE PARK, MARYLAND 20740
PHONE 301.345.3700 FAX 301.220.0289 WWW.CREATIVESIGNAGE.COM

Note: All drawings, notations and design themes expressed herein remain the sole property of Creative Signage Systems and may not be reproduced without written consent.

Aluminum Sign Extrusions to contain 75% Recycled Content.

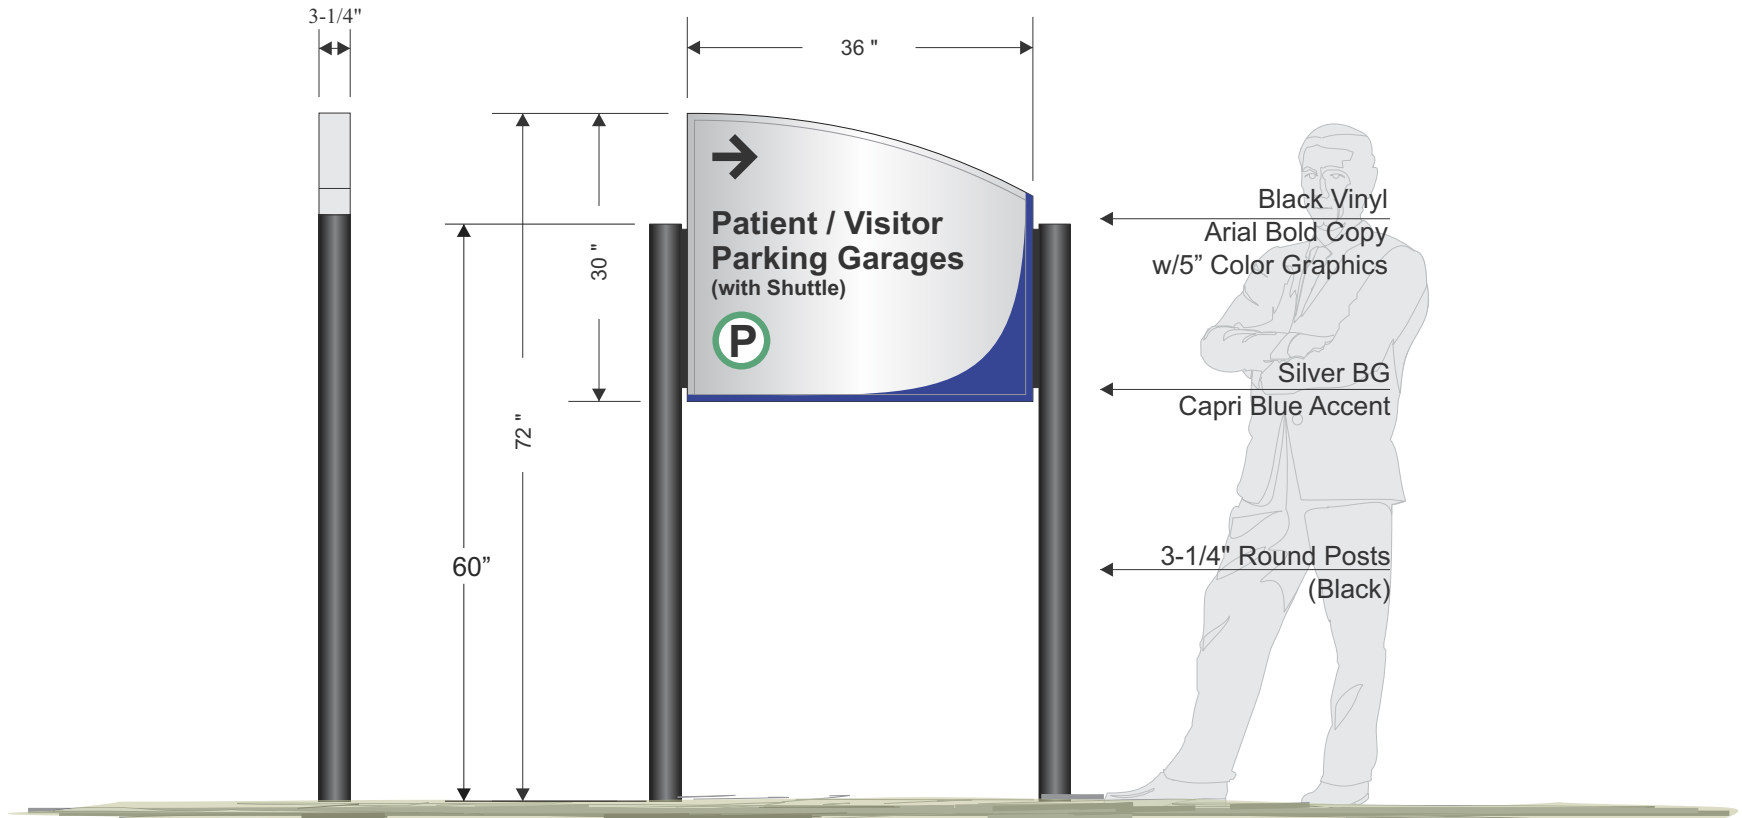


Loc. A.6

VAMC Dallas, TX		
Scale: 1:20	Designer: John T. Mayer	Drawn By: MEA
Date: 5.03.2016	Revised: 06.07.2016	
Type 6/325 S/F Post & Panel		



CREATIVE SIGNAGE SYSTEMS
9101 51st PLACE COLLEGE PARK, MARYLAND 20740
PHONE 301.345.3700 FAX 301.220.0289 WWW.CREATIVESIGNAGE.COM

Note: All drawings, notations and design themes expressed herein remain the sole property of Creative Signage Systems and may not be reproduced without written consent.

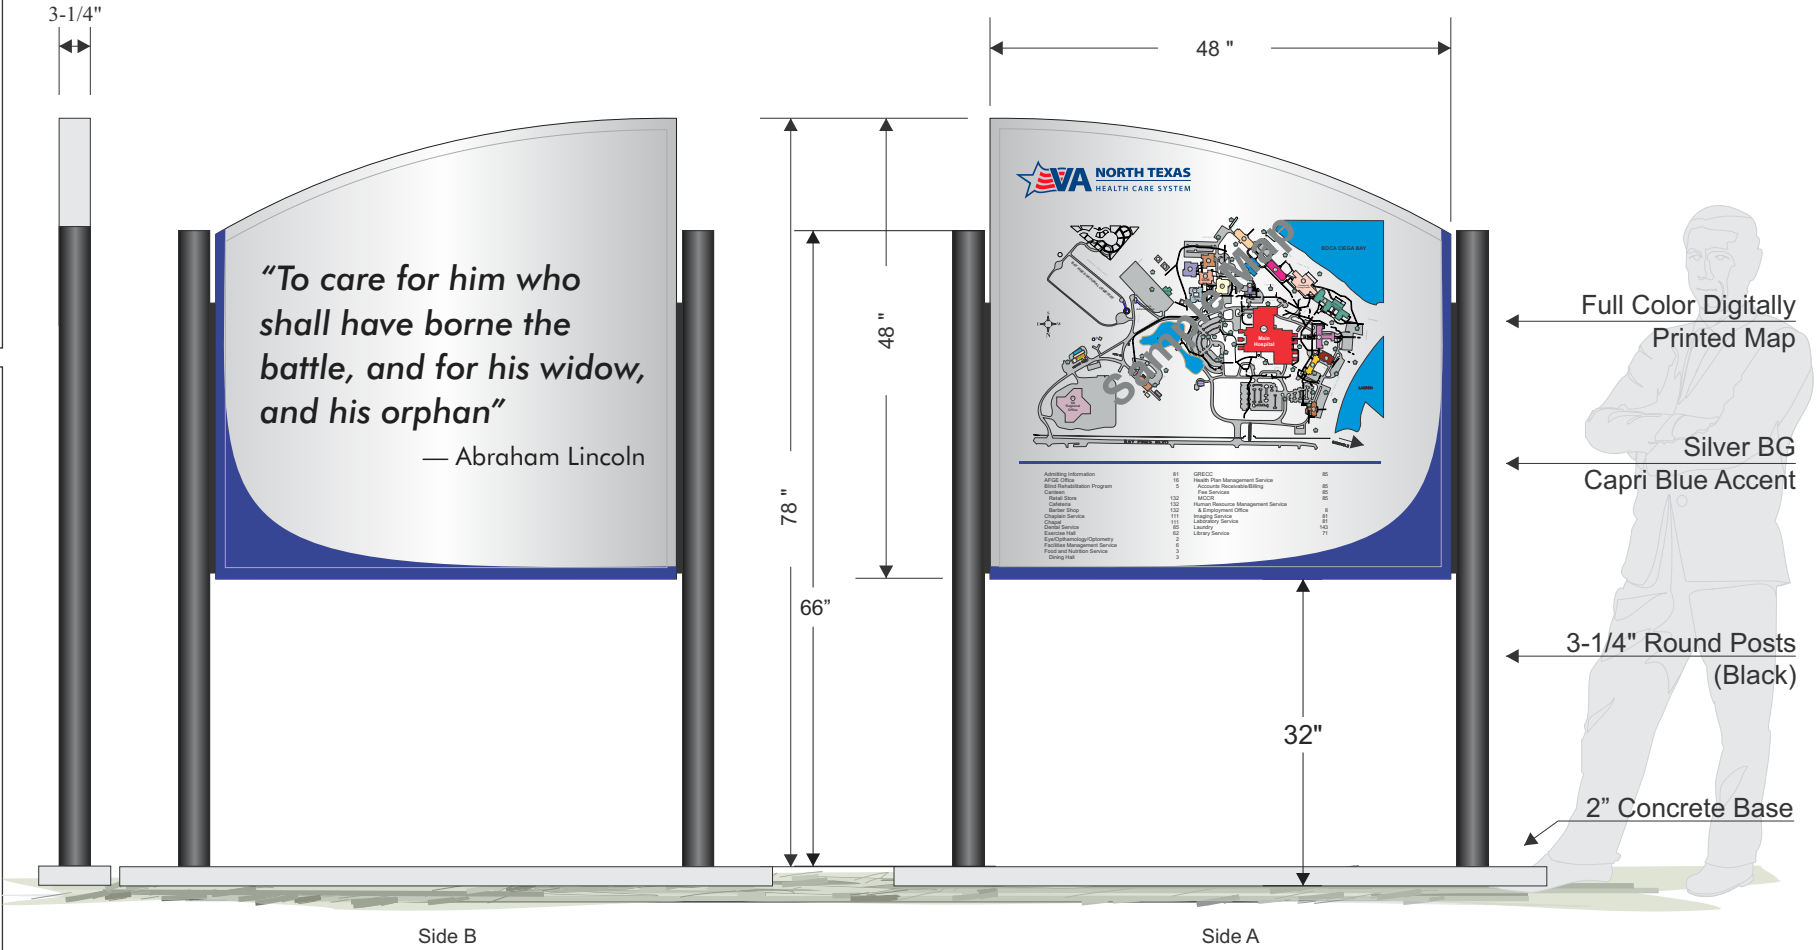

- ← Full Color Digitallly Printed Map
- ← Silver BG Capri Blue Accent
- ← 3-1/4" Round Posts (Black)
- ← 2" Concrete Base


VAMC Dallas, TX		
Scale: 1:20	Designer: John T. Mayer	Drawn By: MEA
Date: 5.03.2016	Revised: 06.07.2016	
Type 6/325 D/F Post & Panel		

CREATIVE SIGNAGE SYSTEMS

9101 51st PLACE COLLEGE PARK, MARYLAND 20740

PHONE 301.345.3700 FAX 301.220.0289 WWW.CREATIVESIGNAGE.COM

Note: All drawings, notations and design themes expressed herein remain the sole property of Creative Signage Systems and may not be reproduced without written consent.

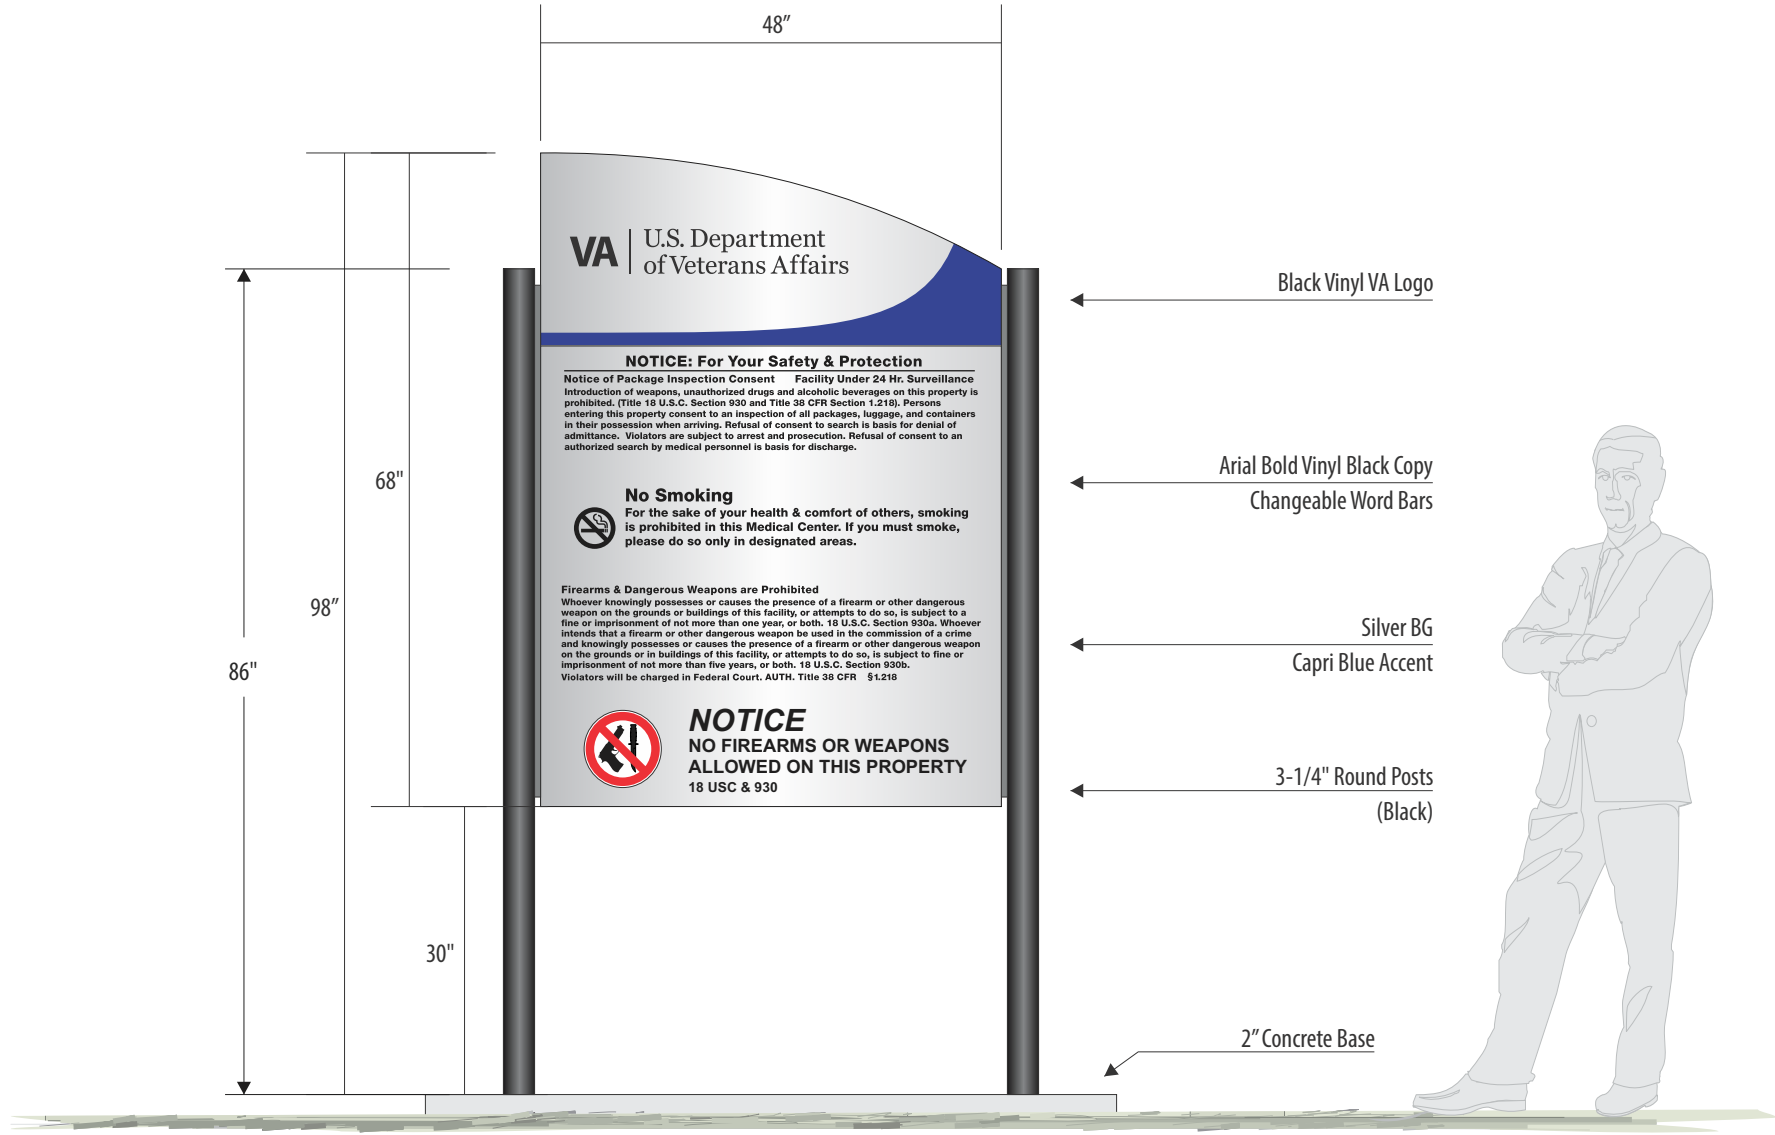


VAMC Dallas, TX	
Scale: 1:20	Designer: John T. Mayer
Date: 5.03.2016	Revised: 06.07.2016
	Drawn By: MEA
Type: 4/CWB Post & Panel D/F	


CREATIVE SIGNAGE SYSTEMS
 9101 51st PLACE COLLEGE PARK, MARYLAND 20740
 PHONE 301.345.3700 FAX 301.220.0289 WWW.CREATIVESIGNAGE.COM

Note: All drawings, notations and design themes expressed herein remain the sole property of Creative Signage Systems and may not be reproduced without written consent.

Aluminum Sign Extrusions to contain 75% Recycled Content.

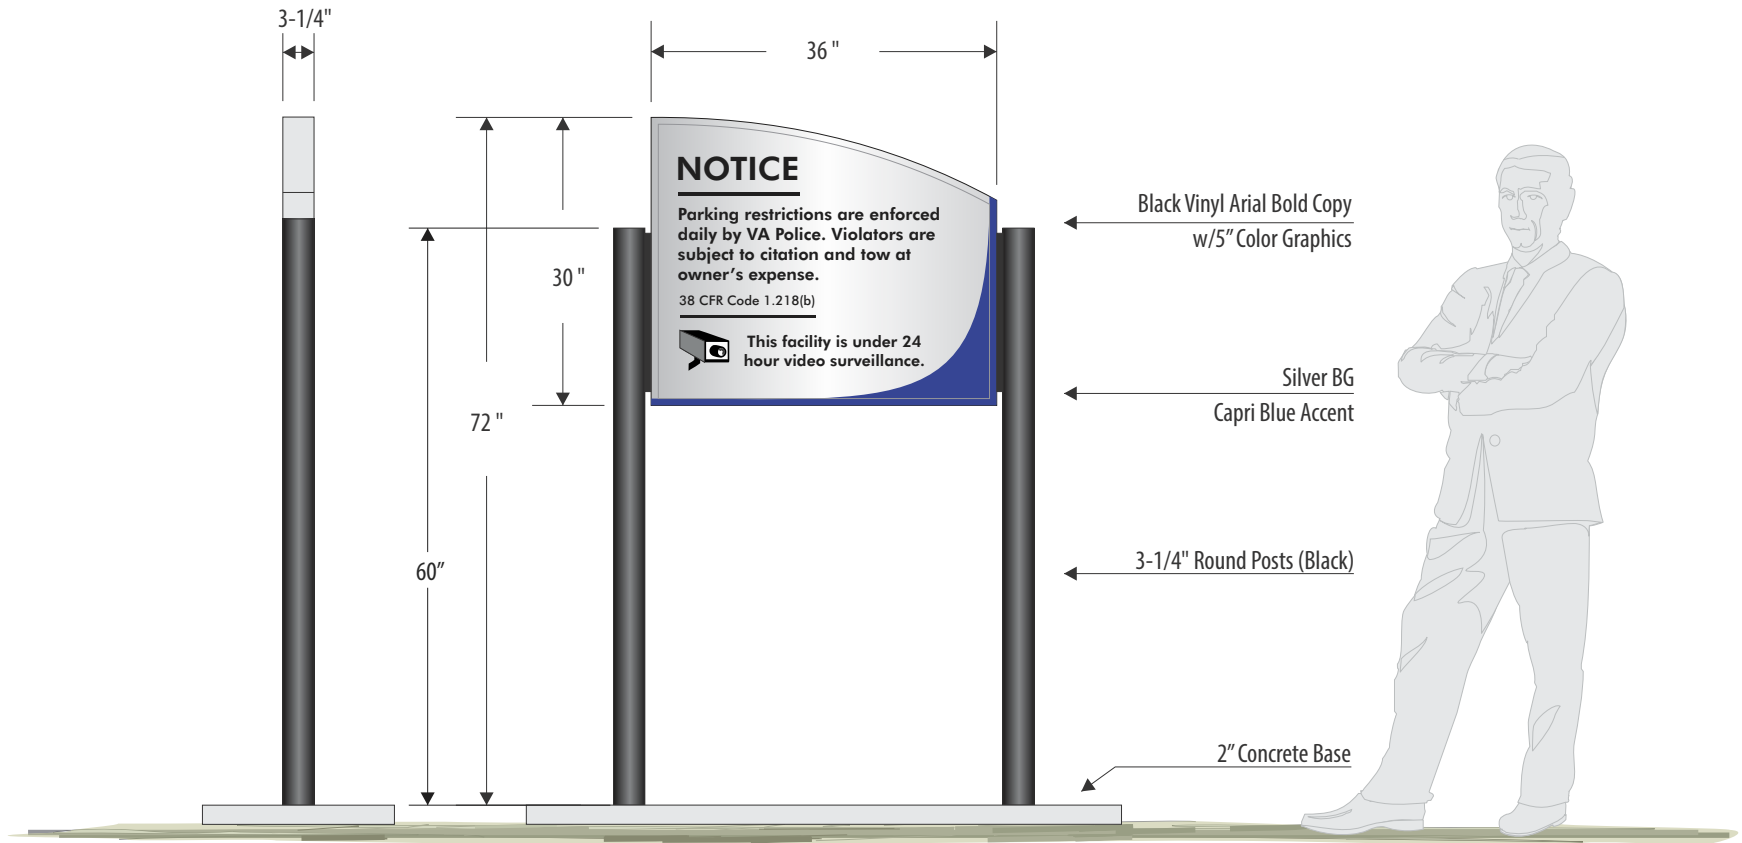

VAMC Dallas, TX

Scale: 1:20

Designer: John T. Mayer

Drawn By: MEA

Date: 5.03.2016

Revised: 06.07.2016


Type 6/325 S/F Post & Panel

CREATIVE SIGNAGE SYSTEMS

9101 51st PLACE COLLEGE PARK, MARYLAND 20740
PHONE 301.345.3700 FAX 301.220.0289 WWW.CREATIVESIGNAGE.COM

Note: All drawings, notations and design themes expressed herein remain the sole property of Creative Signage Systems and may not be reproduced without written consent.

Aluminum Sign Extrusions to contain 75% Recycled Content.

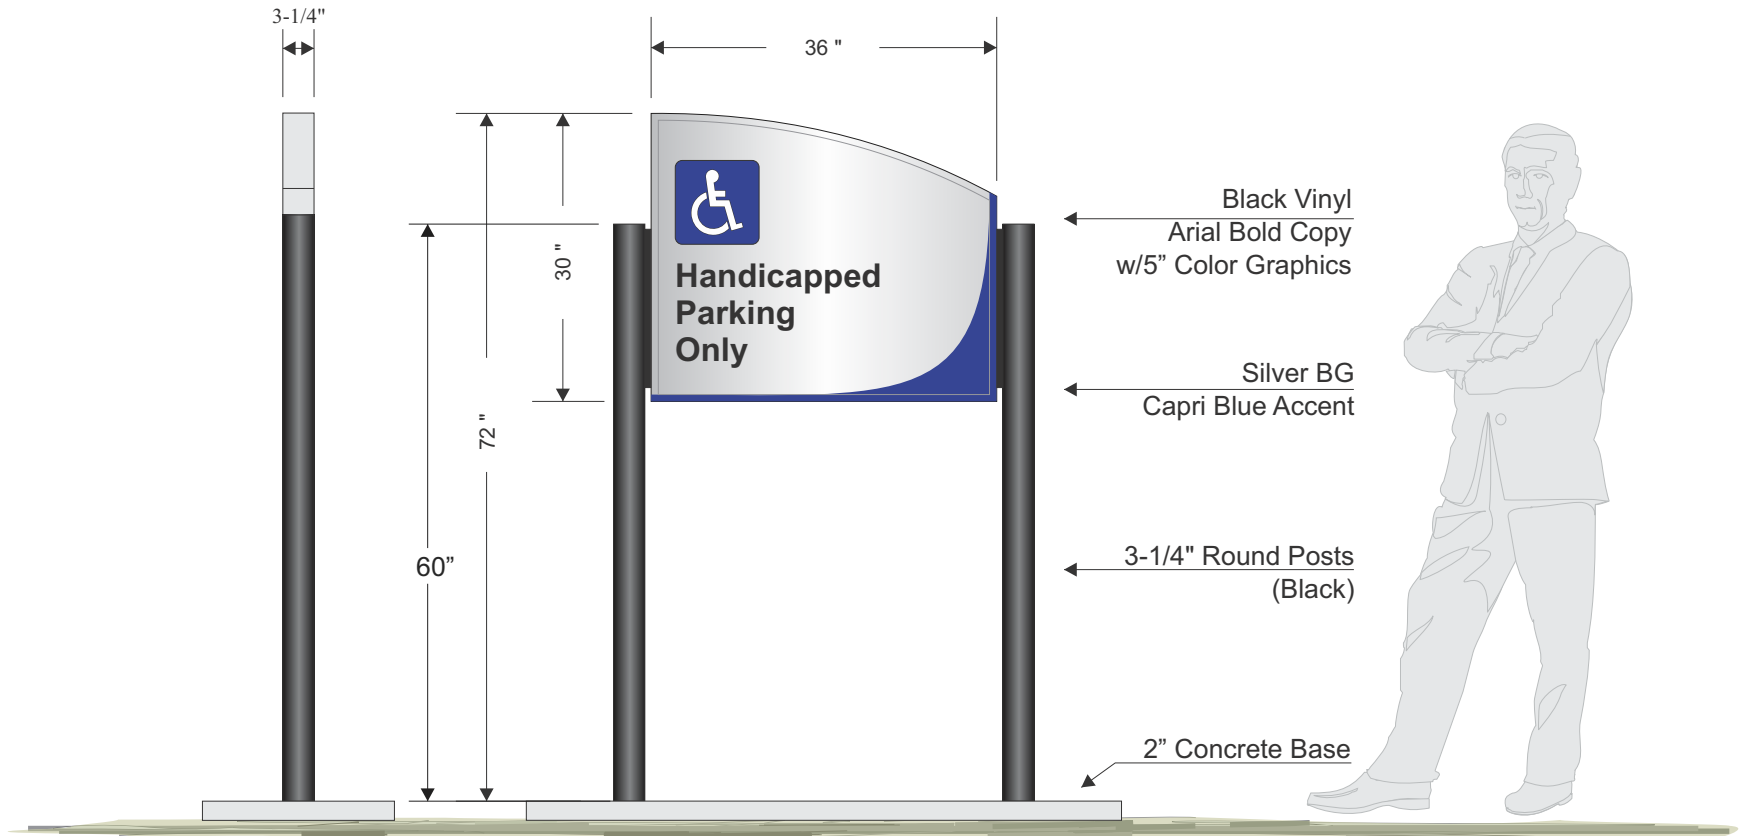

VAMC Dallas, TX

Scale: 1:20

Designer: John T. Mayer

Drawn By: MEA

Date: 5.03.2016

Revised: 06.07.2016


Type 6/325 S/F Post & Panel

CREATIVE SIGNAGE SYSTEMS

9101 51st PLACE COLLEGE PARK, MARYLAND 20740
PHONE 301.345.3700 FAX 301.220.0289 WWW.CREATIVESIGNAGE.COM

Note: All drawings, notations and design themes expressed herein remain the sole property of Creative Signage Systems and may not be reproduced without written consent.

Aluminum Sign Extrusions to contain 75% Recycled Content.

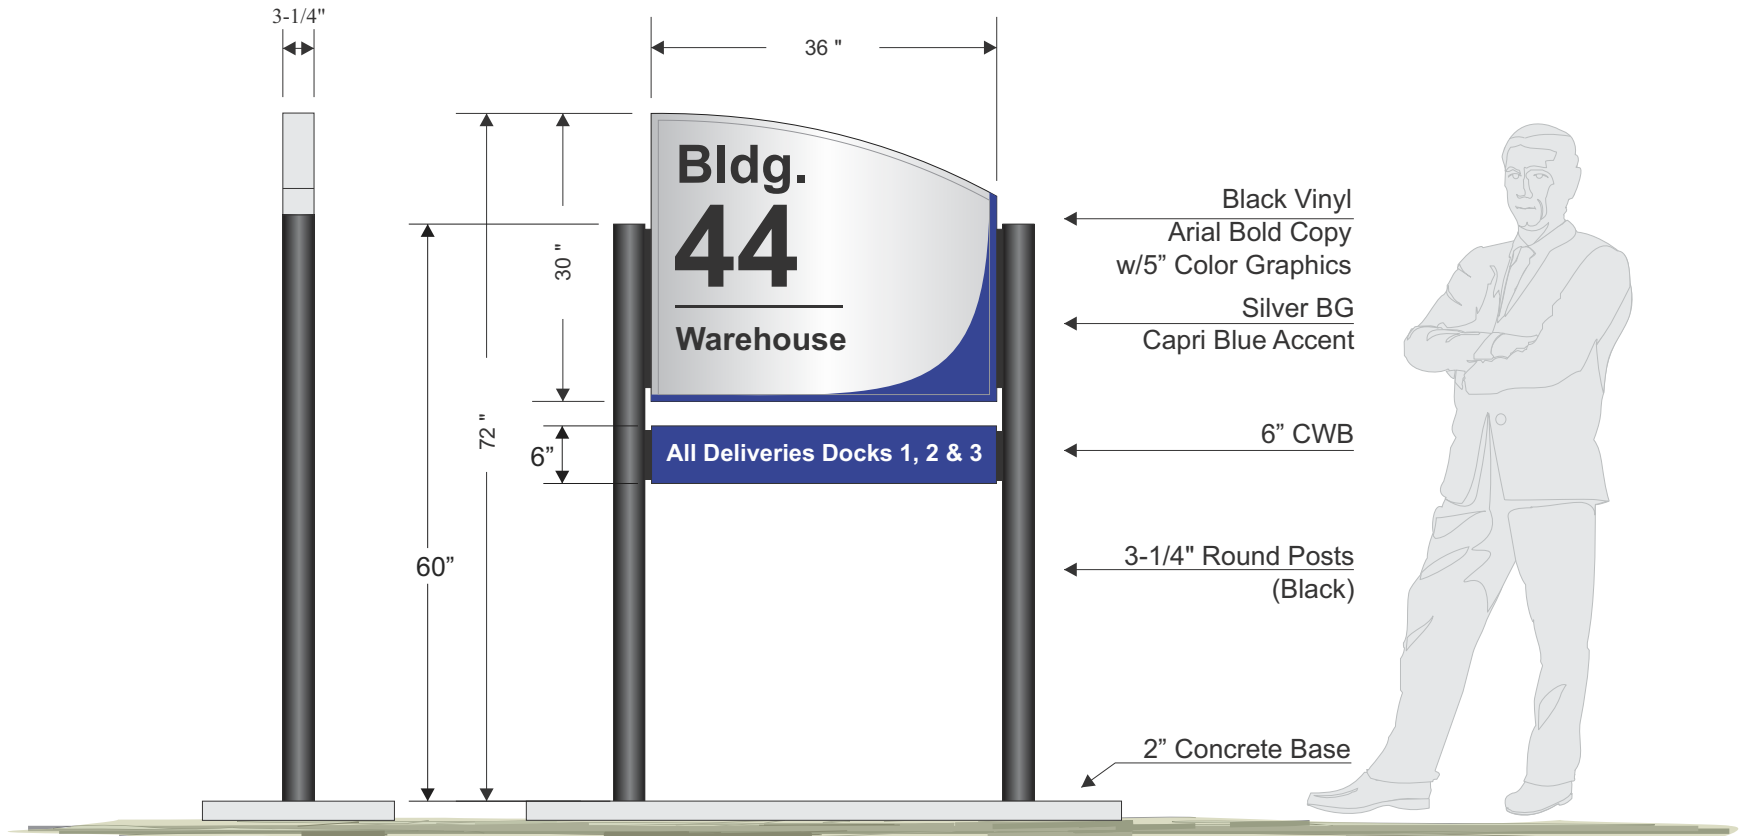

Loc. A21

VAMC Dallas, TX

Scale: 1:20

Designer: John T. Mayer

Drawn By: MEA

Date: 5.03.2016

Revised: 06.07.2016


Type: 6/325 D/F + CWB Post & Panel

CREATIVE SIGNAGE SYSTEMS

9101 51st PLACE COLLEGE PARK, MARYLAND 20740
PHONE 301.345.3700 FAX 301.220.0289 WWW.CREATIVESIGNAGE.COM

Note: All drawings, notations and design themes expressed herein remain the sole property of Creative Signage Systems and may not be reproduced without written consent.

Aluminum Sign Extrusions to contain 75% Recycled Content.

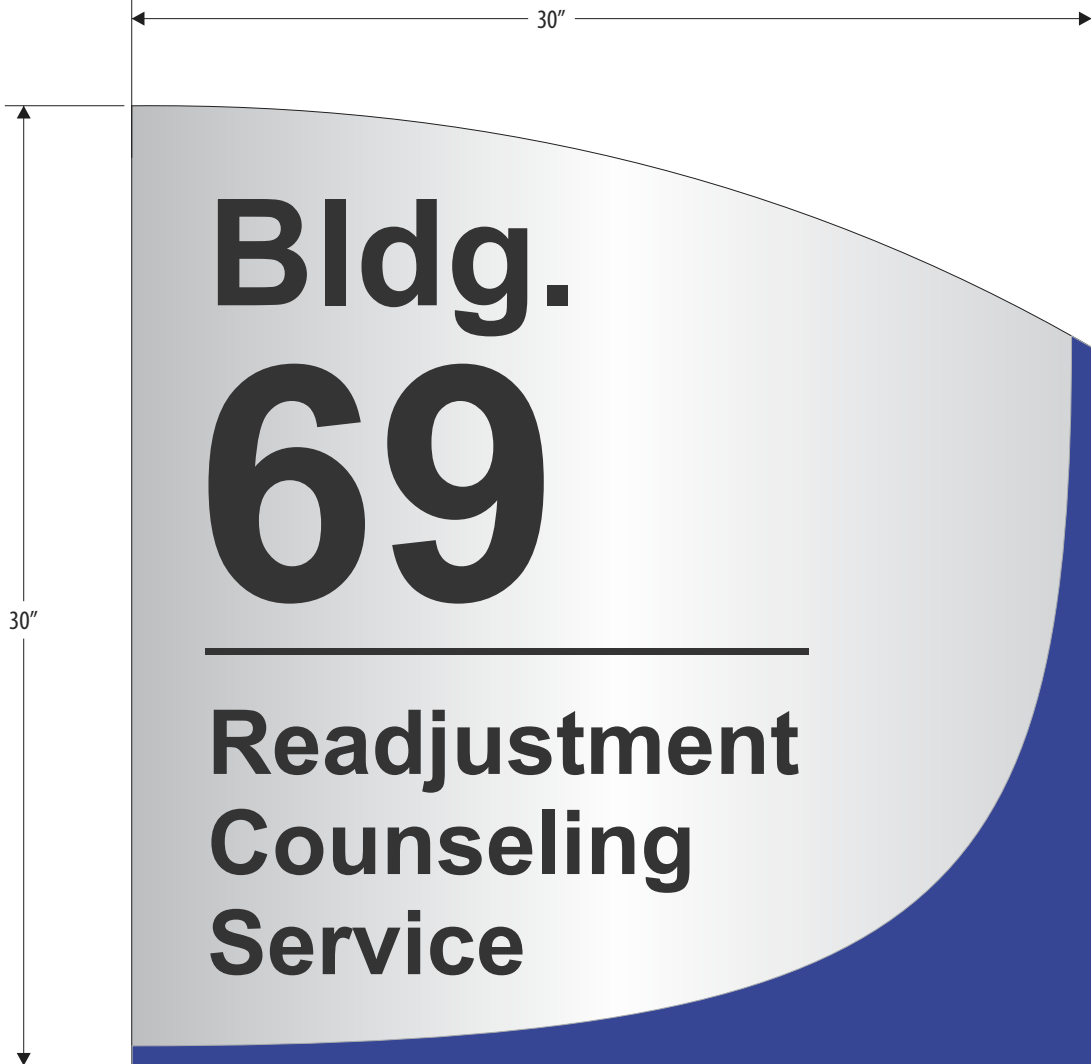

- ← Black Vinyl
Arial Bold Copy
- ← Silver Background
with Capri Blue Accent
- ← 1/8" Aluminum Panel

VAMC Dallas, TX

Scale: 1:6	Designer: John T. Mayer	Drawn By: MEA
Date: 5.03.2016	Revised: 06.07.2016	



Type: 8/218 Wall Mounted

CREATIVE SIGNAGE SYSTEMS

9101 51st PLACE COLLEGE PARK, MARYLAND 20740
PHONE 301.345.3700 FAX 301.220.0289 WWW.CREATIVESIGNAGE.COM

Note: All drawings, notations and design themes expressed herein remain the sole property of Creative Signage Systems and may not be reproduced without written consent.

Aluminum Sign Extrusions to contain 75% Recycled Content.

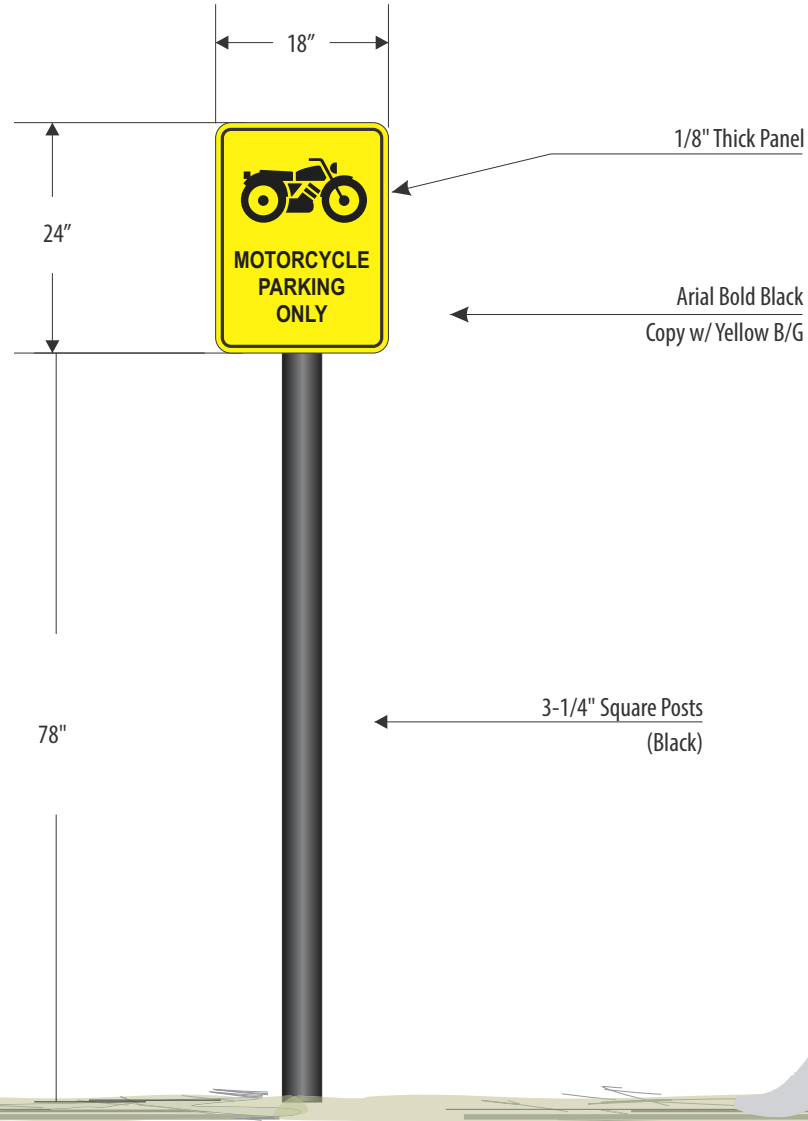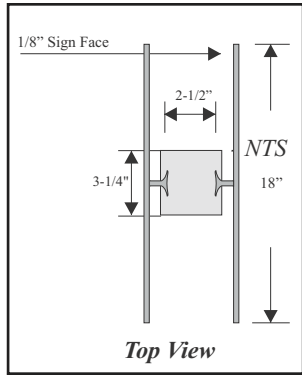

VAMC Dallas, TX	
Scale: 1:20	Designer: John T. Mayer
Date: 5.03.2016	Revised: 06.07.2016
Drawn By: MEA	
Type: 5/218 D/F - Single Post	




CREATIVE SIGNAGE SYSTEMS

9101 51st PLACE COLLEGE PARK, MARYLAND 20740
PHONE 301.345.3700 FAX 301.220.0289 WWW.CREATIVESIGNAGE.COM

Note: All drawings, notations and design themes expressed herein remain the sole property of Creative Signage Systems and may not be reproduced without written consent.

Loc. A9.9

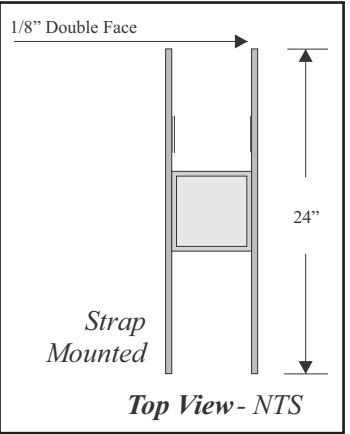

Two Single faced signs attached to pole

1/2" Radius corners
1/8" Aluminum Panel

Top Section
Black Arial Bold Copy

Silver BG
Capri Blue Accent

Attaches Directly to Pole 15' Above Ground

Mounting uses Stainless Steel Straps

VAMC Dallas, TX		
Scale: 1:8	Designer: John T. Mayer	Drawn By: MEA
Date: 5.03.2016	Revised: 06.07.2016	
Type: 8/218 D/F		

CREATIVE SIGNAGE SYSTEMS

9101 51st PLACE COLLEGE PARK, MARYLAND 20740
 PHONE 301.345.3700 FAX 301.220.0289 WWW.CREATIVESIGNAGE.COM

Note: All drawings, notations and design themes expressed herein remain the sole property of Creative Signage Systems and may not be reproduced without written consent.

Patient Parking Lots - Utility Pole ID



42"

24"



Lot

1

Sec A

Mounting uses
Stainless Steel Straps


Two Single faced signs
attached to pole

1/2" Radius corners
1/8" Aluminum Panel

Top Section
Black Arial Bold Copy

Silver BG
Capri Blue Accent

Attaches Directly
to Pole 15'
Above Ground

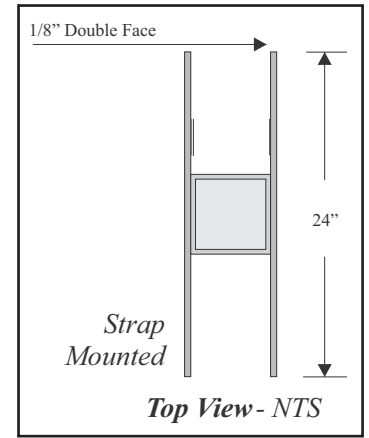

1/8" Double Face

24"

Strap
Mounted

Top View - NTS

VAMC Dallas, TX

Scale: 1:8

Designer: John T. Mayer

Drawn By: MEA

Date: 5.03.2016

Revised: 06.07.2016


Type: 8/218 D/F

CREATIVE SIGNAGE SYSTEMS

9101 51st PLACE COLLEGE PARK, MARYLAND 20740
PHONE 301.345.3700 FAX 301.220.0289 WWW.CREATIVESIGNAGE.COM

Note: All drawings, notations and design themes expressed herein remain the sole property of Creative Signage Systems and may not be reproduced without written consent.

Patient Parking Lot 1 - Utility Pole ID

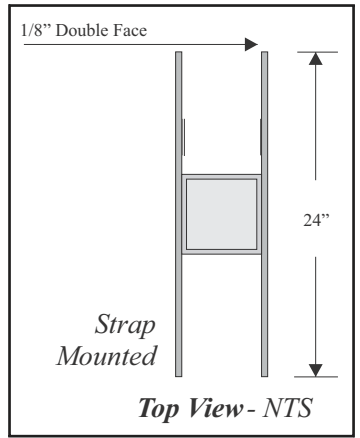

Two Single faced signs attached to pole

1/2" Radius corners
1/8" Aluminum Panel

Digitally Printed on Aluminum

Attaches Directly to Pole 15' Above Ground

Stainless Steel Strap Mounting

VAMC Dallas, TX		
Scale: 1:8	Designer: John T. Mayer	Drawn By: MEA
Date: 5.03.2016	Revised: 06.07.2016	
Type: 8/218 D/F		



CREATIVE SIGNAGE SYSTEMS

9101 51st PLACE COLLEGE PARK, MARYLAND 20740
 PHONE 301.345.3700 FAX 301.220.0289 WWW.CREATIVESIGNAGE.COM

Liberty Loop Graphics - Utility Pole ID

Note: All drawings, notations and design themes expressed herein remain the sole property of Creative Signage Systems and may not be reproduced without written consent.

LED Illuminated Cabinet with
Full Color Panaflex
Translucent Face



VAMC Dallas, TX

Scale: 1:6	Designer: John T. Mayer	Drawn By: MEA
Date: 5.03.2016	Revised: 06.07.2016	

Type: Illuminated Flex Face Box



CREATIVE SIGNAGE SYSTEMS

9101 51st PLACE COLLEGE PARK, MARYLAND 20740
PHONE 301.345.3700 FAX 301.220.0289 WWW.CREATIVESIGNAGE.COM

Note: All drawings, notations and design themes expressed herein remain the sole property of Creative Signage Systems and may not be reproduced without written consent.



WHITE

LED Illuminated Cabinet with
Full Color Panaflex
Translucent Face


60"

70"

VAMC Dallas, TX

Scale: 1:6	Designer: John T. Mayer	Drawn By: MEA
Date: 5.03.2016	Revised: 06.07.2016	

Type: Illuminated Flex Face Box

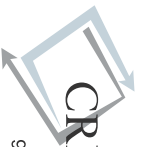

CREATIVE SIGNAGE SYSTEMS

9101 51st PLACE COLLEGE PARK, MARYLAND 20740
PHONE 301.345.3700 FAX 301.220.0289 WWW.CREATIVESIGNAGE.COM

Note: All drawings, notations and design themes expressed herein remain the sole property of Creative Signage Systems and may not be reproduced without written consent.

LED Illuminated Cabinet with
Full Color Panaflex
Translucent Face



VAMC Dallas, TX

Scale: 1:6	Designer: John T. Mayer	Drawn By: MEA
Date: 5.03.2016	Revised: 06.07.2016	

Type: Illuminated Flex Face Box

CREATIVE SIGNAGE SYSTEMS

9101 51st PLACE COLLEGE PARK, MARYLAND 20740
PHONE 301.345.3700 FAX 301.220.0289 WWW.CREATIVESIGNAGE.COM

Note: All drawings, notations and design themes expressed herein remain the sole property of Creative Signage Systems and may not be reproduced without written consent.