

EDWARD HINES, JR. VA HOSPITAL

RFP: UPDATE HINES CAPITAL ASSETS INVENTORY RECORDS

KUTC


FILE:


FACILITY DEPARTMENT FLOOR PLAN - LEVEL 01-C

BLDG NUMBER: 001

PROJECT NUMBER: 578-14-01

DRAWING SCALE: 3/32" = 1'-0"

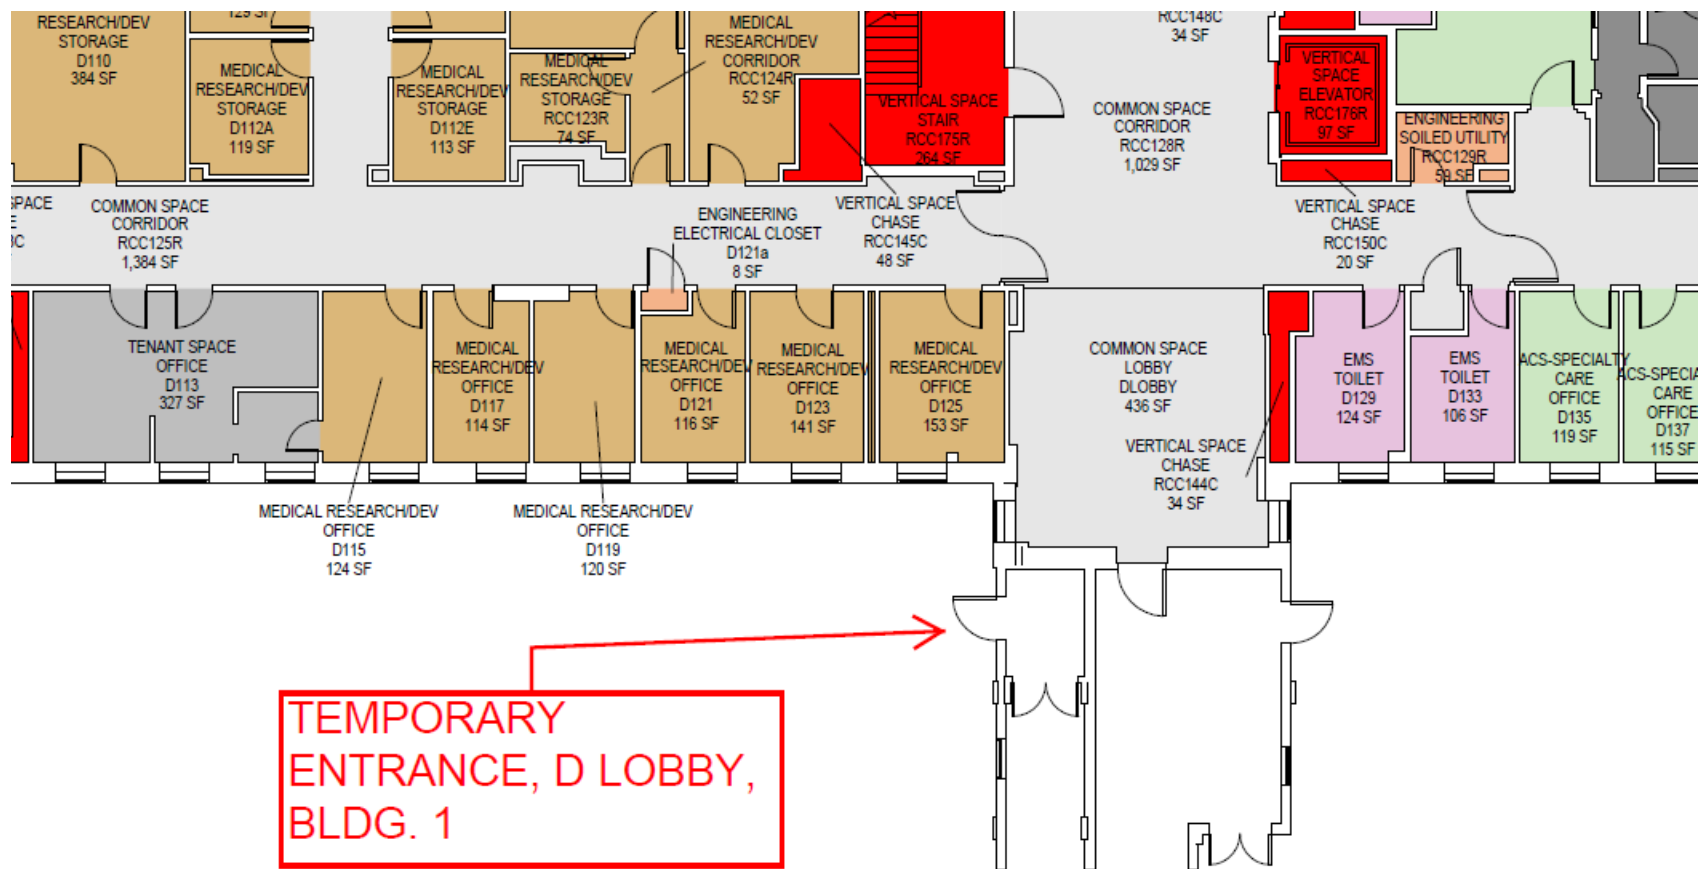

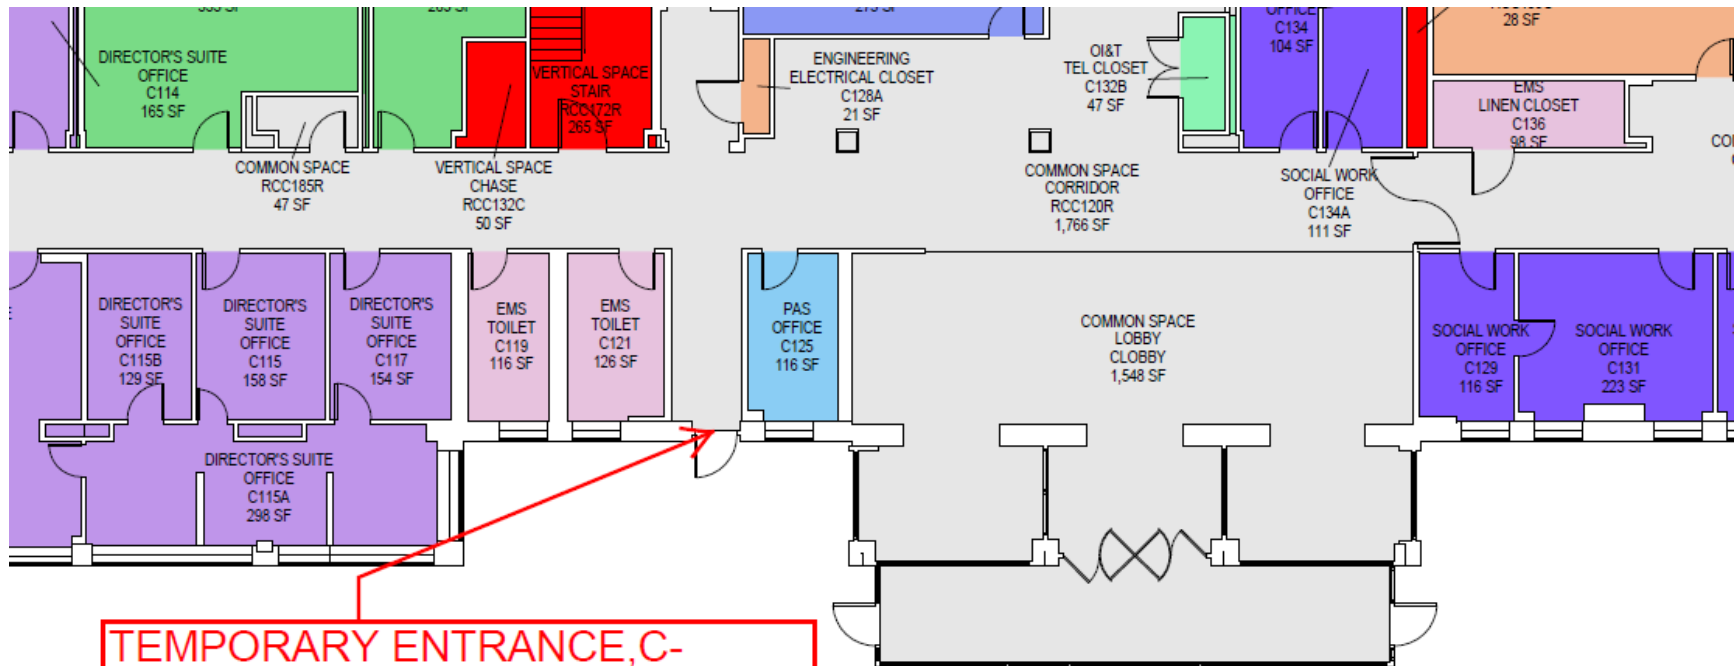

ENT &
JECT
ME:

EDWARD HINES, JR. VA HOSPITAL

RFP: UPDATE HINES CAPITAL ASSETS INVENTORY RECORDS

AWING TITLE:

FACILITY DEPARTMENT FLOOR PLAN - LEVEL 01-C

