




NORTH

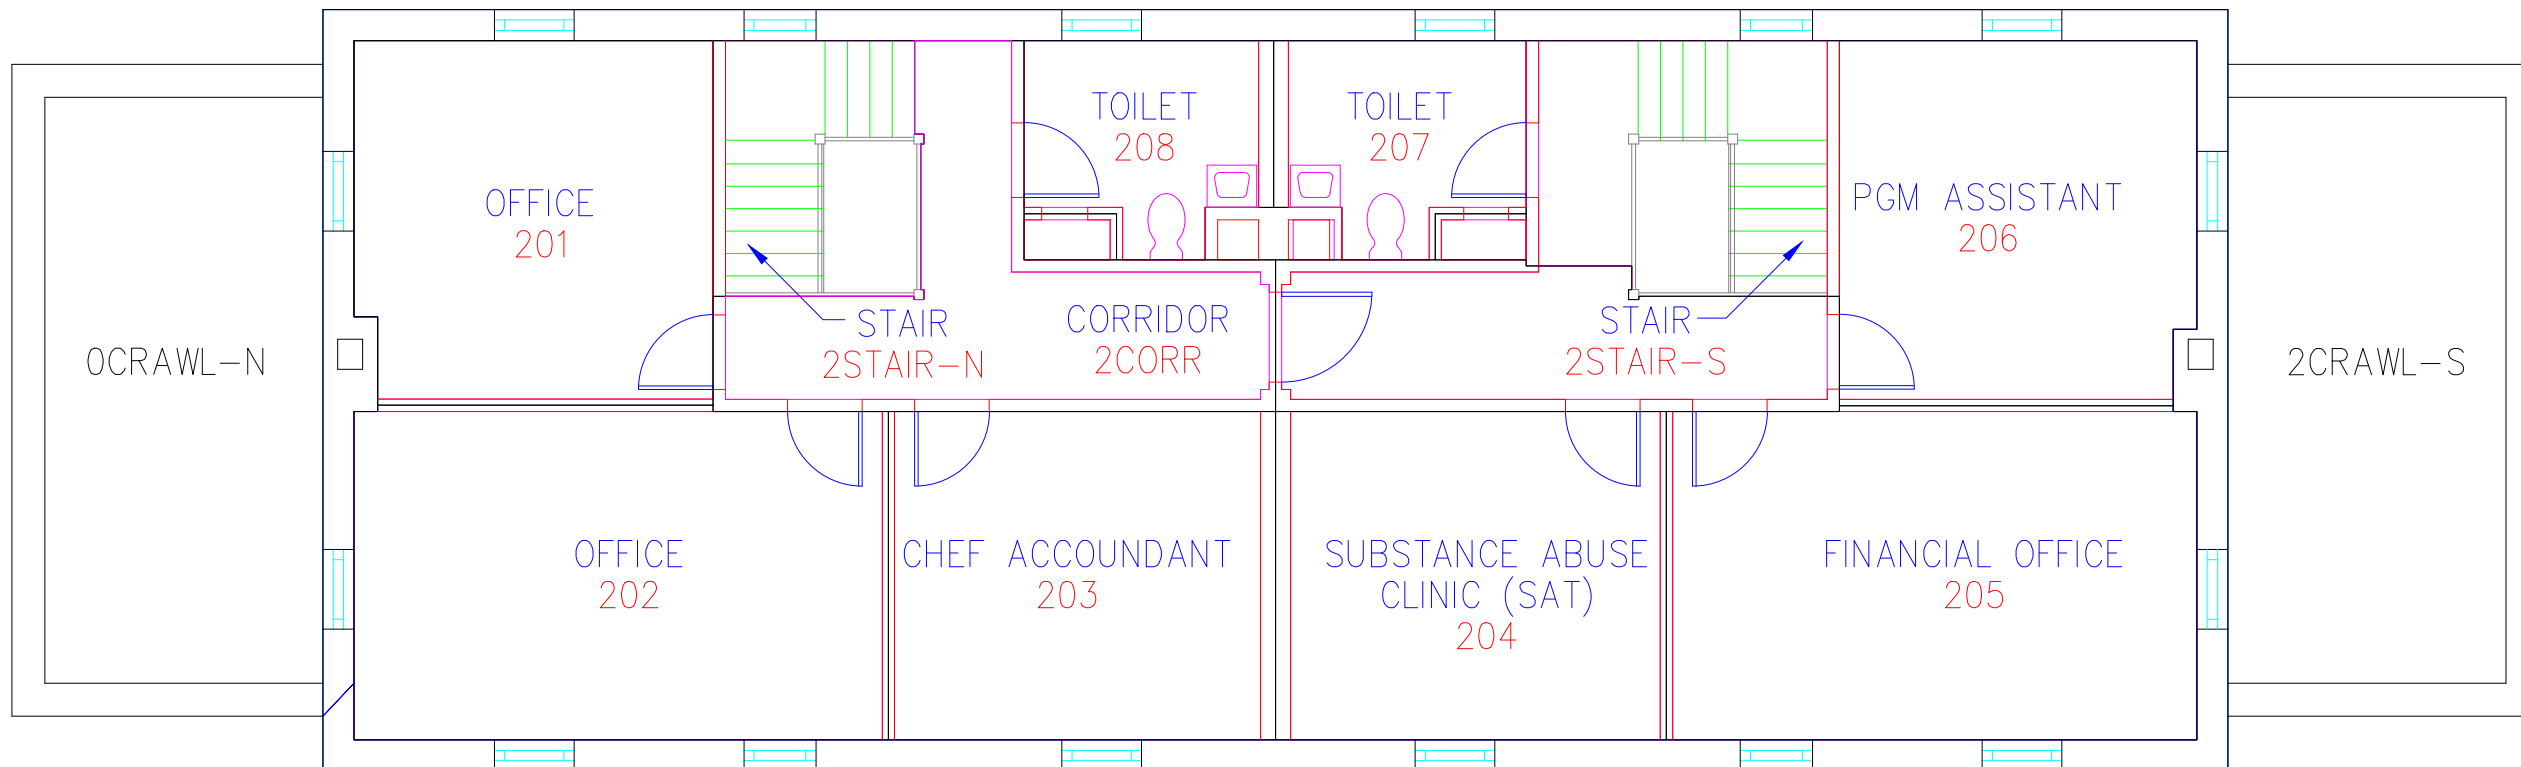

BUILDING 7, FLOOR 2

				 Indus Systems, Inc. 2352, Main Street, Concord MA 01742 Tel: 978-461-0555 www.indus-systems.com				Drawing Title SECOND FLOOR PLAN ARCHITECTURAL		Date 01-23-2012			VA Department of Veterans Affairs	
								Checked		Drawn				Drawing No. WI-07-02AR
Revisions		Date		Professional Seal				Location VAMC & ROC WICHITA, KS						