

0 1 2 3 4 5 6 7 8 9

A
three inches = one foot

B
one and one-half inches = one foot

C
one inch = one foot

D
three-quarters inch = one foot


E
one-half inch = one foot

F
three-eighths inch = one foot

G
one-quarter inch = one foot

H
one-eighth inch = one foot

I
one-sixteenth inch = one foot

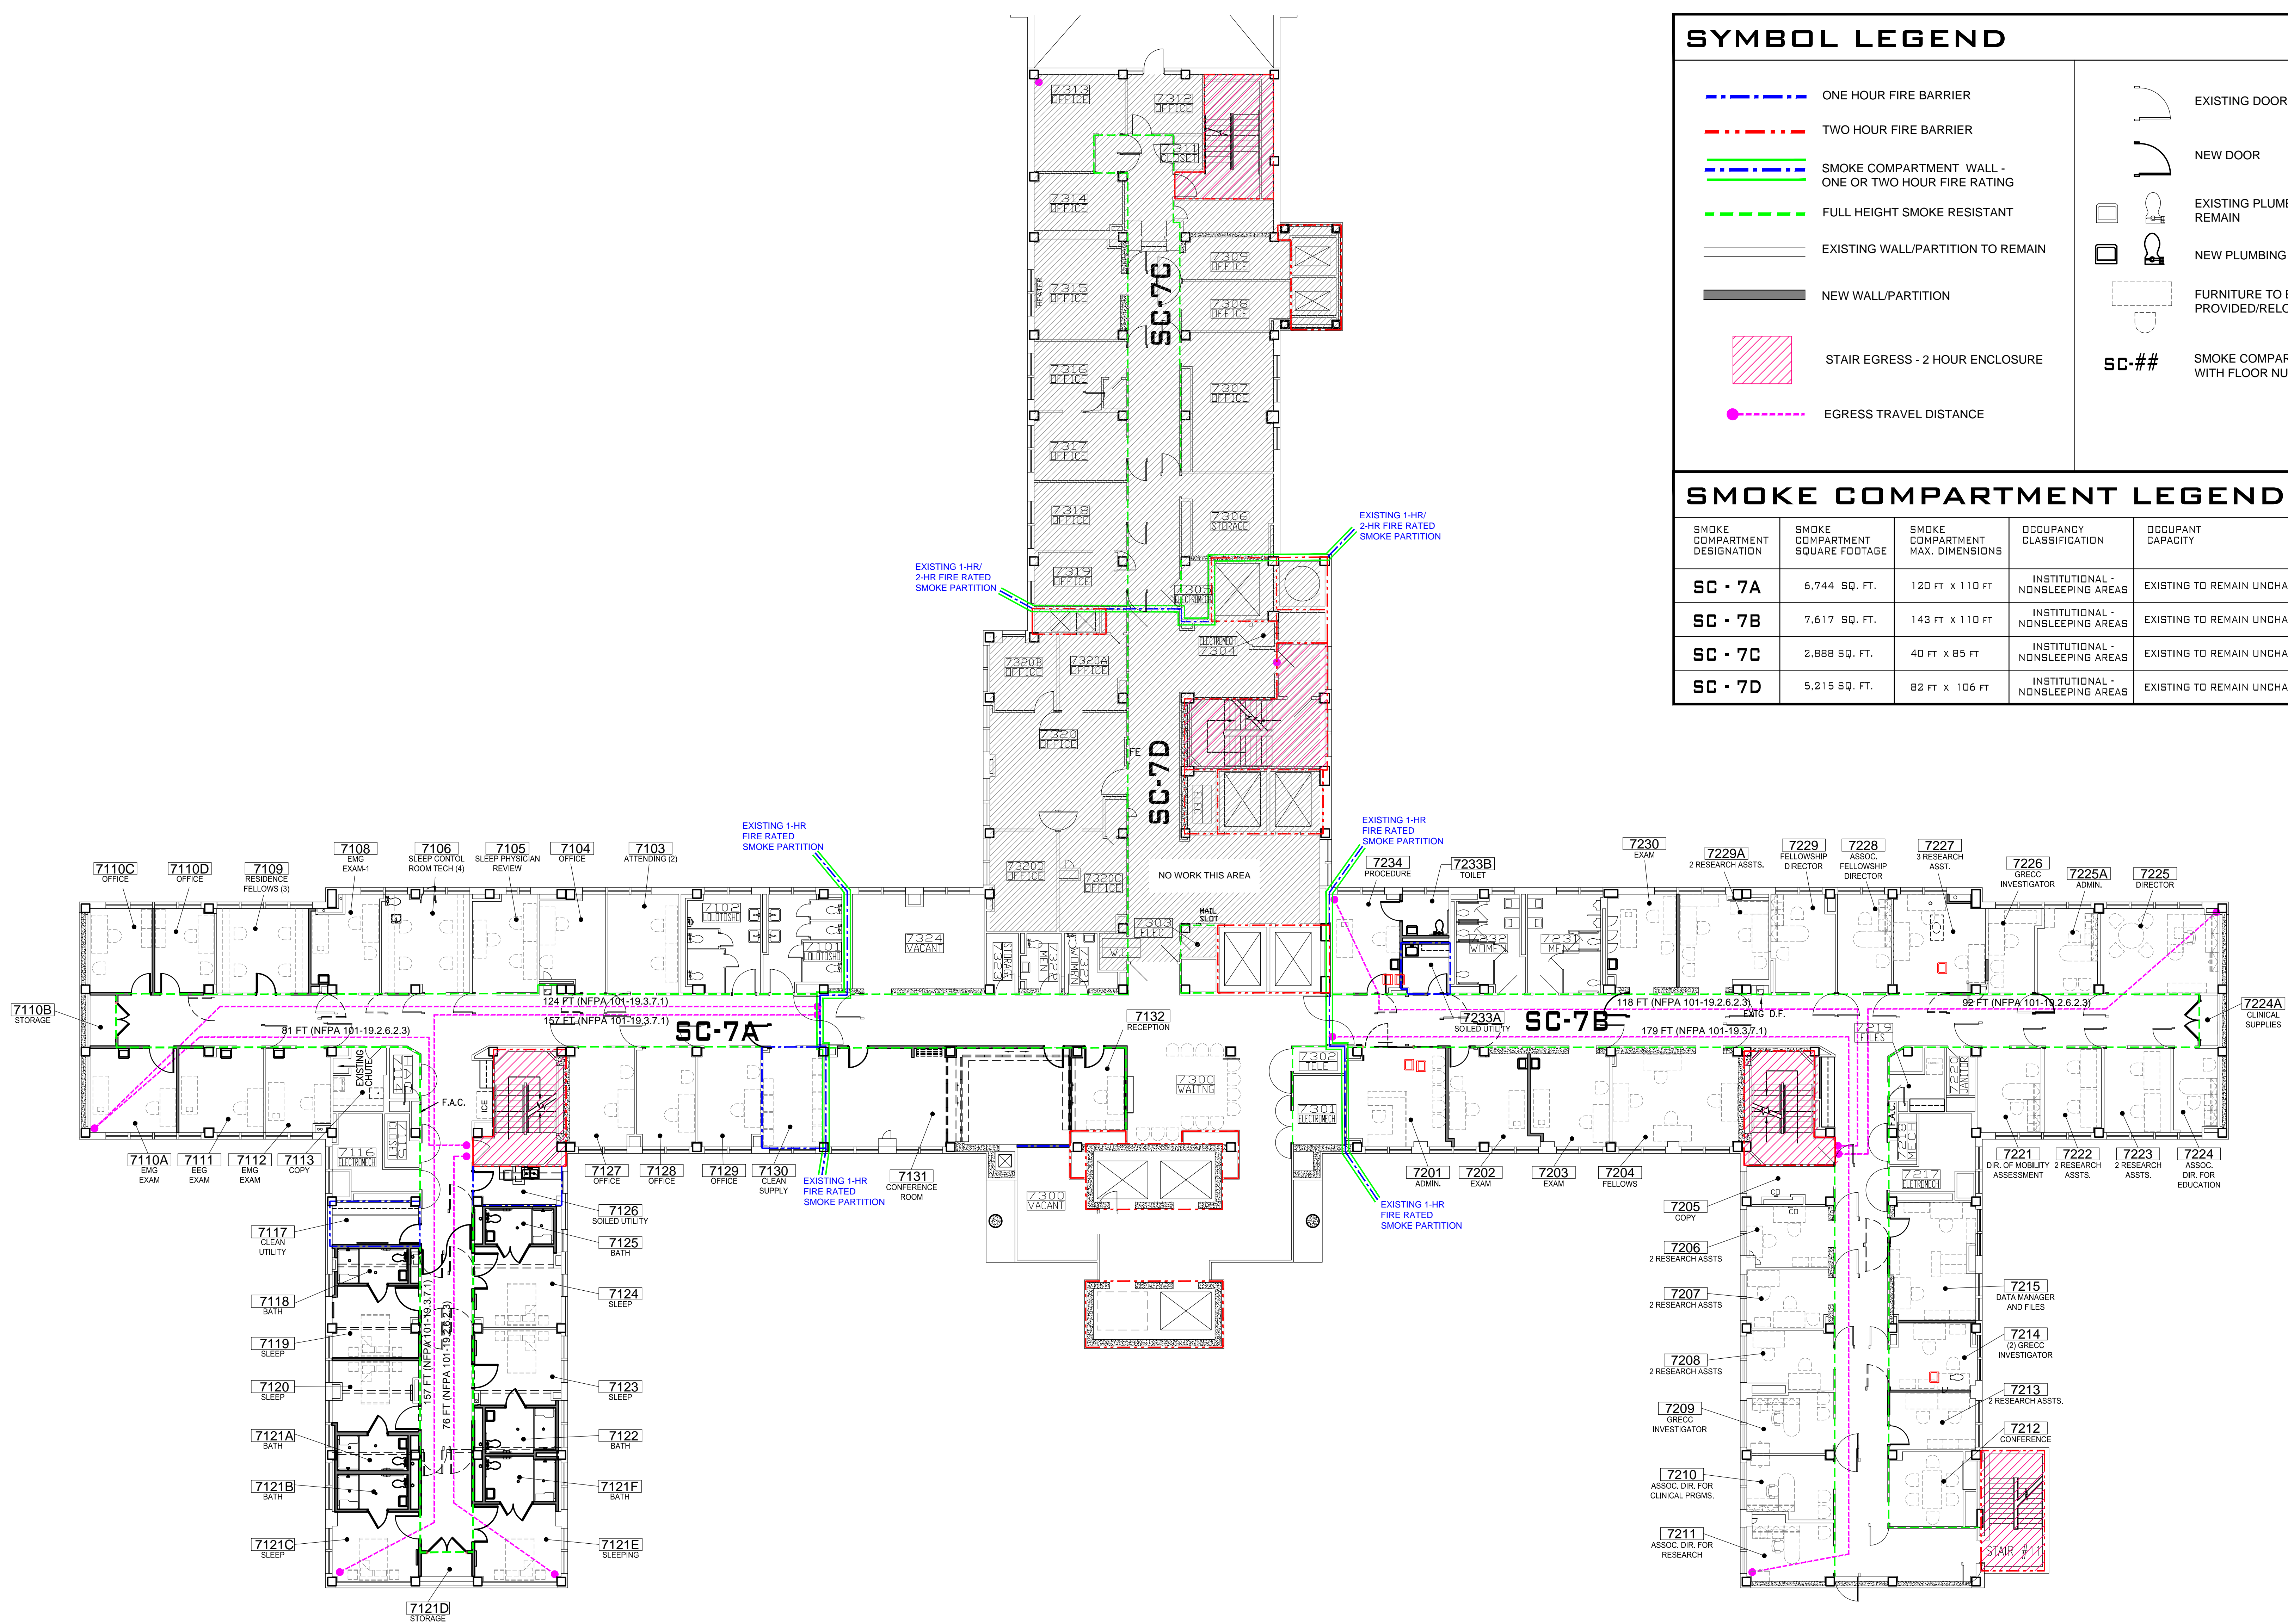

SYMBOL LEGEND

---	ONE HOUR FIRE BARRIER		EXISTING DOOR TO REMAIN
---	TWO HOUR FIRE BARRIER		NEW DOOR
---	SMOKE COMPARTMENT WALL - ONE OR TWO HOUR FIRE RATING		EXISTING PLUMBING FIXTURE TO REMAIN
---	FULL HEIGHT SMOKE RESISTANT		NEW PLUMBING FIXTURE
---	EXISTING WALL/PARTITION TO REMAIN		FURNITURE TO BE PROVIDED/RELOCATED BY OWNER
---	NEW WALL/PARTITION		SC-## SMOKE COMPARTMENT DESIGNATION WITH FLOOR NUMBER
	STAIR EGRESS - 2 HOUR ENCLOSURE		
	EGRESS TRAVEL DISTANCE		

SMOKE COMPARTMENT LEGEND

SMOKE COMPARTMENT DESIGNATION	SMOKE COMPARTMENT SQUARE FOOTAGE	SMOKE COMPARTMENT MAX. DIMENSIONS	OCCUPANCY CLASSIFICATION	OCCUPANT CAPACITY
SC - 7A	6,744 SQ. FT.	120 FT X 110 FT	INSTITUTIONAL - NONSLEEPING AREAS	EXISTING TO REMAIN UNCHANGED
SC - 7B	7,617 SQ. FT.	143 FT X 110 FT	INSTITUTIONAL - NONSLEEPING AREAS	EXISTING TO REMAIN UNCHANGED
SC - 7C	2,888 SQ. FT.	40 FT X 85 FT	INSTITUTIONAL - NONSLEEPING AREAS	EXISTING TO REMAIN UNCHANGED
SC - 7D	5,215 SQ. FT.	82 FT X 106 FT	INSTITUTIONAL - NONSLEEPING AREAS	EXISTING TO REMAIN UNCHANGED

7TH FLOOR LIFE SAFETY PLAN NEW WORK

1

SCALE: 3/32" = 1'-0"

Revisions	Date	 BIRCHFIELD PENUEL & ASSOCIATES, ARCHITECTS 2805 CRESCENT AVENUE • SUITE 200 • BIRMINGHAM, ALABAMA 35209	 CHARLES E. PENUEL NO. 3366 WILLIAM C. BIRCHFIELD NO. 3341 BIRMINGHAM, ALABAMA	Department of Veterans Affairs MEDICAL CENTER BIRMINGHAM, ALABAMA	Drawing Title	Project Title	Date: 08-02-11	
					7th FLOOR LIFE SAFETY PLAN	RENOVATE SPACE FOR REHAB AND PHYSICAL MEDICINE	VA Project No. 521-10-101 CAD File No. 10709A1.2.dwg	
					Building Numbers	Checked	Drawn	Drawing No.
					Location	VA MEDICAL CENTER BIRMINGHAM, ALABAMA		A1.2
							Dwg. of	Veterans Administration