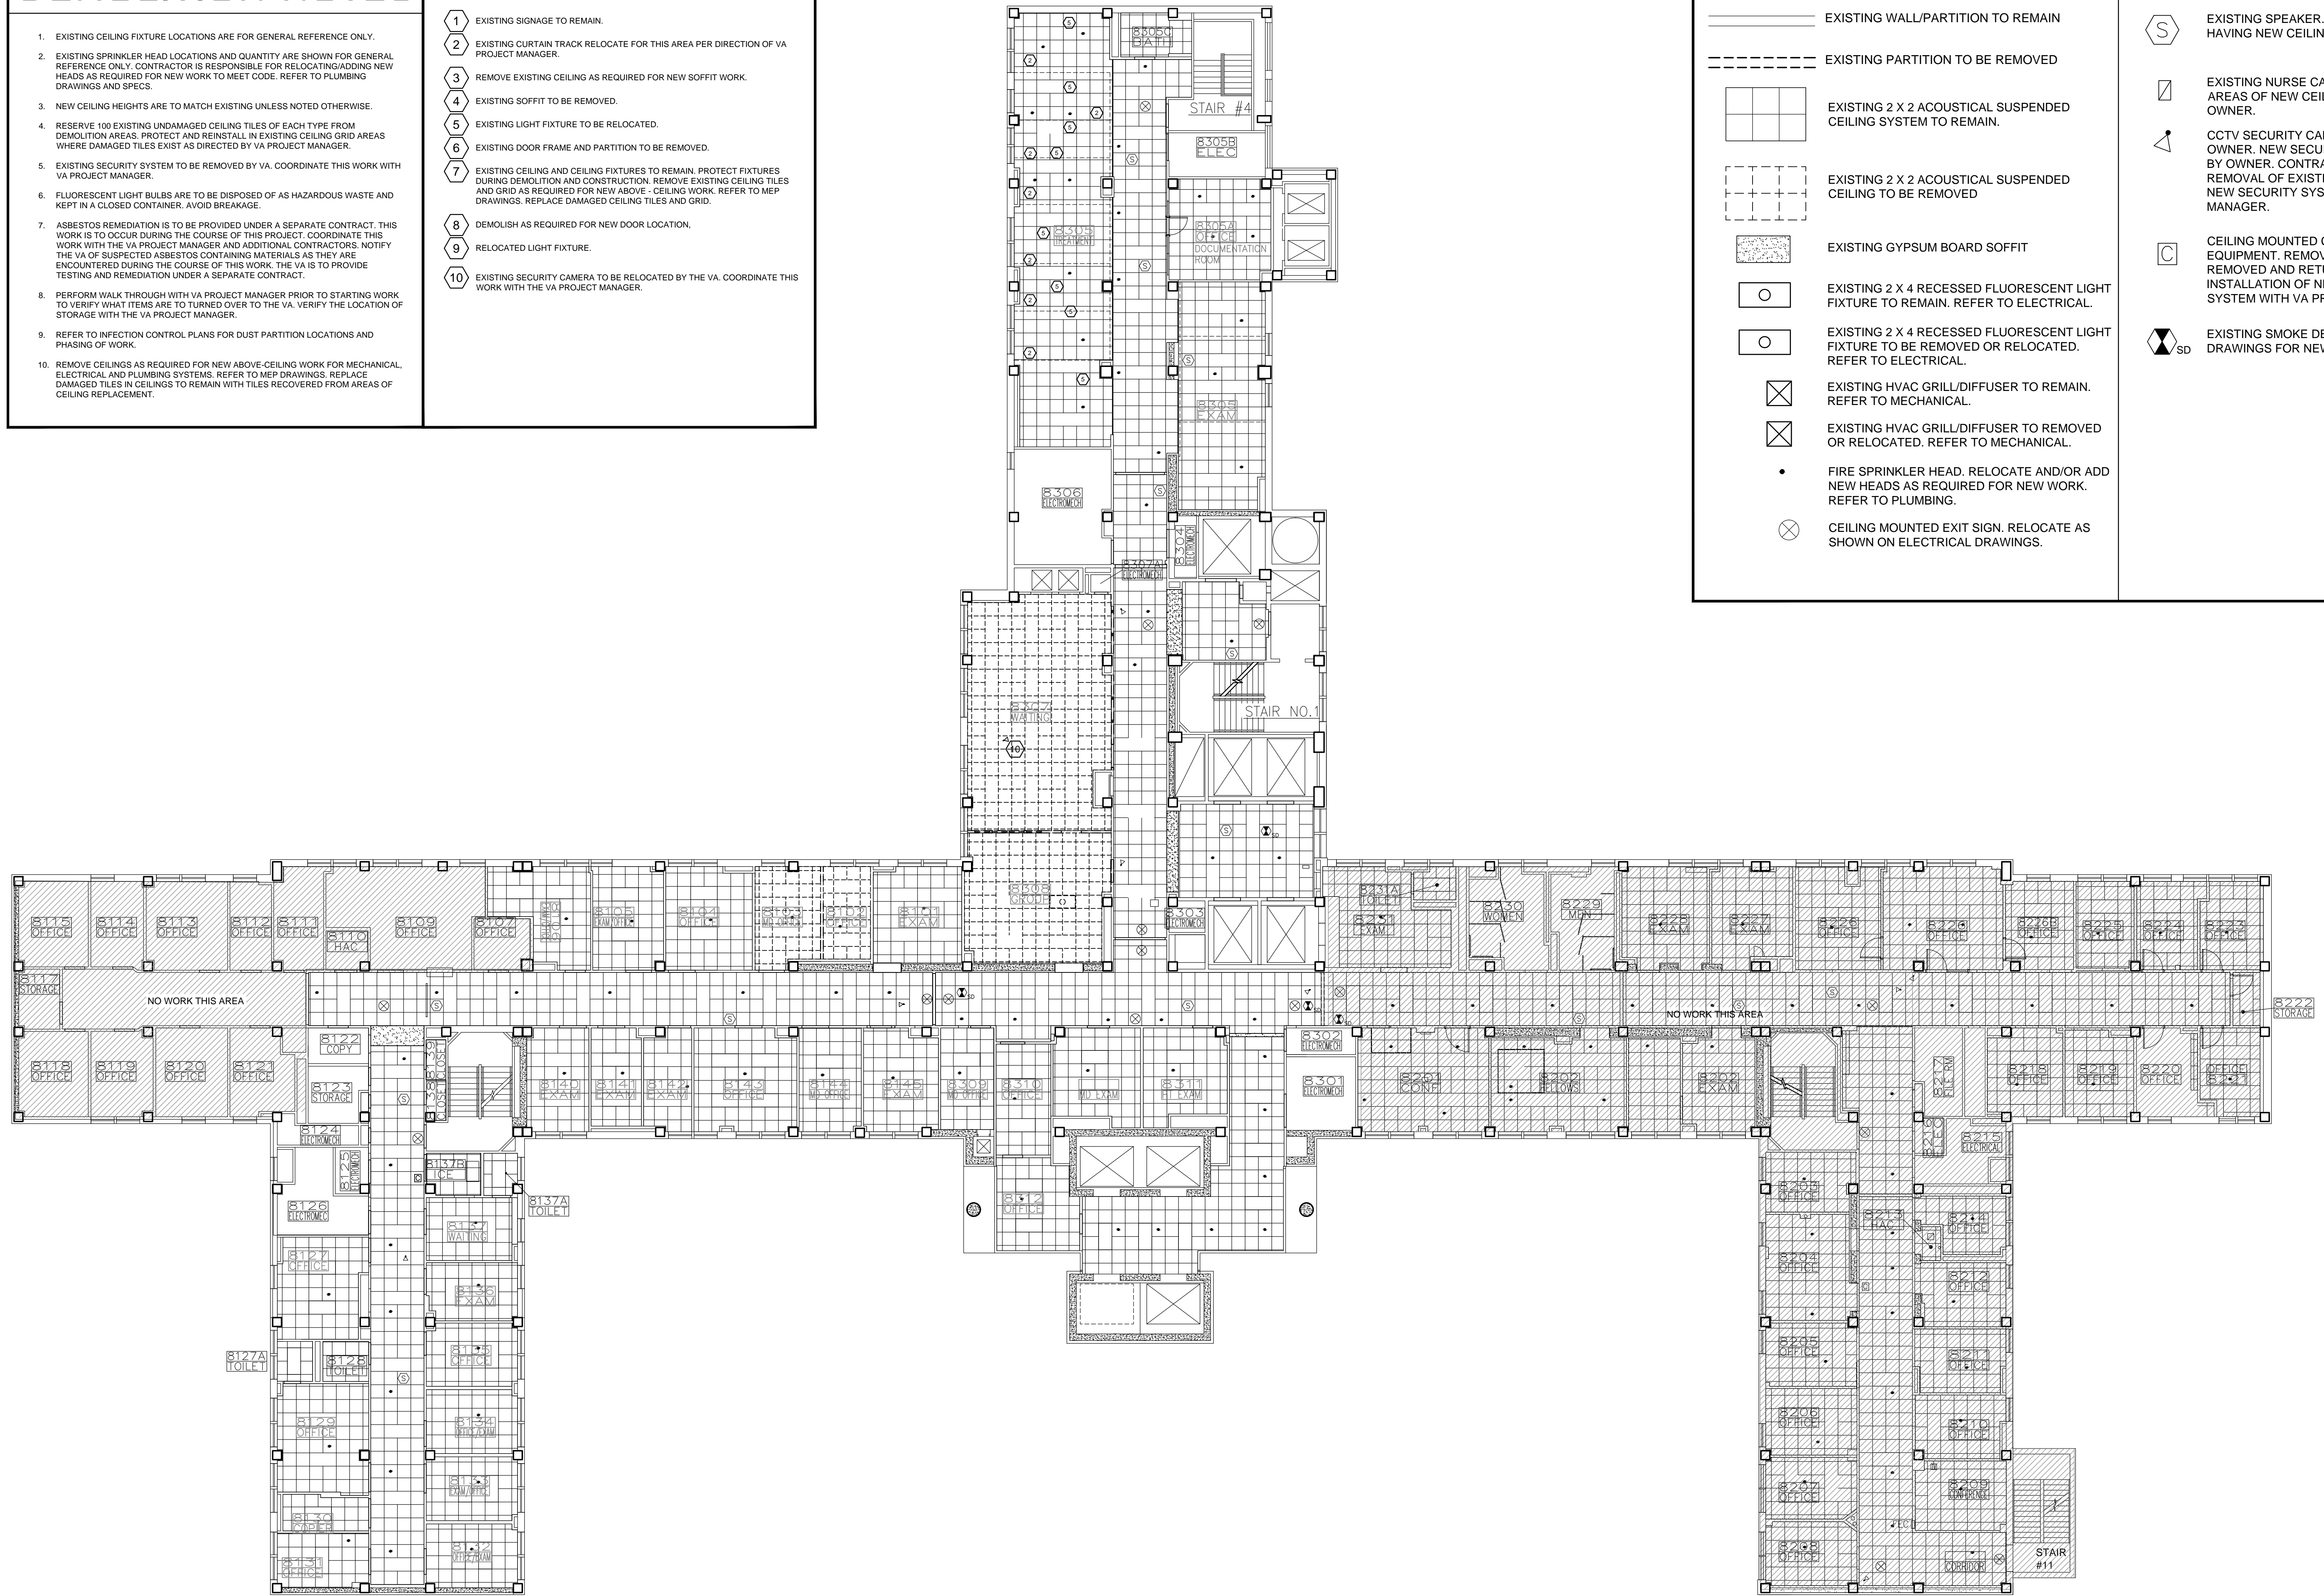


## GENERAL CEILING DEMOLITION NOTES



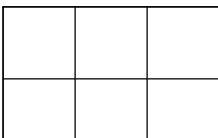

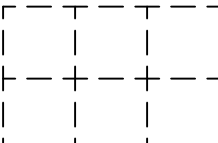

 

 
 



2. EXISTING CEILING FIXTURE LOCATIONS ARE FOR GENERAL REFERENCE ONLY.
3. EXISTING SPRINKLER HEAD LOCATIONS AND QUANTITY ARE SHOWN FOR GENERAL REFERENCE ONLY. CONTRACTOR IS RESPONSIBLE FOR RELOCATING/ADJUSTING NEW HEADS AND SIZES AS REQUIRED FOR NEW WORK TO MEET CODE. REFER TO DRAWINGS, DRAWINGS AND SPECS.
4. NEW CEILING HEIGHTS ARE TO MATCH EXISTING UNLESS NOTED OTHERWISE.
5. RESERVE 10% EXISTING UNMATCHED CEILING TILES OF EACH TYPE FROM DEMOLITION AREAS. PROTECT AND REINSTATE IN EXISTING CEILING GRID AREAS WHERE DEMOLITION TILES EXIST AS DIRECTED BY VA PROJECT MANAGER.
6. EXISTING SECURITY SYSTEM TO BE REMOVED BY VA. COORDINATE THIS WORK WITH VA PROJECT MANAGER.
7. FLUORESCENT LIGHT BULBS ARE TO BE DISPOSED OF AS HAZARDOUS WASTE AND KEPT IN A CLOSED CONTAINER. AVOID BREAKAGE.
8. ASBESTOS REMEDIATION IS TO BE PROVIDED UNDER A SEPARATE CONTRACT. NOTICE IS TO OCCUR DURING THE COURSE OF THIS PROJECT. COORDINATE THIS WORK WITH VA PROJECT MANAGER. CONTRACTOR SHALL NOTIFY VA PROJECT MANAGER OF ANY SUSPECTED ASBESTOS CONTAINING MATERIALS AS THEY ARE ENCOUNTERED DURING CONSTRUCTION. CONTRACTOR IS TO PROVIDE TESTING AND REMEDIATION UNDER A SEPARATE CONTRACT.
9. PERFORM WALK THROUGH WITH VA PROJECT MANAGER PRIOR TO STARTING WORK TO VERIFY WHAT ITEMS ARE TO TURNED OVER TO VA. VERIFY THE LOCATION OF TOBACCO, CIGARETTES, CIGARETTE MANIFEST AND OTHER ITEMS.
10. REFER TO INFECTION CONTROL PLAN FOR DUST PARTICULATE LOCATIONS AND PHASING OF WORK.
11. REMOVE CEILINGS AS REQUIRED FOR NEW ABOVE-CEILING WORK FOR MECHANICAL, ELECTRICAL AND PLUMBING SYSTEMS. REFER TO BIDD DRAWINGS, REPLACE DAMAGED OR MISSING CEILING TO REMAIN WITH TILES RECOVERED FROM AREAS OF CEILING REPLACEMENT.

## KEY NOTES

- 1 EXISTING SIGNAGE TO REMAIN.
- 2 EXISTING CURTAIN TRACK RELOCATE FOR THIS AREA PER DIRECTION OF VA PROJECT MANAGER.
- 3 REMOVE EXISTING CEILING AS REQUIRED FOR NEW SOFFIT WORK.
- 4 EXISTING SOFFIT TO BE REMOVED.
- 5 EXISTING LIGHT FIXTURE TO BE RELOCATED.
- 6 EXISTING DOOR FRAME AND PARTITION TO BE REMOVED.
- 7 EXISTING CEILING AND CEILING FIXTURES TO REMAIN. PROTECT FIXTURES DURING DEMOLITION AND CONSTRUCTION. REMOVE EXISTING CEILING TILES AND GRID AS REQUIRED FOR NEW ABOVE - CEILING WORK. REFER TO MEP DRAWINGS. REPLACE DAMAGED CEILING TILES AND GRID.
- 8 DEMOLISH AS REQUIRED FOR NEW DOOR LOCATION.
- 9 RELOCATED LIGHT FIXTURE.
- 10 EXISTING SECURITY CAMERA TO BE RELOCATED BY THE VA. COORDINATE THE WORK WITH THE VA PROJECT MANAGER.



## SYMBOL LEGEND

- |   |  |   |  |
|---|--|---|--|
| =====   | EXISTING WALL/PARTITION TO REMAIN  |  | EXISTING SPEAKER. REMOVE FROM AREAS HAVING NEW CEILING WORK AND RETURN TO VA.  |
| -----   | EXISTING PARTITION TO BE REMOVED   |  | EXISTING NURSE CALL LIGHT. REMOVE FROM AREAS OF NEW CEILING WORK AND RETURN TO OWNER.  |
|  | EXISTING 2 X 2 ACOUSTICAL SUSPENDED CEILING SYSTEM TO REMAIN.                                      |  | CCTV SECURITY CAMERA TO BE REMOVED BY OWNER. NEW SECURITY SYSTEM TO BE PROVIDED BY OWNER. CONTRACTOR IS TO COORDINATE REMOVAL OF EXISTING AND INSTALLATION OF NEW SECURITY SYSTEM WITH VA PROJECT MANAGER. |
|  | EXISTING 2 X 2 ACOUSTICAL SUSPENDED CEILING TO BE REMOVED  |  | CEILING MOUNTED COMMUNICATIONS EQUIPMENT. REMOVE FROM CEILINGS TO BE REMOVED AND RETURN TO OWNER. COORDINATE INSTALLATION OF NEW COMMUNICATIONS SYSTEM WITH VA PROJECT MANAGER.                            |
|  | EXISTING GYPSUM BOARD SOFFIT   |  | EXISTING SMOKE DETECTOR. SEE ELECTRICAL DRAWINGS FOR NEW WORK.   |
|  | EXISTING 2 X 4 RECESSED FLUORESCENT LIGHT FIXTURE TO REMAIN. REFER TO ELECTRICAL.                  |   |  |
|  | EXISTING 2 X 4 RECESSED FLUORESCENT LIGHT FIXTURE TO BE REMOVED OR RELOCATED. REFER TO ELECTRICAL. |   |  |
|  | EXISTING HVAC GRILL/DIFFUSER TO REMAIN. REFER TO MECHANICAL.                                       |   |  |
|  | EXISTING HVAC GRILL/DIFFUSER TO REMOVED OR RELOCATED. REFER TO MECHANICAL.                         |   |  |
| •   | FIRE SPRINKLER HEAD. RELOCATE AND/OR ADD NEW HEADS AS REQUIRED FOR NEW WORK. REFER TO PLUMBING.    |   |  |
|  | CEILING MOUNTED EXIT SIGN. RELOCATE AS SHOWN ON ELECTRICAL DRAWINGS.                               |   |  |

**1**  **8TH FLOOR  
REFLECTED CEILING PLAN - DEMOLITION**  
SCALE: 3/32" = 1'-0"

[illegible]

**FINAL SUBMITTAL**

Veterans Administration