


GENERAL NOTES

A. LIGHTNING PROTECTION AIR TERMINALS, CONDUCTORS, ETC. ARE SHOWN FOR REFERENCE AND DO NOT REPRESENT A COMPLETE LIGHTNING PROTECTION SYSTEM. REFER TO SPECIFICATION SECTION 264100 FACILITY LIGHTNING PROTECTION.

CODED NOTES

- 1 PROVIDE STAINLESS STEEL UNISTRUT EQUIPMENT RACK.
- 2 PROVIDE SIZE 1 20A 3P 600V COMBINATION MOTOR STARTER DISCONNECT.
- 3 PROVIDE LIGHTNING PROTECTION SYSTEM FOR FIRST FLOOR ADDITION.
- 4 RTU CONTROL PANEL WITH VFD MOTOR CONTROLLERS PROVIDED BY RTU MANUFACTURER. PROVIDE FEEDERS FROM MOTOR CONTROLLERS TO MOTORS.
- 5 PROVIDE LIGHTNING PROTECTION DOWN CONDUCTOR. ROUTE INSIDE EXTERIOR WALL IN 3" PVC CONDUIT.
- 6 PROVIDE CONTROL WIRING FROM DUCT MOUNTED SMOKE DETECTOR TO ROOFTOP FAN STARTER FOR SHUT DOWN.
- 7 PROVIDE 20 AMPERE, 120V, POWER CONNECTION, FROM PANEL FINC, TO HVAC EQUIPMENT ENCLOSURE FOR LIGHTS AND GENERAL RECEPTACLES.
- 8 LIGHTNING PROTECTION AIR TERMINAL.
- 9 MOUNT NEW LIGHT FIXTURE ON EXISTING BUILDING FACADE. PROVIDE CUSTOM CUTTING AND SEALING OF FACADE, AS REQUIRED.

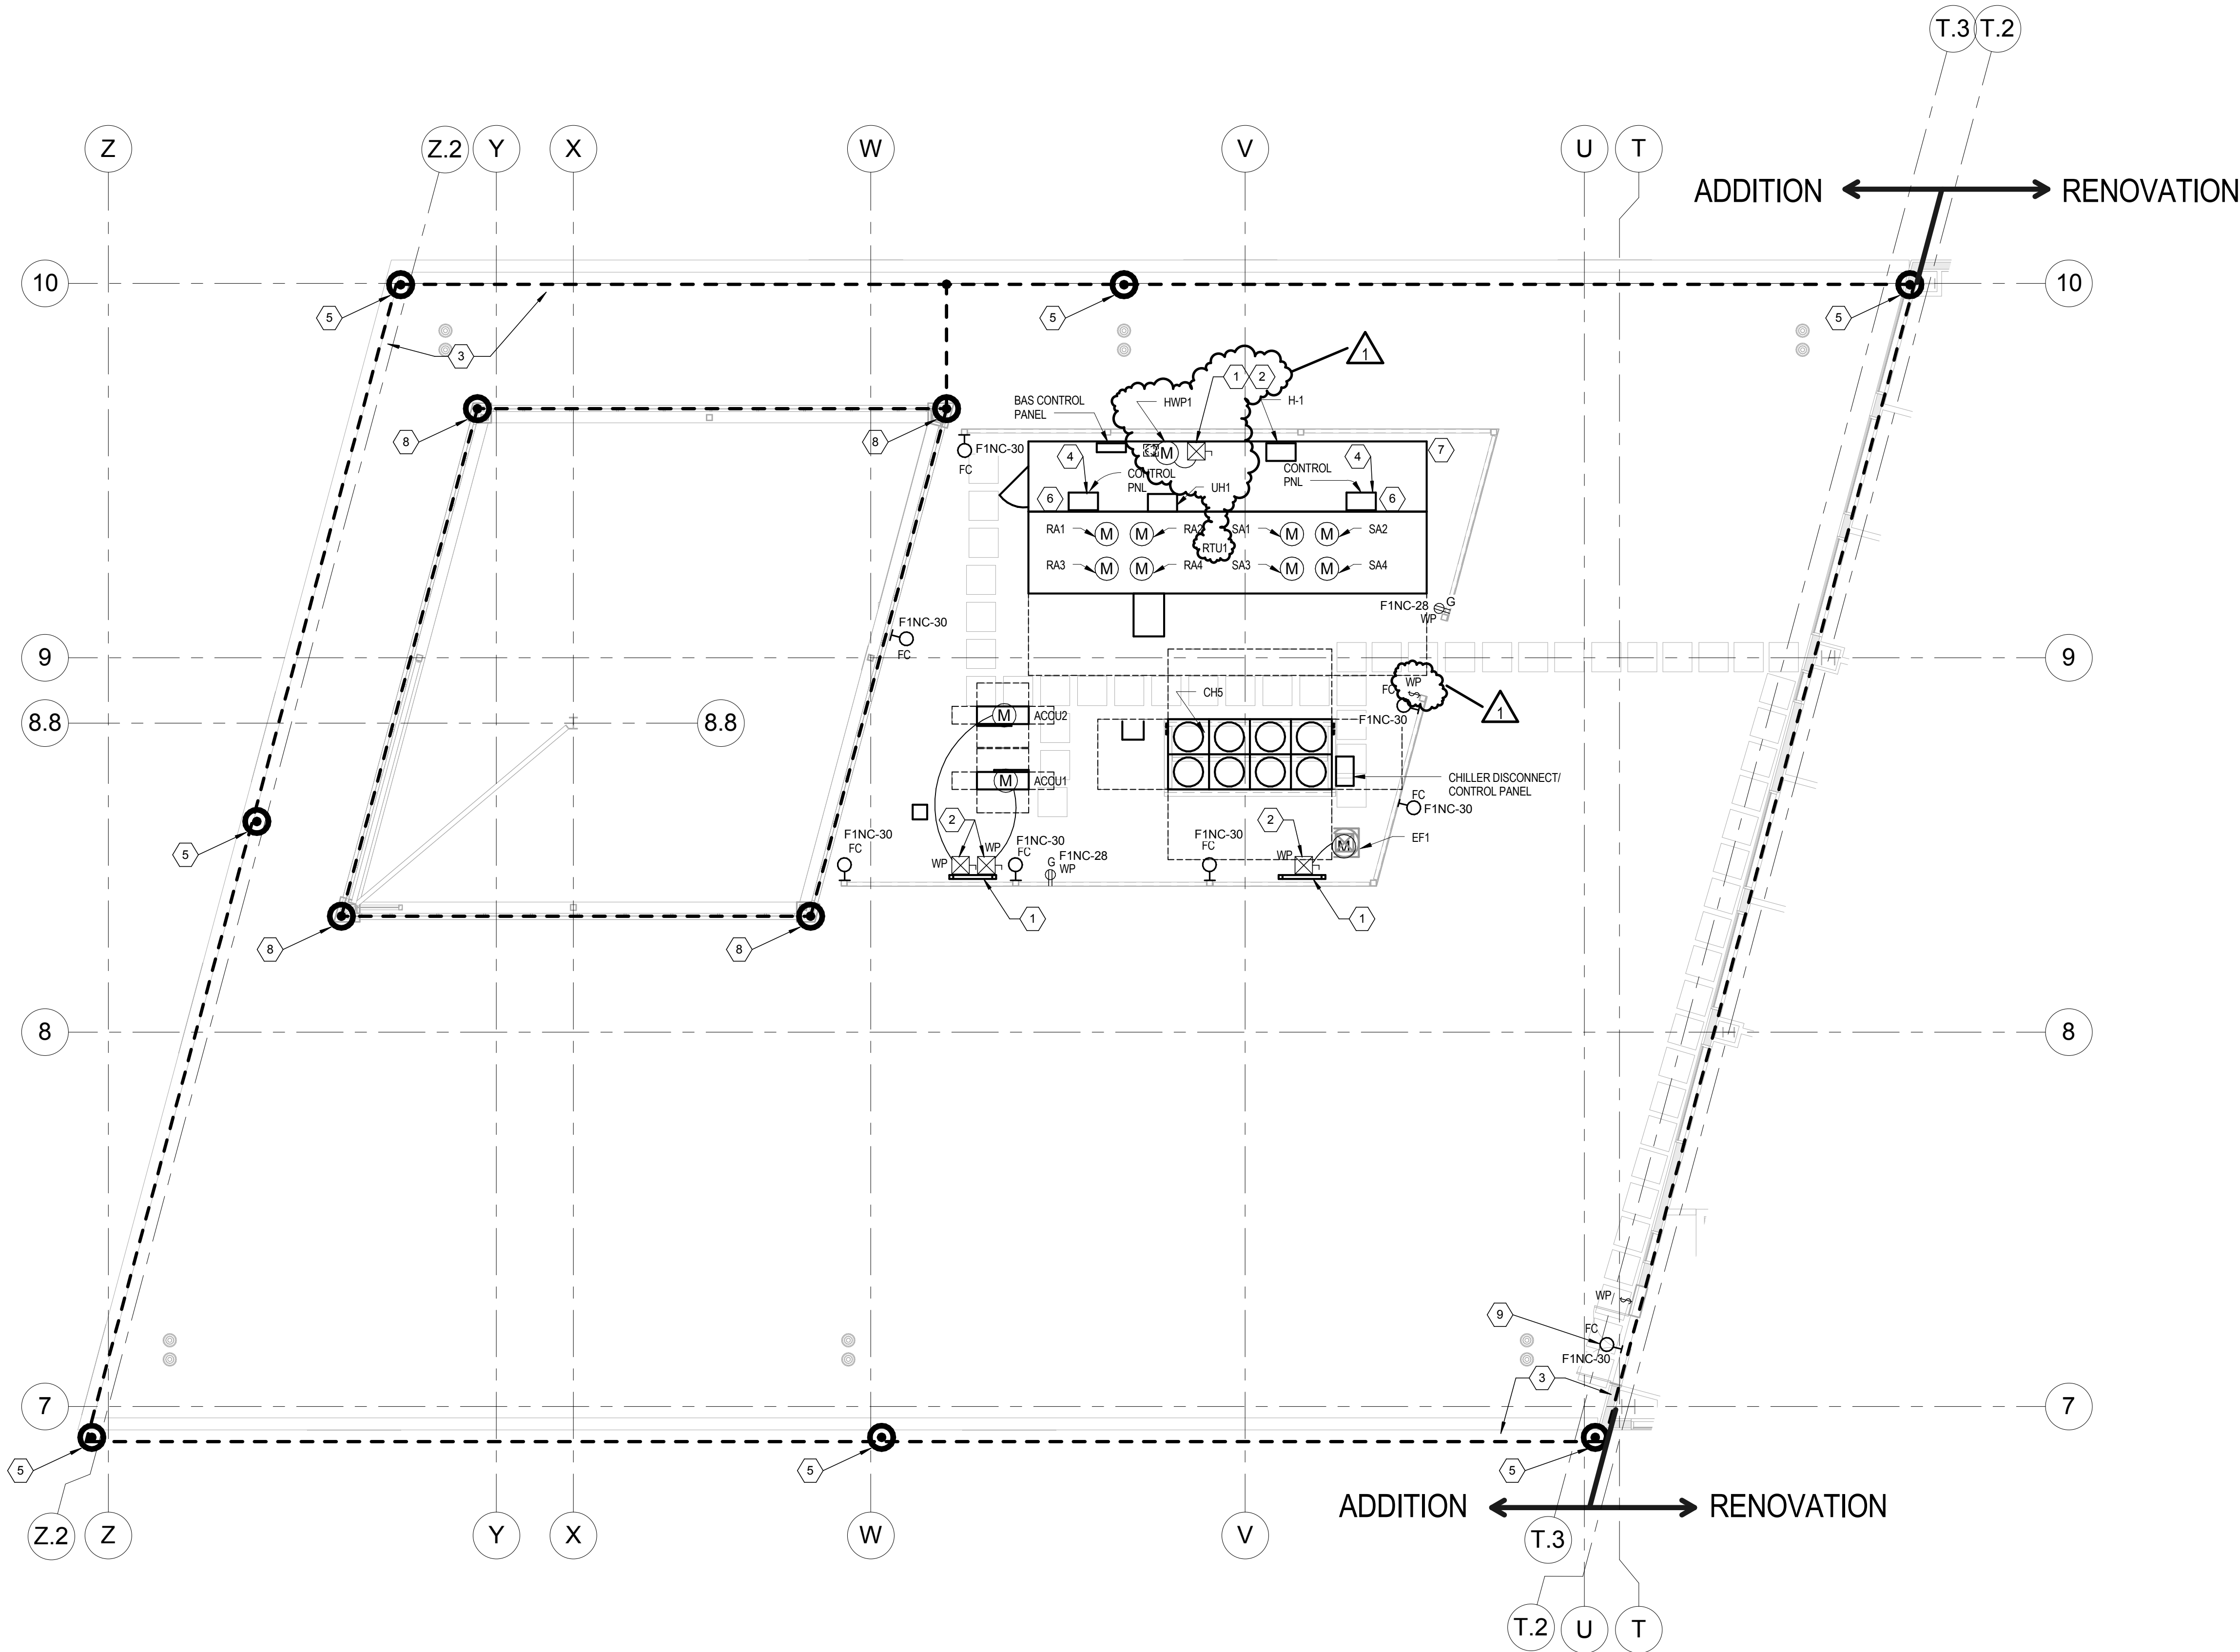

1 ROOF EXPANSION POWER PLAN  
Scale: 1/8" = 1'-0"

ADDENDUM 1	2017.06.05
Revisions:	Date

**VA** U.S. Department of Veterans Affairs  
CHALMERS P. WYLIE VA AMBULATORY CARE CENTER  
420 N JAMES ROAD, COLUMBUS, OH 43219



ARCHITECT/ENGINEERS:  
PROJECT LEAD  
Architect, Structural Engineer, Civil Engineer  
**GUIDON DESIGN**  
905 N. CAPITOL AVE., SUITE 100 | INDIANAPOLIS, IN 46204  
317.800.6388 | WWW.GUIDONDESIGN.COM  
SUSTAINABLE ARCHITECTURE + ENGINEERING

MEP Engineer  
**AECOM**  
277 W. NATIONWIDE BLVD  
COLUMBUS, OH 43215

BID SET			
Drawing Title ROOF EXPANSION POWER PLAN	Project Title CONSTRUCT MENTAL HEALTH AND SPECIALTY CARE ADDITION	VA Project Number 757-202	 Chalmers P. Wylie Ambulatory Care Center
Approved for Design Concept: FARID MEHR CHIEF ENGINEER	Location CHALMERS P. WYLIE VAAMC	Building Number 1A	
Date 23 DEC 2016	Checked By: RA	Drawn By: BW	
		Drawing Number <b>EE213</b>	