


HVAC PIPING PLAN NOTES (THIS PLAN ONLY)  
① SEE DUCTWORK PLANS FOR CONTROL OPTIONS.  
UNDER BASE BID, PROVIDE NECESSARY PIPING  
CHANGES REQUIRED TO UPGRADE CONTROLS.  
COORDINATE WITH JOHNSON CONTROLS BEFORE  
BIDDING TO ENSURE ALL HVAC WORK IS COVERED.

# 7TH FLOOR BLOCK "B" HVAC PIPING NEW WORK PLAN

1/8" = 1'-0"

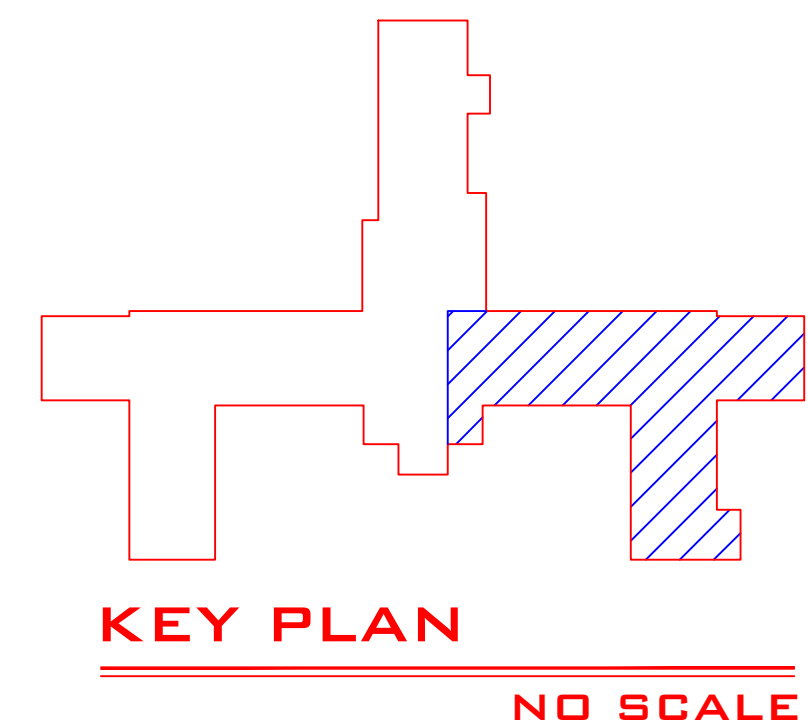

Revisions	Date

F:\10\10007 - VAMC-B'ham - Renovate Space for Rehab & Physical Medicine\CAD\wre\F\08-12-11 Signed Seal.tif



**BIRCHFIELD  
PENUEL &  
ASSOCIATES,  
ARCHITECTS**

2805 CRESCENT AVENUE • SUITE 200 • BIRMINGHAM, ALABAMA 35209

**Department of Veterans Affairs  
MEDICAL CENTER  
BIRMINGHAM, ALABAMA**

Drawing Title
7TH FLOOR BLOCK "B" HVAC DUCTWORK NEW WORK PLANS

Project Title	Renovate Space for Rehab And Physical Medicine
Building Numbers	Checked DER
	Drawn JRB
Location	VA MEDICAL CENTER BIRMINGHAM, ALABAMA

Date: 08-12-11
VA Project No. 521-10-101
CAD File No. 4608A01
DRAWING NO. M1.3-B
Dwg. C1

**Veterans  
Administration**



**Whitaker & Rawson, Inc.**  
3332 Old Montgomery Hwy  
Suite 103 Mark Harris Bldg  
Birmingham, AL 35209  
Phone: 205-870-0801  
Fax: 205-870-0891  
www.whitakerandrawson.com  
Mechanical: Doug Rawson  
Direct Line: (205) 870-0801  
Plumbing: Carol Johnson  
Direct Line: (205) 909-5123

**FINAL SUBMITTAL**