


HVAC PIPING PLAN NOTES (THIS PLAN ONLY)
① SEE DUCTWORK PLANS FOR CONTROL OPTIONS. UNDER BASE BID, PROVIDE NECESSARY PIPING CHANGES REQUIRED TO UPGRADE CONTROLS. COORDINATE WITH JOHNSON CONTROLS BEFORE BIDDING TO ENSURE ALL HVAC WORK IS COVERED.

1 7TH FLOOR BLOCK "A" HVAC PIPING NEW WORK PLAN
1/8" = 1'-0"




Revisions	Date

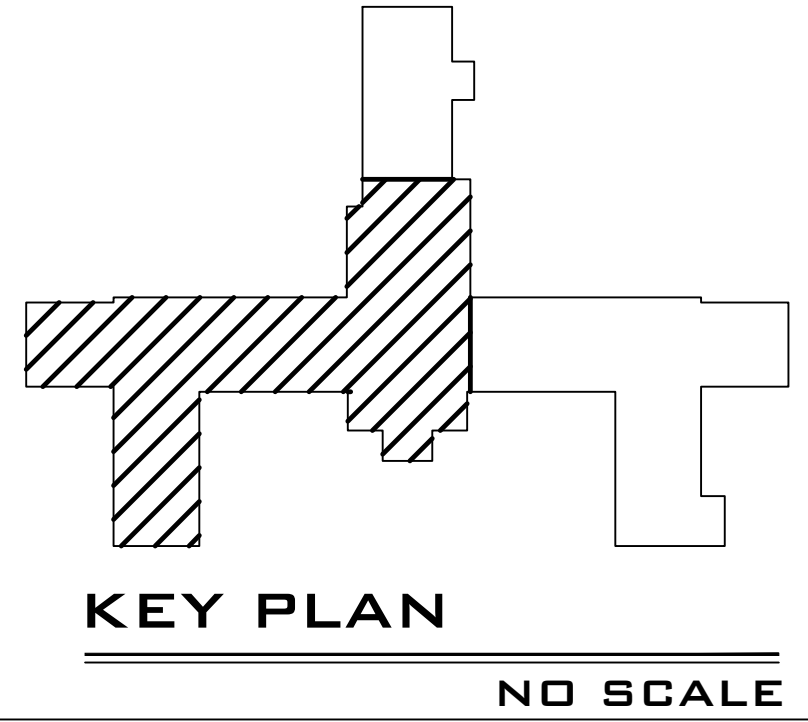



**BIRCHFIELD
PENUEL &
ASSOCIATES,
ARCHITECTS**

 2805 CRESCENT AVENUE • SUITE 200 • BIRMINGHAM, ALABAMA 35209



**Department of Veterans Affairs
MEDICAL CENTER
BIRMINGHAM, ALABAMA**

Drawing Title
7TH FLOOR BLOCK "A" HVAC PIPING NEW WORK PLANS

Project Title
RENOVATE SPACE FOR REHAB AND PHYSICAL MEDICINE
Building Numbers
Checked DER
Drawn JRB
Location
VA MEDICAL CENTER BIRMINGHAM, ALABAMA

Date: 08-12-11
VA Project No. 521-10-101
CAD File No. 4608A01
Drawing NO. M1.3-A
Dwg. Of

**Veterans
Administration**

Whitaker & Rawson, Inc.
3332 Old Montgomery Hwy
Suite 103 Mark Harris Bldg
Birmingham, AL 35209
Phone: 205-870-0801
Fax: 205-870-0891
www.whitakerandrawson.com
Mechanical Doug Rawson
Direct Line - (205) 870-0801
Planning: Carol Johnson
Direct Line - (205) 949-5123

FINAL SUBMITTAL