



1 8TH FLOOR PART "A" ENLARGED DEMO FIRE PROTECTION PLAN

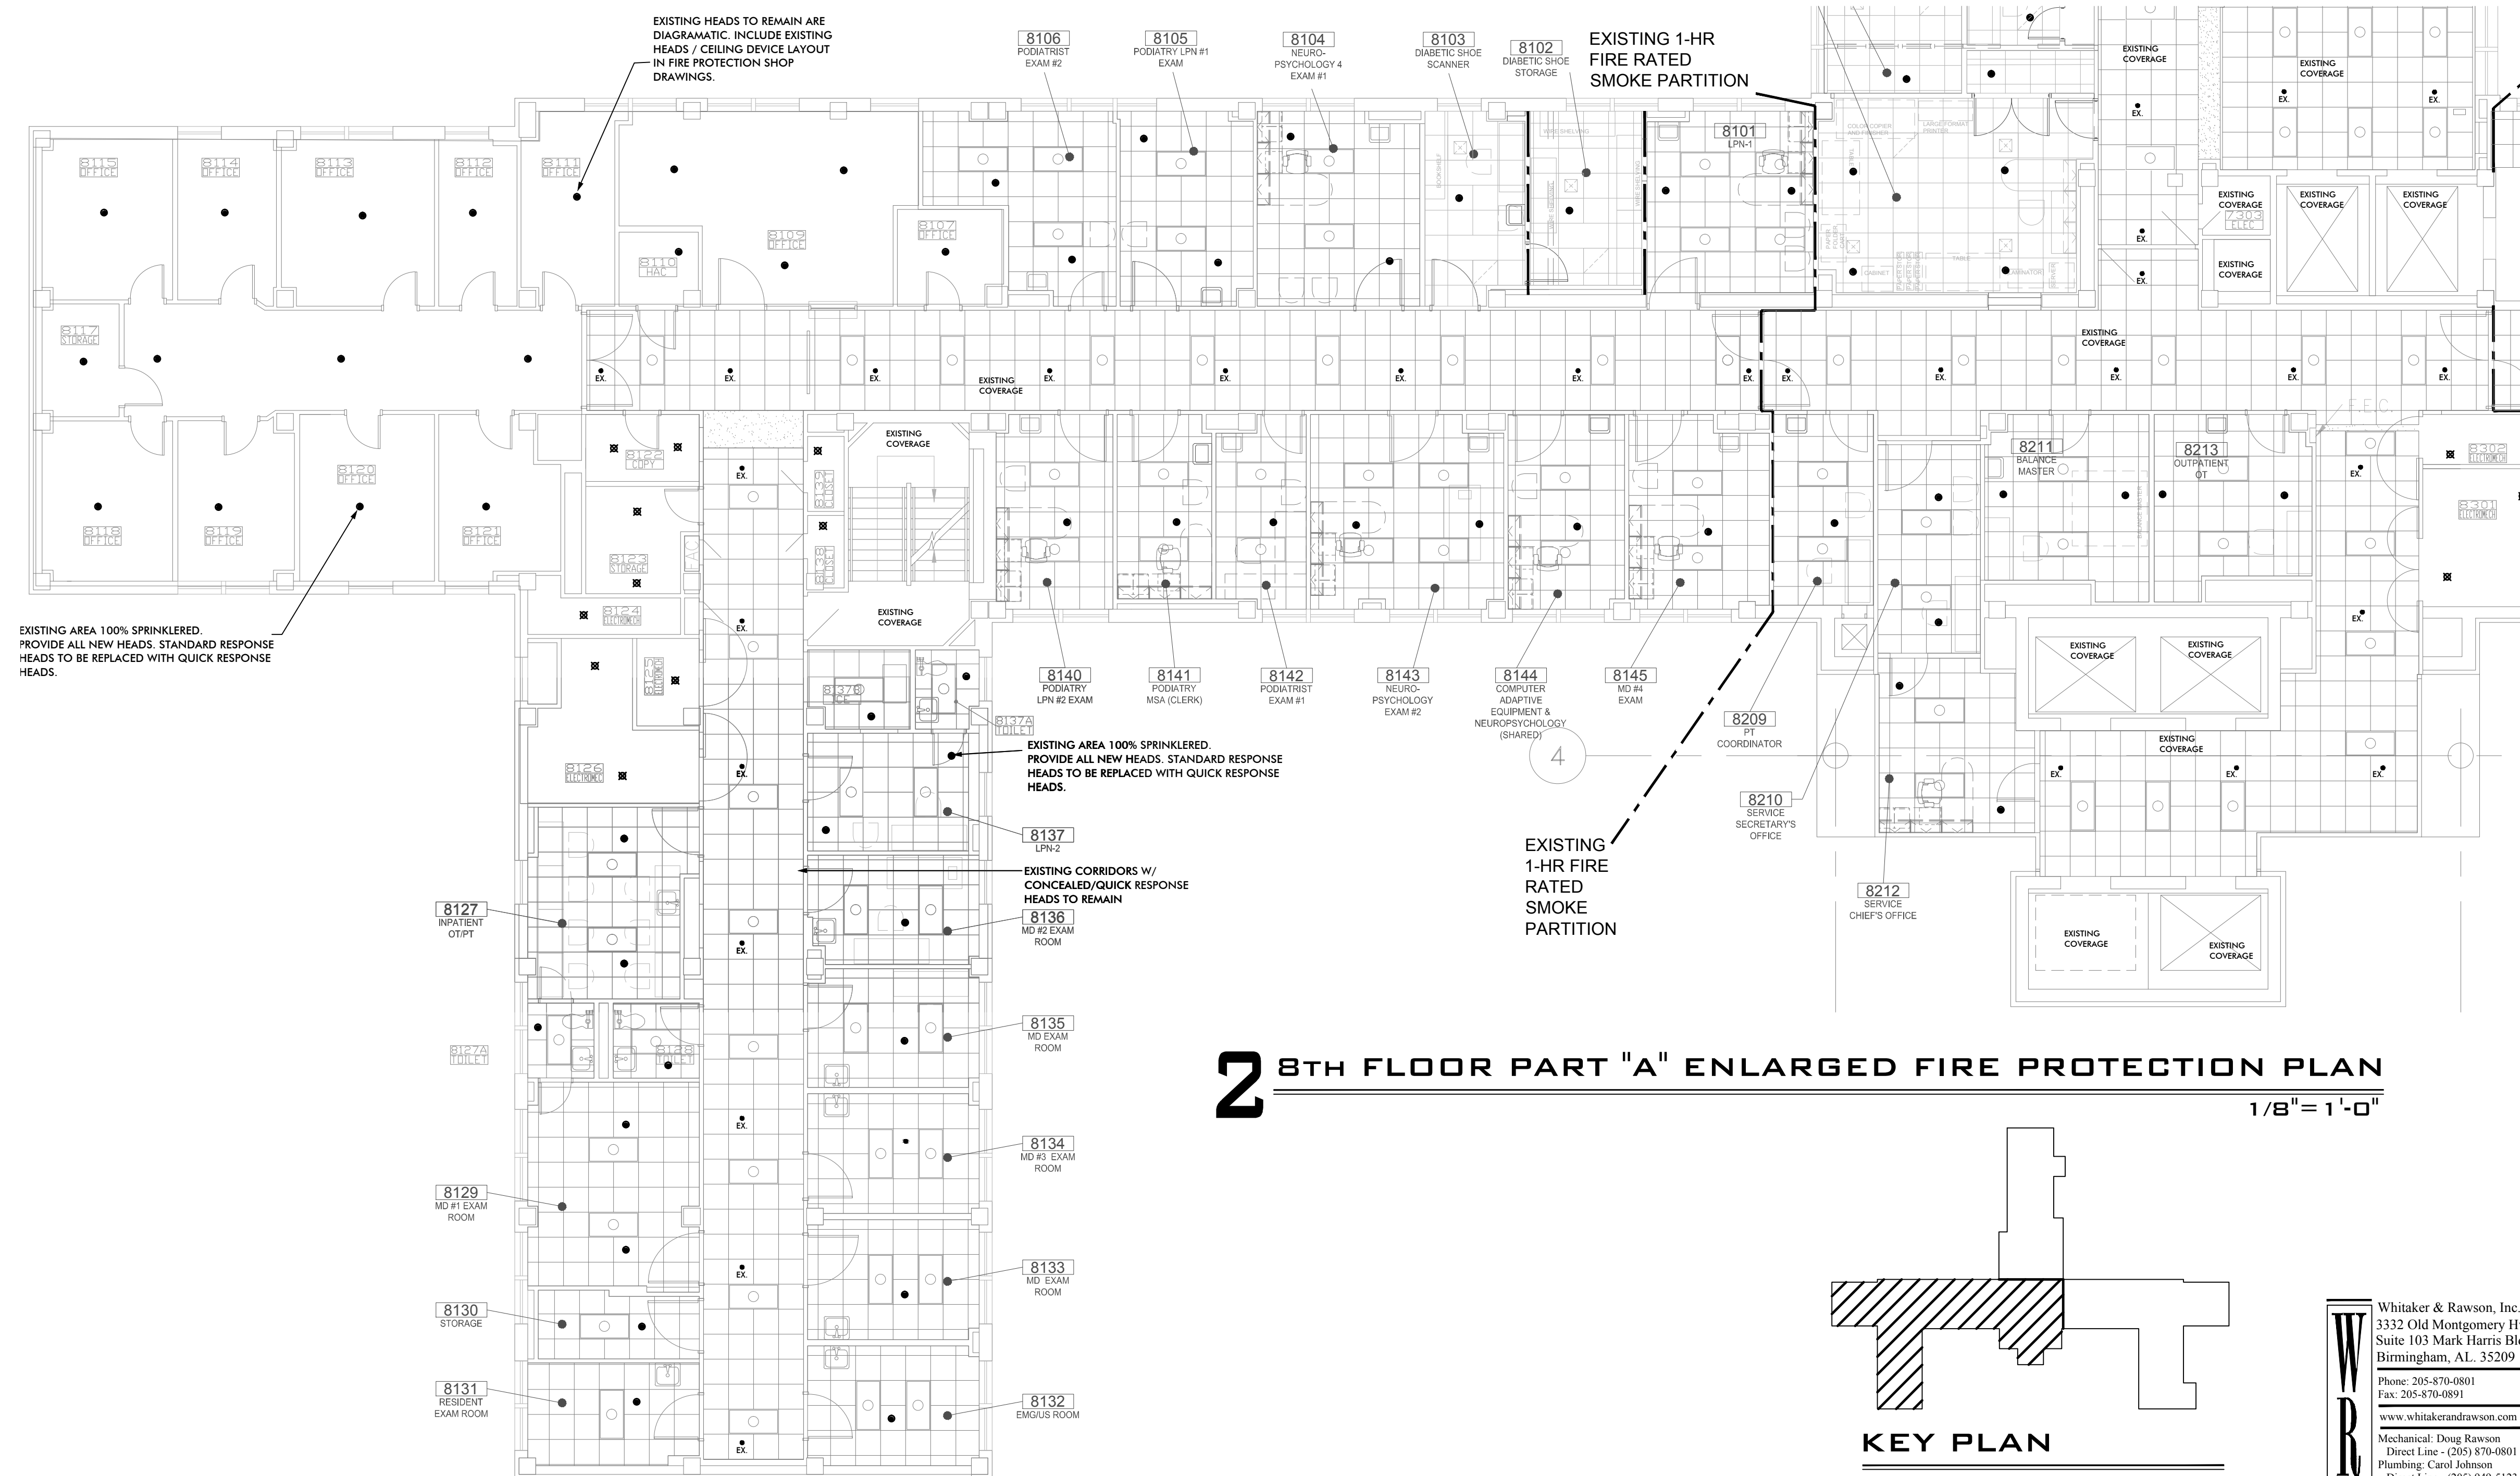

2 8TH FLOOR PART "A" ENLARGED FIRE PROTECTION PLAN
1/8" = 1'-0"

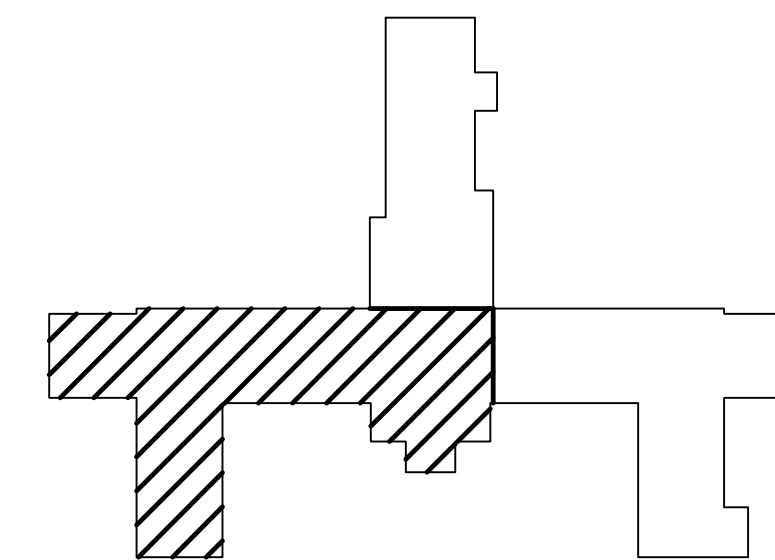

KEY PLAN

NO SCALE


**W
R**

Whitaker & Rawson, Inc.
3332 Old Montgomery Hwy
Suite 103 Mark Harris Bldg
Birmingham, AL. 35209

Phone: 205-870-0801
Fax: 205-870-0891

www.whitakerandrawson.com

Mechanical: Doug Rawson
Direct Line - (205) 870-0801
Plumbing: Carol Johnson
Direct Line - (205) 949-5123

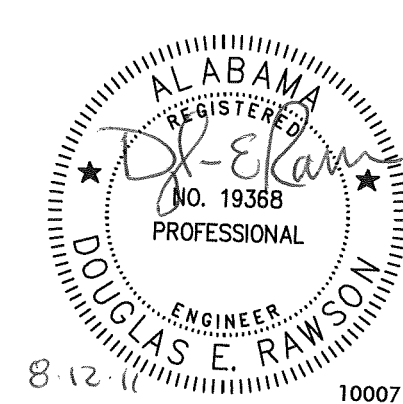[illegible]

BIRCHFIELD
PENUEL &
ASSOCIATES,
ARCHITECTS

2805 CRESCENT AVENUE • SUITE 200 • BIRMINGHAM, ALABAMA 35209

Department of Veterans Affairs
MEDICAL CENTER
BIRMINGHAM, ALABAMA

	Drawing Title
--	---------------

8TH FLOOR PART "A" ENLARGED
FIRE PROTECTION NEW & DEMO PLANS

	Project Title
--	---------------

RENOVATE SPACE FOR REHAB AND PHYSICAL MEDICINE

Building Numbers

Location	VA MEDICAL CENTER BIRMINGHAM, ALABAMA
----------	---------------------------------------

Date: 08-12-11

MA Project No. 524-18-104

VA Project No. 521-10-101

CAD File No.	4608A01

DRAWING NO.

FP2.1

A. B. C. D. E. F. G. H. I. J. K. L. M. N. O. P. Q. R. S. T. U. V. W. X. Y. Z.

Veterans Administration