



# 1 8TH FLOOR PART "C" ENLARGED DEMO FIRE PROTECTION PLAN

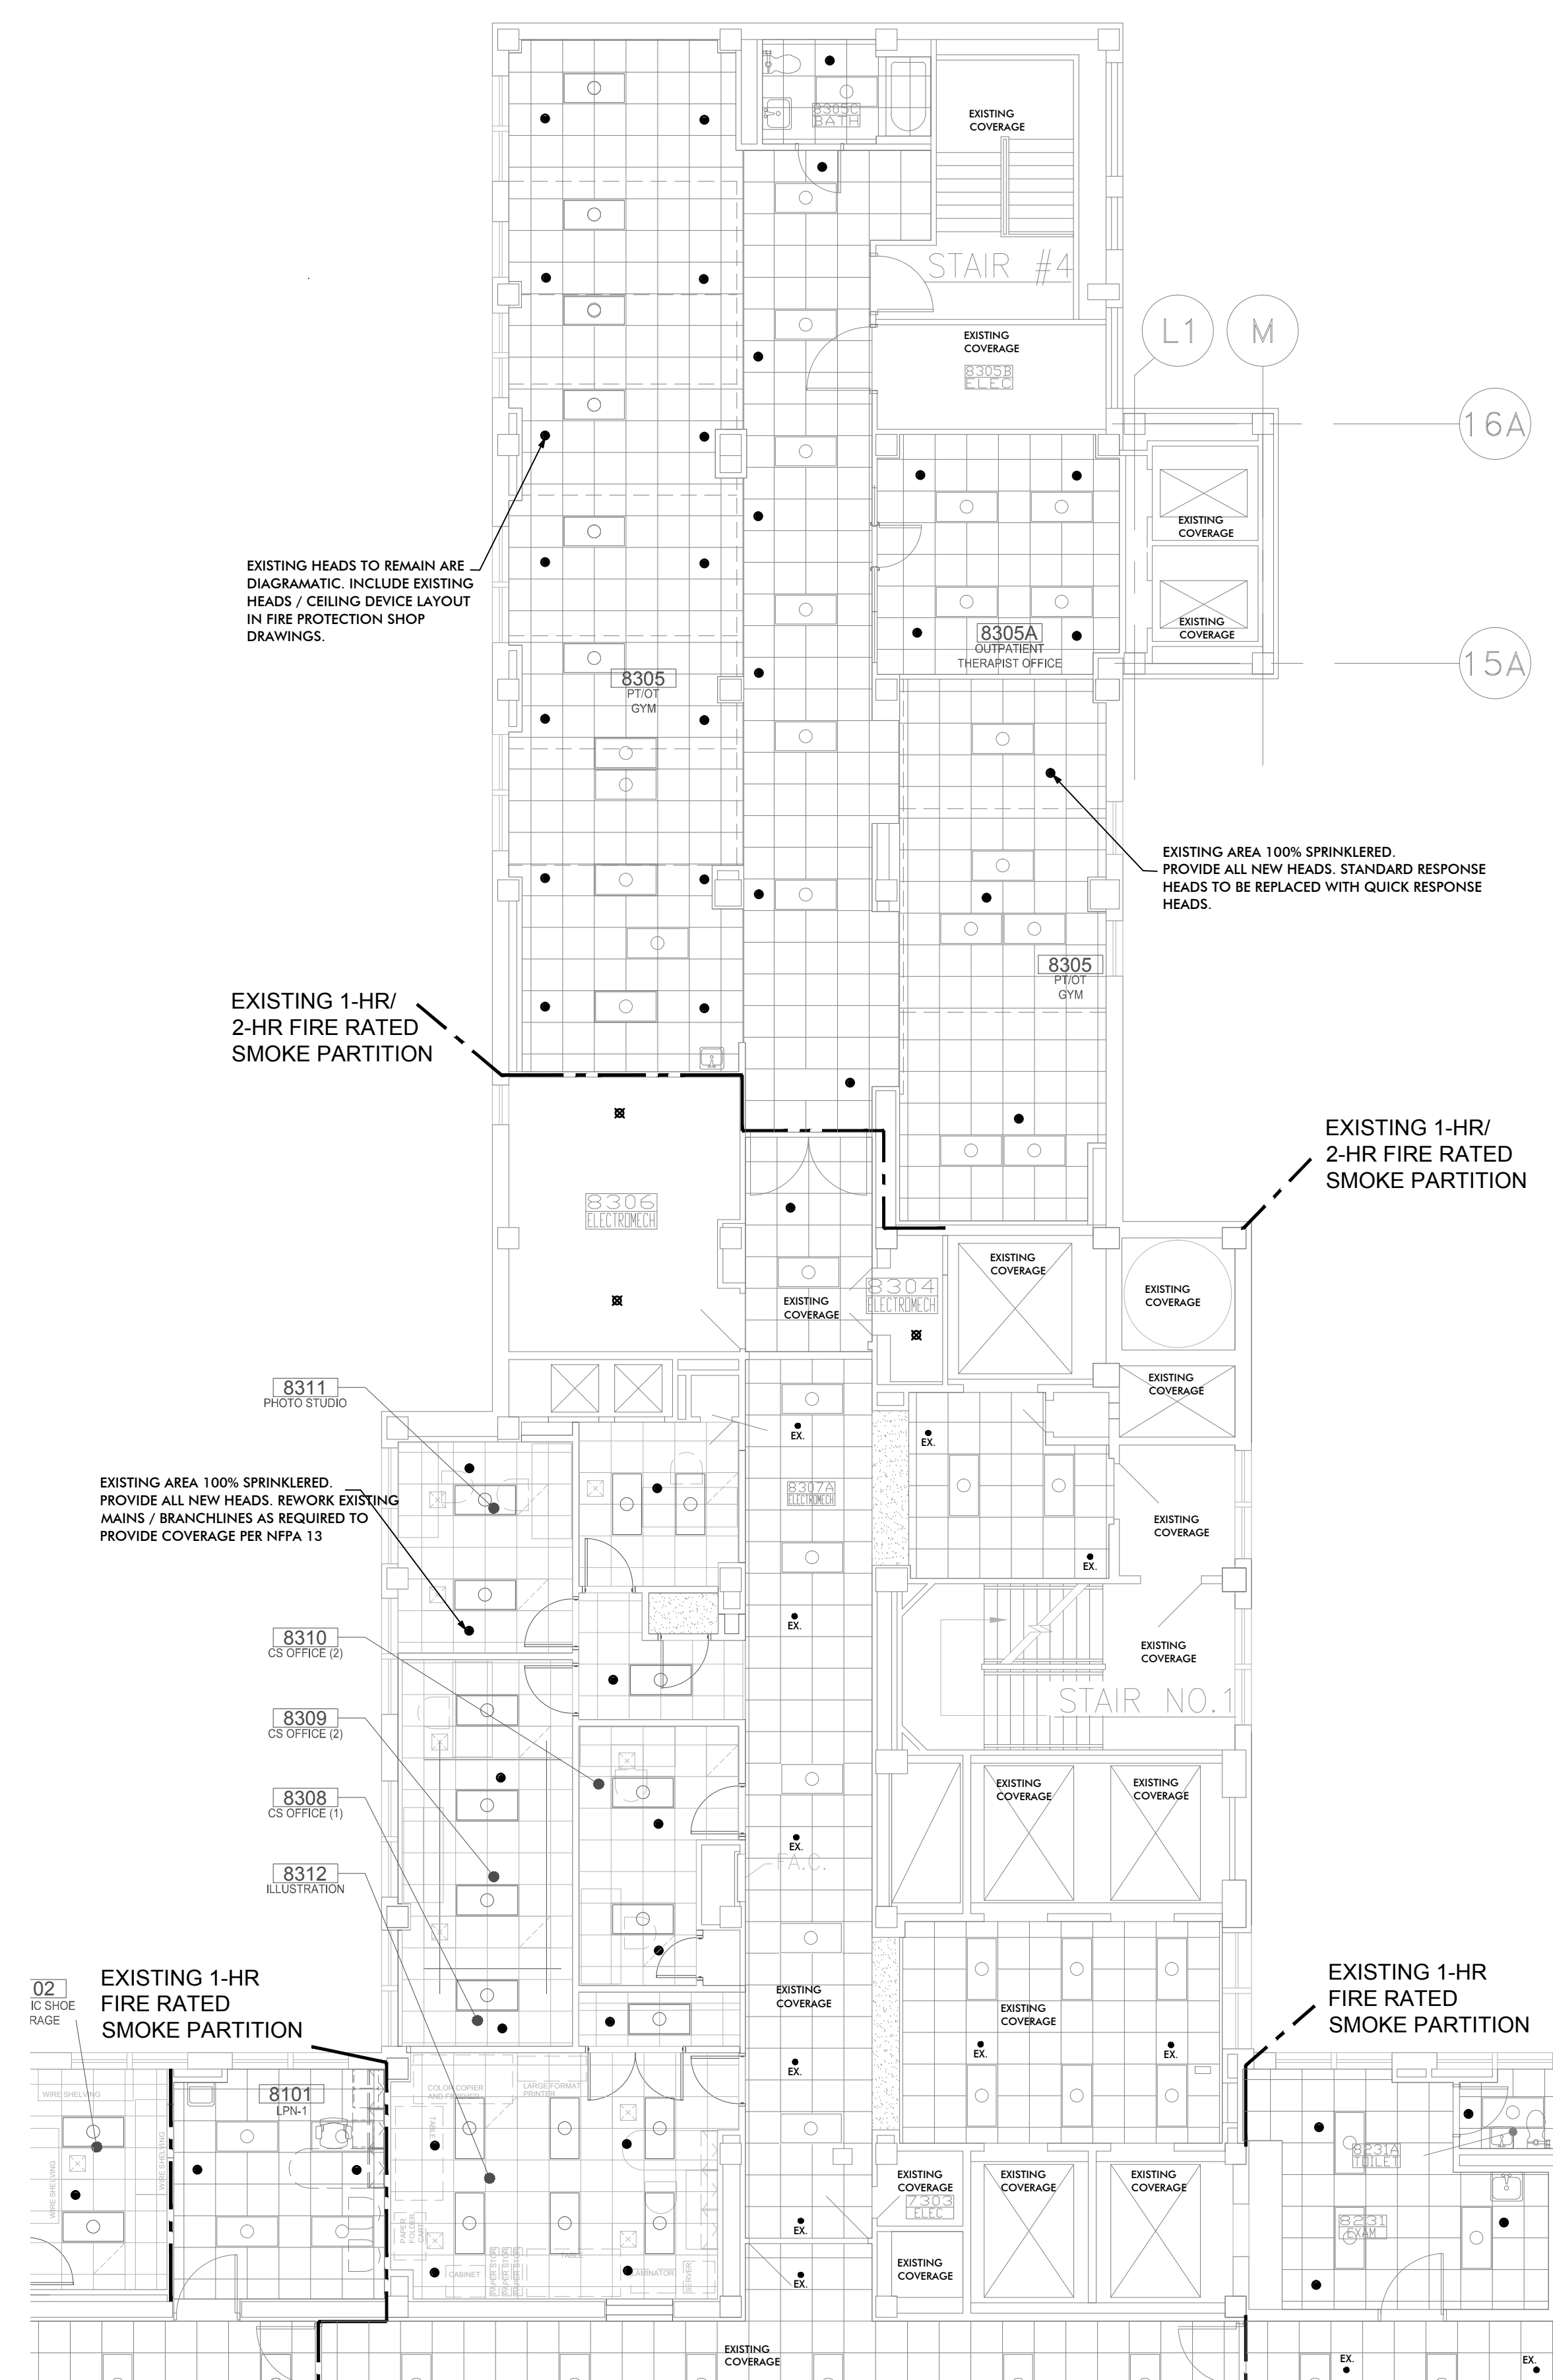

## 2 8TH FLOOR PART "C" ENLARGED FIRE PROTECTION PLAN

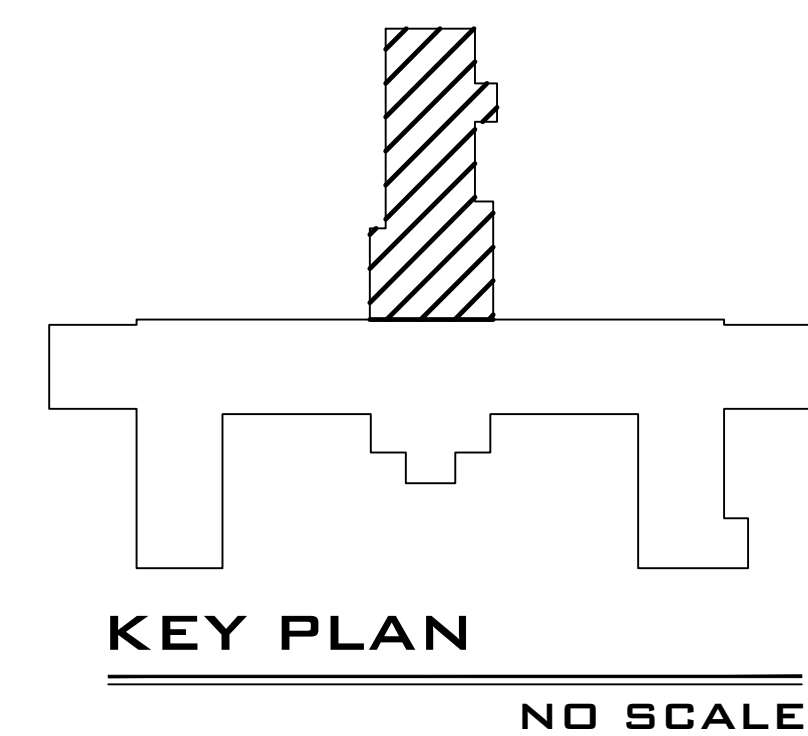


**W**  
**R**

Whitaker & Rawson, Inc.  
3332 Old Montgomery H  
Suite 103 Mark Harris Bldg  
Birmingham, AL 35209

Phone: 205-870-0801  
Fax: 205-870-0891

[www.whitakerandrawson.com](http://www.whitakerandrawson.com)

Mechanical: Doug Rawson  
Direct Line - (205) 870-0801  
Plumbing: Carol Johnson  
Direct Line - (205) 949-5123

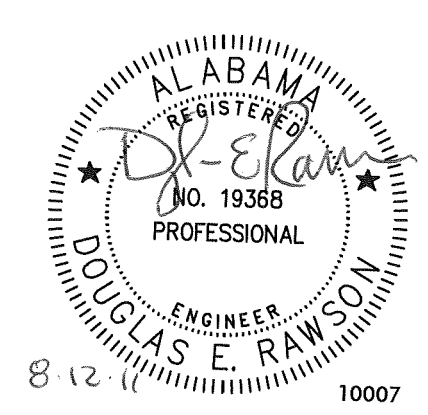[illegible]

**BIRCHFIELD  
PENUEL &  
ASSOCIATES,  
ARCHITECTS**

2805 CRESCENT AVENUE • SUITE 200 • BIRMINGHAM, ALABAMA 35209

Department of Veterans Affairs  
**MEDICAL CENTER**  
BIRMINGHAM, ALABAMA

|   |   |                    |                           |                            |
|---|---|--------------------|---------------------------|----------------------------|
| Drawing Title   | Project Title                                     |                    | Date: 08-12-11            | Veterans<br>Administration |
| 8TH FLOOR PART "C" ENLARGED<br>FIRE PROTECTION NEW & DEMO PLANS | RENOVATE SPACE FOR REHAB<br>AND PHYSICAL MEDICINE |                    | VA Project No. 521-10-101 |                            |
|   |   |                    | CAD File No. 4608A01      |                            |
|   | Building Numbers                                  | Checked<br>DER/CLJ | Drawn<br>RMB              |                            |
|   | Location  |                    | DRAWING NO.<br><br>FP2.3  |                            |
|   | VA MEDICAL CENTER BIRMINGHAM, ALABAMA             |                    | Dwg. Of                   |                            |