



3 8TH FLOOR - PART "A" ENLARGED PLUMBING DEMOLITION PLAN

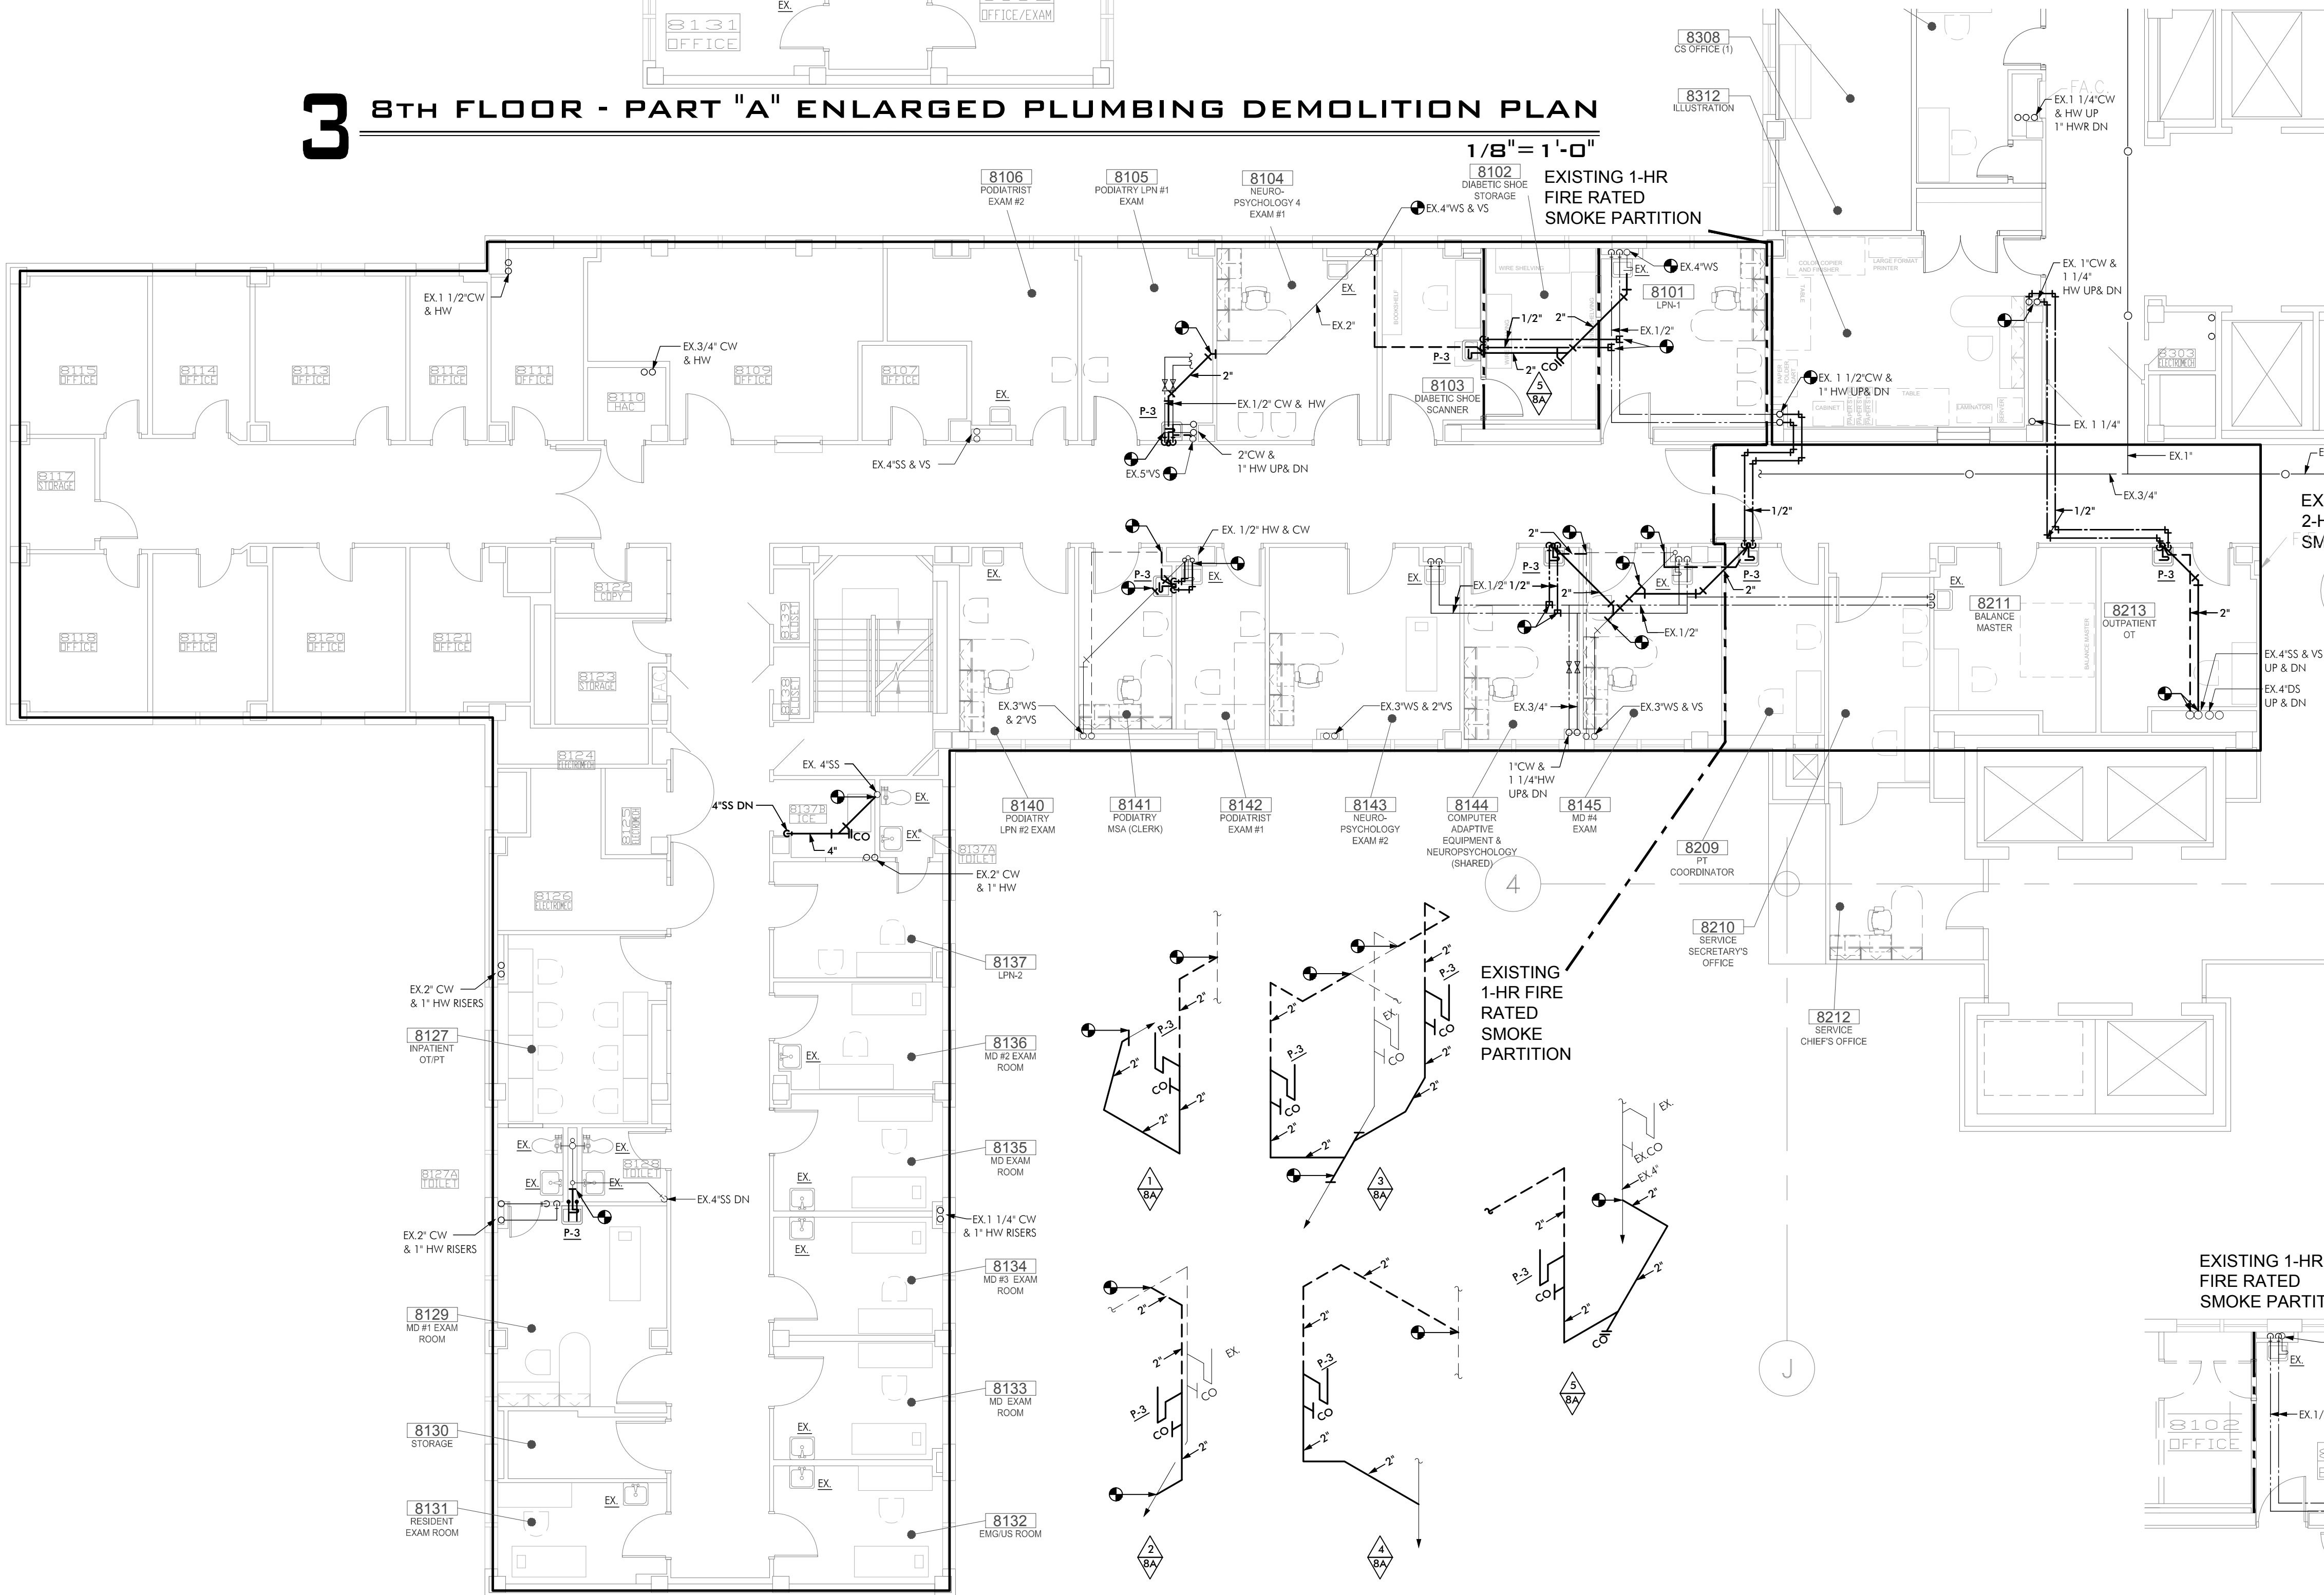

1 8TH FLOOR - PART "A" ENLARGED PLUMBING PIPING PLAN

2 8TH FLOOR - PART "C" ENLARGED PLUMBING DEMOLITION PLAN

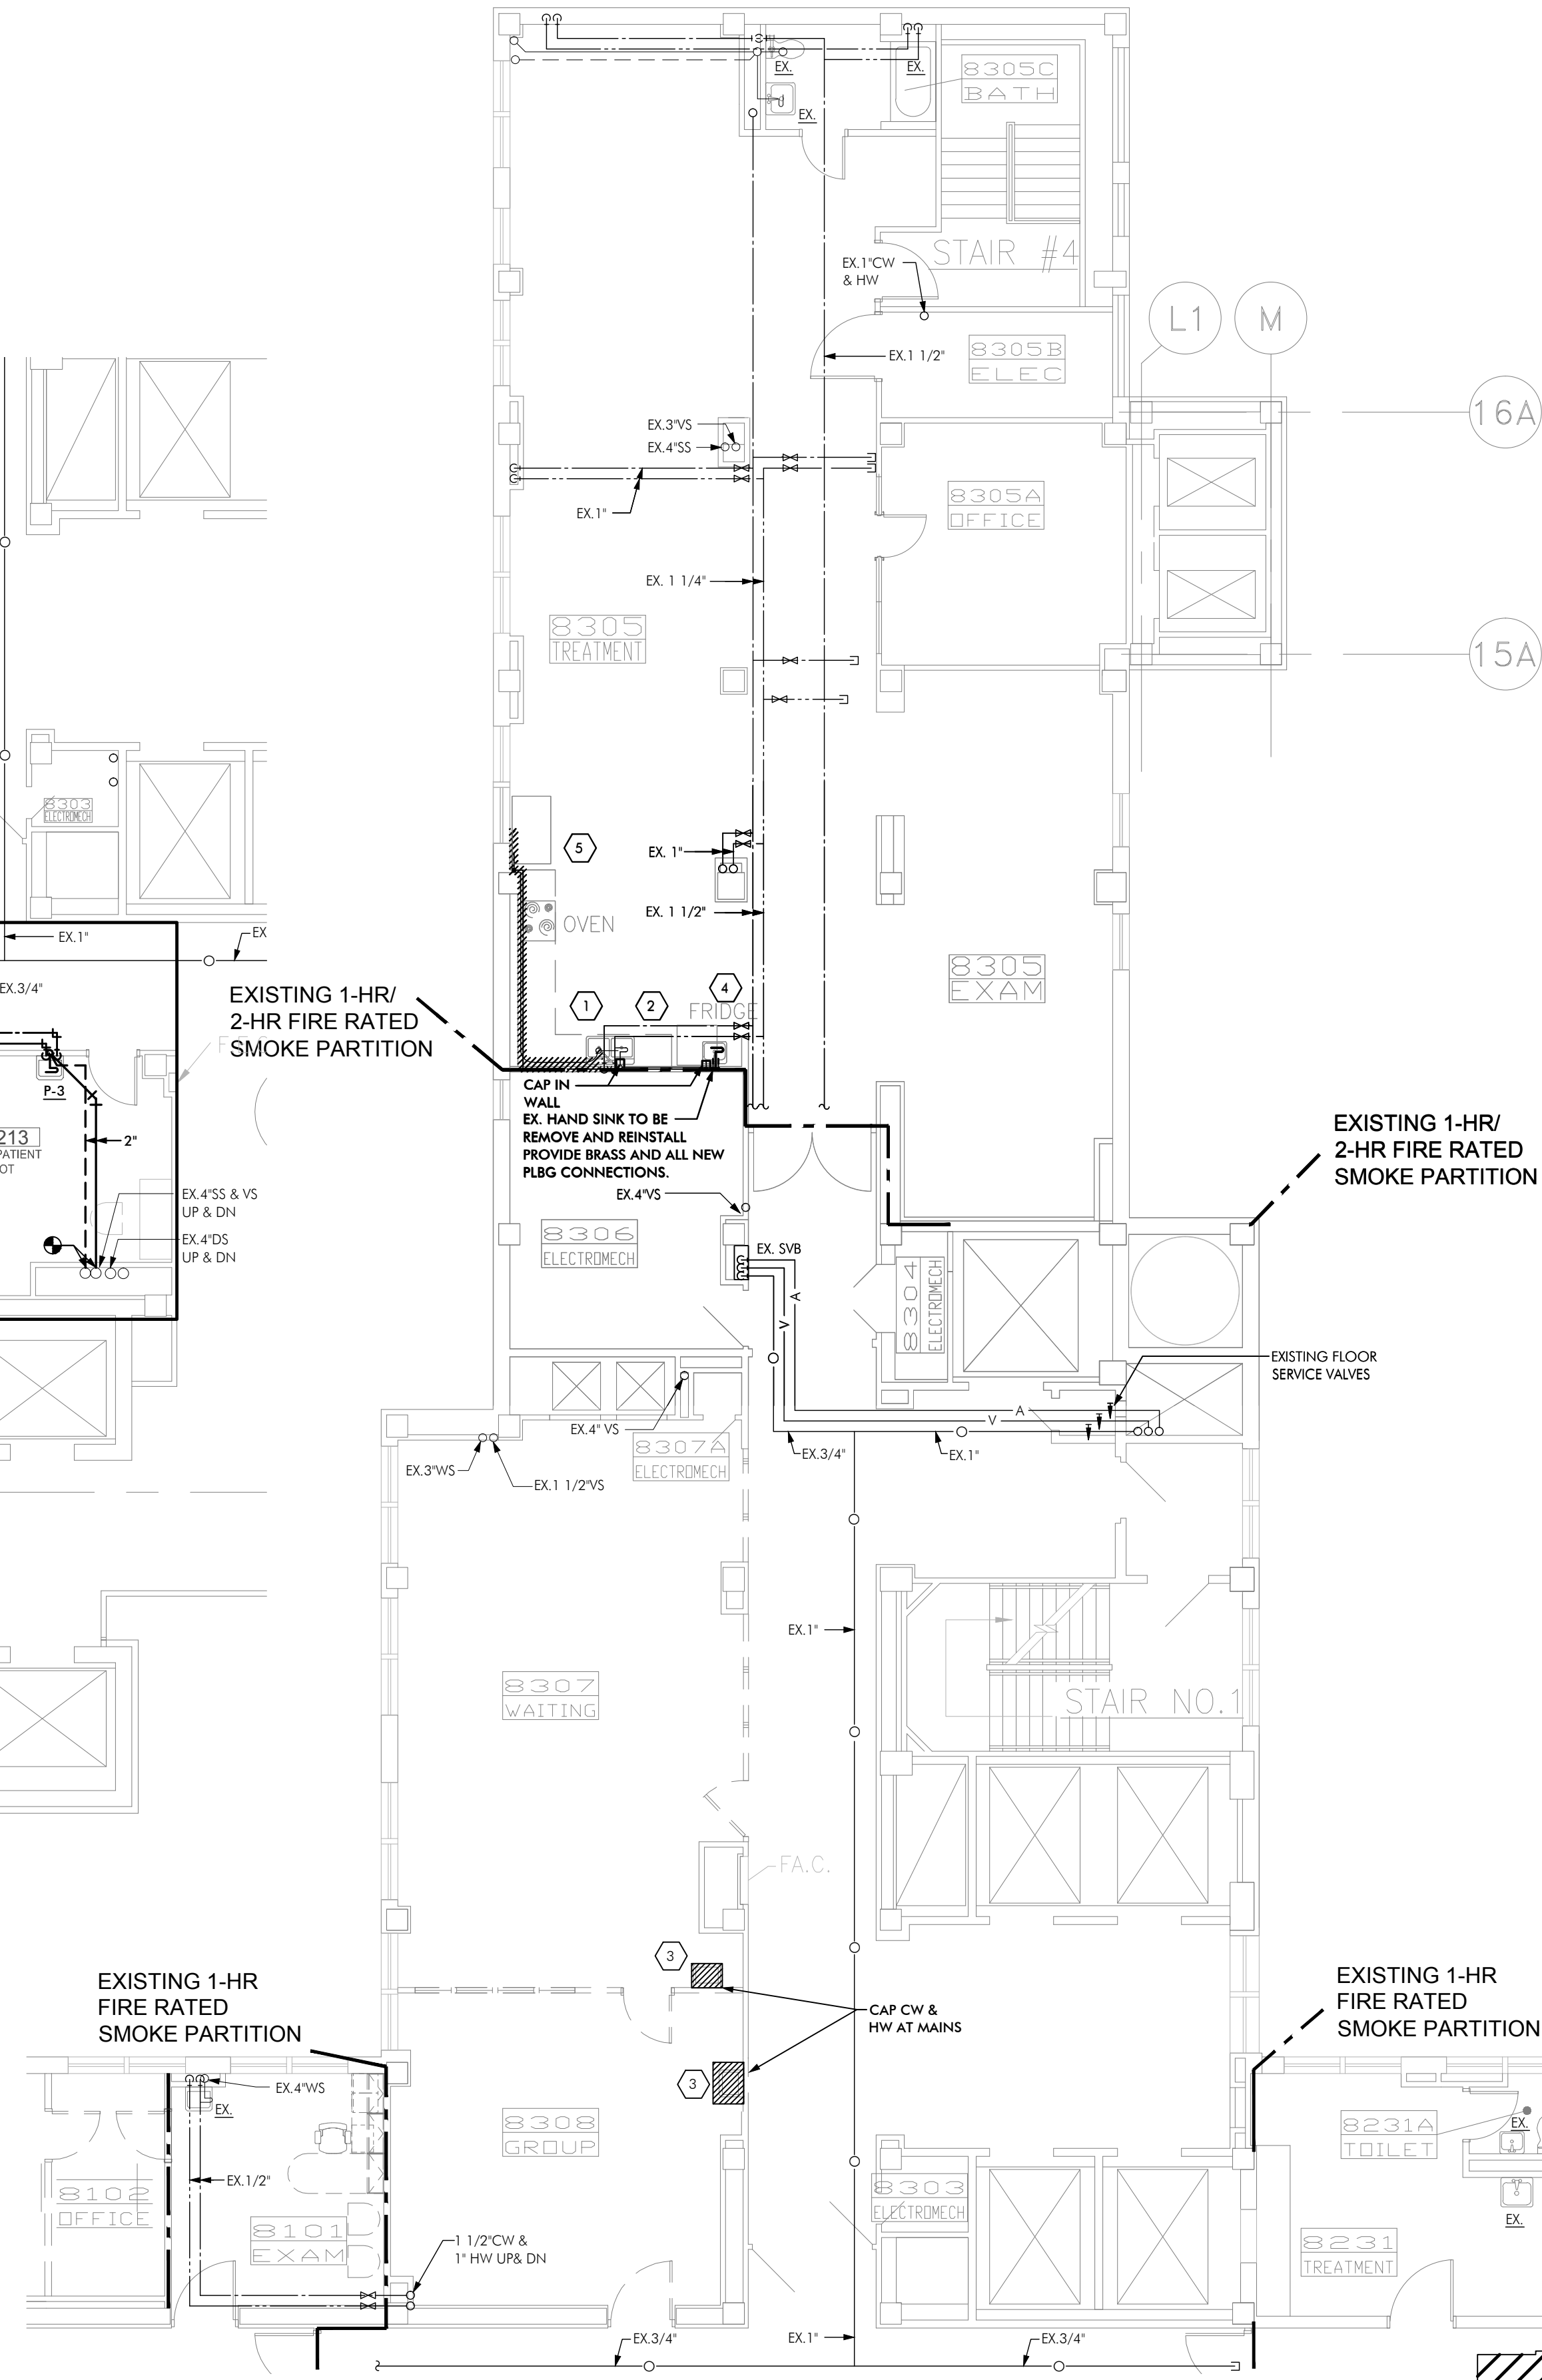

KEY PLAN
NO SCALE

PLUMBING DEMOLITION NOTES

- WHERE FIXTURES OR EQUIPMENT ARE INDICATED TO BE REMOVED, REMOVE THE FIXTURE, ROUGHING AND ALL PIPING TO BACK TO MAINS AND CAP. REMOVE ALL ABANDONED PIPING FROM SITE.
- WHERE FIXTURES OR EQUIPMENT ARE INDICATED TO BE REMOVED, THE FIXTURE OR EQUIPMENT IS TO REMAIN THE PROPERTY OF THE OWNER AND THE CONTRACTOR SHALL DELIVER THE FIXTURES AND EQUIPMENT TO THE OWNERS STORAGE FACILITY AS DIRECTED BY THE OWNER. SHOULD THE OWNER DECIDE NOT TO RETAIN THE FIXTURES OR EQUIPMENT, THE FIXTURES AND EQUIPMENT BECOME THE PROPERTY OF THE CONTRACTOR AND SHALL BE REMOVED FROM THE SITE.

PLUMBING DEMOLITION PLAN NOTES

- REMOVE EXISTING 2 COMP SINK
- REMOVE EXISTING REFRIGERATOR
- REMOVE EXISTING HAND SINK
- REMOVE & RELOCATE EXISTING ICE MAKER & PUMP
- REMOVE EXISTING ICE MAKER

REFER TO ARCHITECTURAL FOR RELOCATED ITEMS.

Whitaker & Rawson, Inc.
3332 Old Montgomery Hwy
Suite 103 Mark Harris Bldg
Birmingham, AL 35209
Phone: 205-870-0801
Fax: 205-870-0801
www.whitakerandrawson.com
Mechanical Doug Rawson
Direct Line - (205) 870-0801
Planning: Carol Johnson
Direct Line - (205) 949-5123

Veterans Administration

FINAL SUBMITTAL

BIRCHFIELD
PENUEL &
ASSOCIATES,
ARCHITECTS
2805 CRESCENT AVENUE • SUITE 200 • BIRMINGHAM, ALABAMA 35209

Department of Veterans Affairs
MEDICAL CENTER
BIRMINGHAM, ALABAMA

Drawing Title	8TH FLOOR PART "A" & "C" ENLARGED PLUMBING PIPING & DEMOLITION PLANS	Project Title	RENOVATE SPACE FOR REHAB AND PHYSICAL MEDICINE	Date:	08-12-11
Building Numbers		Checked	DER/CLJ	CAD File No.	4608A01
Location	VA MEDICAL CENTER BIRMINGHAM, ALABAMA	Drawn	RMB	Drawing NO.	P2.1
				Dwg.	Of