
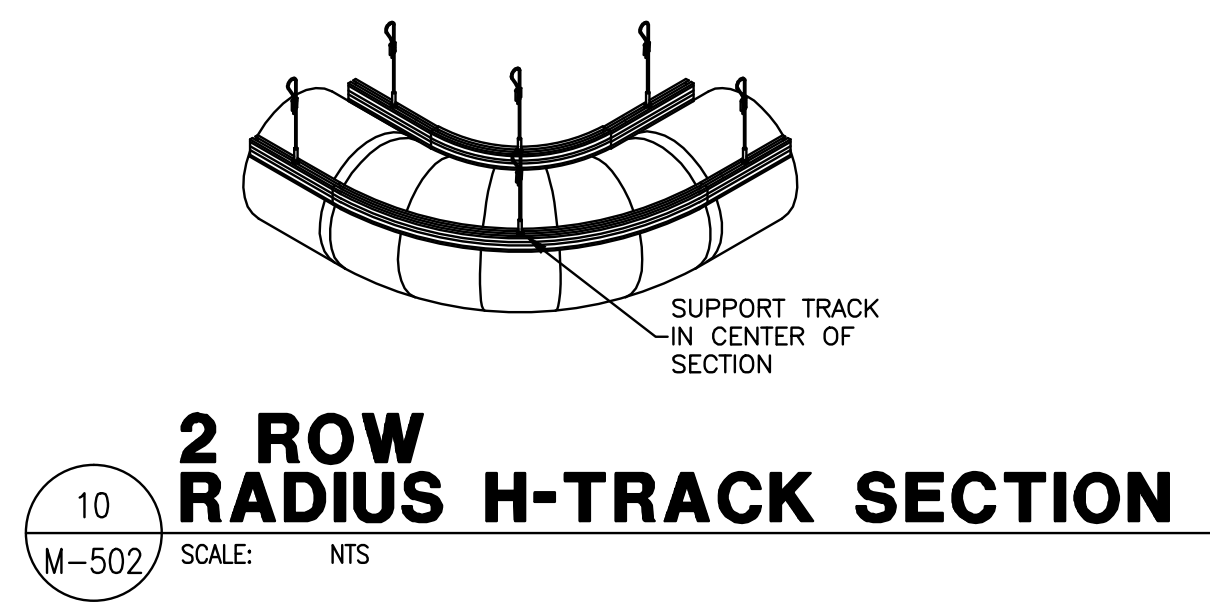
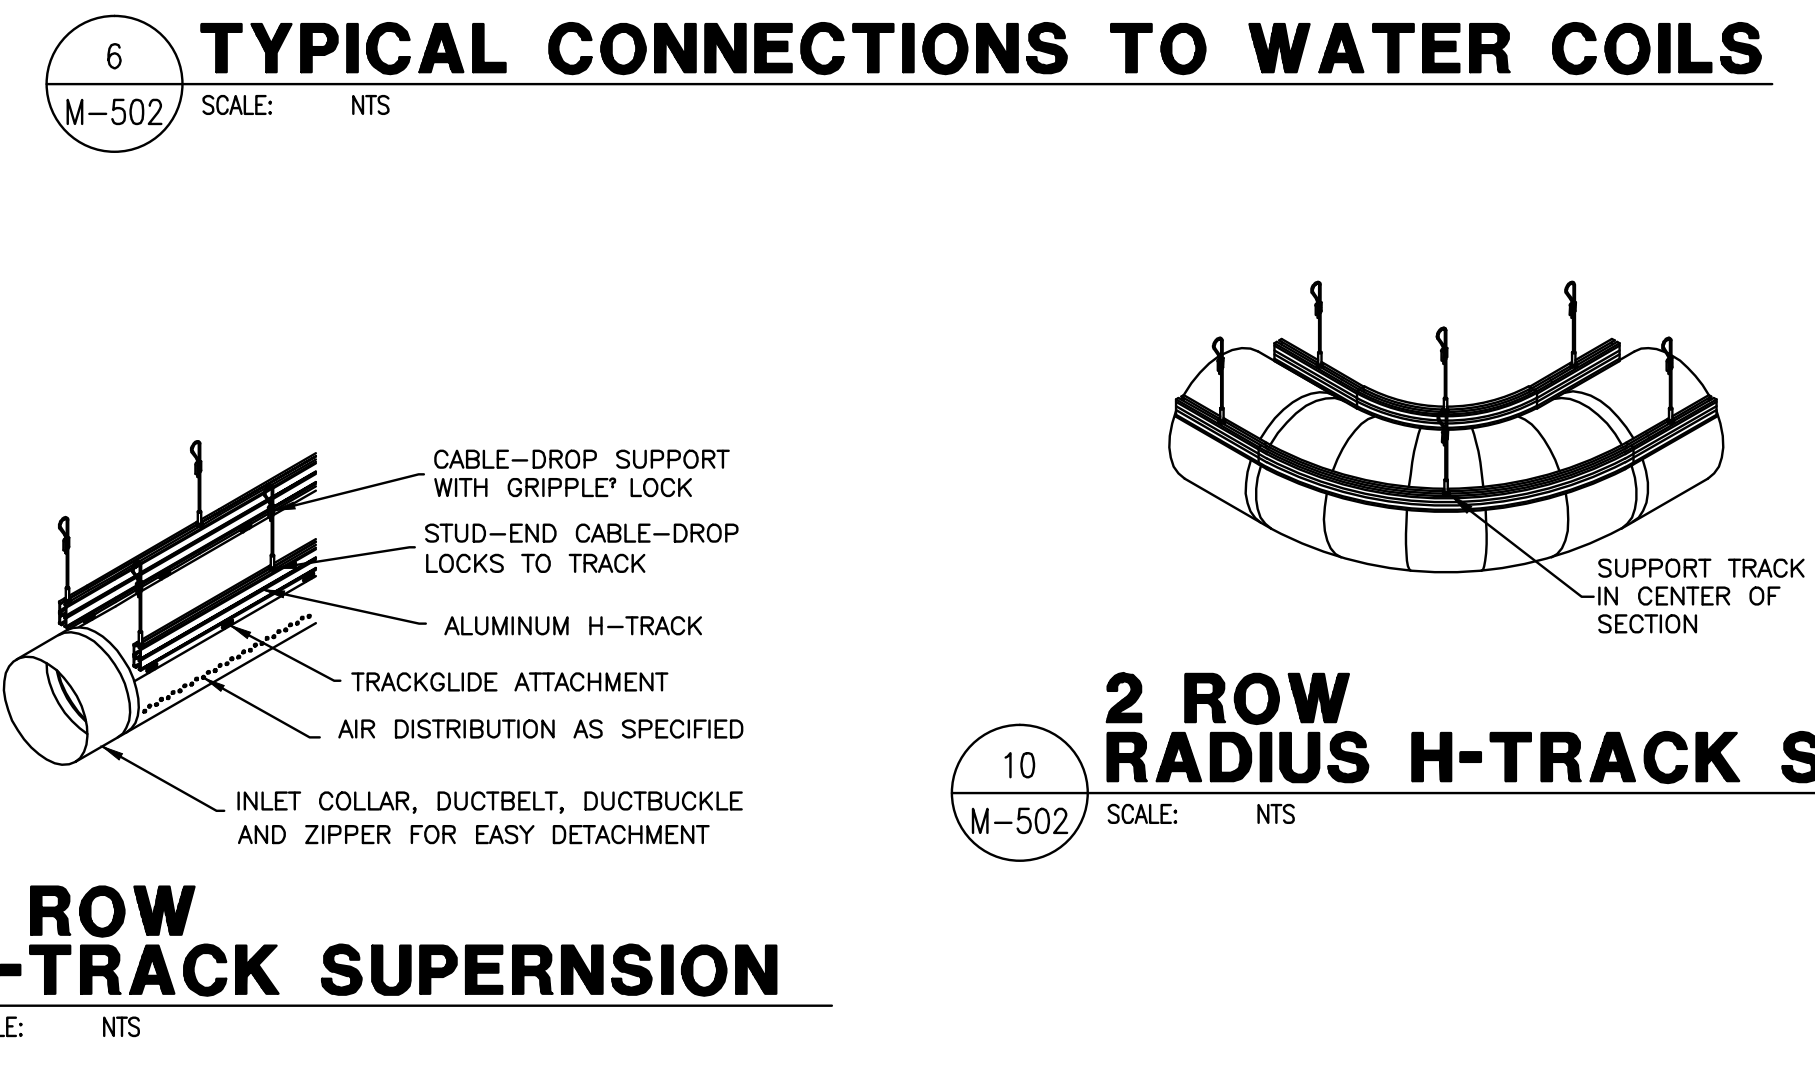
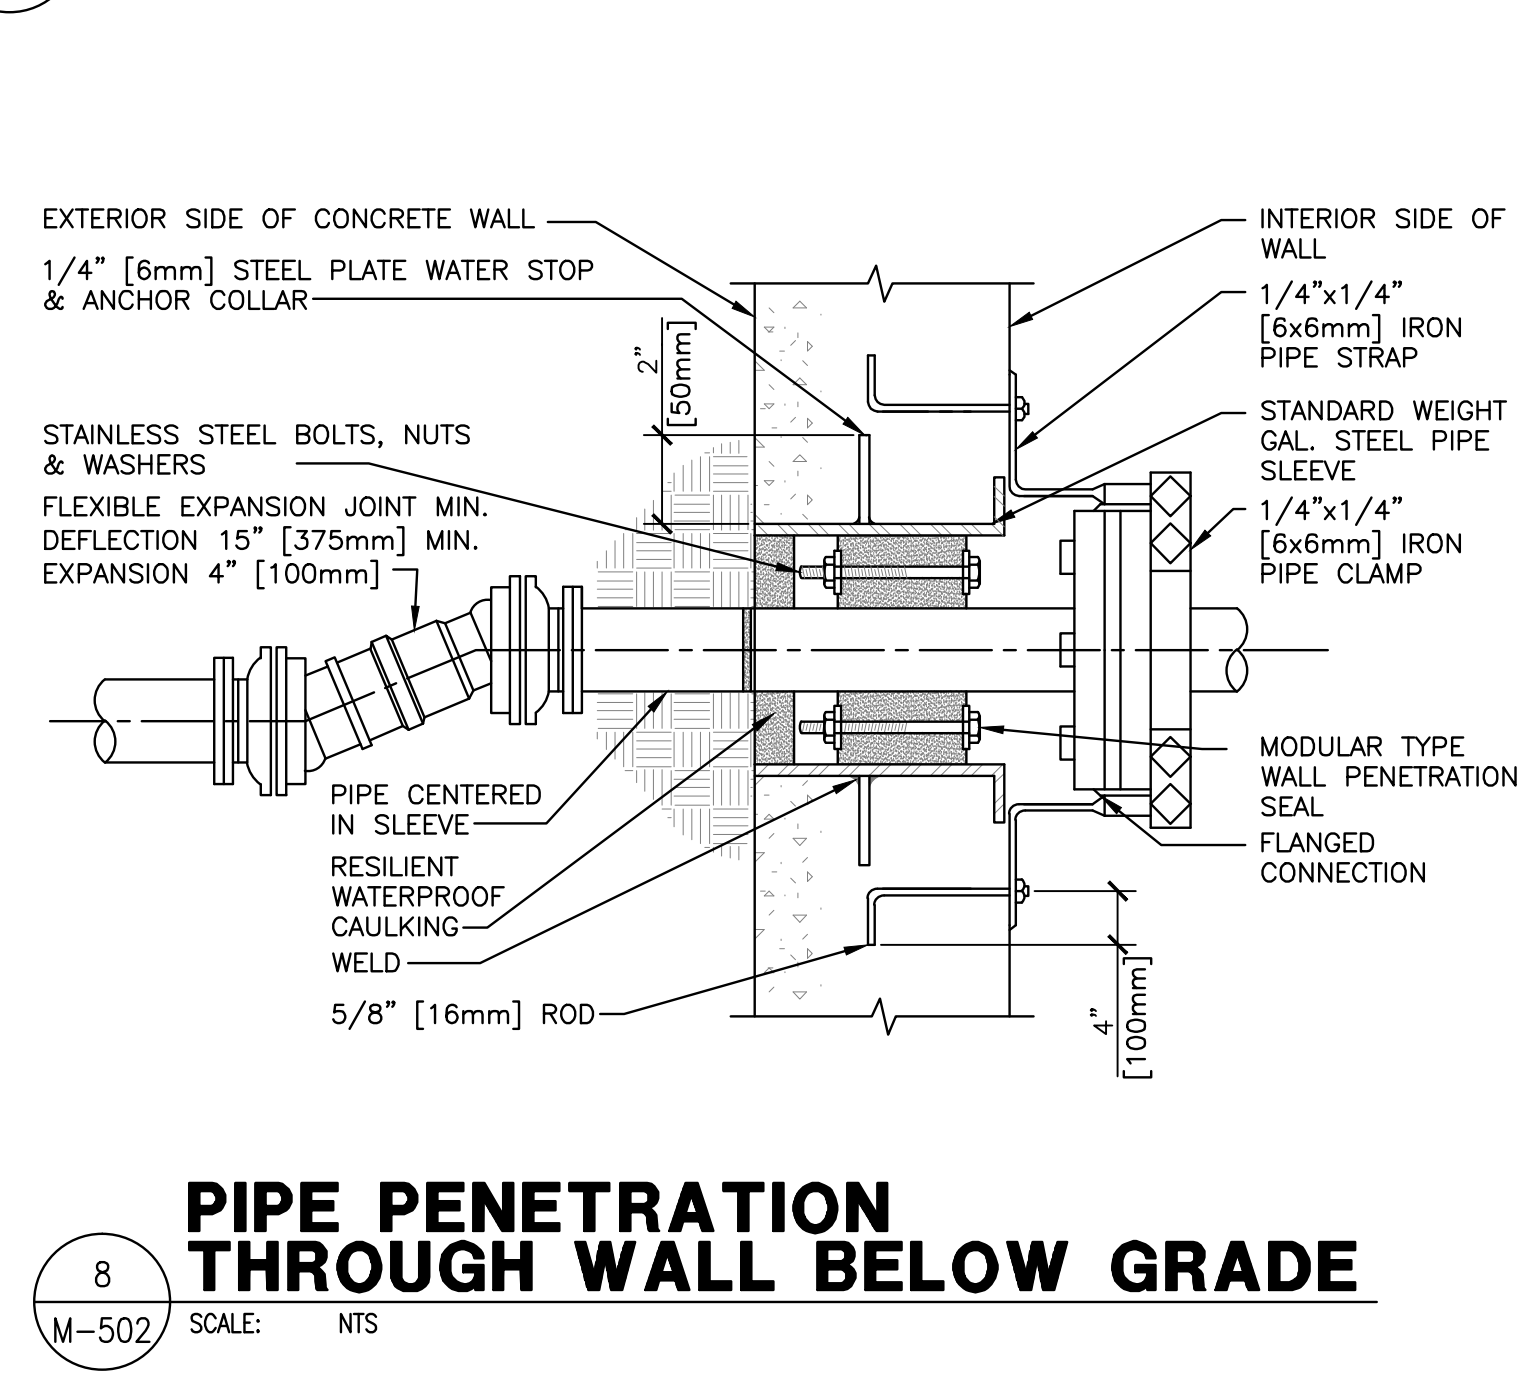
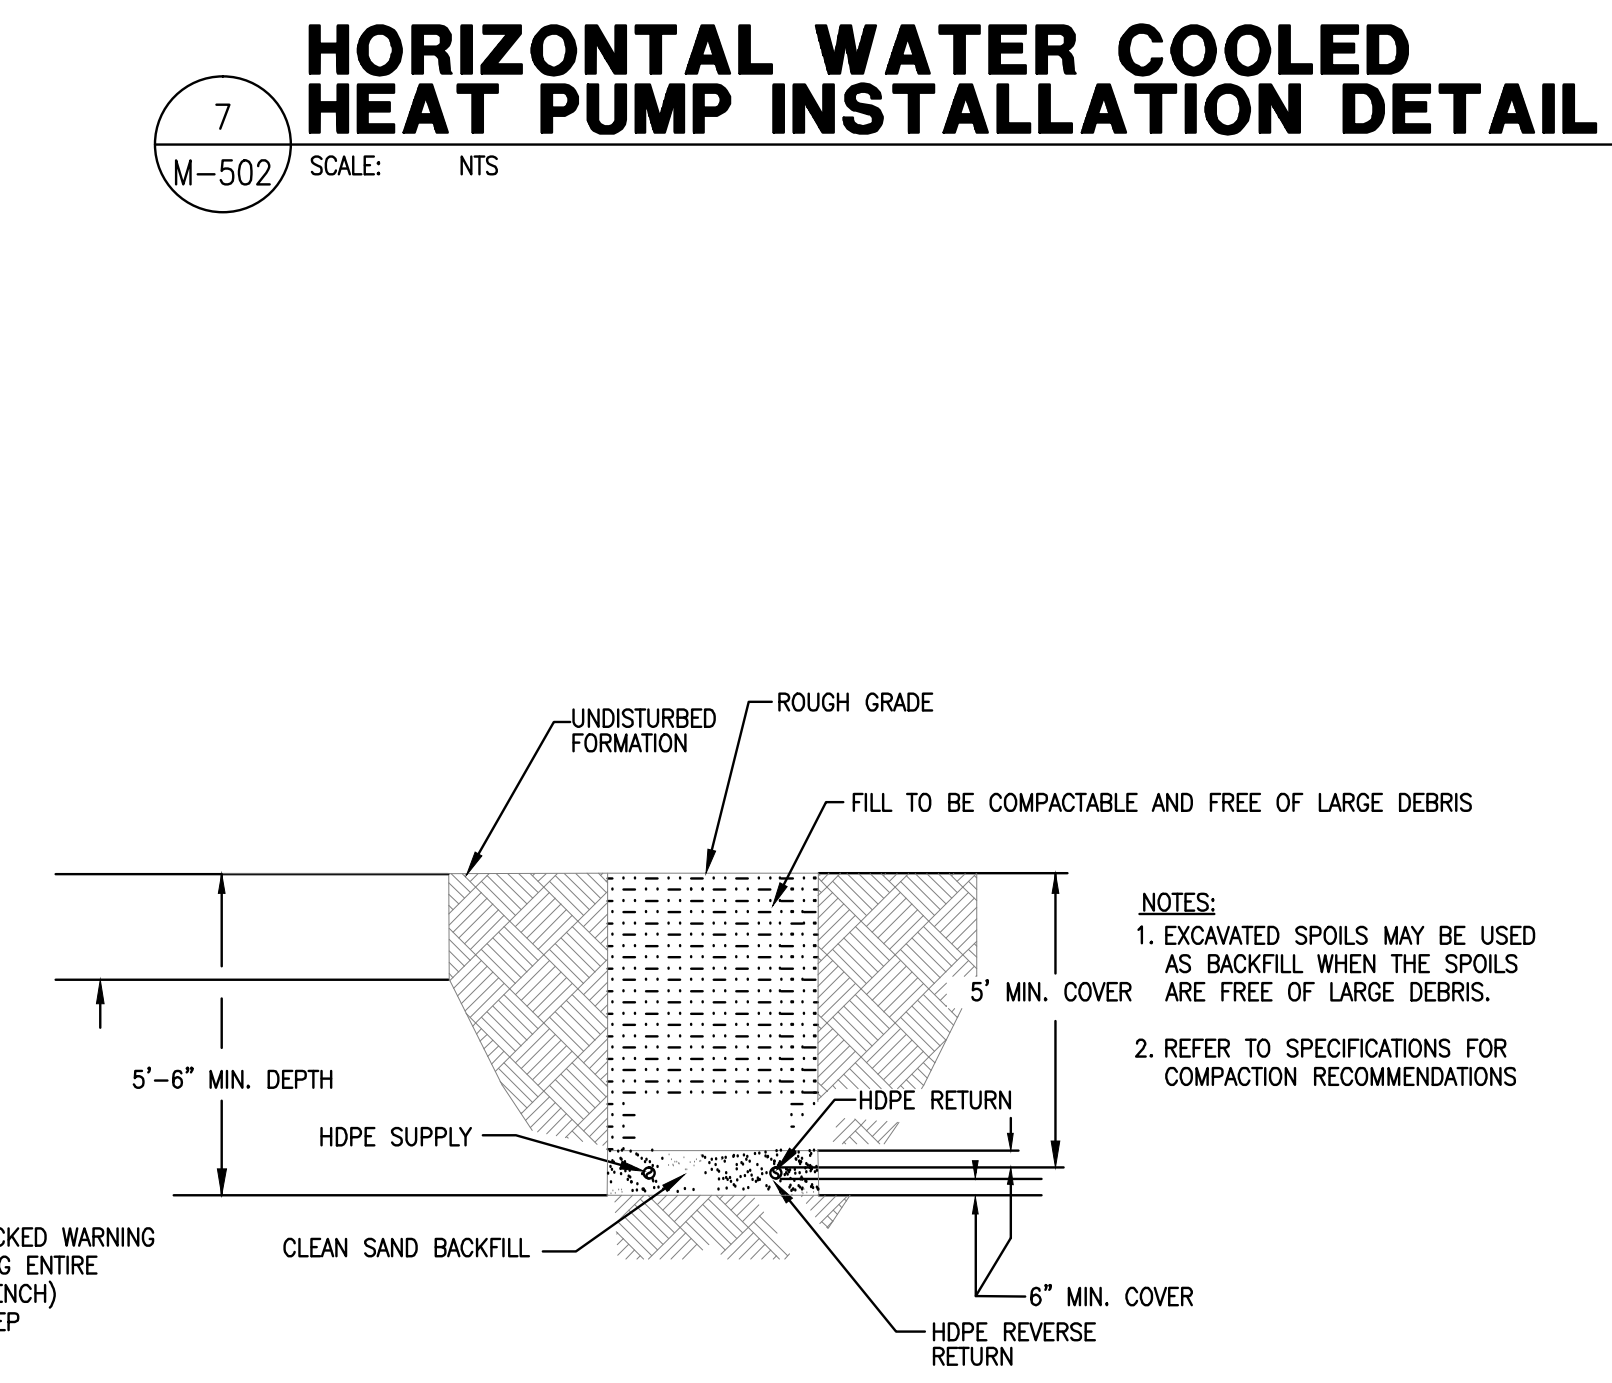
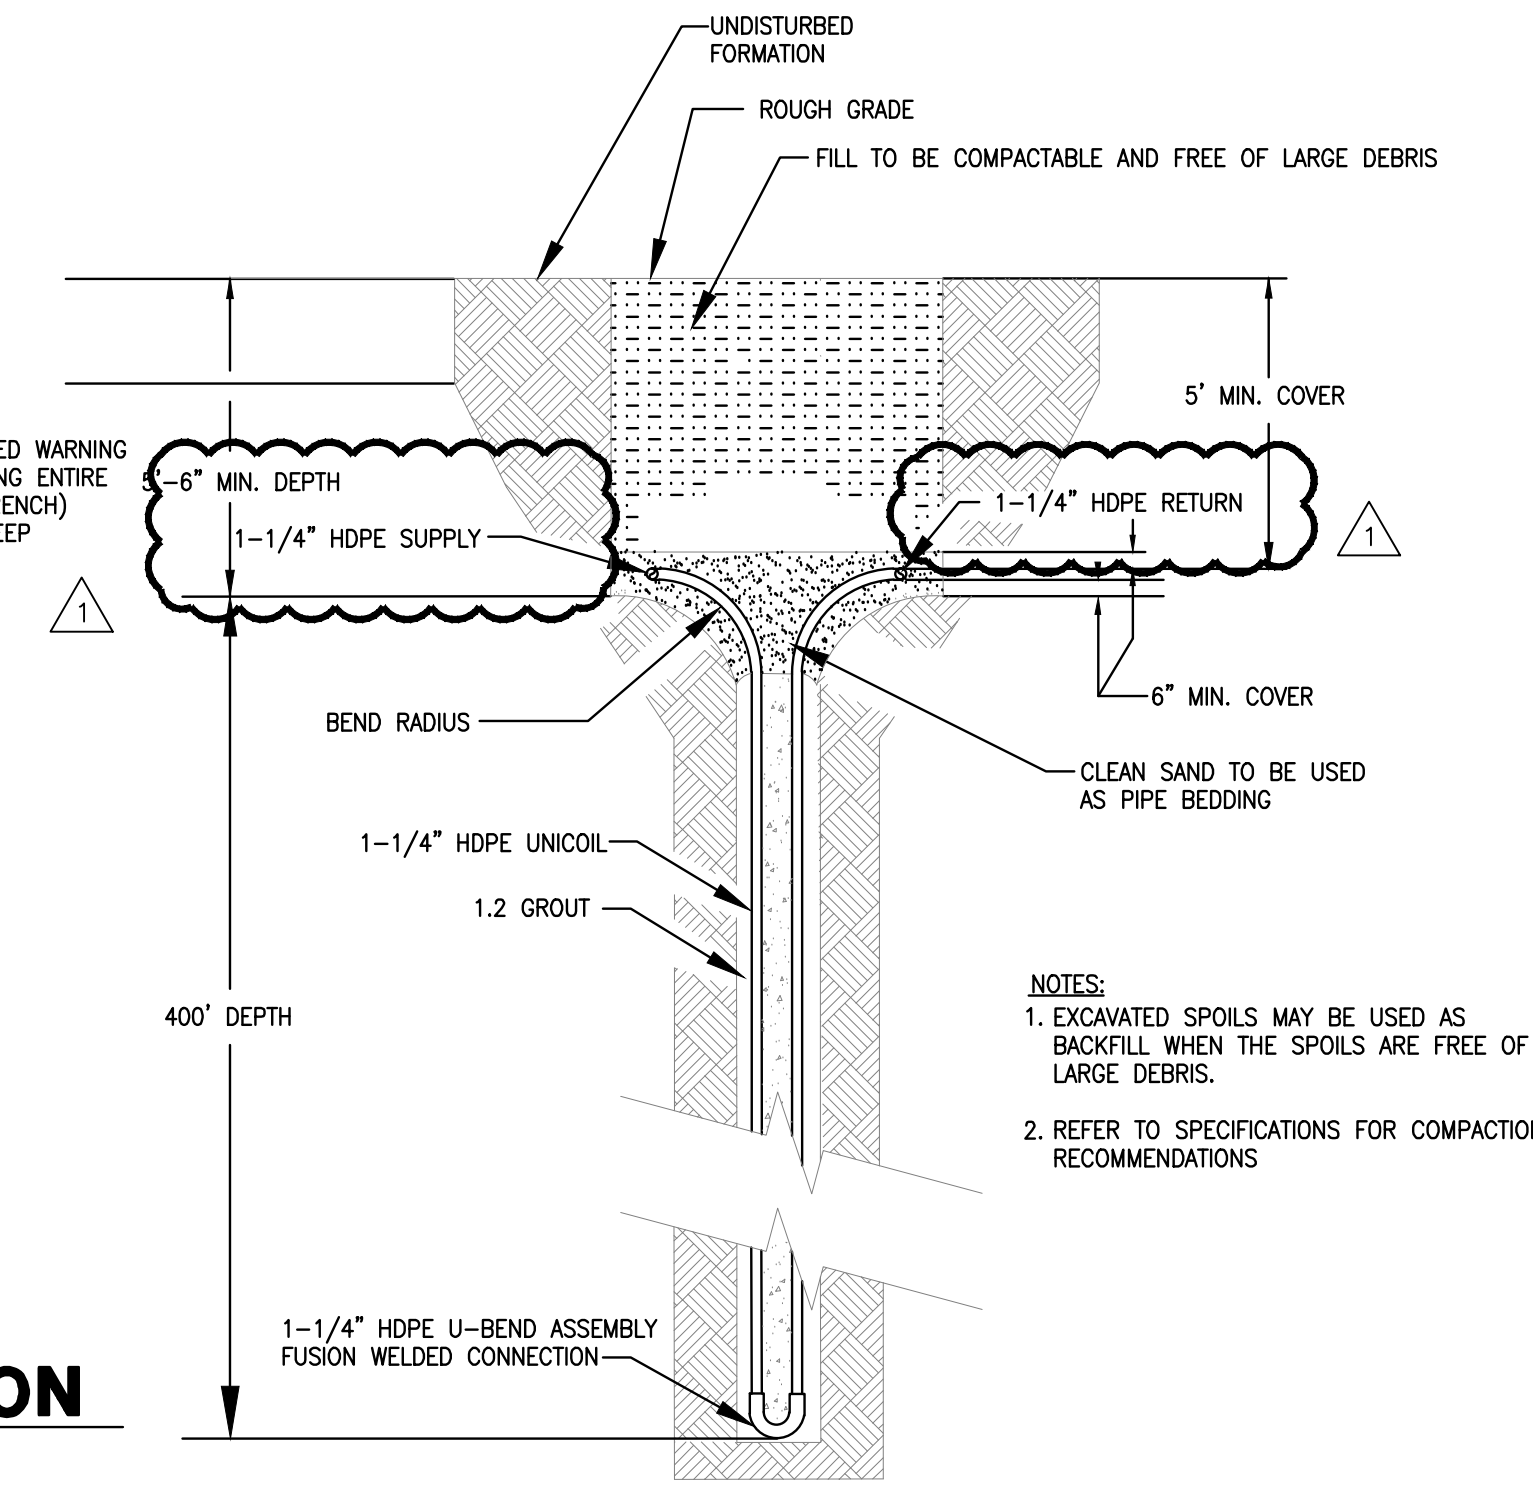
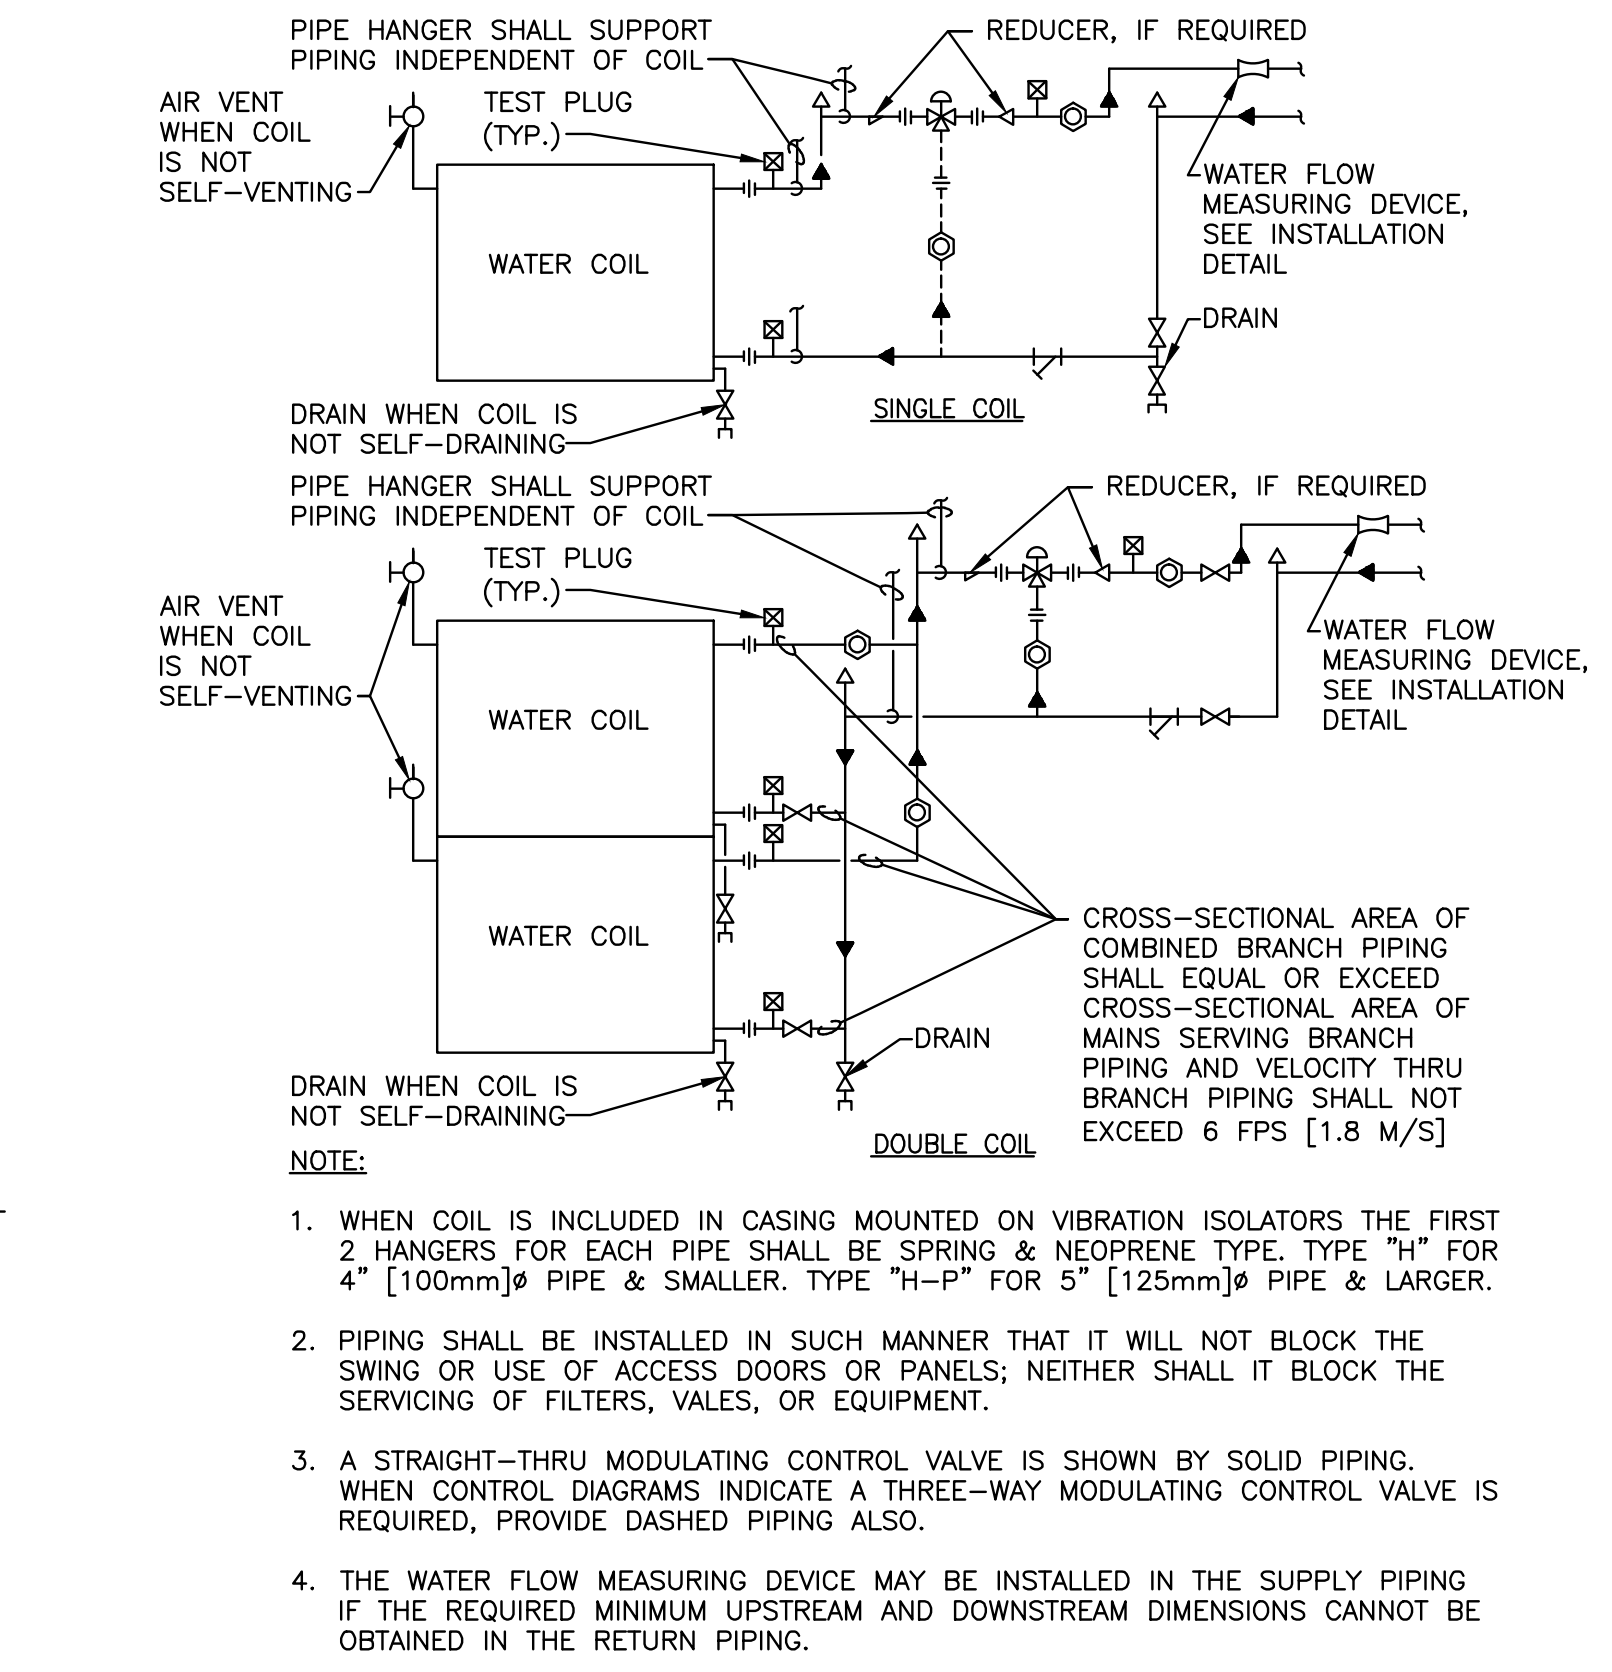
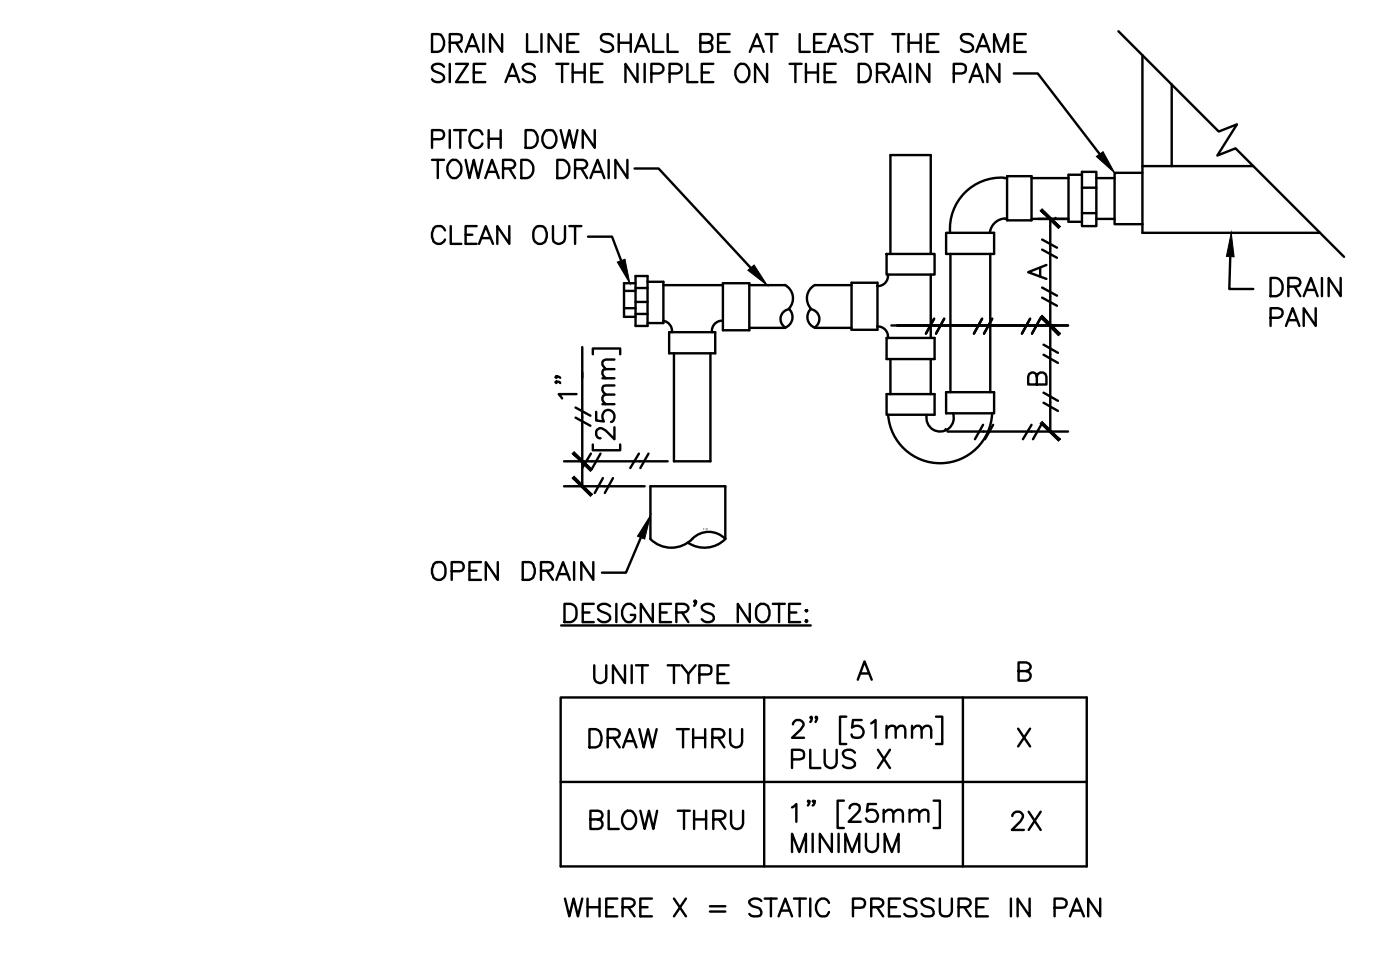
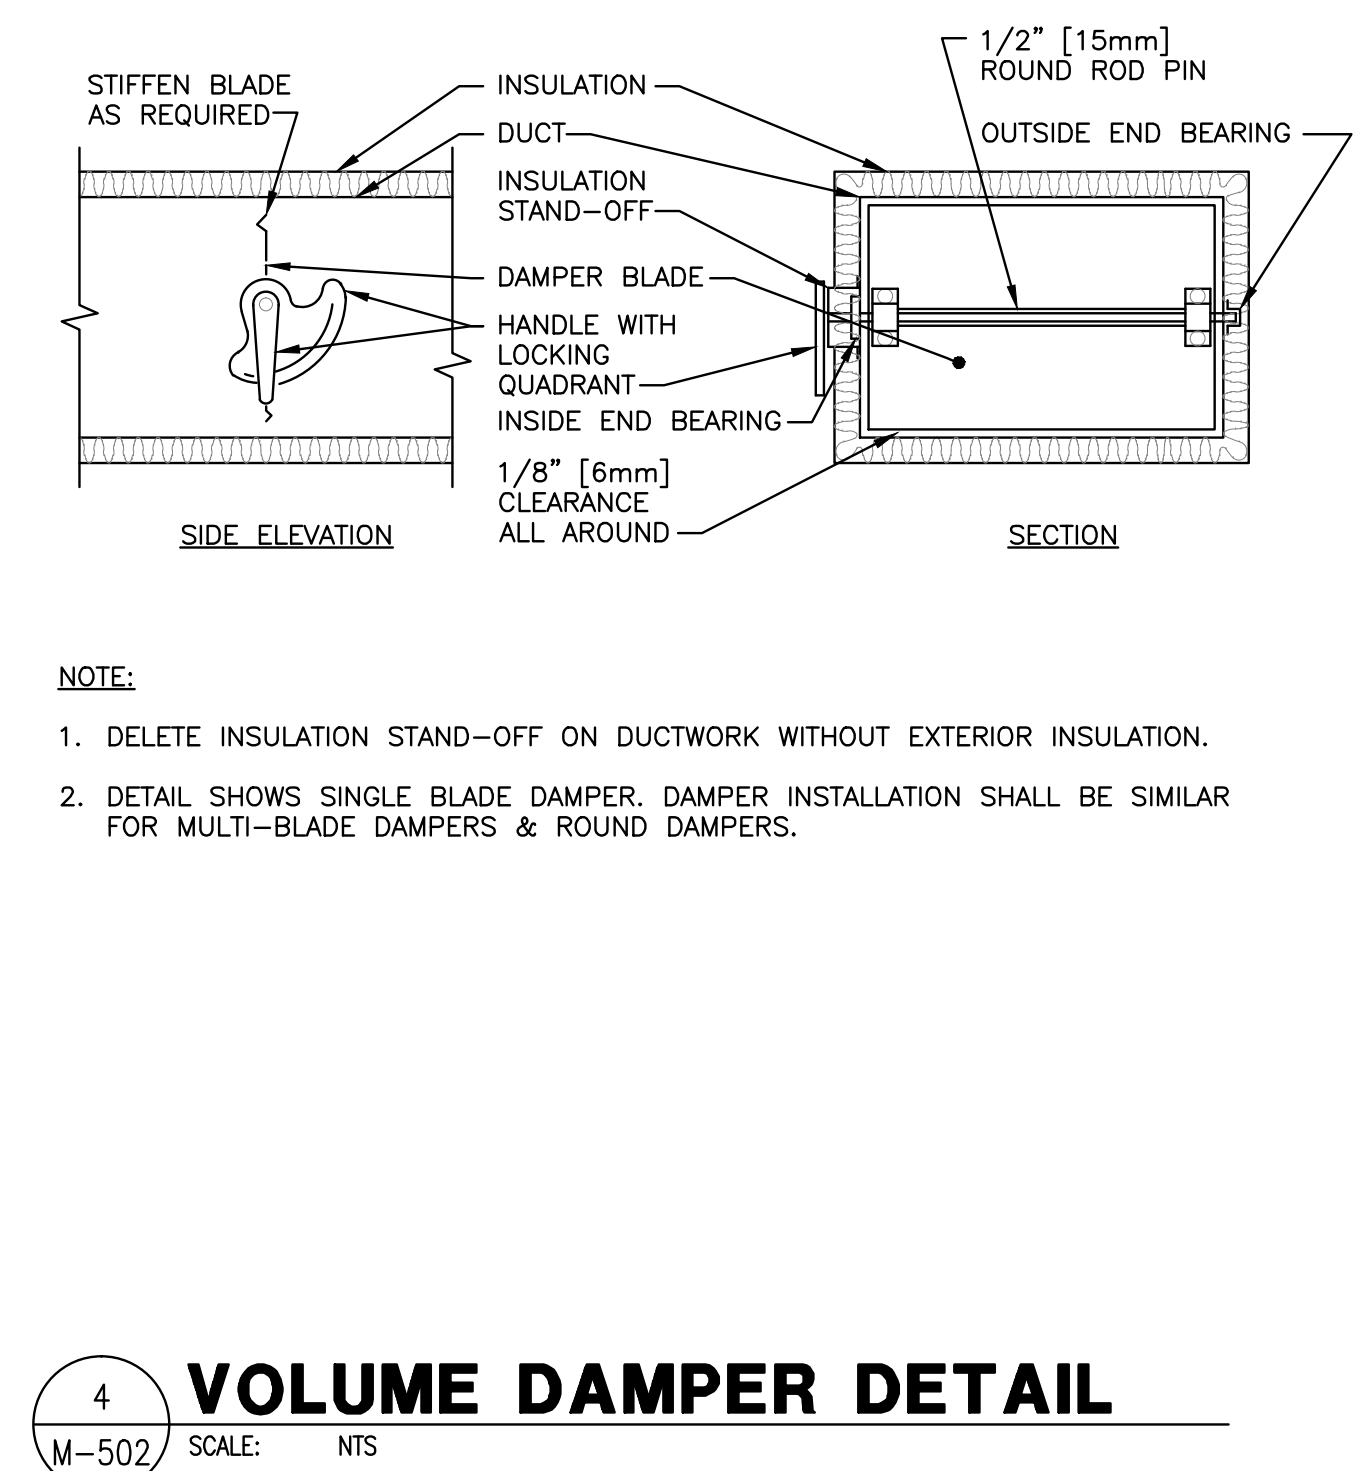
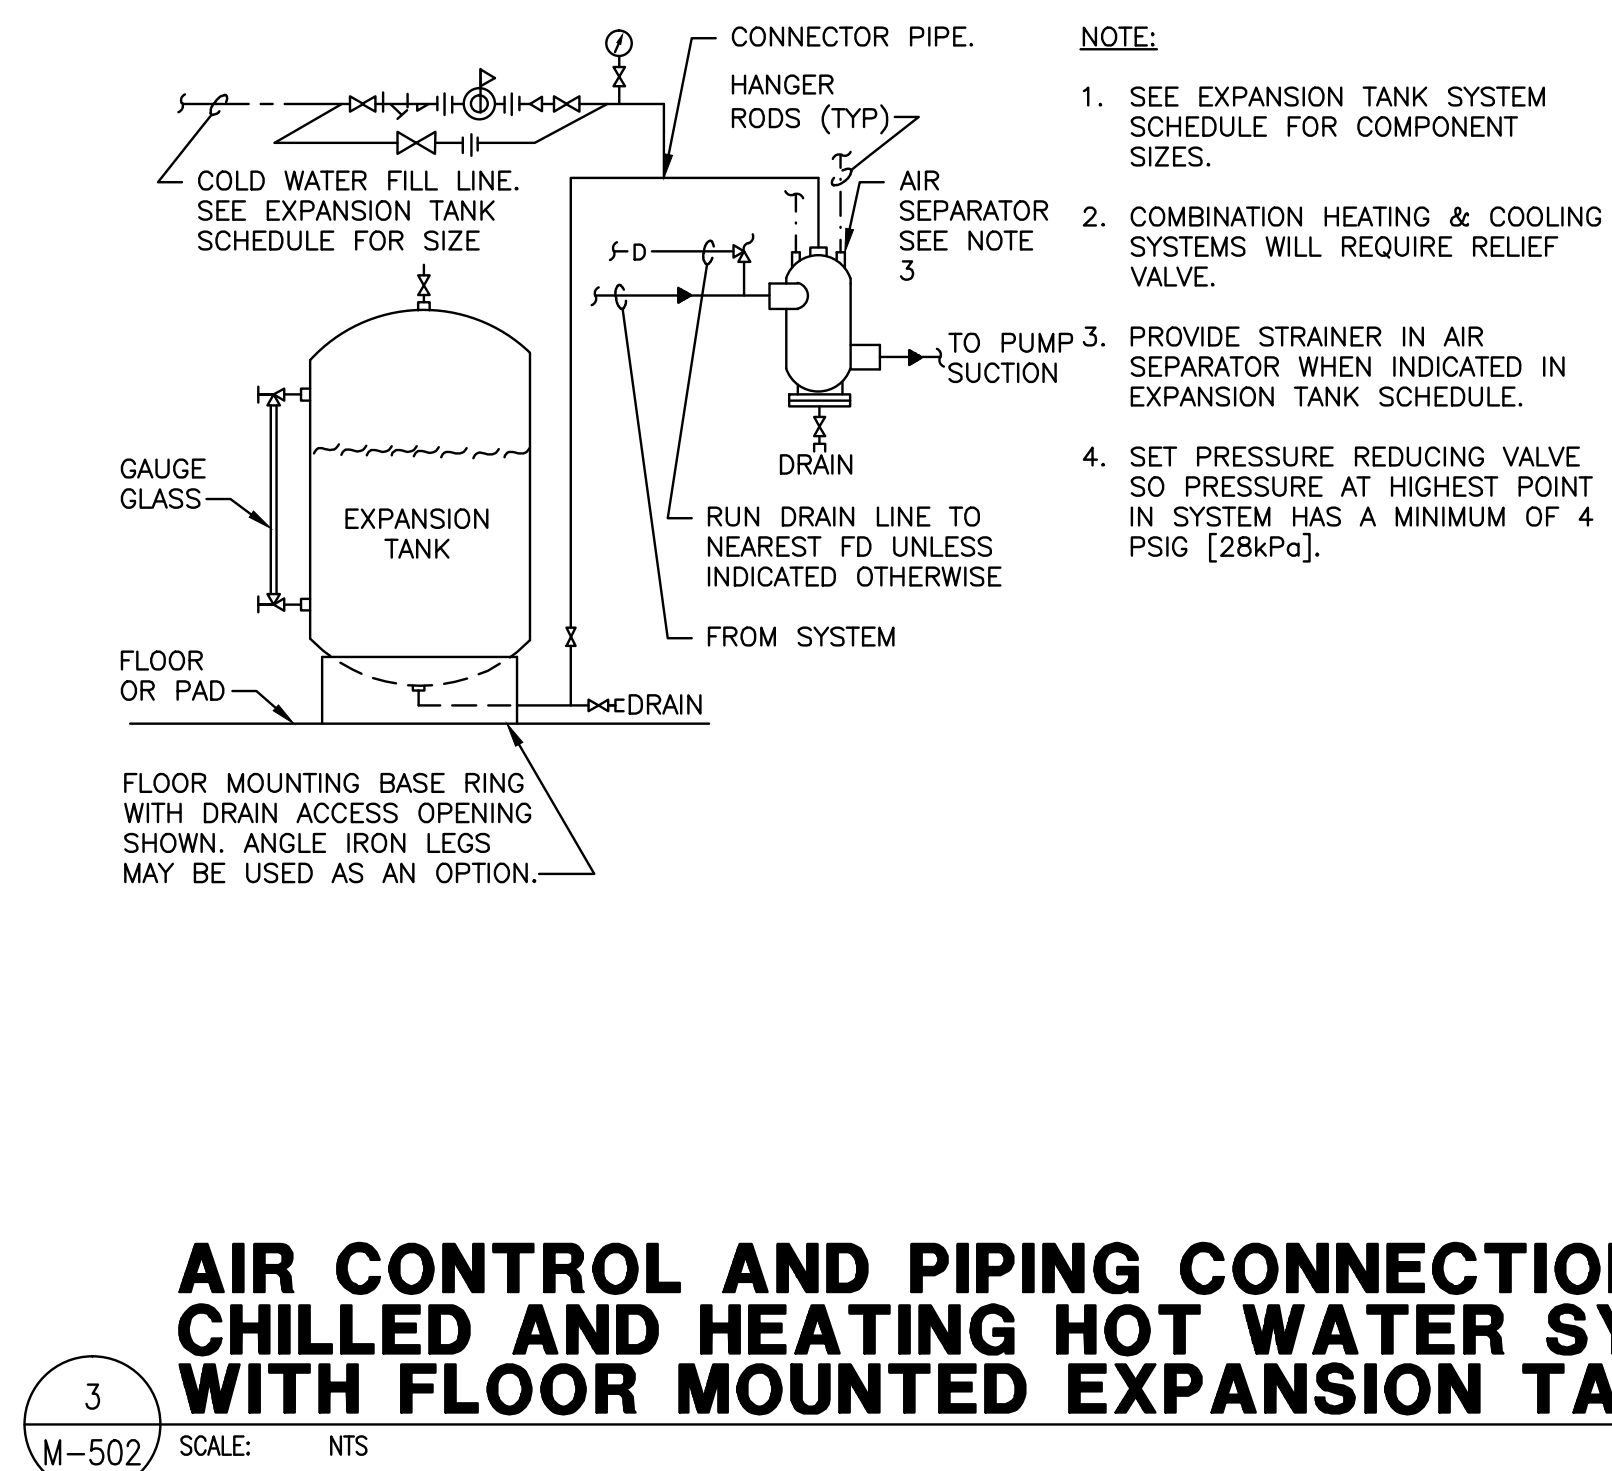
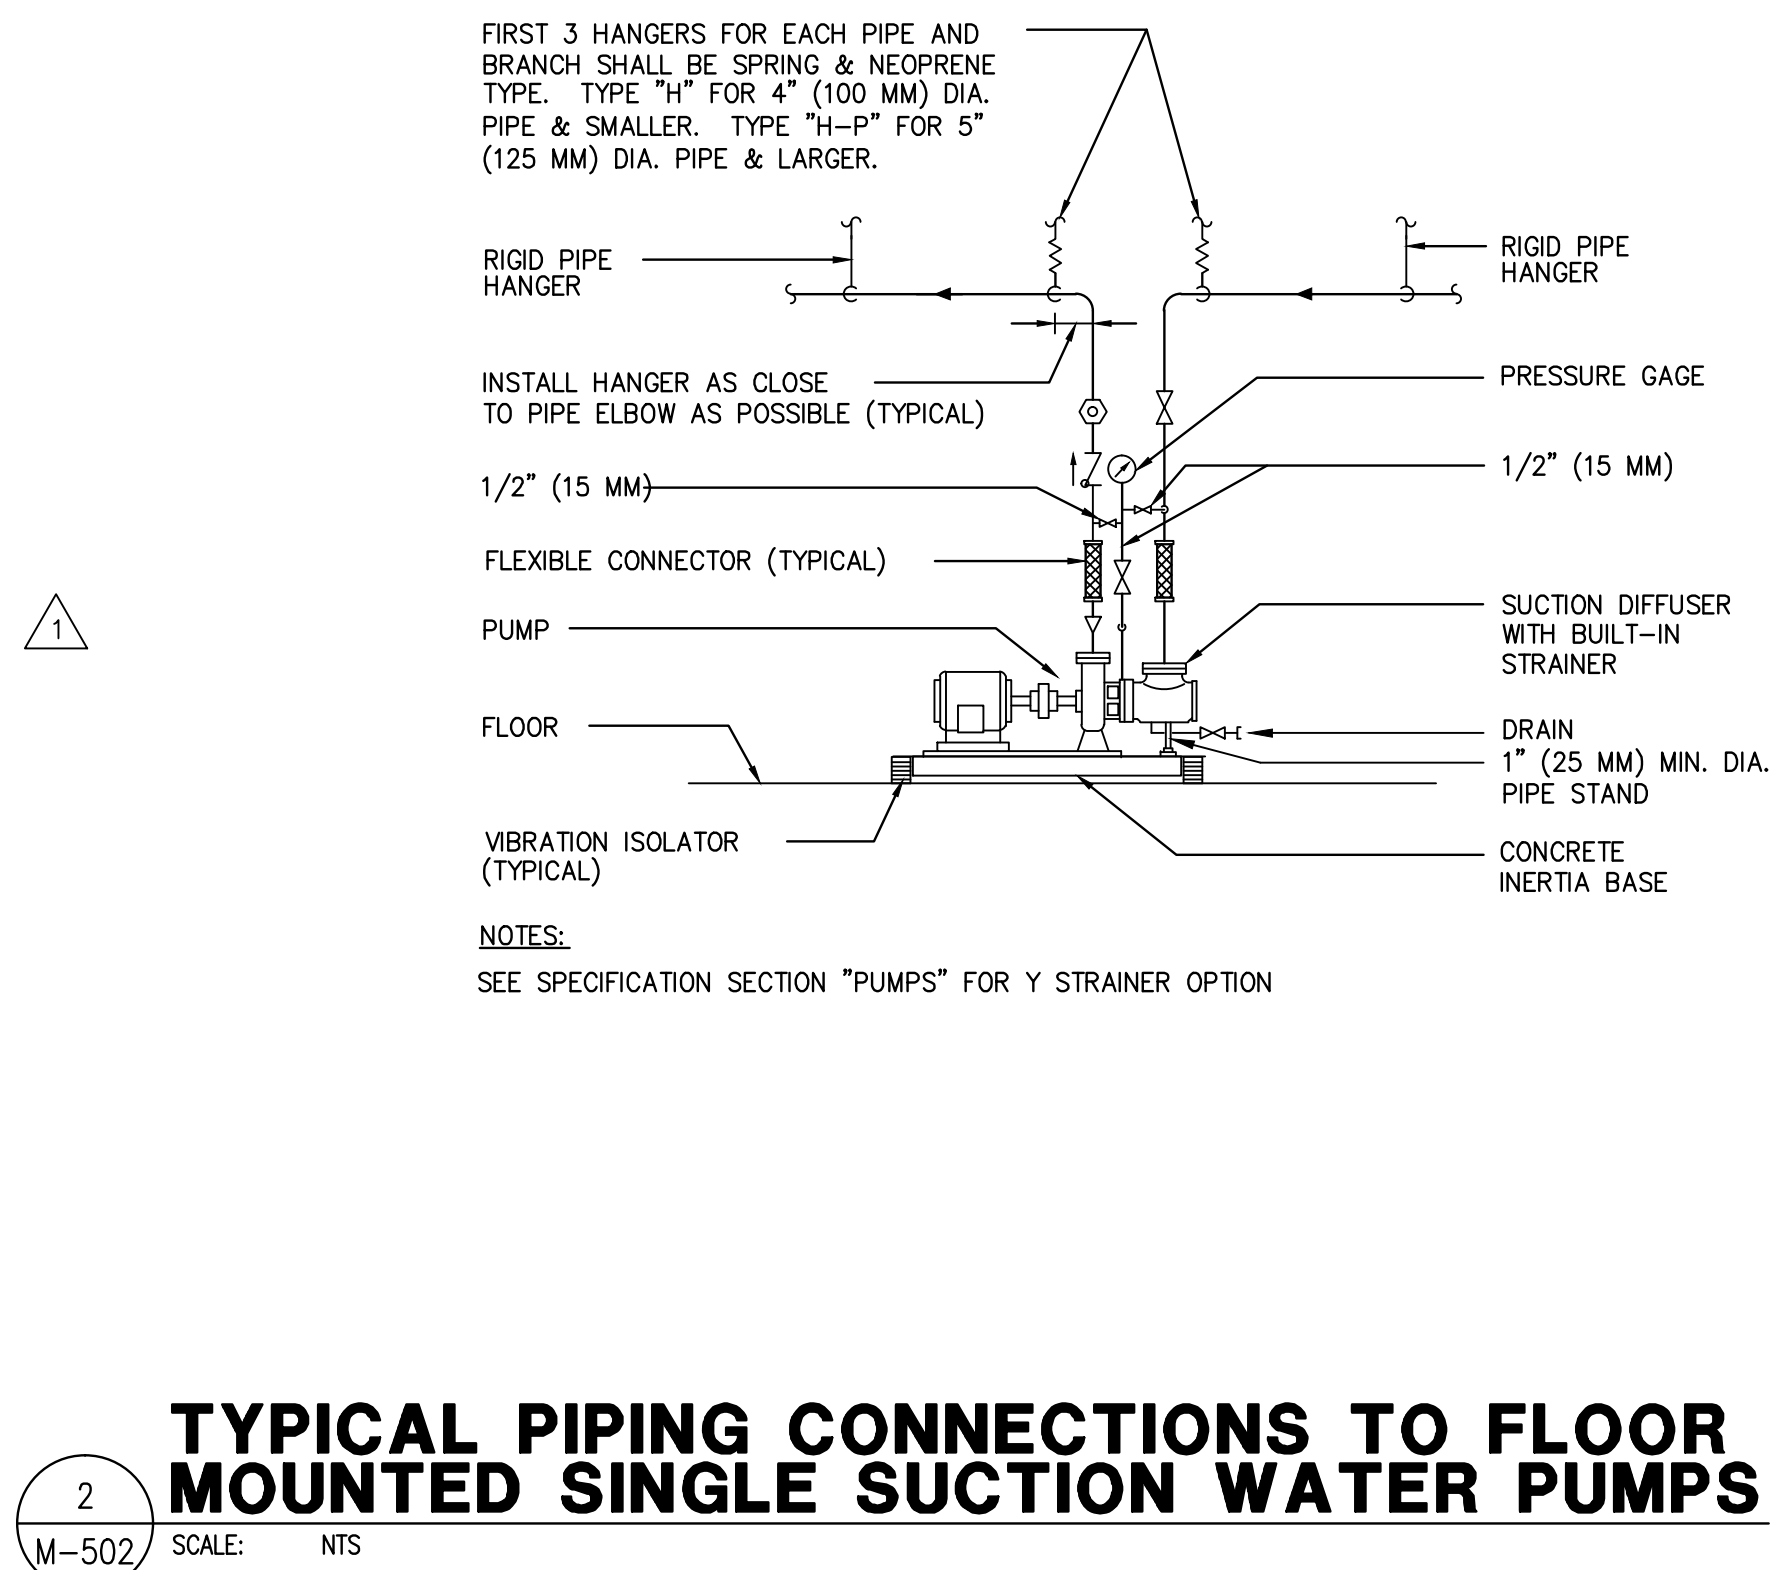


A three inches = one foot  
B one and one-half inches = one foot  
C one inch = one foot  
D three-quarters inch = one foot  
E one-half inch = one foot  
F three-eighths inch = one foot  
G one-quarter inch = one foot  
H one-eighth inch = one foot

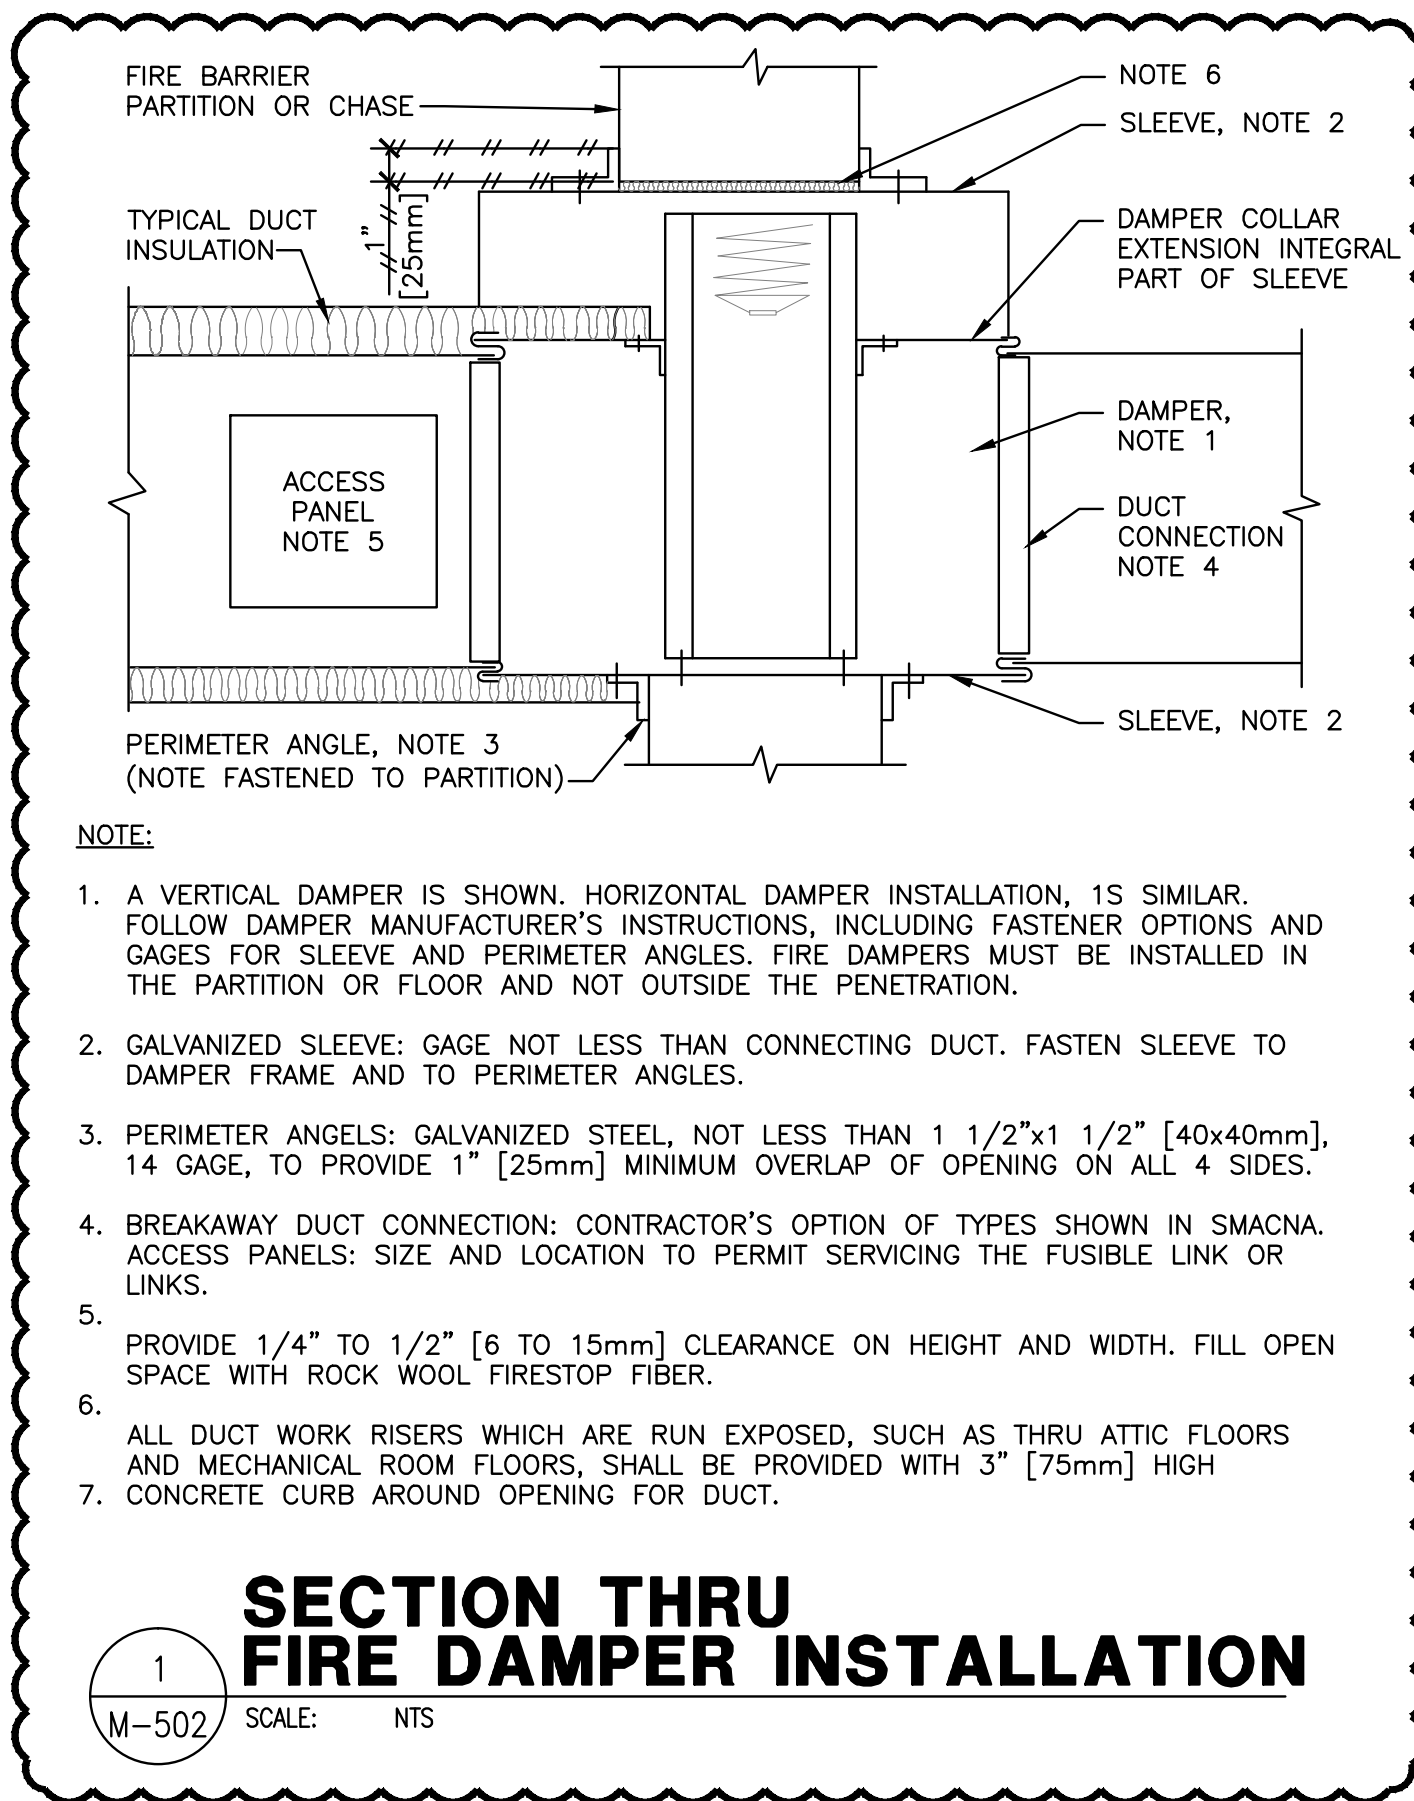

Revisions	Date
ADDENDUM 1	06/01/12

**ENGINEERS:**

**APOGEE**  
Consulting Group, PA  
(317) 819-0200 Fax (919) 858-7423  
Apogee Project # 2011 135  
Apogee CO# PC8080089

8831 Keystone Crossing  
Indianapolis, IN 46240

Professional Stamp/Seal

**ARCHITECT:**

**CSO Architects**  
ARCHITECTURE • INTERIOR DESIGN  
8831 Keystone Crossing • Indianapolis, IN 46240  
Main 317.848.7800 • Fax 317.574.0957 • csolac.net



Drawing Title

**MECHANICAL DETAILS**

Approved: Robert Nash, CO  
Approved: Andrew Mercker, COTR

Project Title

**ENERGY IMPROVEMENTS & AIR CONDITIONING BUILDING #8, GYM**

Building No. 8  
Scale AS SHOWN  
Drawn/Checked DMB/JVM

Location  
VA MEDICAL CENTER  
ENGINEERING BLDG #52, RM 201  
1700 E. 38TH ST.  
MARION, IN 46953

Date 09/19/11  
Project No. 610-10-100  
DRAWING NO. **M-502**  
Dwg. 6 of 7

**VA NIHCS Engineering**

**Department of Veterans Affairs**