




1. MOUNT RECEPTACLE TO SERVER RACK. REFER TO EY-501.2. COORDINATE WITH TECHNOLOGY CONTRACTOR.
2. DISCONNECT AND REMOVE EXISTING ELEVATOR/CAB LIGHTING DISCONNECTS. MAINTAIN WIRING FOR RECONNECTION.
3. PROVIDE 30A FUSED DISCONNECT FOR ELEVATOR CAB LIGHTING. PROVIDE NEW FEEDERS THROUGH EXISTING CONDUIT EXTENDED TO ACCOMMODATE NEW WORK. COORDINATE FINAL REQUIREMENTS AND LOCATIONS WITH ELEVATOR VENDOR.
4. MAKE CONNECTIONS FOR ELEVATOR SHUTDOWN AND RECALL TO FIRE ALARM SYSTEM.
5. LOCATE VFD'S FOR ALL ROOF MOUNTED MECHANICAL EQUIPMENT IN THIS ROOM. PROVIDE ALL WIRING FROM VFD'S TO LOCAL DISCONNECT SWITCH FOR MAKE BEFORE BREAK CONTACTS. PROVIDE CONNECTION AND WIRING TO FIRE ALARM SYSTEM FOR SHUTDOWN RELAY FUNCTIONALITY ON ALL VFD'S. REFER TO EP-501.2.
6. REMOVE EXISTING DETECTORS AND REPLACE WITH NEW DETECTORS IN THE ELEVATOR PIT.
7. MOUNT HEAT DETECTORS WITHIN 2' OF ALL SPRINKLER HEADS.
8. PROVIDE 100A BUSSMANN POWER MODULE FOR EACH NEW ELEVATOR MOTOR. PROVIDE NEW FEEDERS THROUGH EXISTING CONDUIT EXTENDED TO ACCOMMODATE NEW WORK. COORDINATE FINAL REQUIREMENTS AND LOCATIONS WITH ELEVATOR VENDOR.

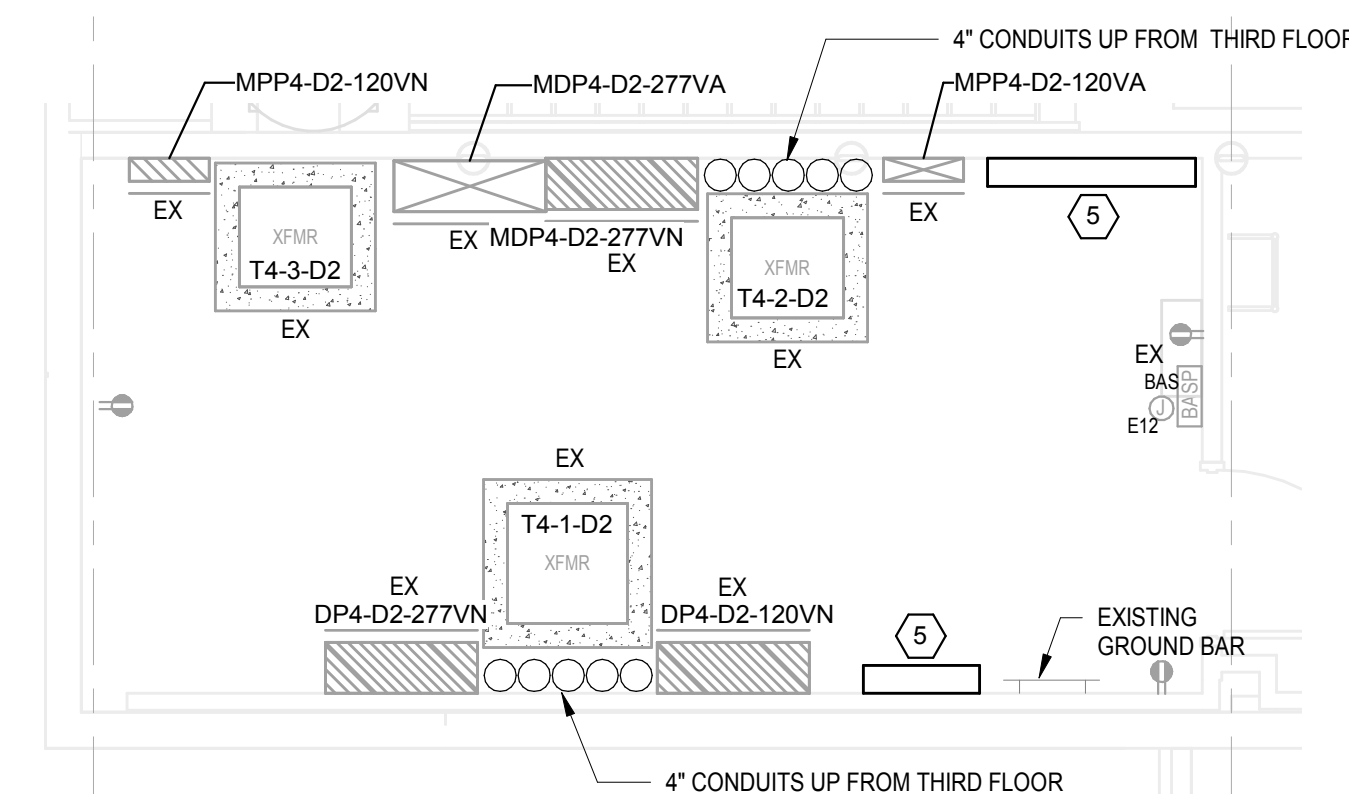


8B ENLARGED PLAN - FOURTH FLOOR ELECTRICAL ROOM  
1/4" = 1'-0"

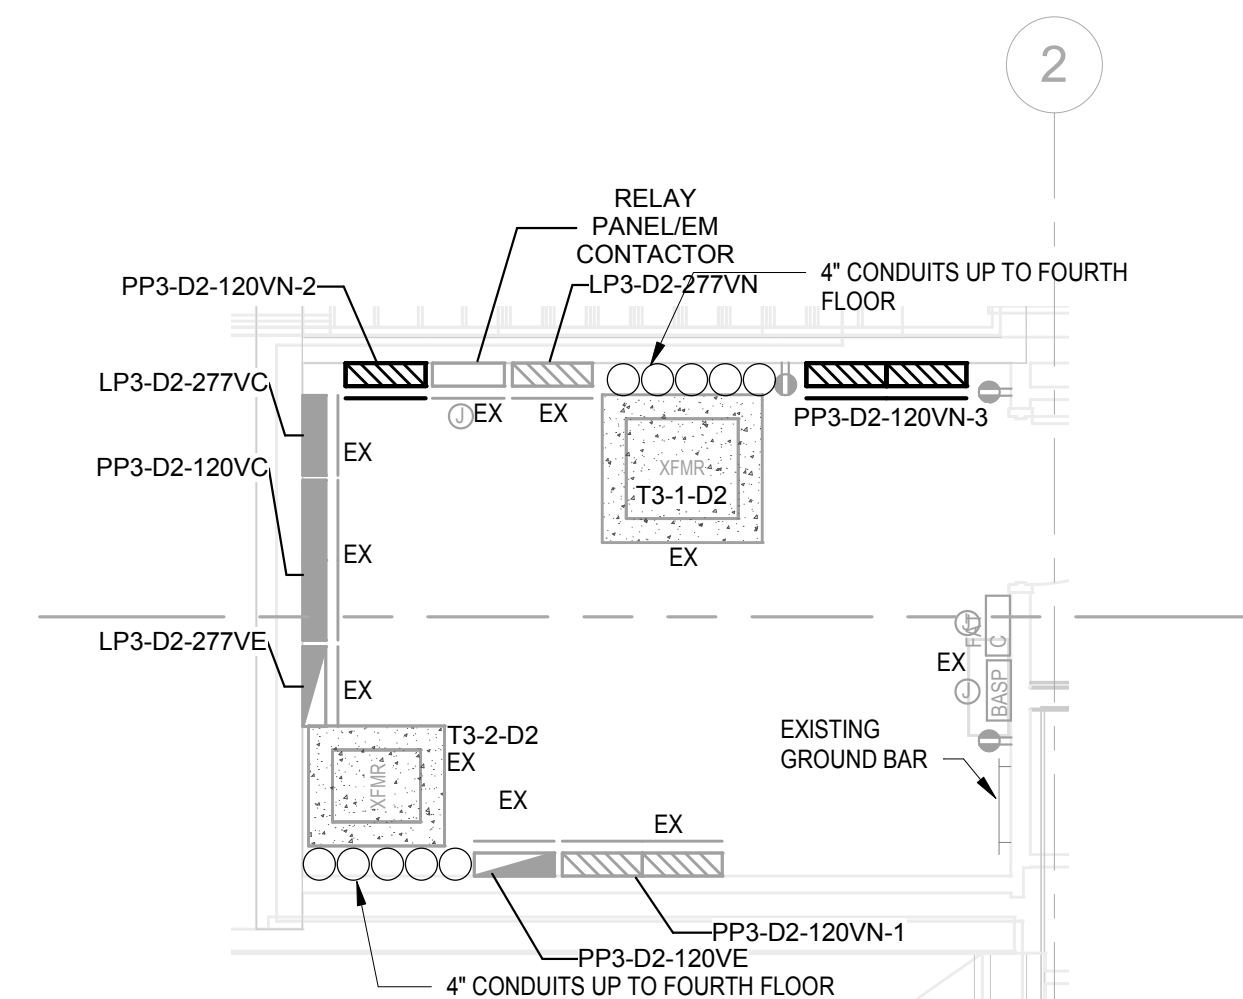


8D ENLARGED PLAN - THIRD FLOOR ELECTRICAL ROOM WEST  
1/4" = 1'-0"

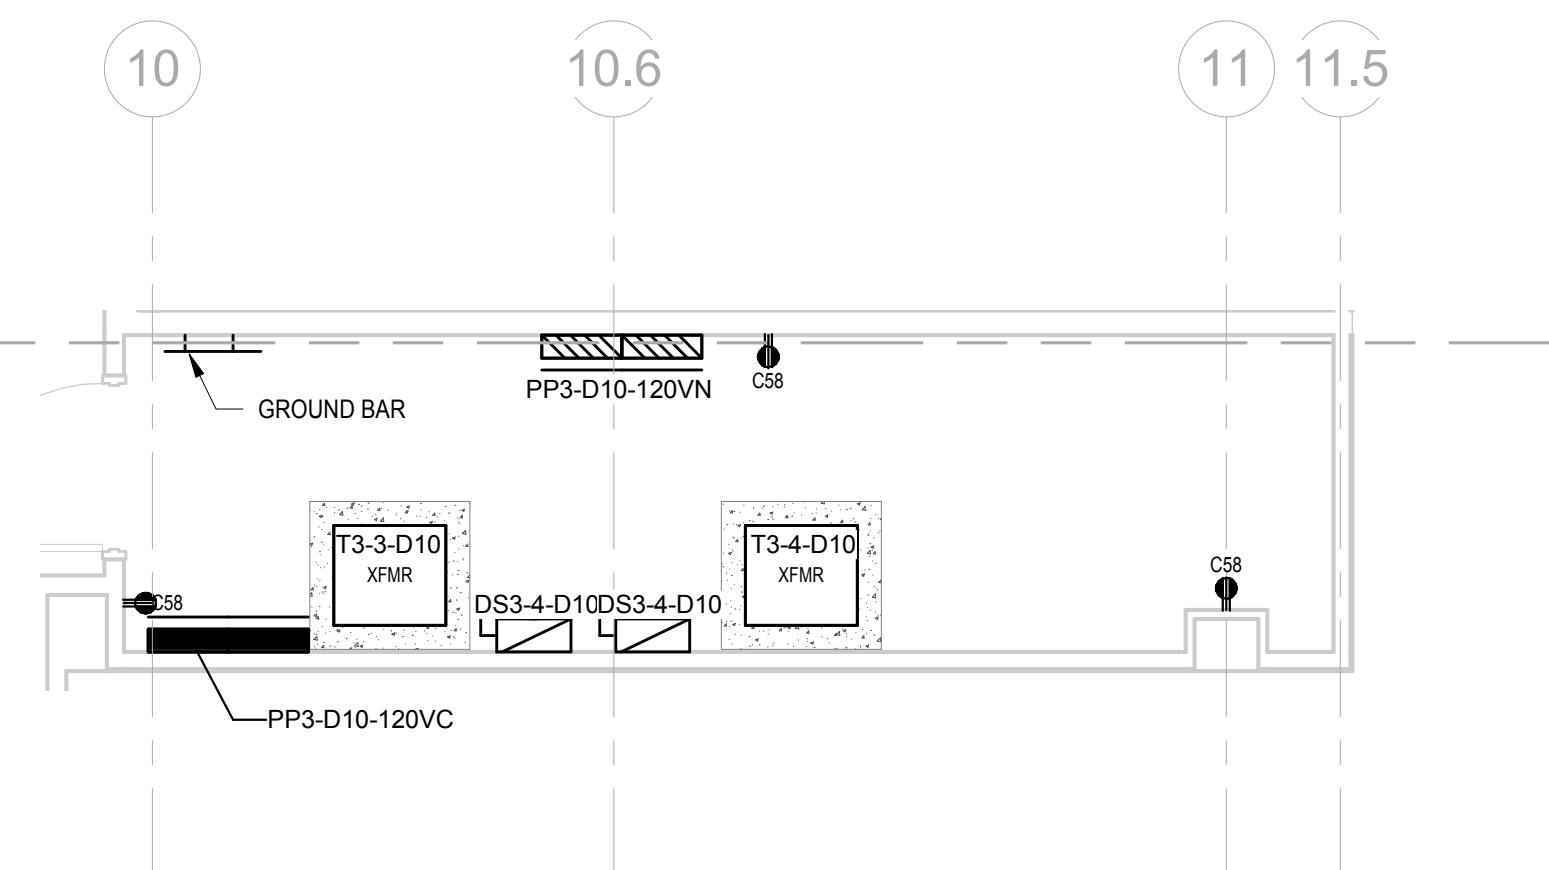


8F ENLARGED PLAN - THIRD FLOOR ELECTRICAL ROOM EAST  
1/4" = 1'-0"

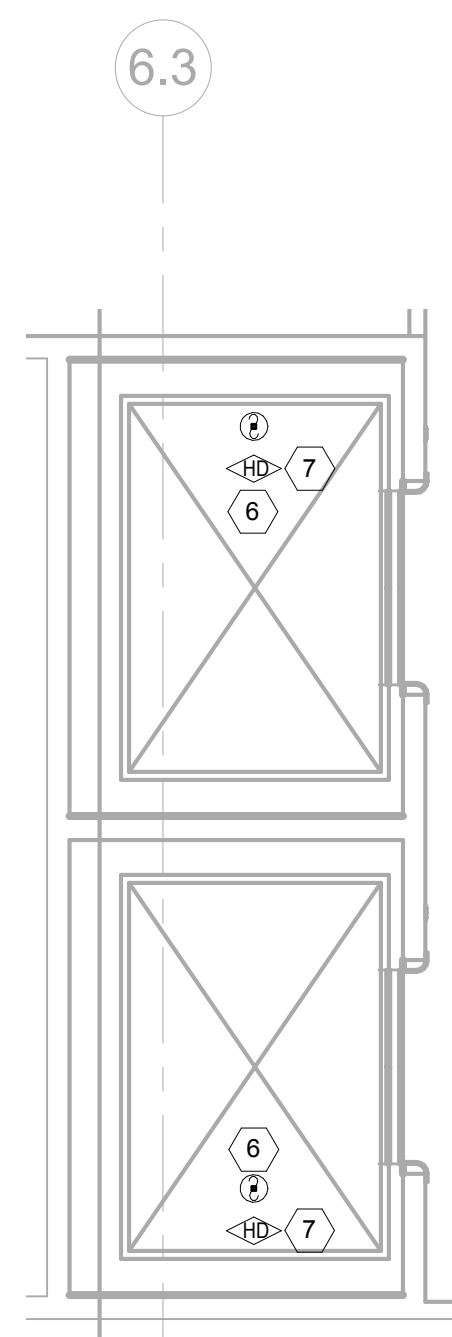

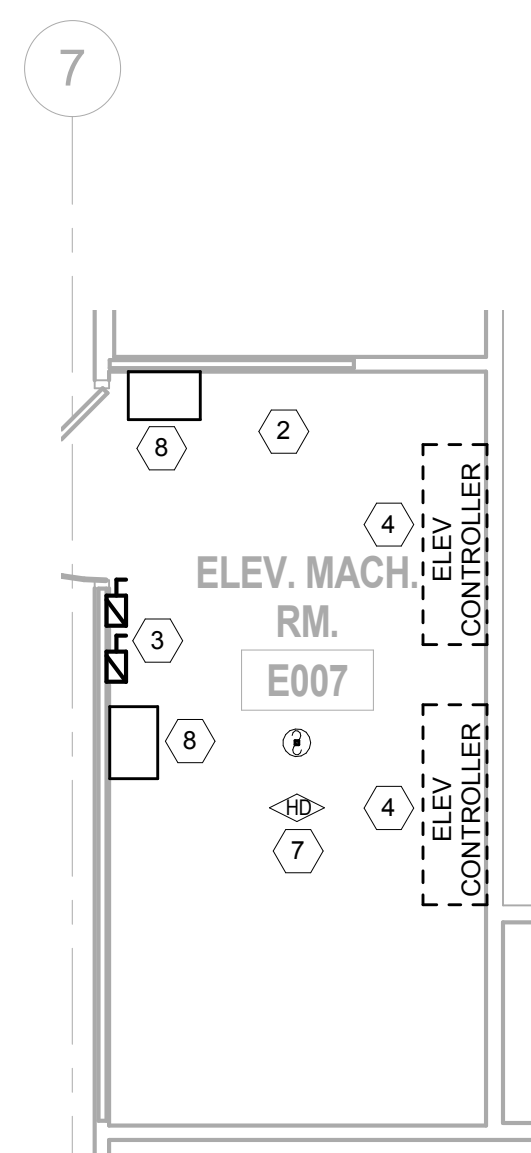

2F ENLARGED PLAN - ELEVATOR PIT  
1/4" = 1'-0"

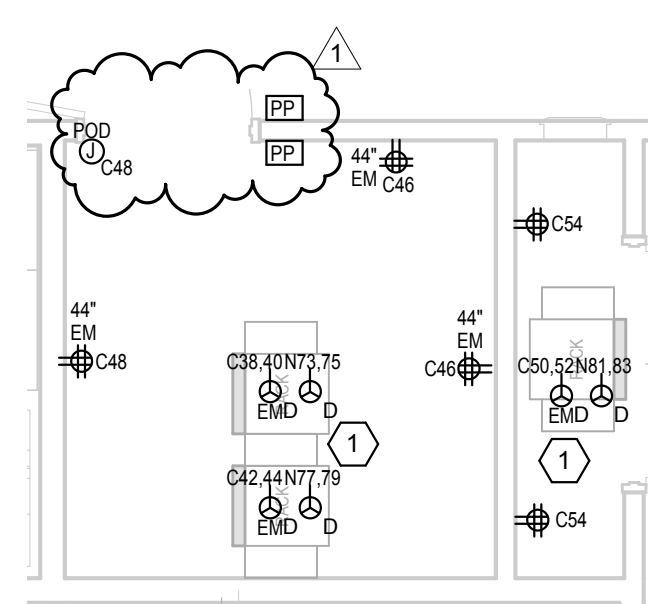

4F ENLARGED PLAN - EXISTING PASSENGER ELEVATOR MACHINE ROOM BASEMENT  
1/4" = 1'-0"



6F ENLARGED PLAN - IT ROOM / BIOMED CLOSET EAST  
1/4" = 1'-0"

			CONSULTANTS:						ARCHITECT/ENGINEERS:			Drawing Title <b>ENLARGED PLANS</b>			Project Title <b>Harry S. Truman Memorial Veterans' Hospital Expand Ambulatory Care Addition</b>			Project Number 599-333 <small>CANNON DESIGN PROJECT NO. 3850.06</small>			Office of Construction and Facilities Management								
			AcoustControl Acoustical Engineer 2464 Taylor Road Suite 214 Wildwood, MO 63040 314 436 9770			The Schachinger Group Elevator 4256 Stony Creek Drive Fort Collins, CO 90505 703.608.2263			<b>CANNON</b> <b>DESIGN</b>			Approved: Project Director			Location Columbia, Missouri			Drawing Number <b>EP-401.2</b>											
1 Addendum 02 06/08/17 Revisions: Date									1100 Clark Avenue St. Louis, Missouri 63102 T: 314.241.6250 F: 314.241.2570			© CannonDesign 2017 All rights reserved. No part of this document may be reproduced or utilized in any form, without prior written authorization by the Cannon Corporation			Date JANUARY 13, 2017			Checked TZ			Drawn AW			Dwg. of			 Department of Veterans Affairs		