

A

B

C

D

E

F

G

H

I

J

K

L

A

B

C

D

E

F

G

H

I

J

 
 
K


L


KEYED NOTES THIS SHEET


- (401) LIGHT FIXTURE BRANCH CIRCUITS AND SWITCHING
- (403) CORRIDOR LIGHTING CIRCUIT

SYMBOL LEGEND

-  FLOURESCENT TROFFER, 2x4, PRISMATIC LENS, TWO (2) T8 LAMPS.
-  FLOURESCENT TROFFER

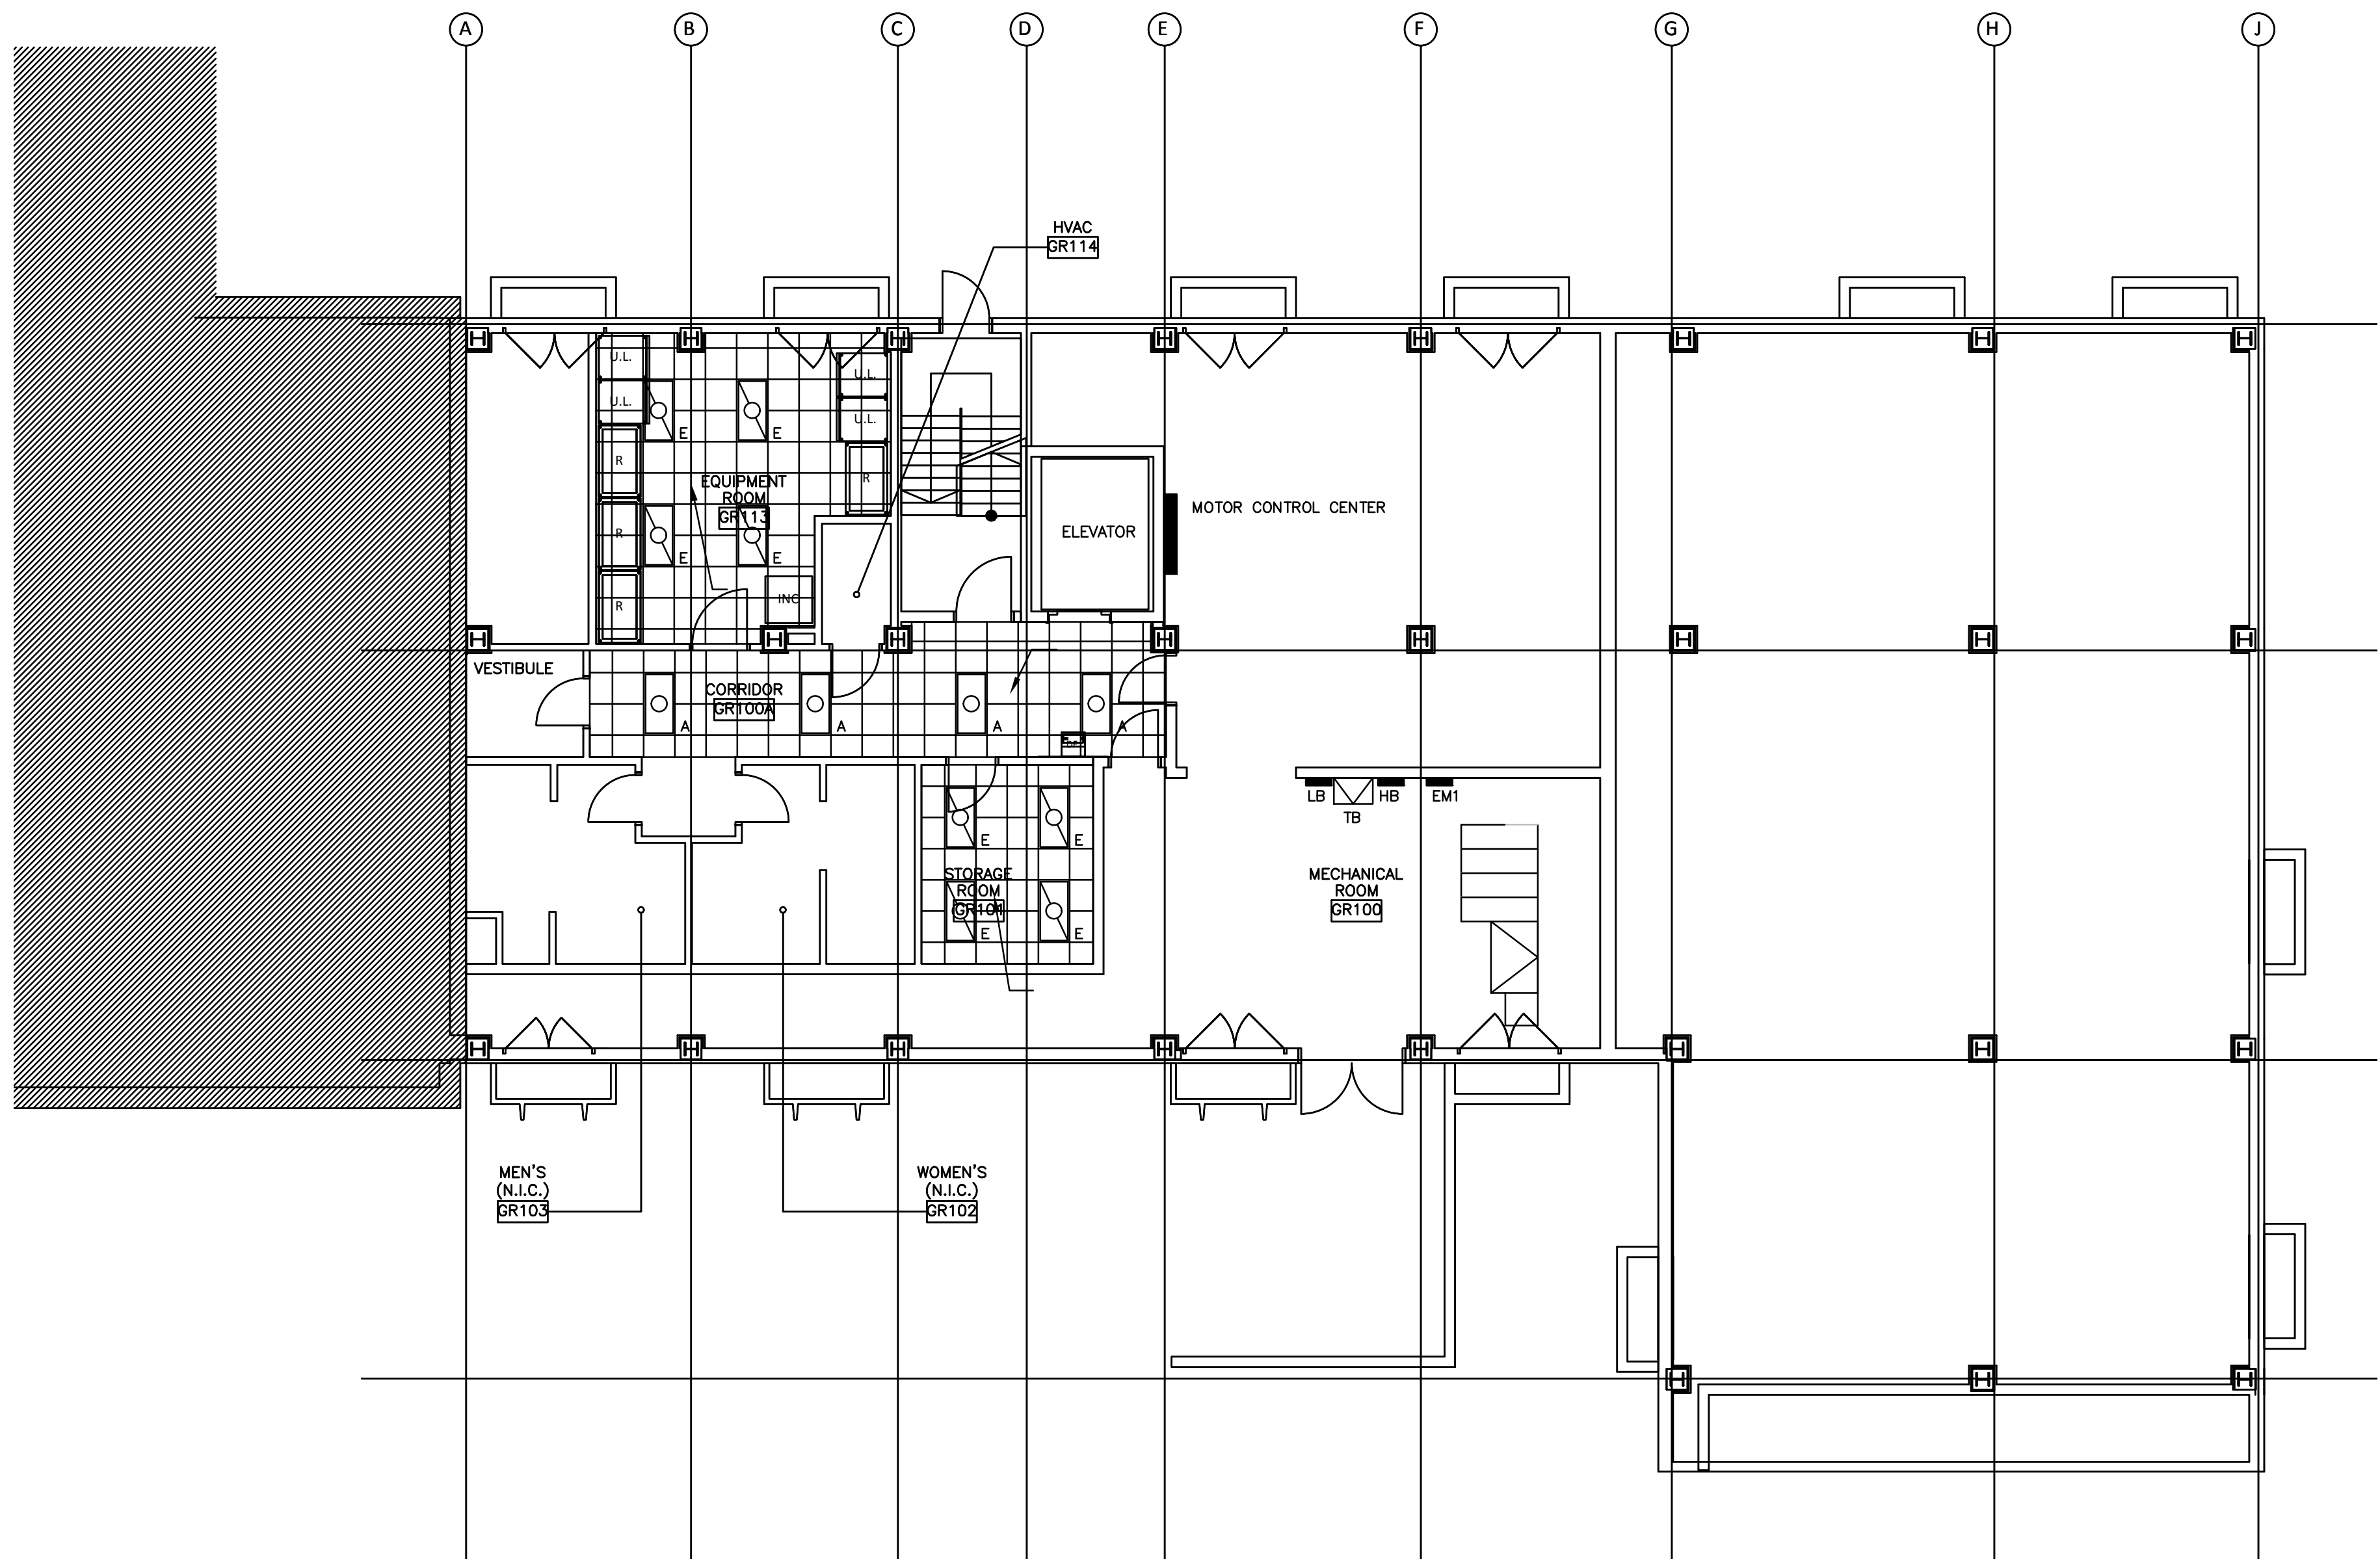

 **1 LIGHTING PLAN - BASEMENT**
E-400/ SCALE: 1/8"=1'-0"
8' 4' 0 8'
SCALE IN FEET

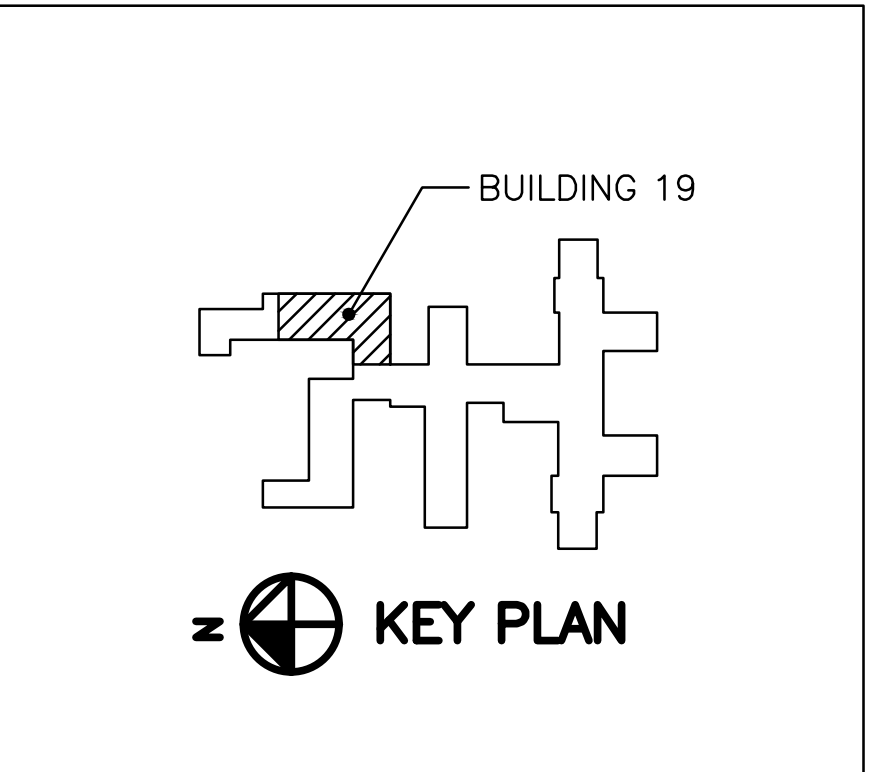

		CONSULTANTS:		ARCHITECT/ENGINEERS:	Drawing Title	BASEMENT LIGHTING PLAN			Project Title	BUILDING 19			Project Number	Office of OKC VAMC ENGINEERING PROJECTS Department of Veterans Affairs
			Approved: Medical Center Director				Approved: Chief, Engineers	VA MEDICAL CENTER OKLAHOMA CITY, OKLAHOMA			Location	Building Number	Bldg. 1	
							Approved: Chief, Projects				Drawing Number			
											Dwg. 9 of 16			
Revisions	Date													